

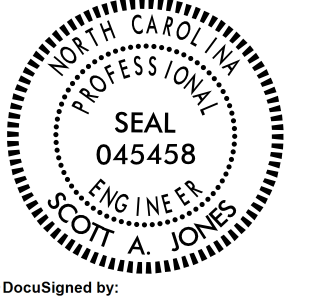


5/14/99

PROJECT REFERENCE NO. 1-5952	SHEET NO. 11
RW SHEET NO.	
ROADWAY DESIGN ENGINEER	HYDRAULICS ENGINEER
 SEAL 045458 ENGINEER SCOTT A. JONES	
Designed by: Scott Jones 9/19/2018	
DOCUMENT NOT CONSIDERED FINAL UNLESS ALL SIGNATURES COMPLETED	

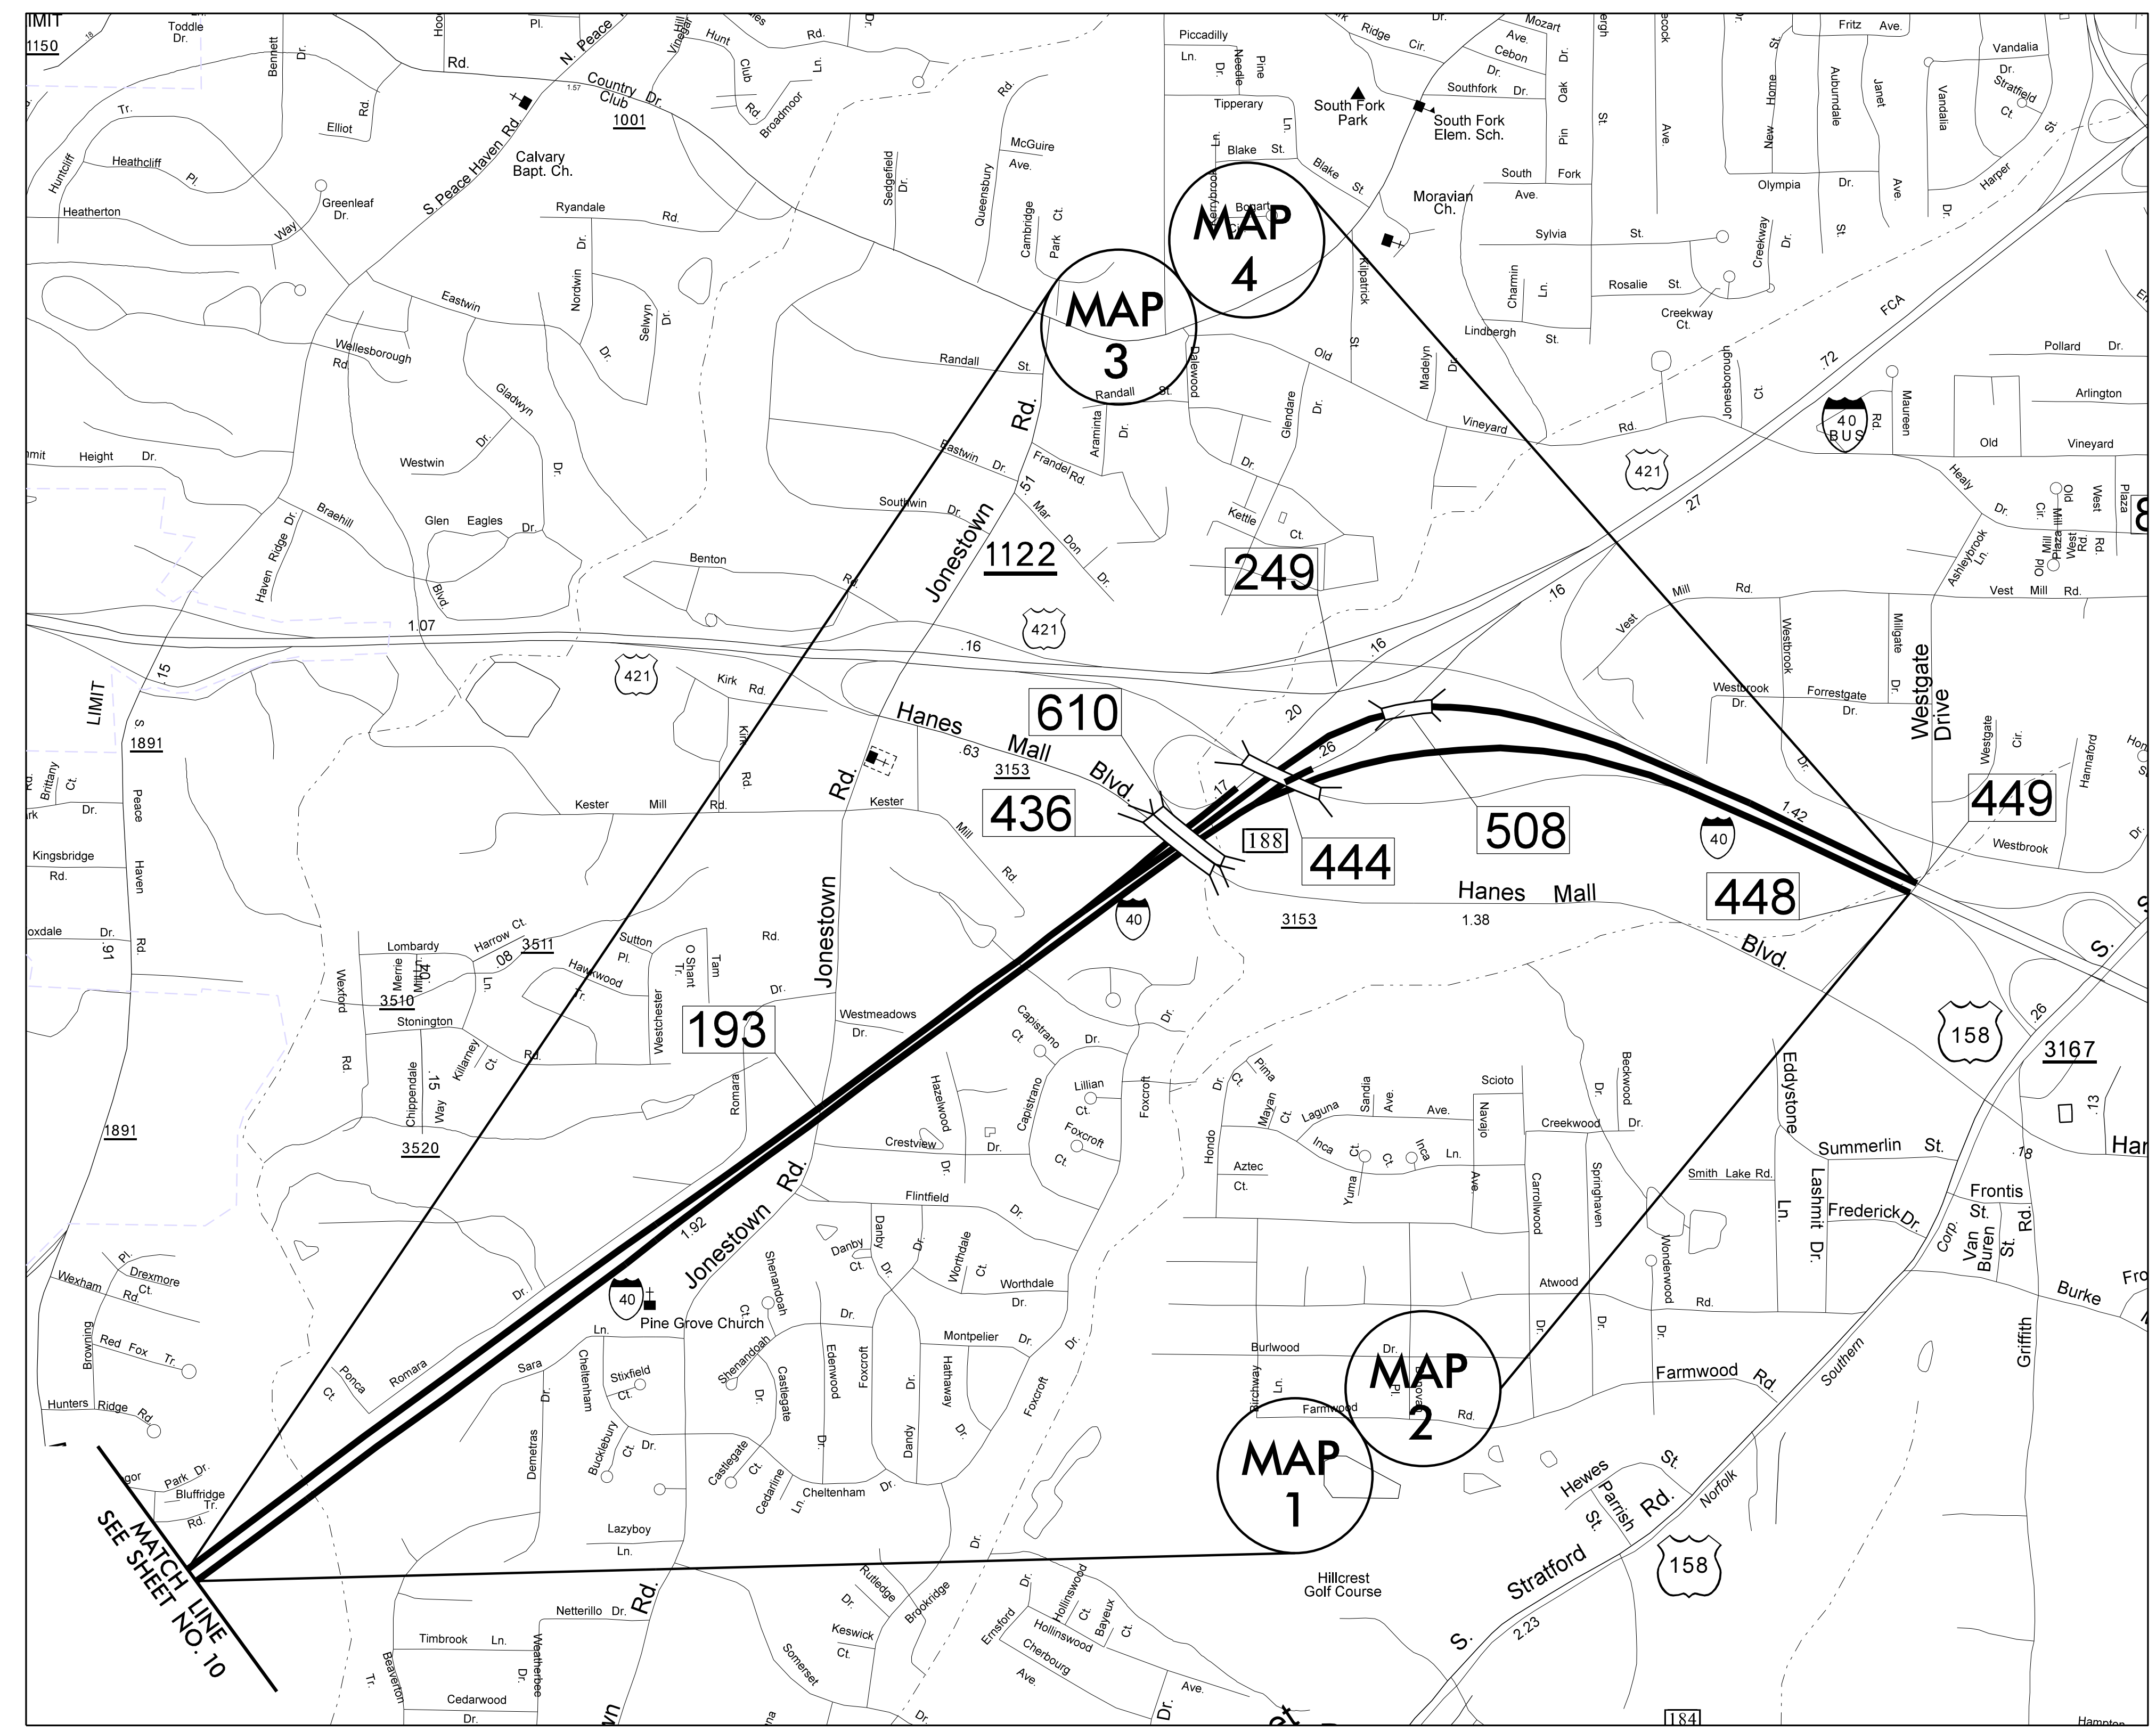

- Map 1
Map 2
I-40 East Bound
Mill Travel lanes only 2 1/2" depth
Pave back with 2 1/2" I19.0C.
Overlay entire width with 2" S9.5D.
- Map 3
Map 4
I-40 West Bound
Mill Travel lanes only 2 1/2" depth
Pave back with 2 1/2" I19.0C.
Overlay entire width with 2" S9.5D.

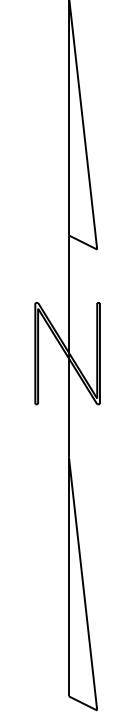

FORSYTH COUNTY
NORTH CAROLINA

19 SEP 2018 10:03 AM
 Project: C:\Users\jones\OneDrive\Documents\Forsyth\Roadway\Design Files\1-5952-ddc-psh11.dgn
 \$\$\$\$\$\$FRONTVIEW\$\$\$\$\$\$

MATCH LINE
SEE SHEET NO. 10