 



6/23/16  
9 SEP 2018 11:30  
S:\Projects\Development\IP Projects\11-5952-140-West Forsyth\Roadway\Design Files\1-5952.ddc.xp.i.dgn  
At 011% 2% 4.5%



PROJ. REFERENCE NO.  
I-5952

SHEET NO.  
X-21

75 70 65 60 55 50 45 40 35 30 25 20 15 10 5 0 5 10 15 20 25 30 35 40 45 50 55 60 65 70 75

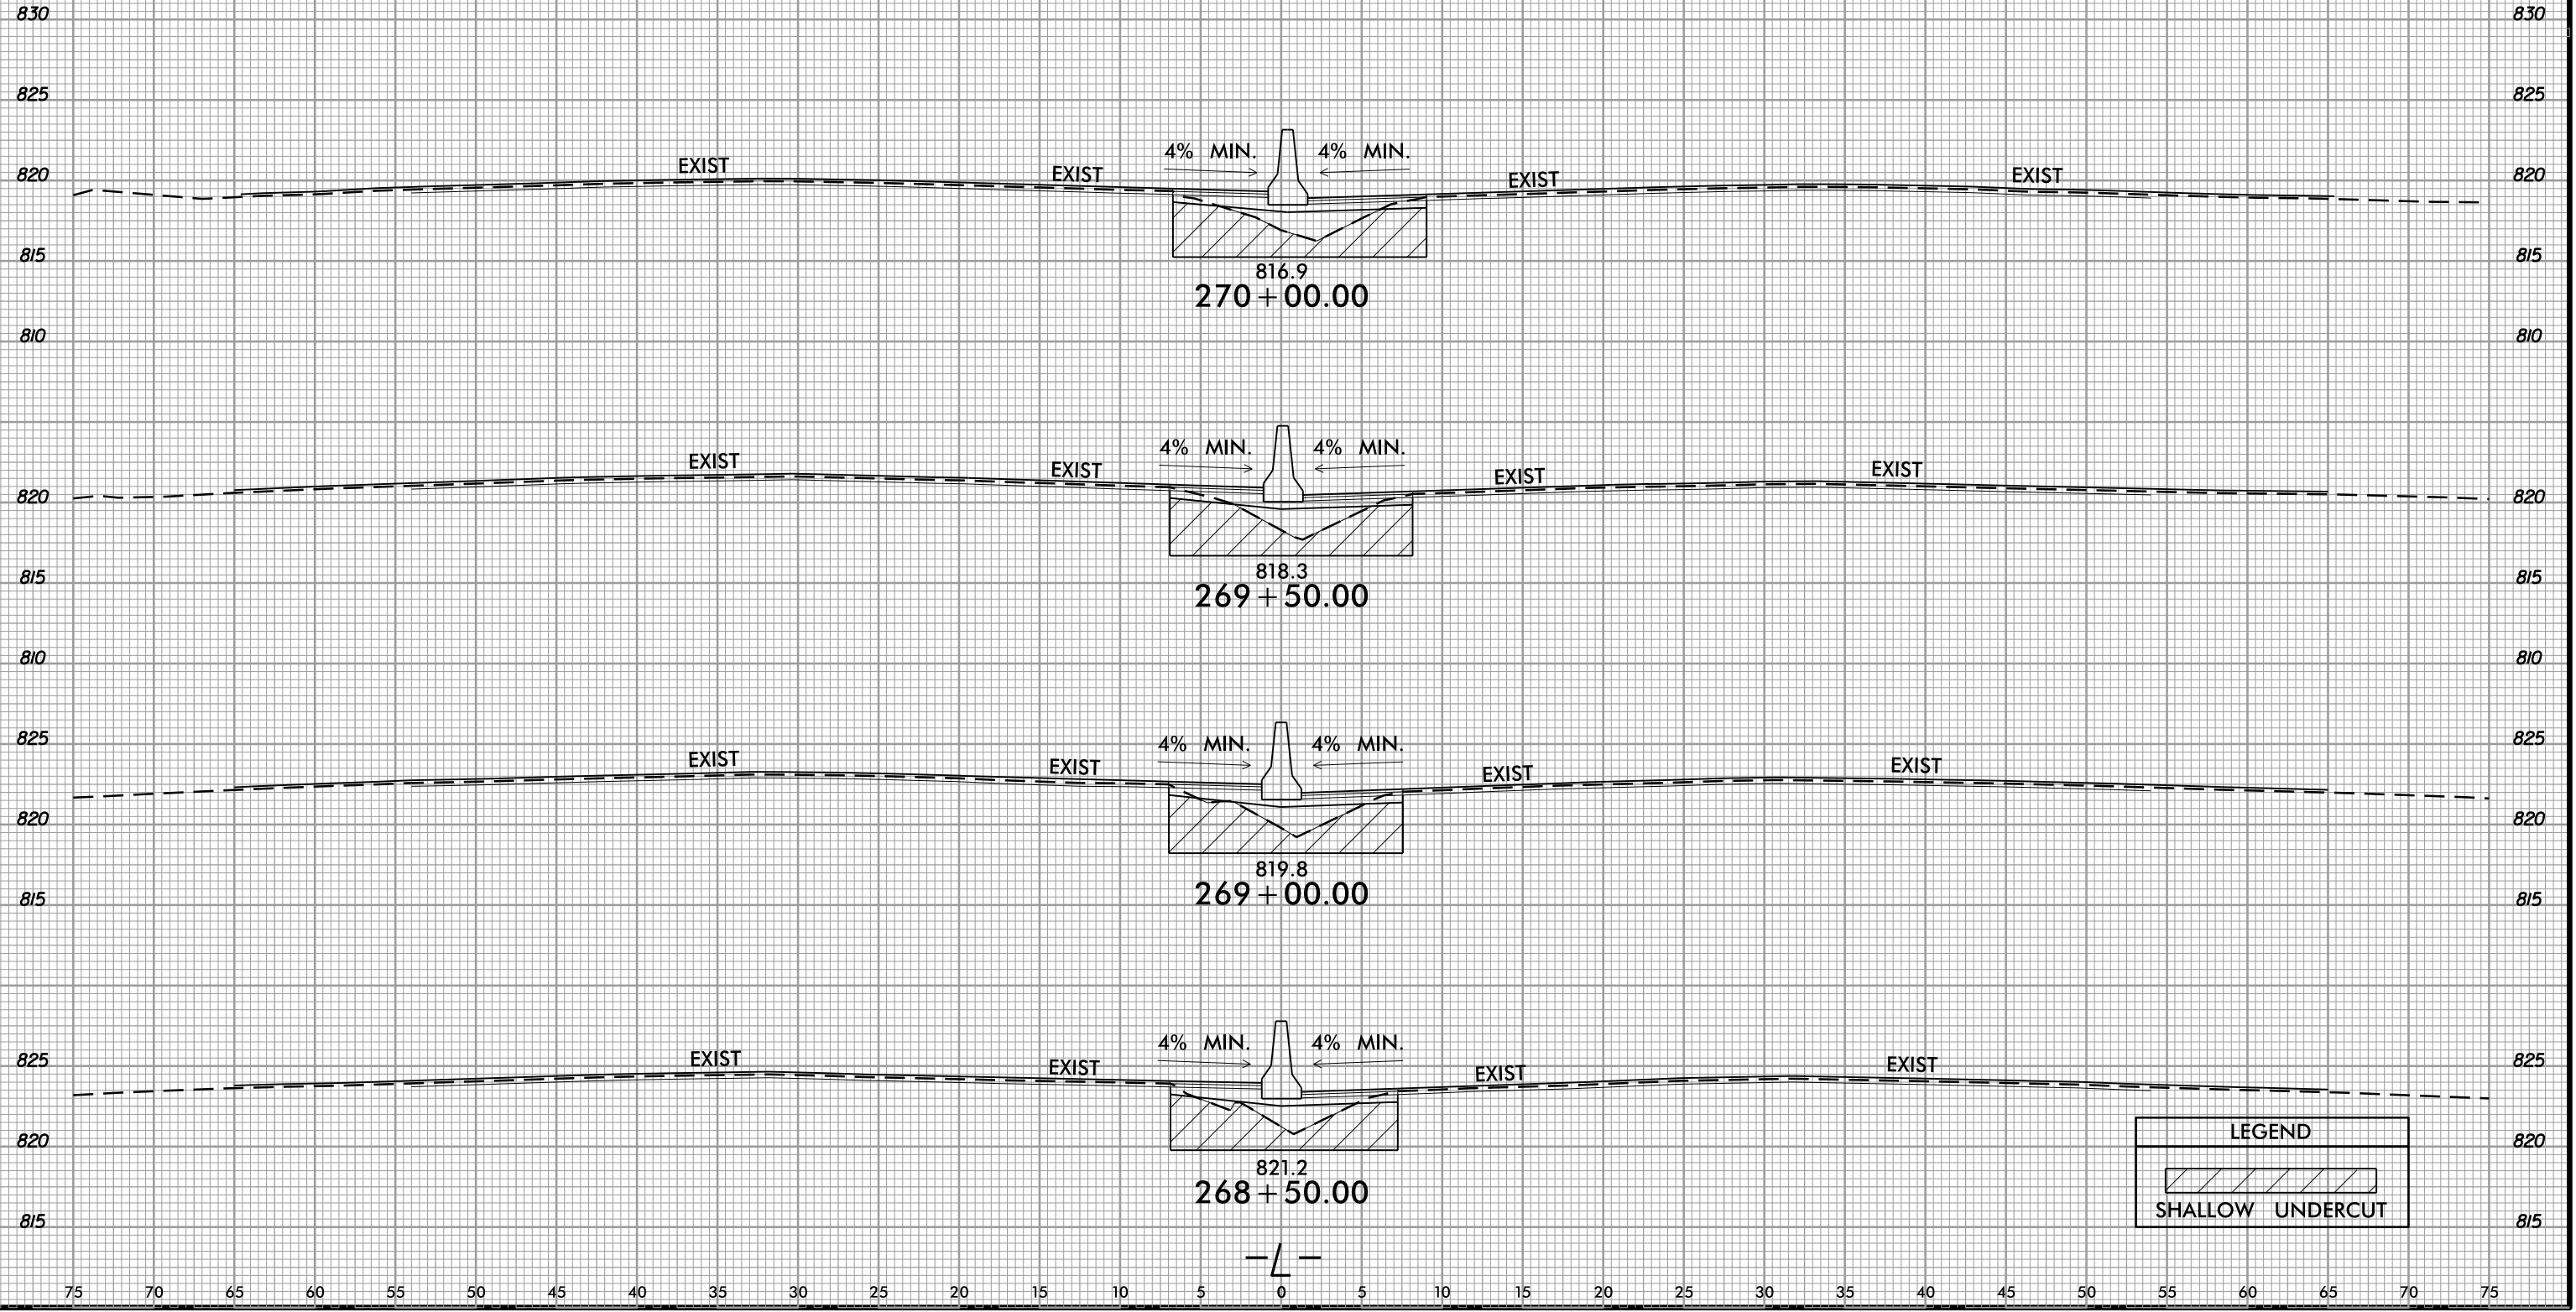

LEGEND

SHALLOW UNDERCUT