 



6/23/16
9-SEP-2018 11:30
S:\Projects\Development\IP Projects\11-5952-140-West For syth\Roadway\Design Files\1-5952.ddc.xp.i.dgn
At DIV 20450



PROJ. REFERENCE NO.
I-5952

SHEET NO.
X-22

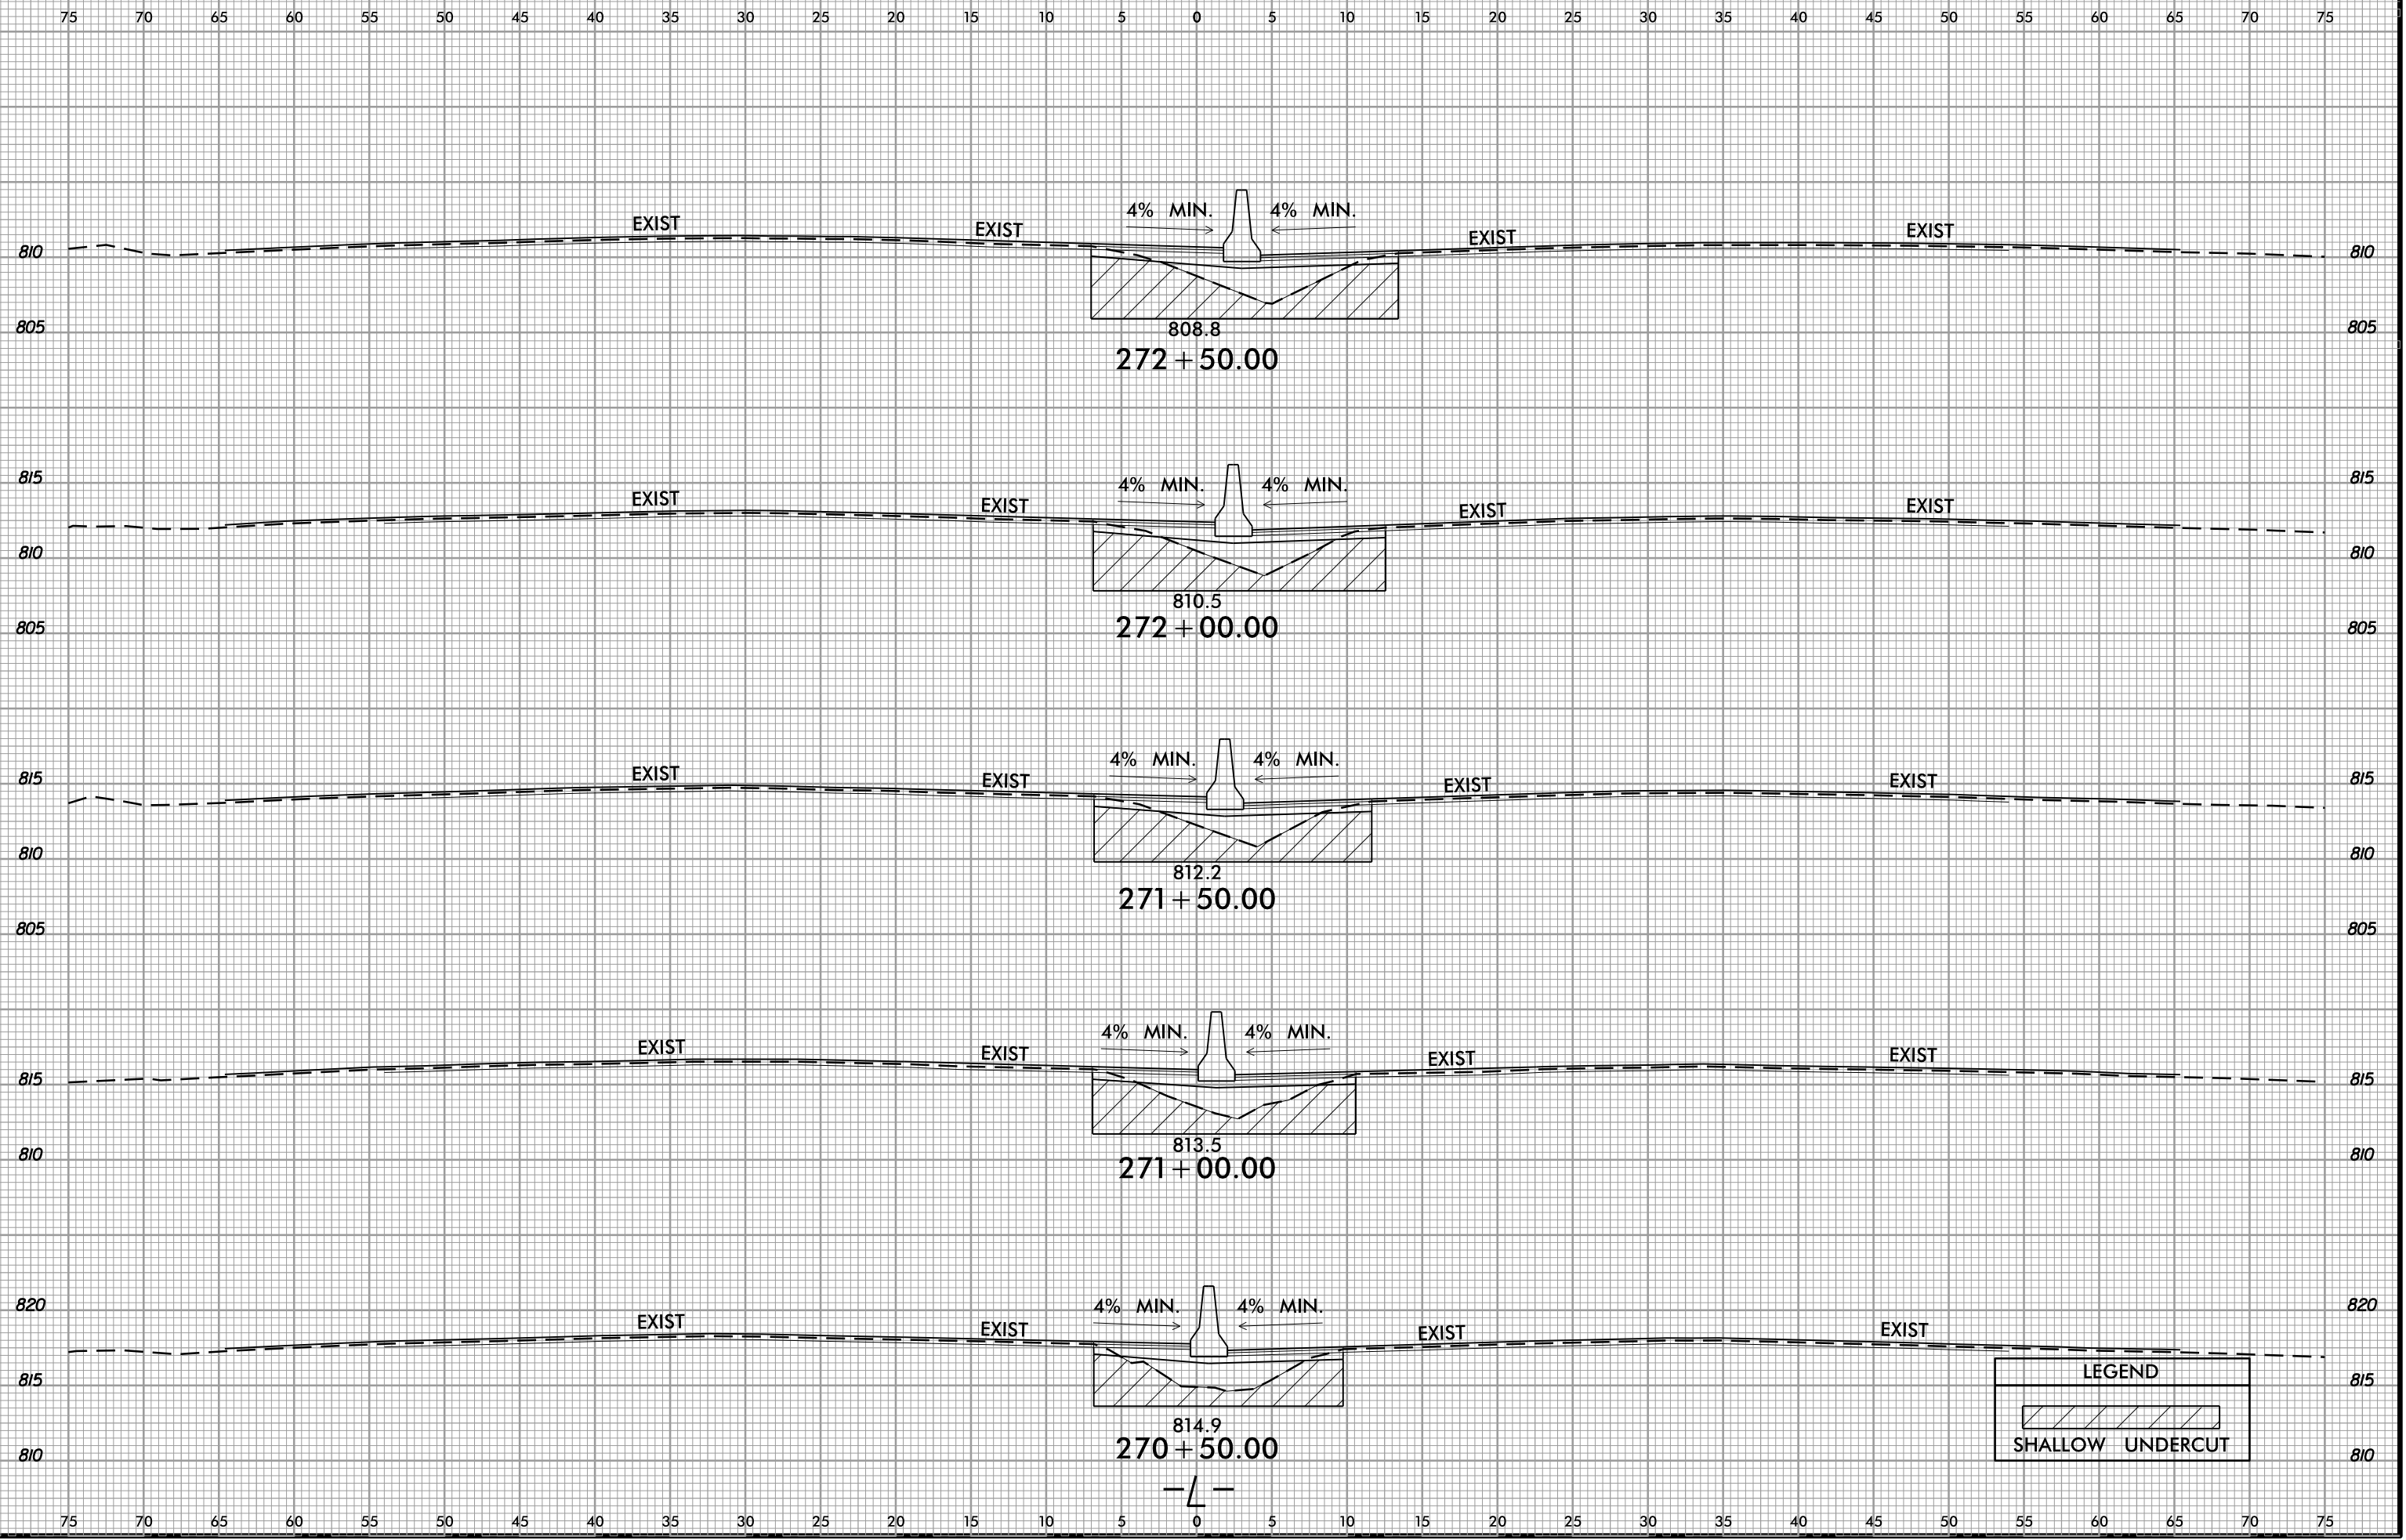

LEGEND

SHALLOW UNDERCUT