 



6/23/16
9 SEP 2018 11:31
S:\Projects\Development\IP Projects\11-5952-140-West_Forsyth\Roadway\Design Files\1-5952.ddc.xp.i.dgn
At Division 204500



PROJ. REFERENCE NO.
1-5952

SHEET NO.
X-23

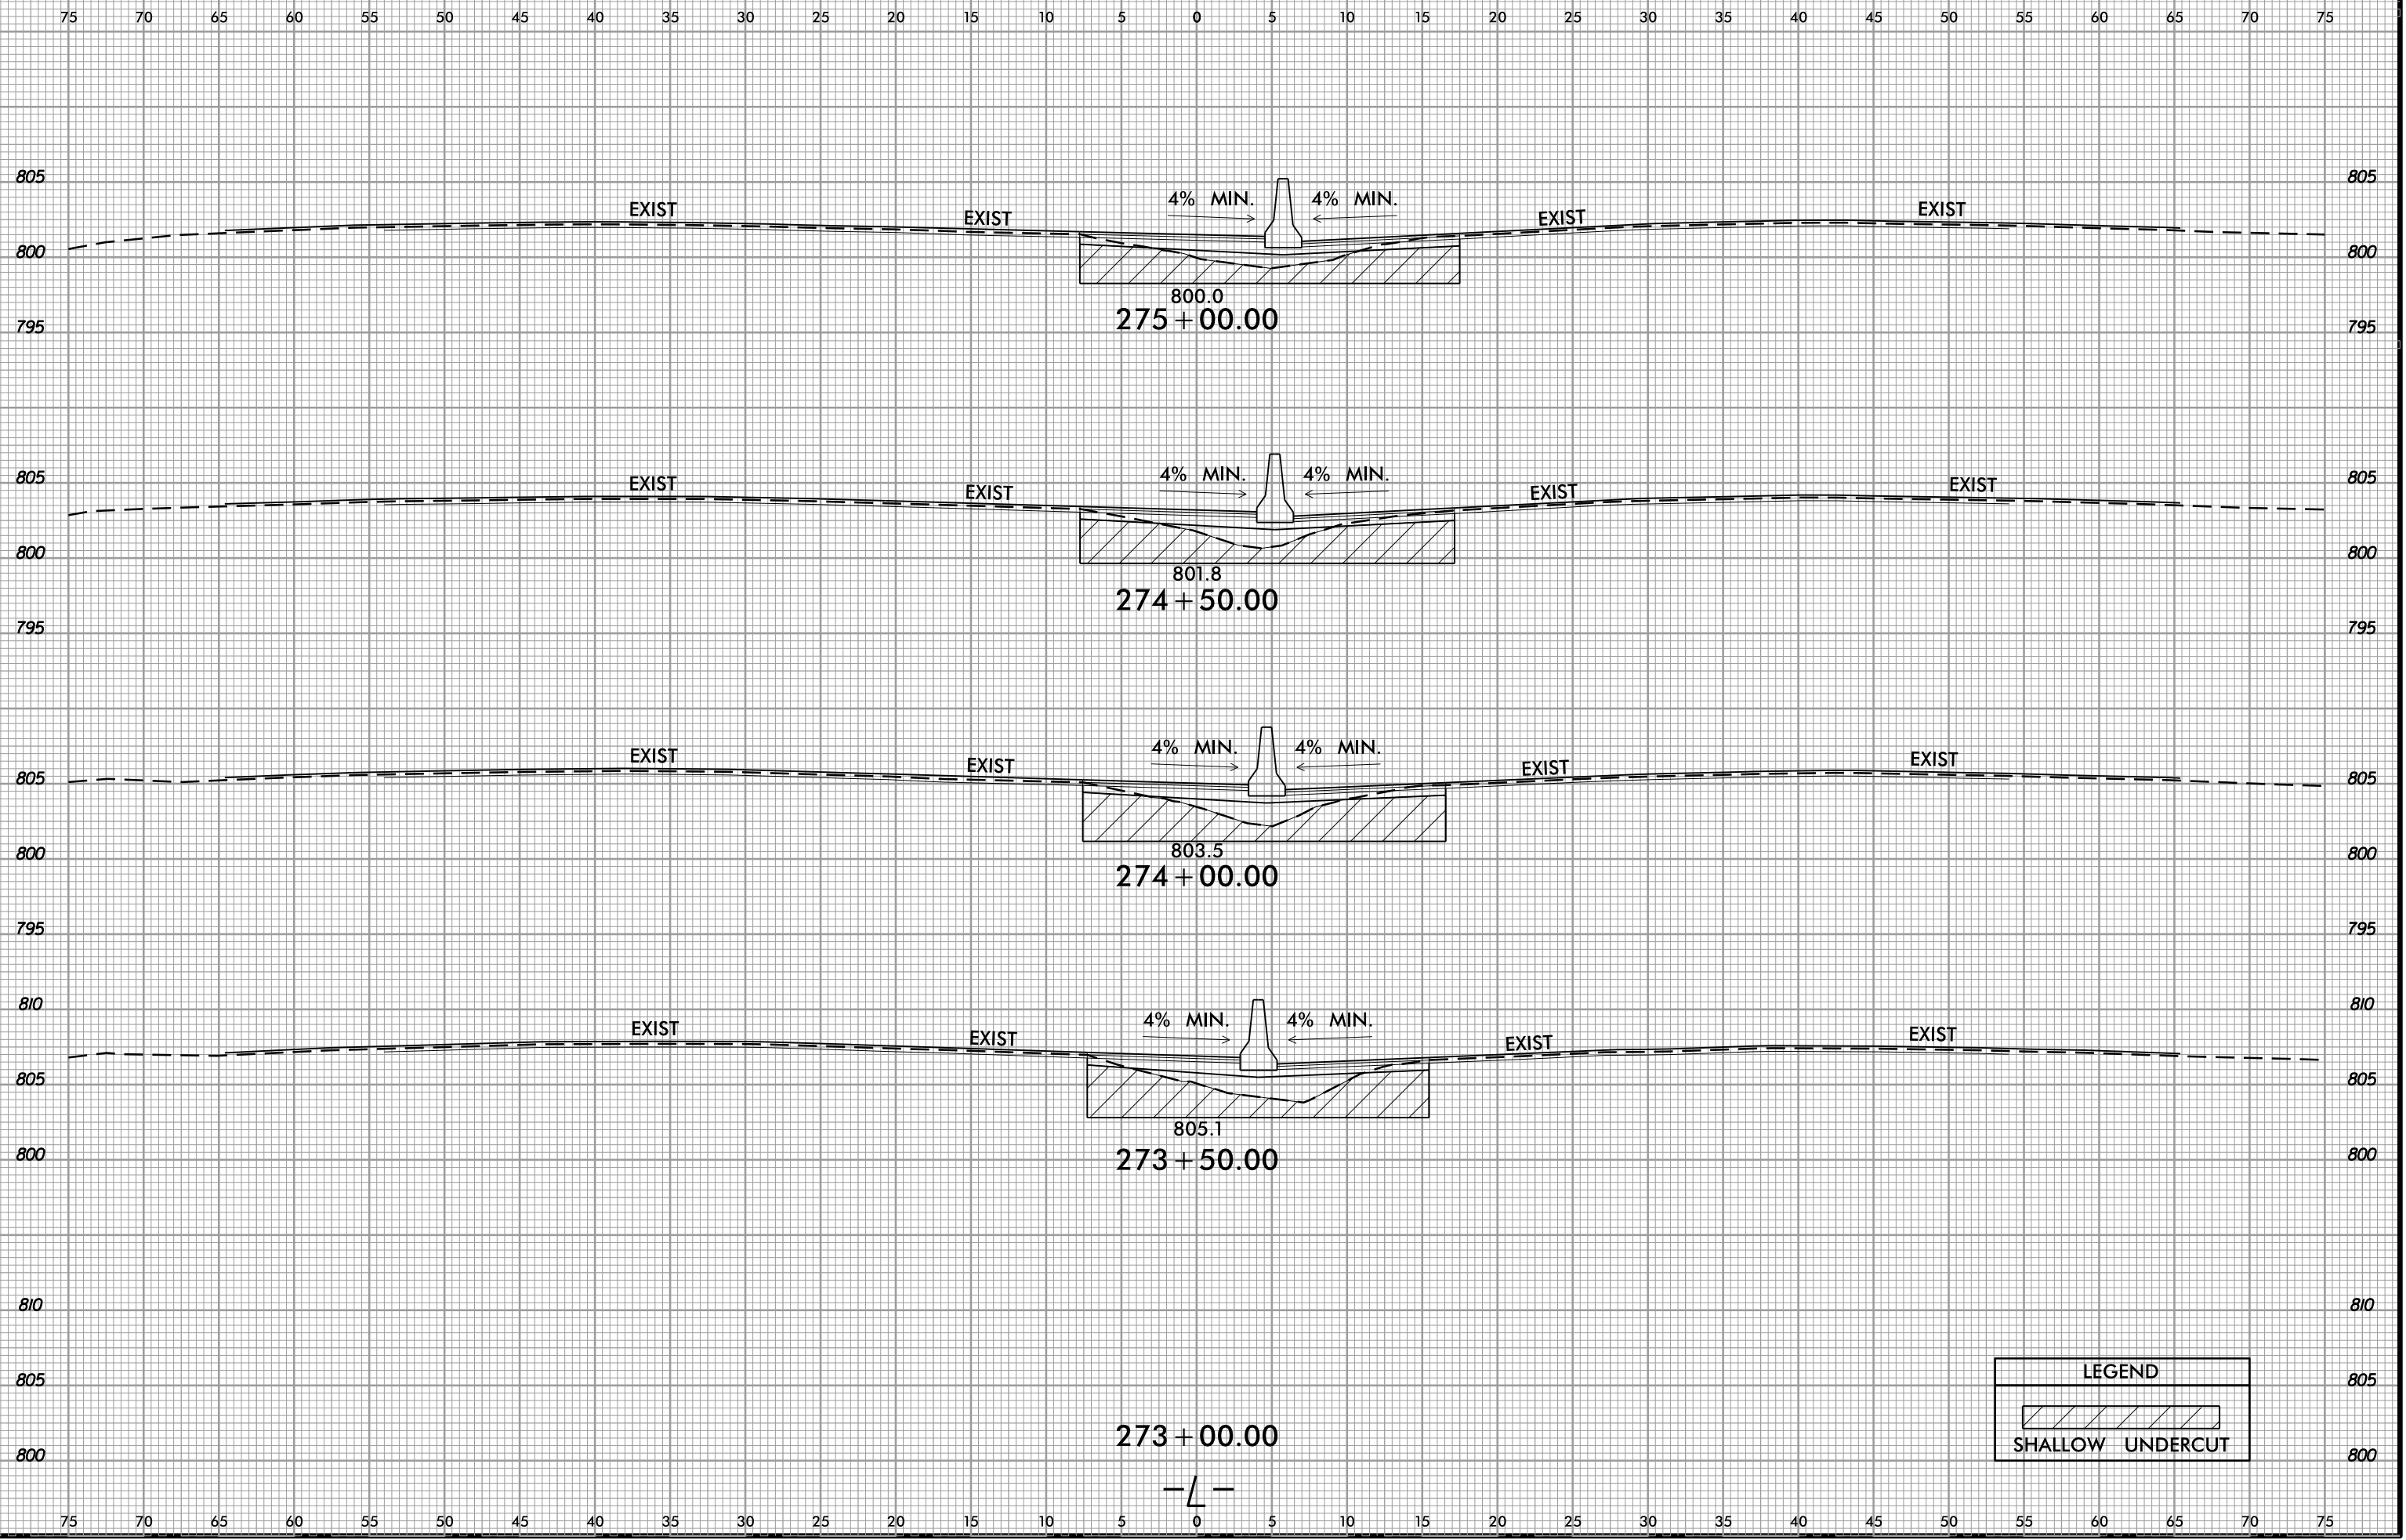

LEGEND

SHALLOW UNDERCUT