
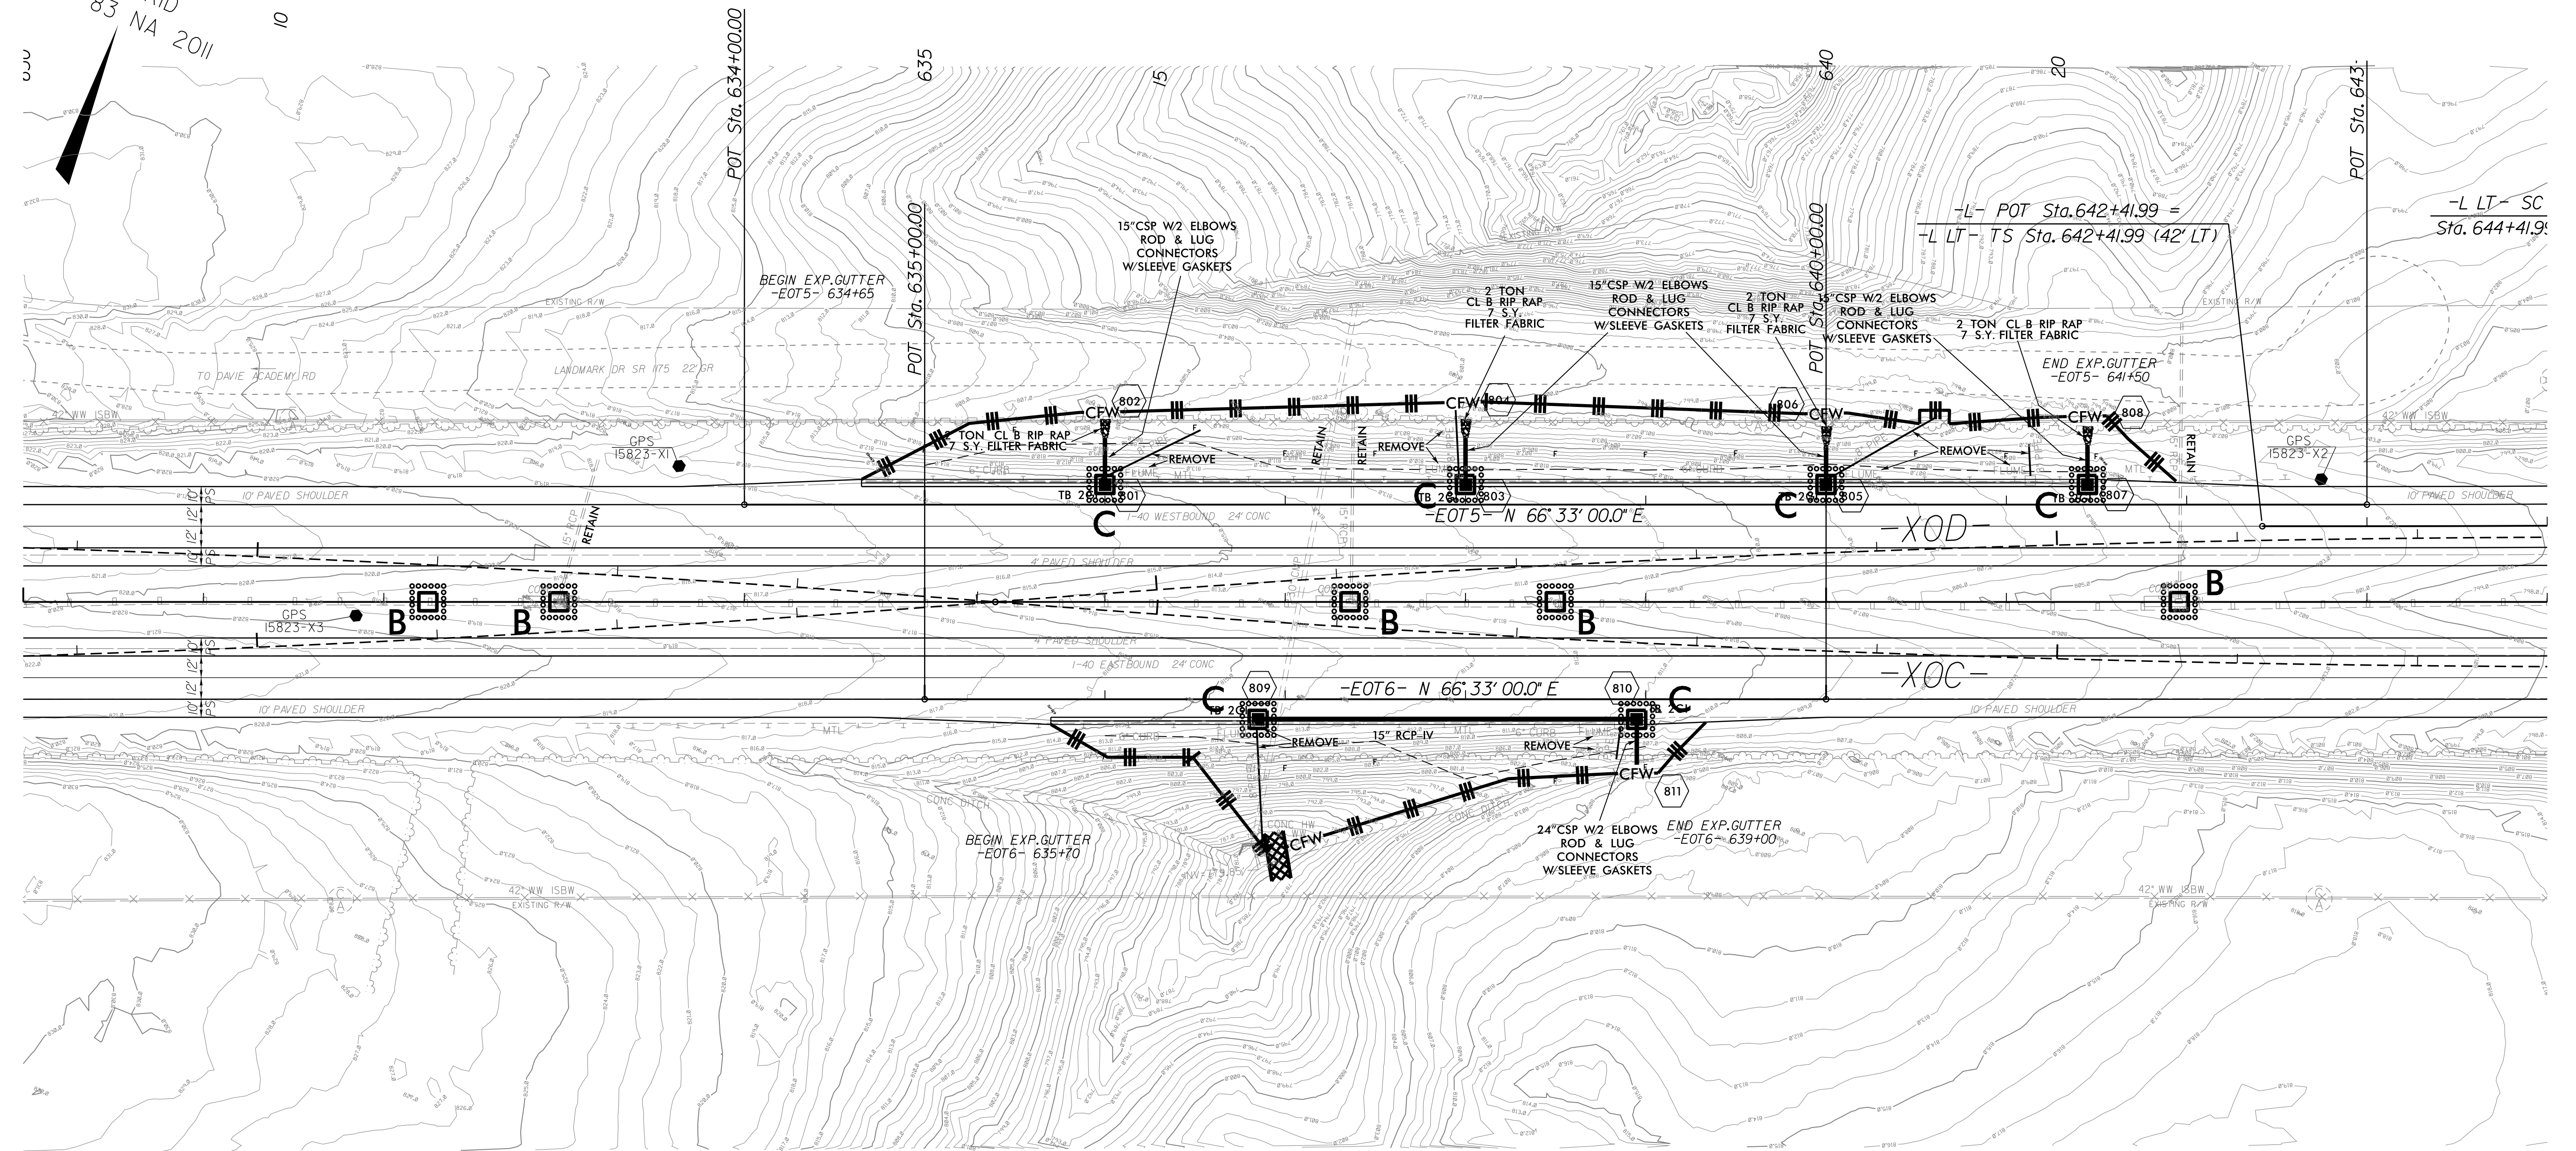


PROJECT REFERENCE NO.	SHEET NO.
1-5823	EC-8
RW SHEET NO.	
ROADWAY DESIGN ENGINEER	HYDRAULICS ENGINEER

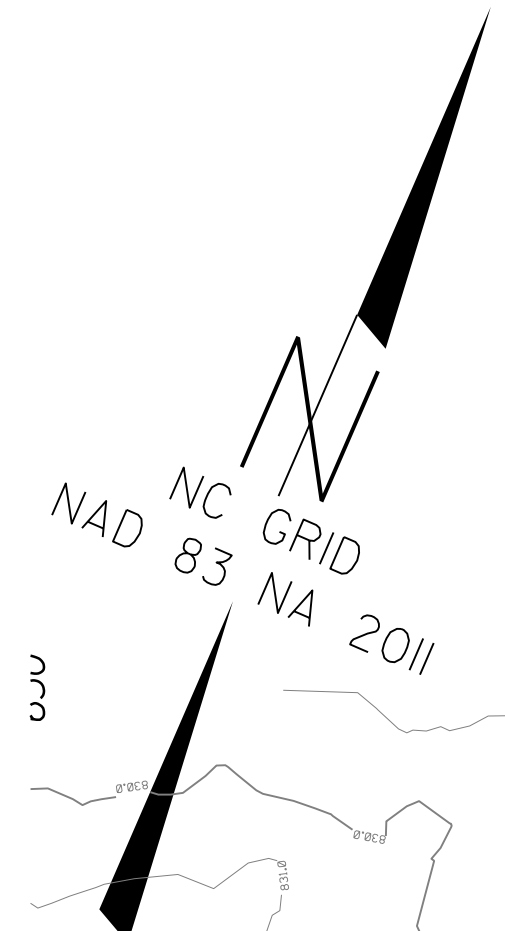

NOTE:  
TEMPORARY SILT FENCE SHALL BE INSTALLED A MINIMUM OF 3 FEET FROM TOE OF FILL IN WETLAND AREAS

NOTE:  
PLACE TEMPORARY ROCK SEDIMENT DAMS TYPE-B AND TEMPORARY ROCK SILT CHECKS TYPE-A AT DRAINAGE OUTLETS

CLEARING AND GRUBBING EROSION CONTROL FOR CONSTRUCTION SHEET 8

Pls Sta 643+75.32  
 $\theta_s = 0^\circ 30' 00.0''$   
 $L_s = 200.00'$   
 $LT = 133.33'$   
 $ST = 66.67'$

8/17/99  
 29 NOV 2016 11:28  
 C:\ProgramData\Autodesk\LT15\Projects\1-5823-40-Davie\ErostonControl\15823.ddc\_EC-B.dgn  
 USER:RAME\$