


**This electronic collection of documents is provided  
for the convenience of the user  
and is Not a Certified Document –**

**The documents contained herein were originally issued  
and sealed by the individuals whose names and license  
numbers appear on each page, on the dates appearing  
with their signature on that page.**

**This file or an individual page  
shall not be considered a certified document.**

6/23/16  
29-NOV-2018 09:08  
S:\Project\_Development\TIP\_Projects\1-5823-140-Devie\Roadway\DesignFiles\15823-ddc-xpl-EOTI.dgn  
Keston - DIV 24050

NOTE: CROSS SECTIONS ARE FOR INFORMATIONAL PURPOSES ONLY

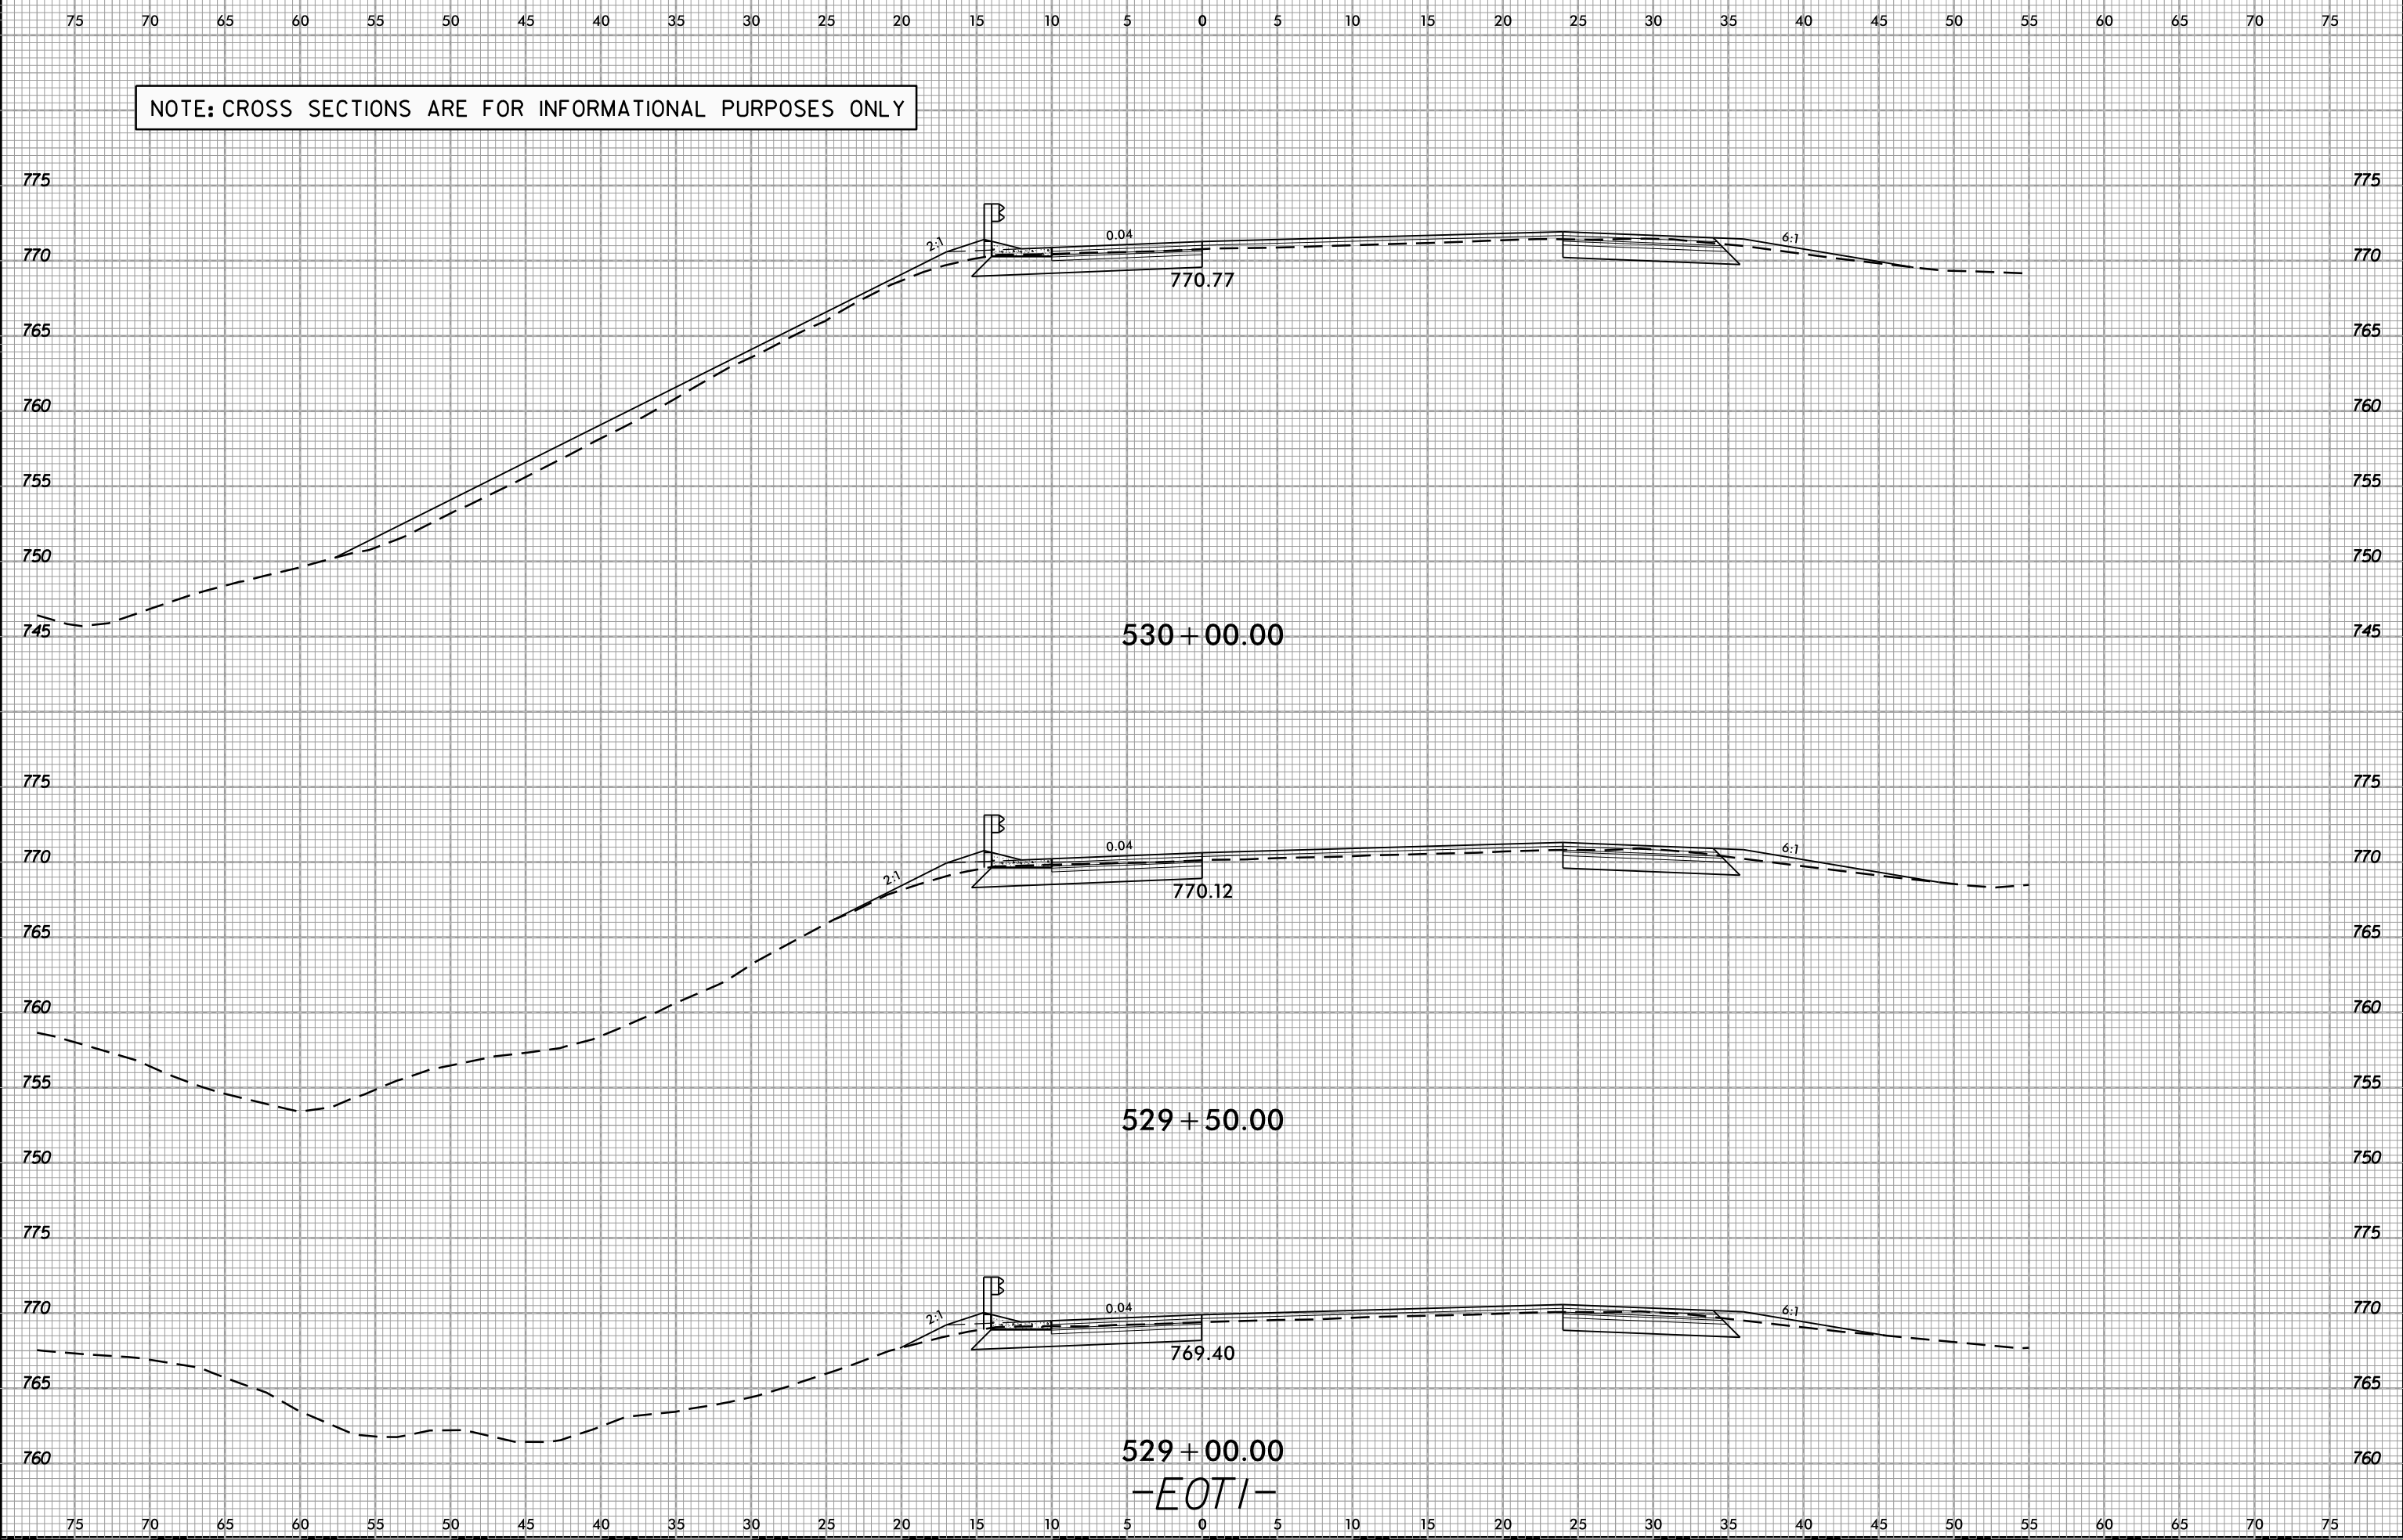


530+00.00

529+50.00


529+00.00

-EOTI-


6/23/16  
02-NOV-2018 13:46  
S:\Projects-Development\115823-140-Dave\Roadway\DesignFiles\15823.ddc.xpl.EOT1.dgn  
AT DIV 29450

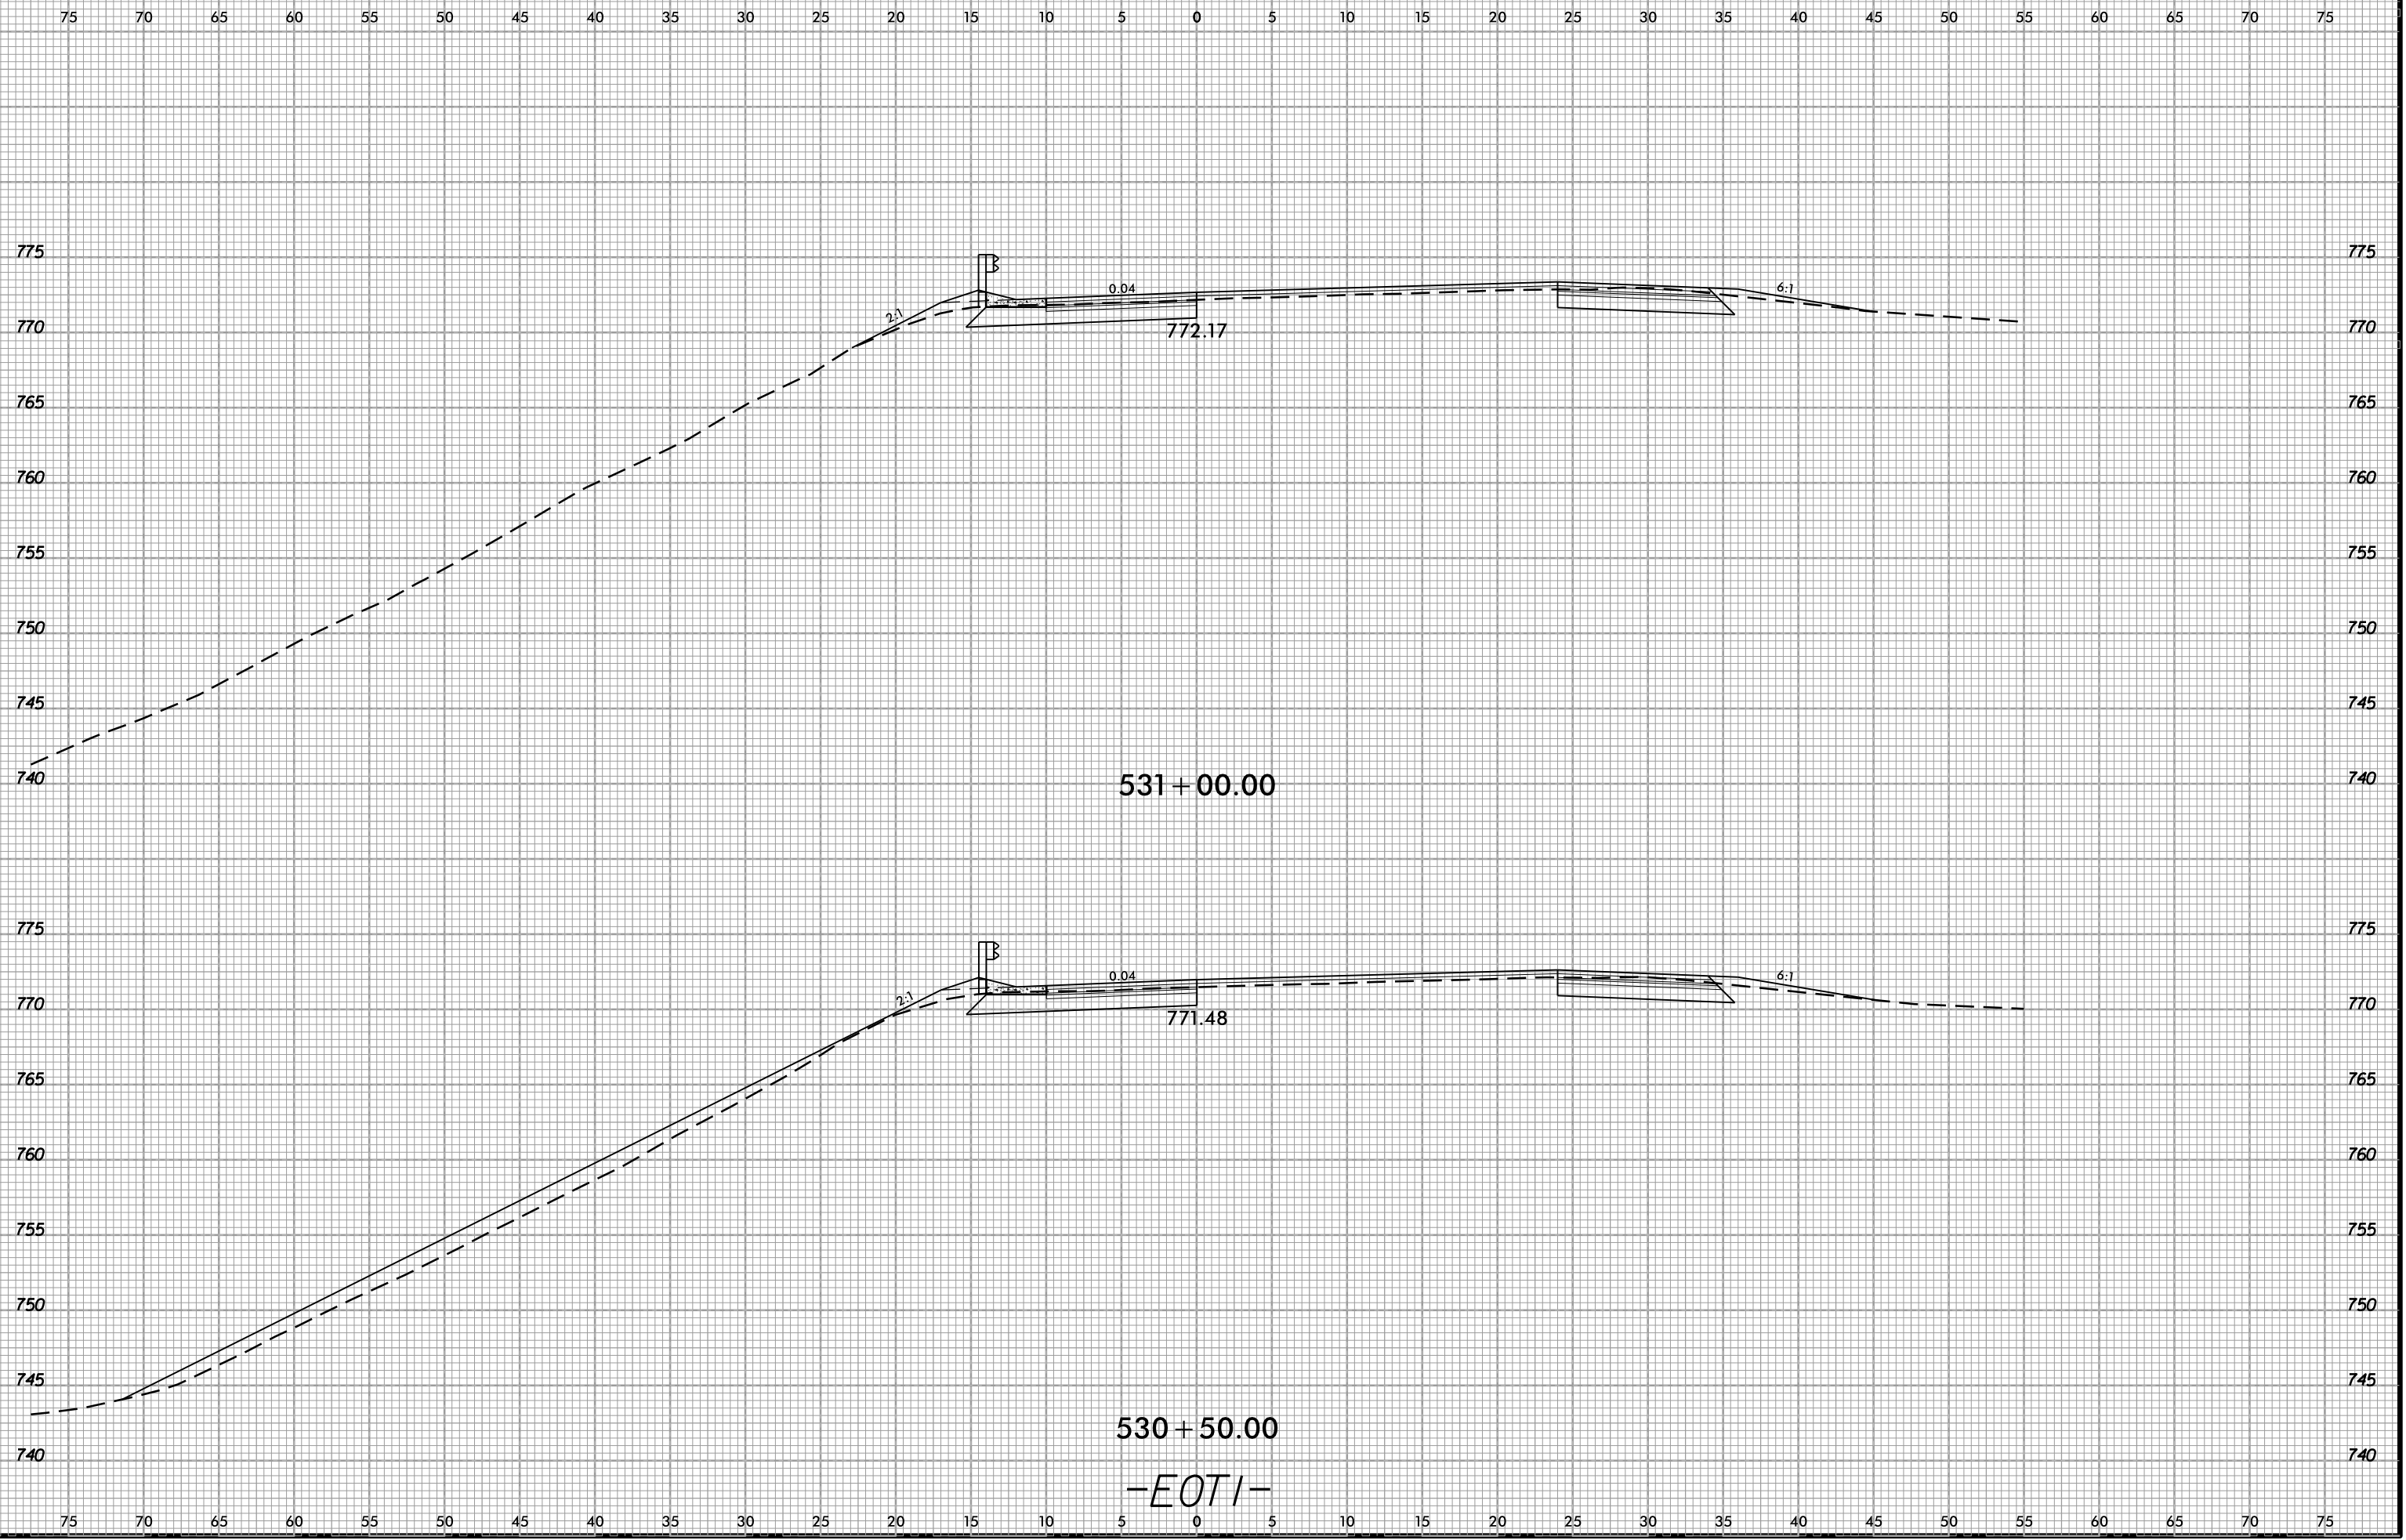

6/23/16  
02-NOV-2018 13:46  
S:\Project-Development\11-5823-140-Dave\Roadway\DesignFiles\5823.dwg - xpl.EOT1.dgn  
AT DIV 29450

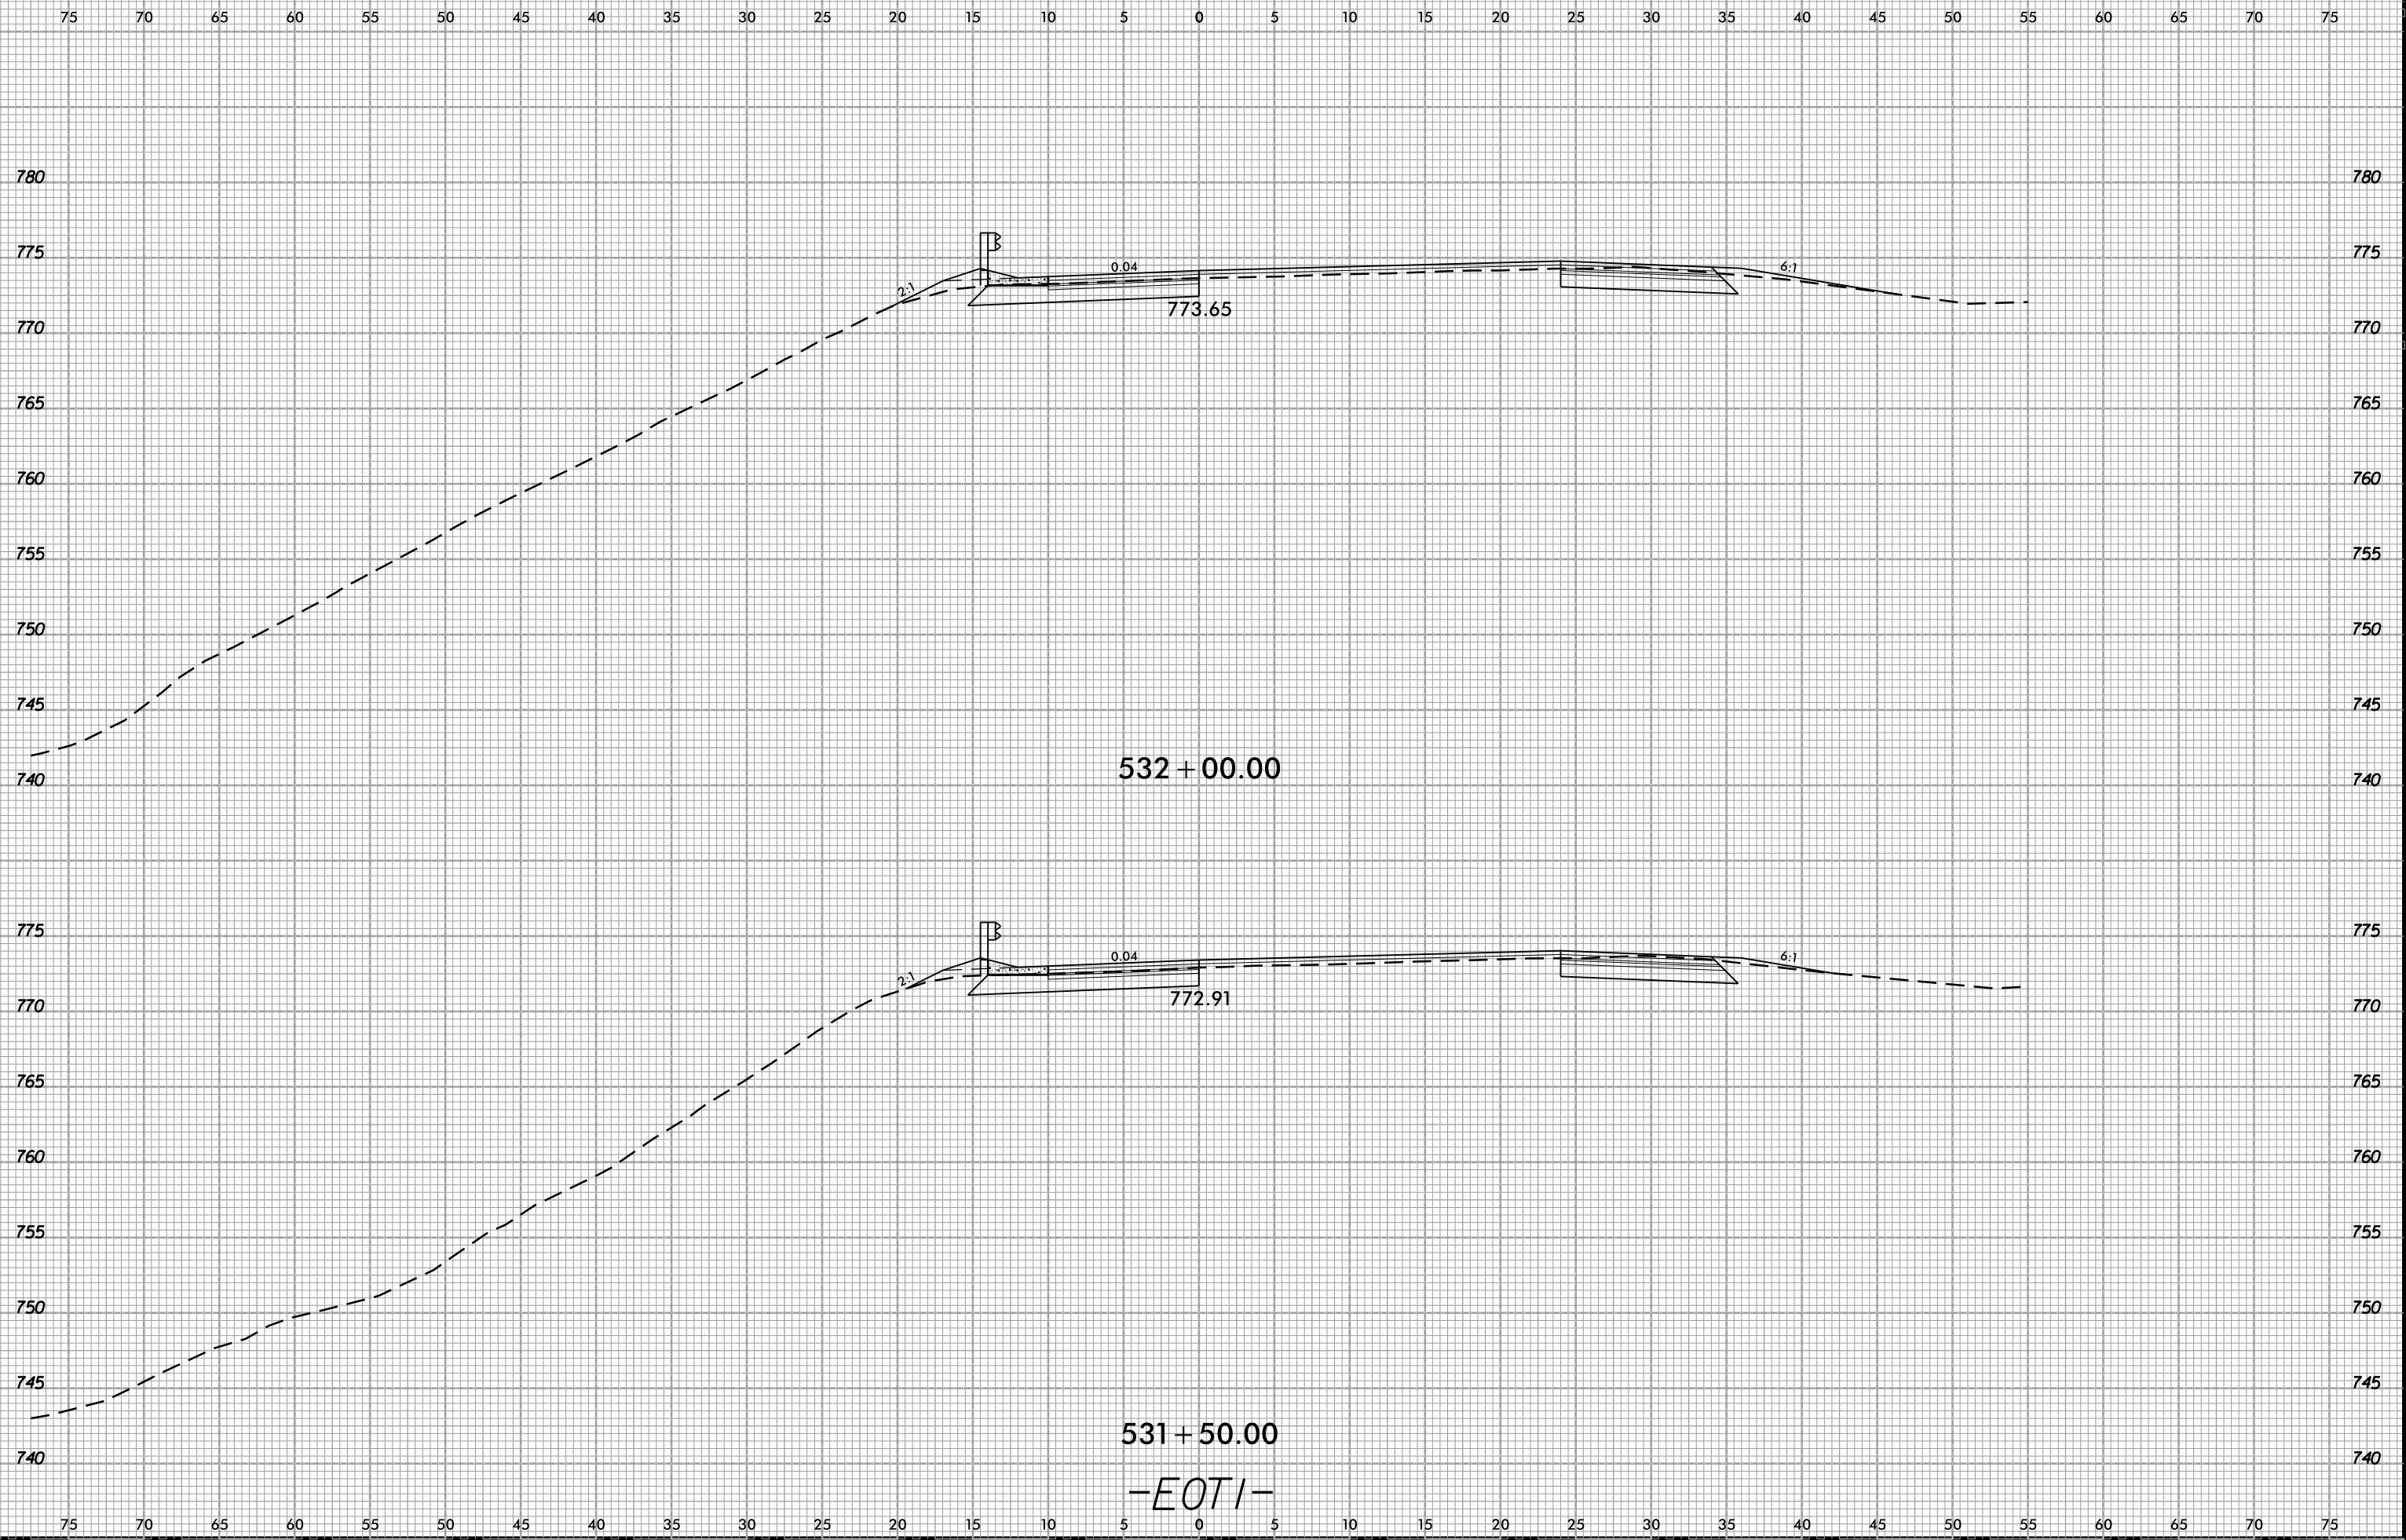

6/23/16  
02-NOV-2018 13:46  
S:\Projects-Development\IP Projects\1-5823-140-Dave\Roadway\DesignFiles\5823.ddc.xpl.EOT1.dgn  
AT DIV 20450

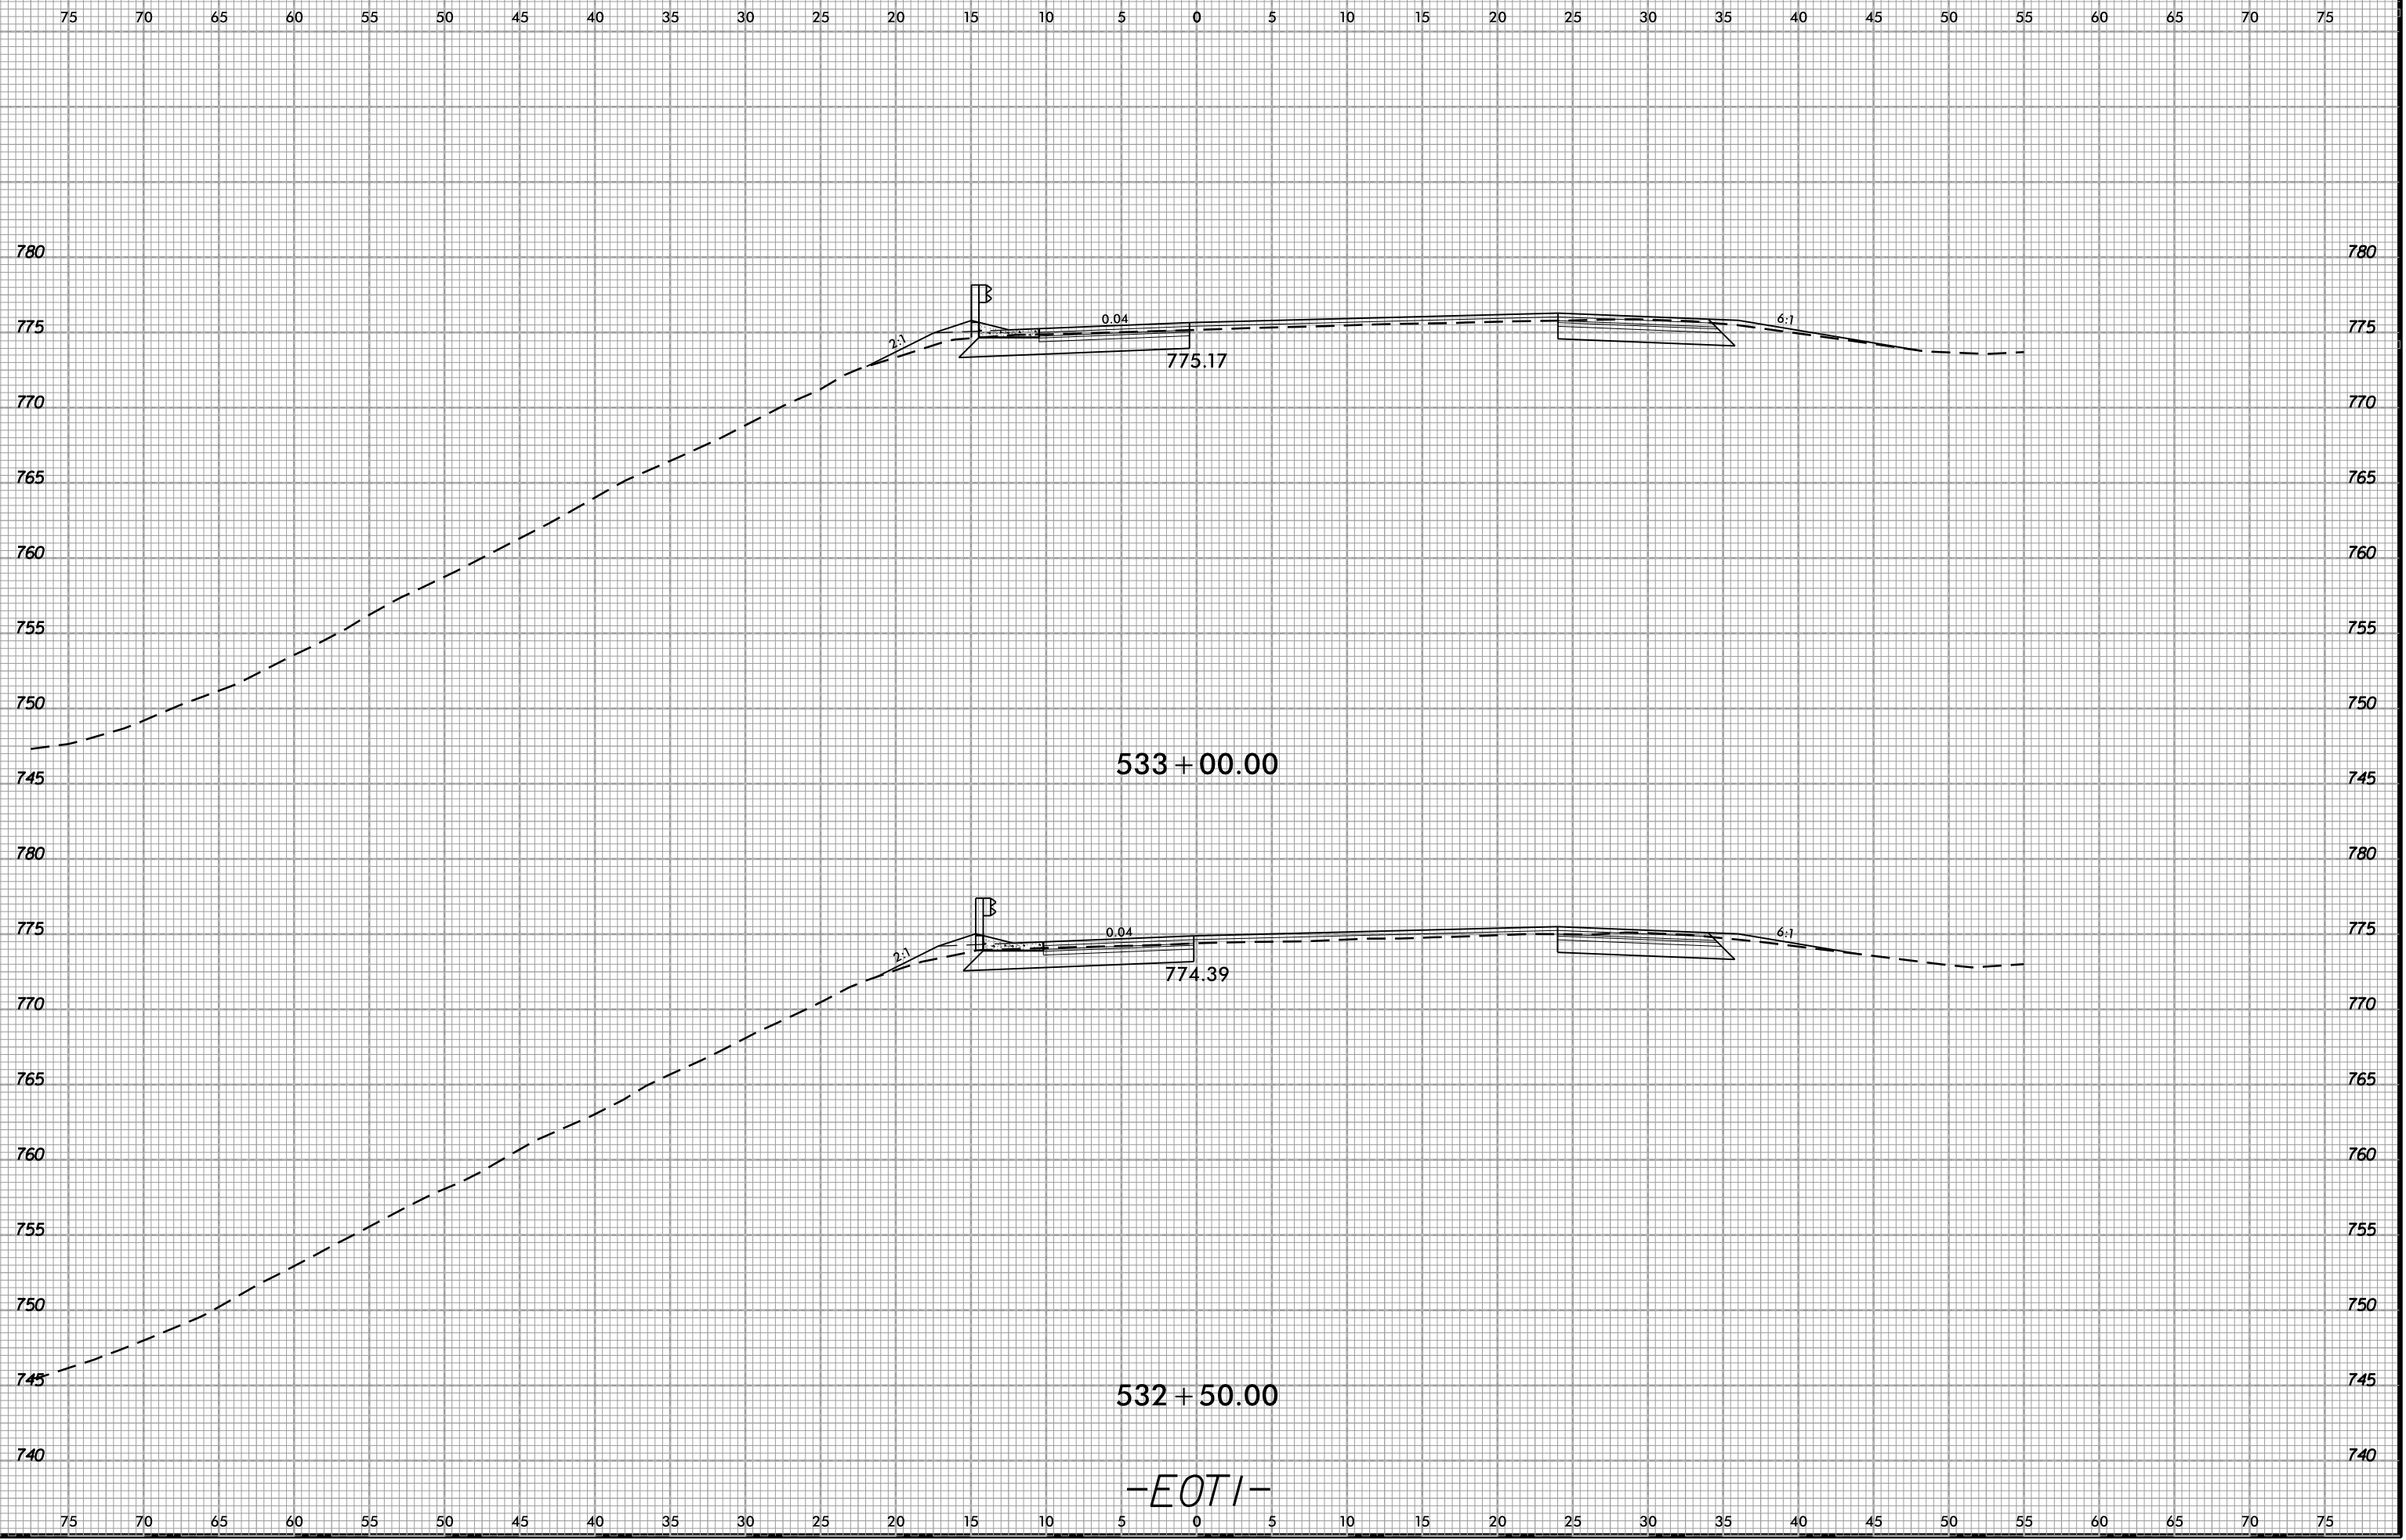


533 + 00.00

532 + 50.00

-EOT1-

6/23/16

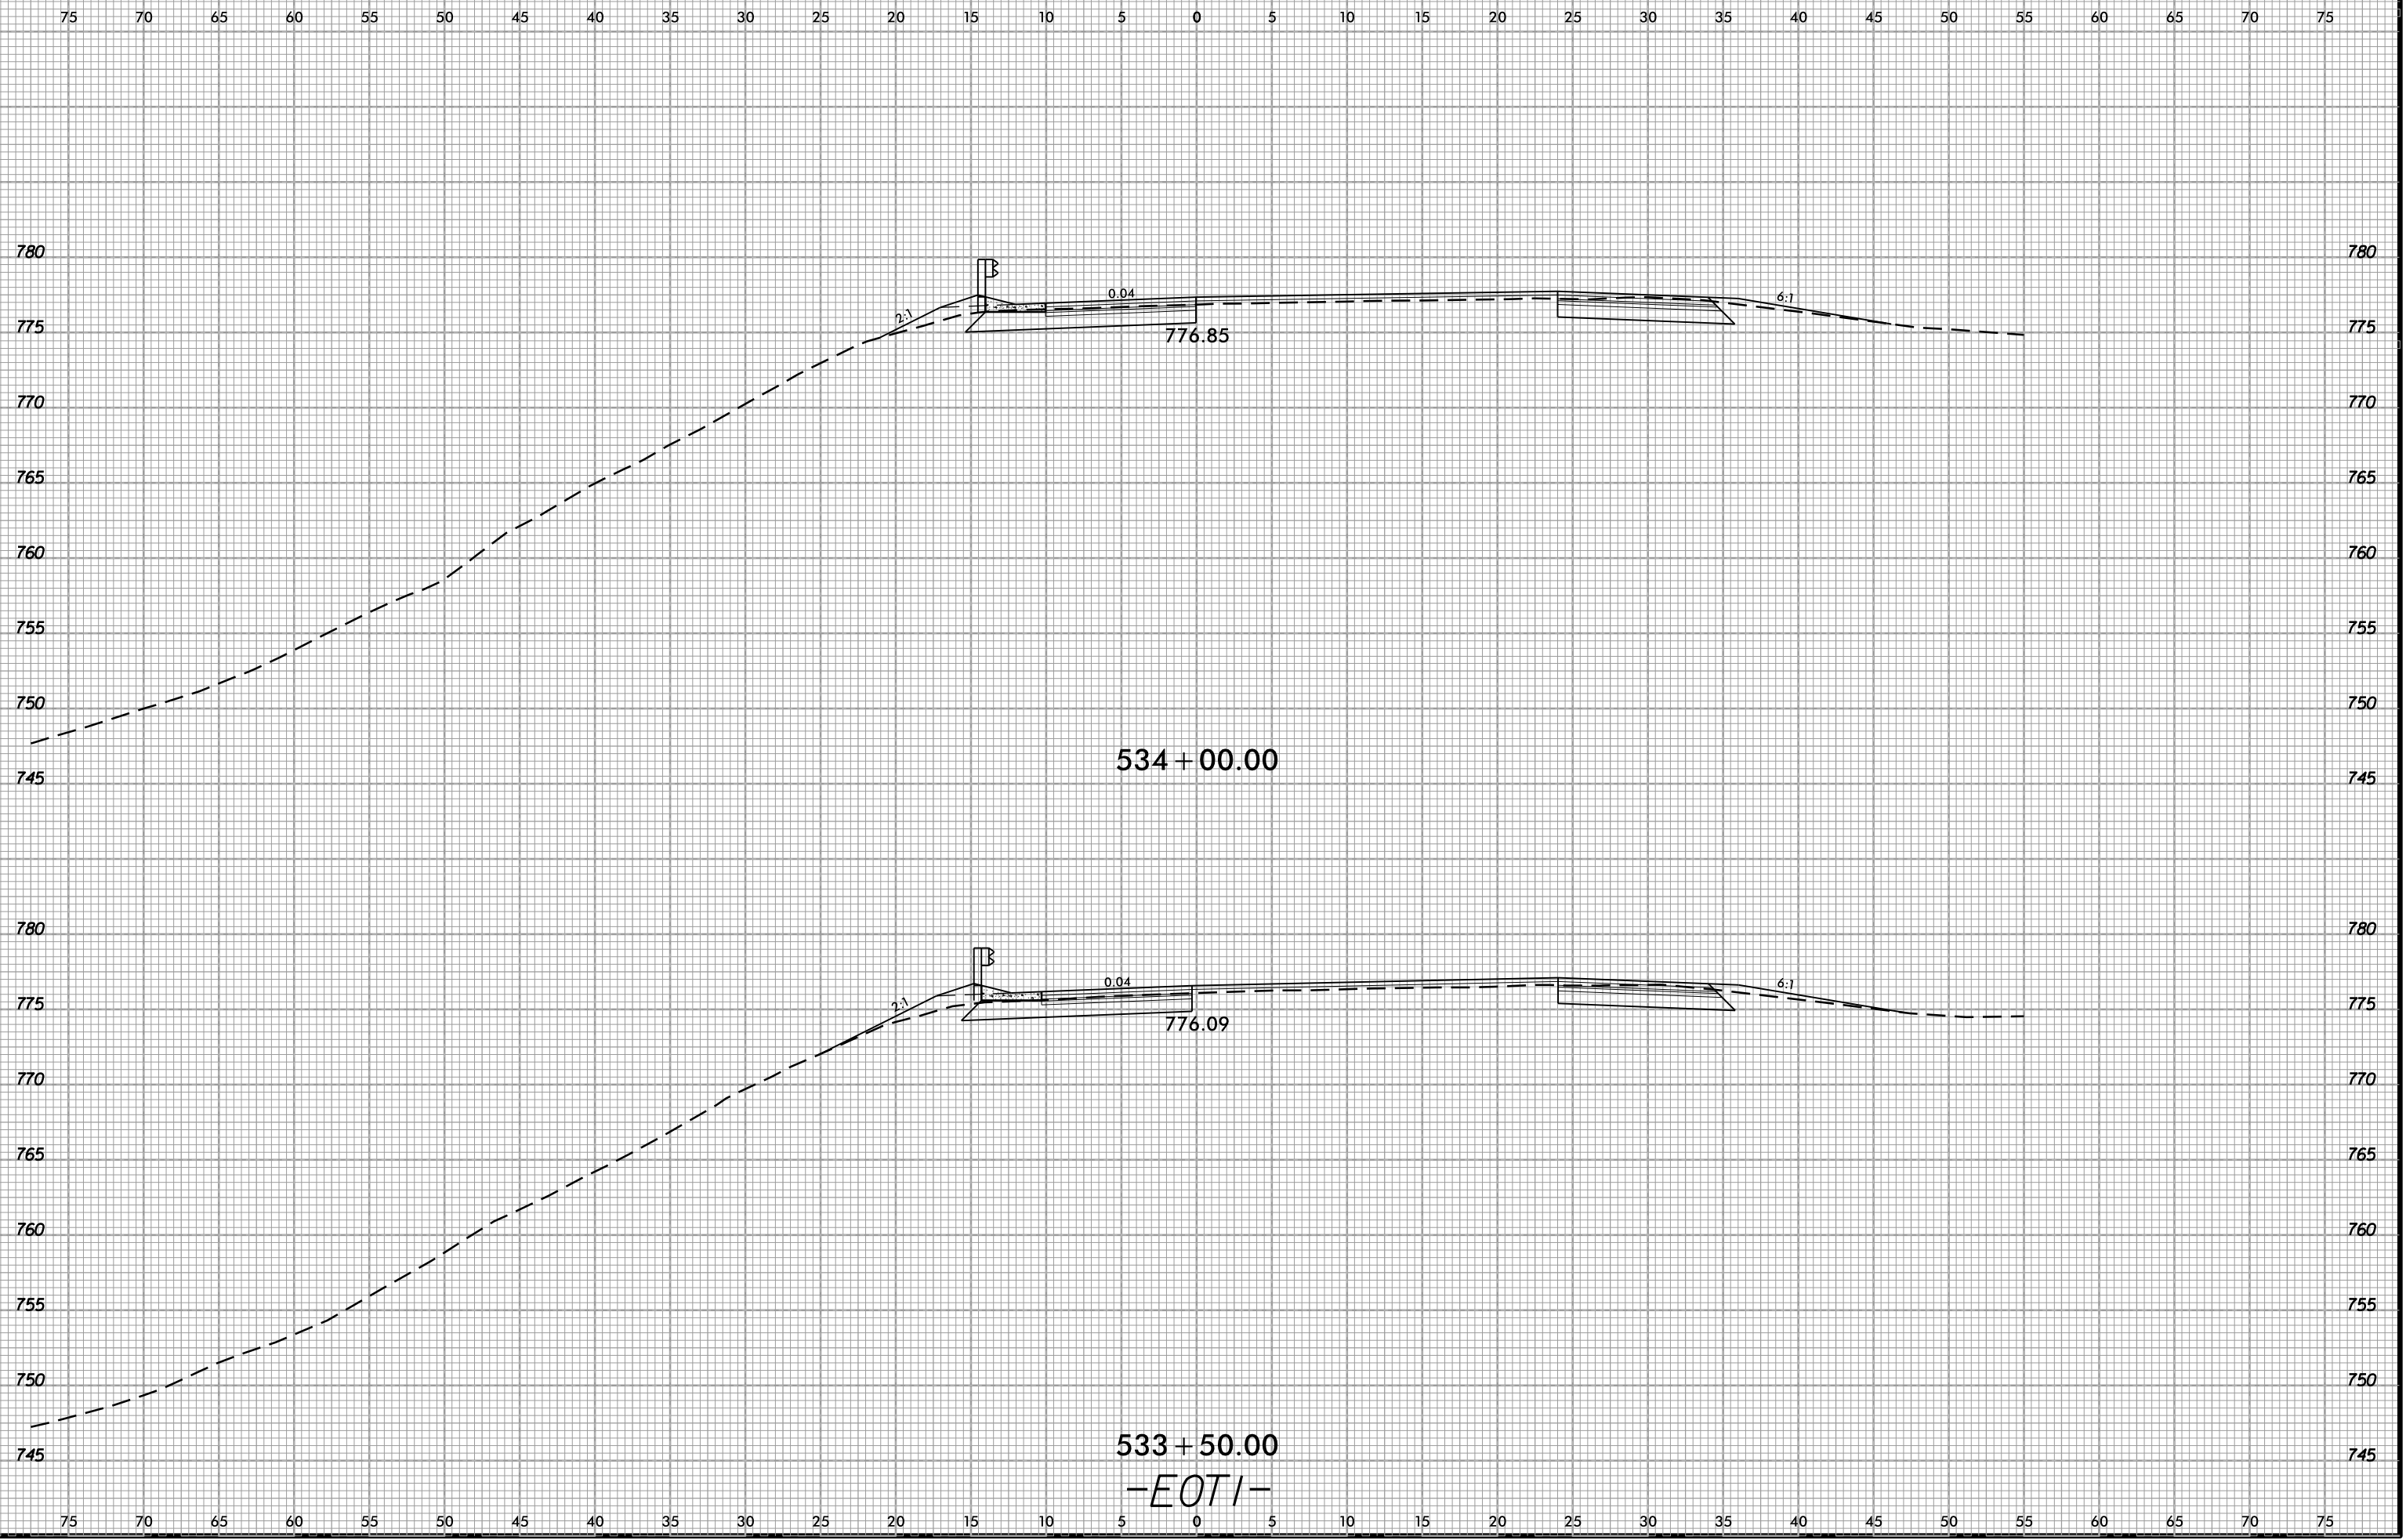


02-NOV-2018 13:47  
S:\Project-Development\11-5823-140-Dave\Roadway\DesignFiles\5823.ddc.xpl.EOT1.dgn  
AT DIV 29450

534 + 00.00


533 + 50.00

-EOT1-

6/23/16  
02-NOV-2018 13:47  
S:\Project-Development\IP Projects\1-5823-140-Dave\Roadway\DesignFiles\5823.ddc.xpl.EOT1.dgn  
AT DIV 2 450

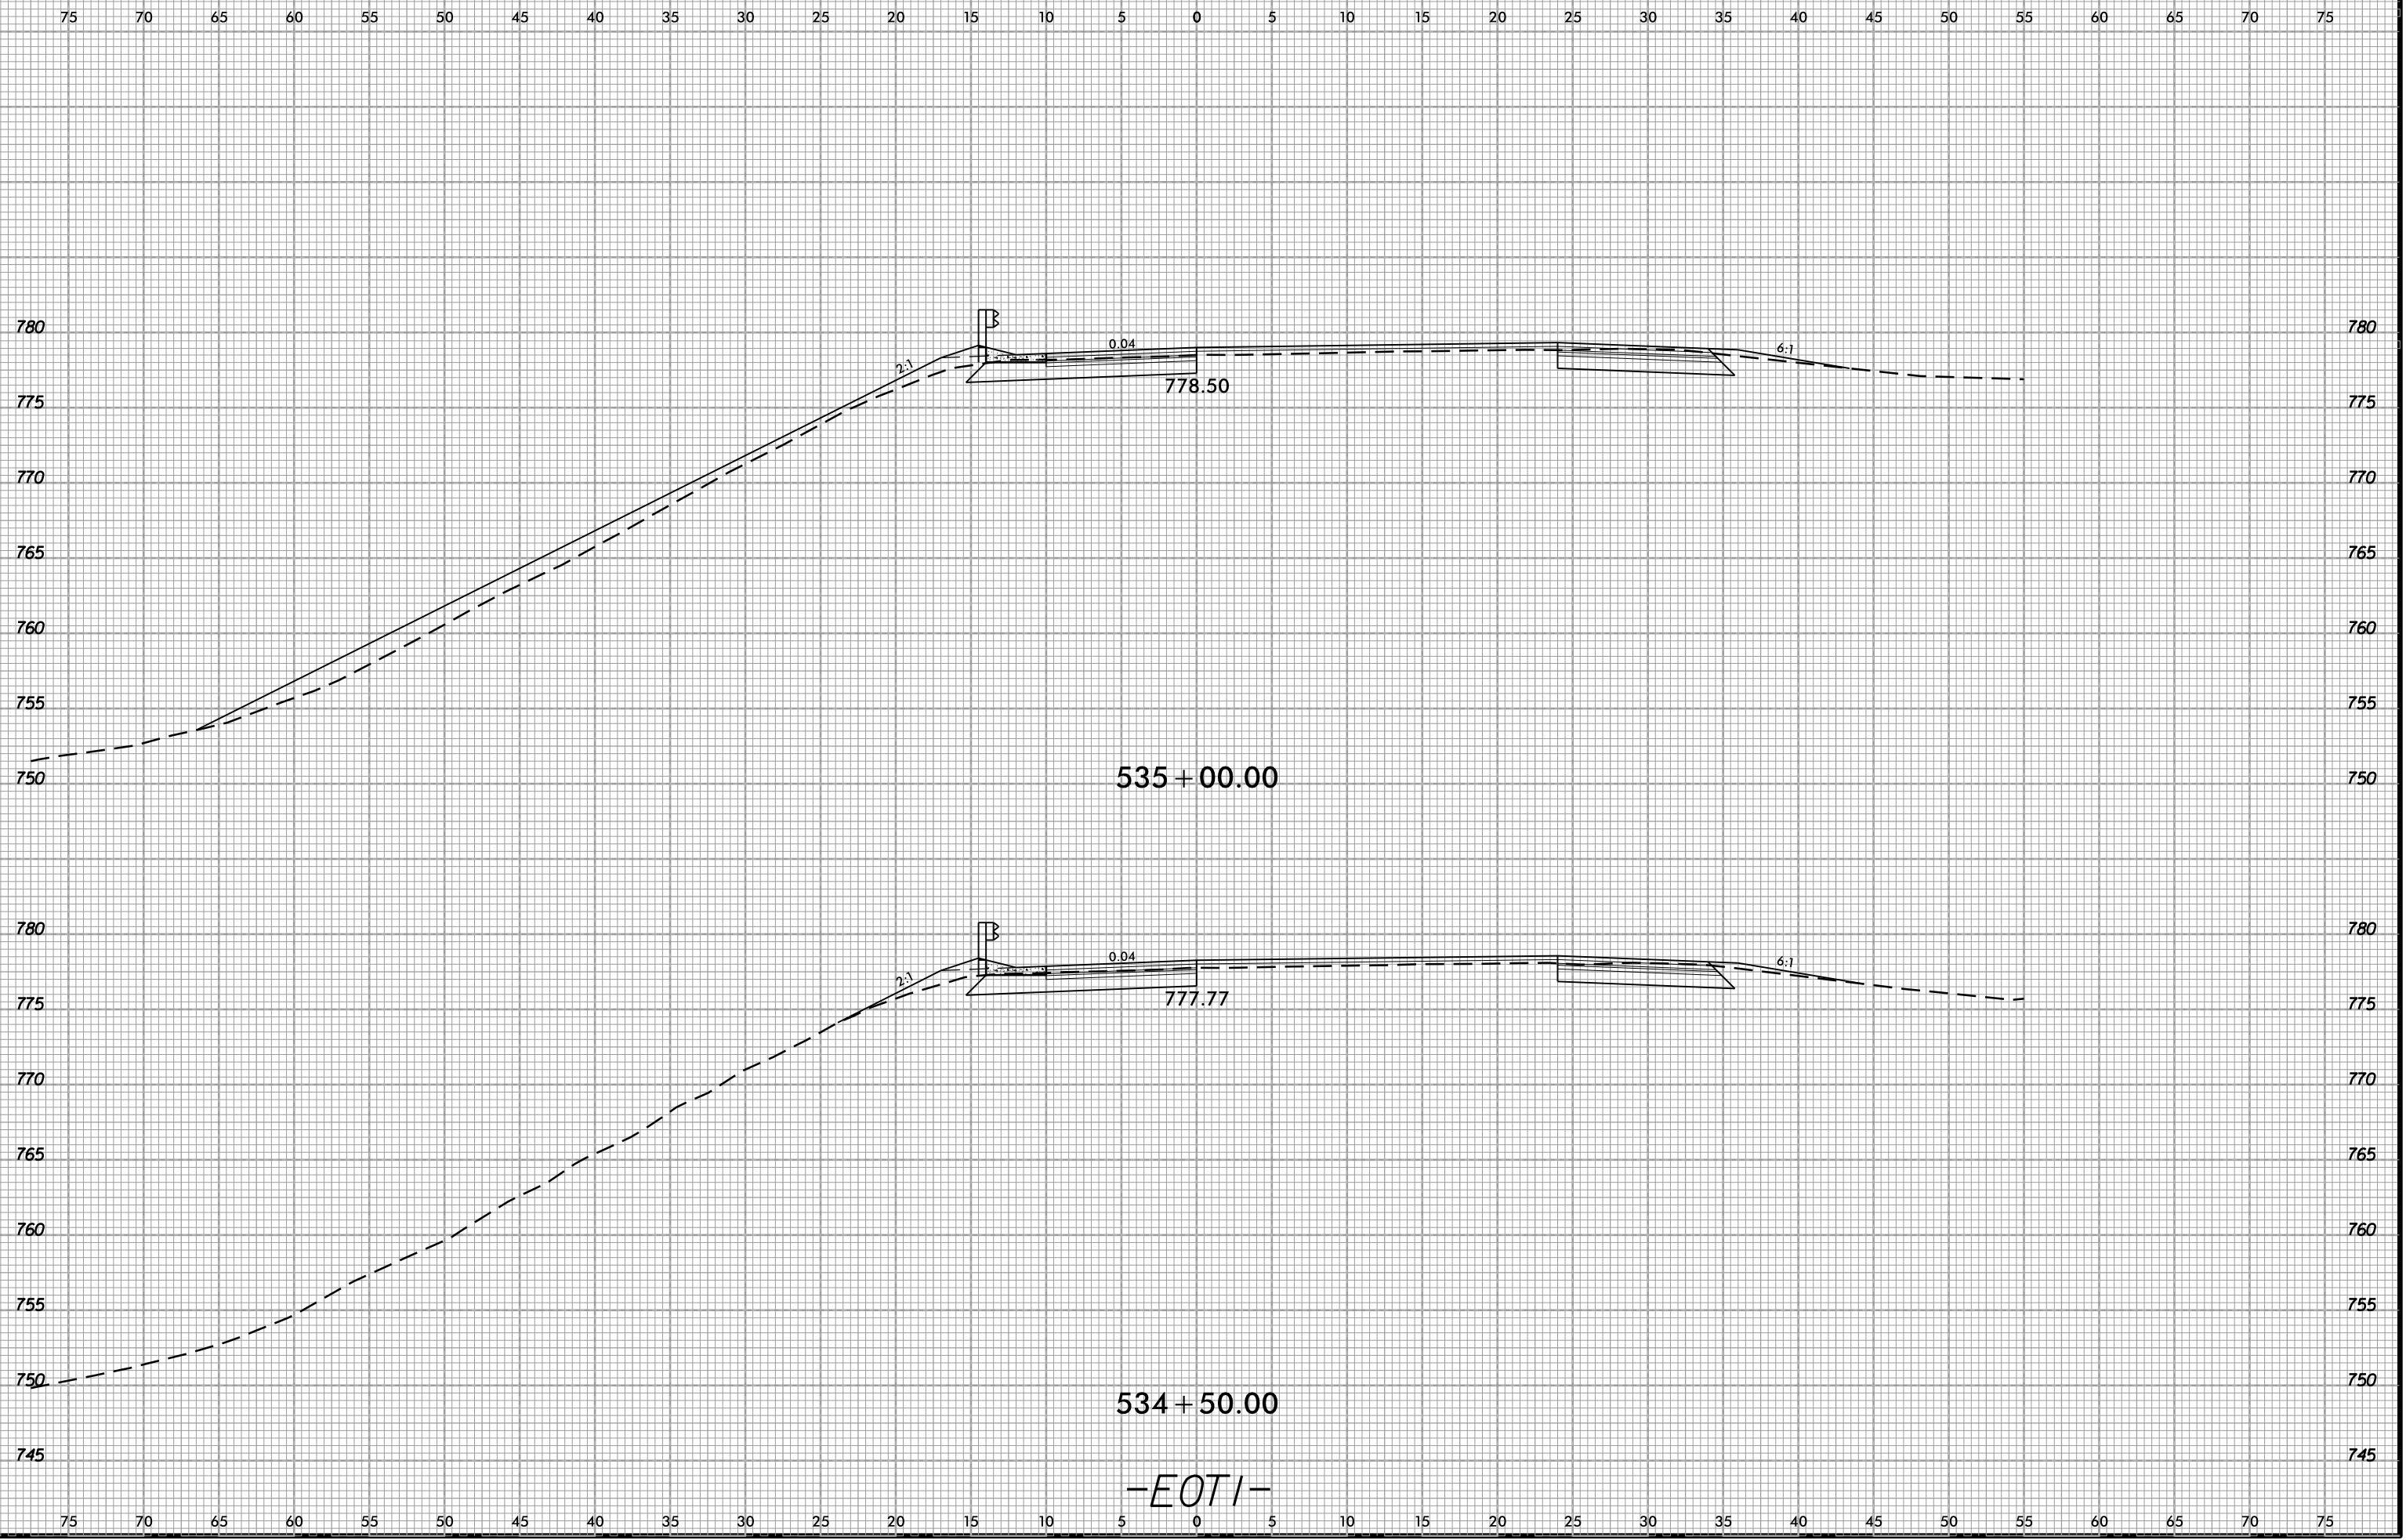


6/23/16  
02-NOV-2018 13:47  
S:\Project-Development\11-5823-140-Dave\Roadway\DesignFiles\5823.ddc.xpl.EOT1.dgn  
AT DIV 29450

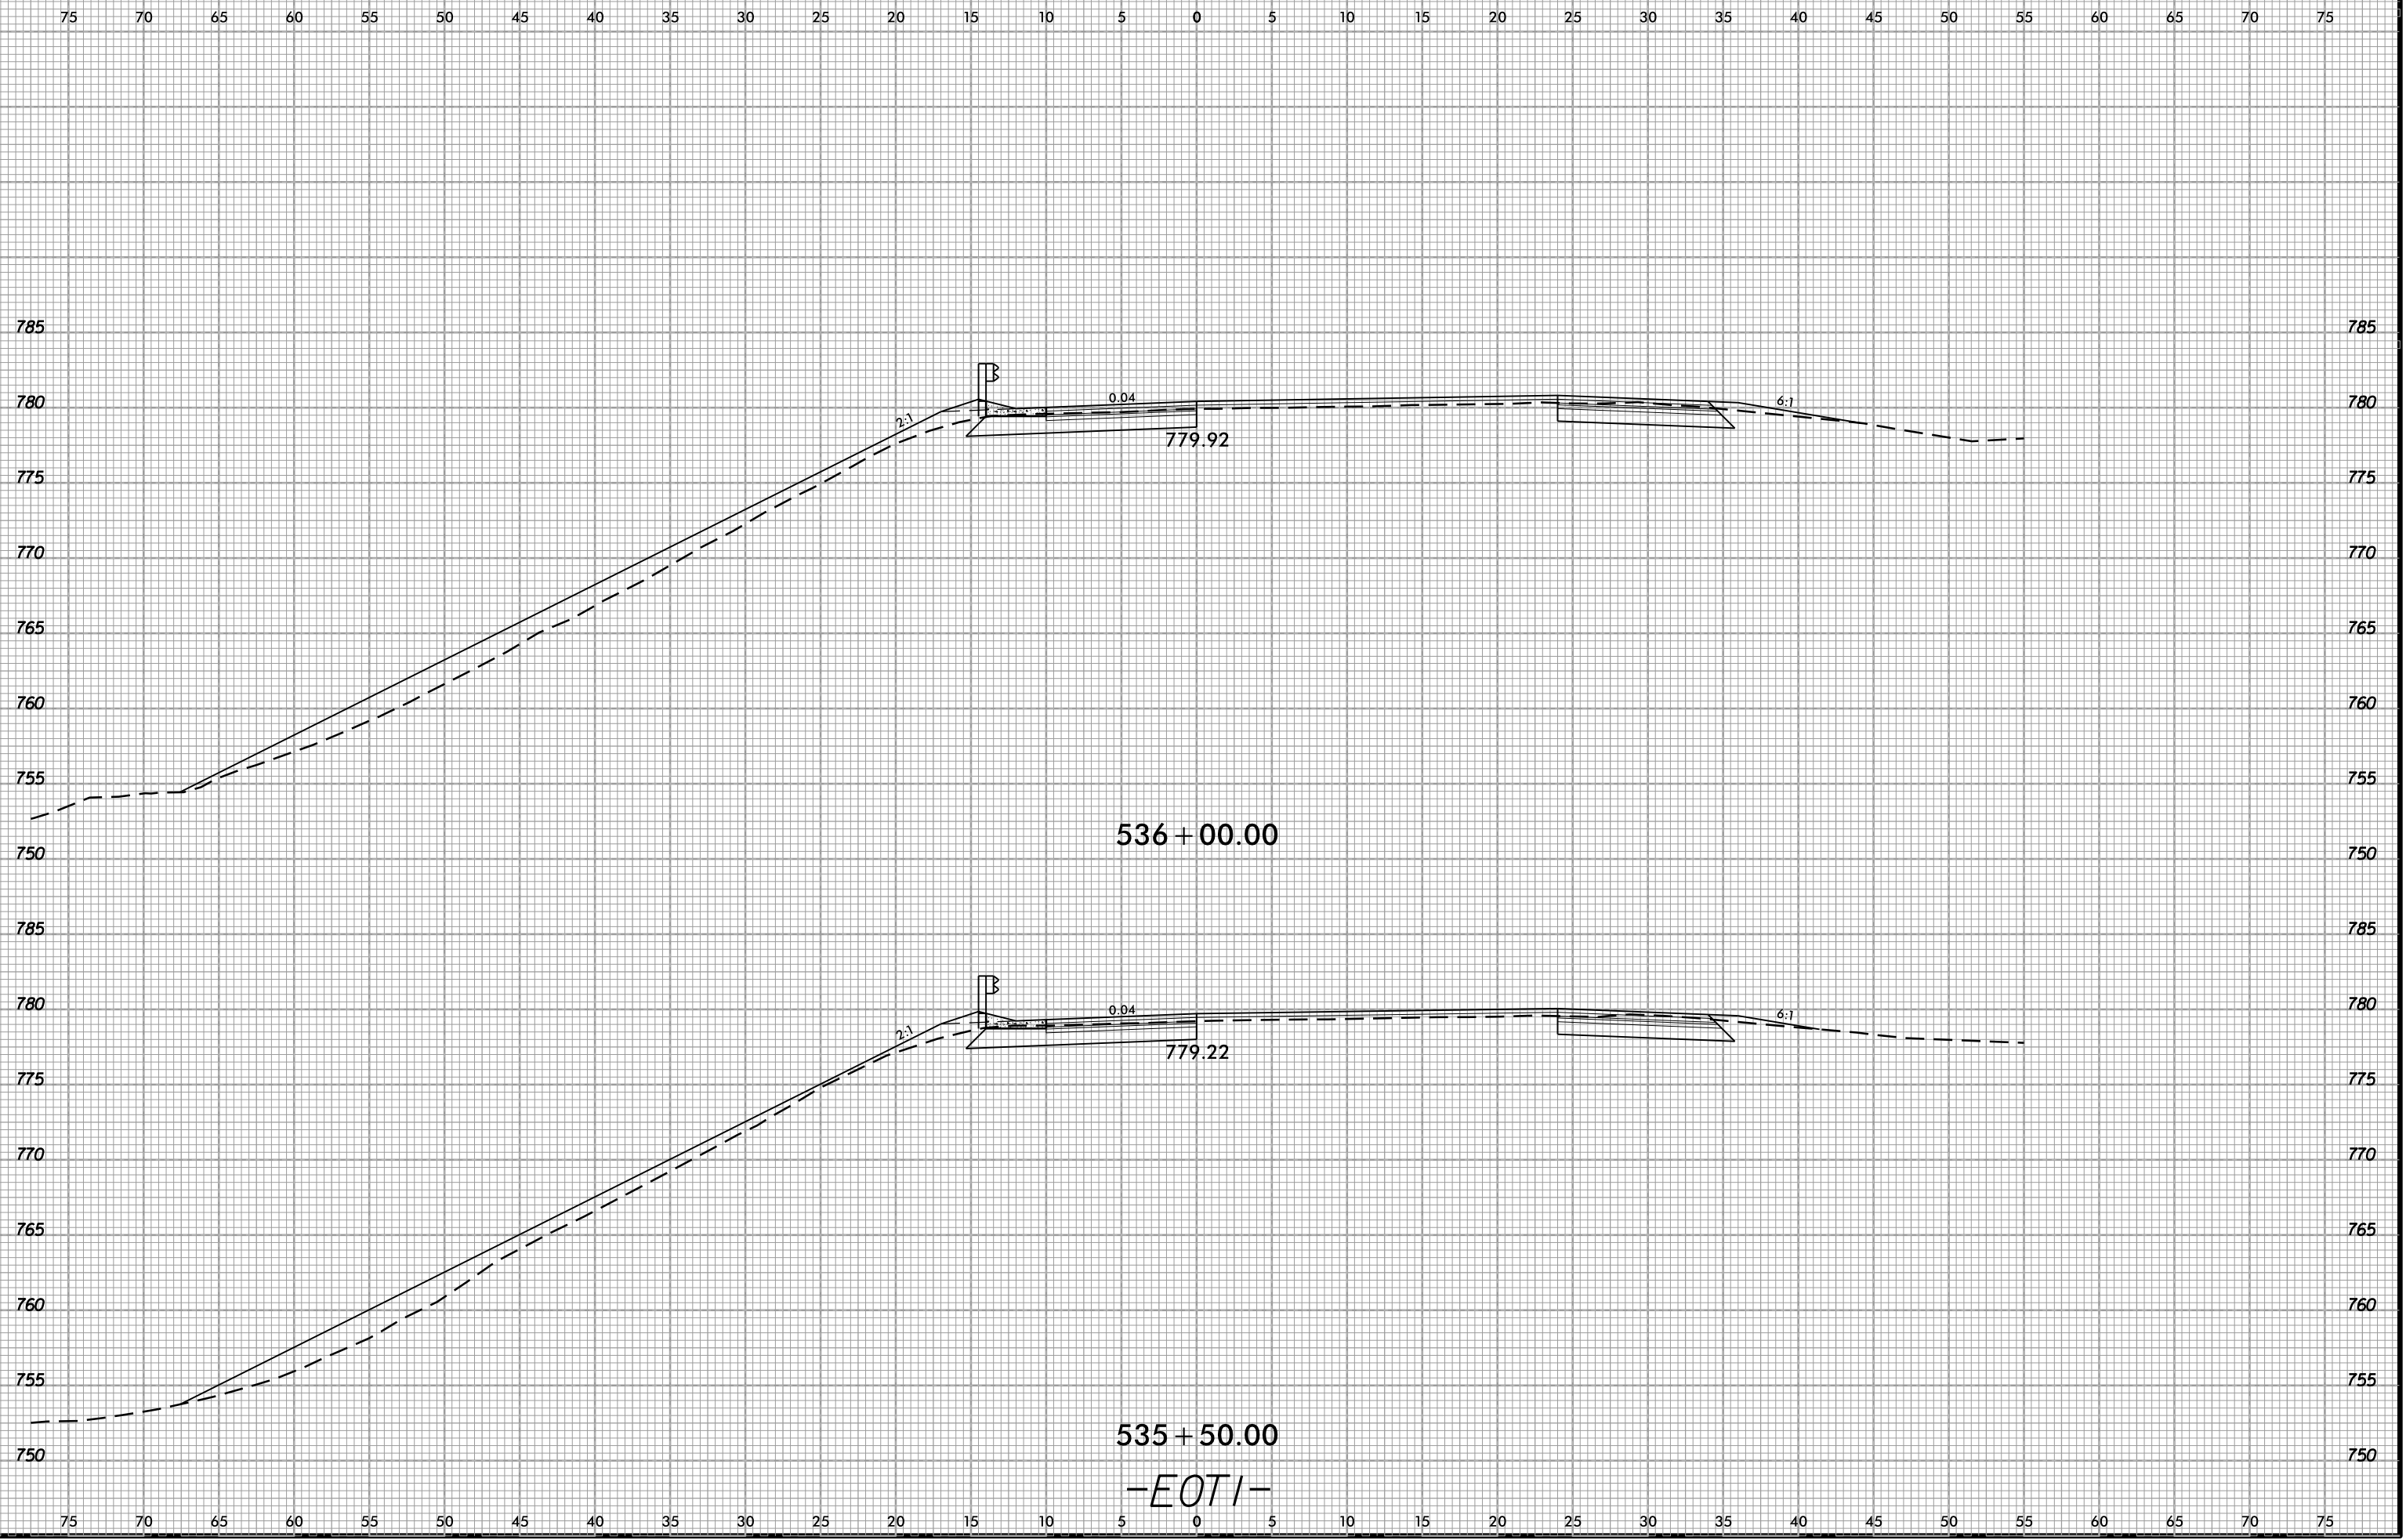





6/23/16  
02-NOV-2018 13:47  
S:\Project-Development\IP Projects\1-5823-140-Dave\Roadway\DesignFiles\5823.ddc.xpl.EOT1.dgn  
AT DIV 2 450

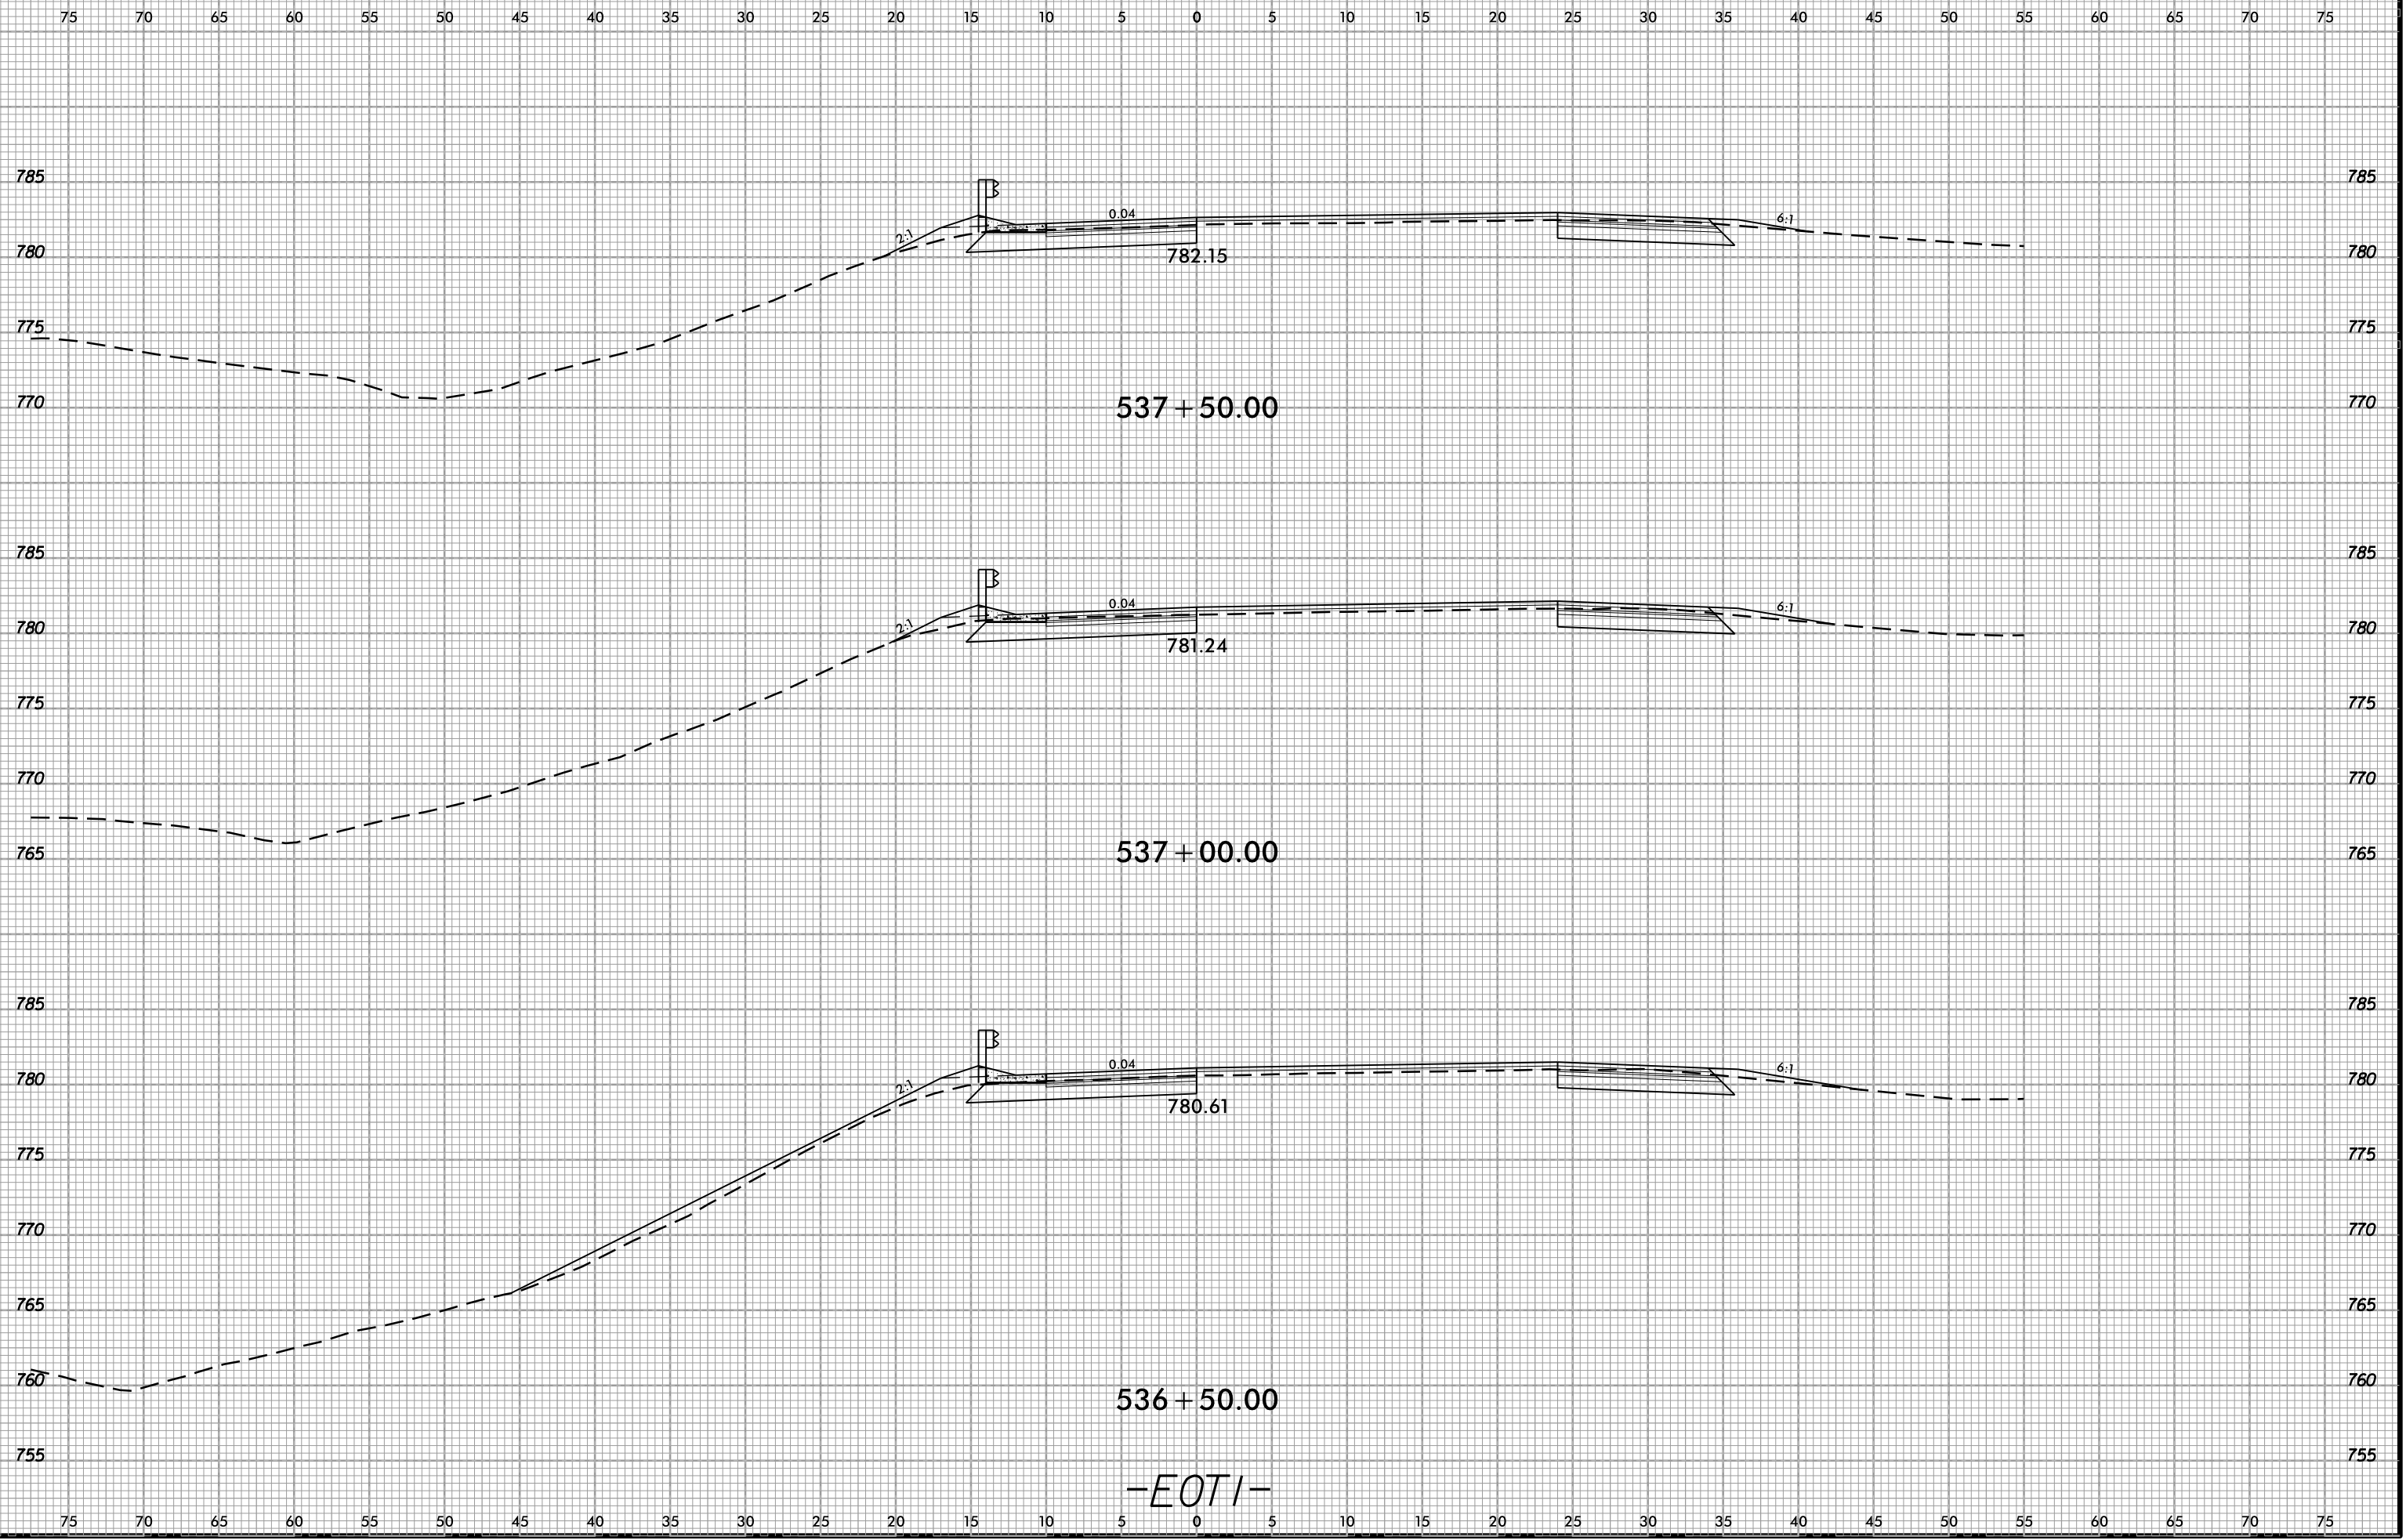

-EOT1-

75 70 65 60 55 50 45 40 35 30 25 20 15 10 5 0 5 10 15 20 25 30 35 40 45 50 55 60 65 70 75

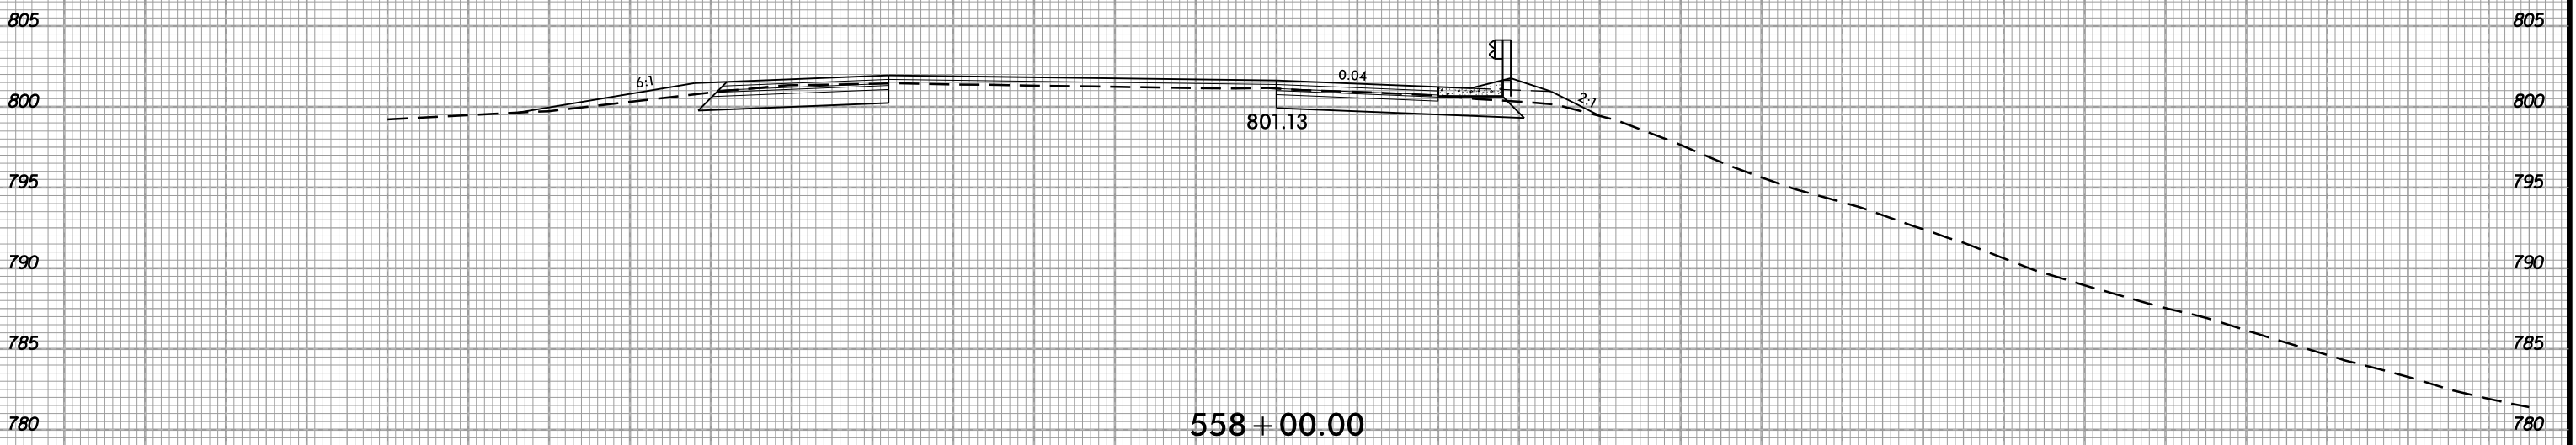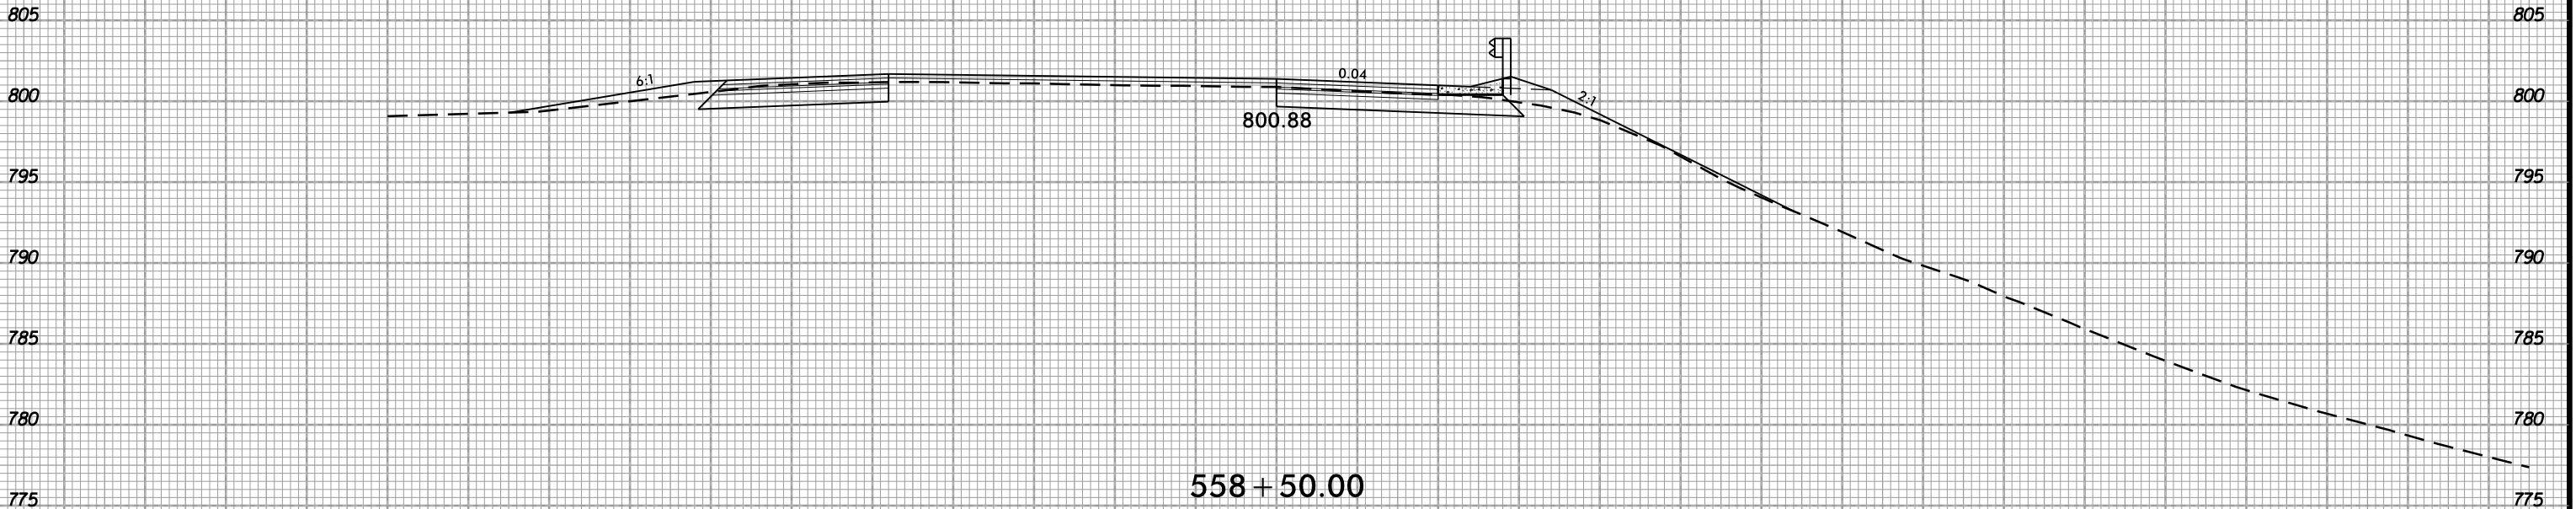

-EOT2-

75 70 65 60 55 50 45 40 35 30 25 20 15 10 5 0 5 10 15 20 25 30 35 40 45 50 55 60 65 70 75


6/23/16  
02-NOV-2018 13:47  
S:\Projects-Development\IP Projects\140-Dave\Roadway\DesignFiles\5823.ddc.xpl.EOT2.dgn  
Mike@ion




PROJ. REFERENCE NO.  
I-5823

SHEET NO.  
X-10

75 70 65 60 55 50 45 40 35 30 25 20 15 10 5 0 5 10 15 20 25 30 35 40 45 50 55 60 65 70 75

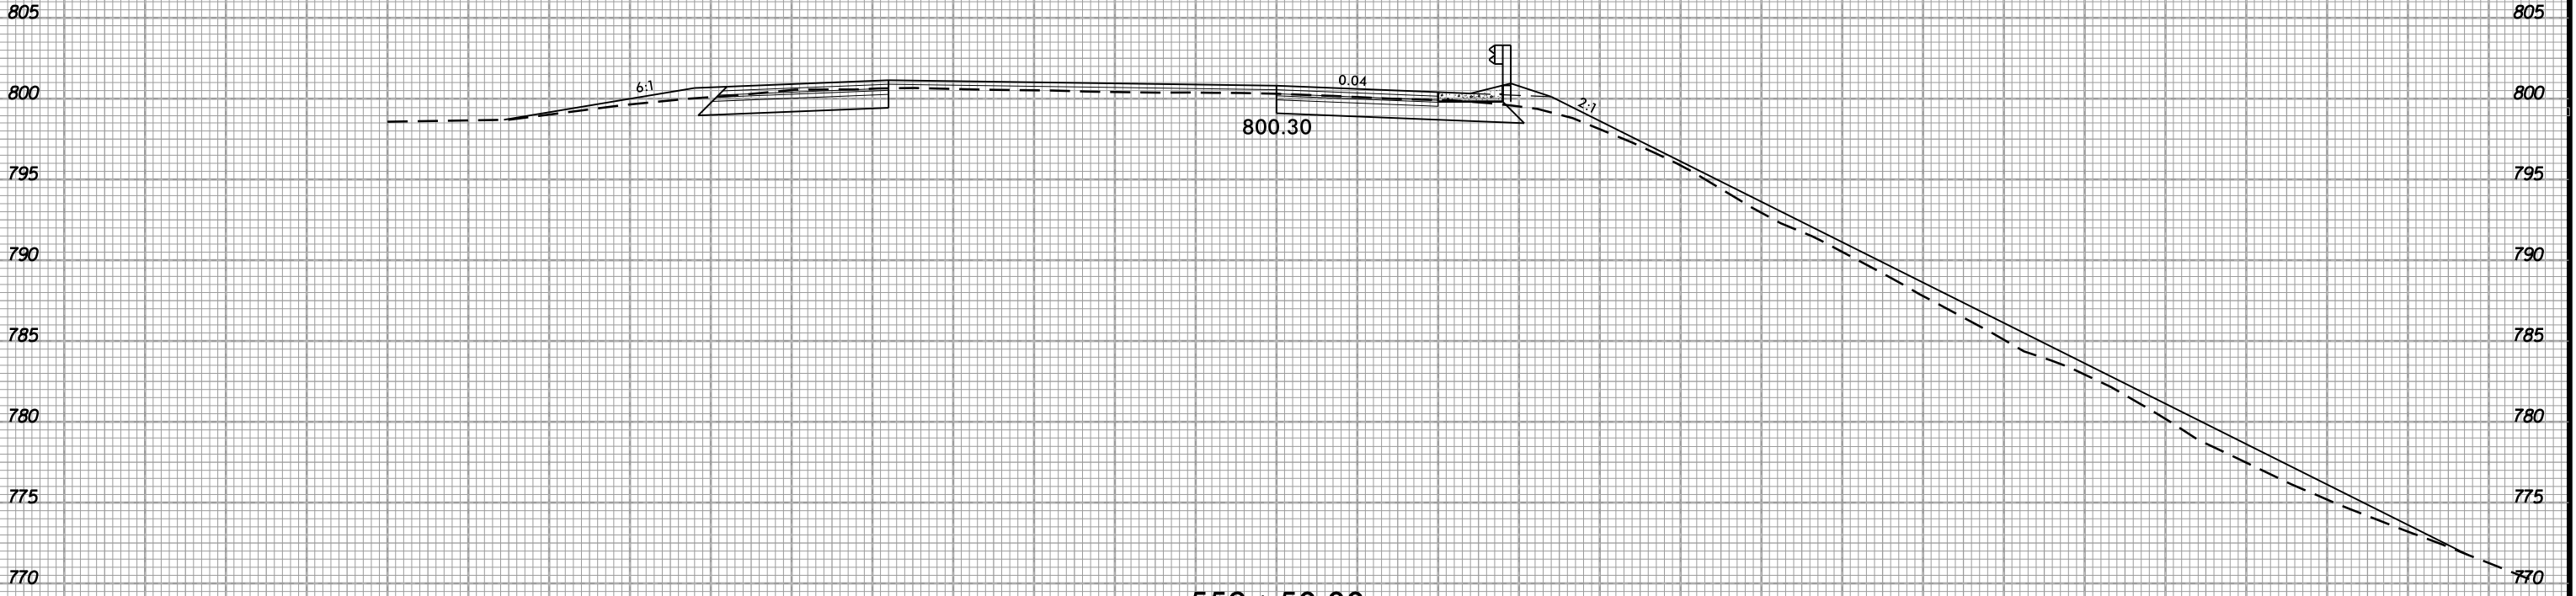

559 + 50.00

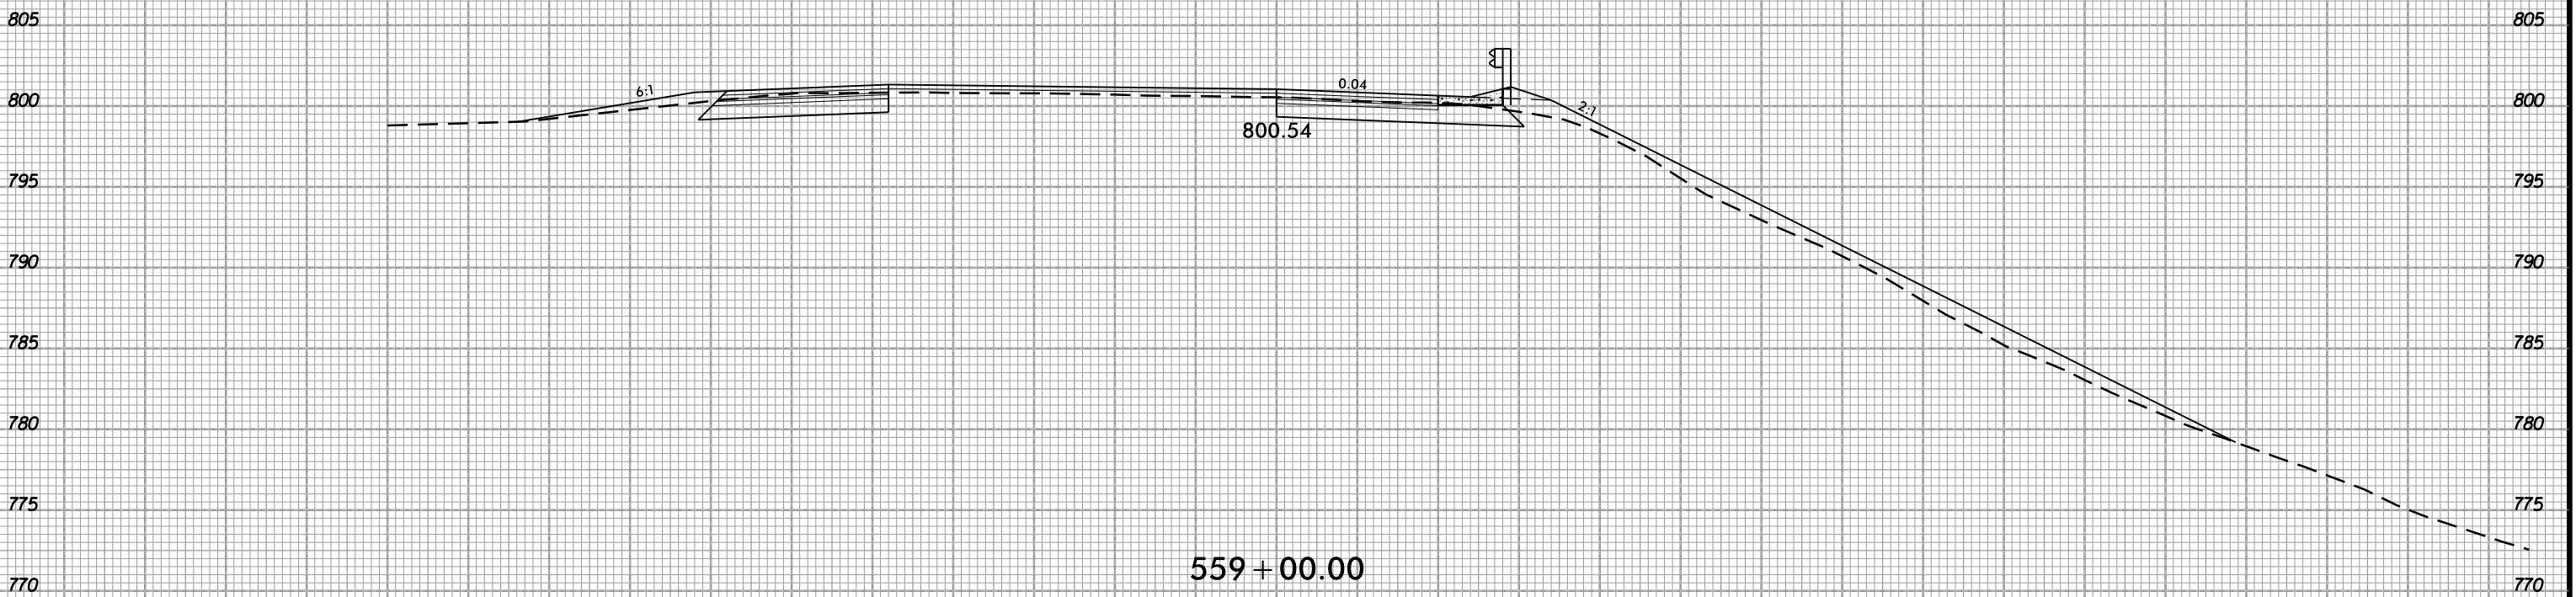


559 + 00.00


-EOT2-

75 70 65 60 55 50 45 40 35 30 25 20 15 10 5 0 5 10 15 20 25 30 35 40 45 50 55 60 65 70 75

6/23/16  
02-NOV-2018 13:47  
S:\Project-Development\IP Projects\140-Dave\Roadway\DesignFiles\5823.ddc.xpl.EOT2.dgn  
Mike@ion

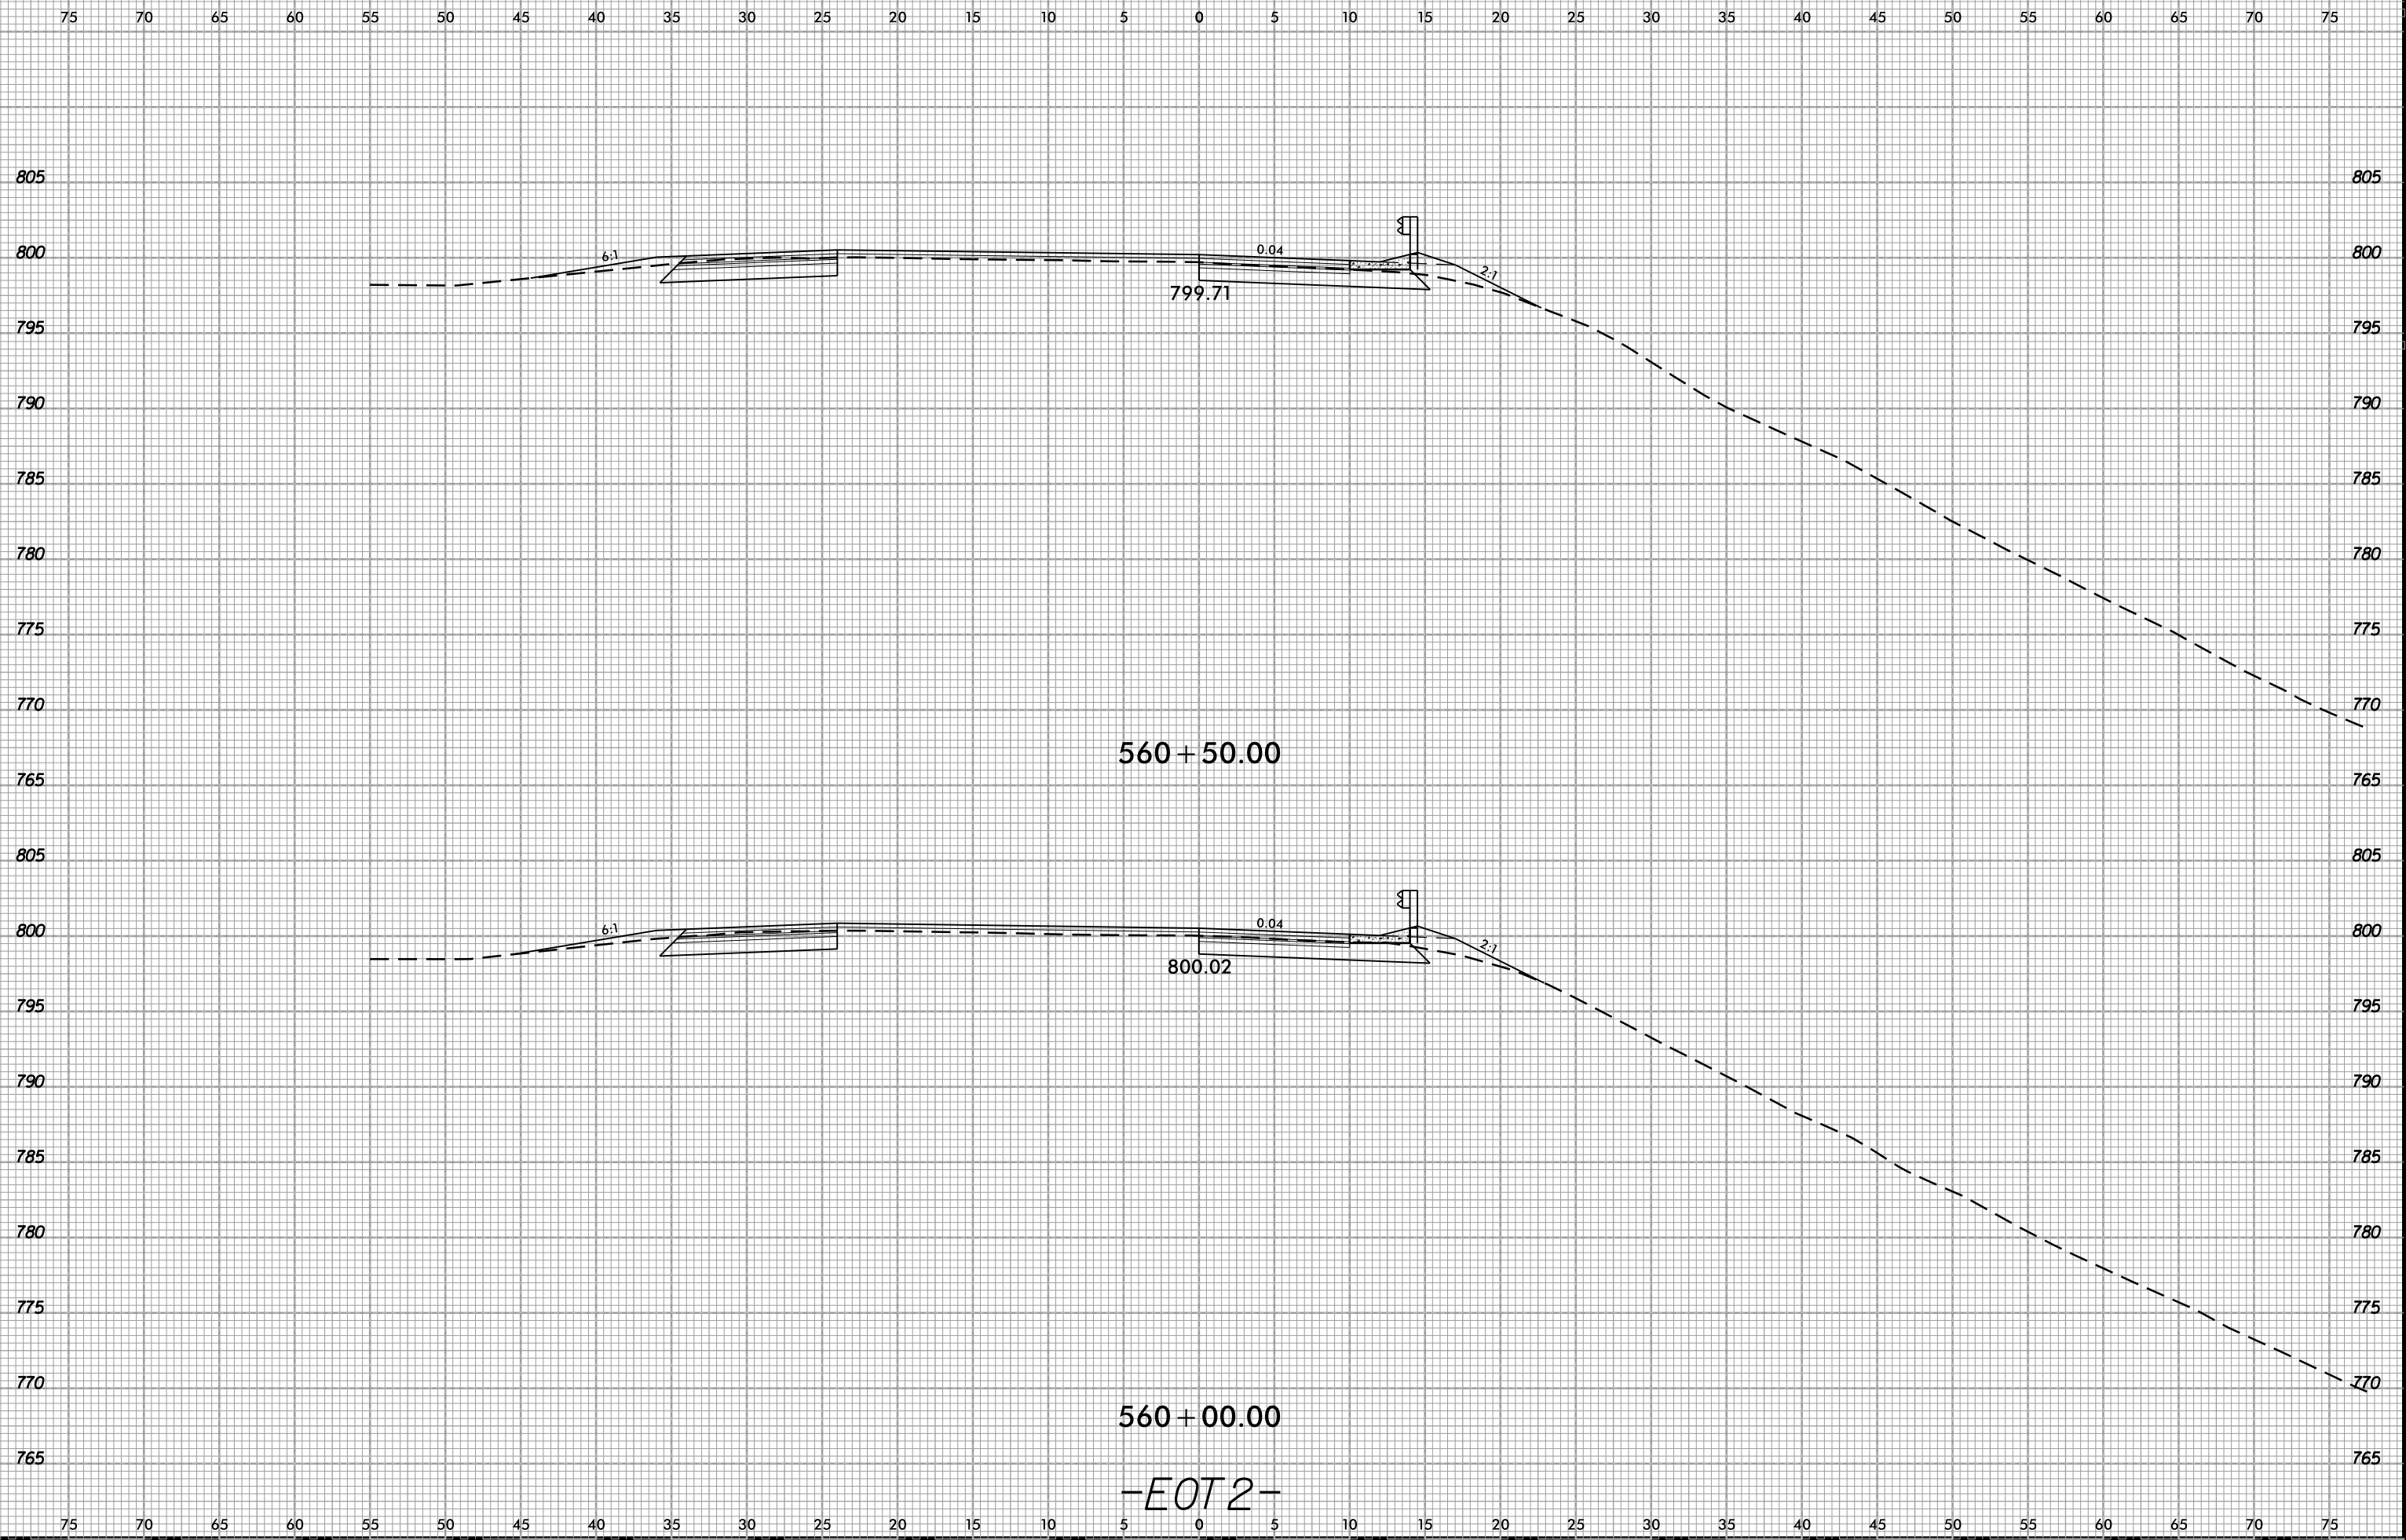



6/23/16

 

PROJ. REFERENCE NO. I-5823

SHEET NO. X-12

75 70 65 60 55 50 45 40 35 30 25 20 15 10 5 0 5 10 15 20 25 30 35 40 45 50 55 60 65 70 75

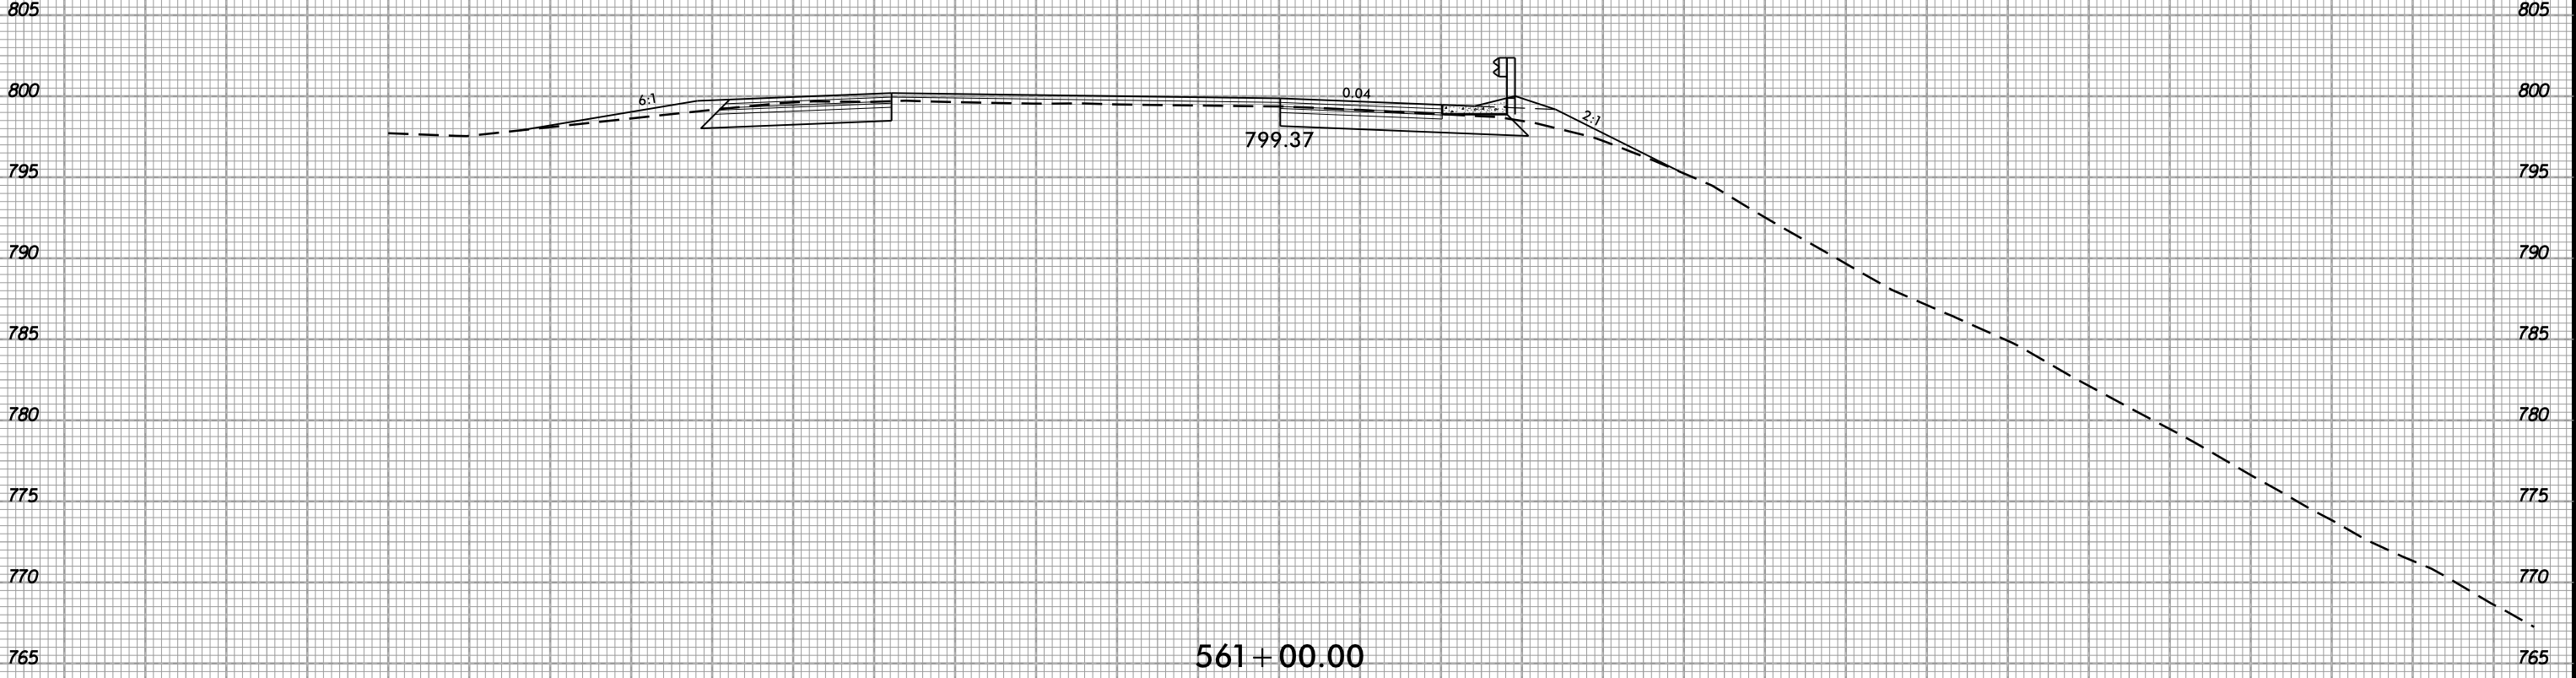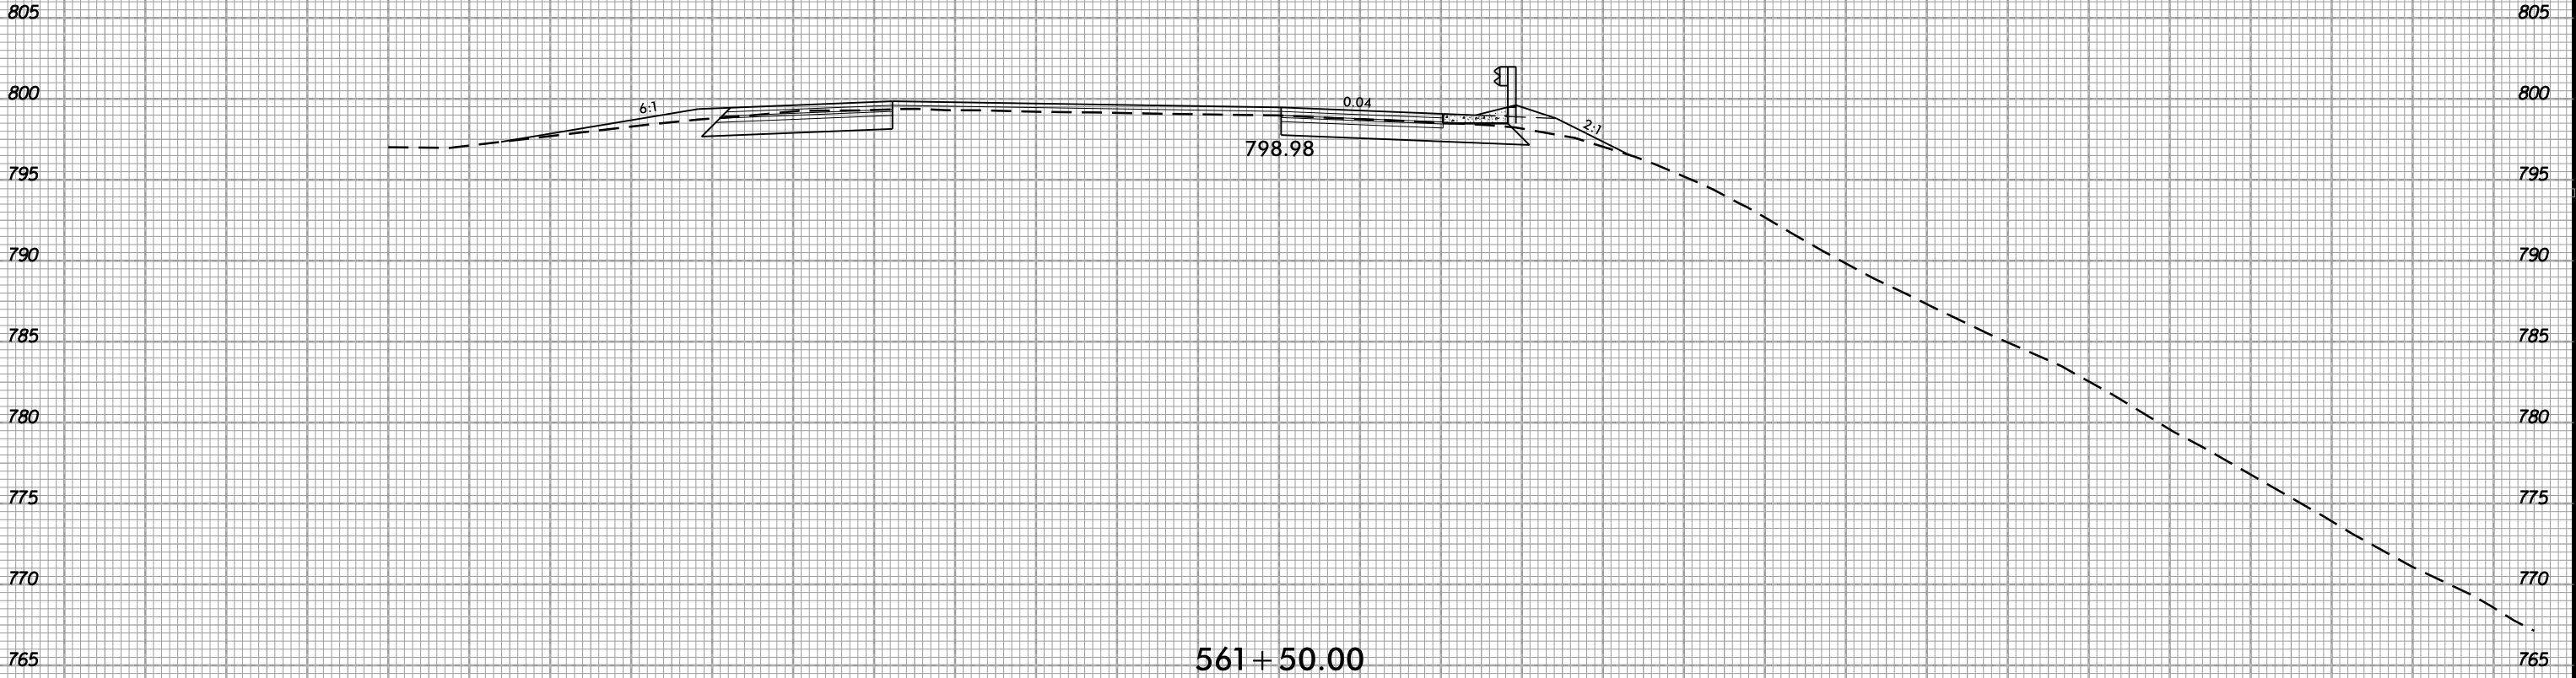


561+00.00  
-EOT2-

02-NOV-2018 13:47  
S:\Projects-Development\IIP Projects\I-5823-140-Dave\Roadway\DesignFiles\5823.ddc.xpl.EOT2.dgn  
Ikeation AT DIV 294550

75 70 65 60 55 50 45 40 35 30 25 20 15 10 5 0 5 10 15 20 25 30 35 40 45 50 55 60 65 70 75

75 70 65 60 55 50 45 40 35 30 25 20 15 10 5 0 5 10 15 20 25 30 35 40 45 50 55 60 65 70 75

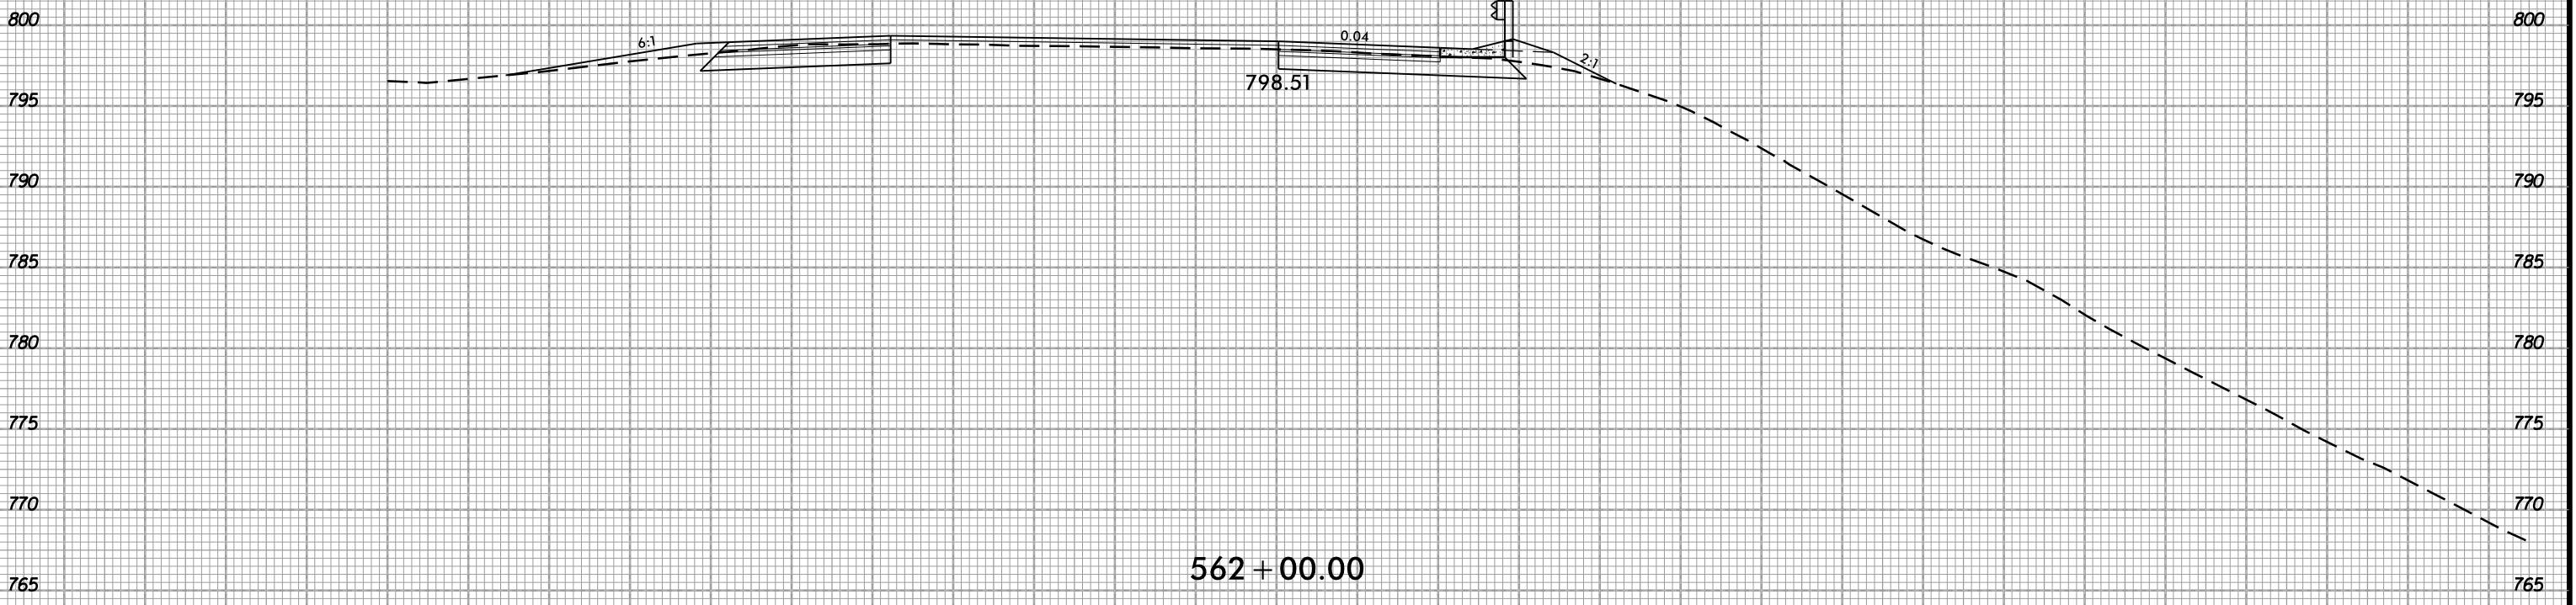

-EOT2-

75 70 65 60 55 50 45 40 35 30 25 20 15 10 5 0 5 10 15 20 25 30 35 40 45 50 55 60 65 70 75


6/23/16



PROJ. REFERENCE NO.  
I-5823

SHEET NO.  
X-14

75 70 65 60 55 50 45 40 35 30 25 20 15 10 5 0 5 10 15 20 25 30 35 40 45 50 55 60 65 70 75

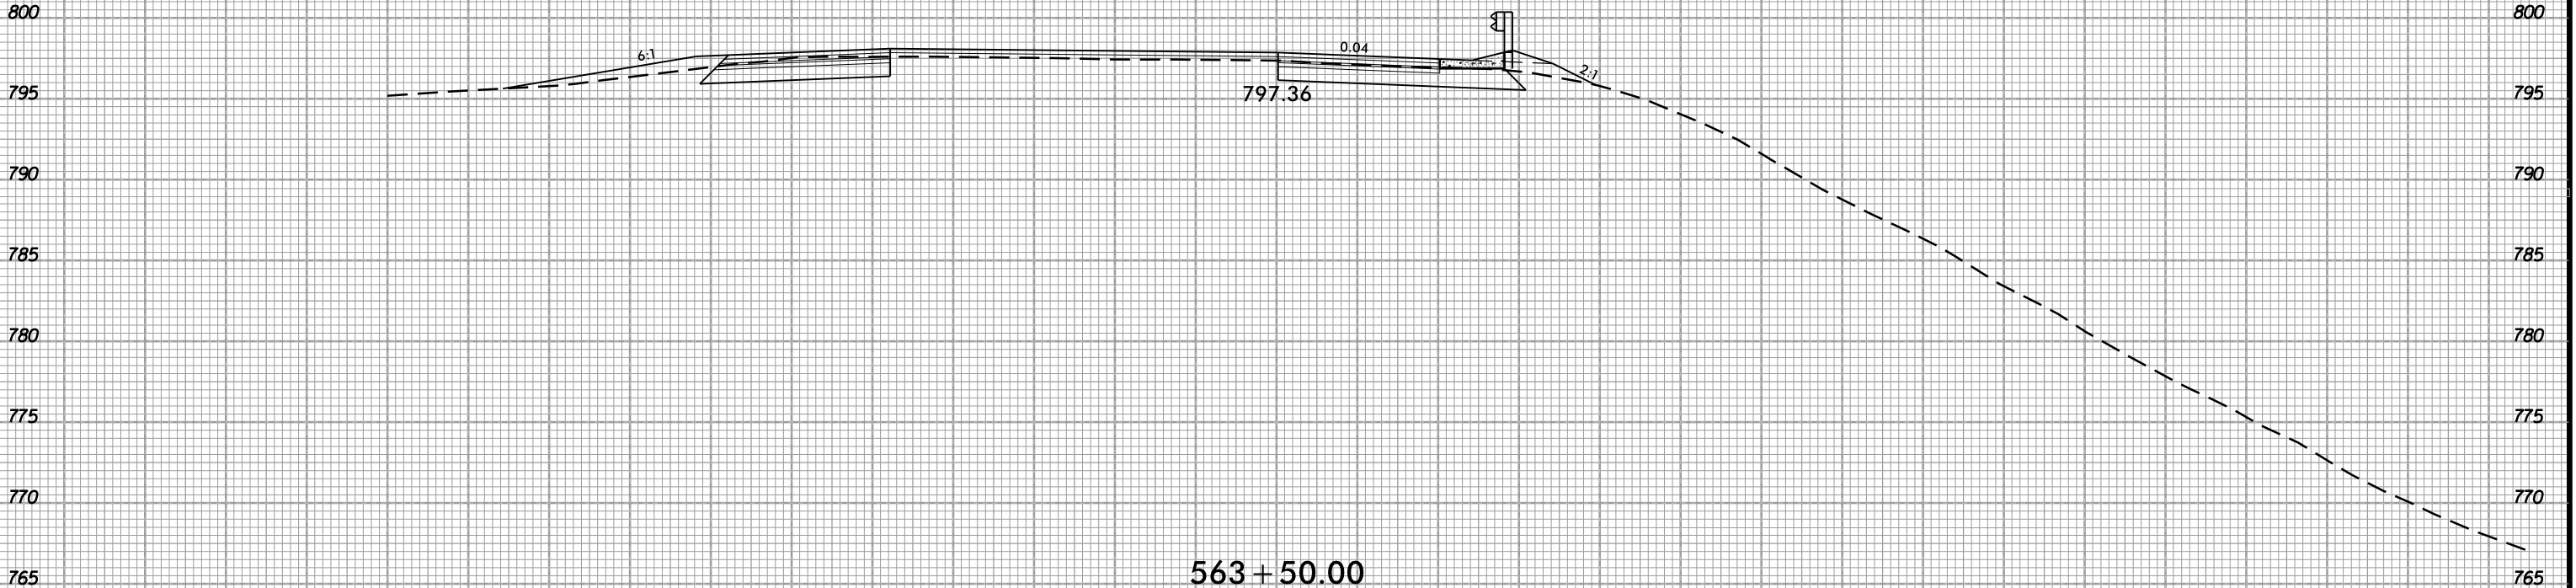


-EOT2-

02-NOV-2018 13:47  
 S:\Projects-Development\IIP Projects\I-5823-140-Dave\Roadway\DesignFiles\5823.ddc.xpl.EOT2.dgn  
 I:\keaton

75 70 65 60 55 50 45 40 35 30 25 20 15 10 5 0 5 10 15 20 25 30 35 40 45 50 55 60 65 70 75


 
6/23/16



PROJ. REFERENCE NO. I-5823

SHEET NO. X-15

75 70 65 60 55 50 45 40 35 30 25 20 15 10 5 0 5 10 15 20 25 30 35 40 45 50 55 60 65 70 75

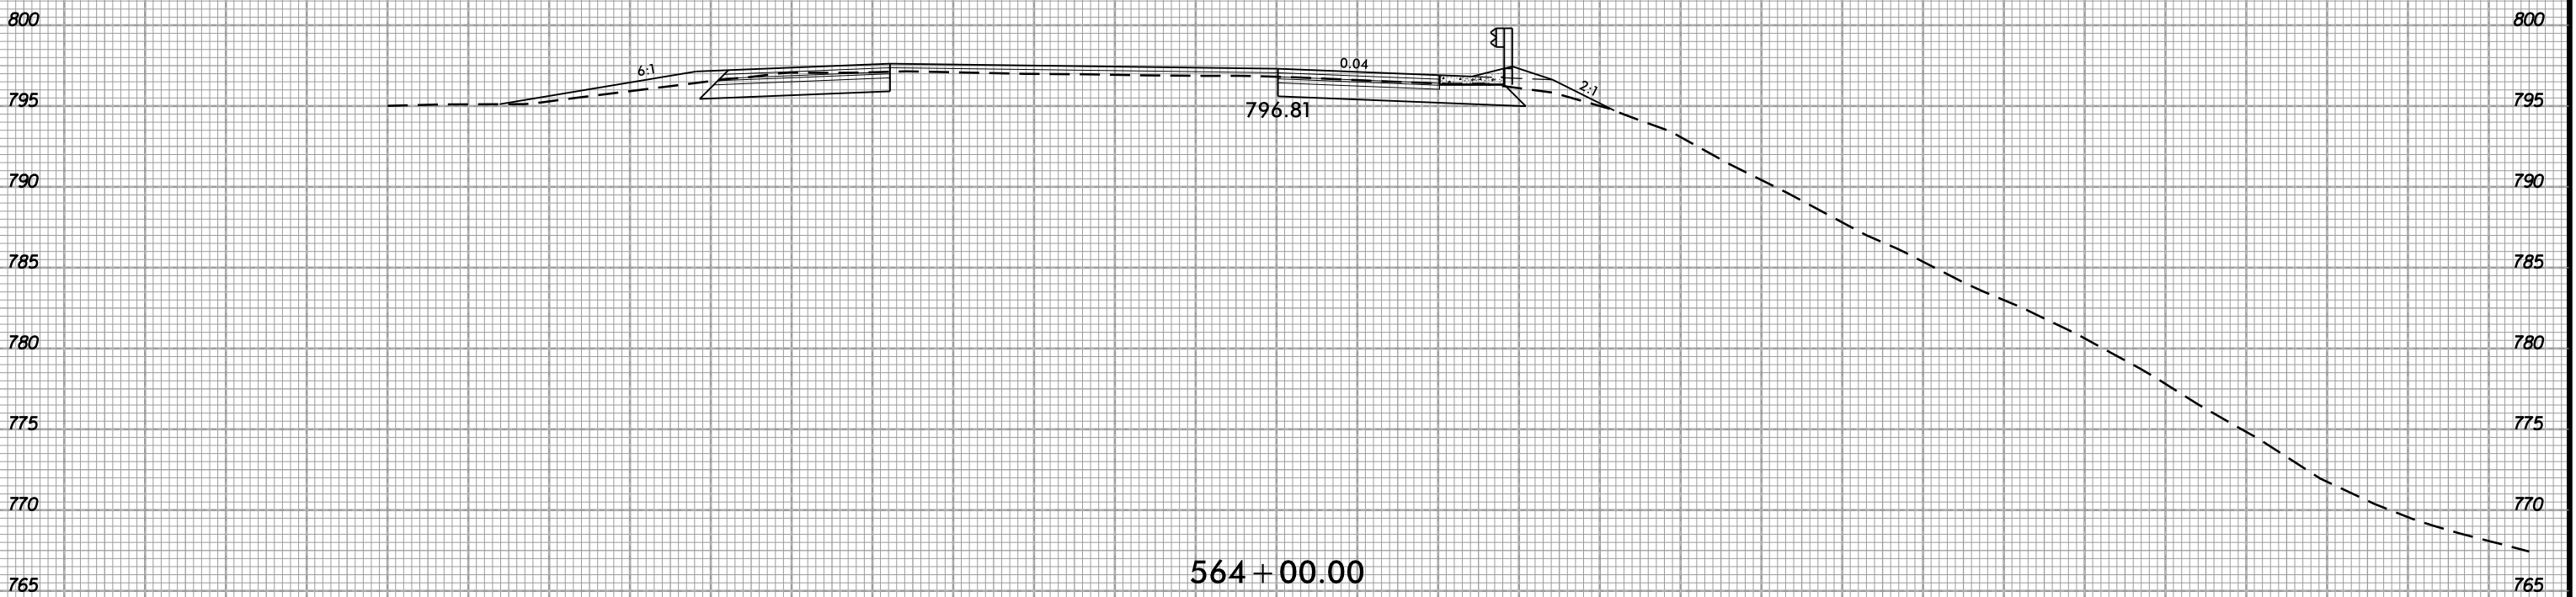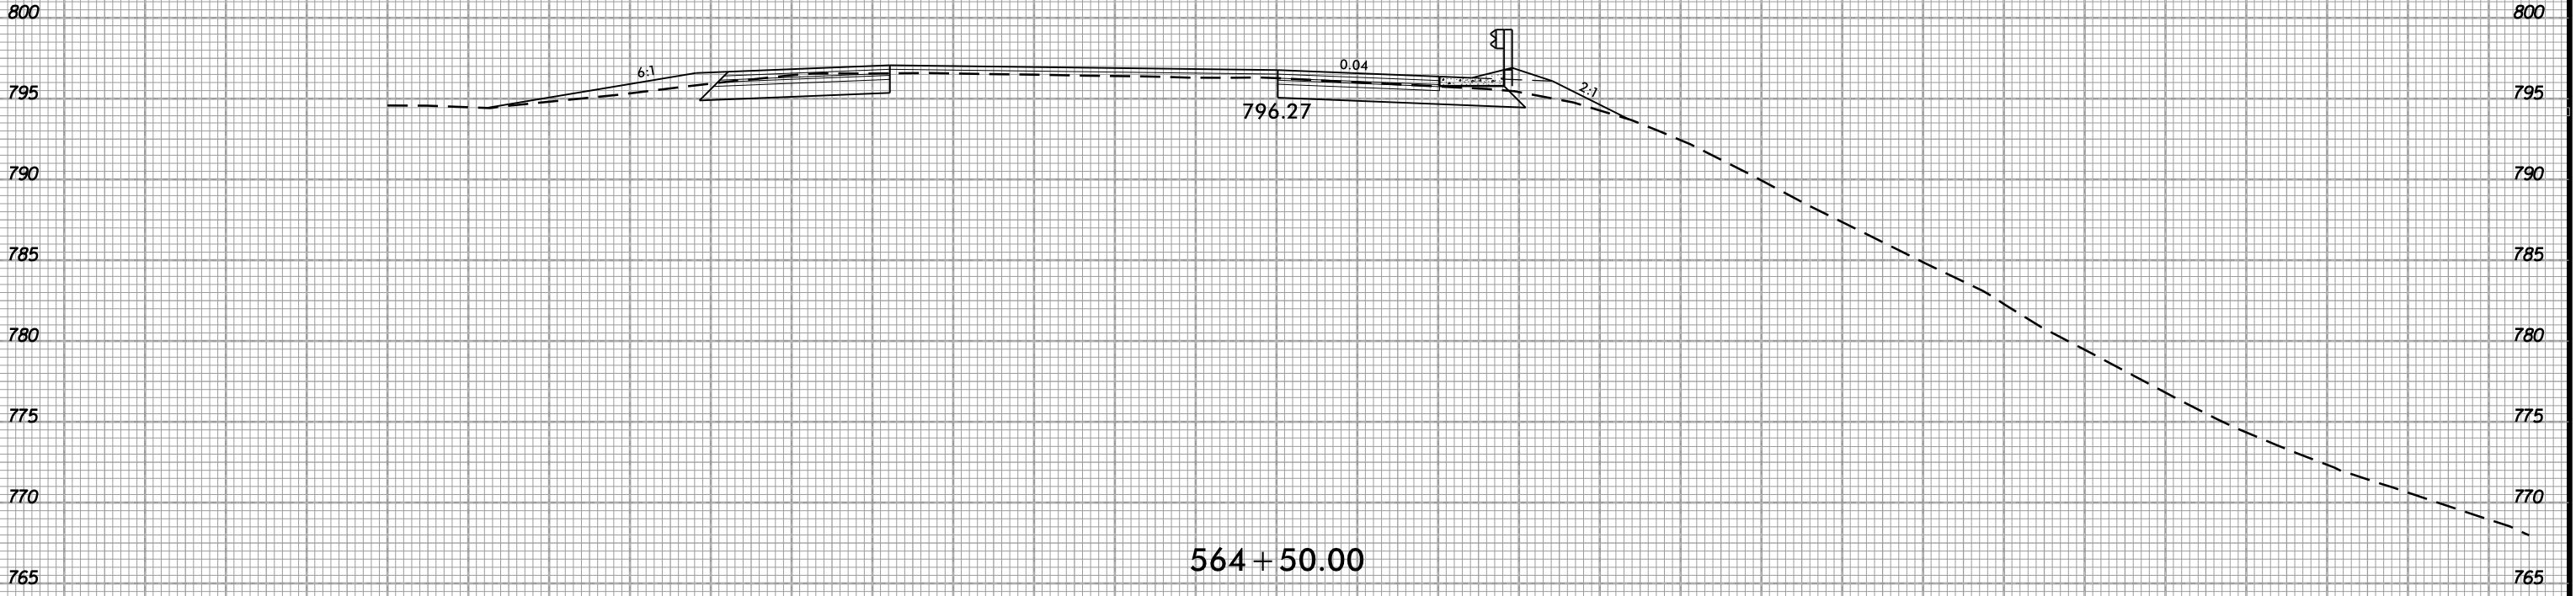


-EOT2-

75 70 65 60 55 50 45 40 35 30 25 20 15 10 5 0 5 10 15 20 25 30 35 40 45 50 55 60 65 70 75

02-NOV-2018 13:47  
 S:\Projects-Development\IIP Projects\I-5823-140-Davie Roadway\DesignFiles\5823.ddc.xpl.EOT2.dgn  
 ilke@ion




 
6/23/16



PROJ. REFERENCE NO.  
I-5823

SHEET NO.  
X-16

75 70 65 60 55 50 45 40 35 30 25 20 15 10 5 0 5 10 15 20 25 30 35 40 45 50 55 60 65 70 75

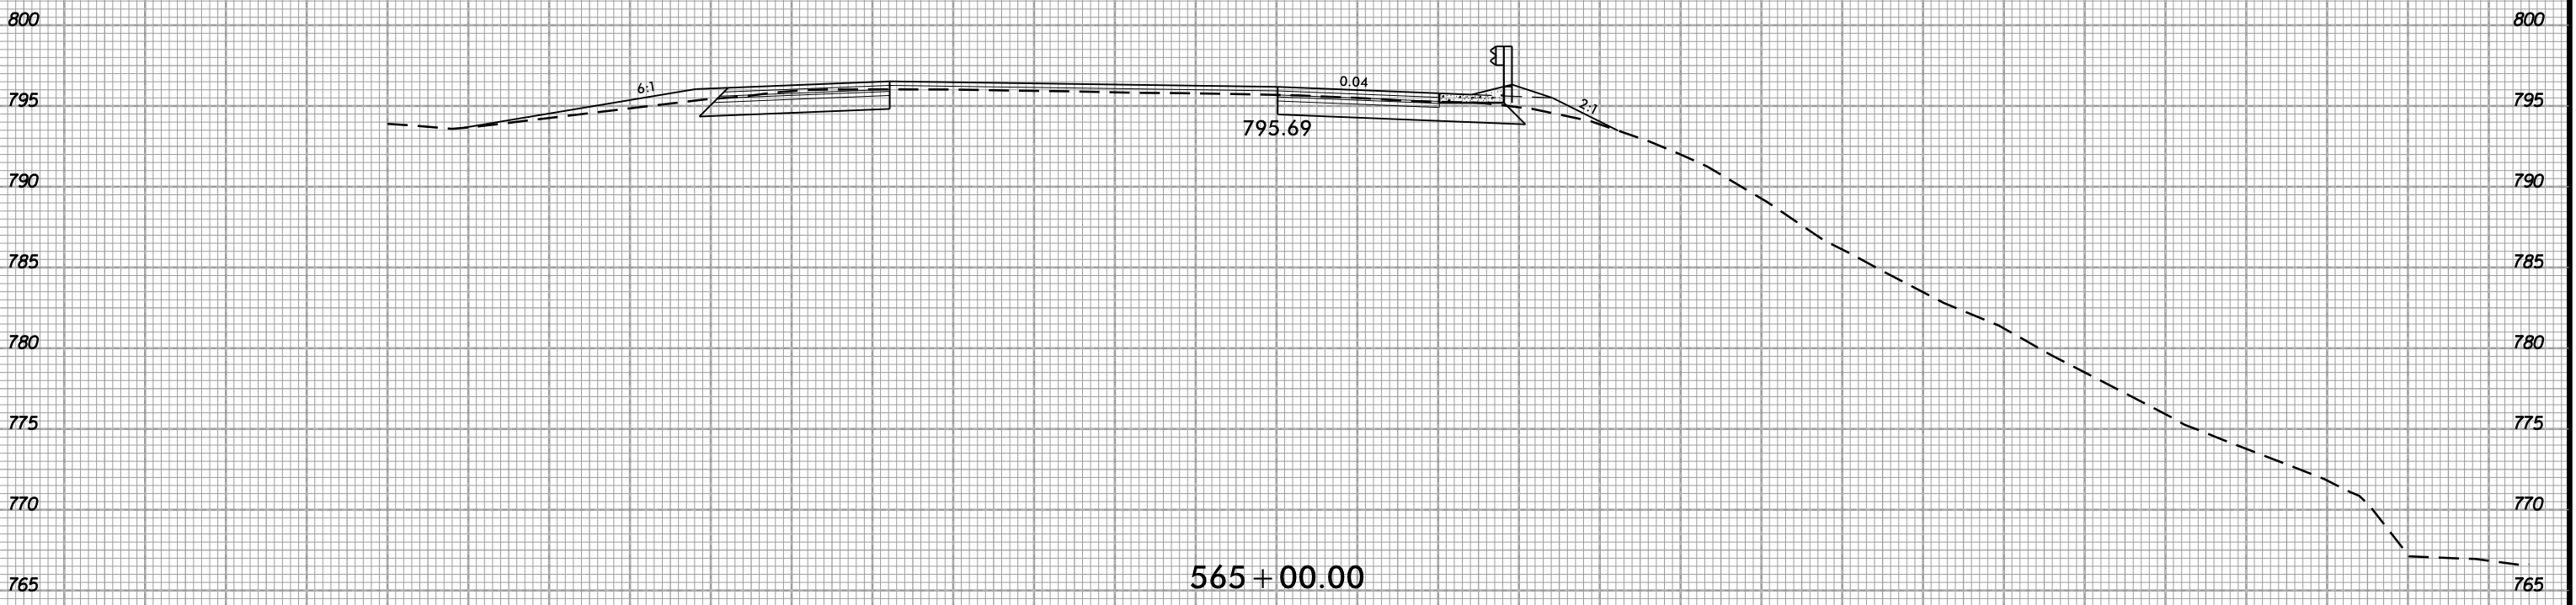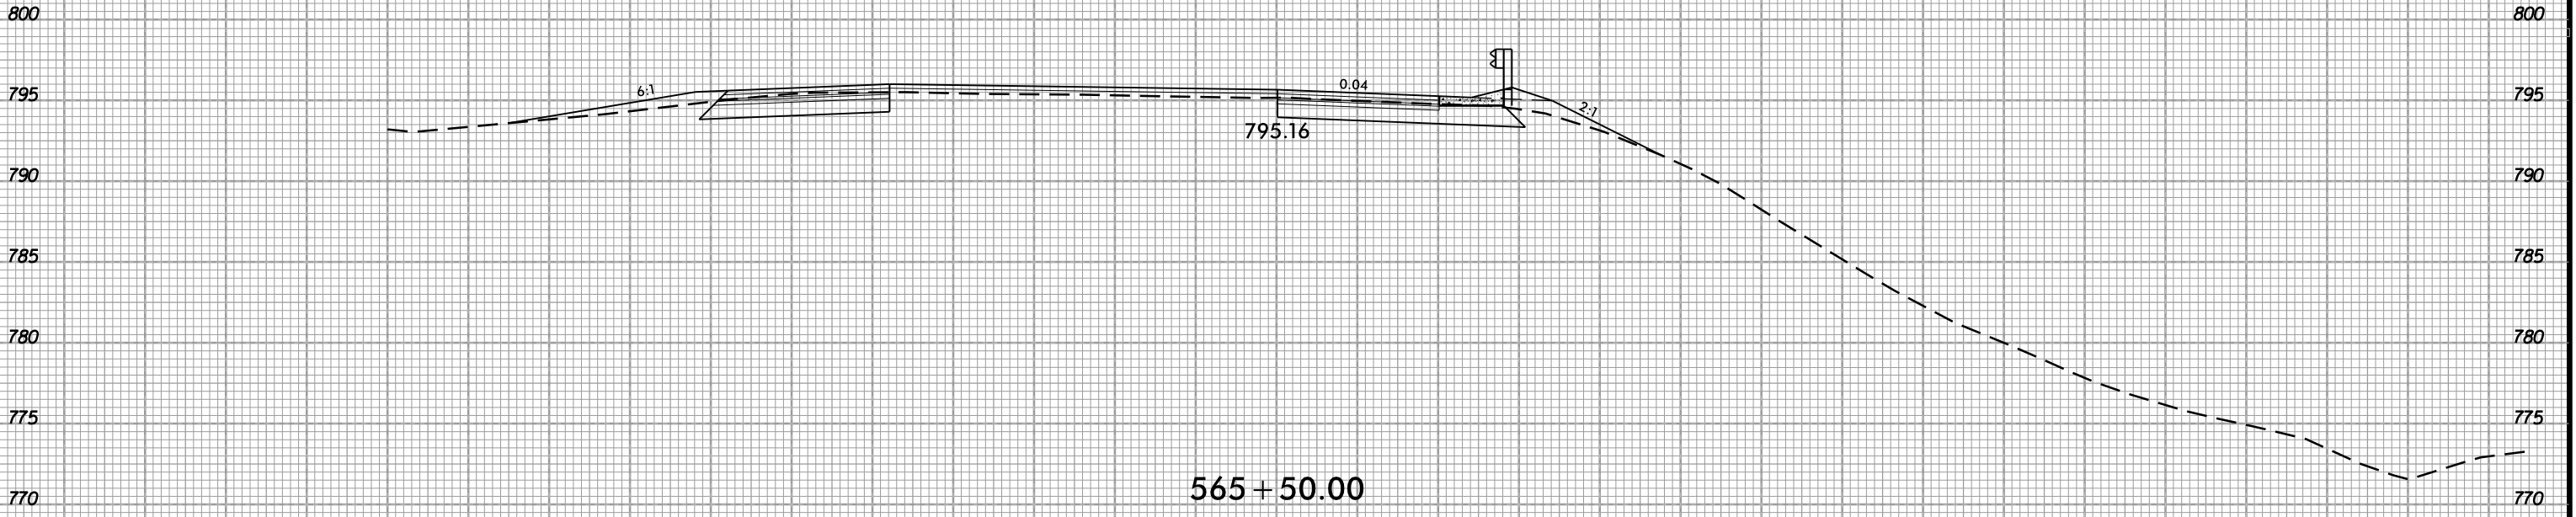

-EOT2-

75 70 65 60 55 50 45 40 35 30 25 20 15 10 5 0 5 10 15 20 25 30 35 40 45 50 55 60 65 70 75

02-NOV-2018 13:47  
S:\Project-Development\IIP Projects\I-5823-140-Dave\Roadway\DesignFiles\5823.ddc.xpl.EOT2.dgn  
Ikeation AT DIV 29450


6/23/16  
02-NOV-2018 13:47  
S:\Projects-Development\JIP Projects\140-Dave\Roadway\DesignFiles\5823.ddc.xpl.EOT2.dgn  
Mikeston



PROJ. REFERENCE NO.  
-5823

SHEET NO.  
X-17

75 70 65 60 55 50 45 40 35 30 25 20 15 10 5 0 5 10 15 20 25 30 35 40 45 50 55 60 65 70 75

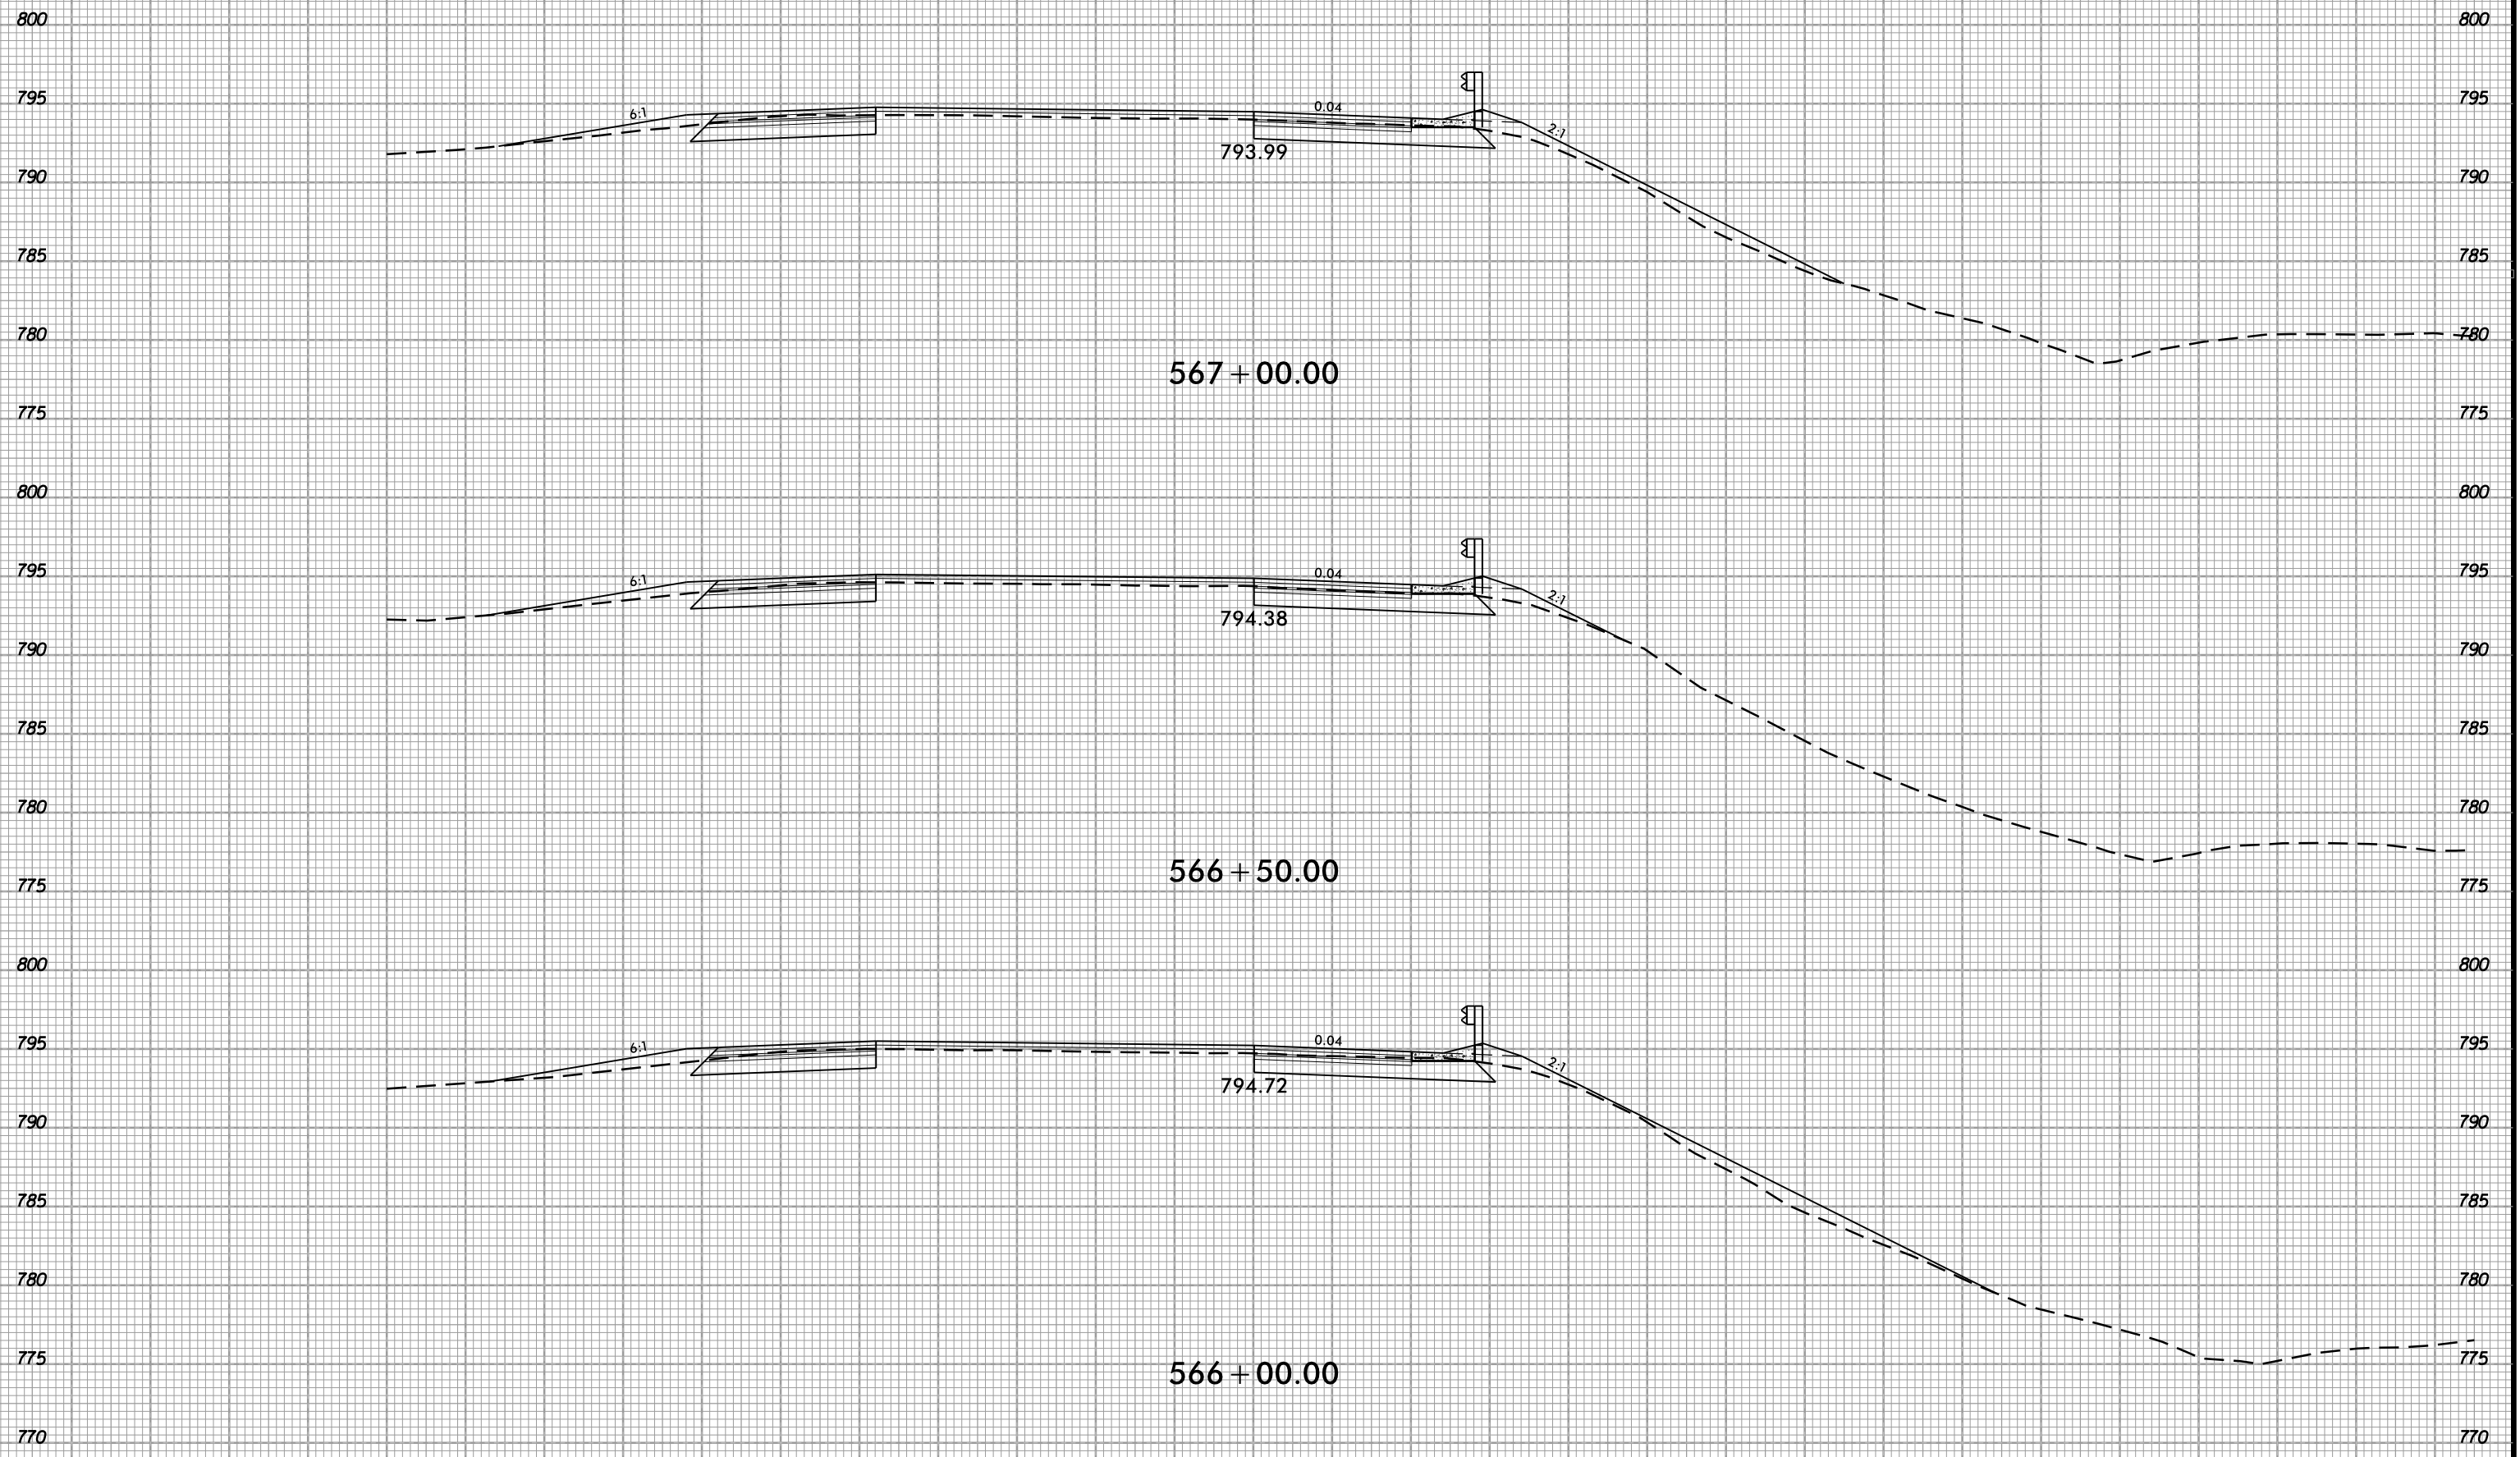

567 + 00.00

566 + 50.00

566 + 00.00

-EOT2-

75 70 65 60 55 50 45 40 35 30 25 20 15 10 5 0 5 10 15 20 25 30 35 40 45 50 55 60 65 70 75


02-NOV-2018 13:47  
S:\Projects-Development\JIP Projects\1-5823-140-Dave\Roadway\DesignFiles\5823.ddc.xpl.EOT2.dgn  
Mike@ion



PROJ. REFERENCE NO.  
I-5823

SHEET NO.  
X-18

75 70 65 60 55 50 45 40 35 30 25 20 15 10 5 0 5 10 15 20 25 30 35 40 45 50 55 60 65 70 75

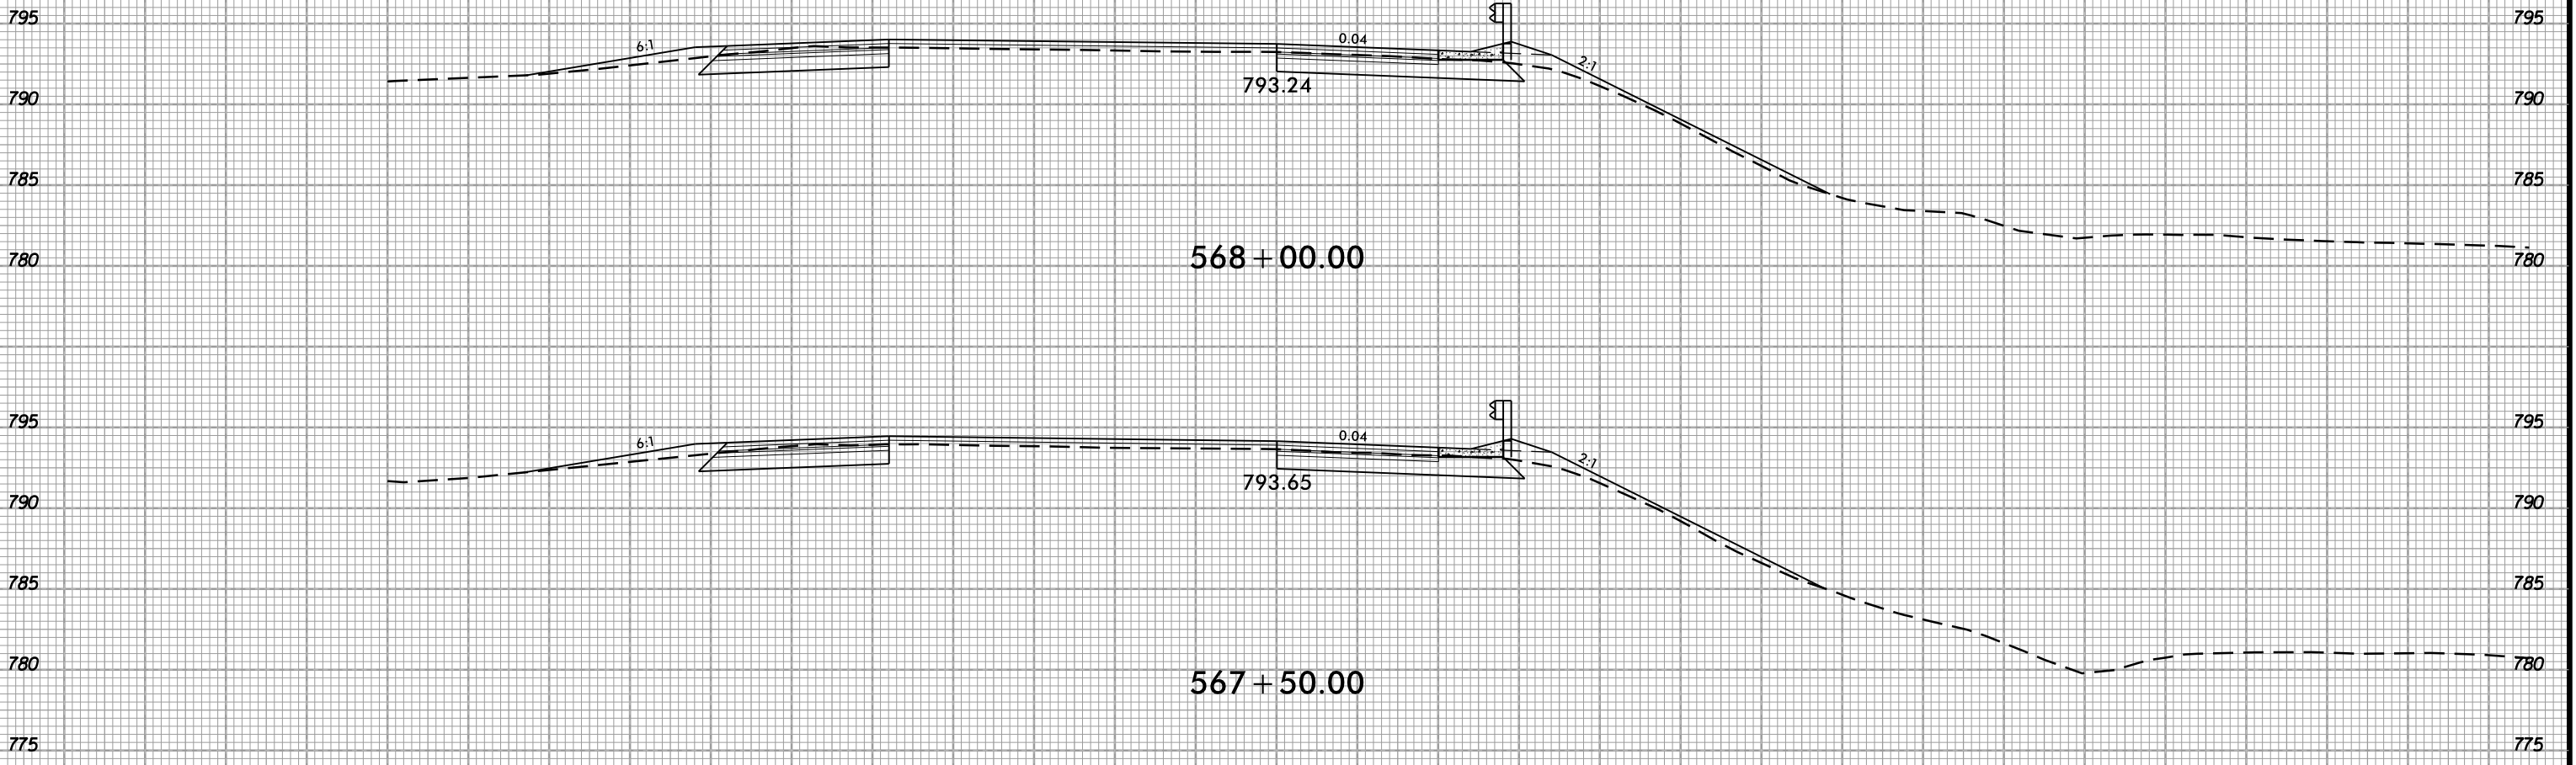


568 + 00.00

567 + 50.00

-EOT2-


75 70 65 60 55 50 45 40 35 30 25 20 15 10 5 0 5 10 15 20 25 30 35 40 45 50 55 60 65 70 75

6/23/16  
02-NOV-2018 13:47  
S:\Project-Development\IP Projects\140-Dave\Roadway\DesignFiles\5823.ddc.xpl.EOT3.dgn  
Mike@ion

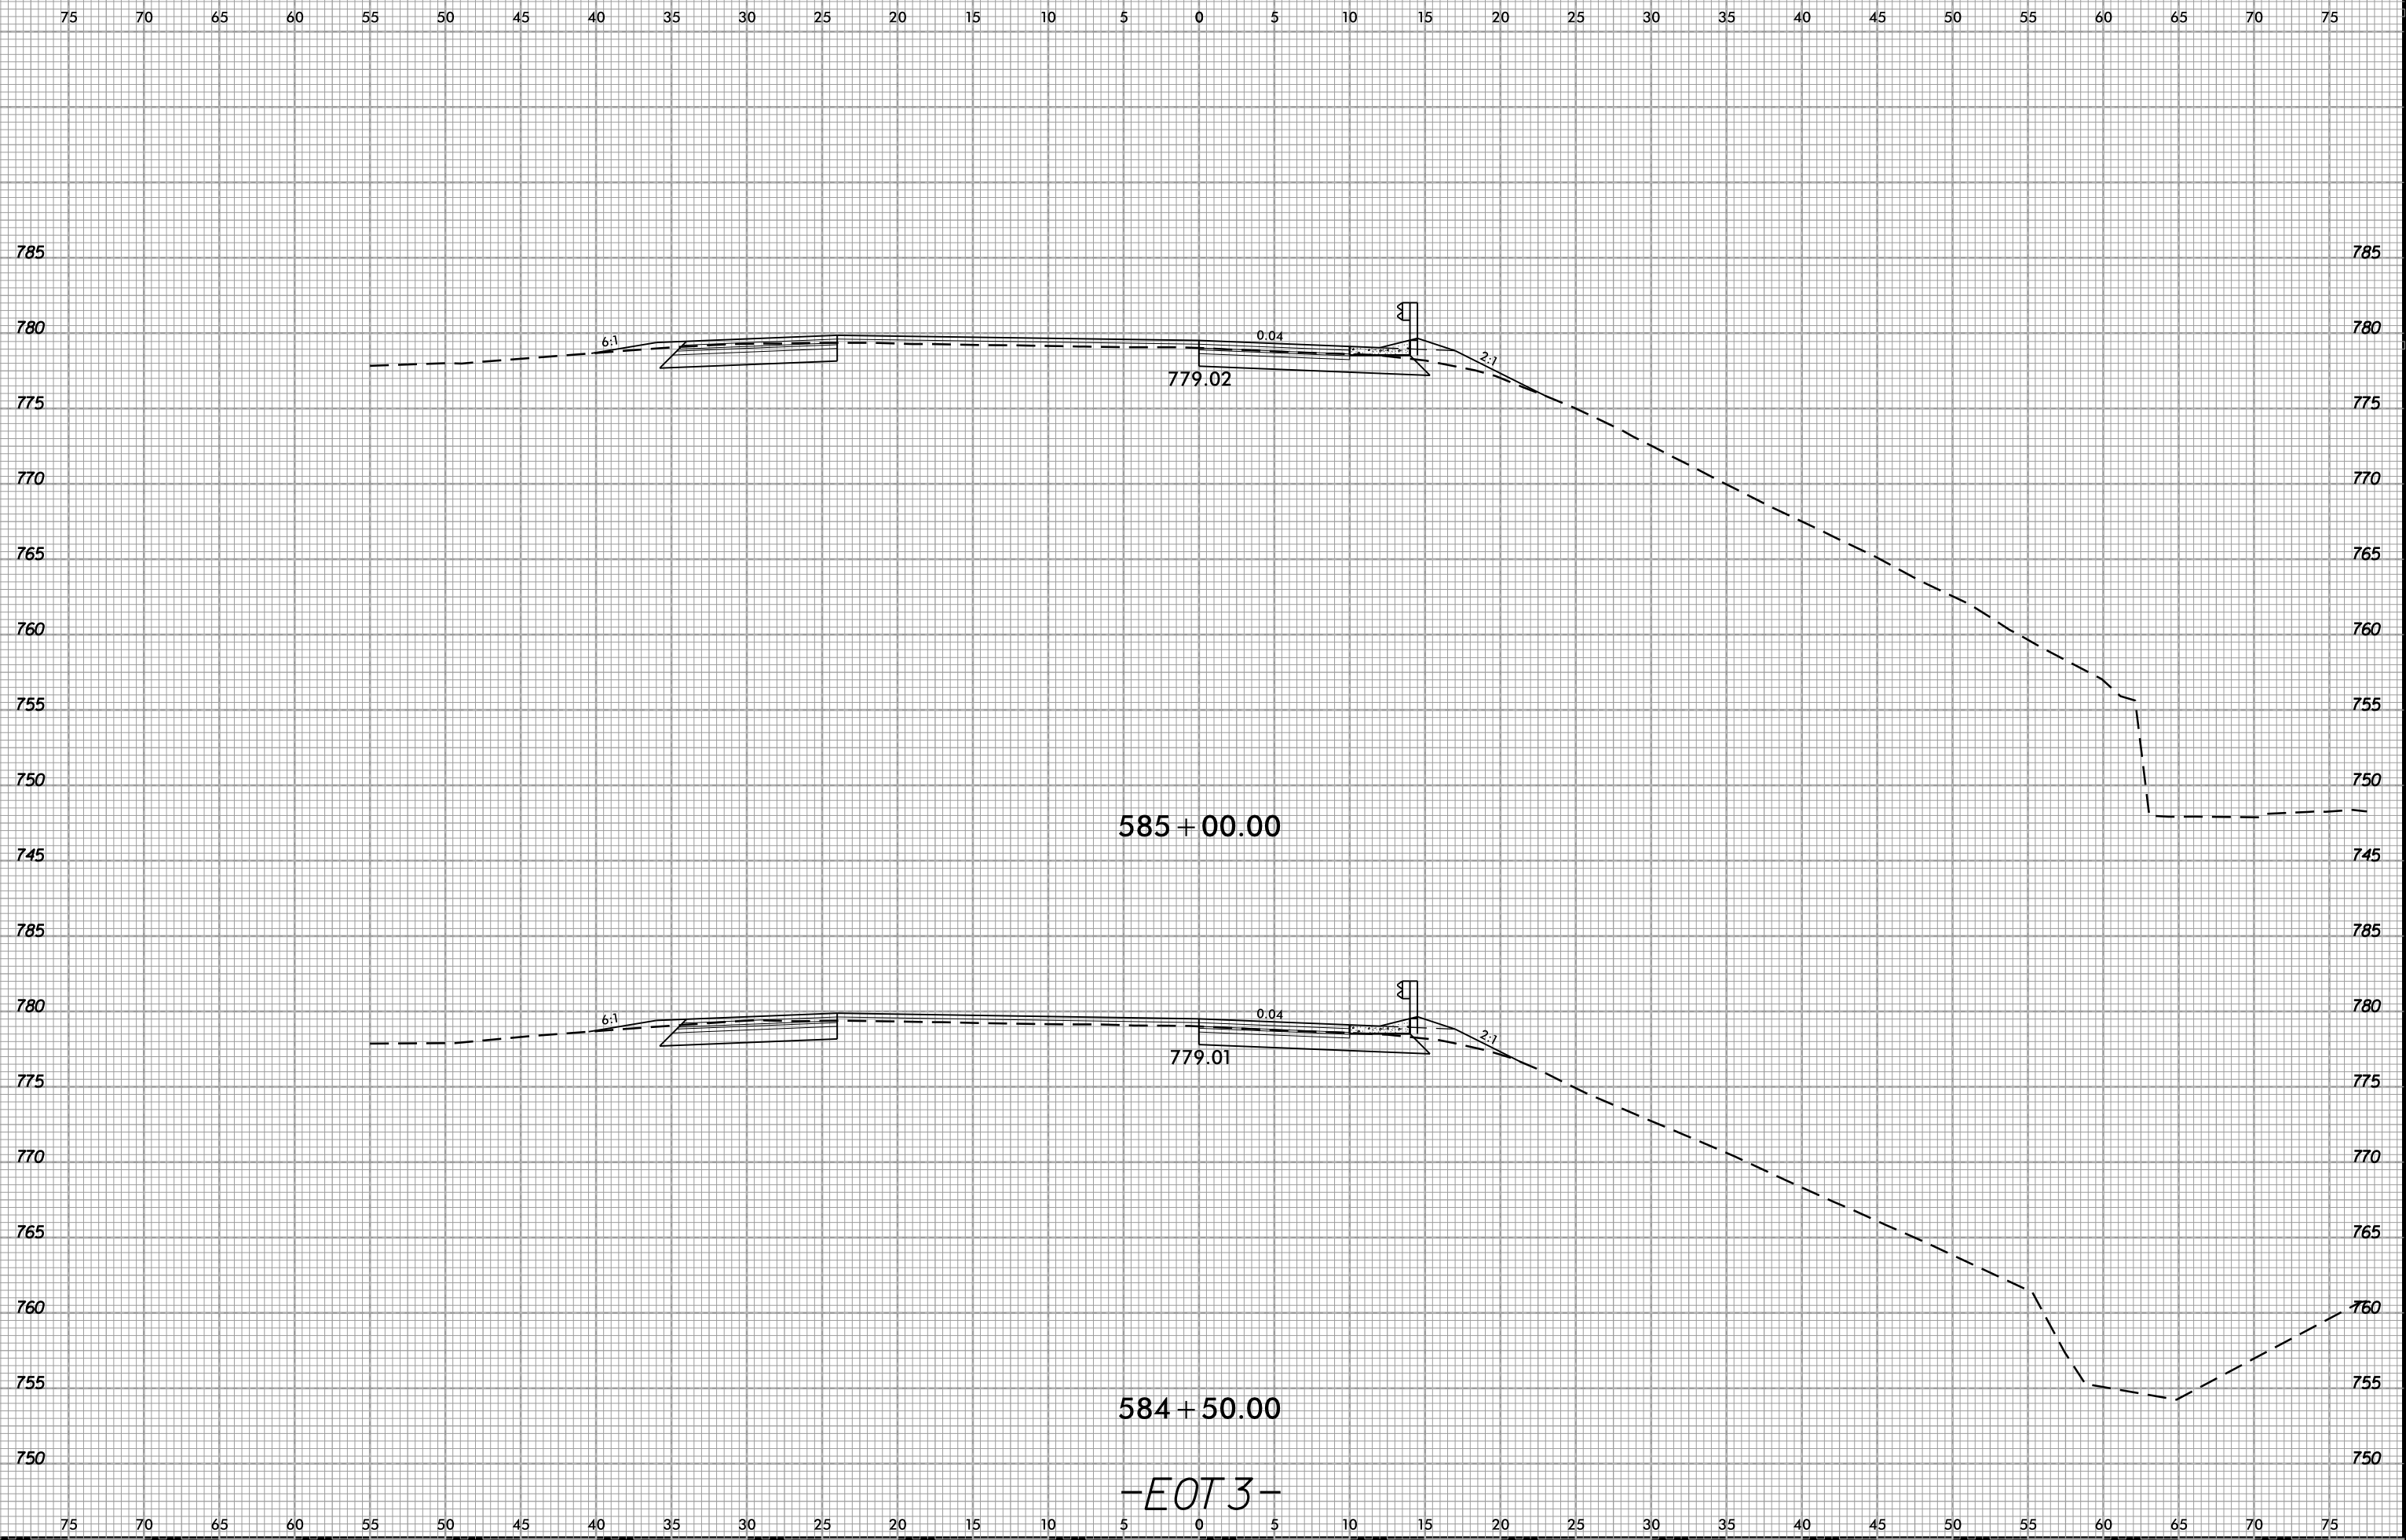

-EOT3-

75 70 65 60 55 50 45 40 35 30 25 20 15 10 5 0 5 10 15 20 25 30 35 40 45 50 55 60 65 70 75

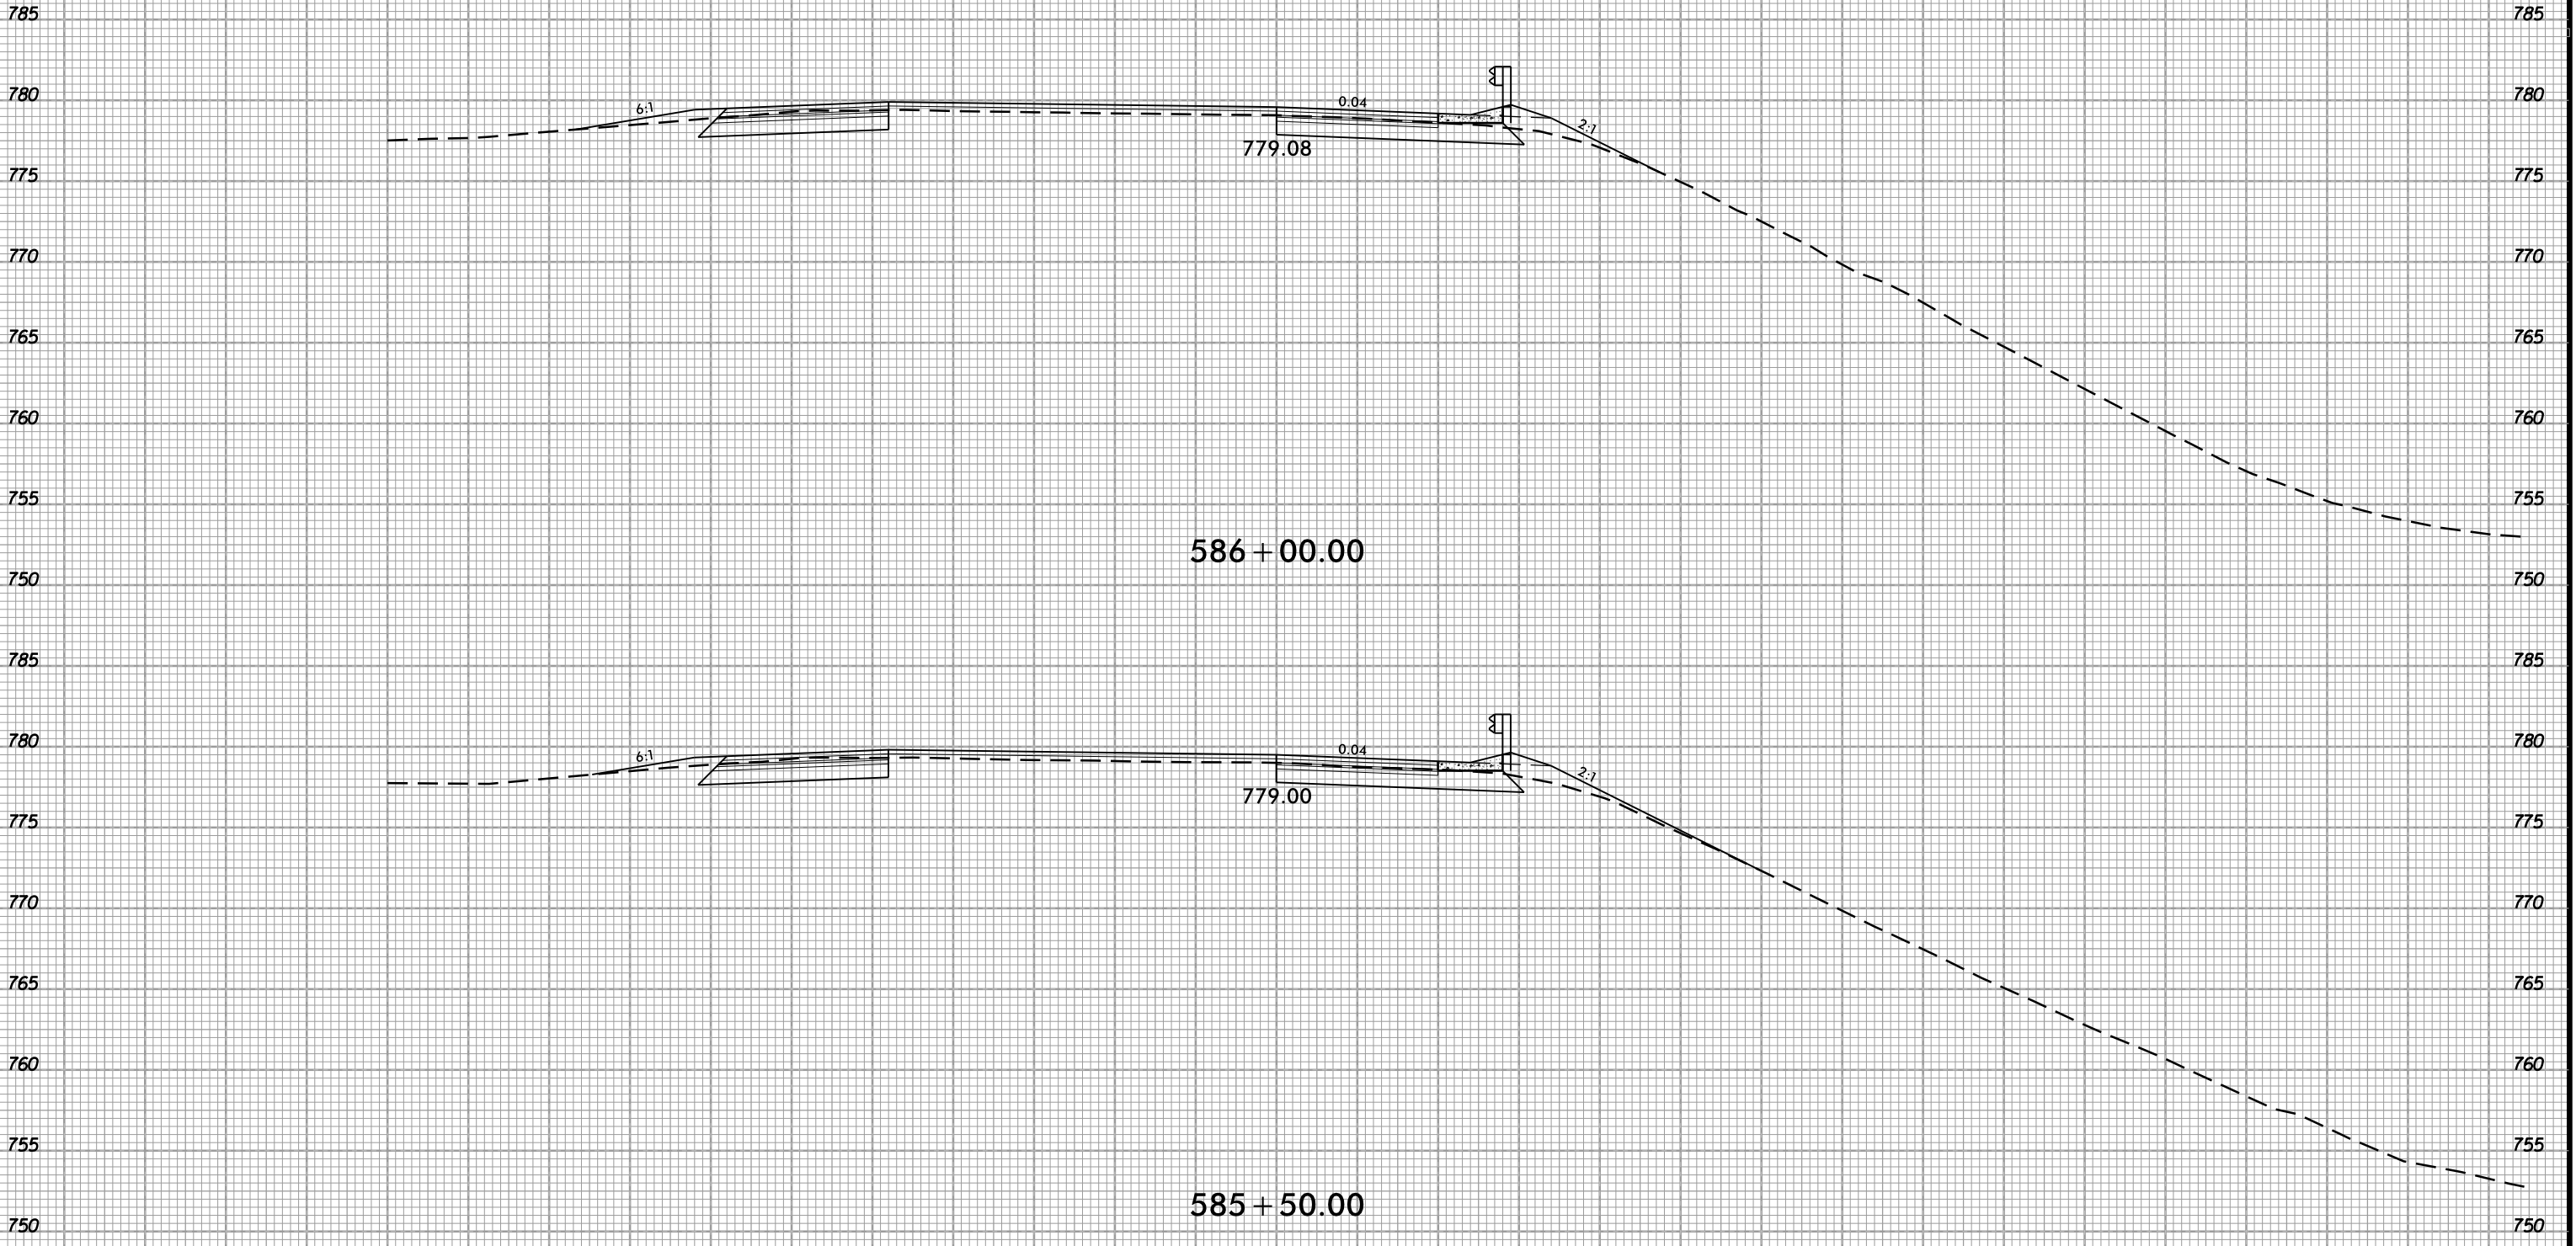


586 + 00.00

585 + 50.00

-EOT3-

75 70 65 60 55 50 45 40 35 30 25 20 15 10 5 0 5 10 15 20 25 30 35 40 45 50 55 60 65 70 75

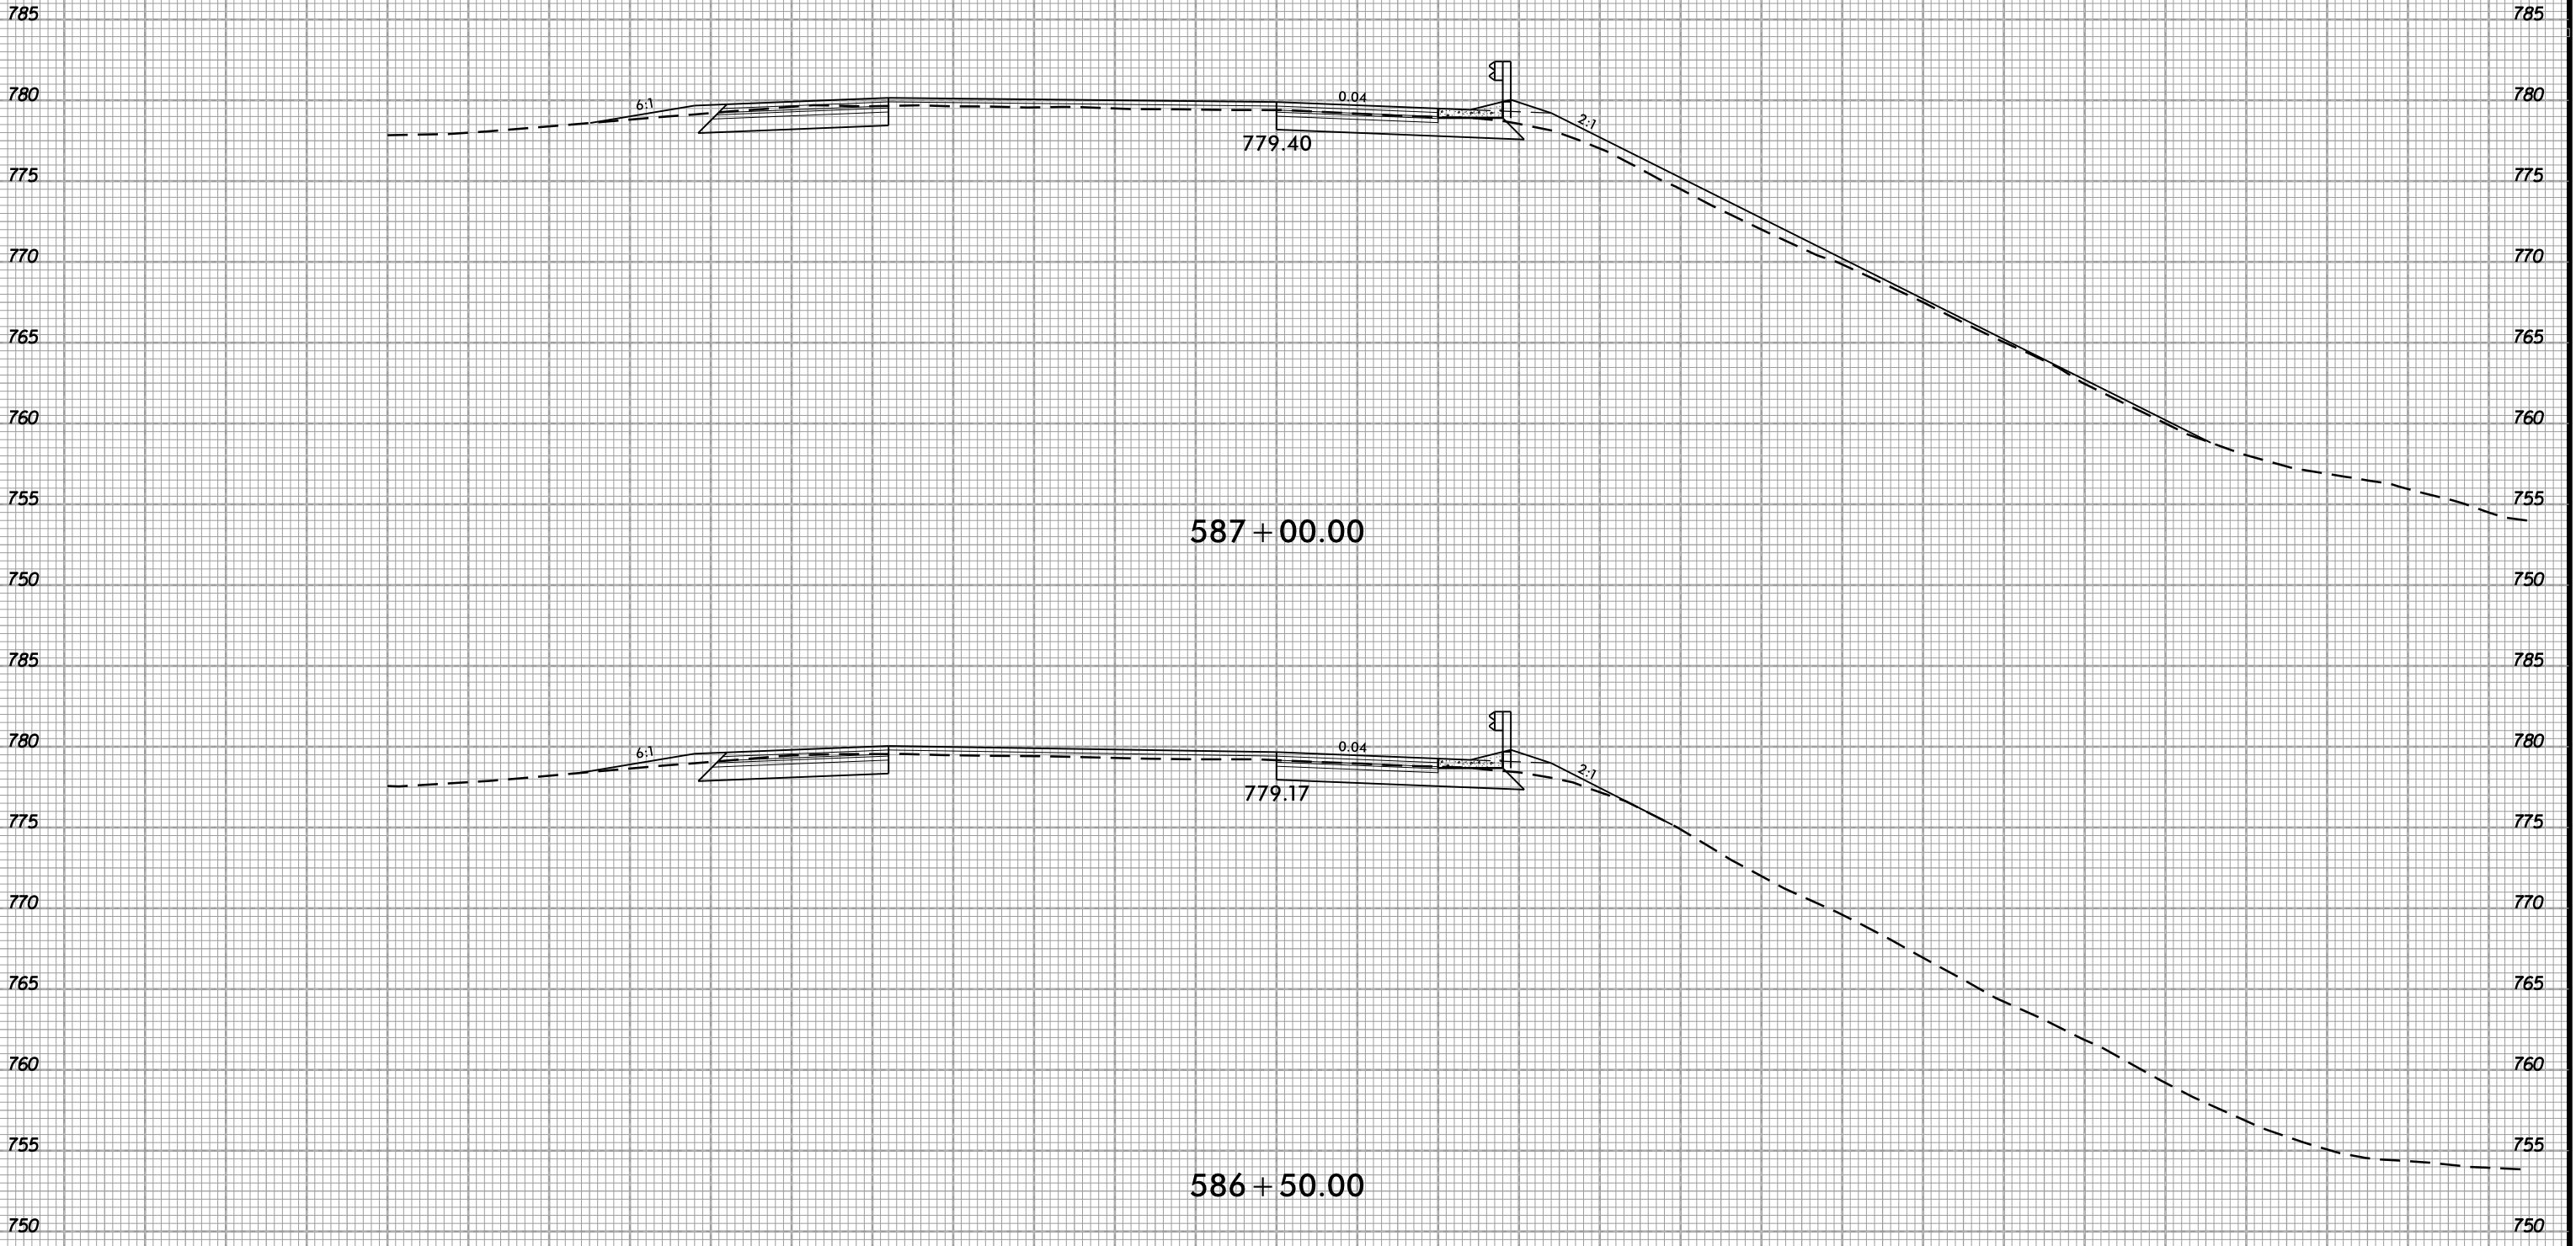


587 + 00.00


586 + 50.00

-EOT3-

6/23/16  
02-NOV-2018 13:47  
S:\Project-Development\IP Projects\140-Dave\Roadway\DesignFiles\5823.ddc.xpl.EOT3.dgn  
At Division 294550

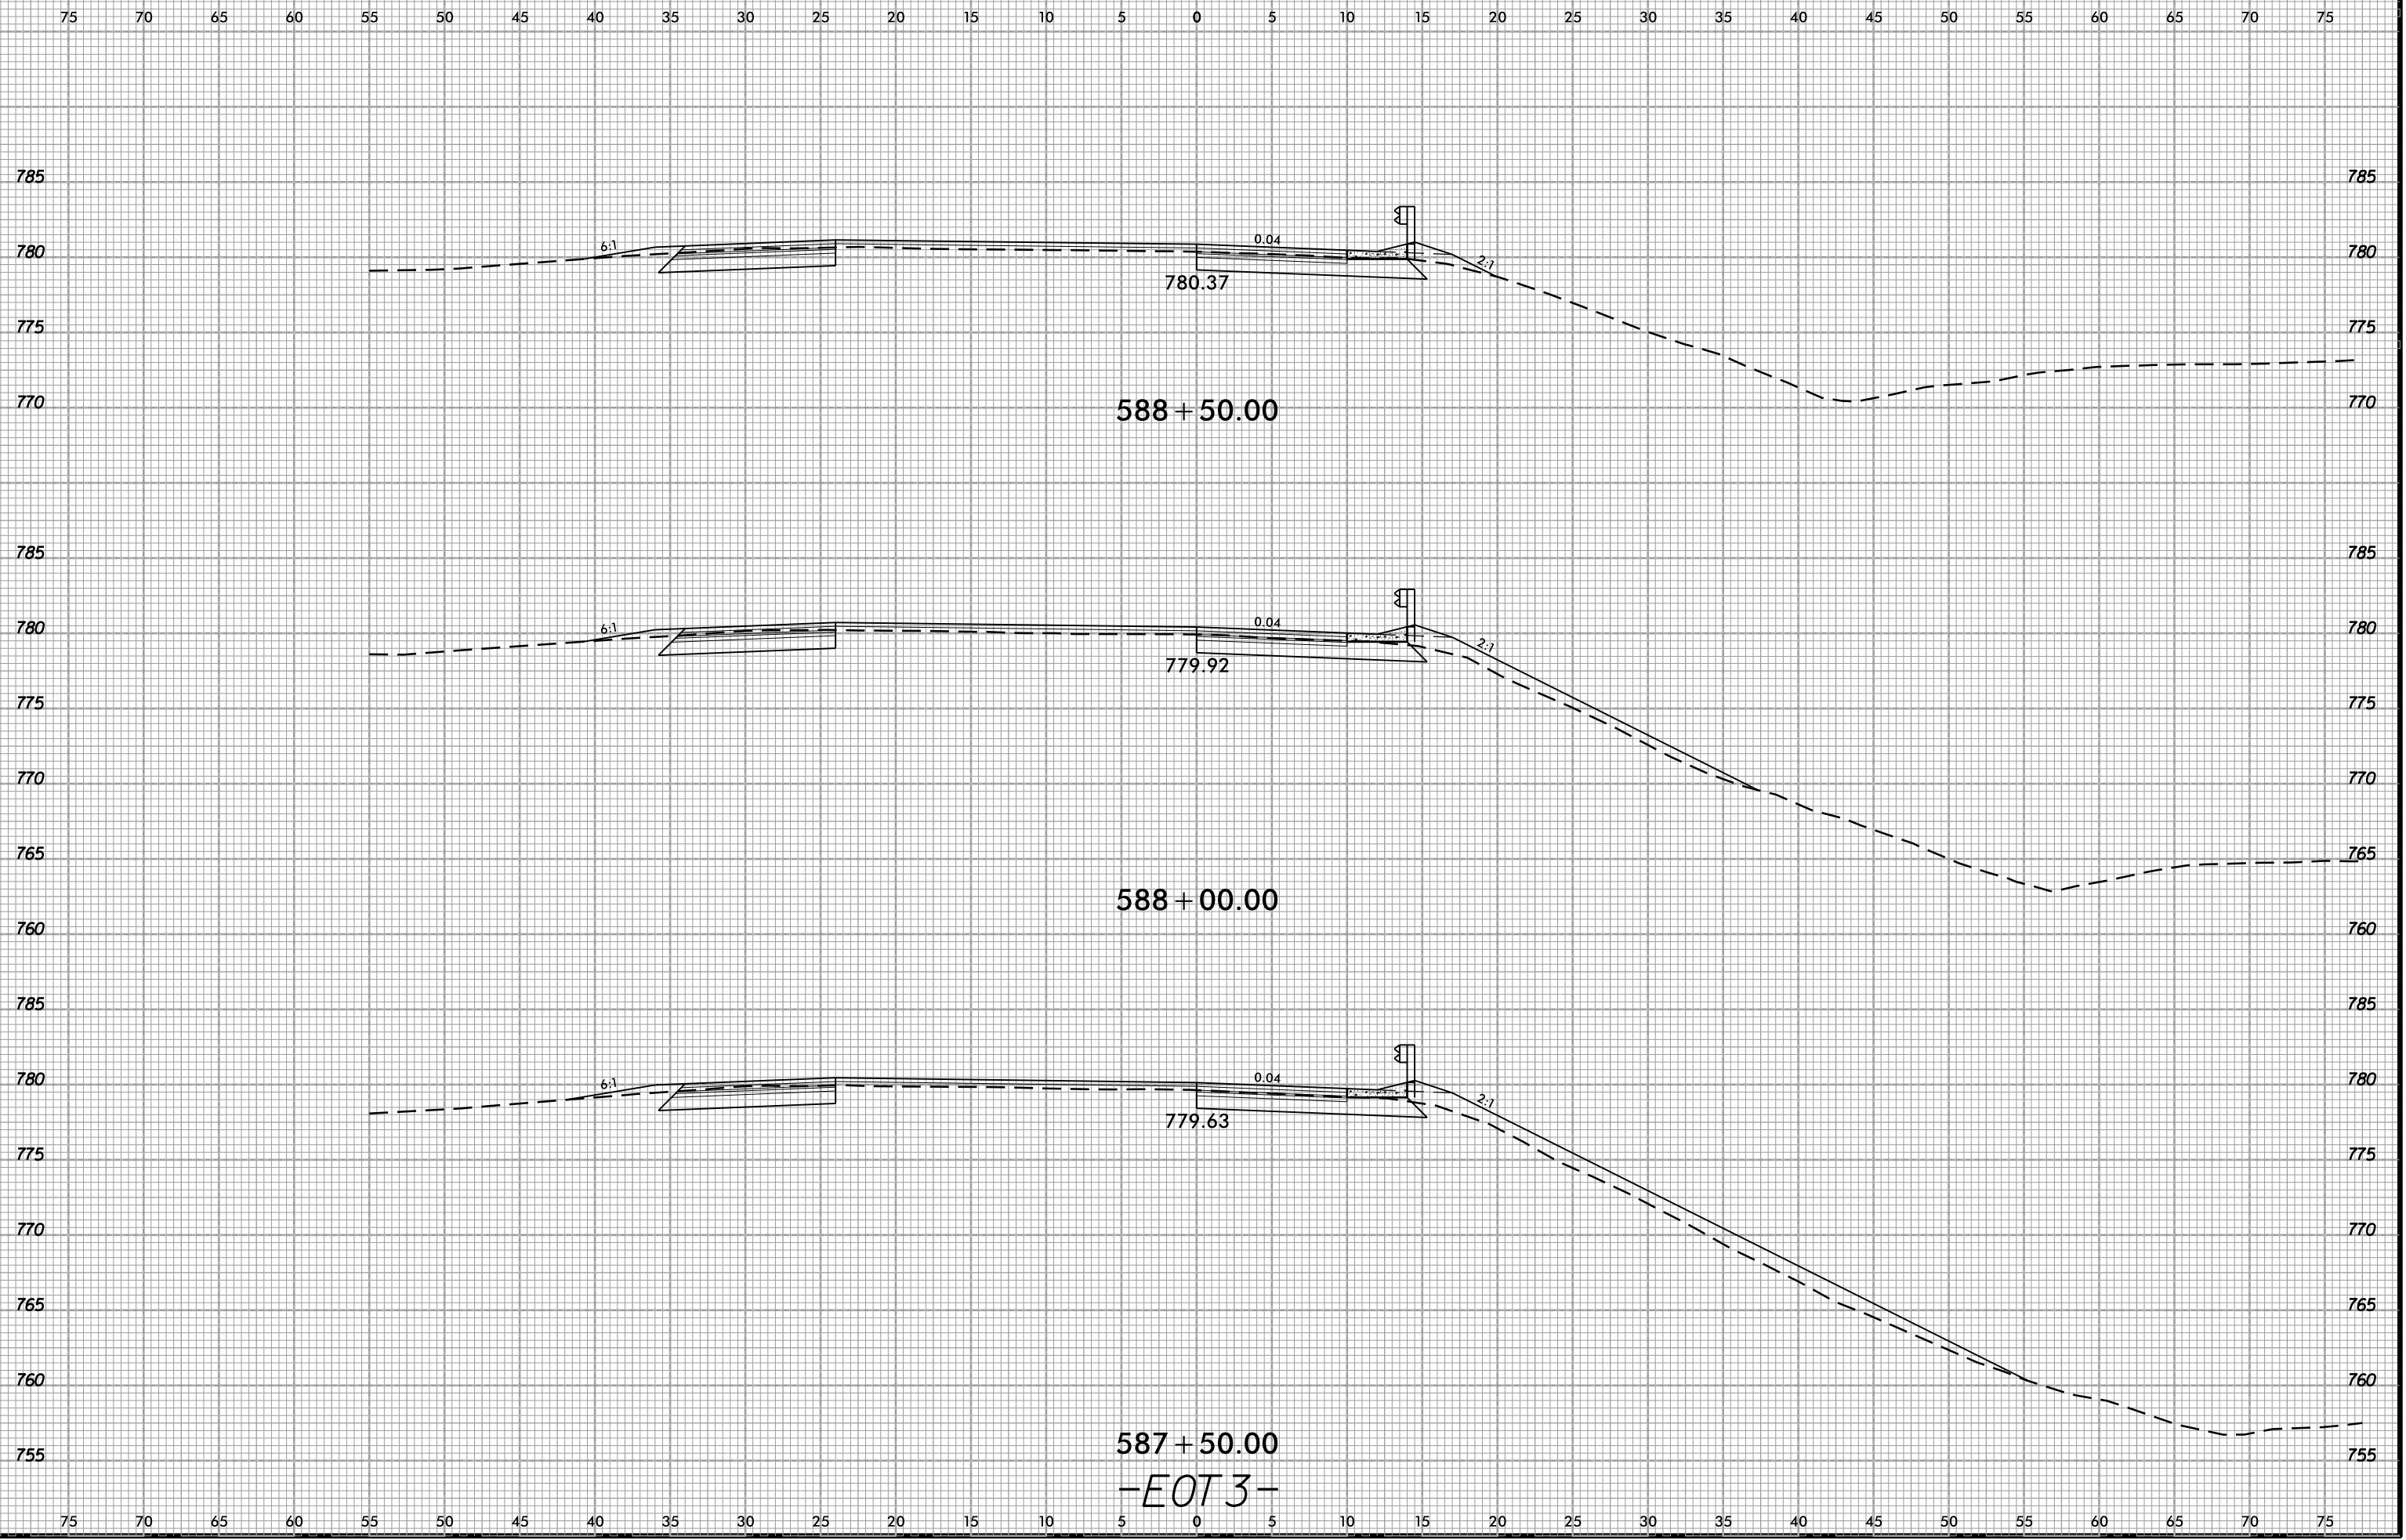

6/23/16  
02-NOV-2018 13:47  
S:\Project-Development\IP Projects\140-Dave\Roadway\DesignFiles\5823.ddc.xpl.EOT4.dgn  
AT DIV 294550

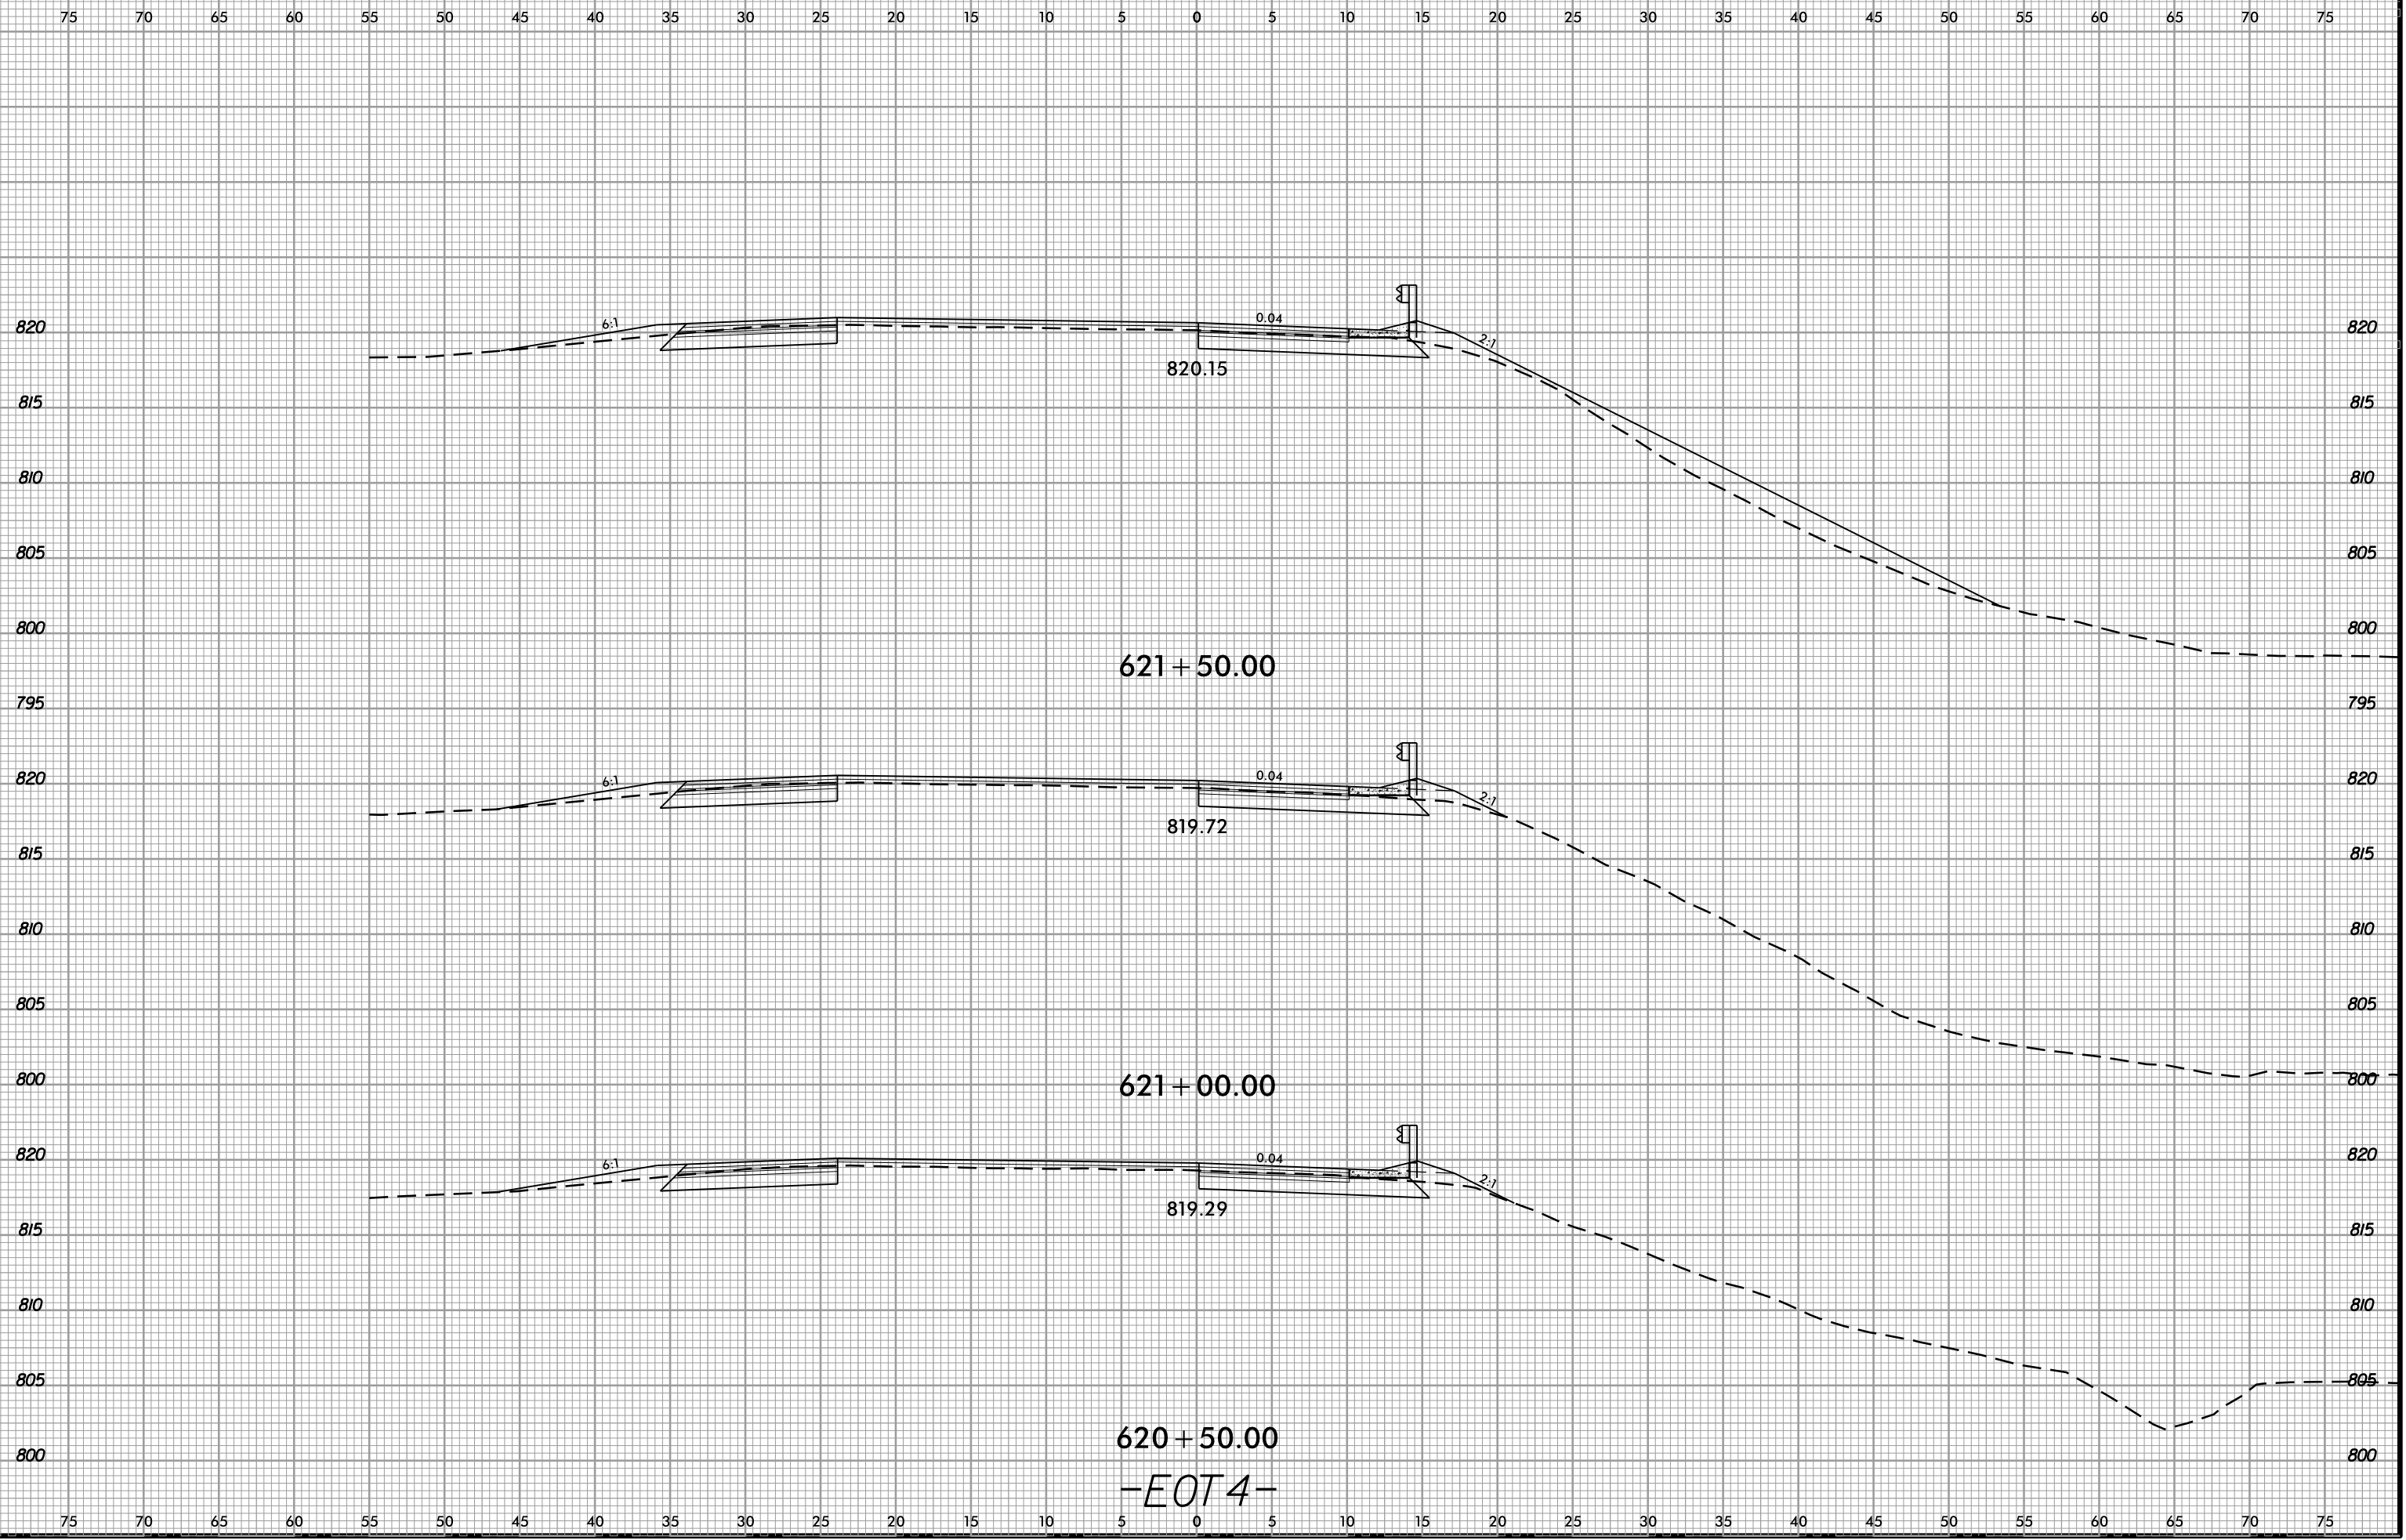

-EOT4-




6/23/16




PROJ. REFERENCE NO. I-5823

SHEET NO. X-24


75 70 65 60 55 50 45 40 35 30 25 20 15 10 5 0 5 10 15 20 25 30 35 40 45 50 55 60 65 70 75

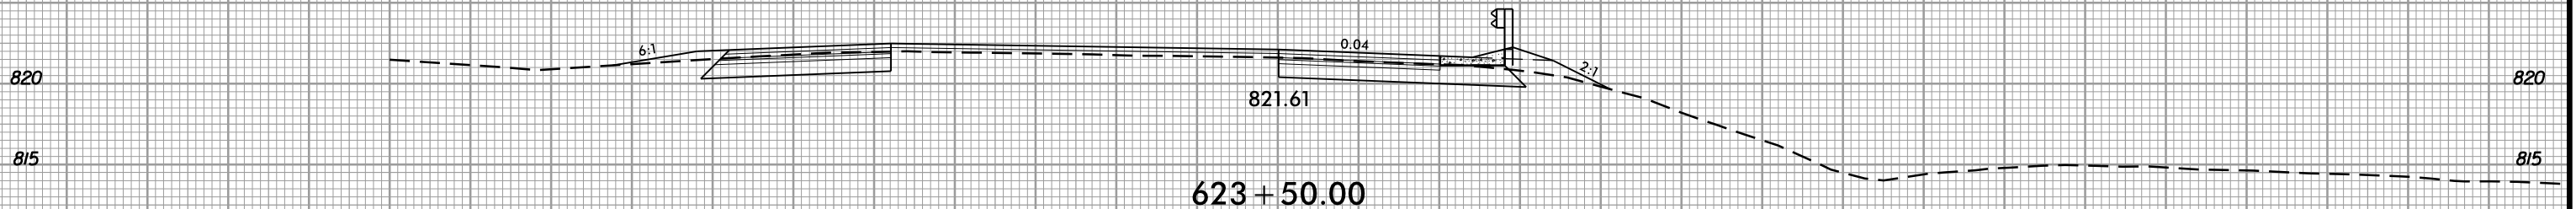


623 + 50.00

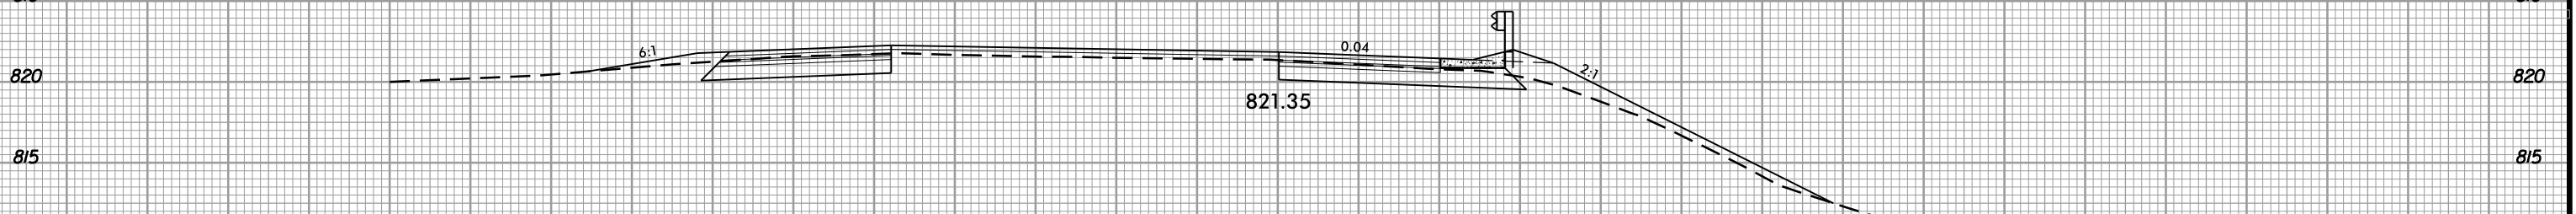

623 + 00.00

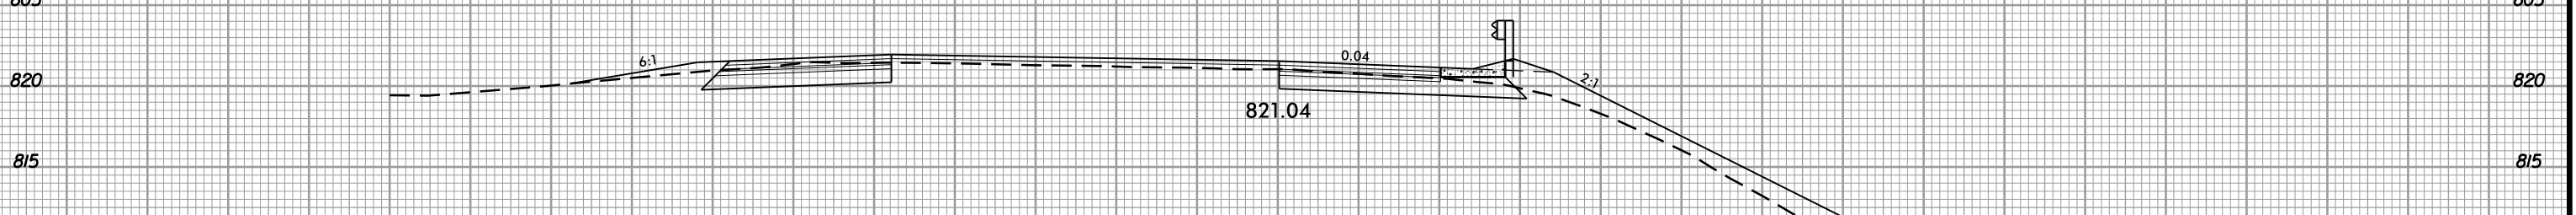

622 + 50.00

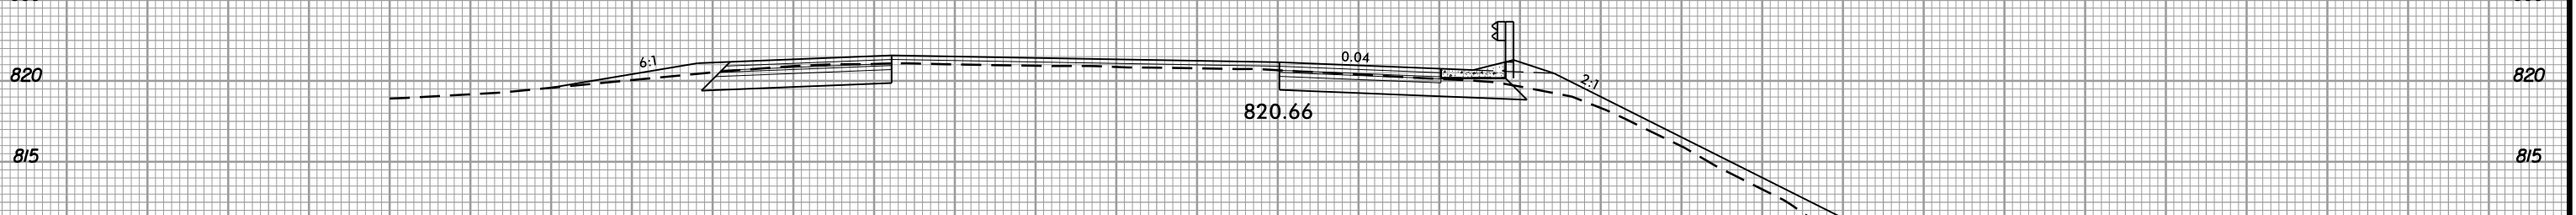


622 + 00.00

-EOT4-

75 70 65 60 55 50 45 40 35 30 25 20 15 10 5 0 5 10 15 20 25 30 35 40 45 50 55 60 65 70 75


02-NOV-2018 13:47  
 S:\Project-Development\IP Projects\I-5823-140-Dave\Roadway\DesignFiles\5823.adc.xpl.EOT4.dgn  
 I:\kason

6/23/16  
02-NOV-2018 13:47  
S:\Project-Development\IP Projects\11-5823-140-Dave\Roadway\DesignFiles\5823.ddc.xpl.EOT5.dgn  
Mikeston AT DIV 294550

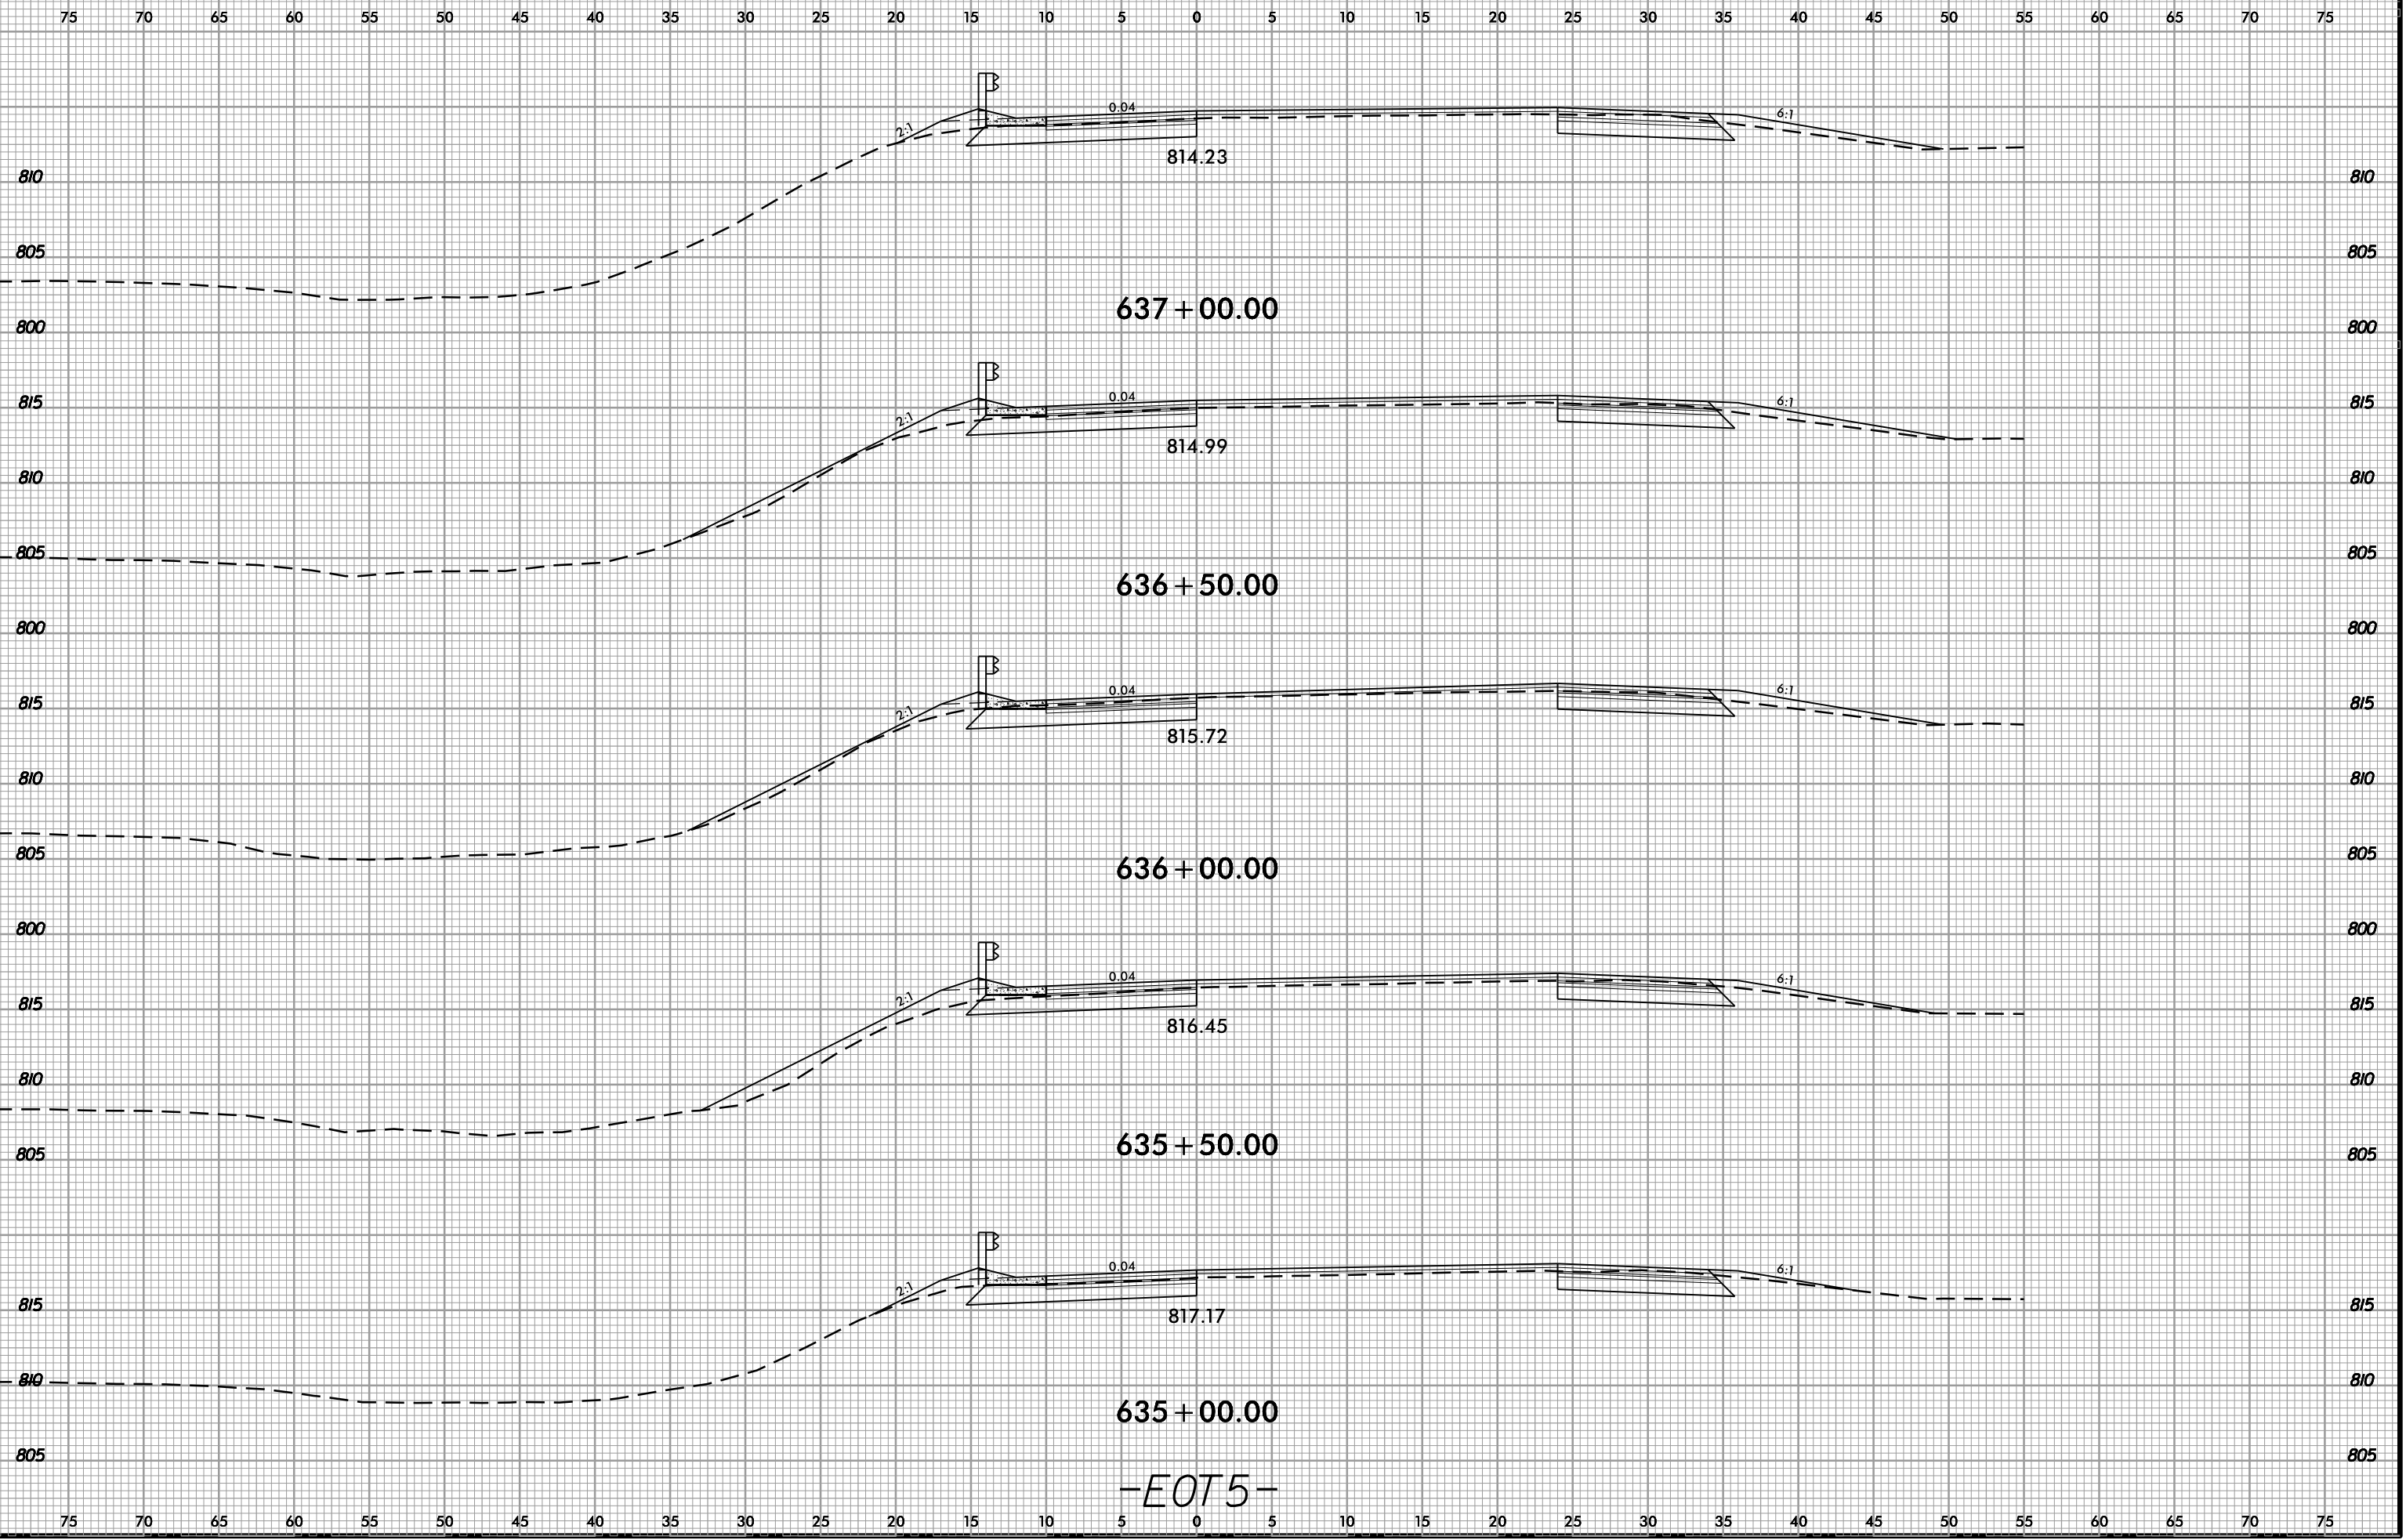


-EOT5-

6/23/16  
02-NOV-2018 13:47  
S:\Projects\_Development\JIP Projects\140-Dave\Roadway\DesignFiles\5823.ddc.xpl.EOT5.dgn  
AT DIV 294550

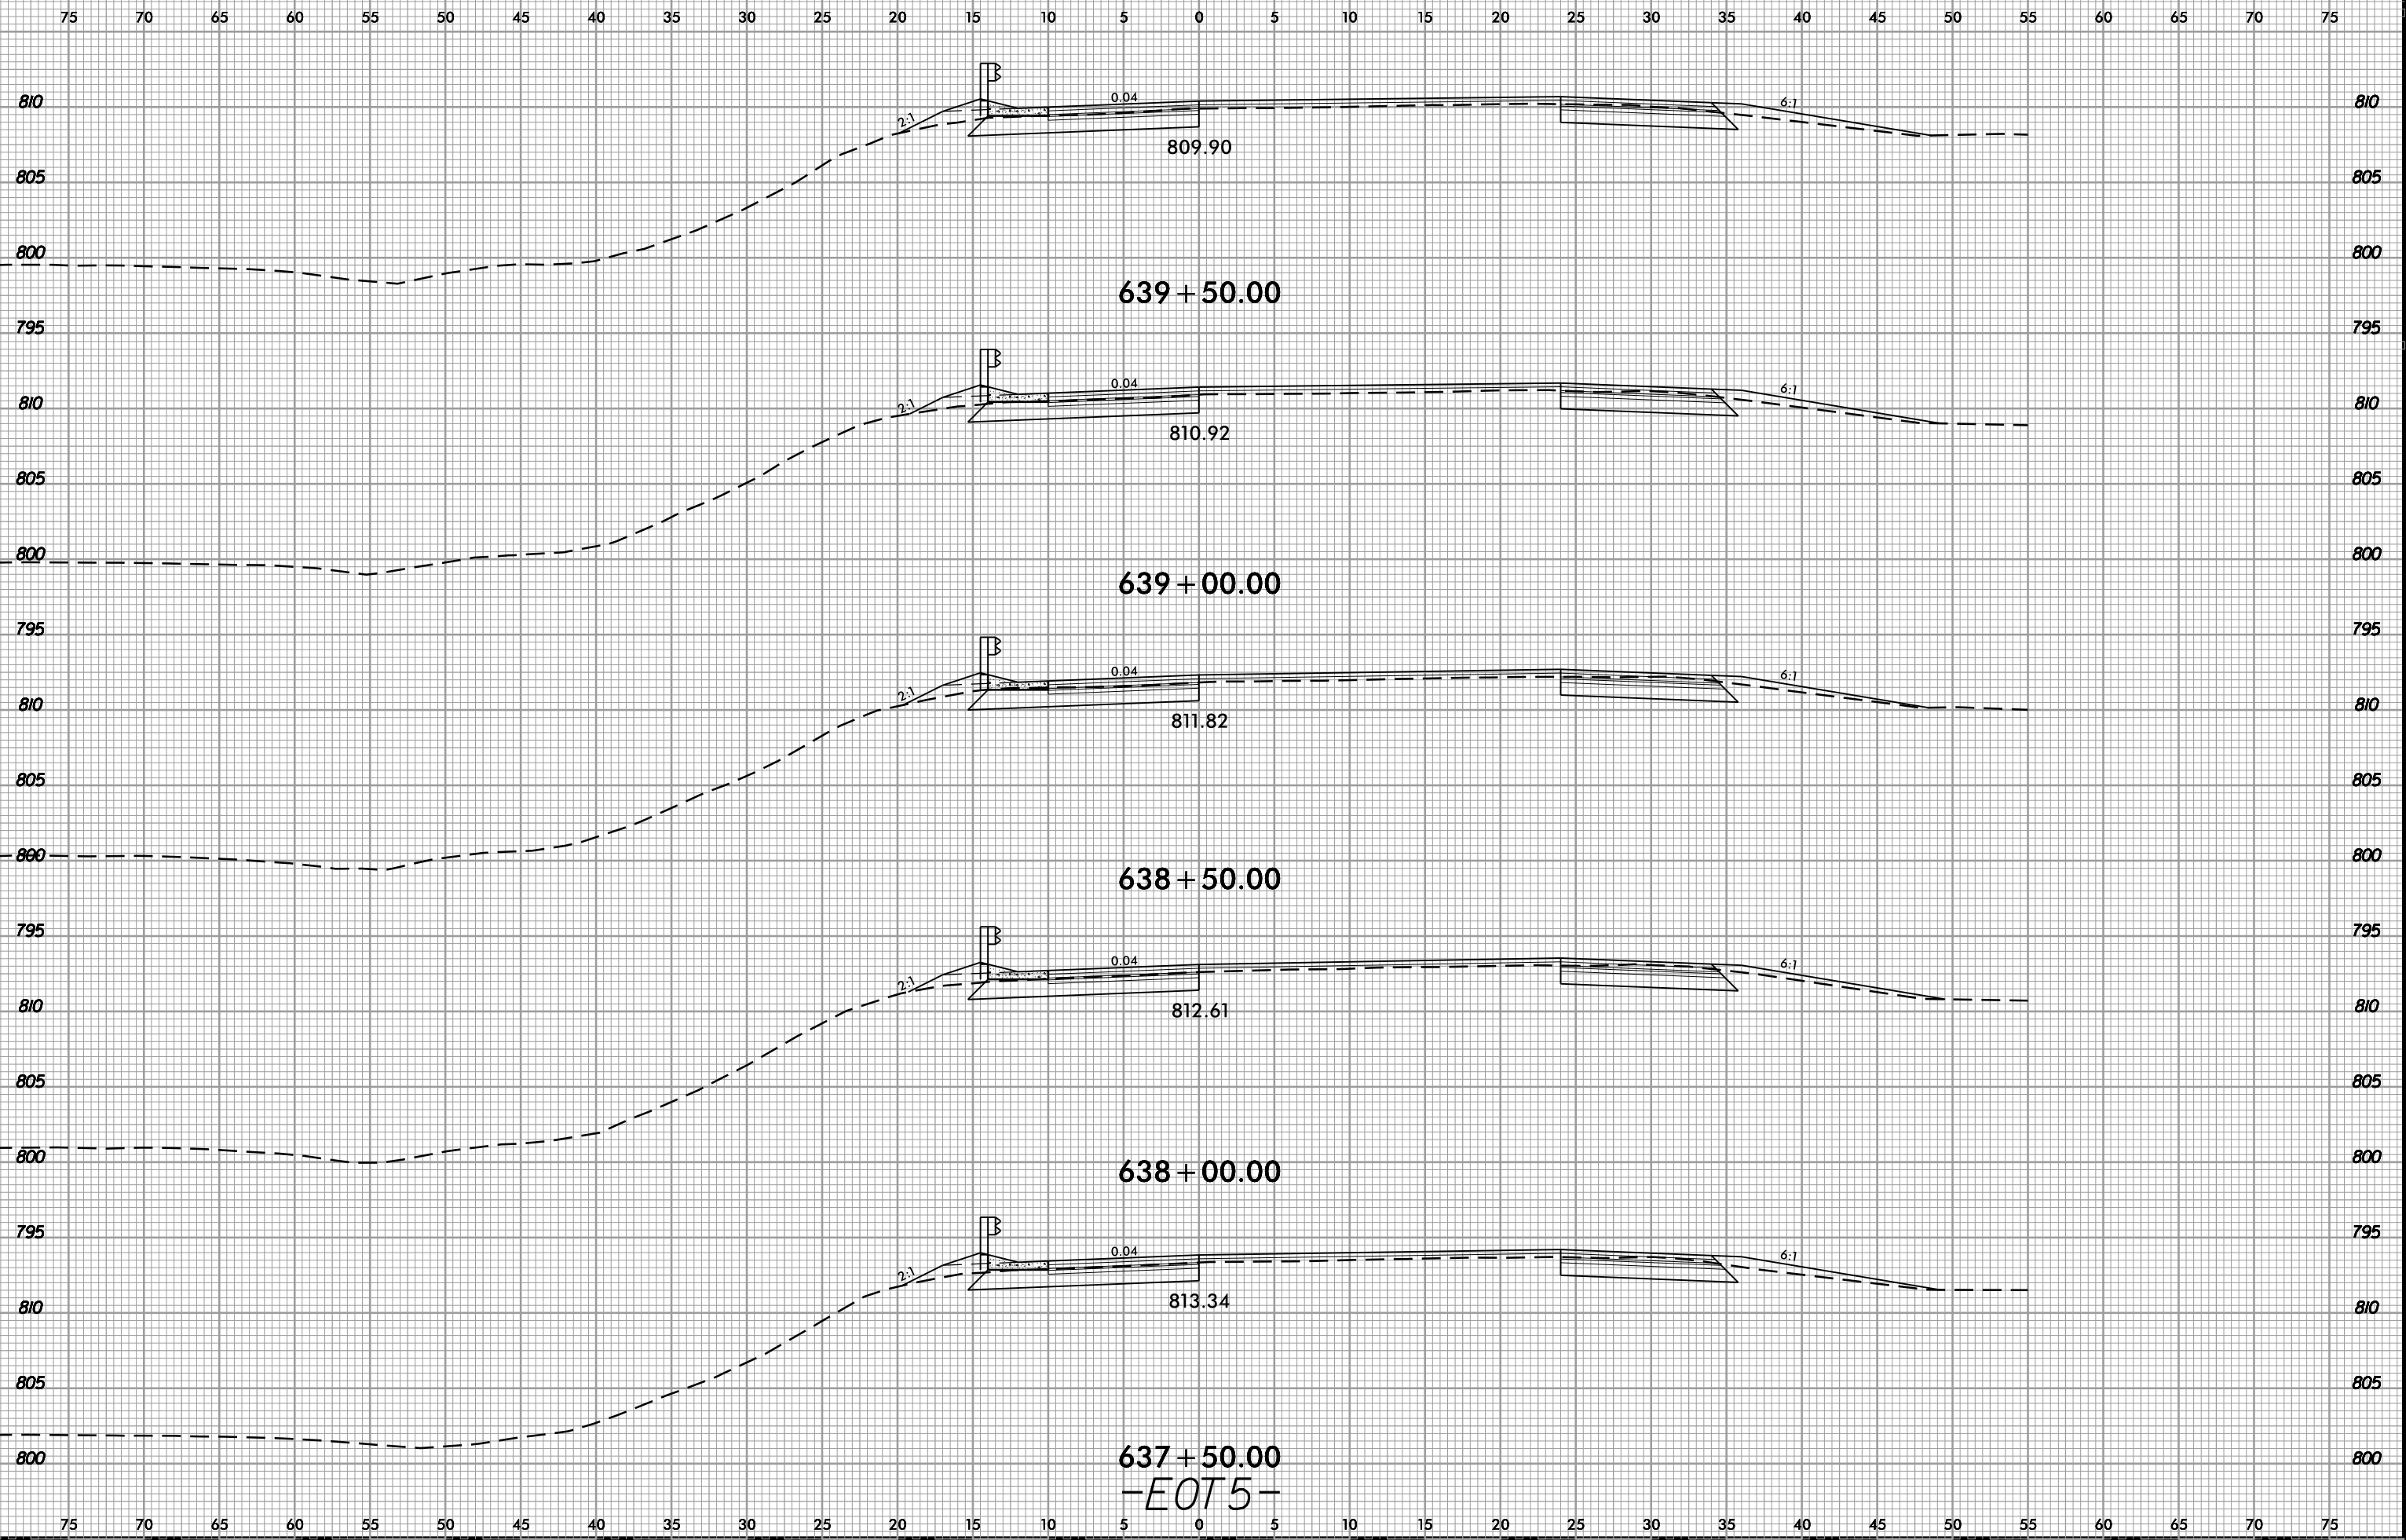


637+50.00  
-EOT5-

75 70 65 60 55 50 45 40 35 30 25 20 15 10 5 0 5 10 15 20 25 30 35 40 45 50 55 60 65 70 75

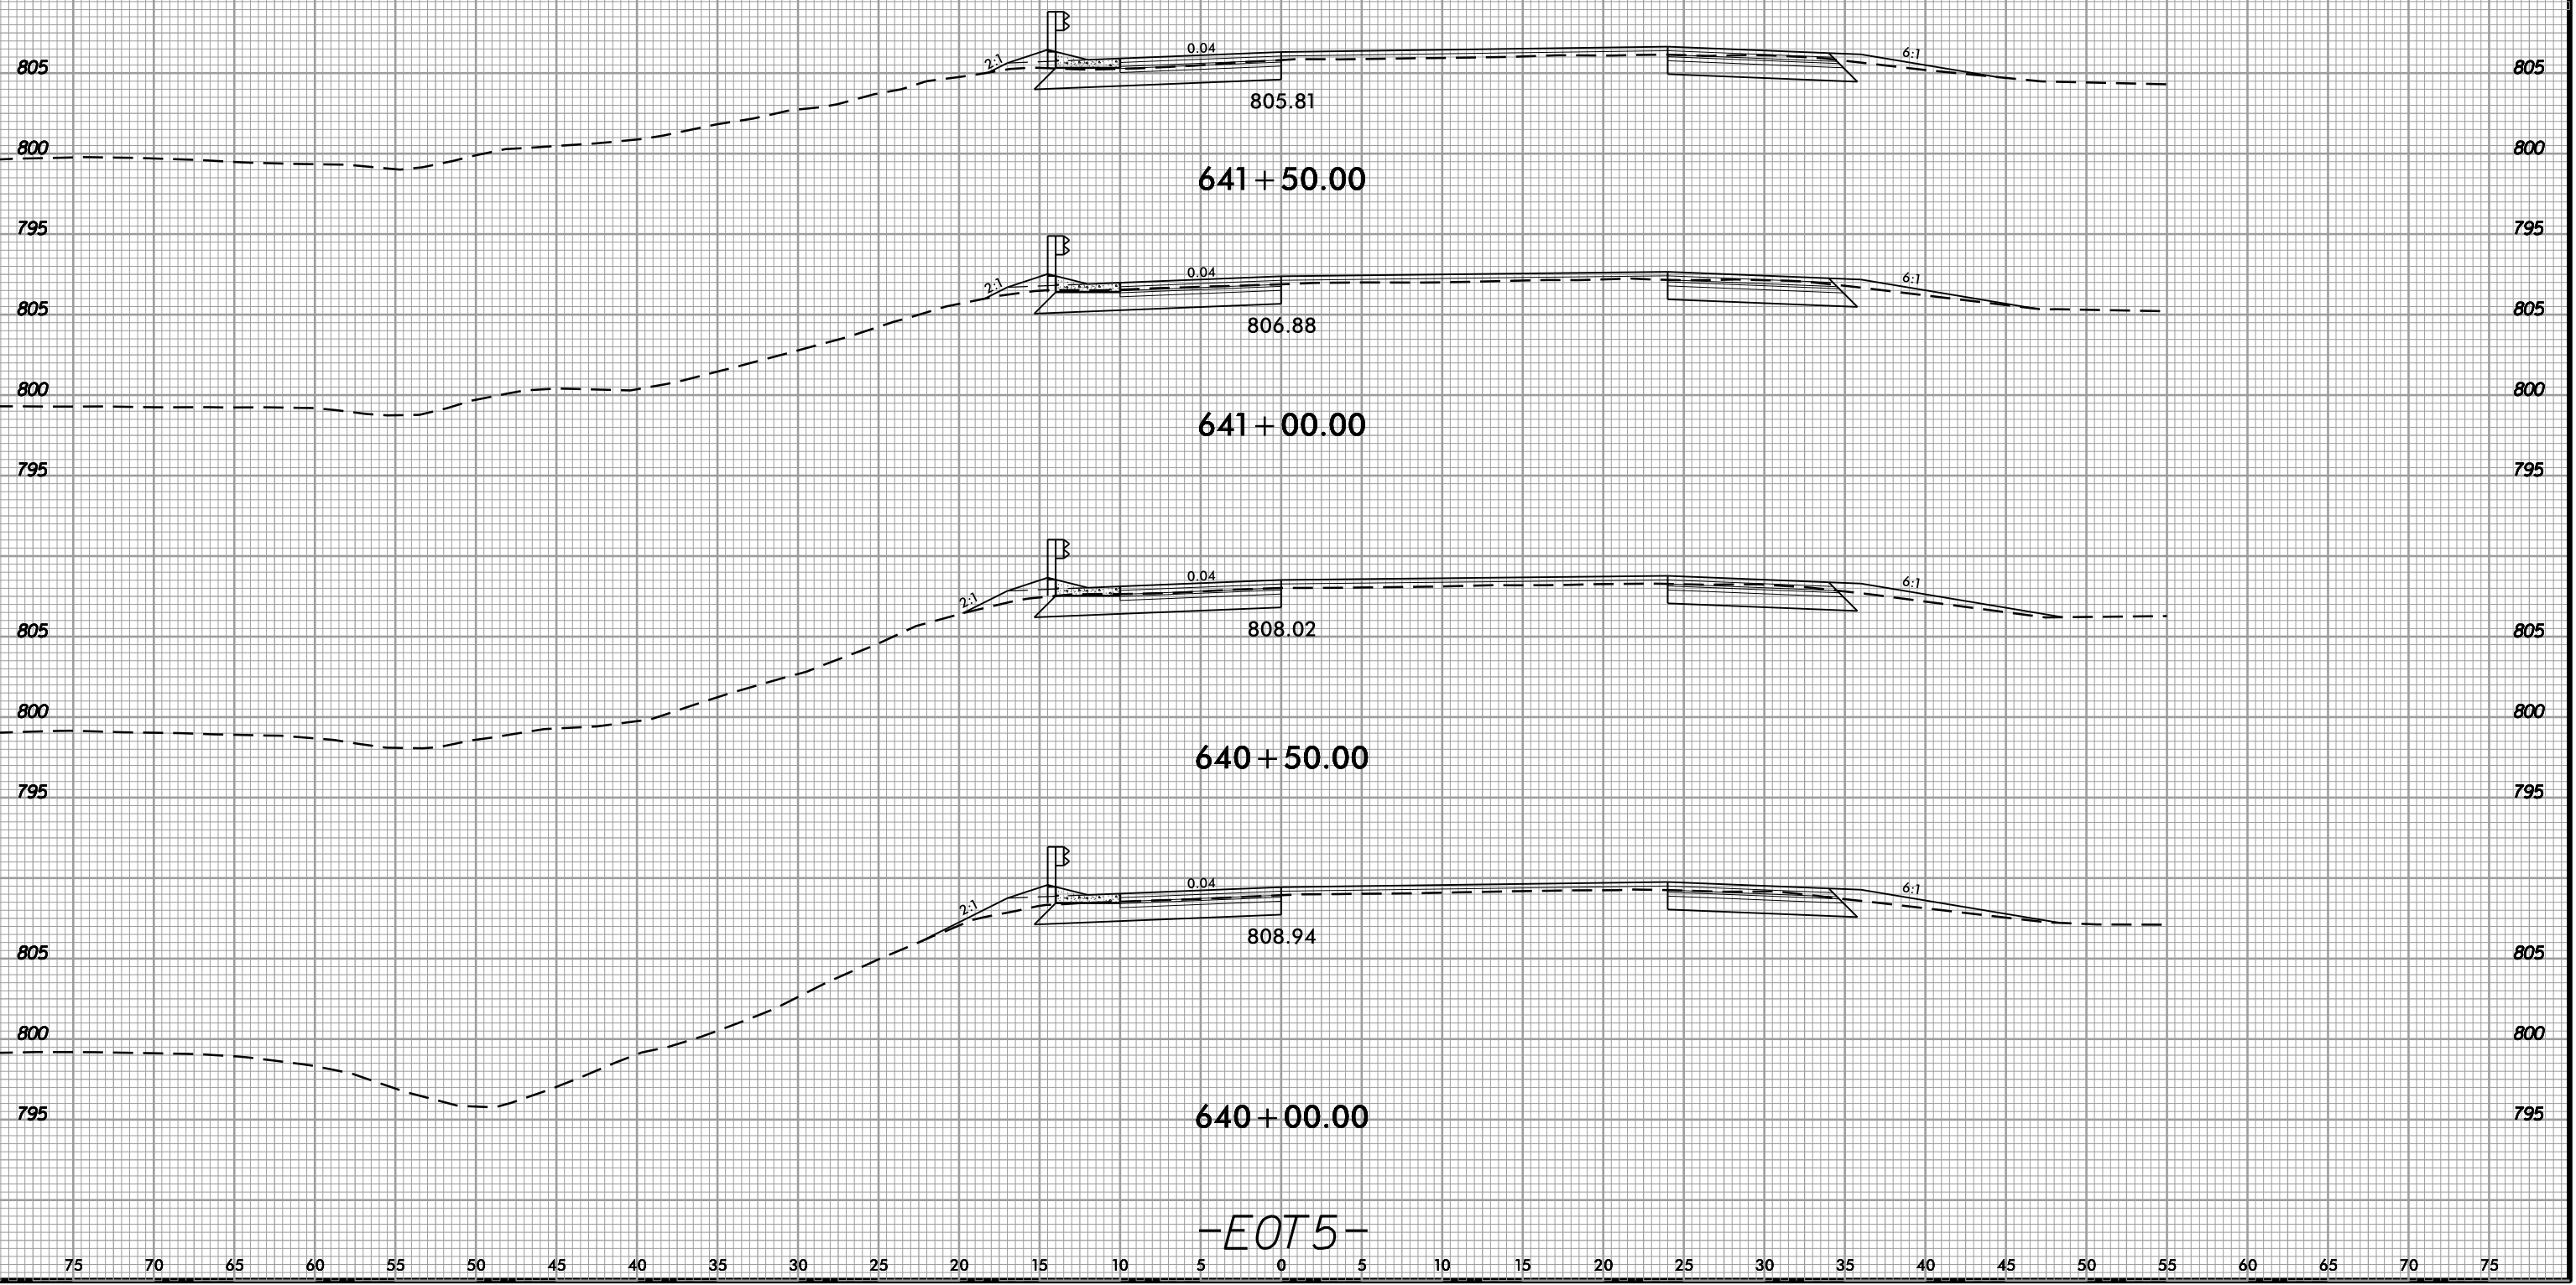

-EOT5-

6/23/16  
02-NOV-2018 13:47  
S:\Projects-Development\JIP Projects\140-Dave\Roadway\DesignFiles\5823.ddc.xpl.EOT6.dgn  
Mike@on AT DIV@294550

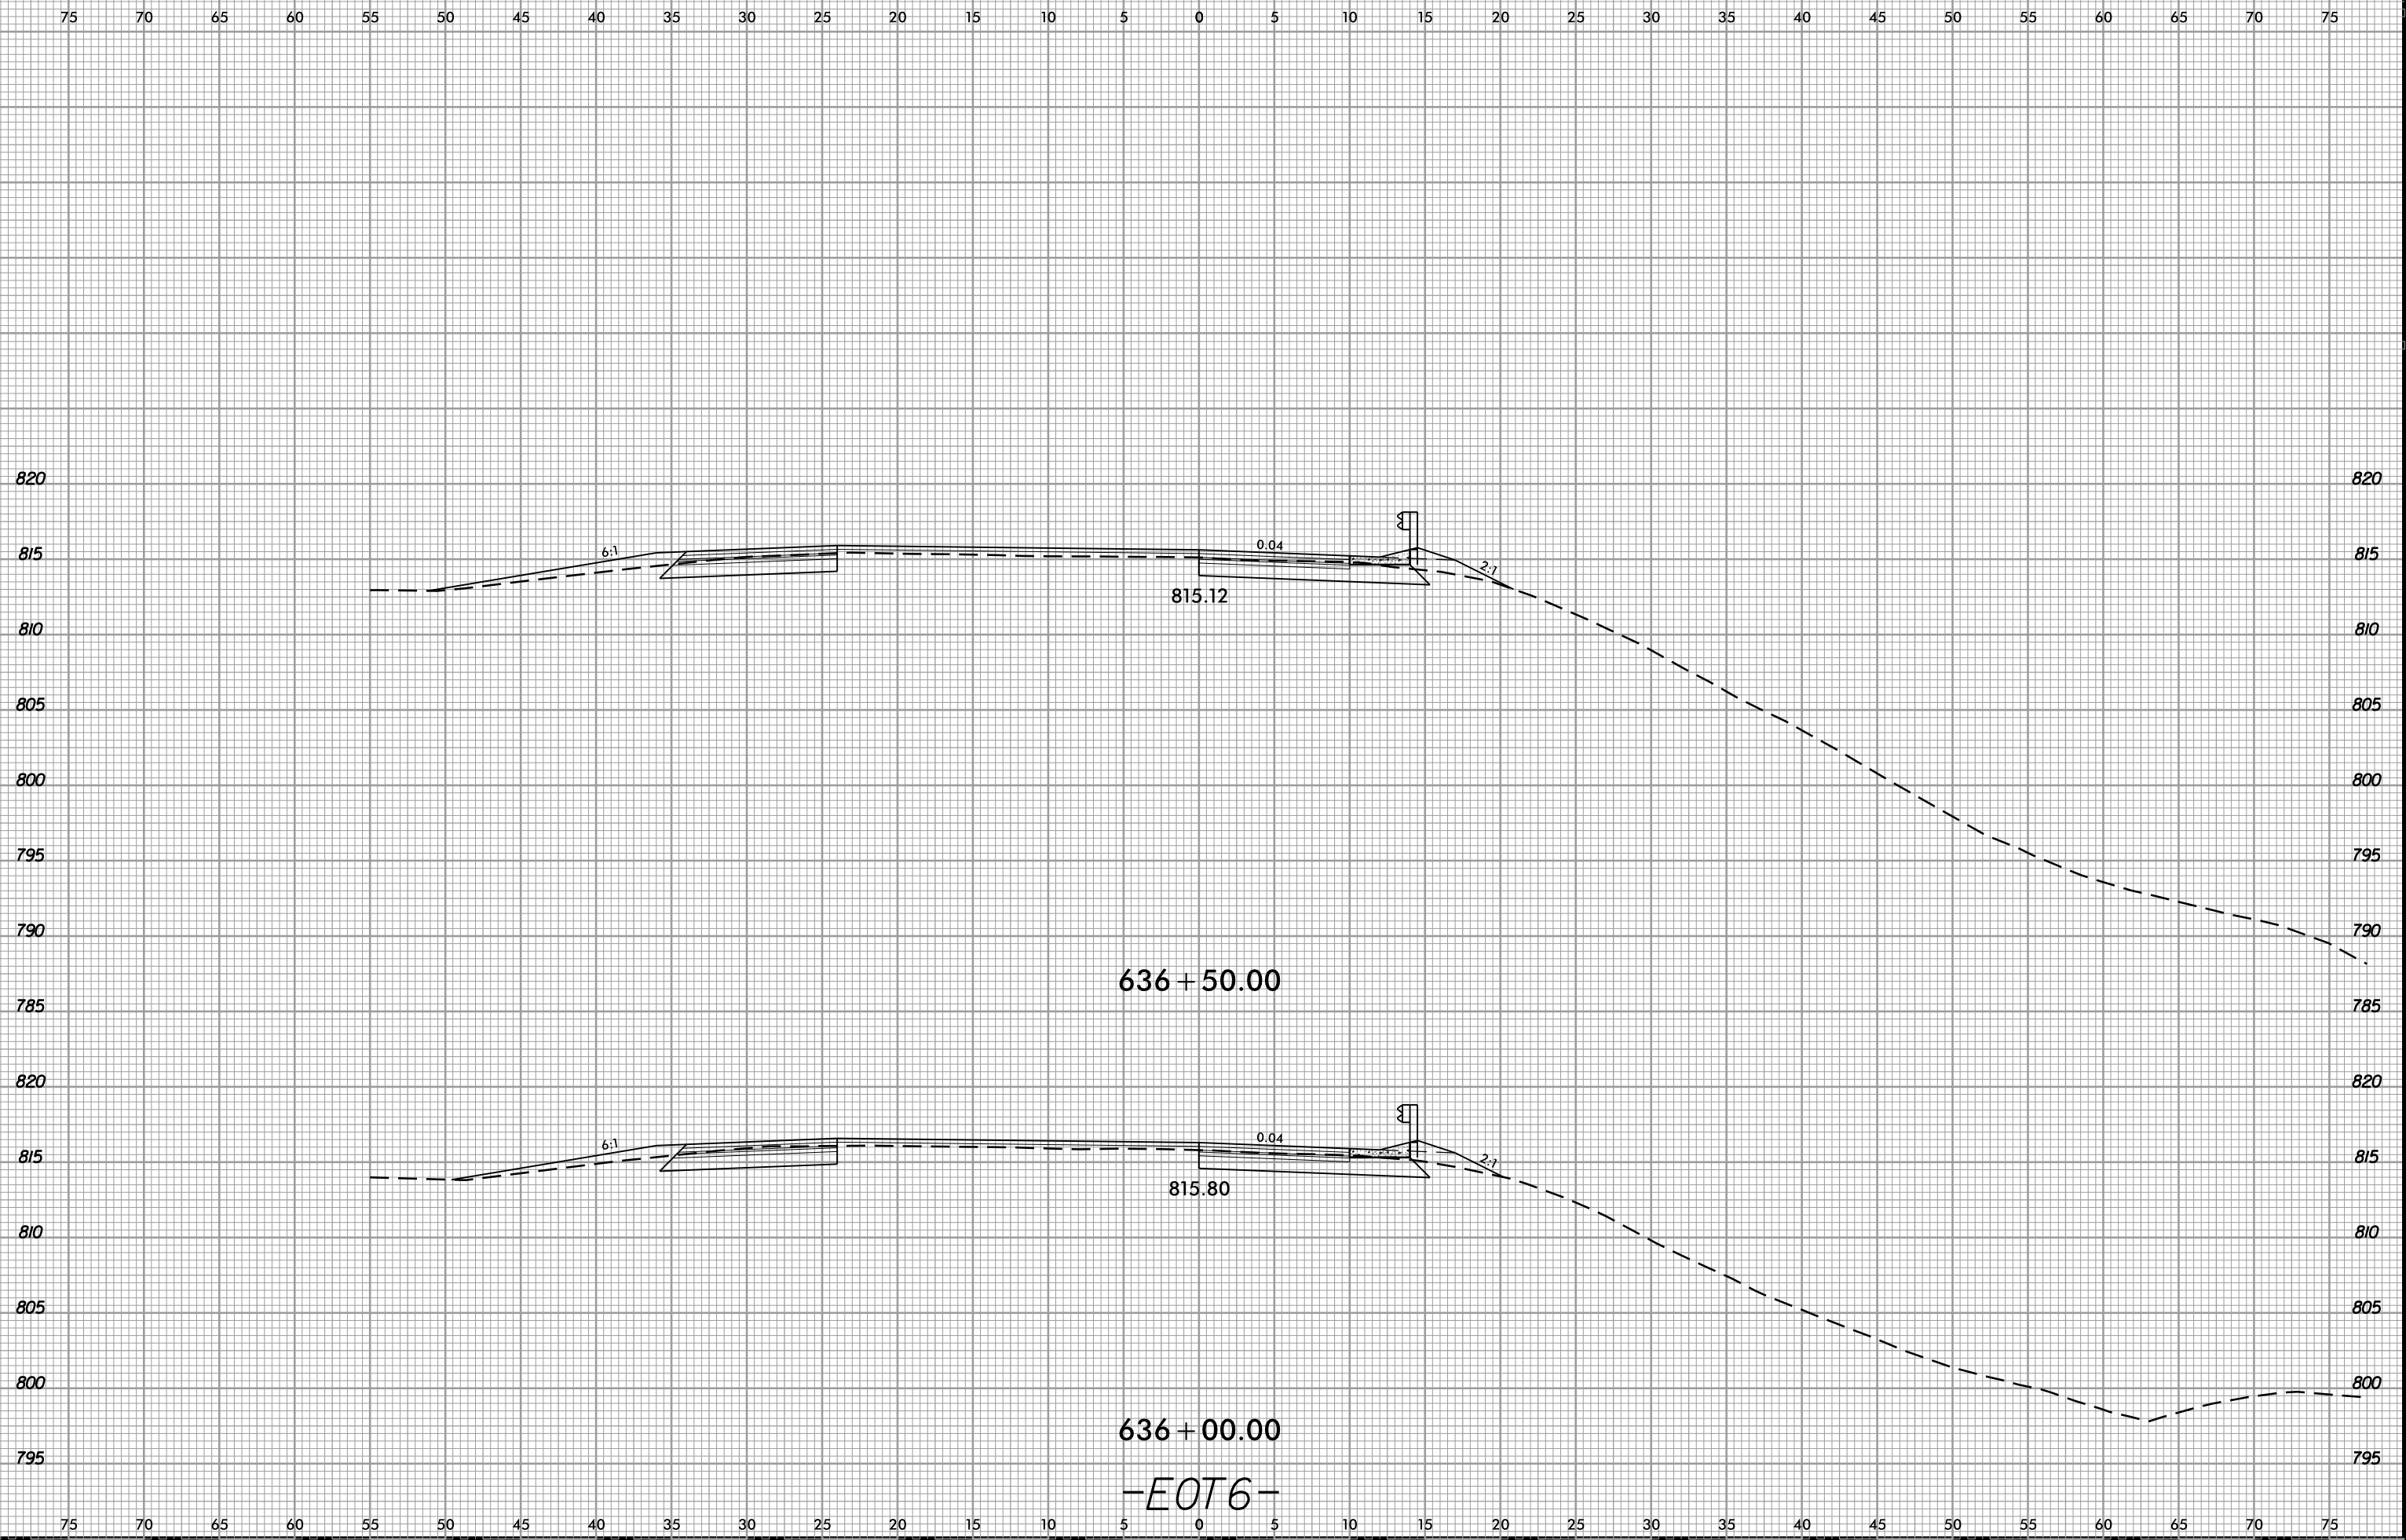


636 + 50.00

636 + 00.00

-EOT6-

75 70 65 60 55 50 45 40 35 30 25 20 15 10 5 0 5 10 15 20 25 30 35 40 45 50 55 60 65 70 75

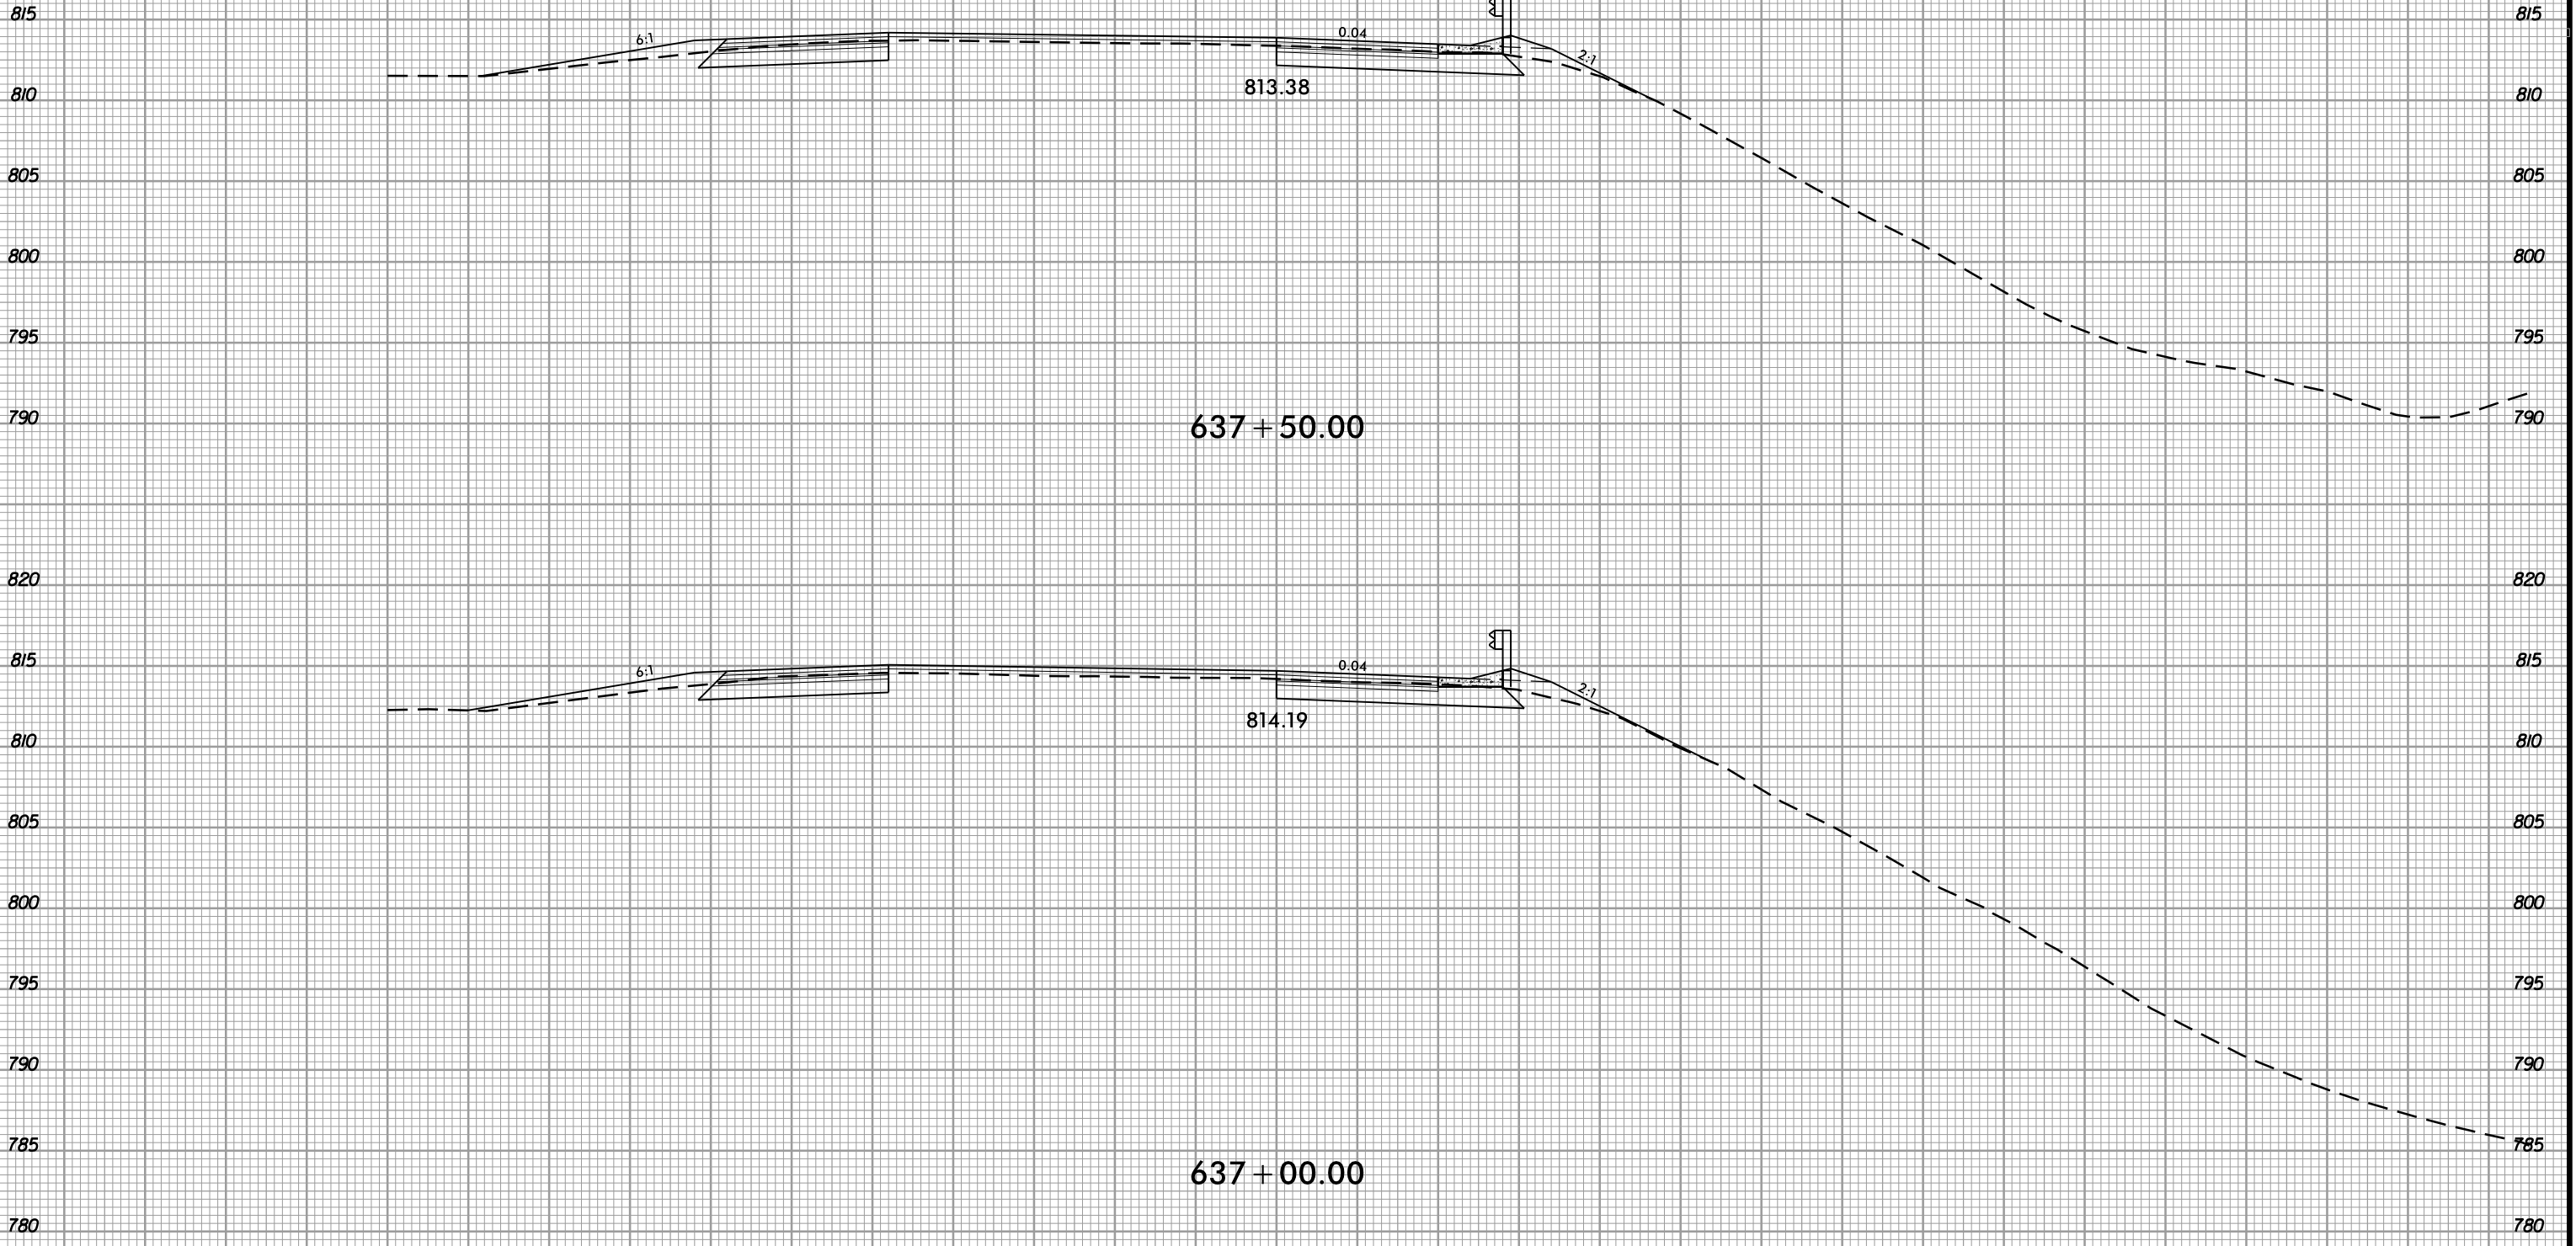

-EOT6-

75 70 65 60 55 50 45 40 35 30 25 20 15 10 5 0 5 10 15 20 25 30 35 40 45 50 55 60 65 70 75


6/23/16



PROJ. REFERENCE NO.  
I-5823

SHEET NO.  
X-30

75 70 65 60 55 50 45 40 35 30 25 20 15 10 5 0 5 10 15 20 25 30 35 40 45 50 55 60 65 70 75

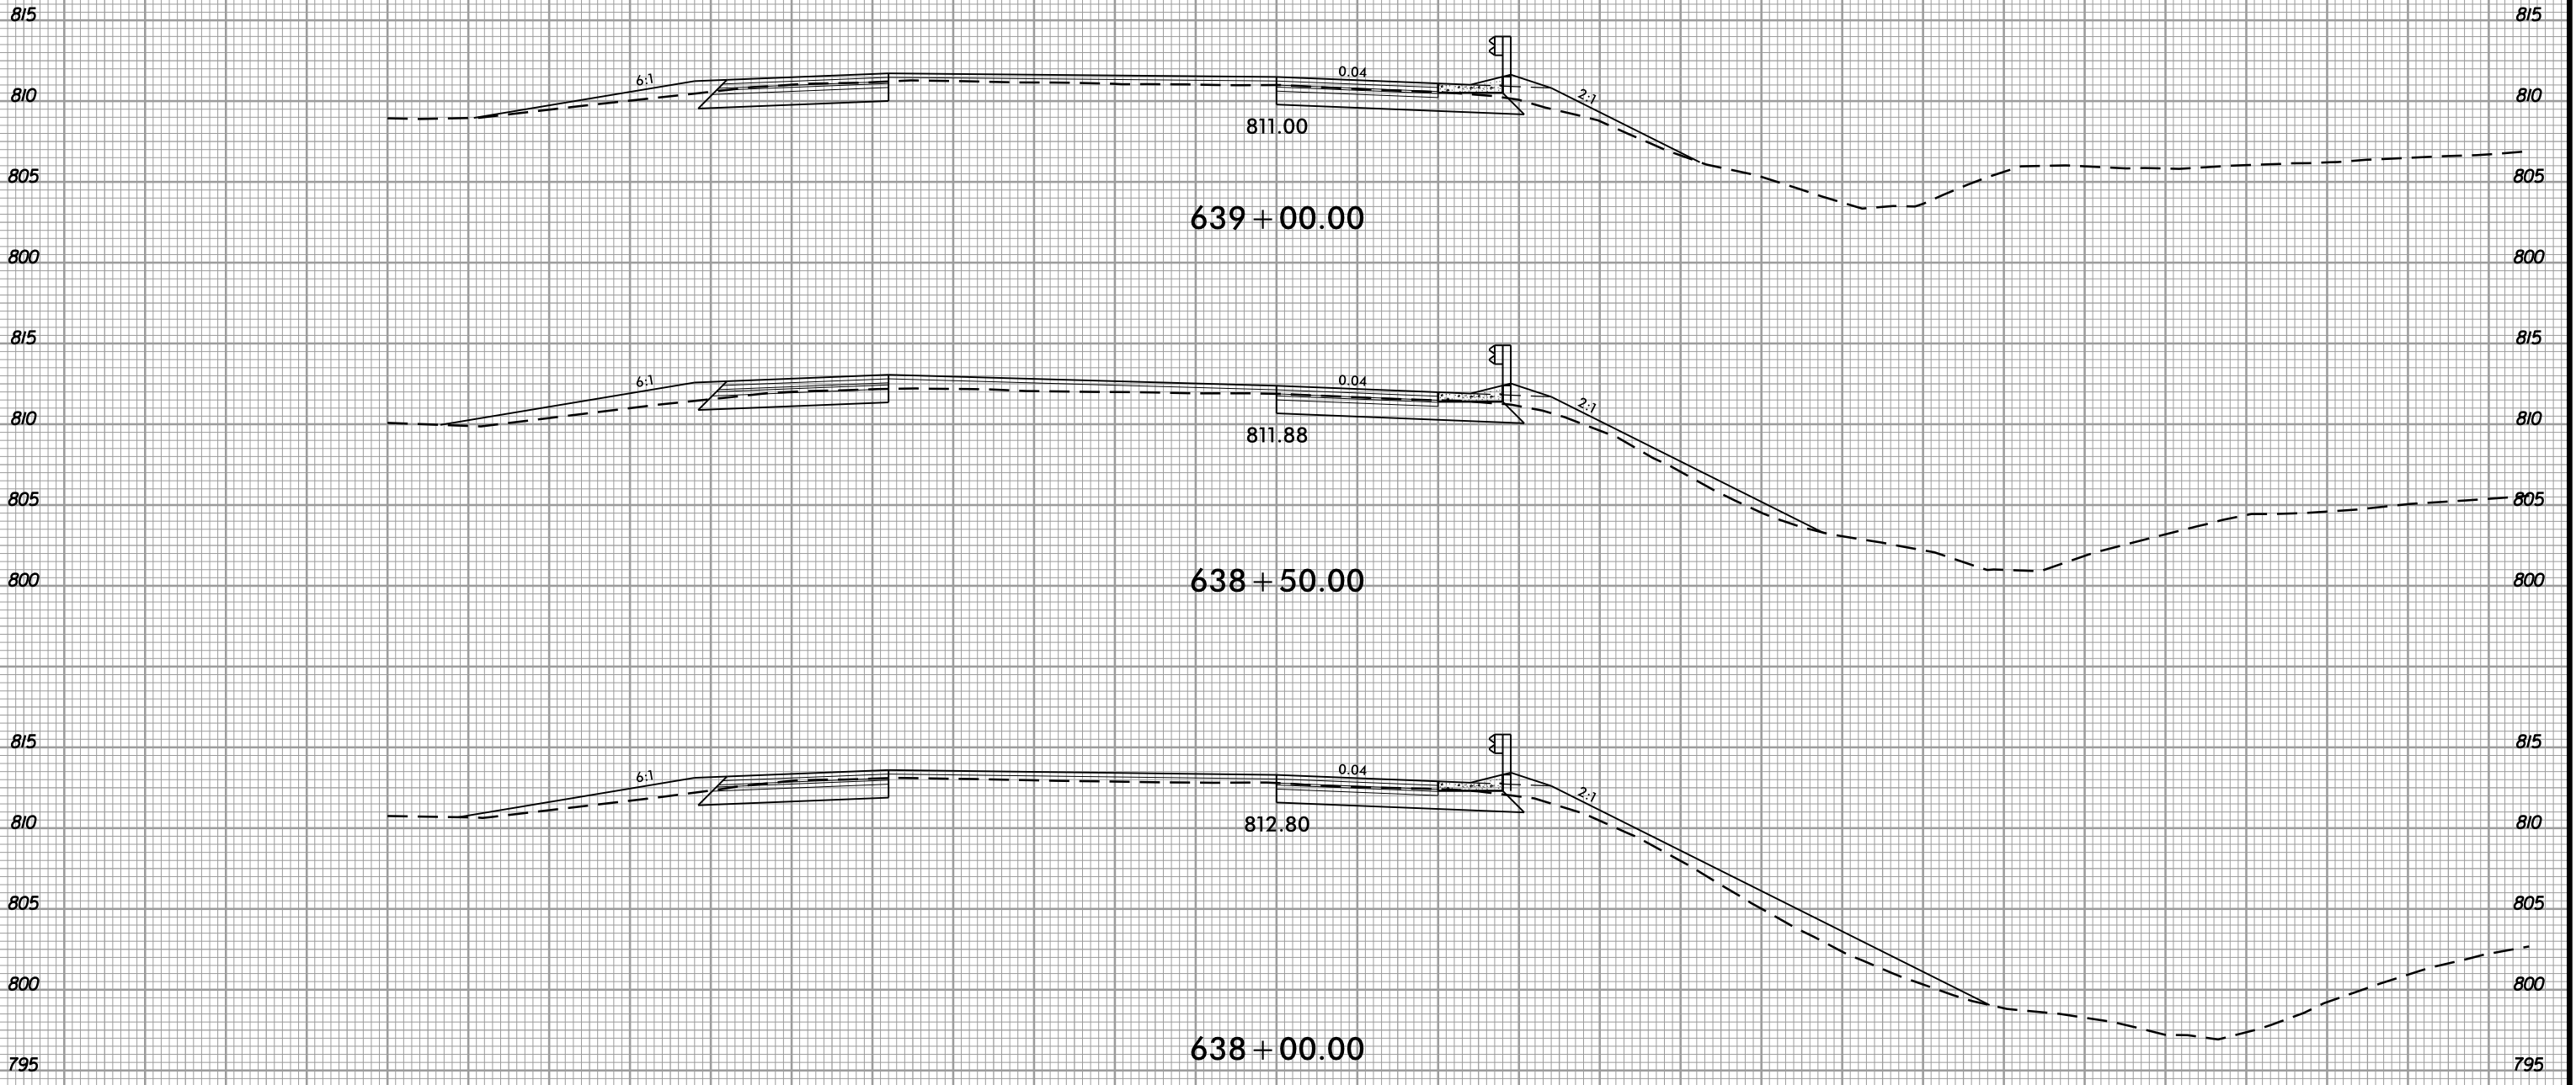


-EOT6-

02-NOV-2018 13:48  
S:\Project-Development\IP Projects\I-5823-140-Dave\Roadway\DesignFiles\5823.ddc.xpl.EOT6.dgn  
Ikeation AT DIV 9-294550

75 70 65 60 55 50 45 40 35 30 25 20 15 10 5 0 5 10 15 20 25 30 35 40 45 50 55 60 65 70 75


6/23/16  
02-NOV-2018 13:48  
S:\Projects-Development\IP Projects\1-5823-140-Dave Roadway\DesignFiles\5823.dwg - xpl.EOT7.dgn  
AT DIV 294550

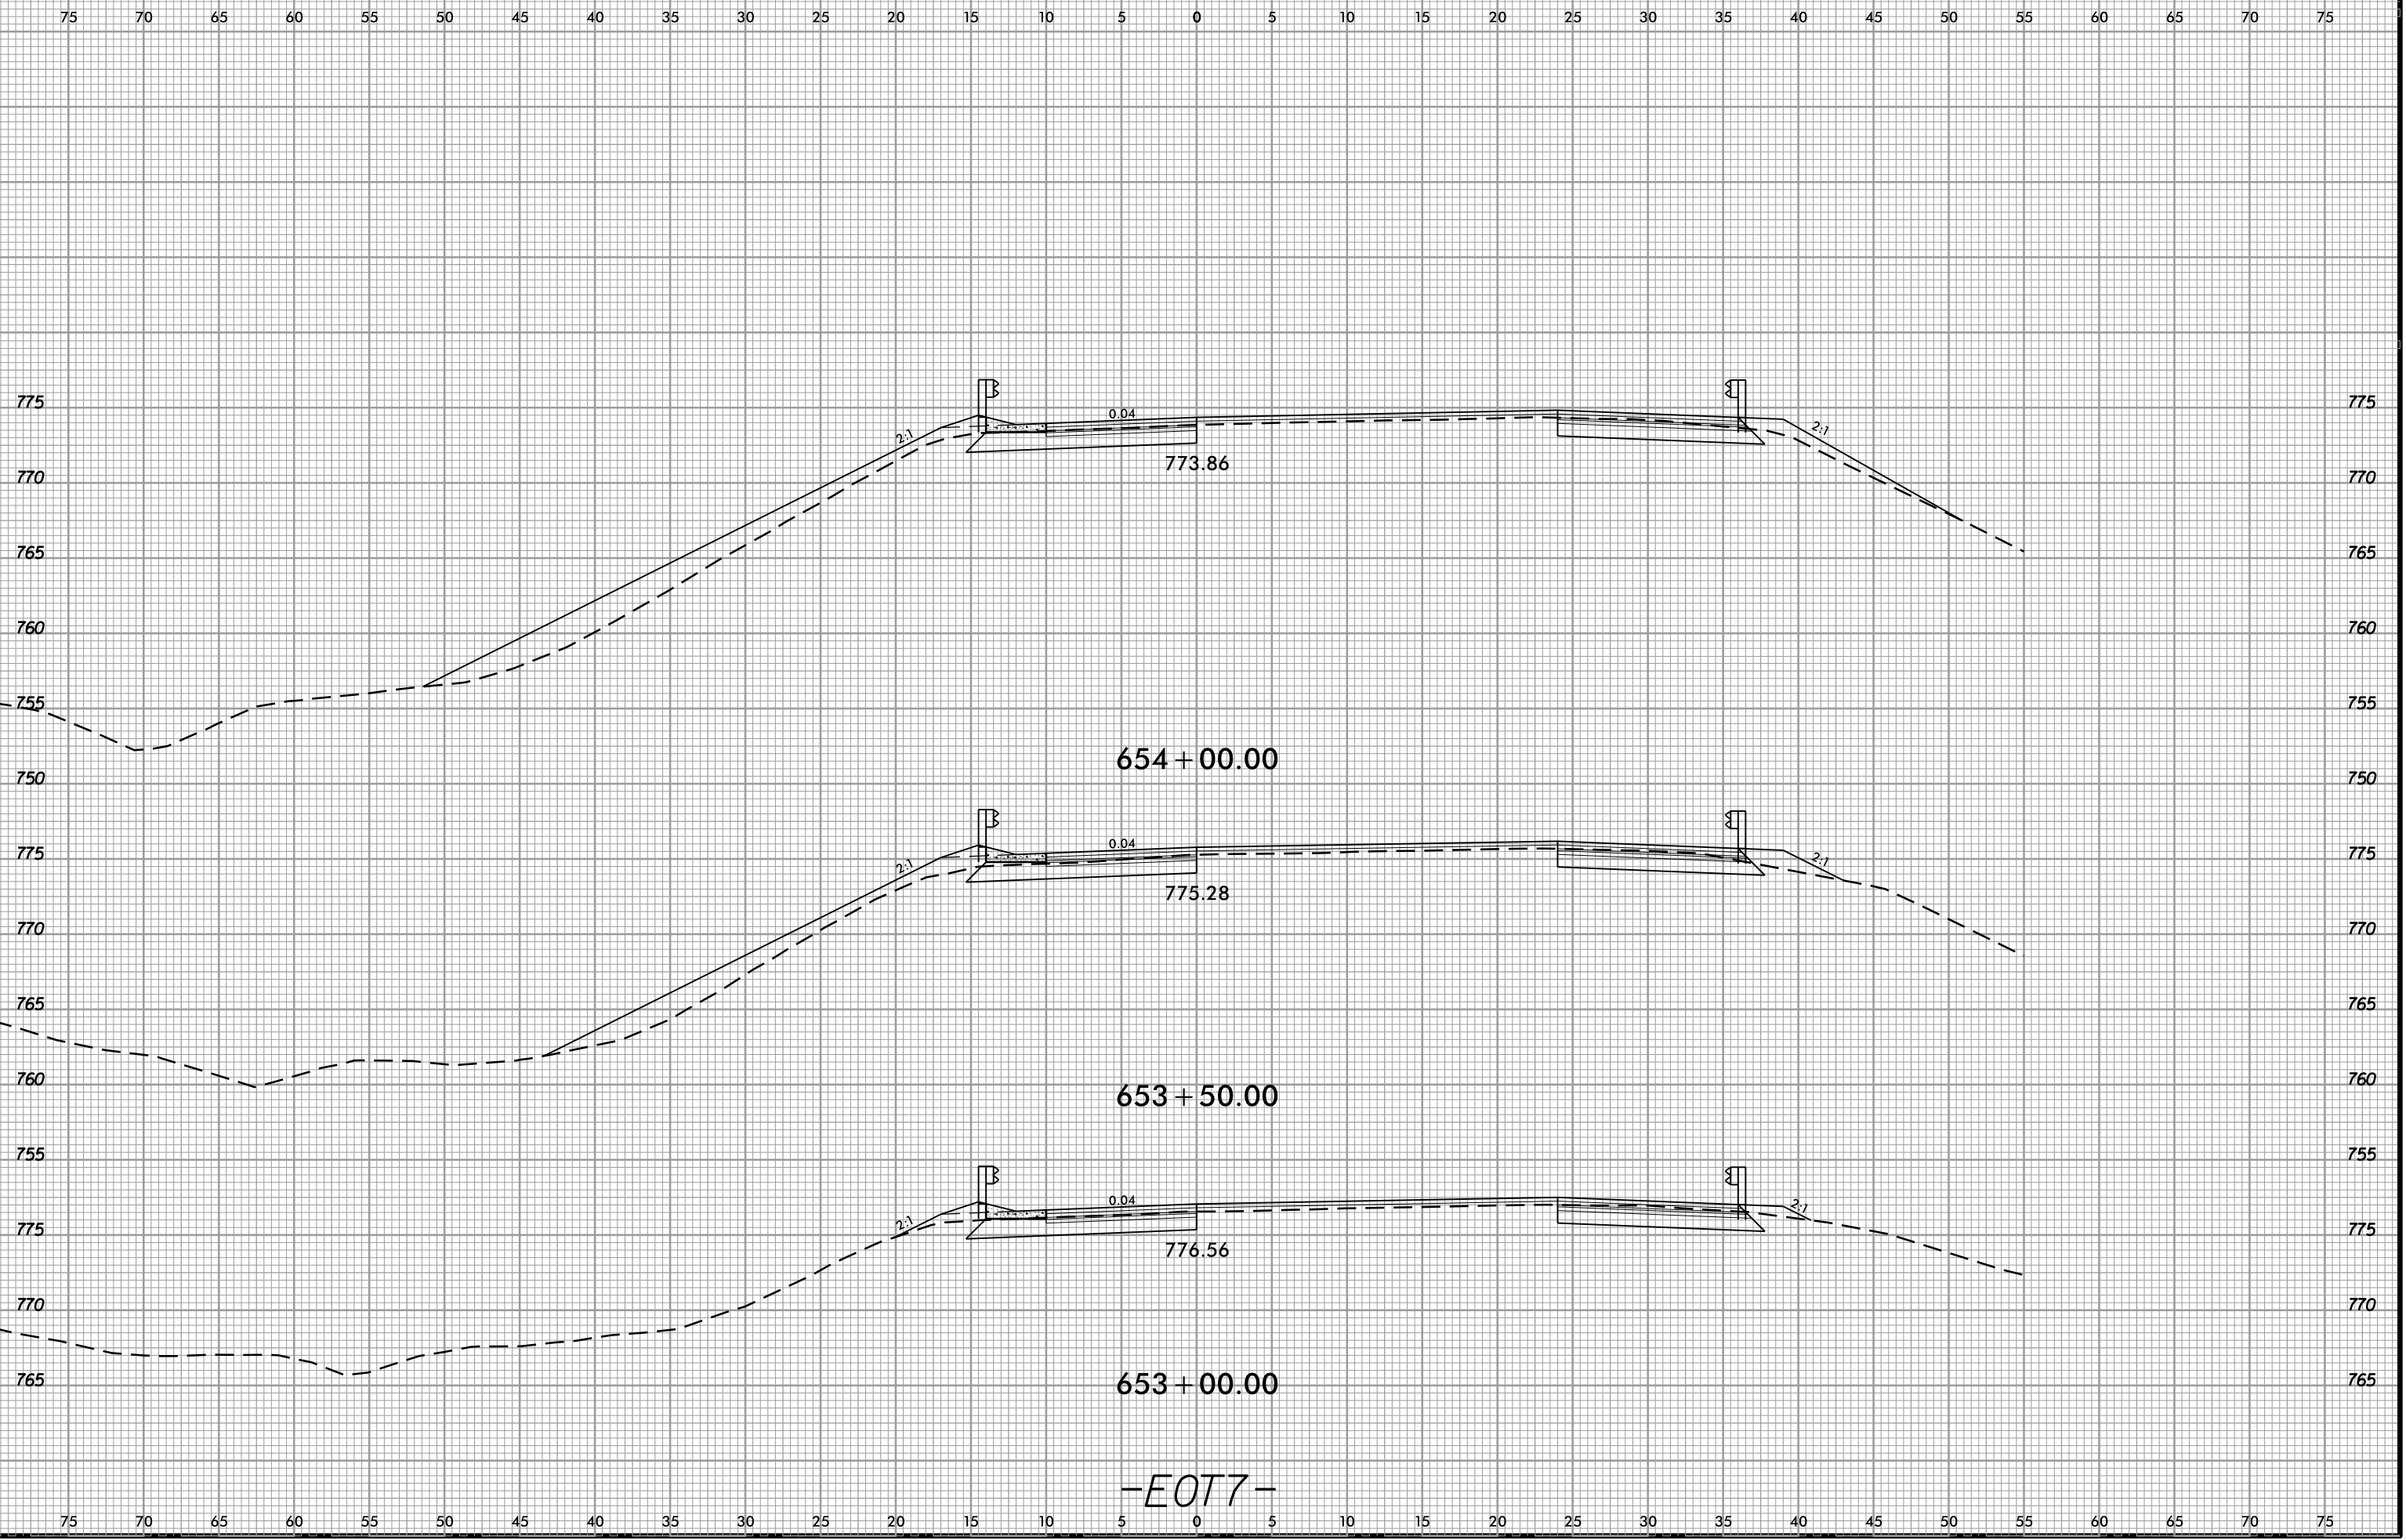


-EOT7-



6/23/16  
02-NOV-2018 13:48  
S:\Projects-Development\JIP Projects\140-Dave\Roadway\DesignFiles\5823.ddc.xpl.EOT7.dgn  
At Division 20450

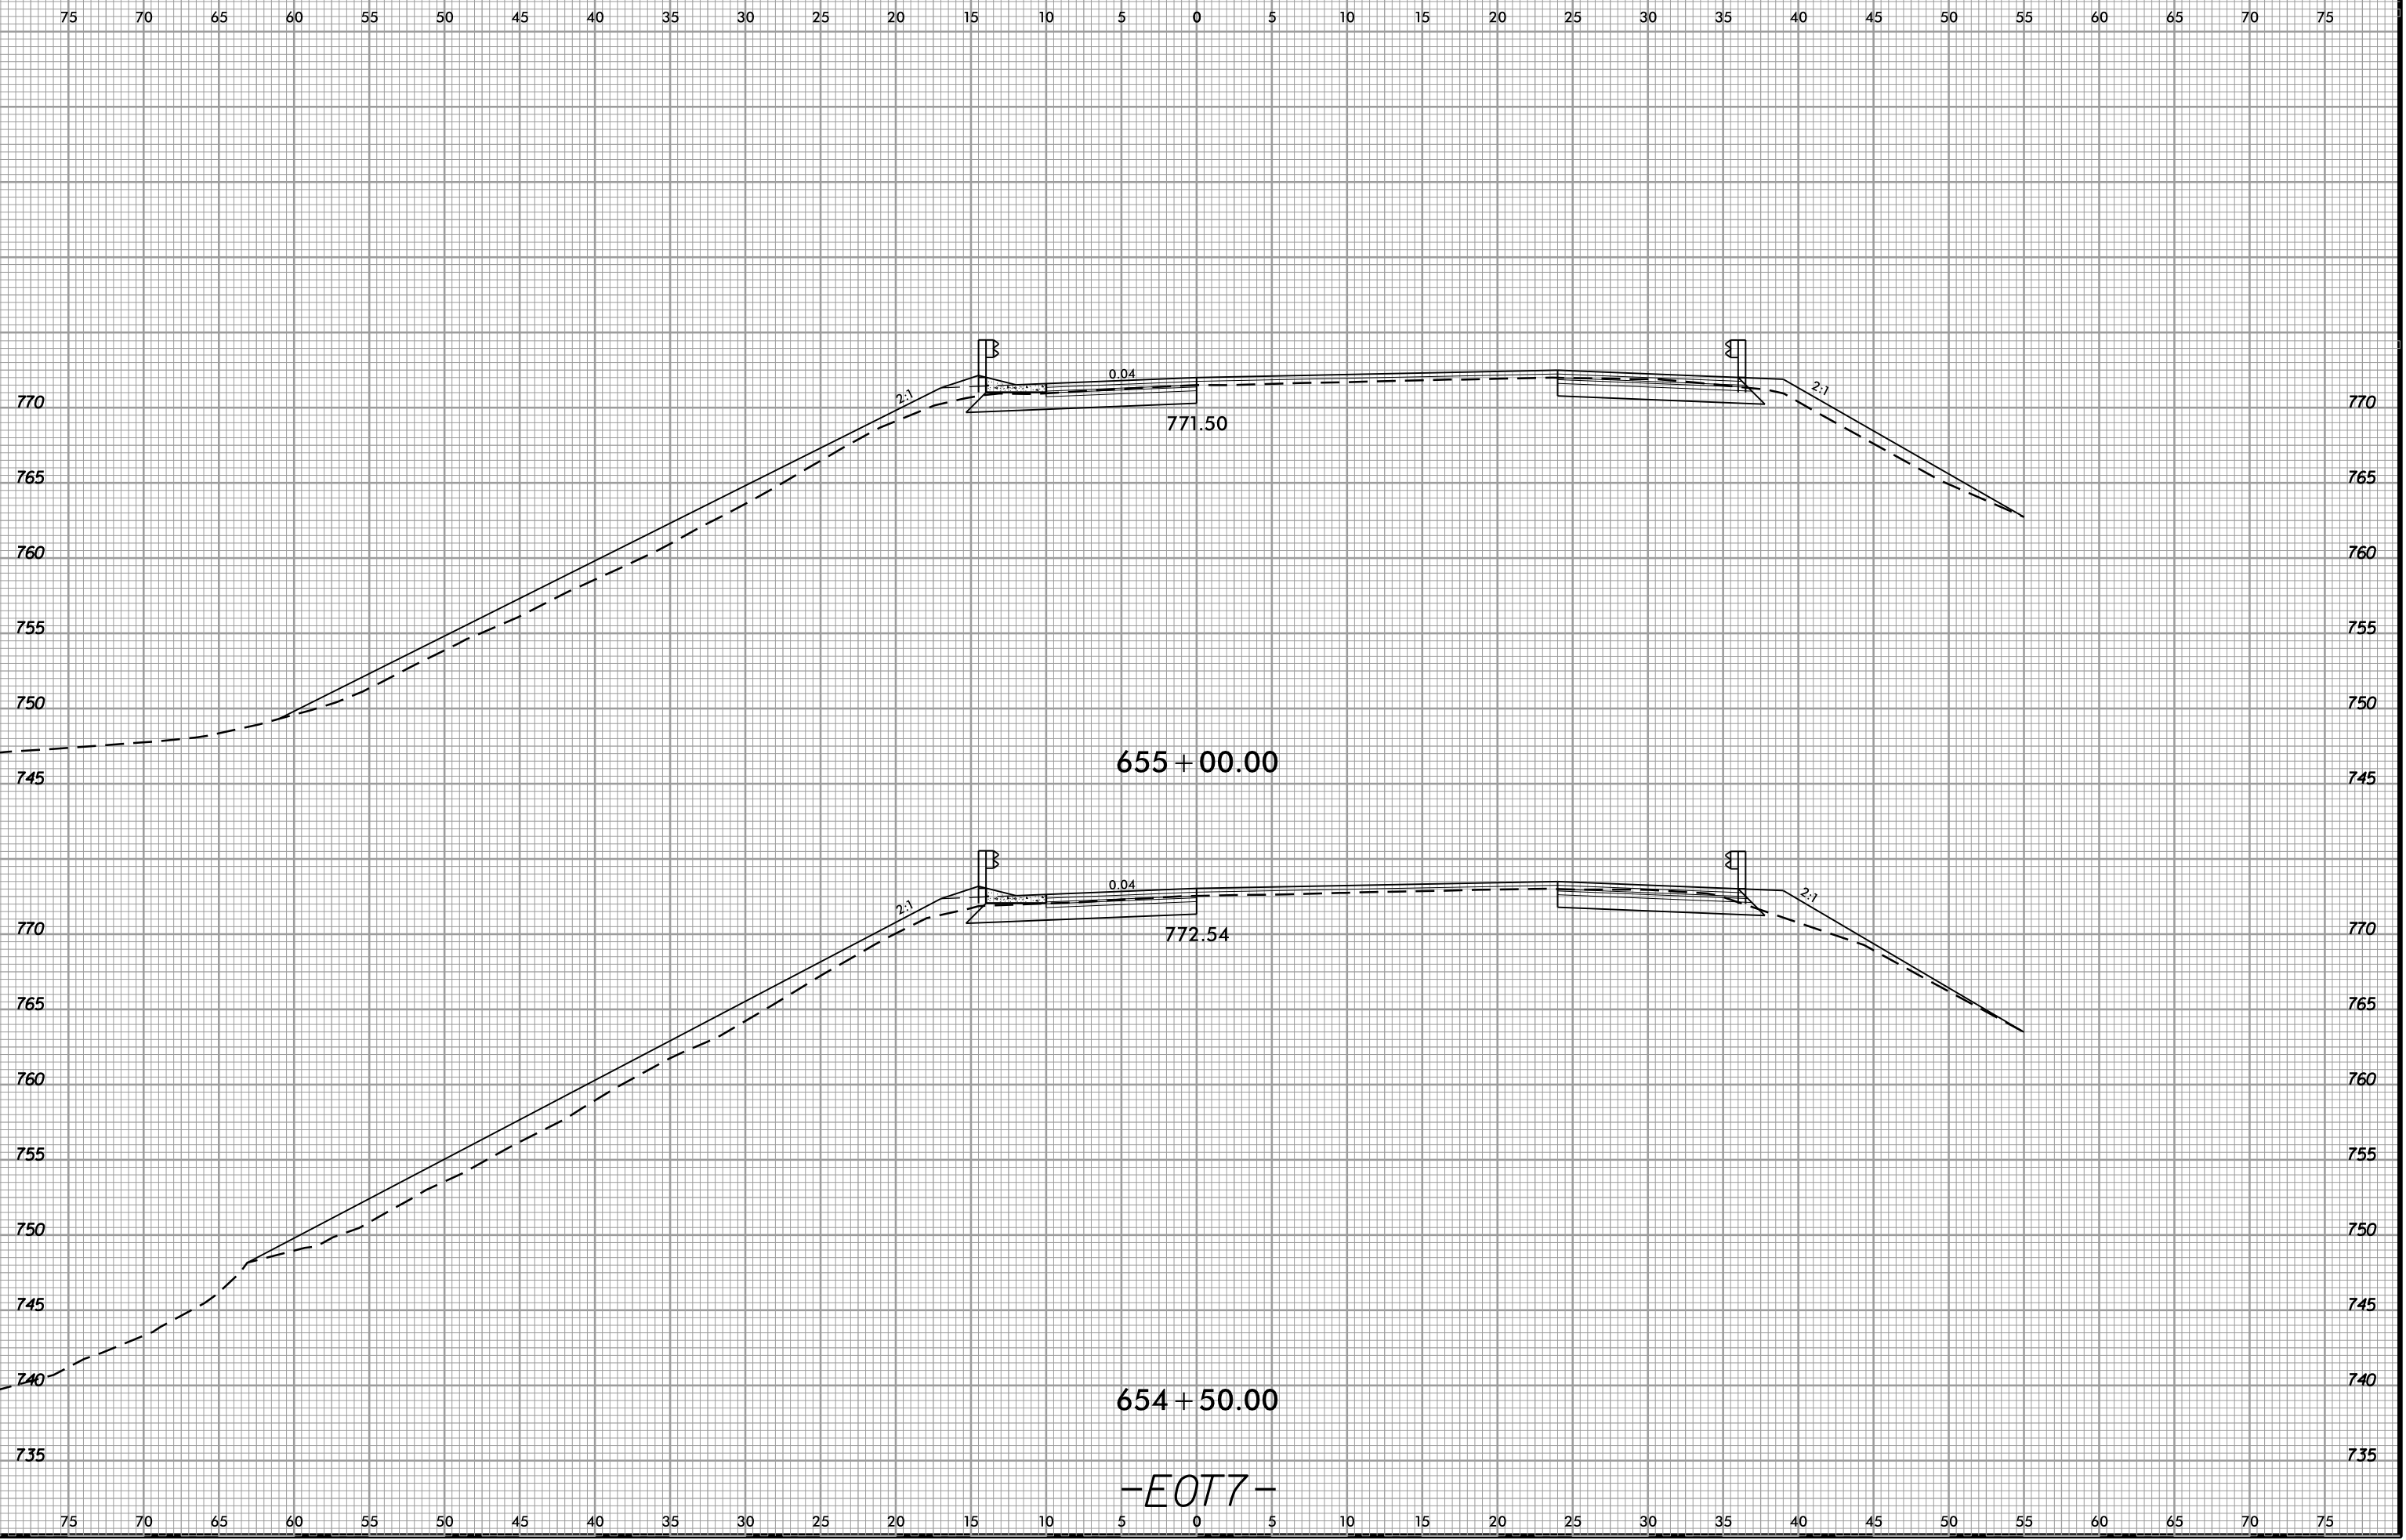


 6/23/16  
02-NOV-2018 13:48  
S:\Projects-Development\IP Projects\1-5823-140-Dave\Roadway\DesignFiles\5823.dwg - xpl.EOT7.dgn  
1:1  
AT DIV 29450



PROJ. REFERENCE NO.  
I-5823

SHEET NO.  
X-33

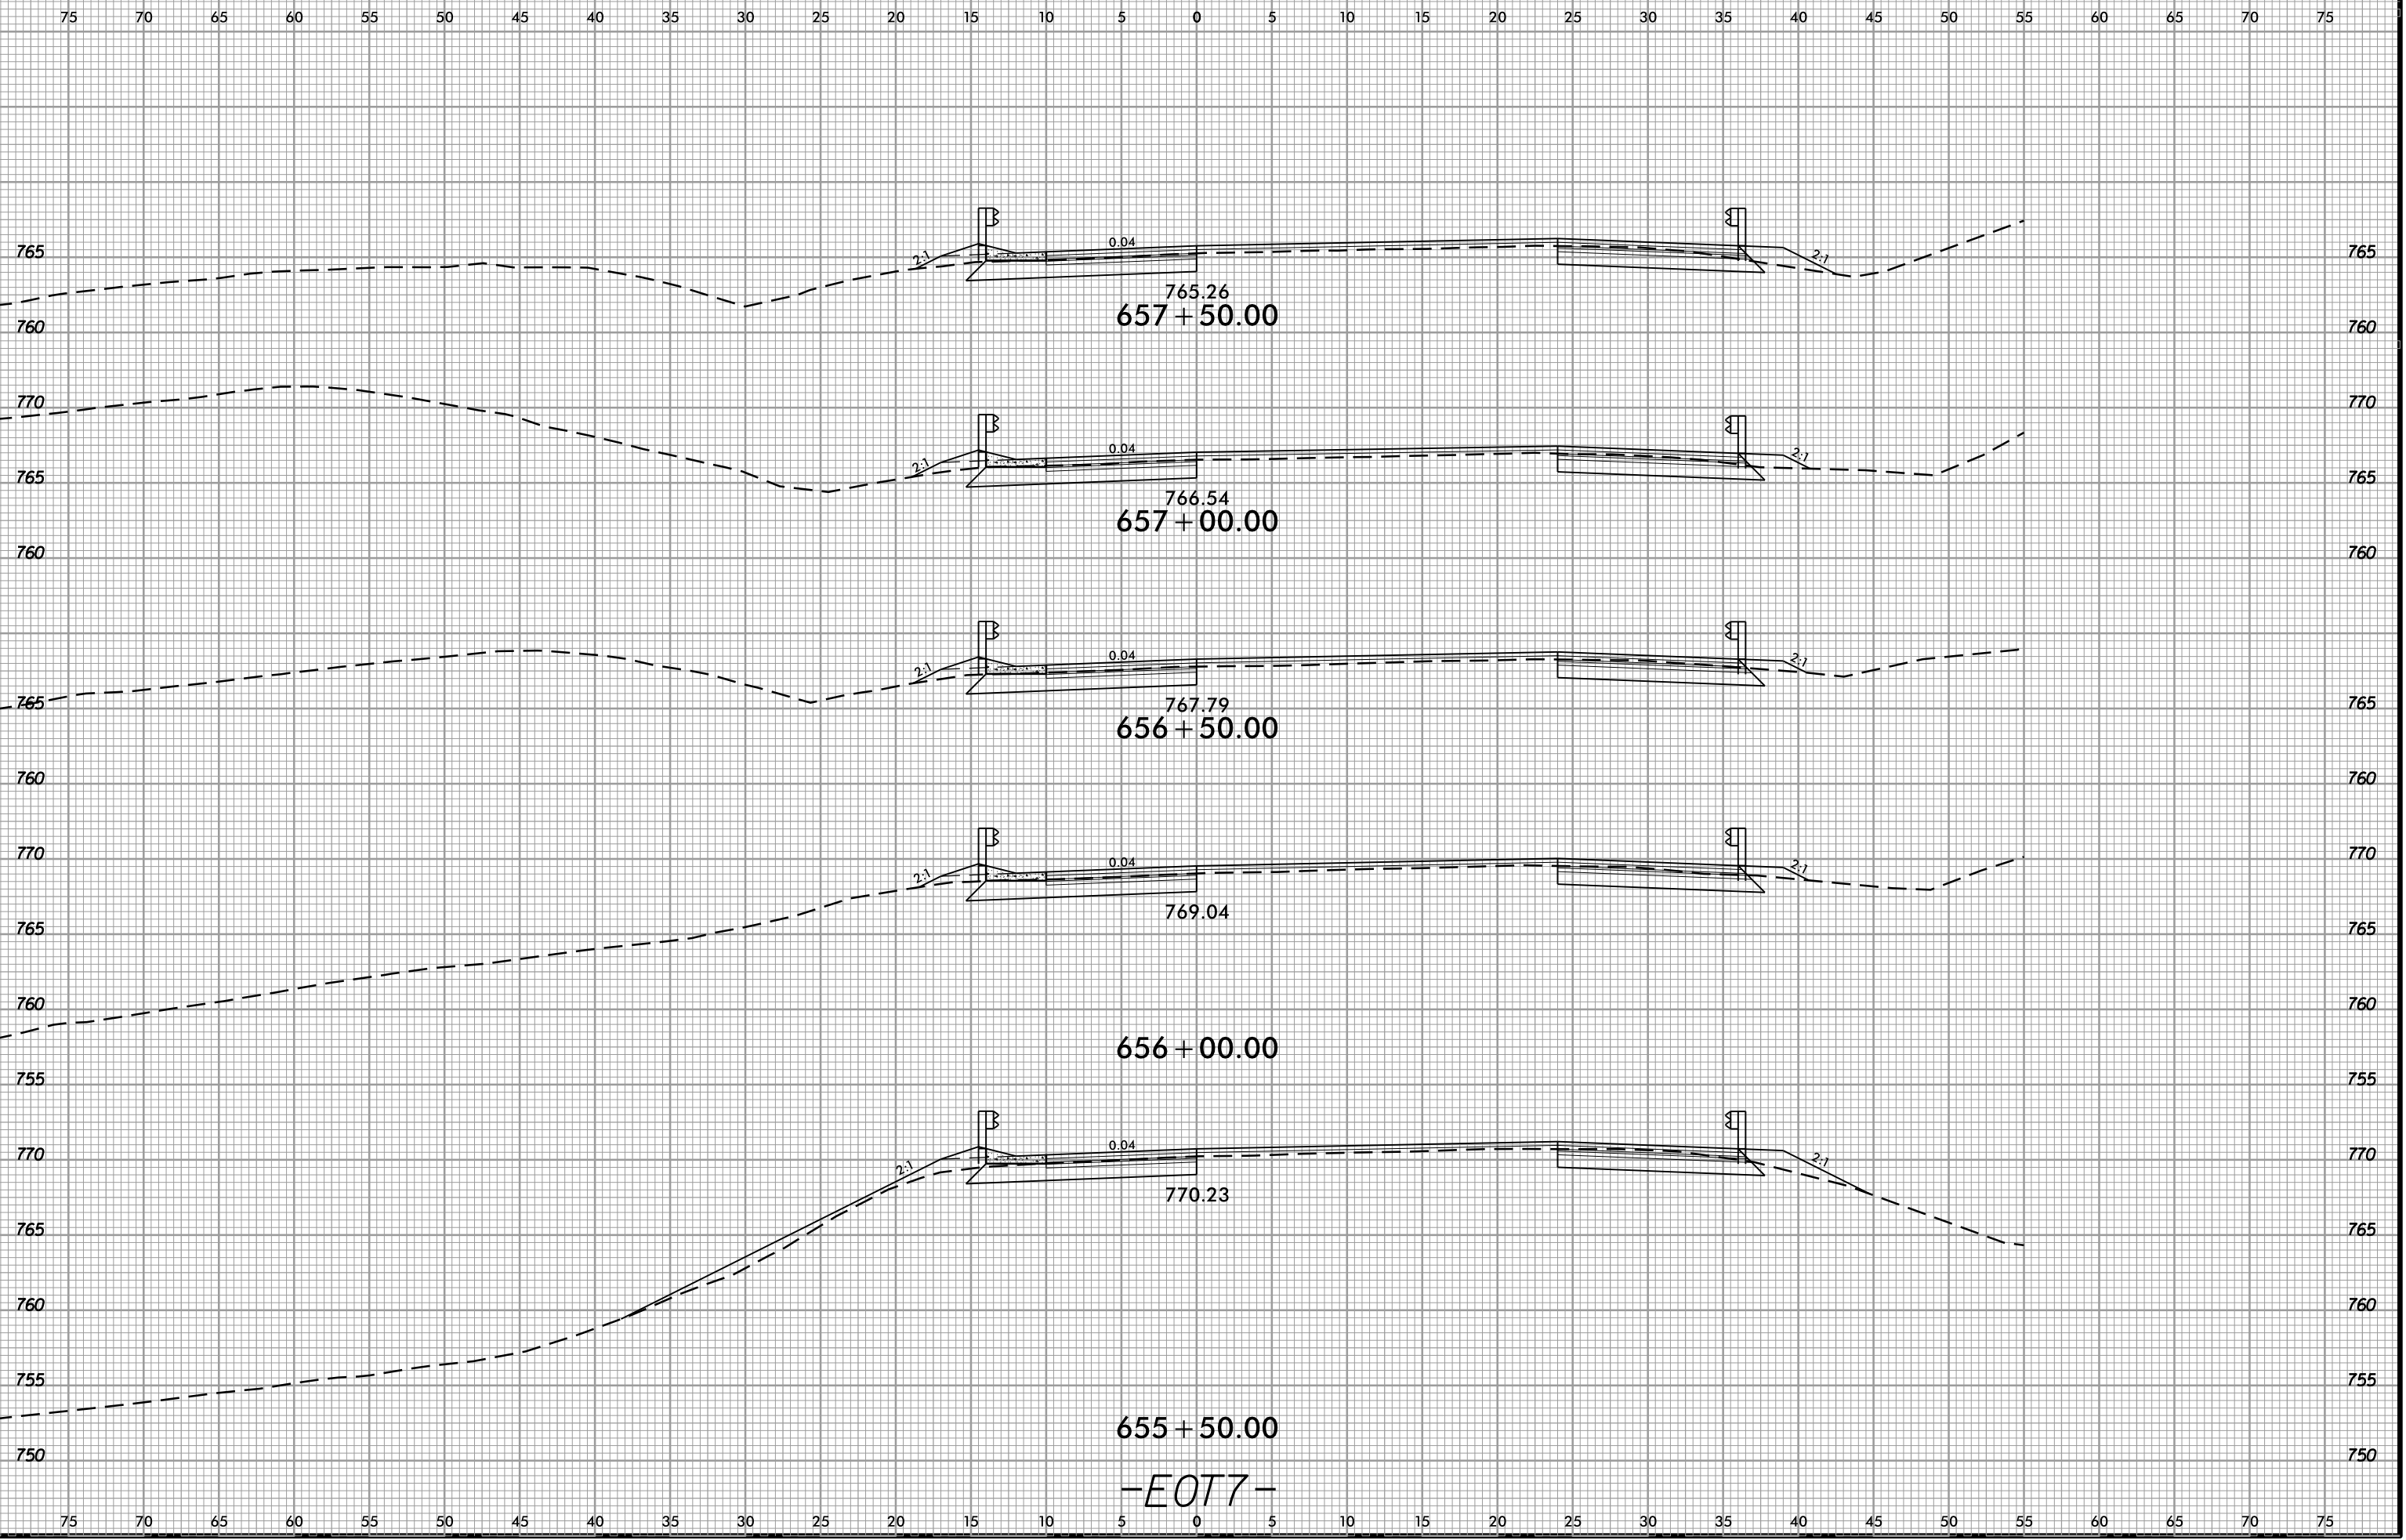

765.26  
657+50.00

766.54  
657+00.00

767.79  
656+50.00


769.04  
656+00.00

770.23  
655+50.00










655+50.00

-EOT7-

6/23/16  
02-NOV-2018 13:48  
S:\Project-Development\IP Projects\1-5823-140-Dave\Roadway\DesignFiles\5823.ddc.xpl.EOT7.dgn  
Mikeston

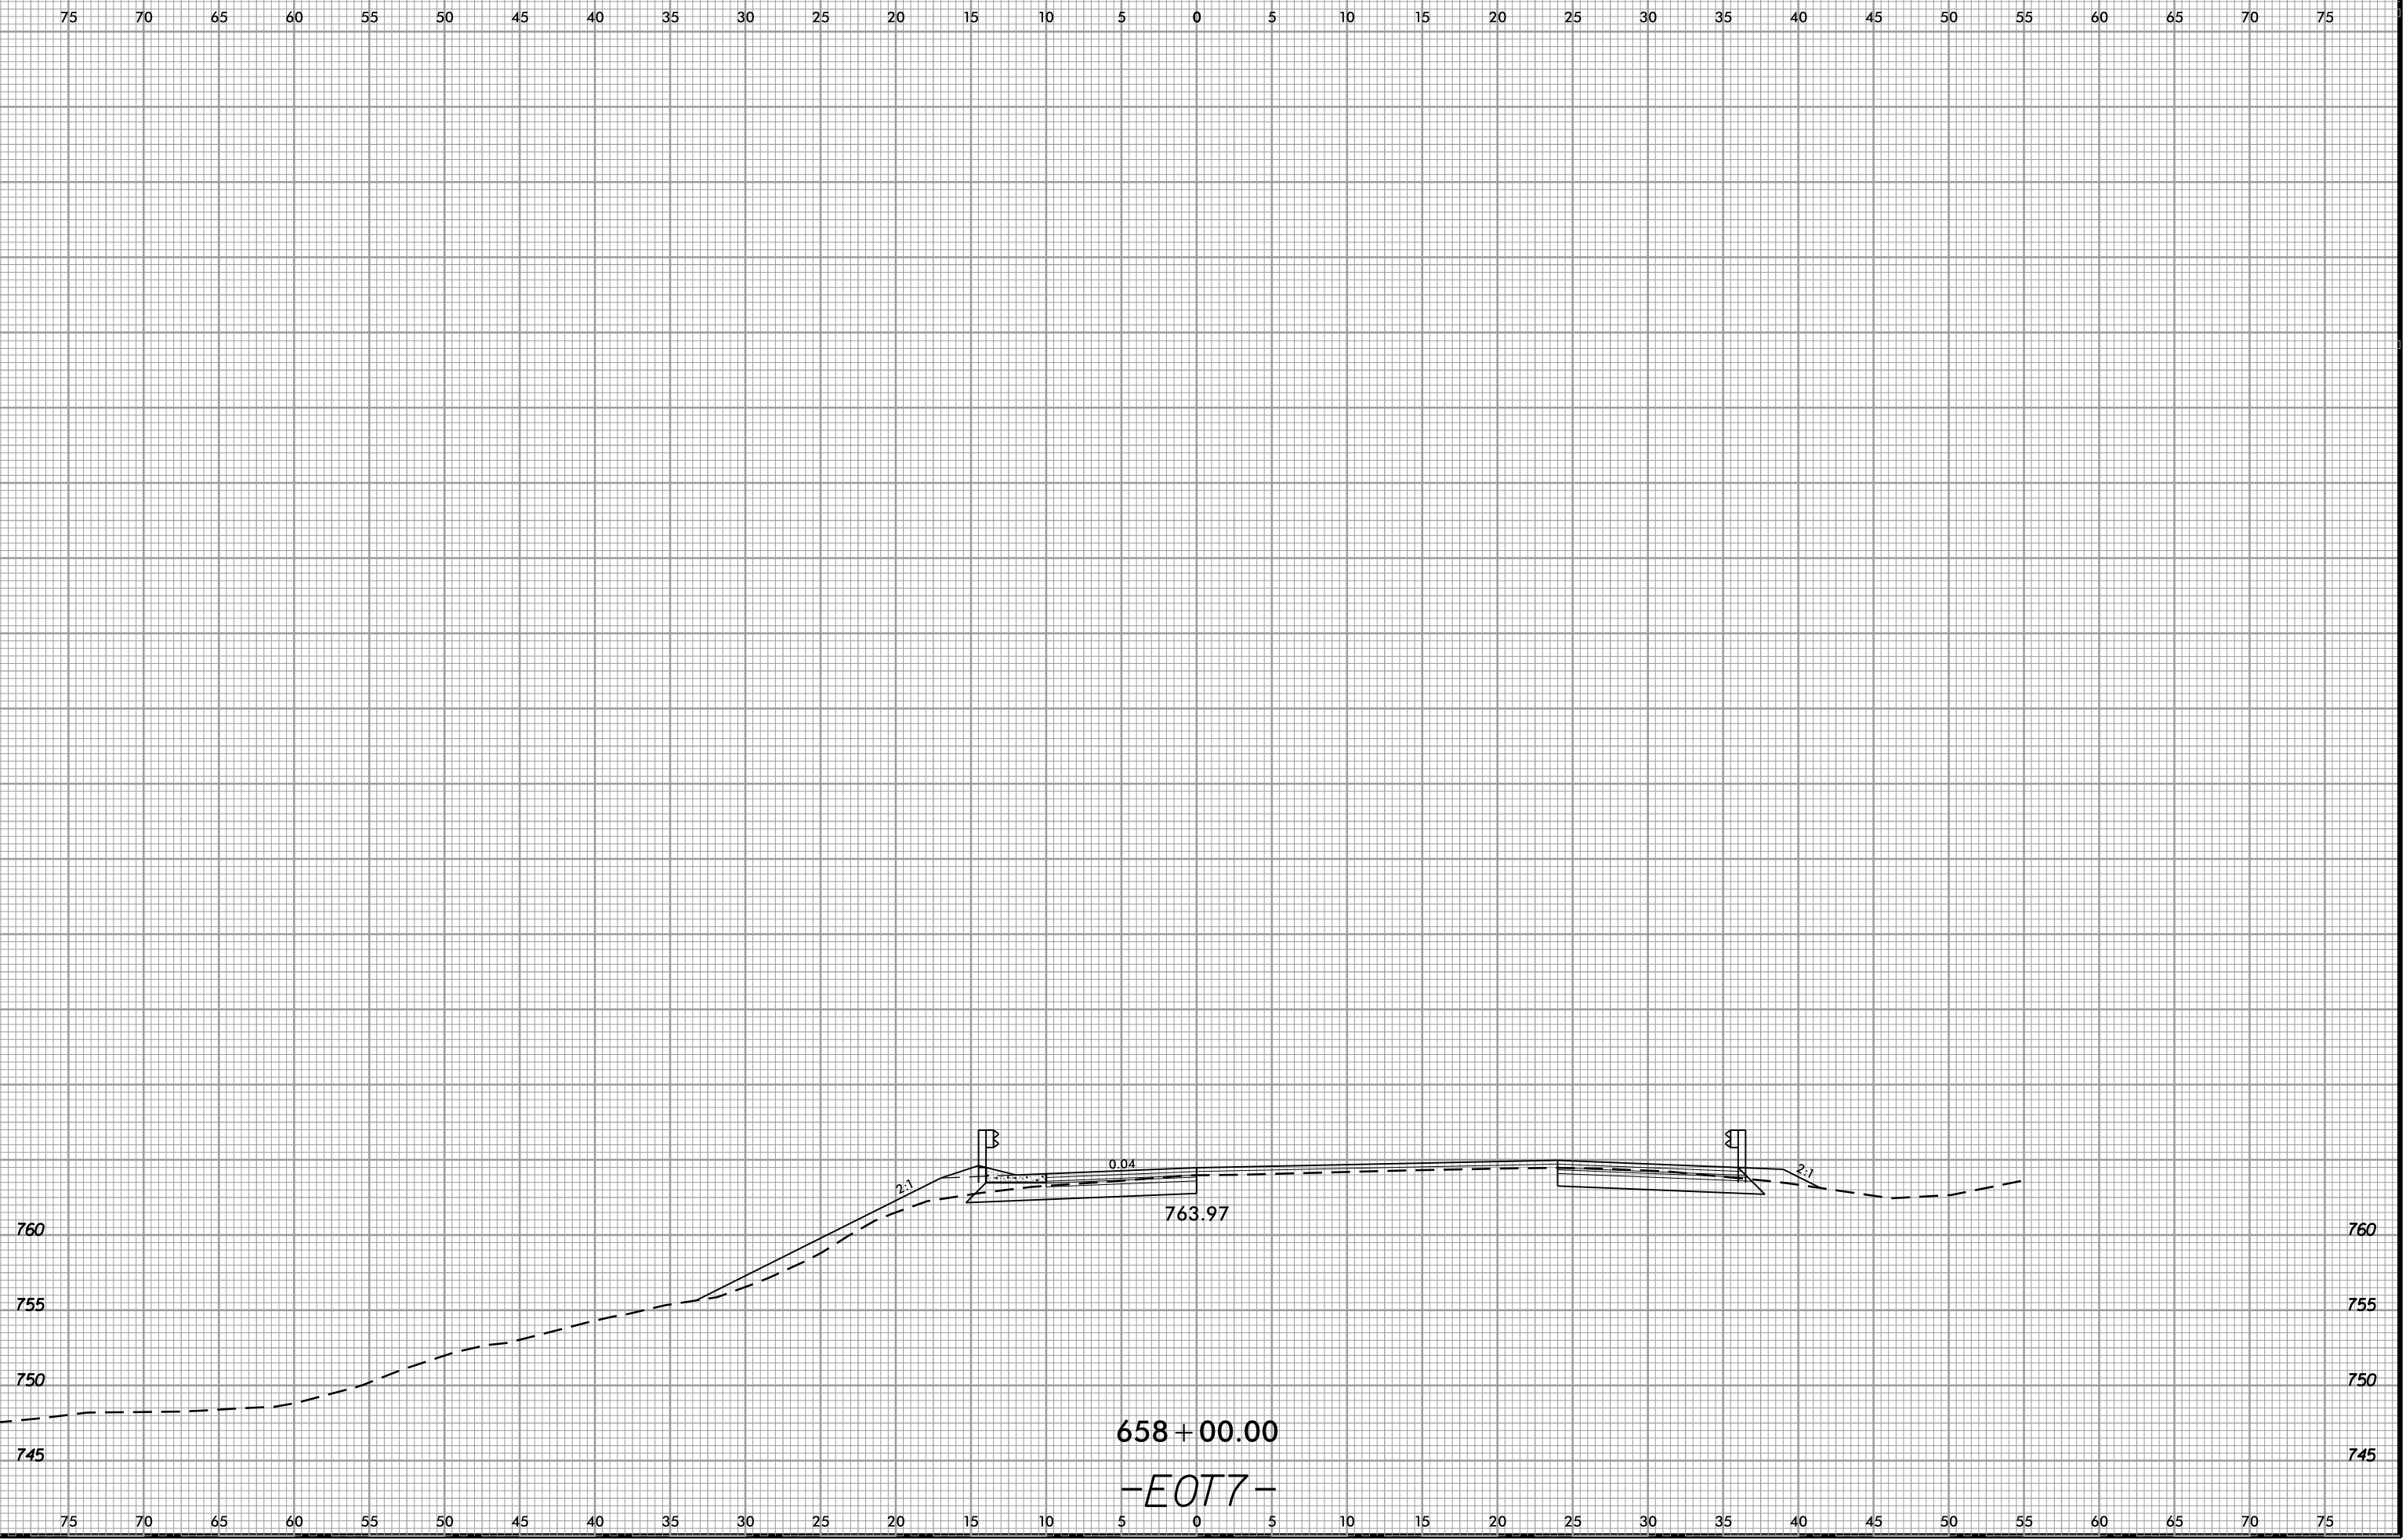


75 70 65 60 55 50 45 40 35 30 25 20 15 10 5 0 5 10 15 20 25 30 35 40 45 50 55 60 65 70 75

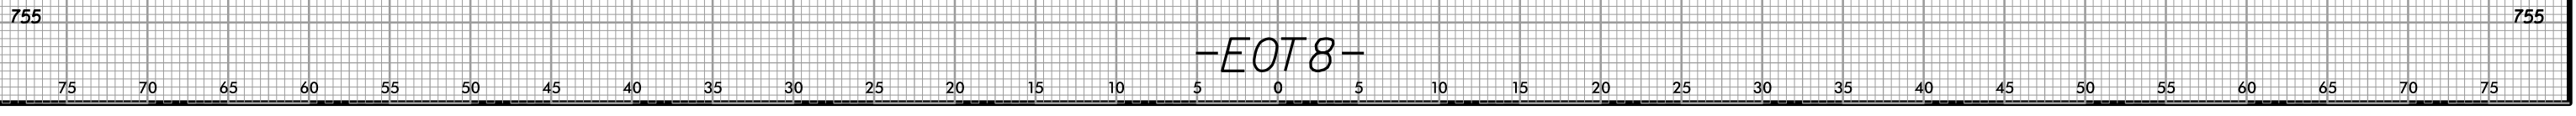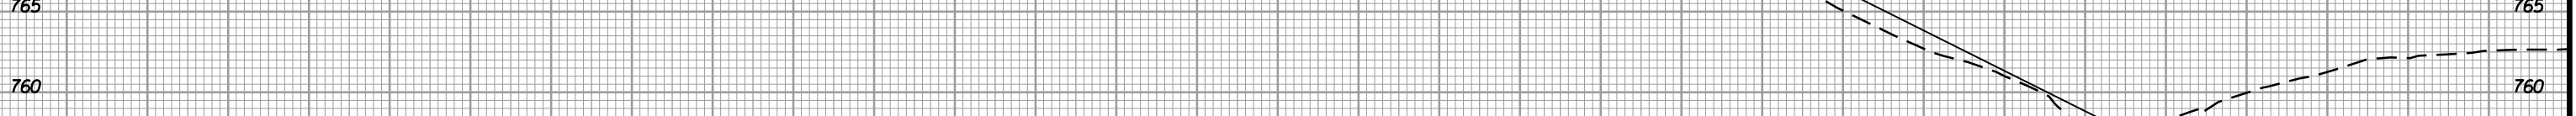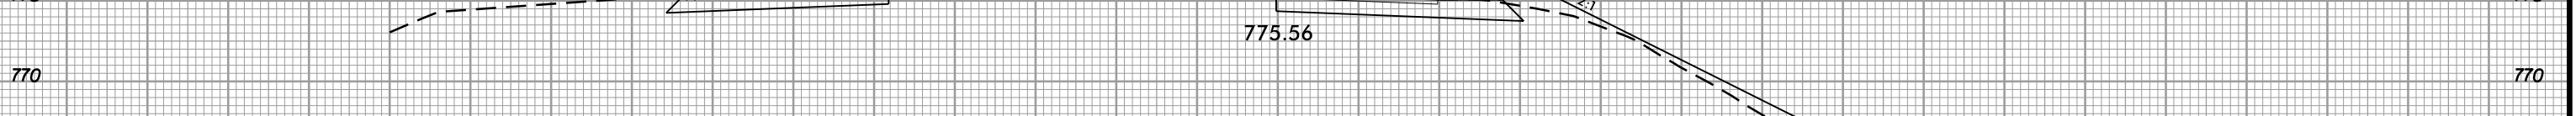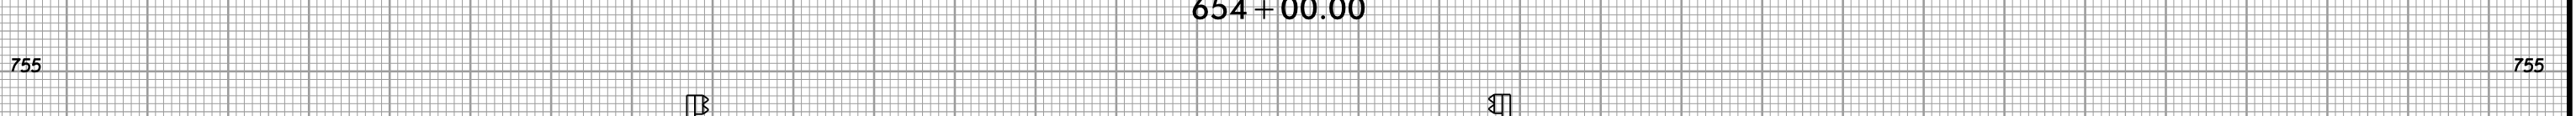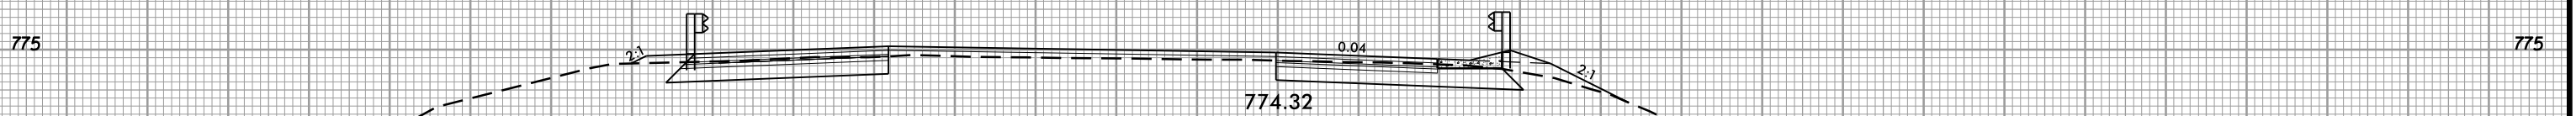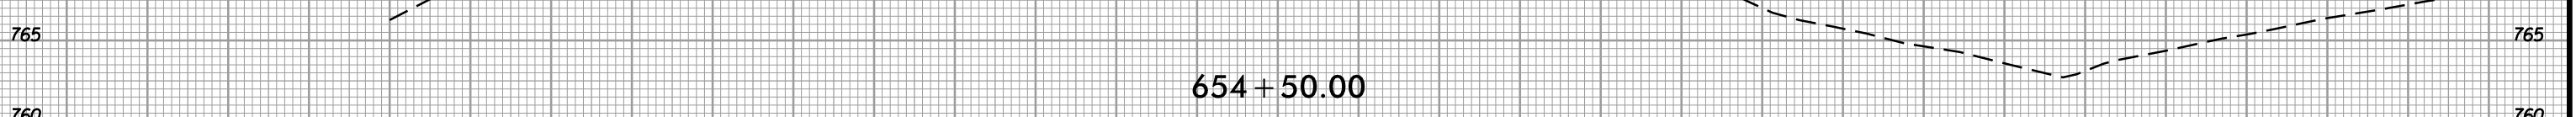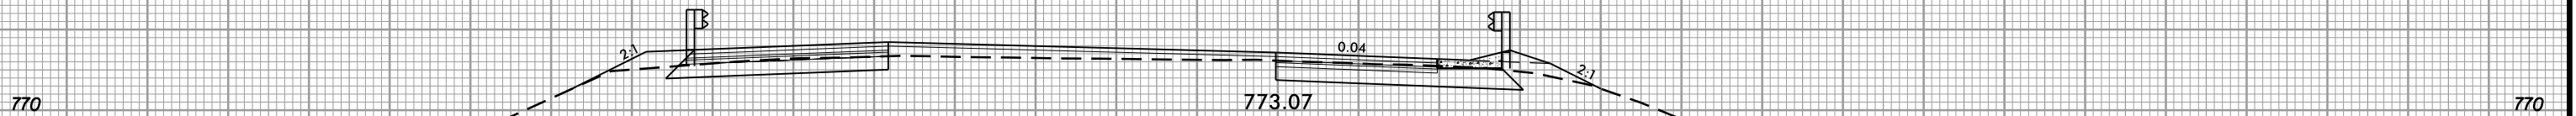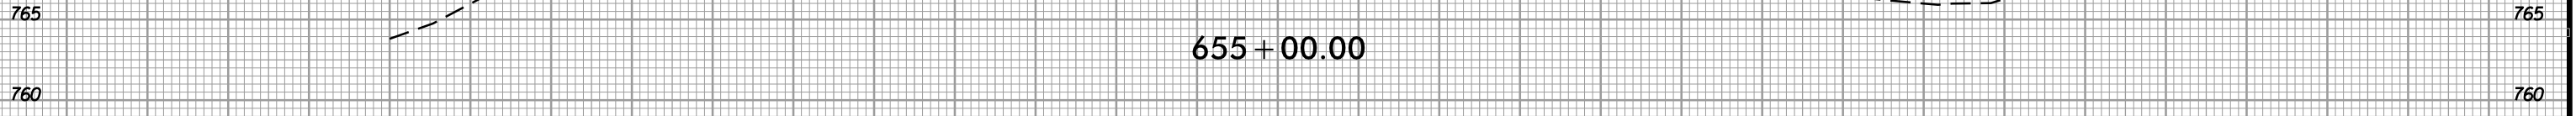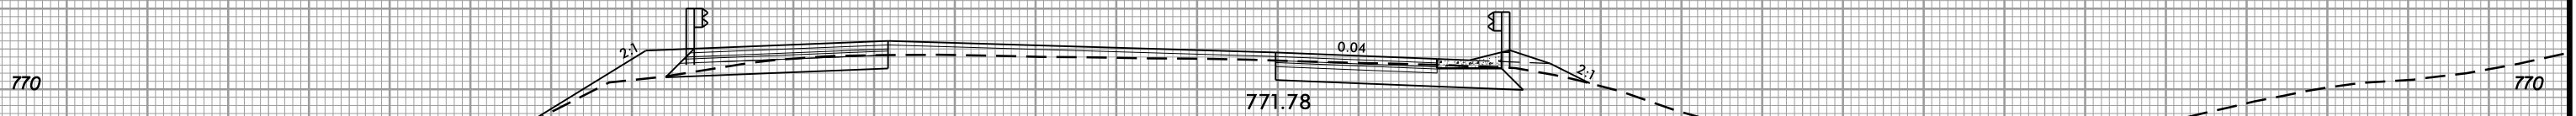


-EOT8-


6/23/16  
02-NOV-2018 13:48  
S:\Projects-Development\JIP Projects\140-Dave\Roadway\DesignFiles\5823.dwg - xpl.EOT9.dgn  
AT DIV 9-294550

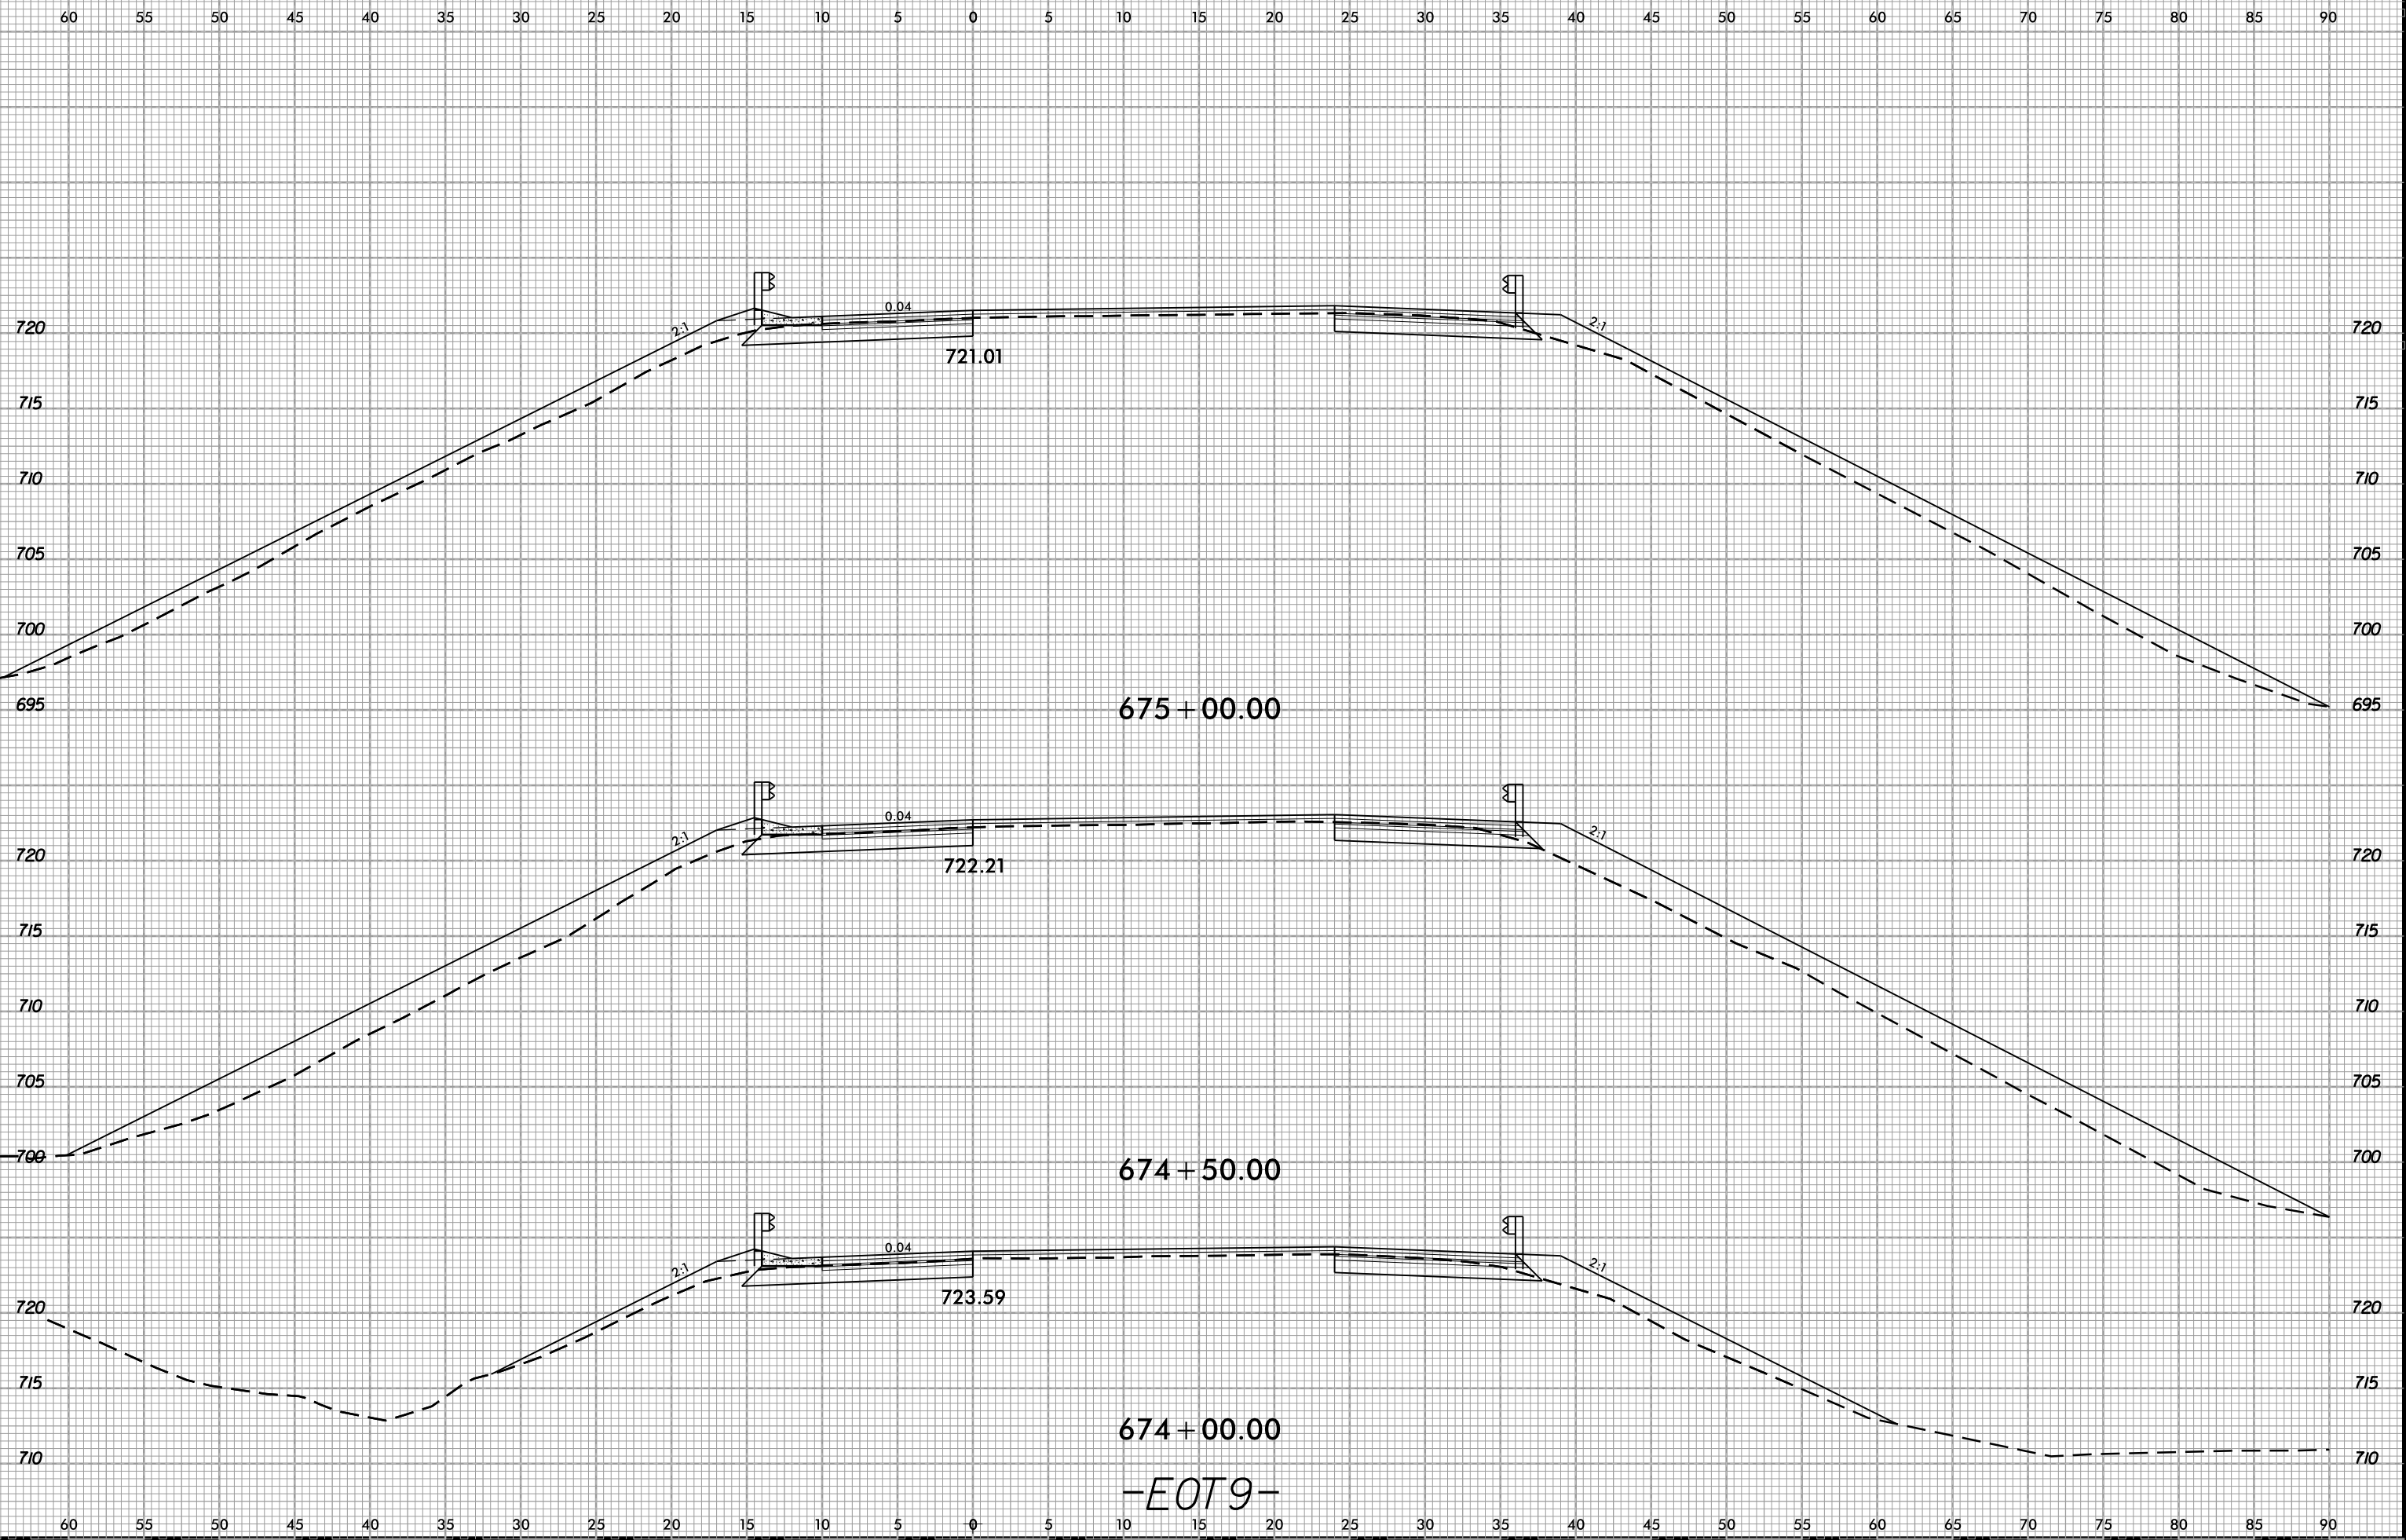

6/23/16  
02-NOV-2018 13:48  
S:\Projects-Development\IP Projects\1-5823-140-Dave Roadway\DesignFiles\5823.ddc.xpl.EOT9.dgn  
AT DIV 2 4550

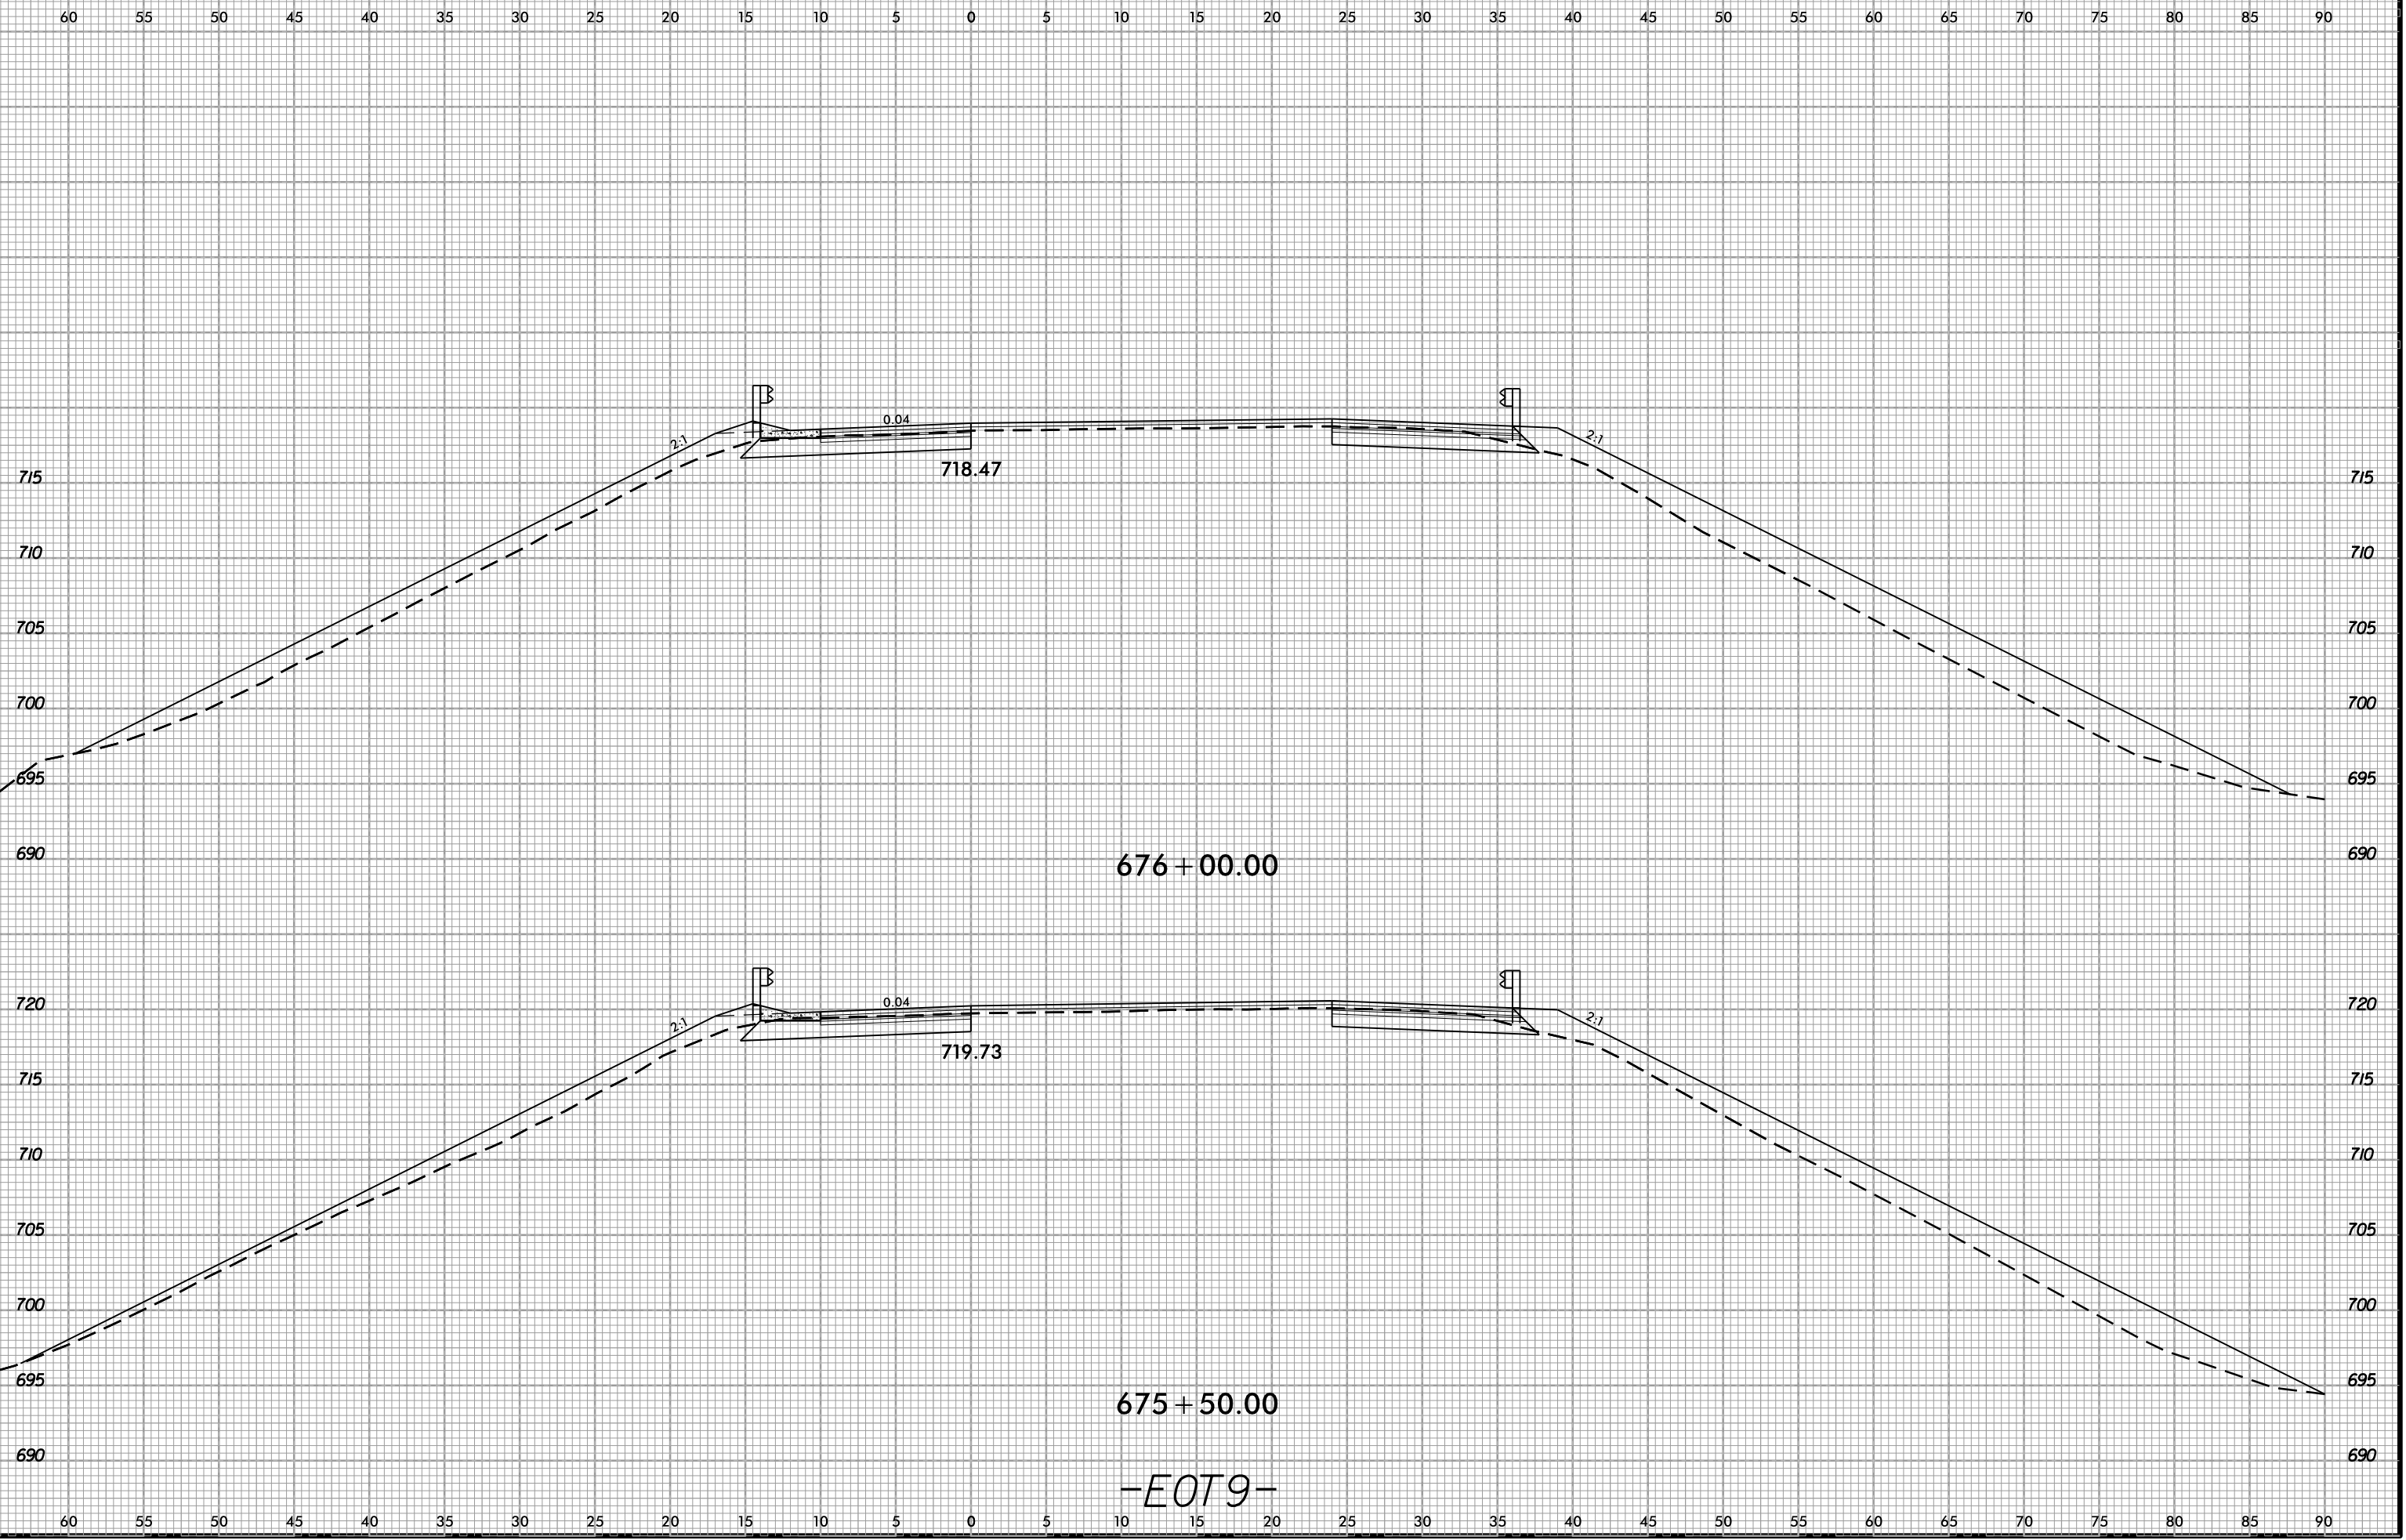

6/23/16  
02-NOV-2018 13:48  
S:\Projects-Development\IP Projects\140-Dave\Roadway\DesignFiles\5823.ddc.xpl.EOT9.dgn  
AT DIV 9-294550

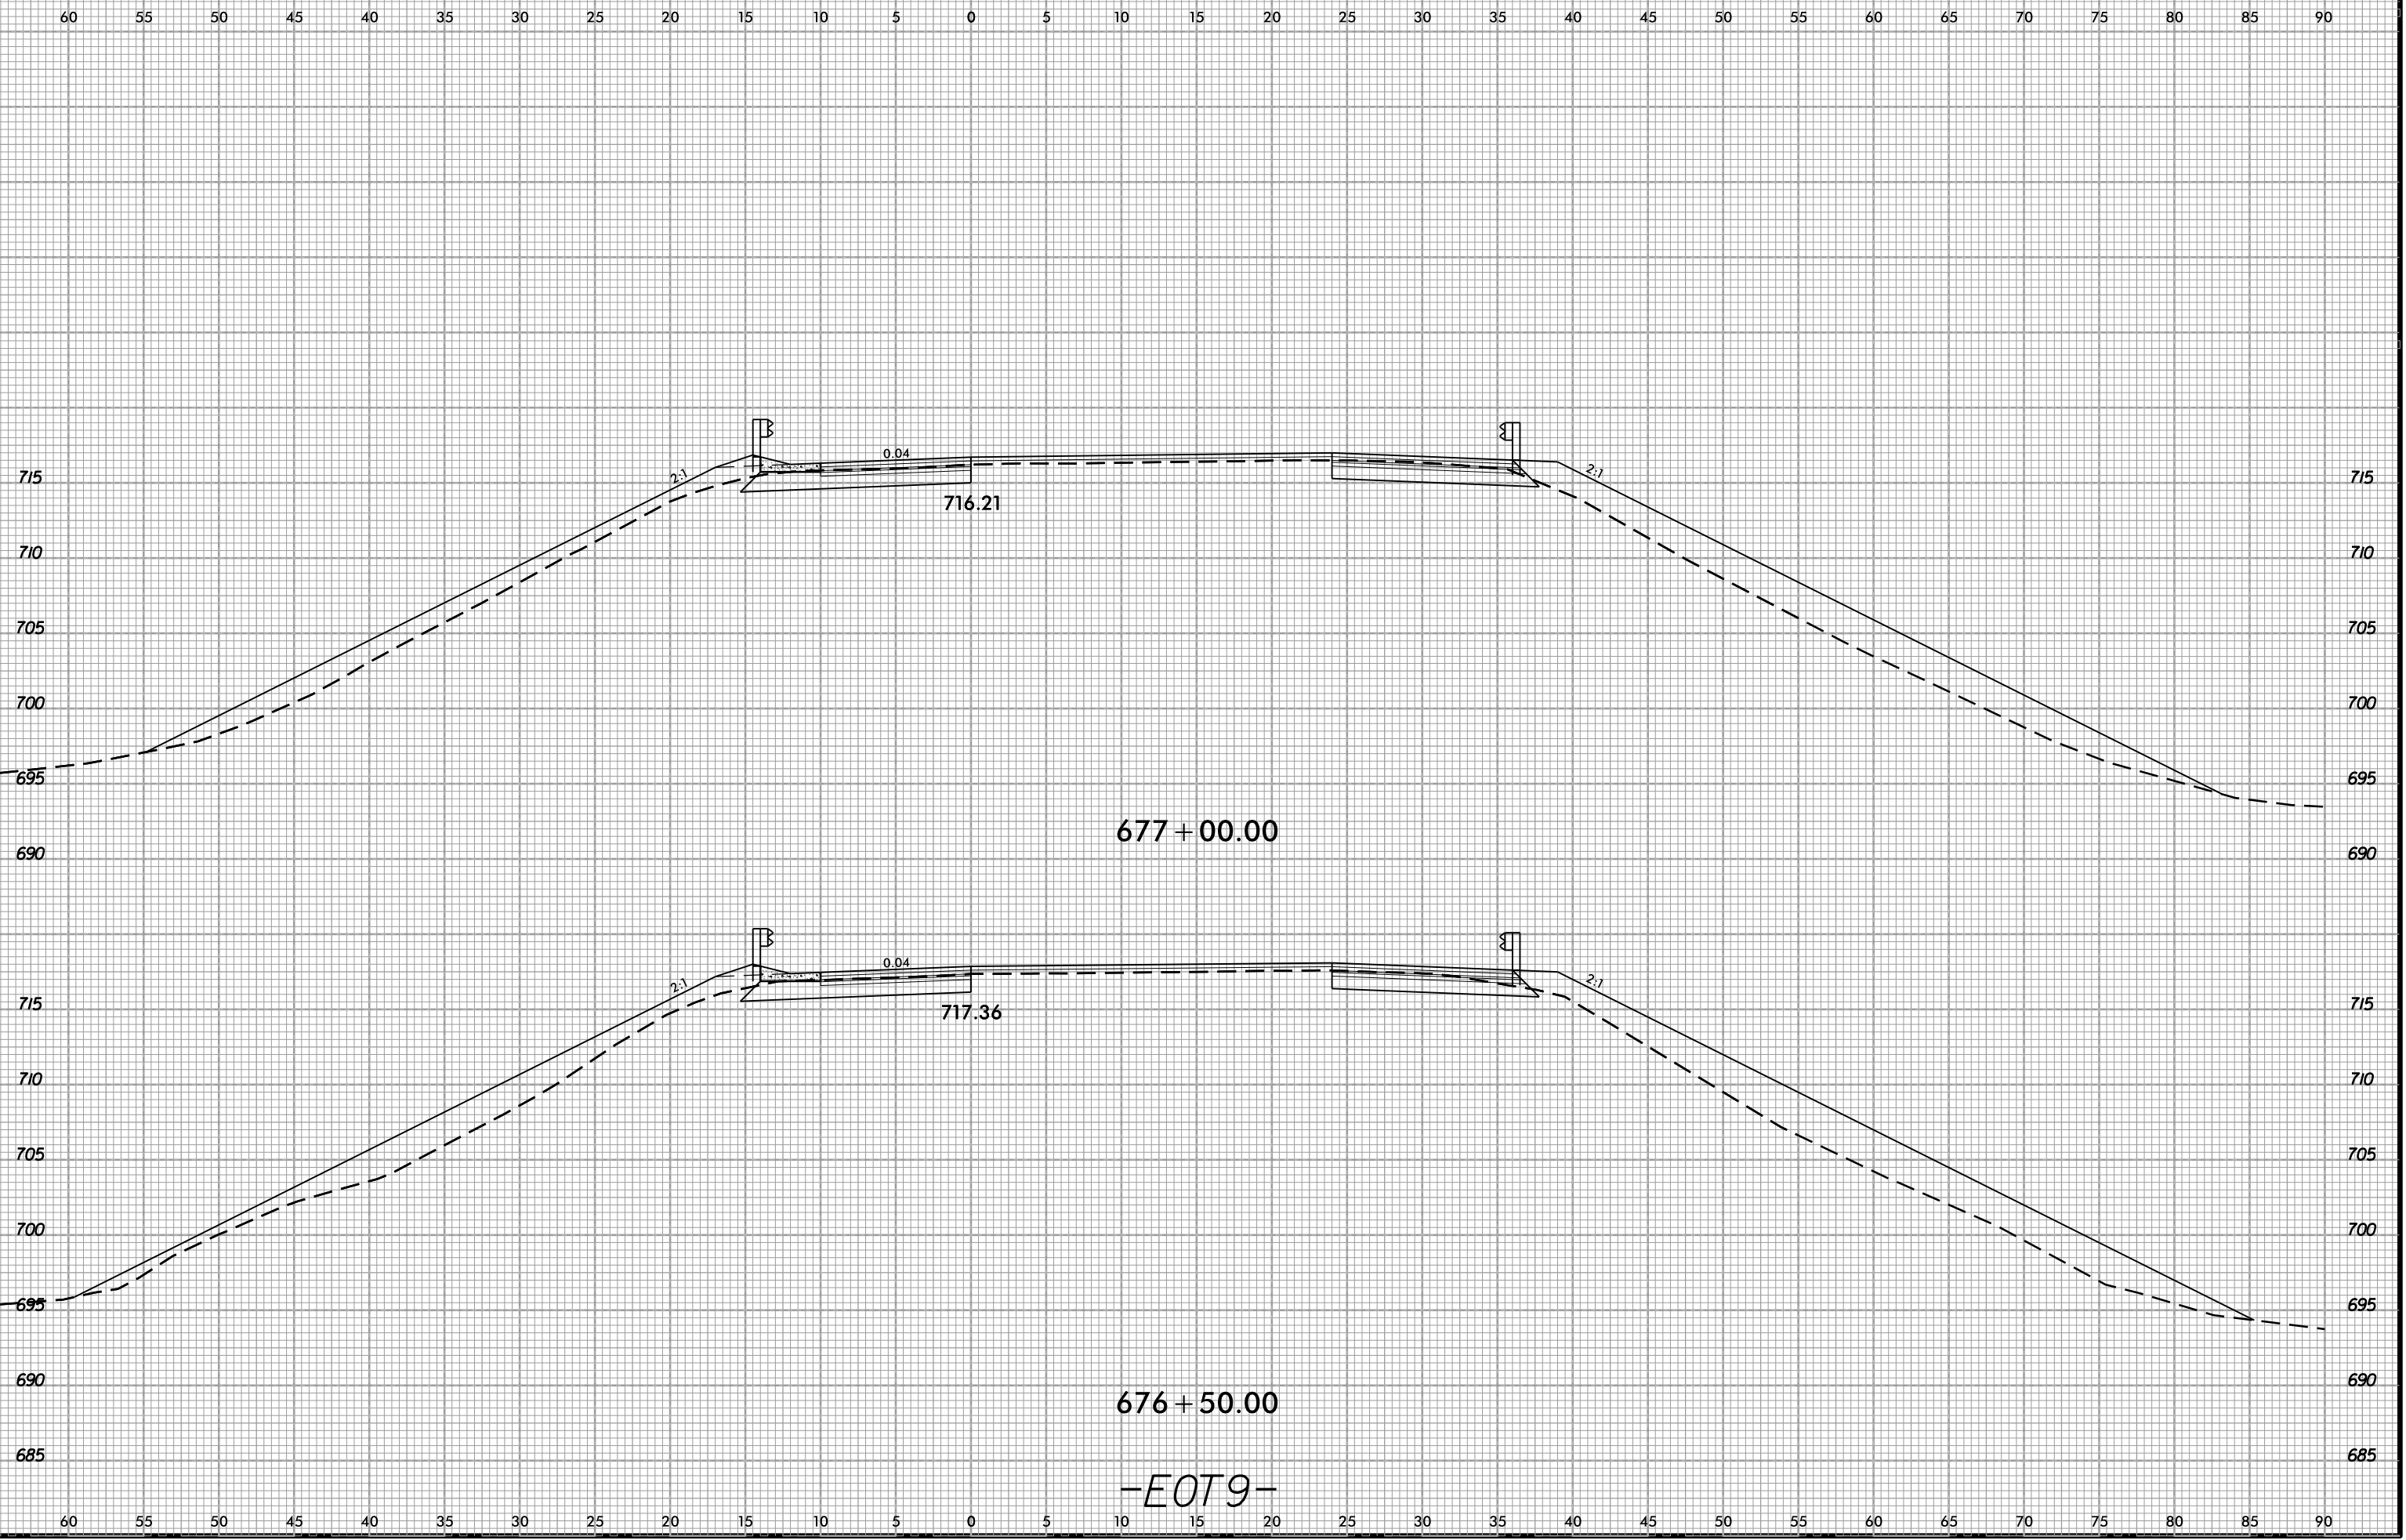


677 + 00.00

676 + 50.00


-EOT9-

6/23/16  
02-NOV-2018 13:48  
S:\Project-Development\IP Projects\1-5823-140-Dave Roadway\DesignFiles\5823.ddc.xpl.EOT9.dgn  
AT DIV 294550

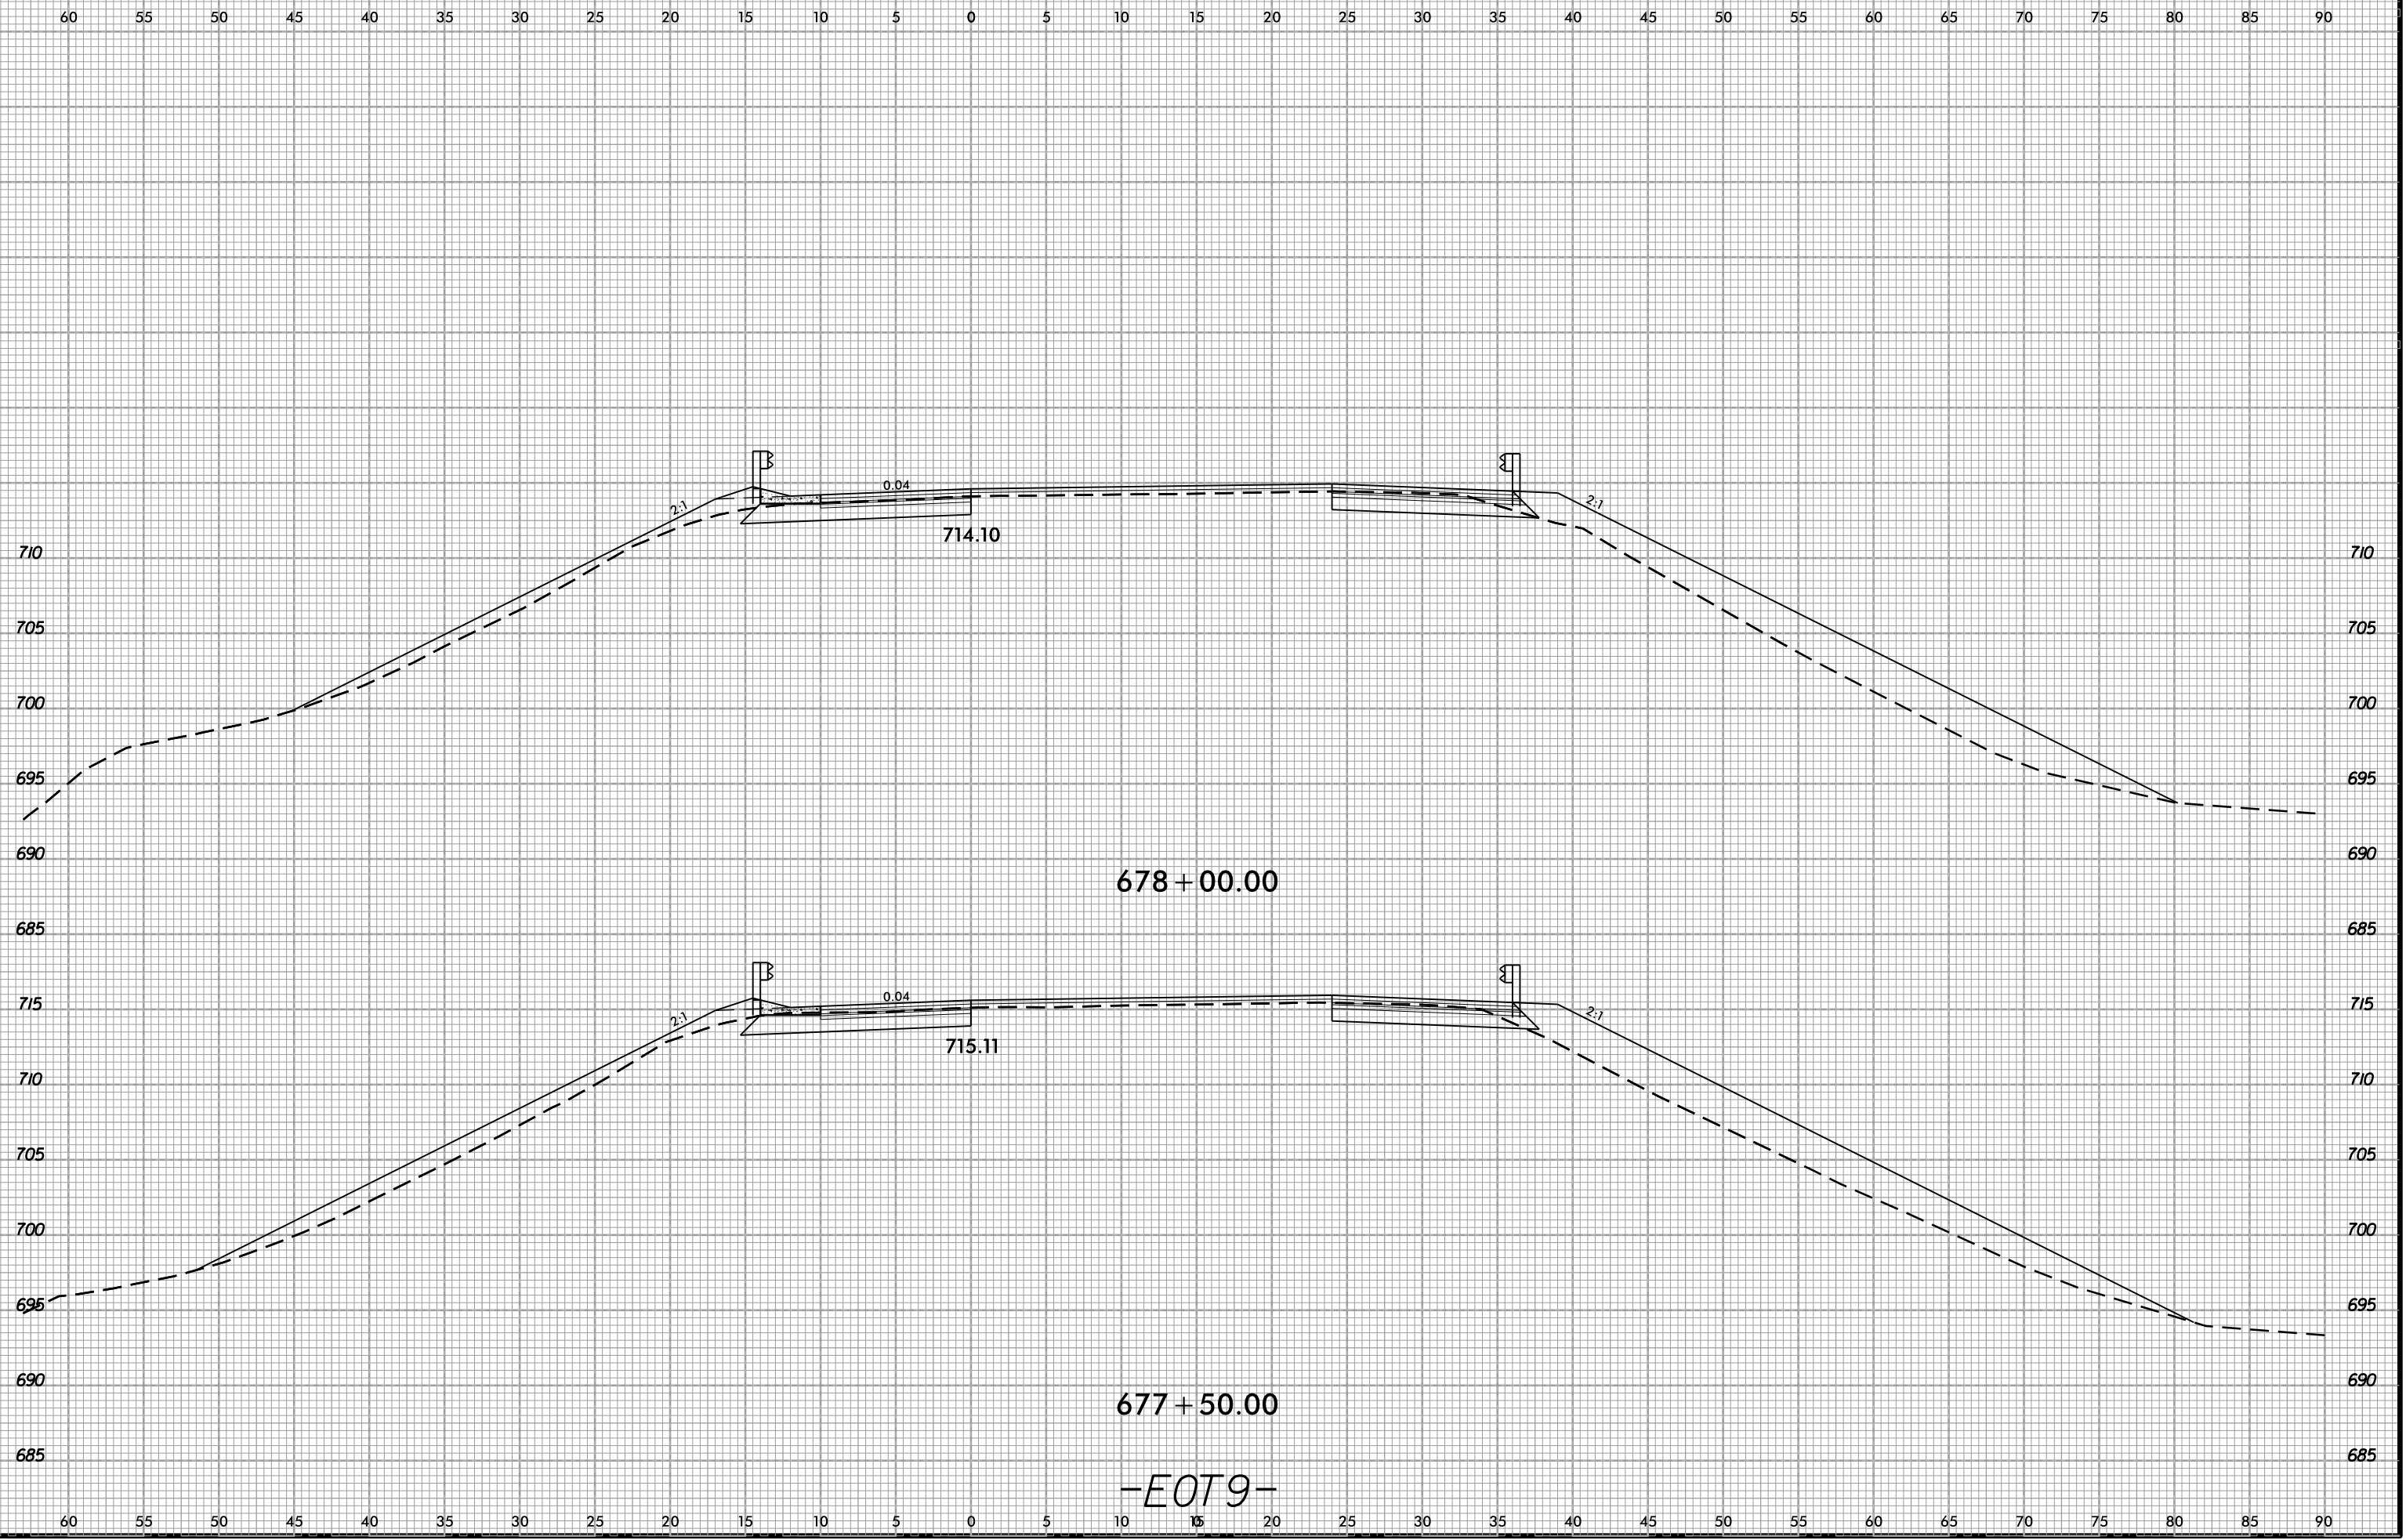




6/23/16  
02-NOV-2018 13:48  
S:\Projects-Development\IP Projects\1-5823-140-Dave Roadway\DesignFiles\5823.dwg - xpl.EOT9.dgn  
AT DIV 2 4550

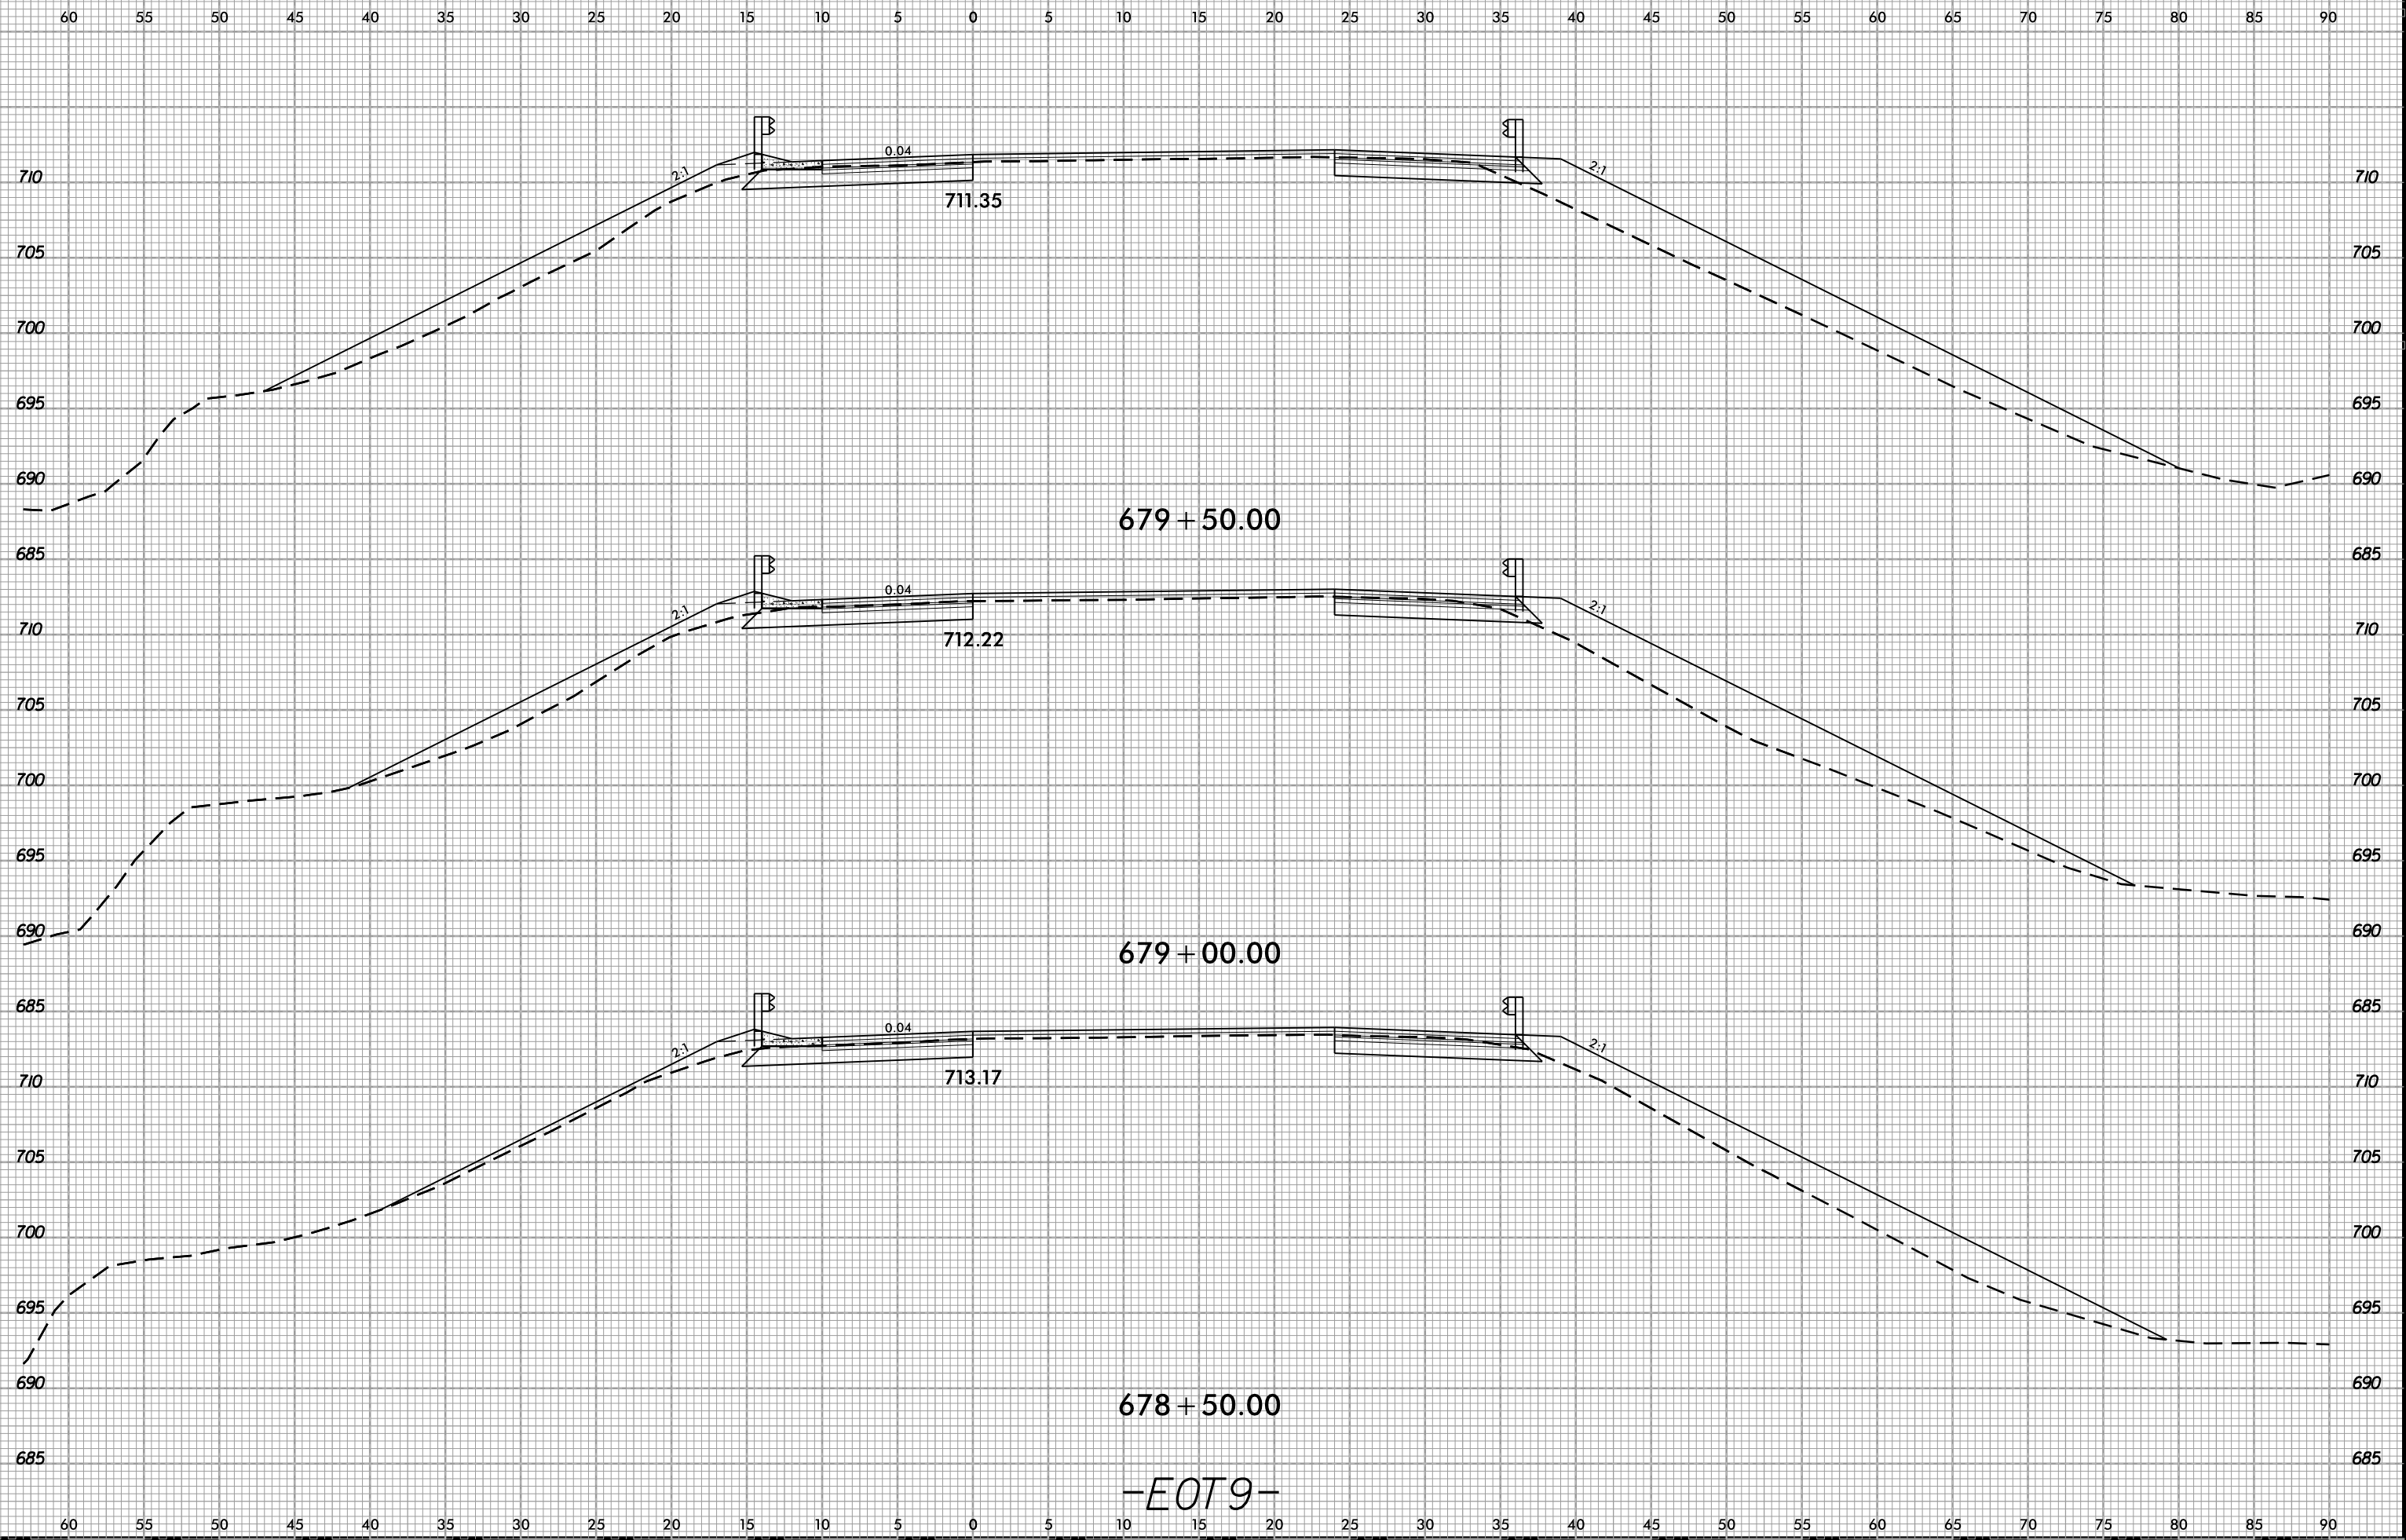


6/23/16  
02-NOV-2018 13:48  
S:\Project-Development\IP Projects\140-Dave\Roadway\DesignFiles\5823.ddc.xpl.EOT9.dgn  
AT DIV 9-294550

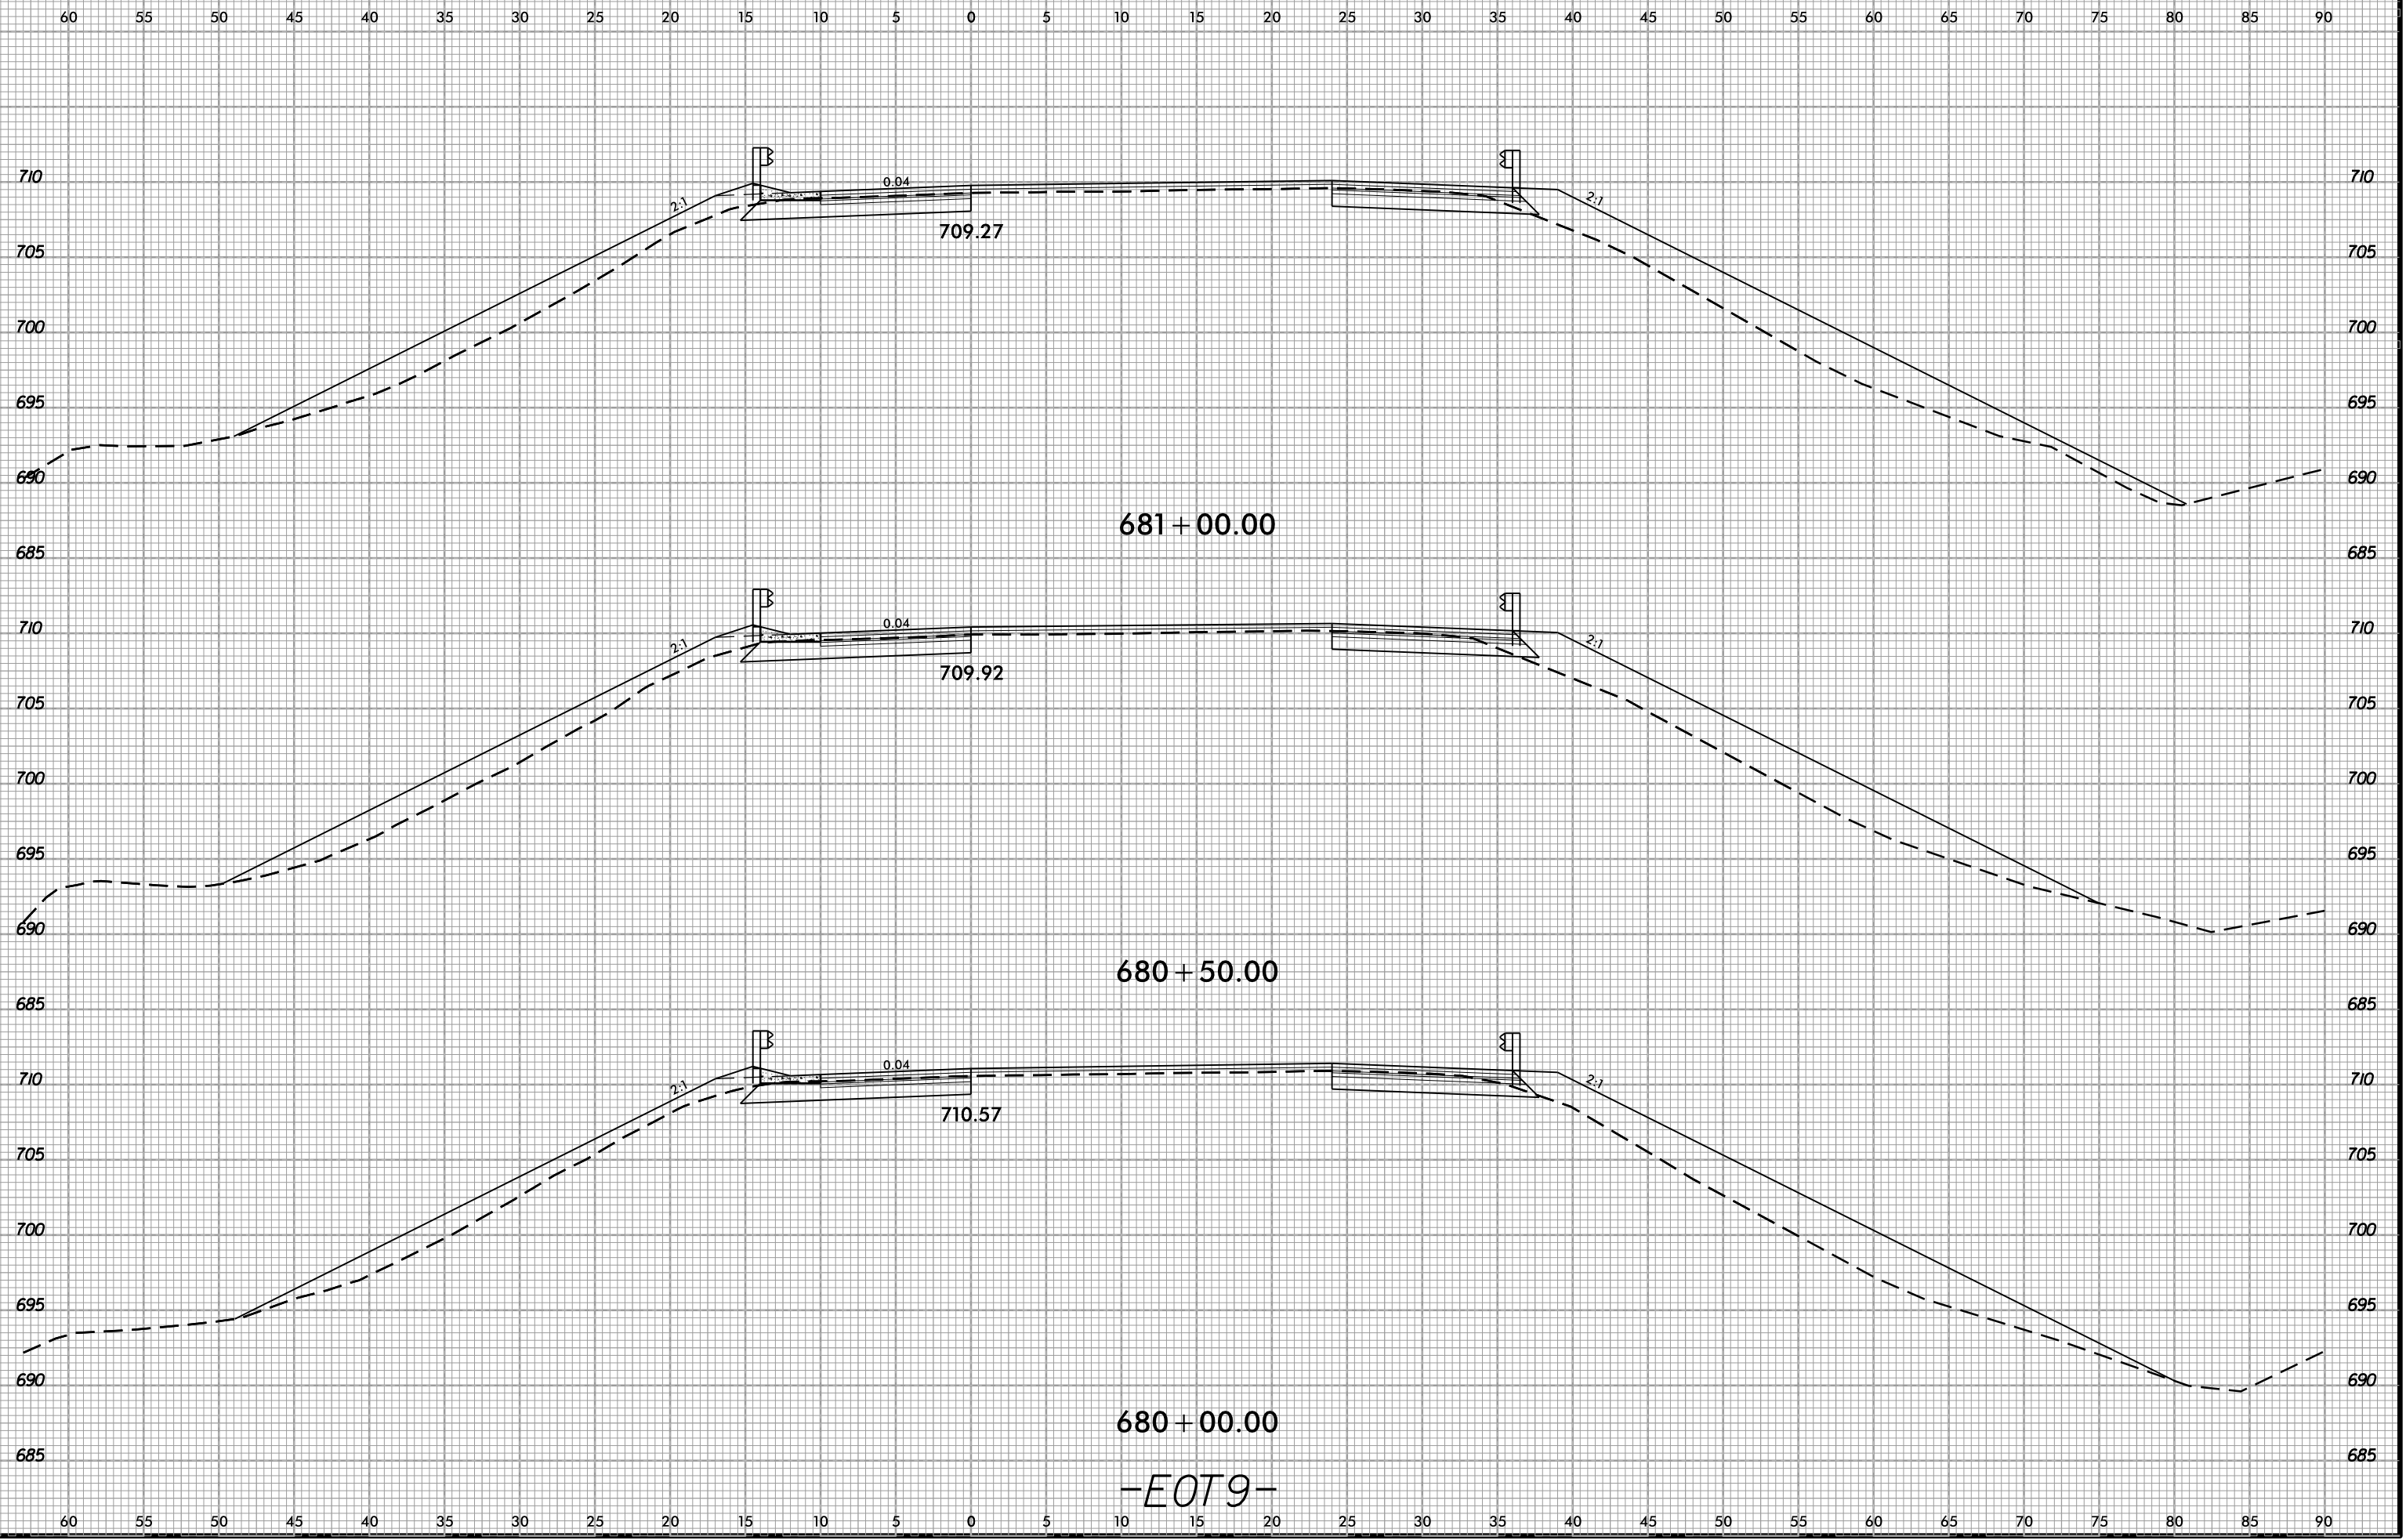


-EOT9-


6/23/16  
02-NOV-2018 13:48  
S:\Projects-Development\IP Projects\140-Dave Roadway\DesignFiles\5823.dwg - xpl-EOT9.dgn  
AT DIV 9-294550

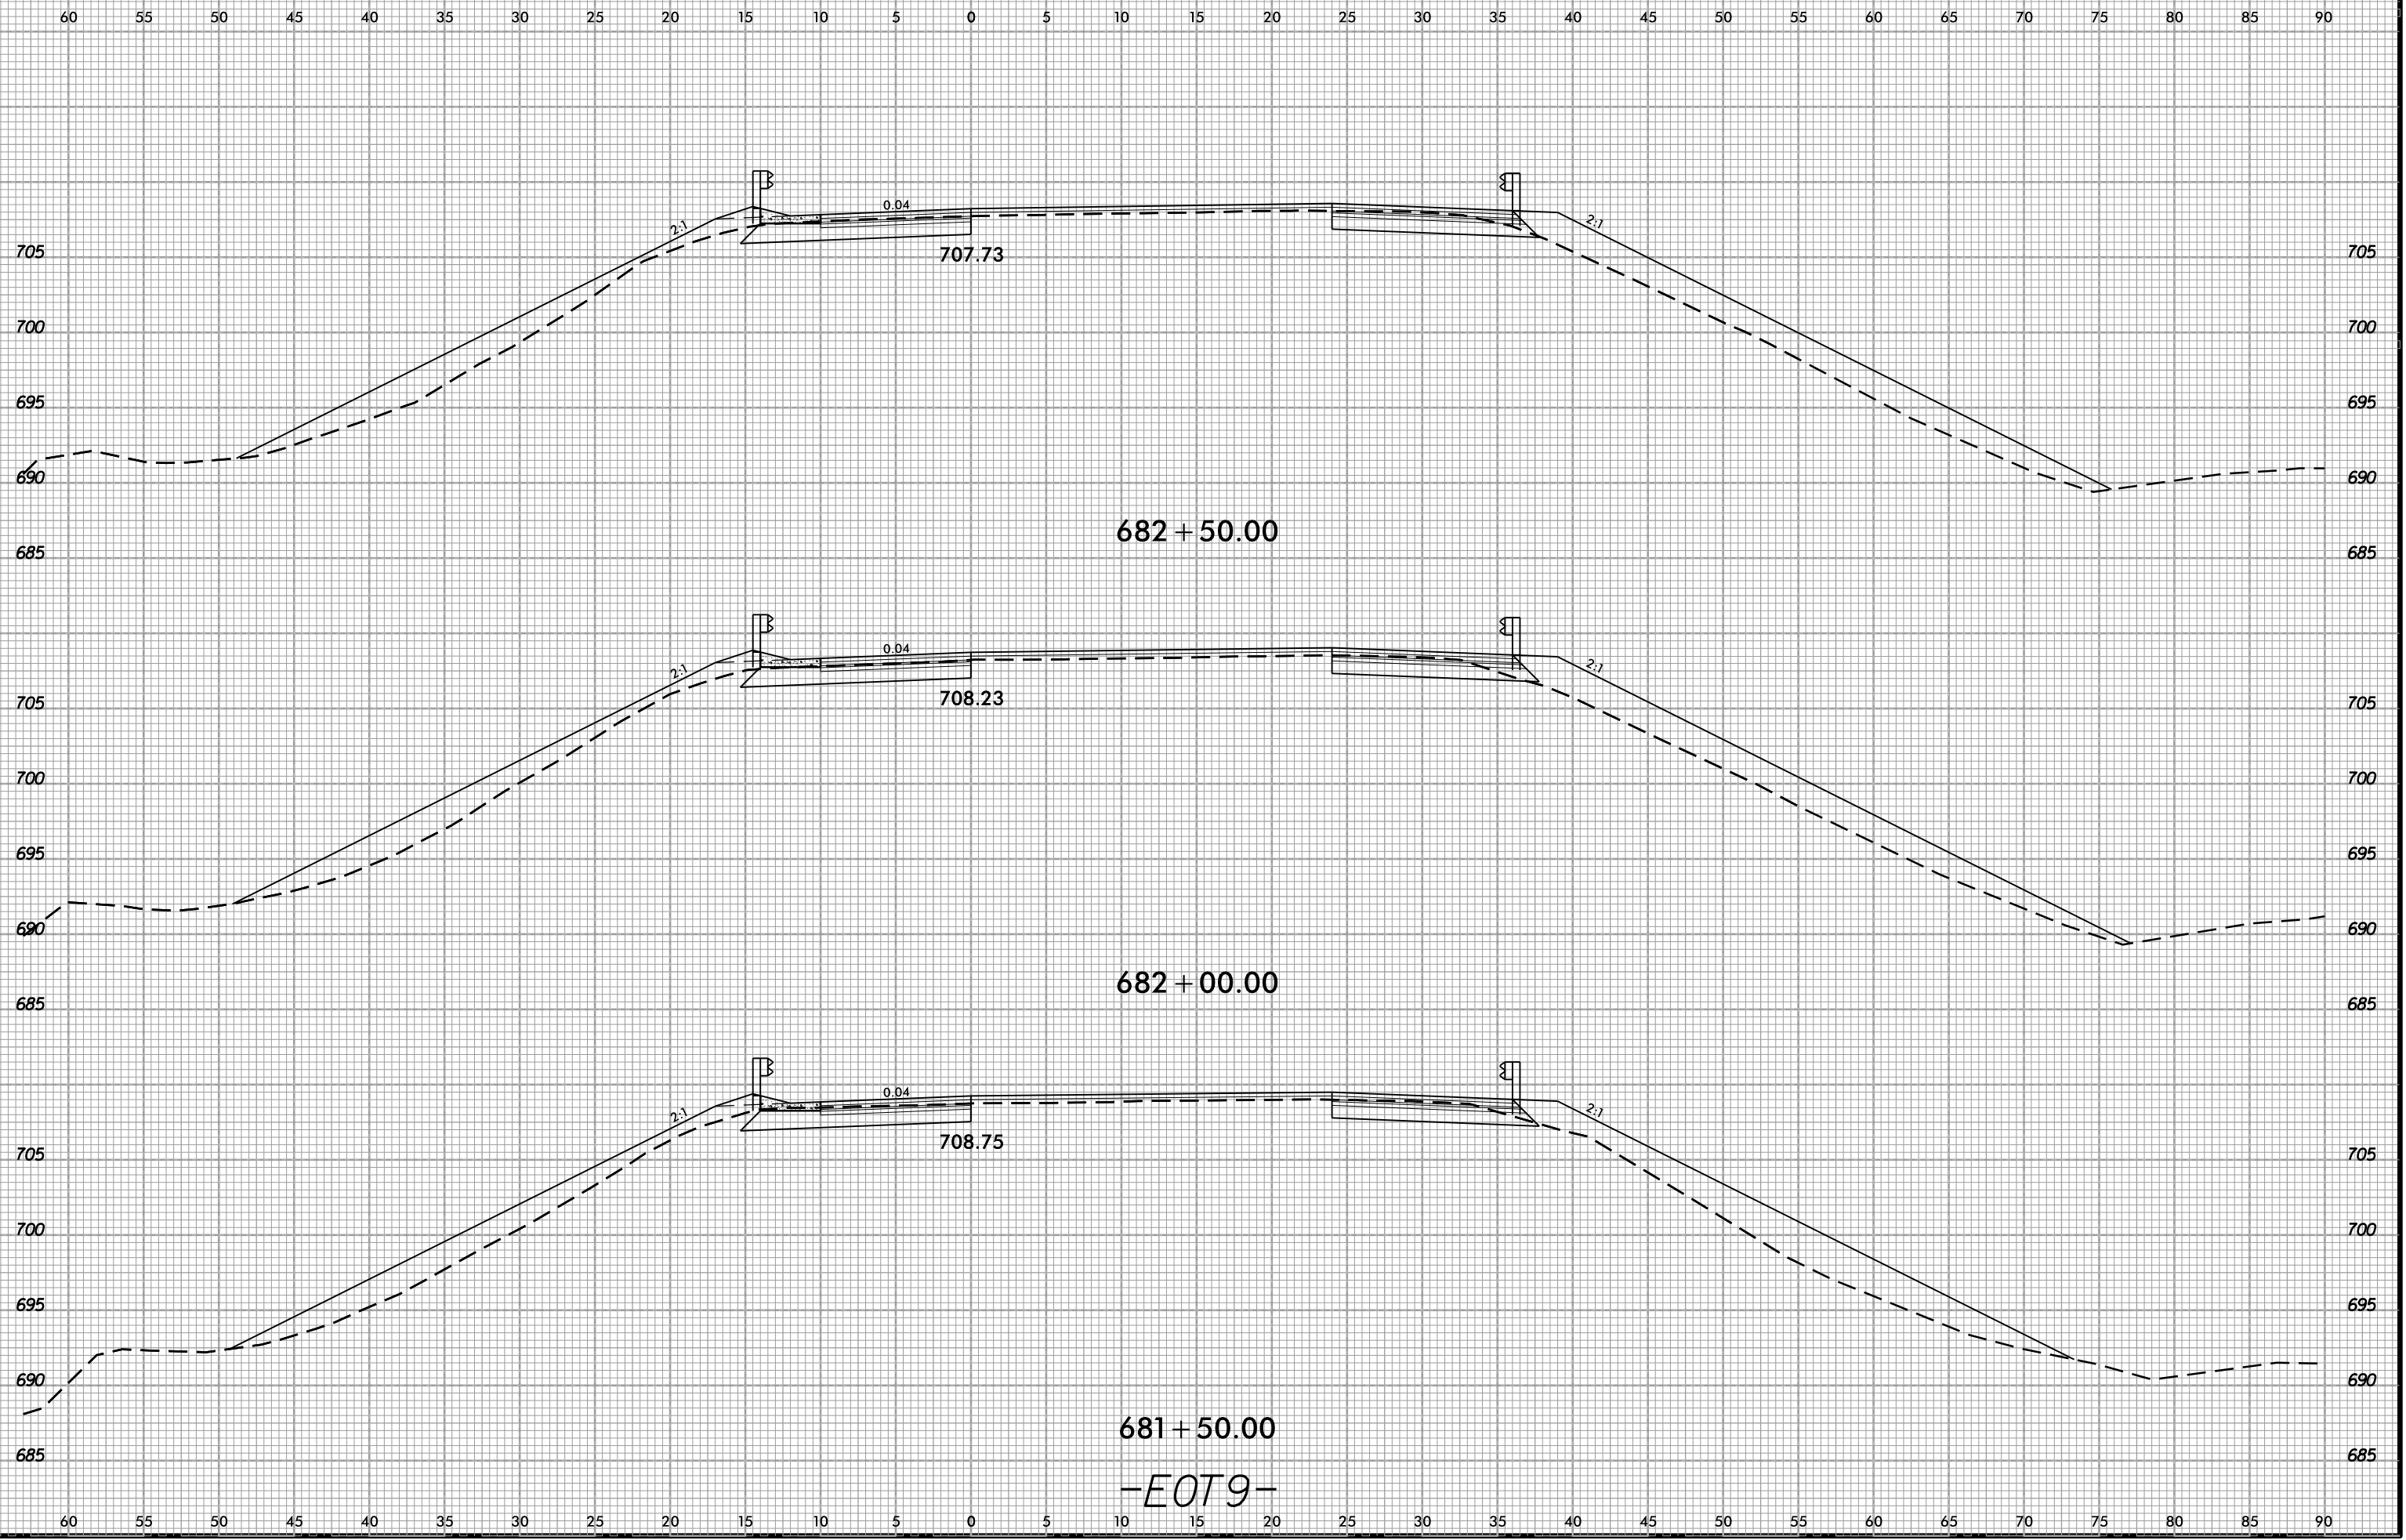

6/23/16  
02-NOV-2018 13:48  
S:\Projects-Development\IP Projects\1-5823-140-Dave Roadway\DesignFiles\5823.dwg - xpl.EOT9.dgn  
AT DIV 2 450

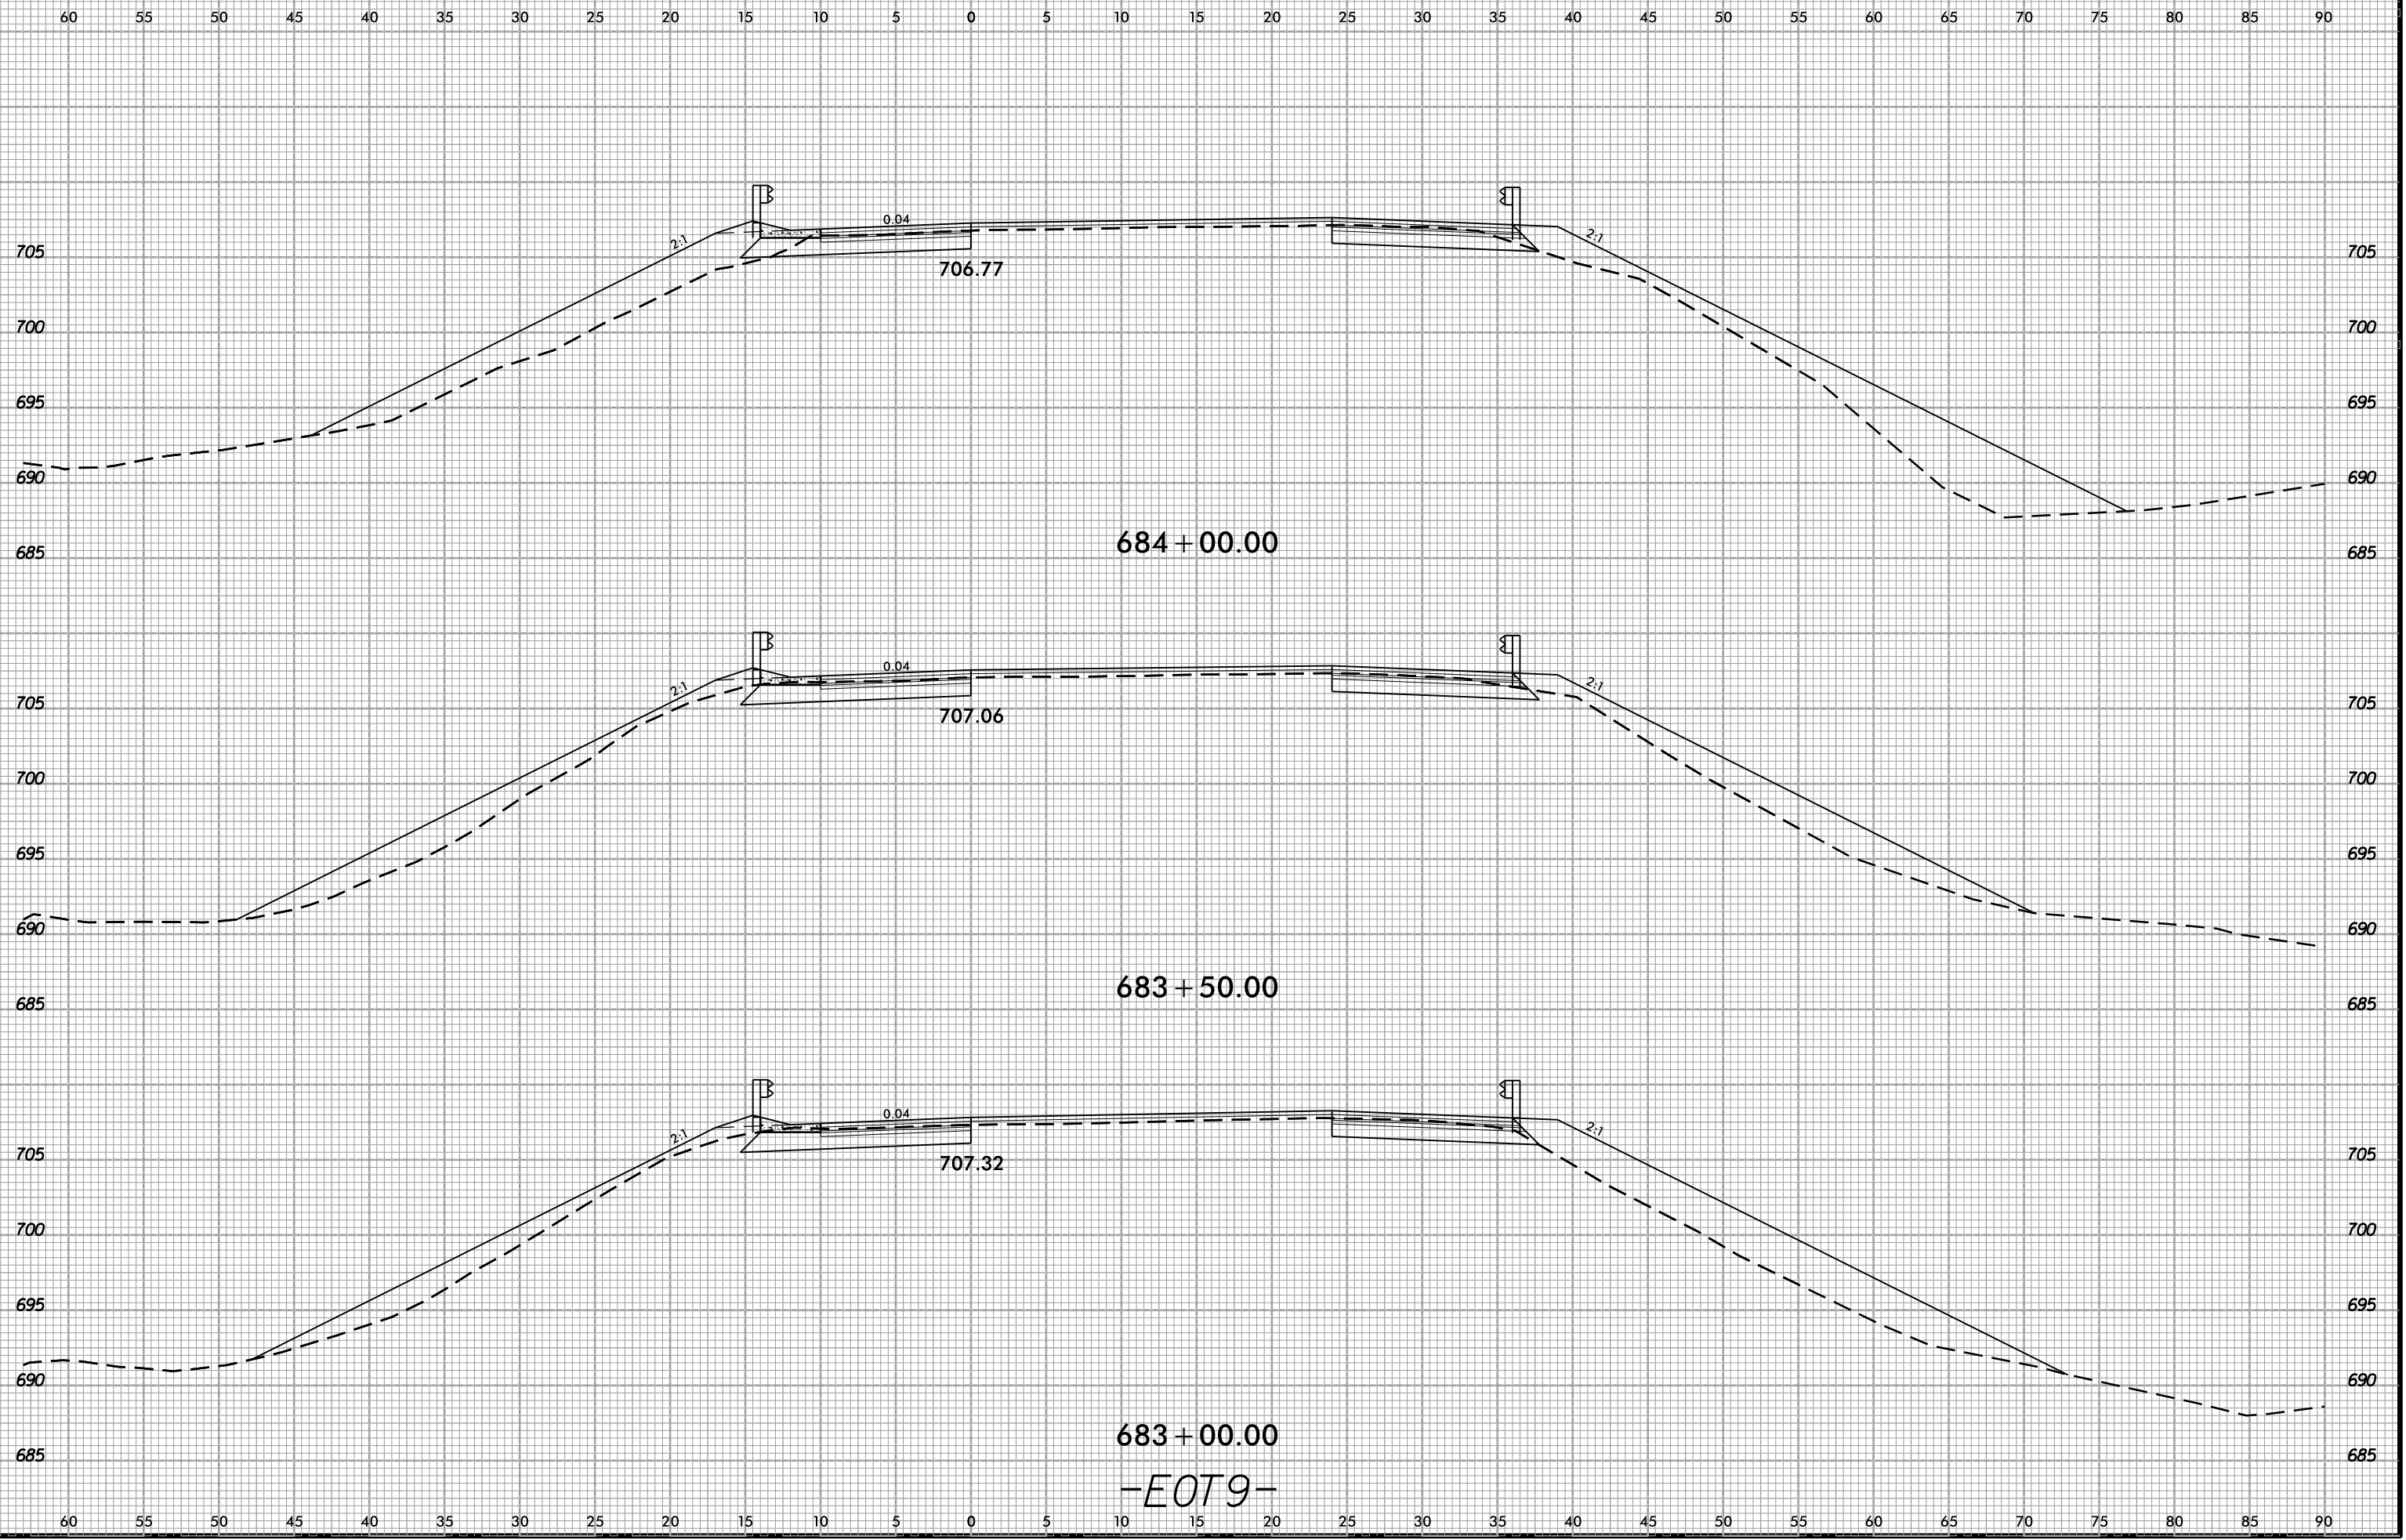


6/23/16  
02-NOV-2018 13:48  
S:\Project-Development\IP Projects\140-Dave Roadway\DesignFiles\5823.ddc.xpl.EOT9.dgn  
AT DIV 9-294550

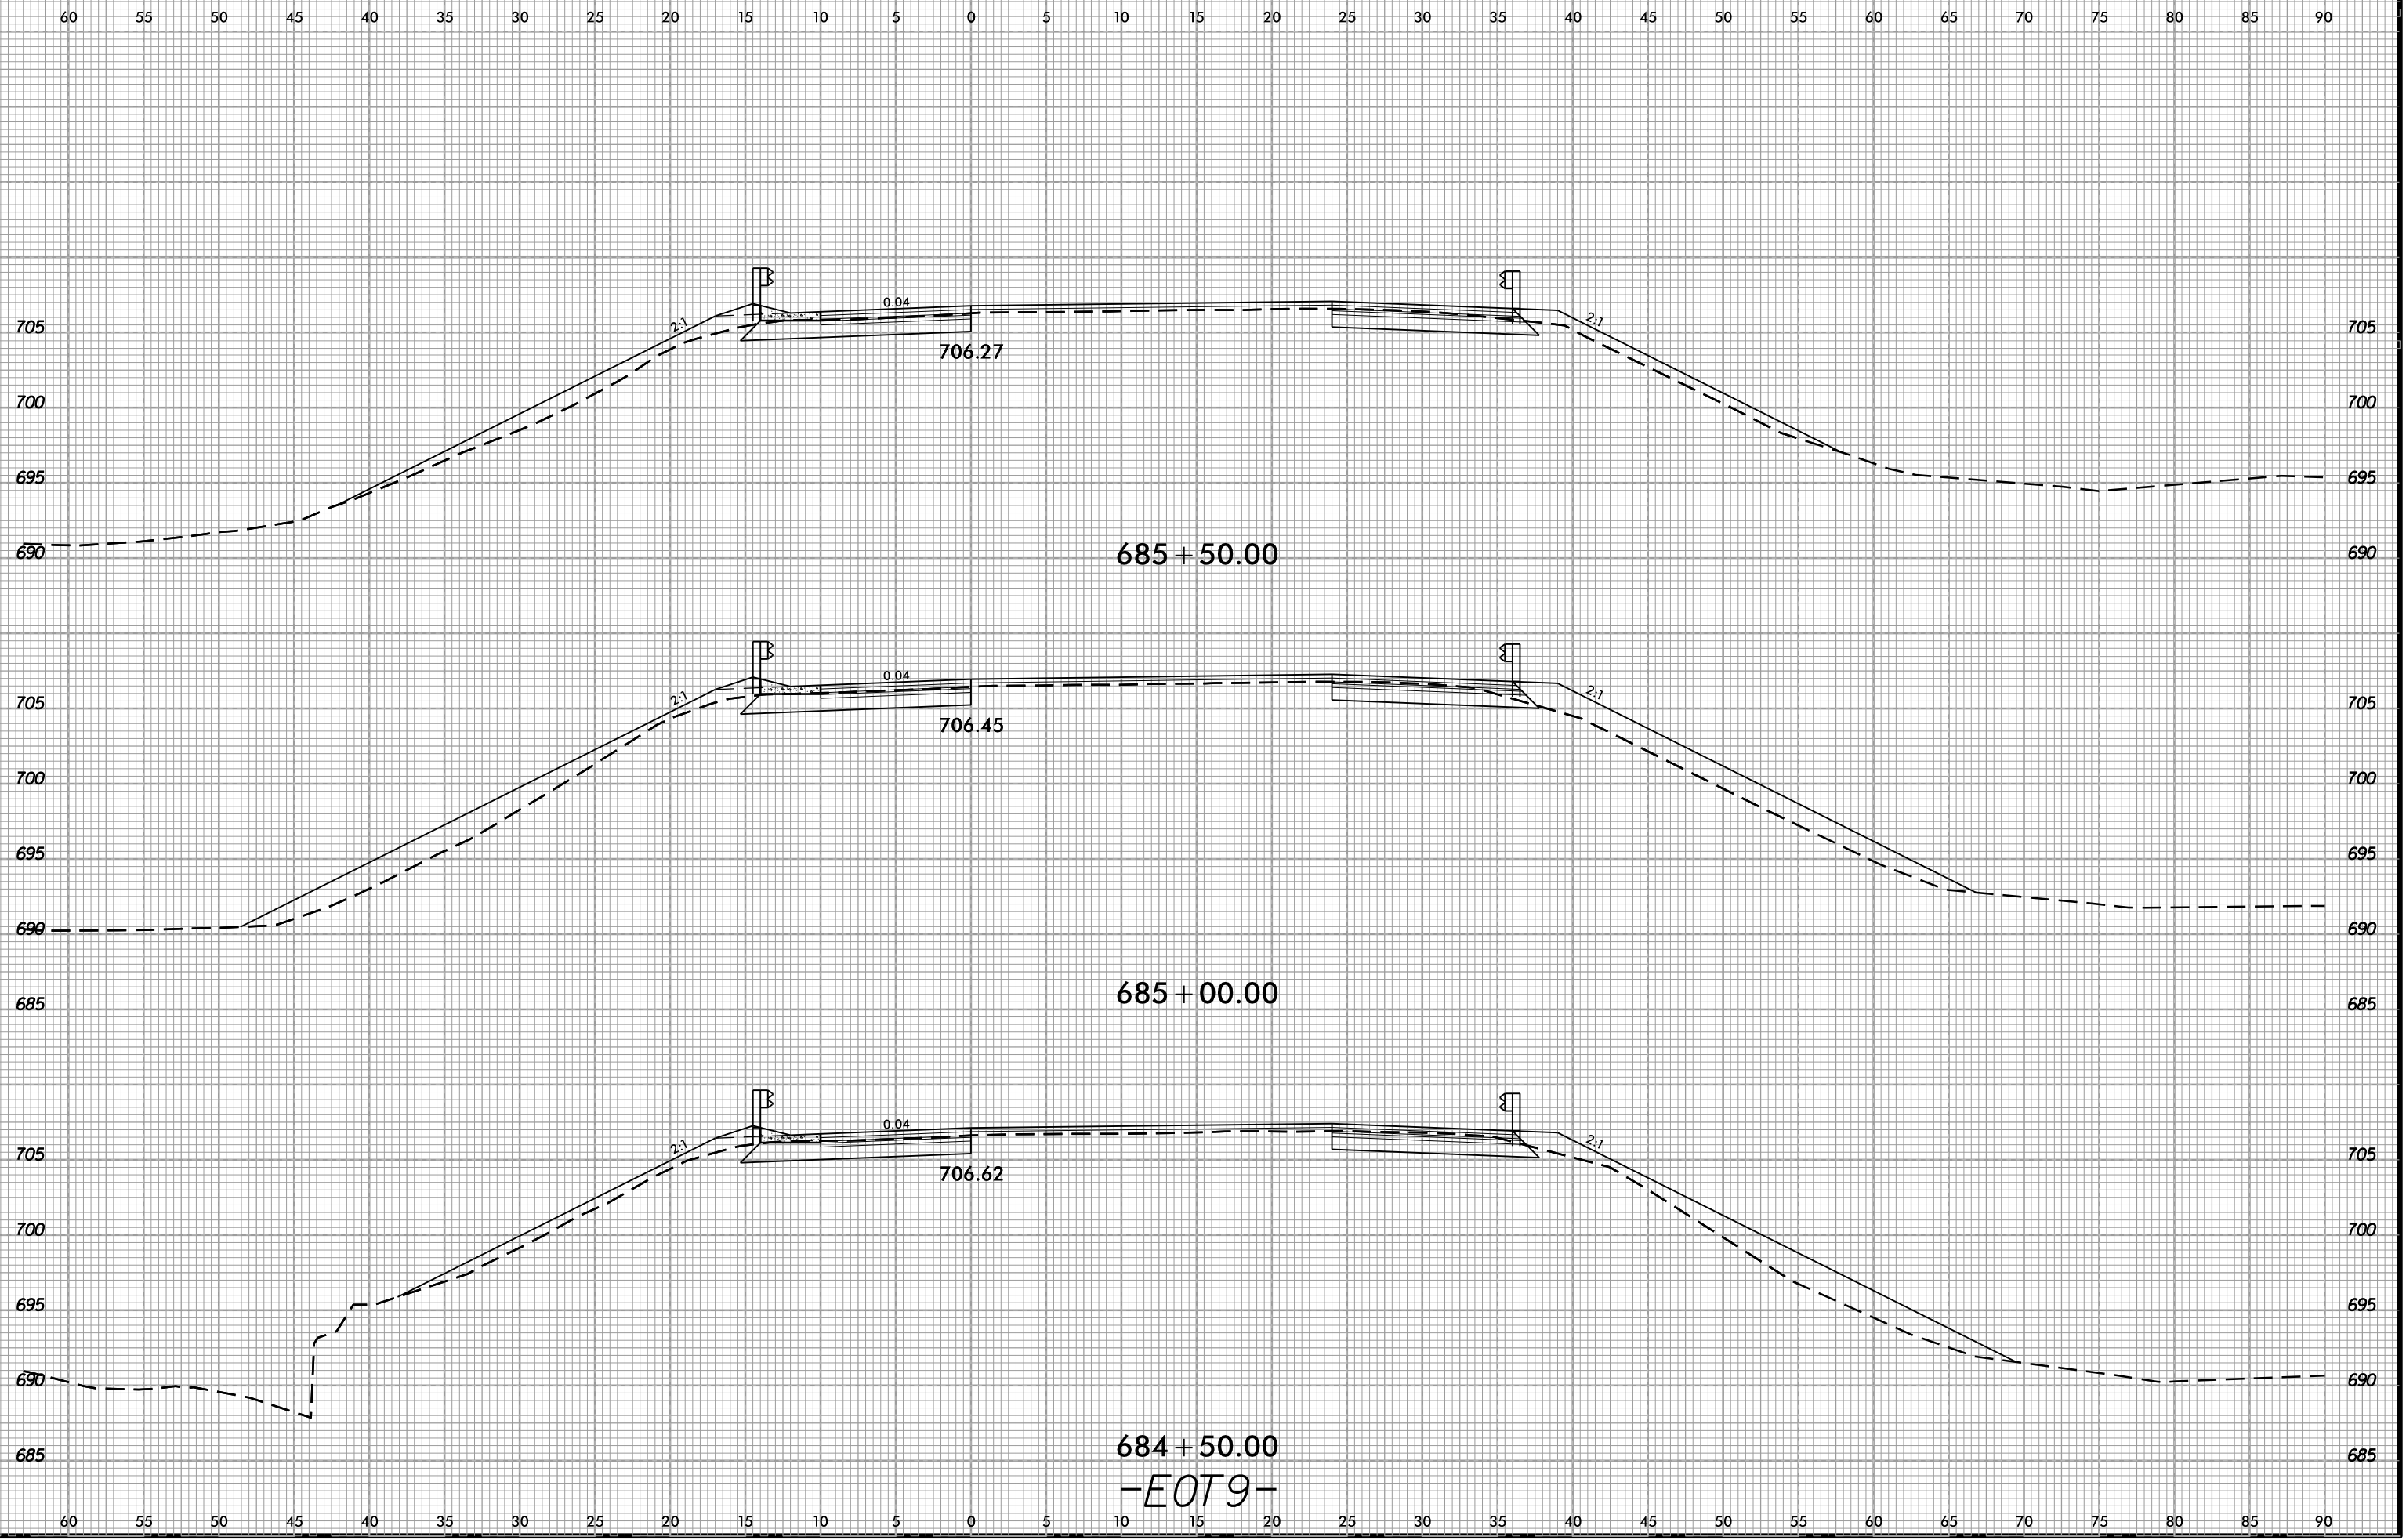


684 + 50.00  
-EOT9-


6/23/16  
02-NOV-2018 13:48  
S:\Projects-Development\IP Projects\1-5823-140-Dave Roadway\DesignFiles\5823.ddc.xpl.EOT10.dgn  
AT DIV 294550

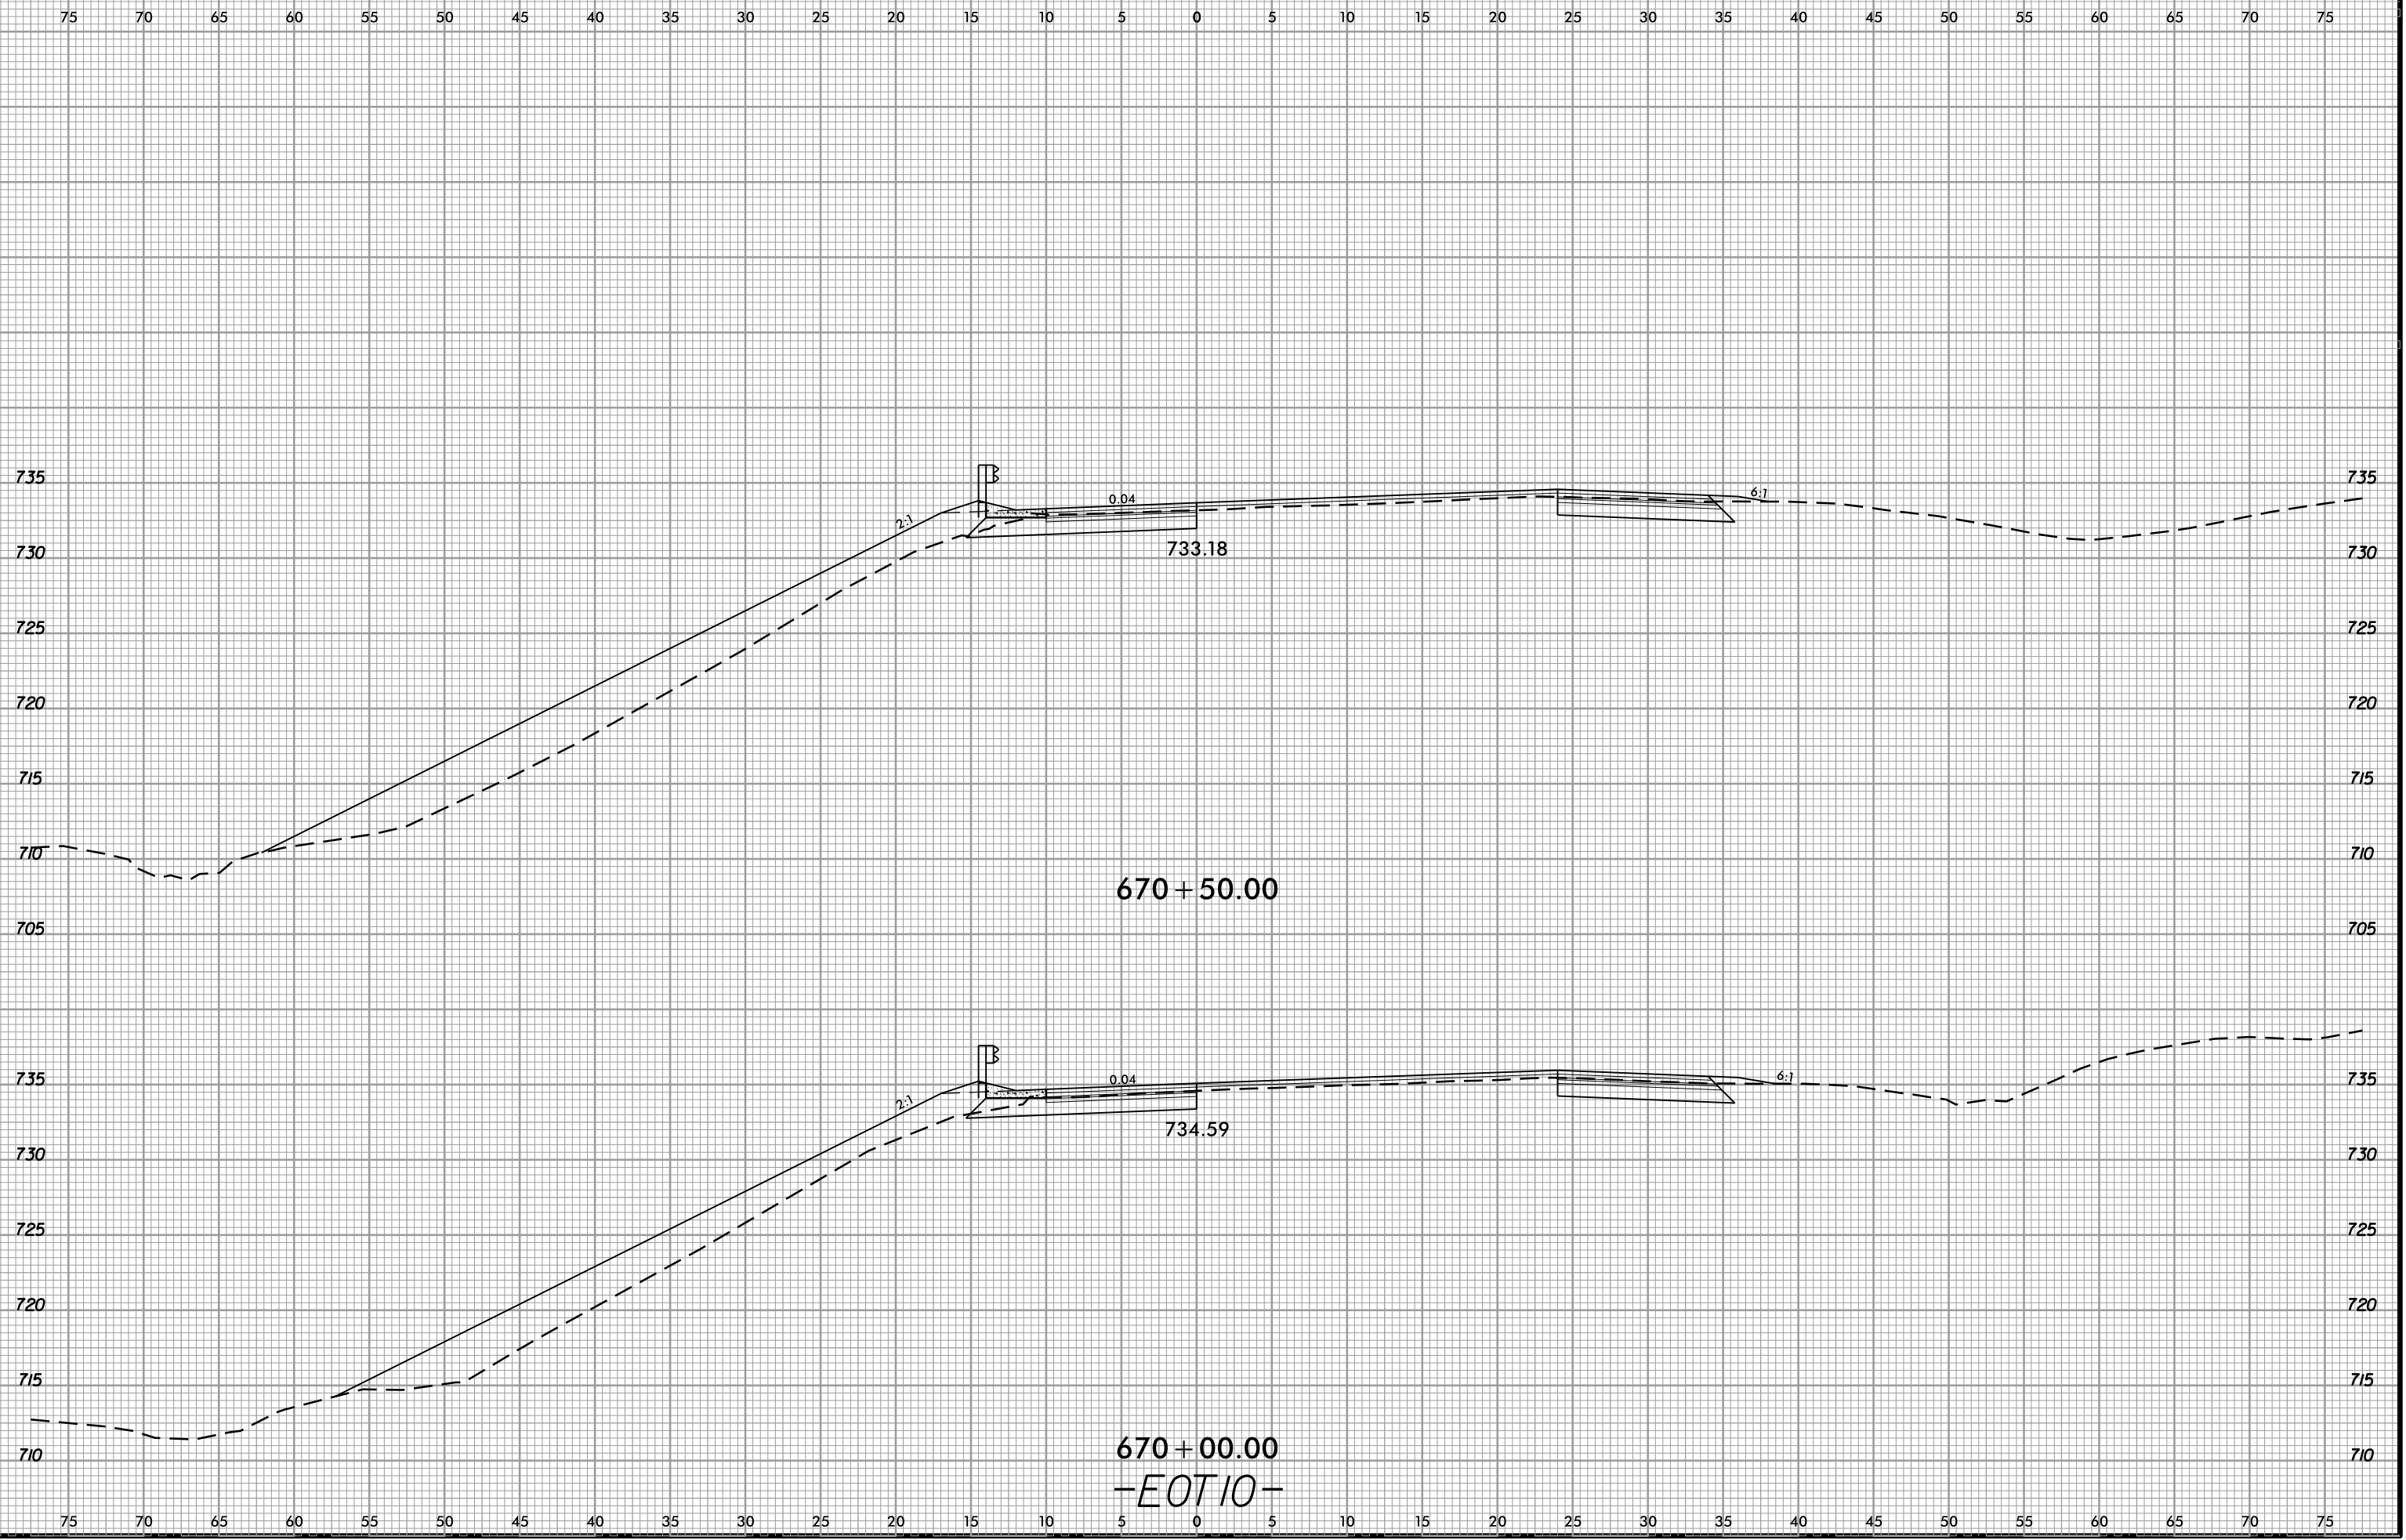

6/23/16  
02-NOV-2018 13:48  
S:\Project-Development\IP Projects\1-5823-140-Dave\Roadway\DesignFiles\5823.ddc.xpl.EOT10.dgn  
AT DIV 294550

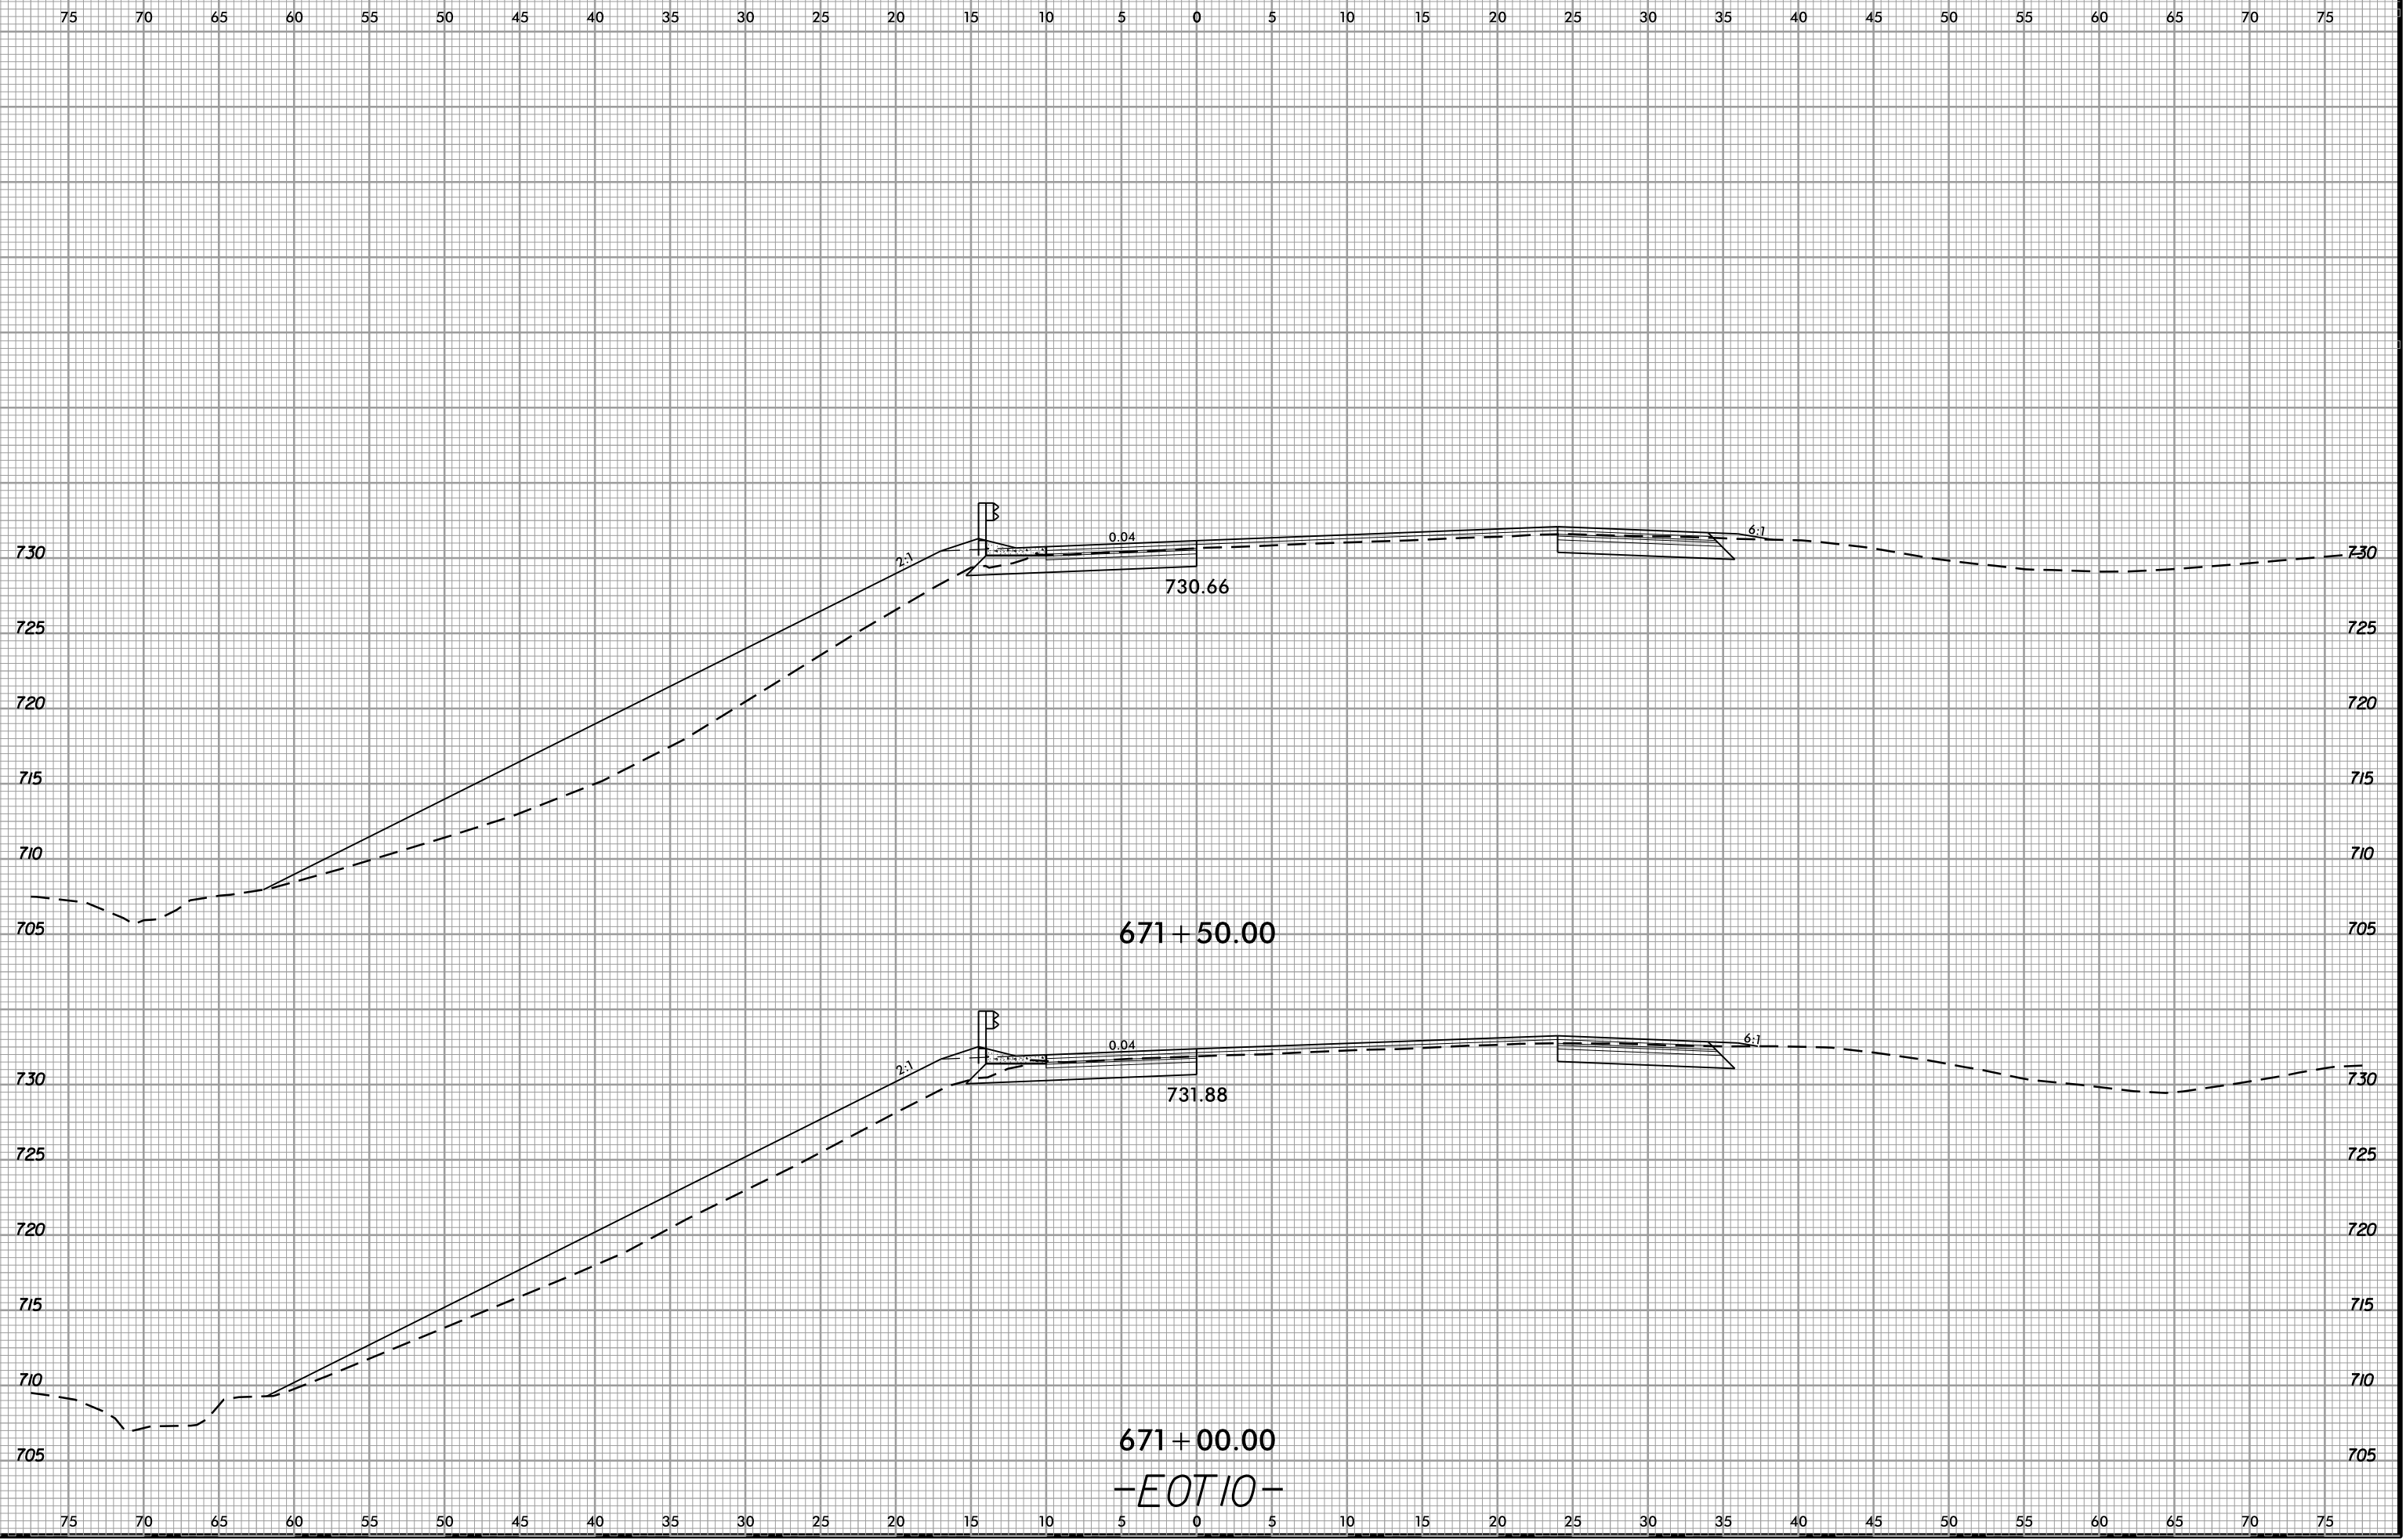


6/23/16  
02-NOV-2018 13:48  
S:\Project-Development\IP Projects\1-5823-140-Dave\Roadway\DesignFiles\5823.ddc.xpl.EOT10.dgn  
Mikeston

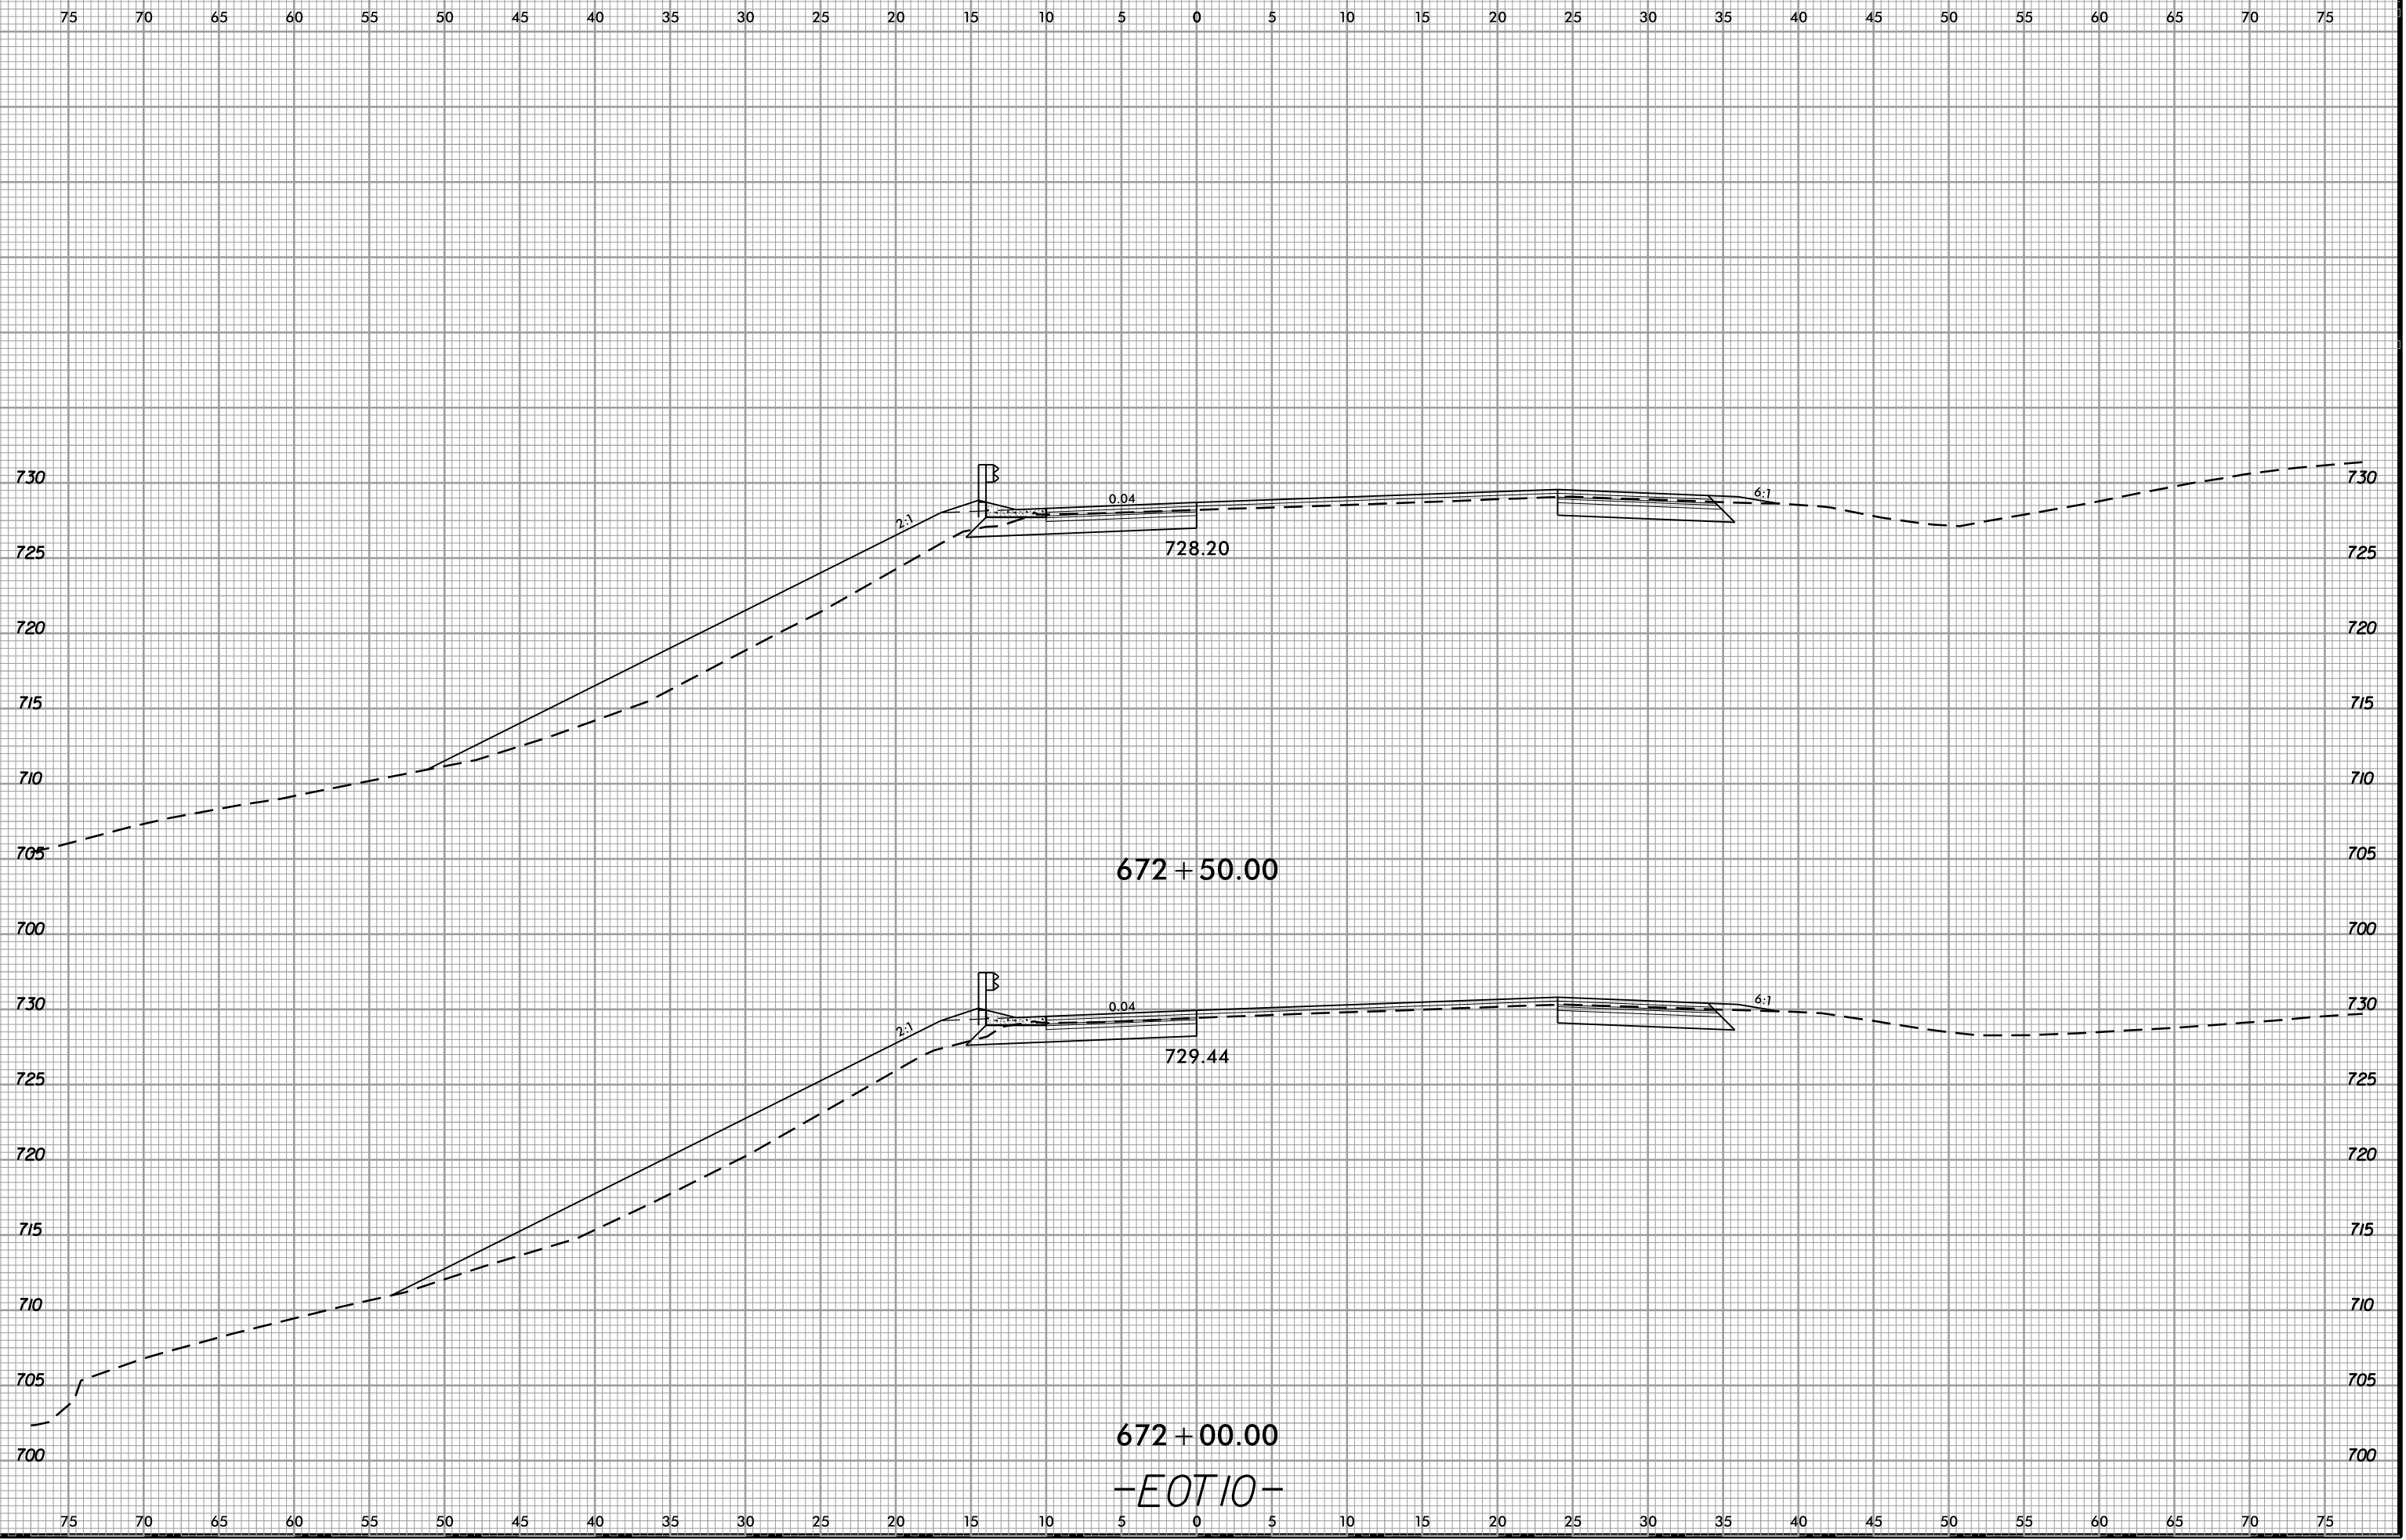


-EOT10-



6/23/16  
02-NOV-2018 13:48  
S:\Projects-Development\IP Projects\11-5823-140-Dave\Roadway\DesignFiles\5823.ddc.xpl.EOT10.dgn  
AT DIV 29450

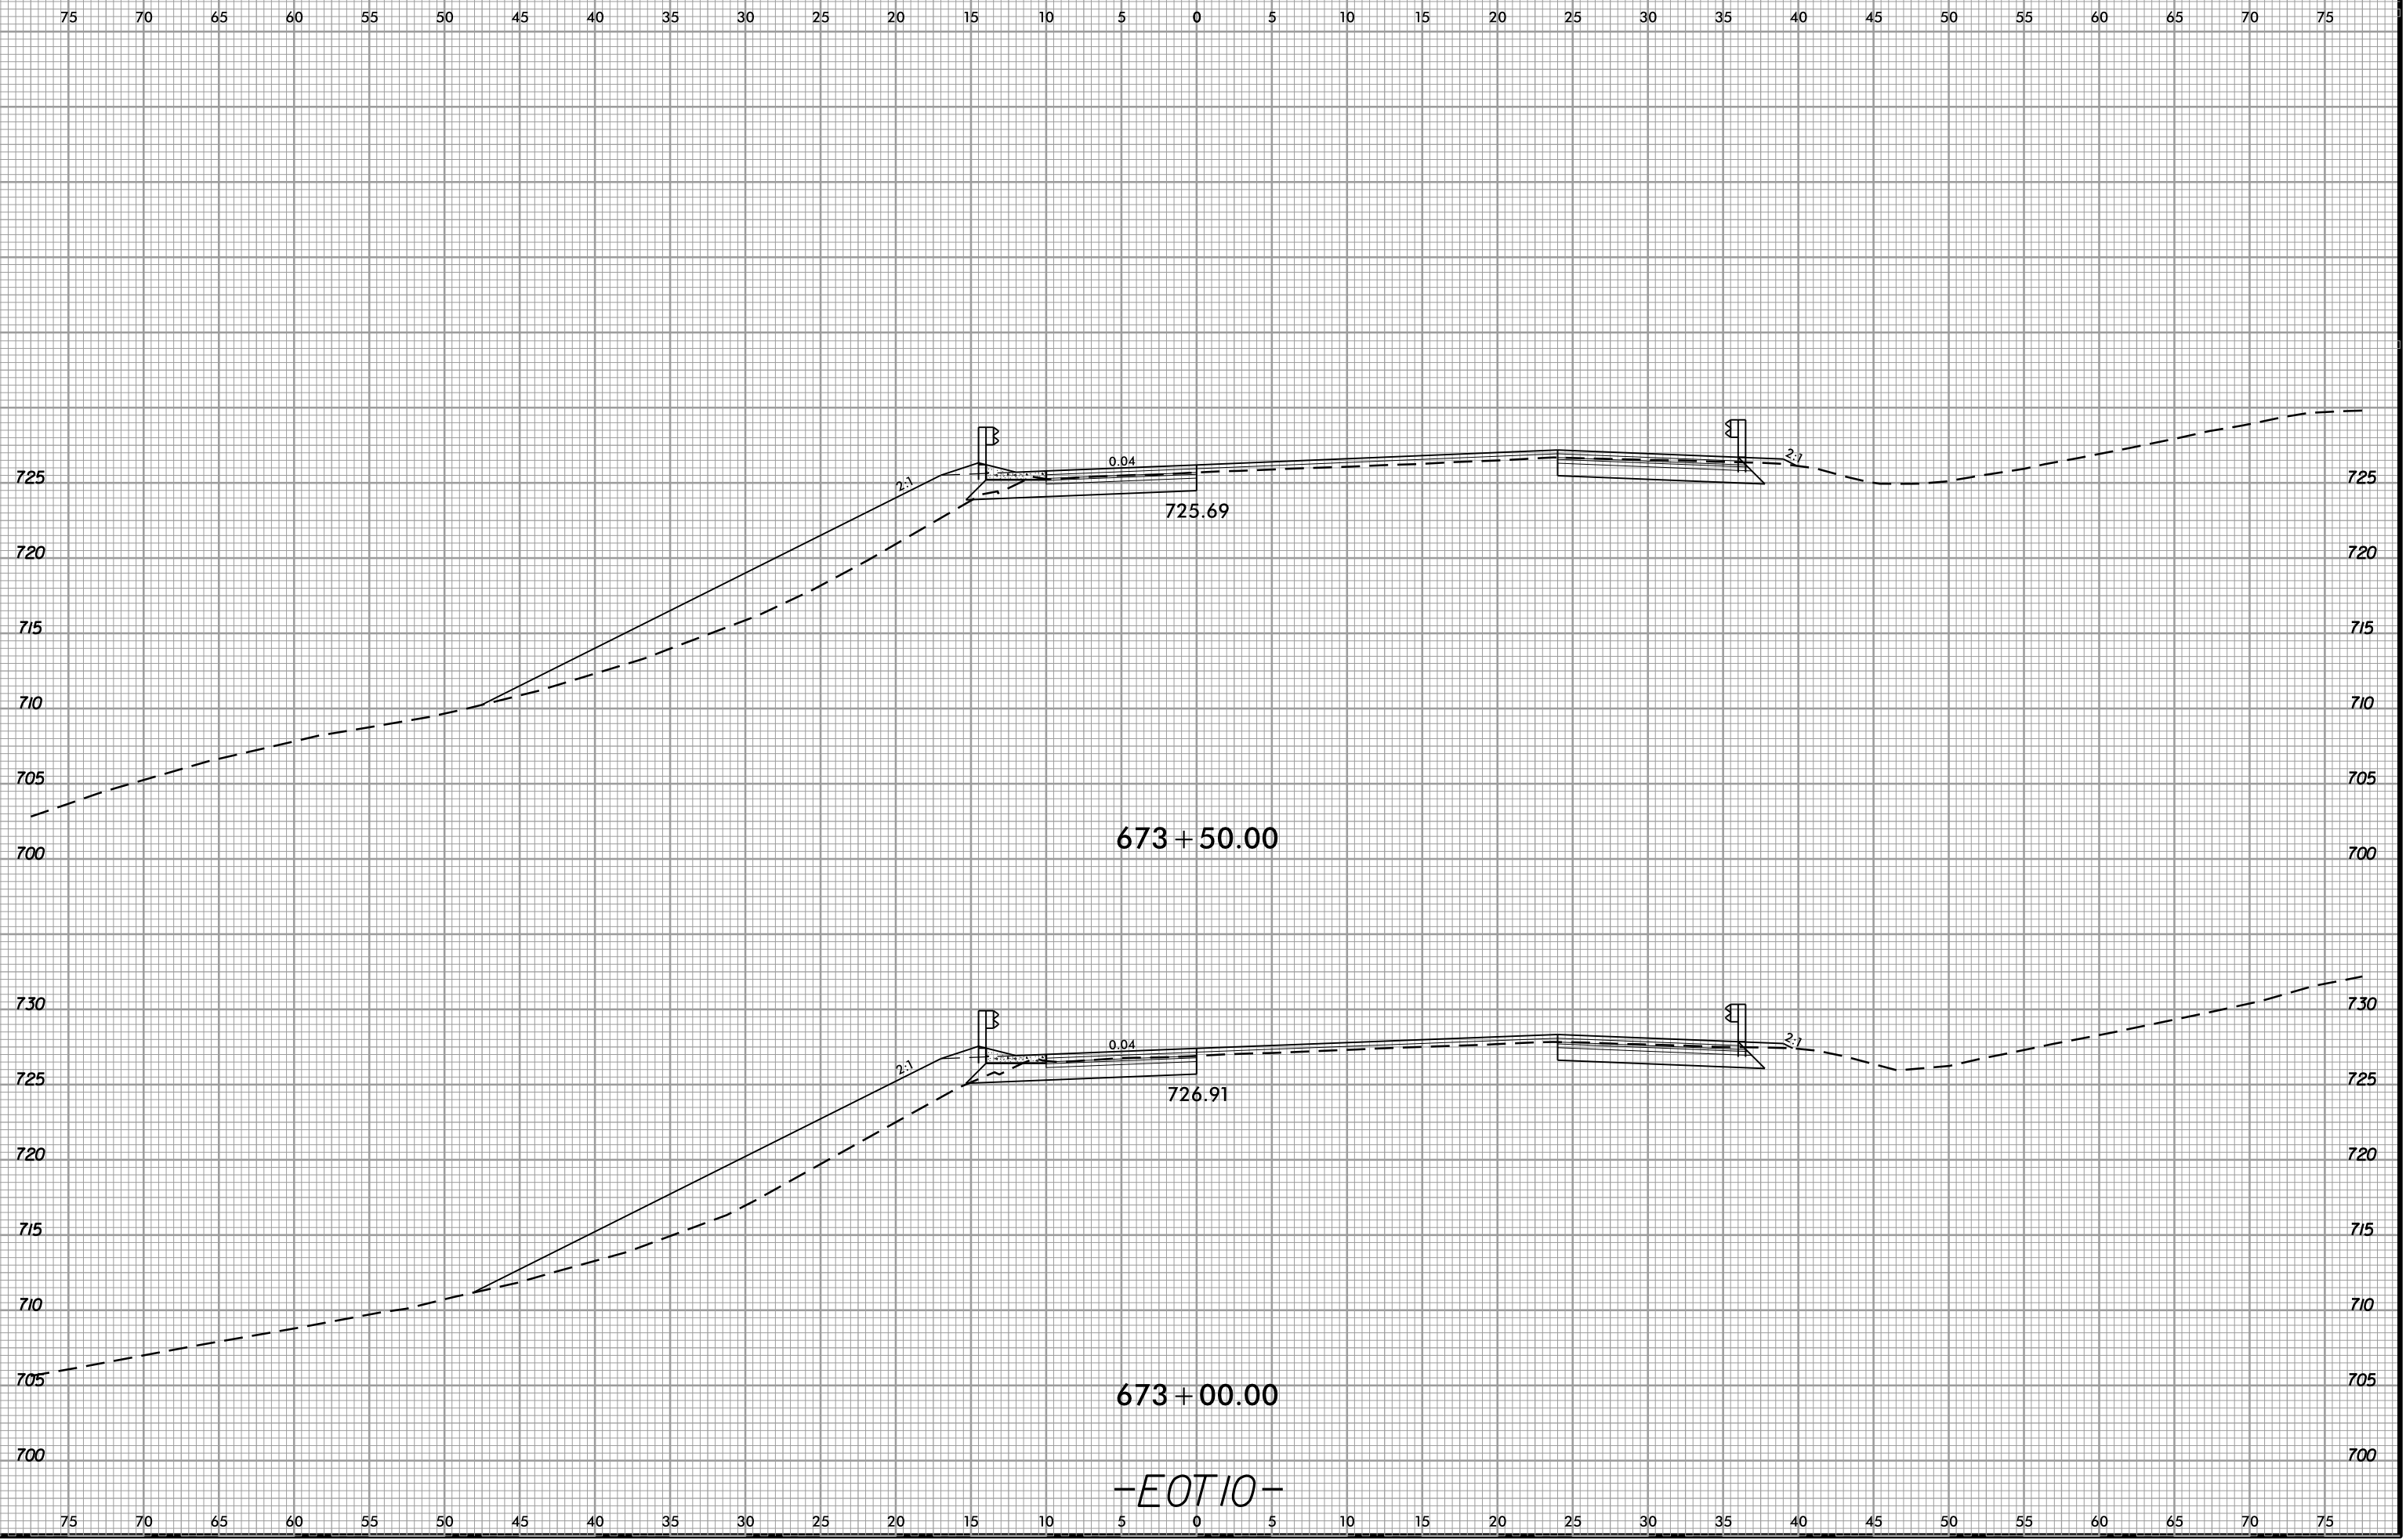


6/23/16  
02-NOV-2018 13:48  
S:\Project-Development\11-5823-140-Dave\Roadway\DesignFiles\5823.ddc.xpl.EOT10.dgn  
AT DIV 294550

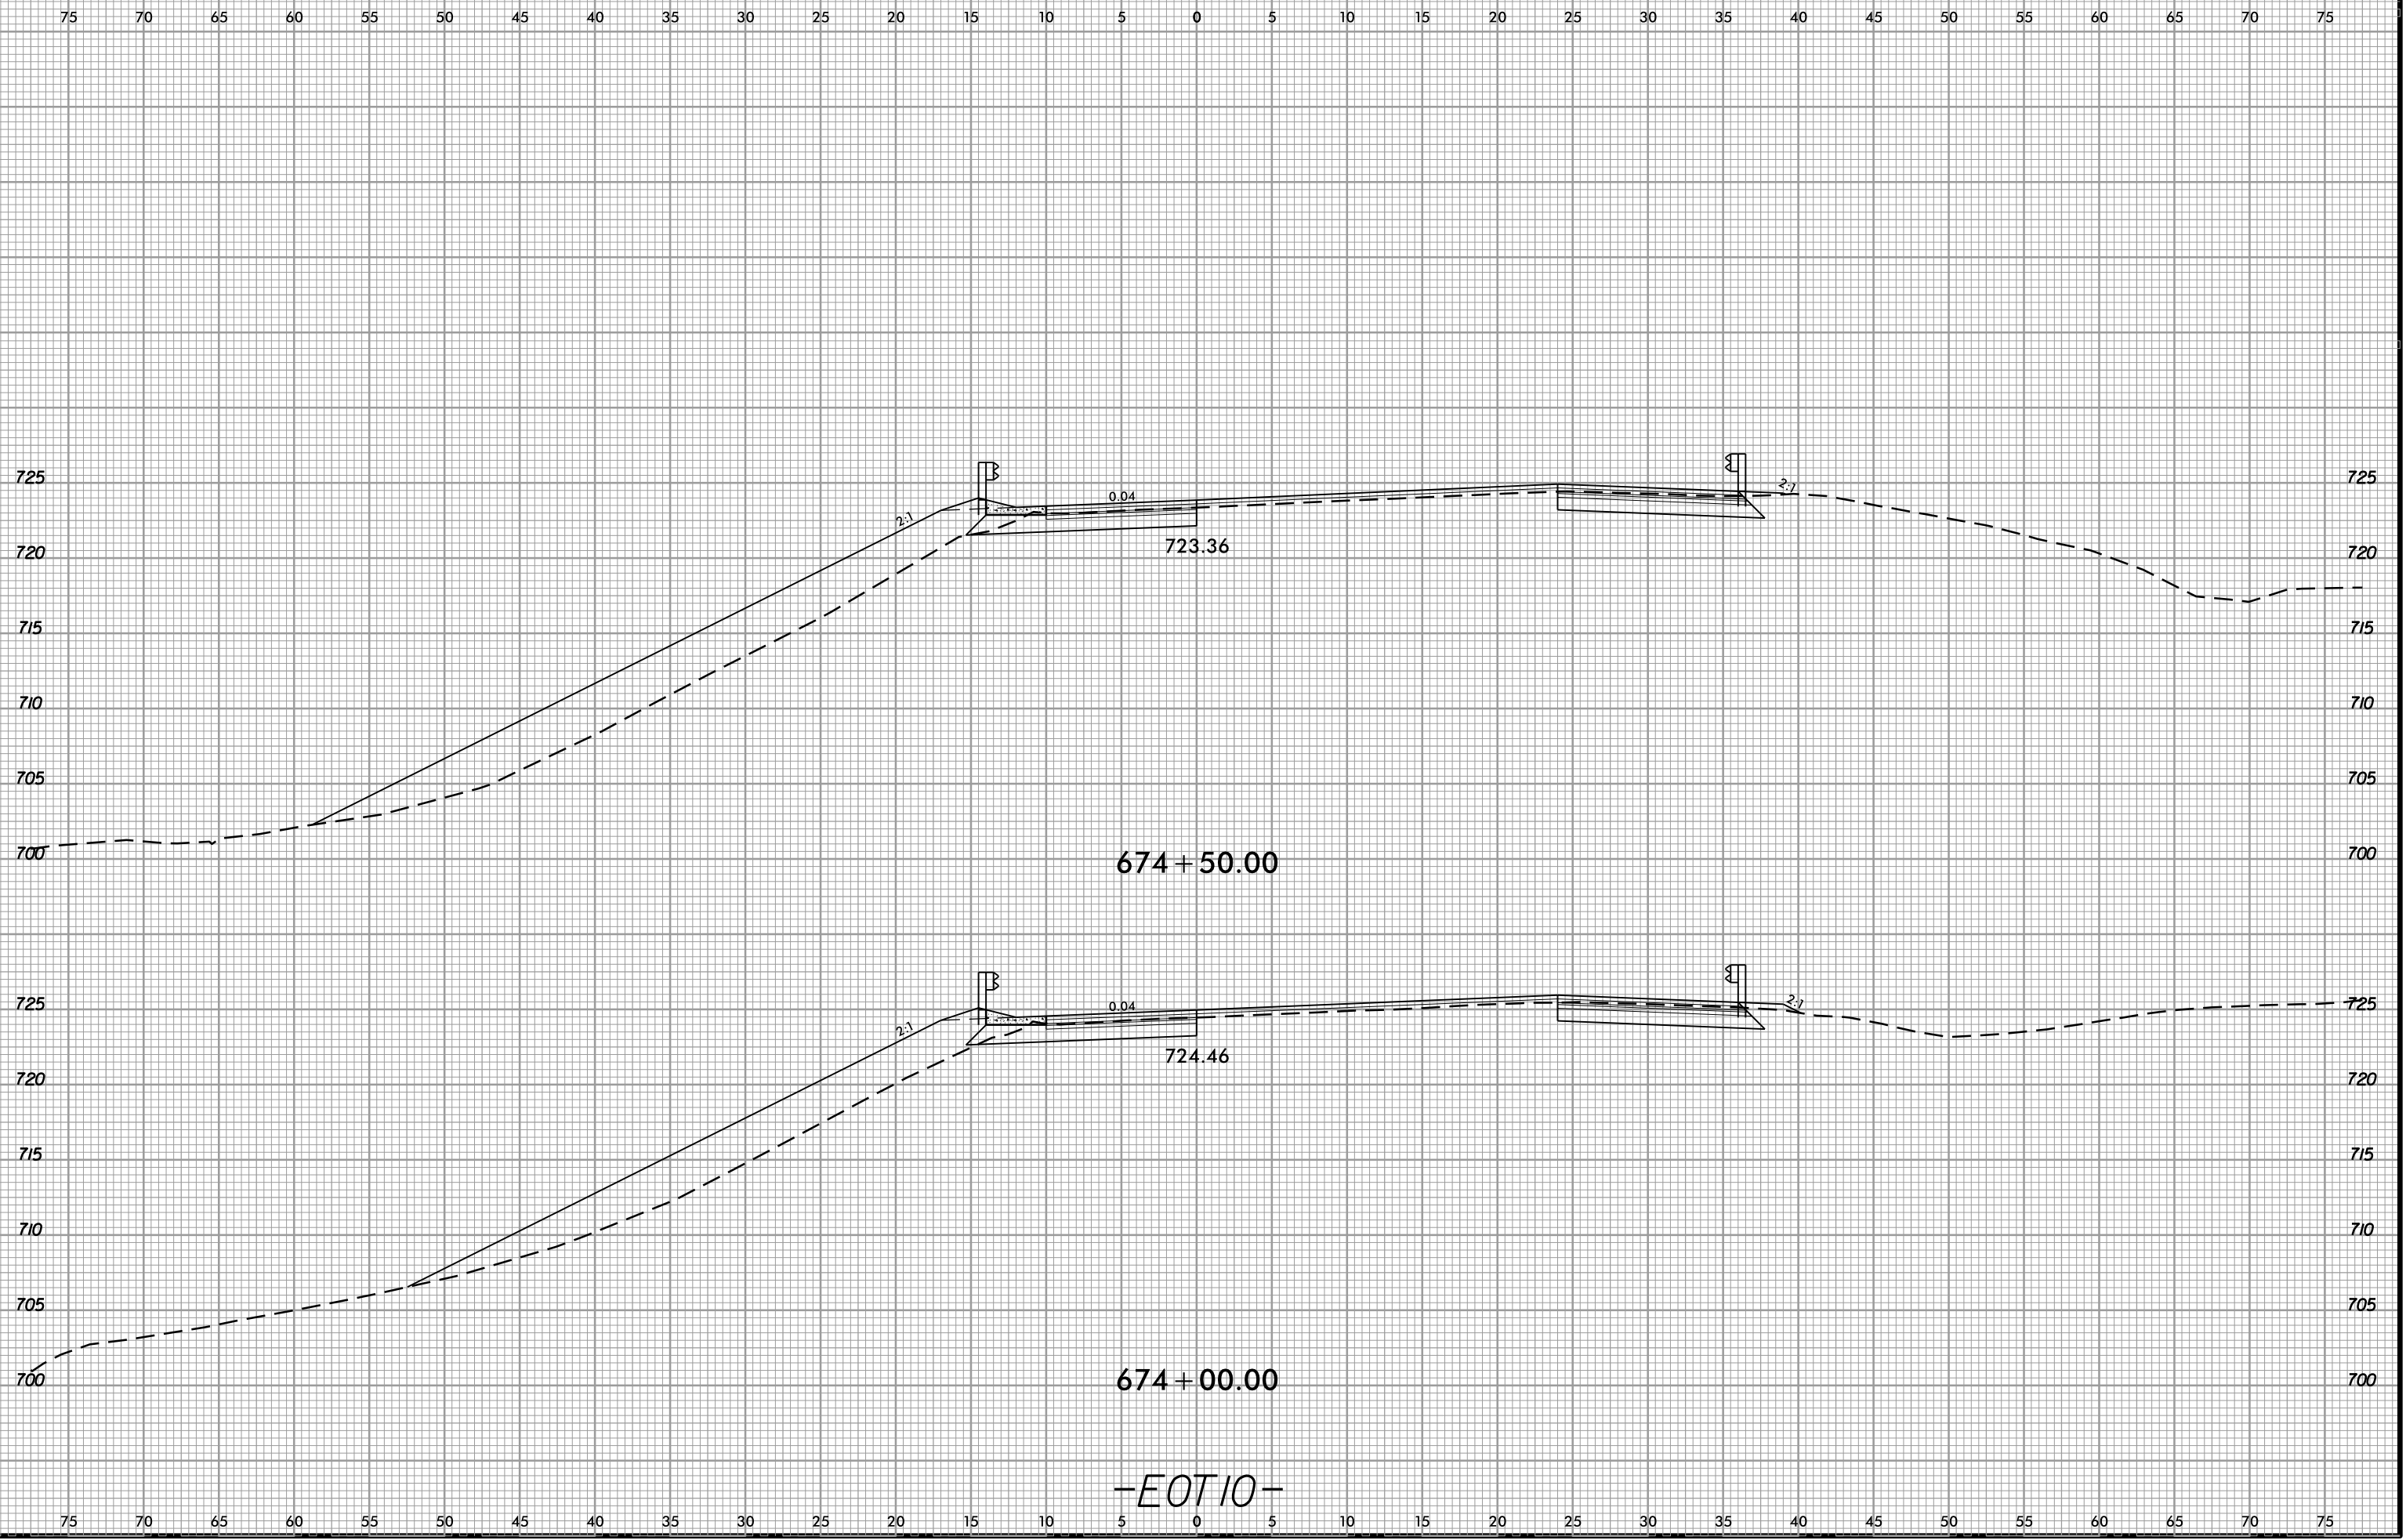


-EOT10-


6/23/16  
02-NOV-2018 13:48  
S:\Project-Development\IP Projects\1-5823-140-Dave\Roadway\DesignFiles\5823.ddc.xpl.EOT10.dgn  
Mikeston AT DIV 294550

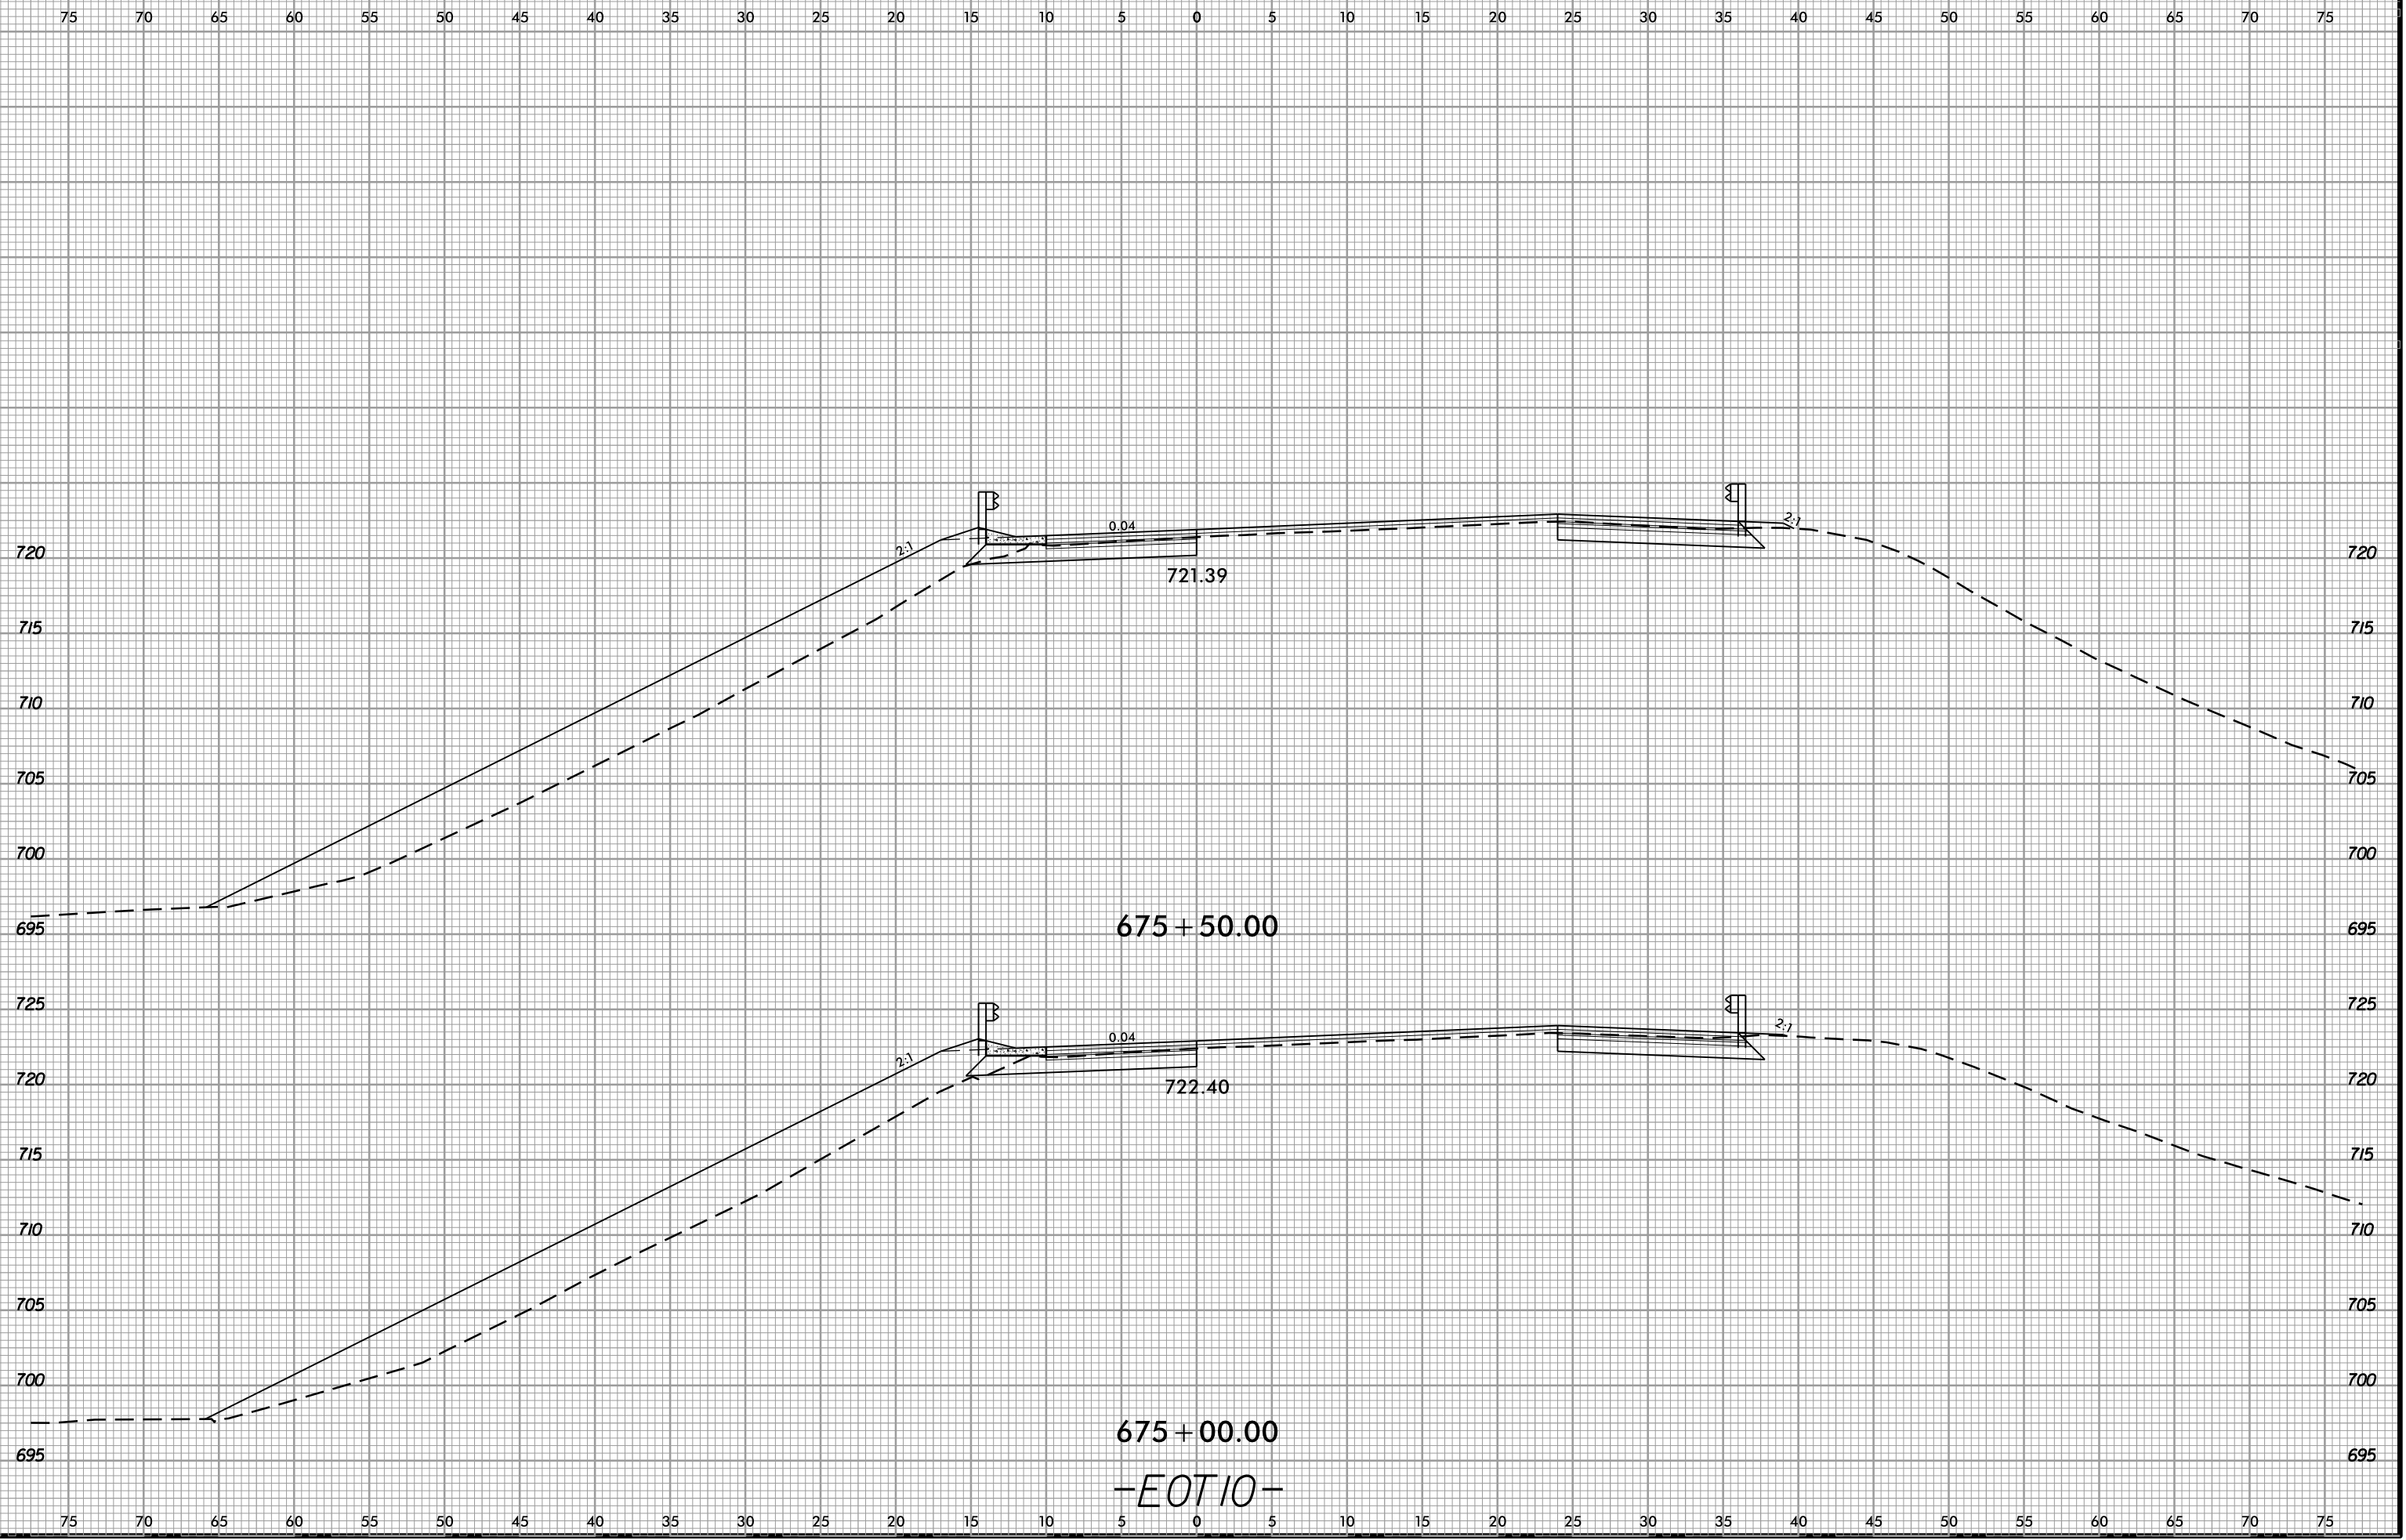


02-NOV-2018 13:49  
S:\Projects-Development\IP Projects\1-5823-140-Dave\Roadway\DesignFiles\5823.ddc.xpl.EOT10.dgn  
Mikeston AT DIV 294550

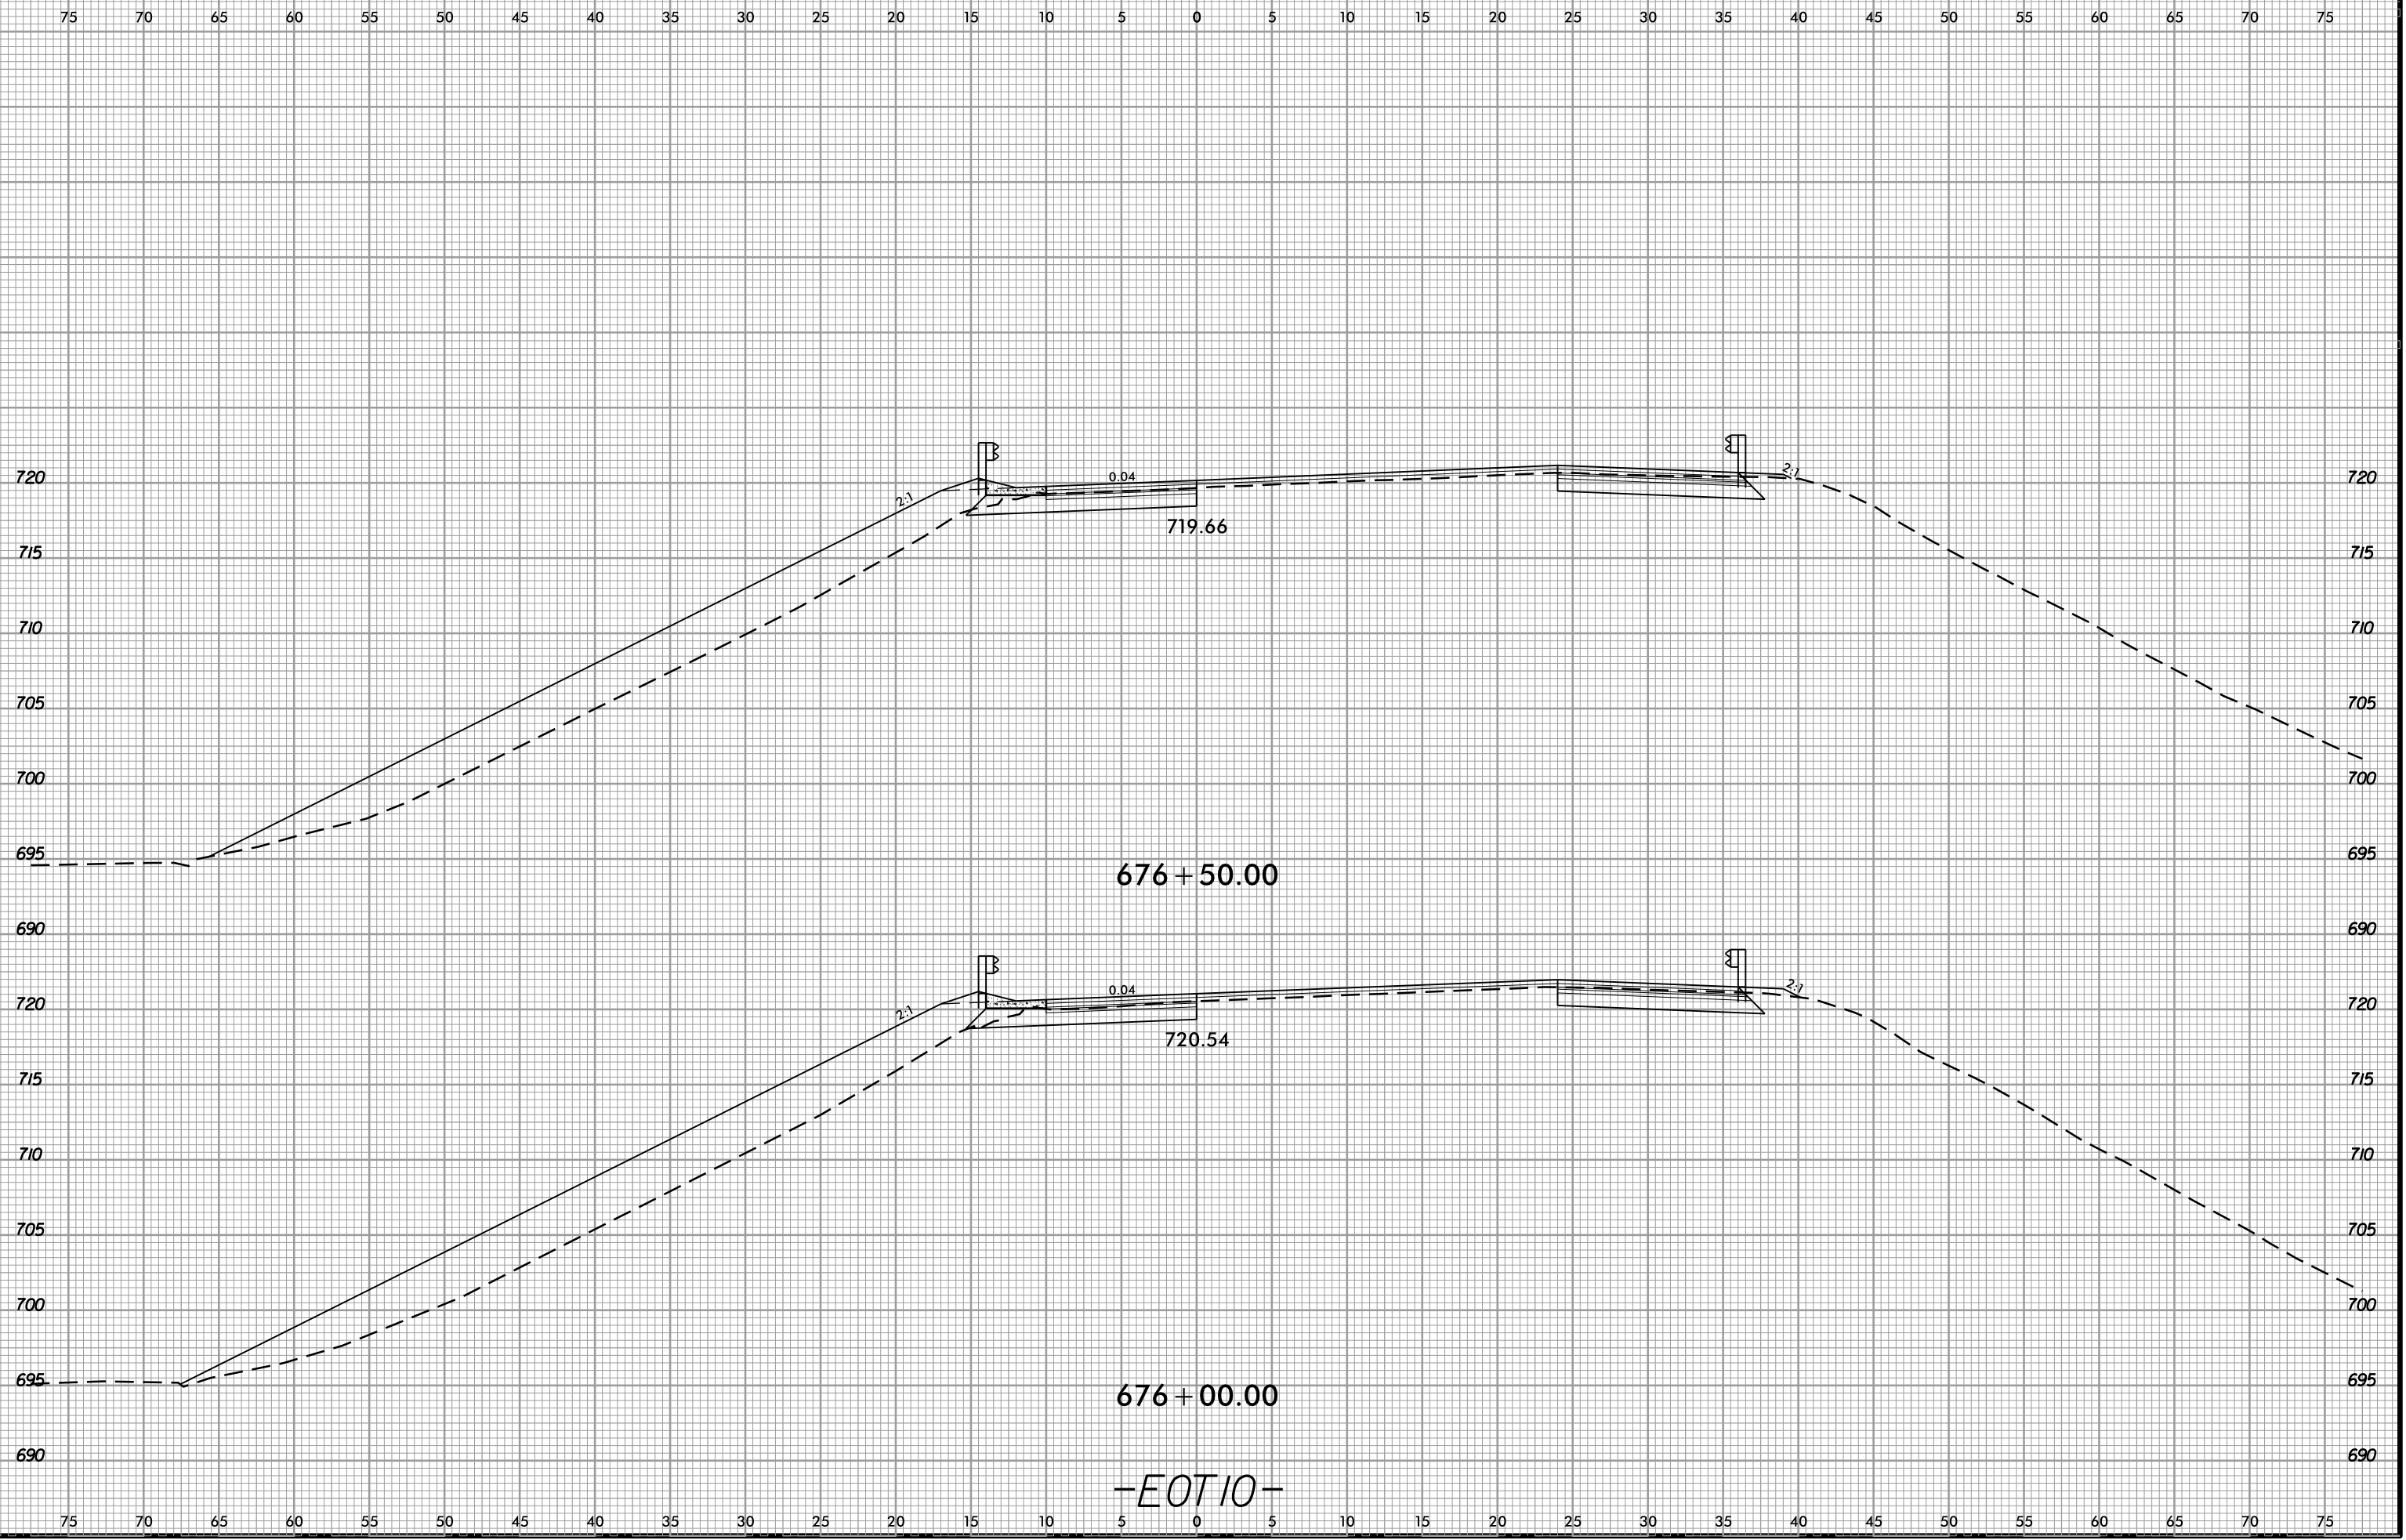

6/23/16  
02-NOV-2018 13:49  
S:\Projects-Development\IP Projects\1-5823-140-Dave Roadway\DesignFiles\5823.ddc.xpl.EOT10.dgn  
AT DIV 29450

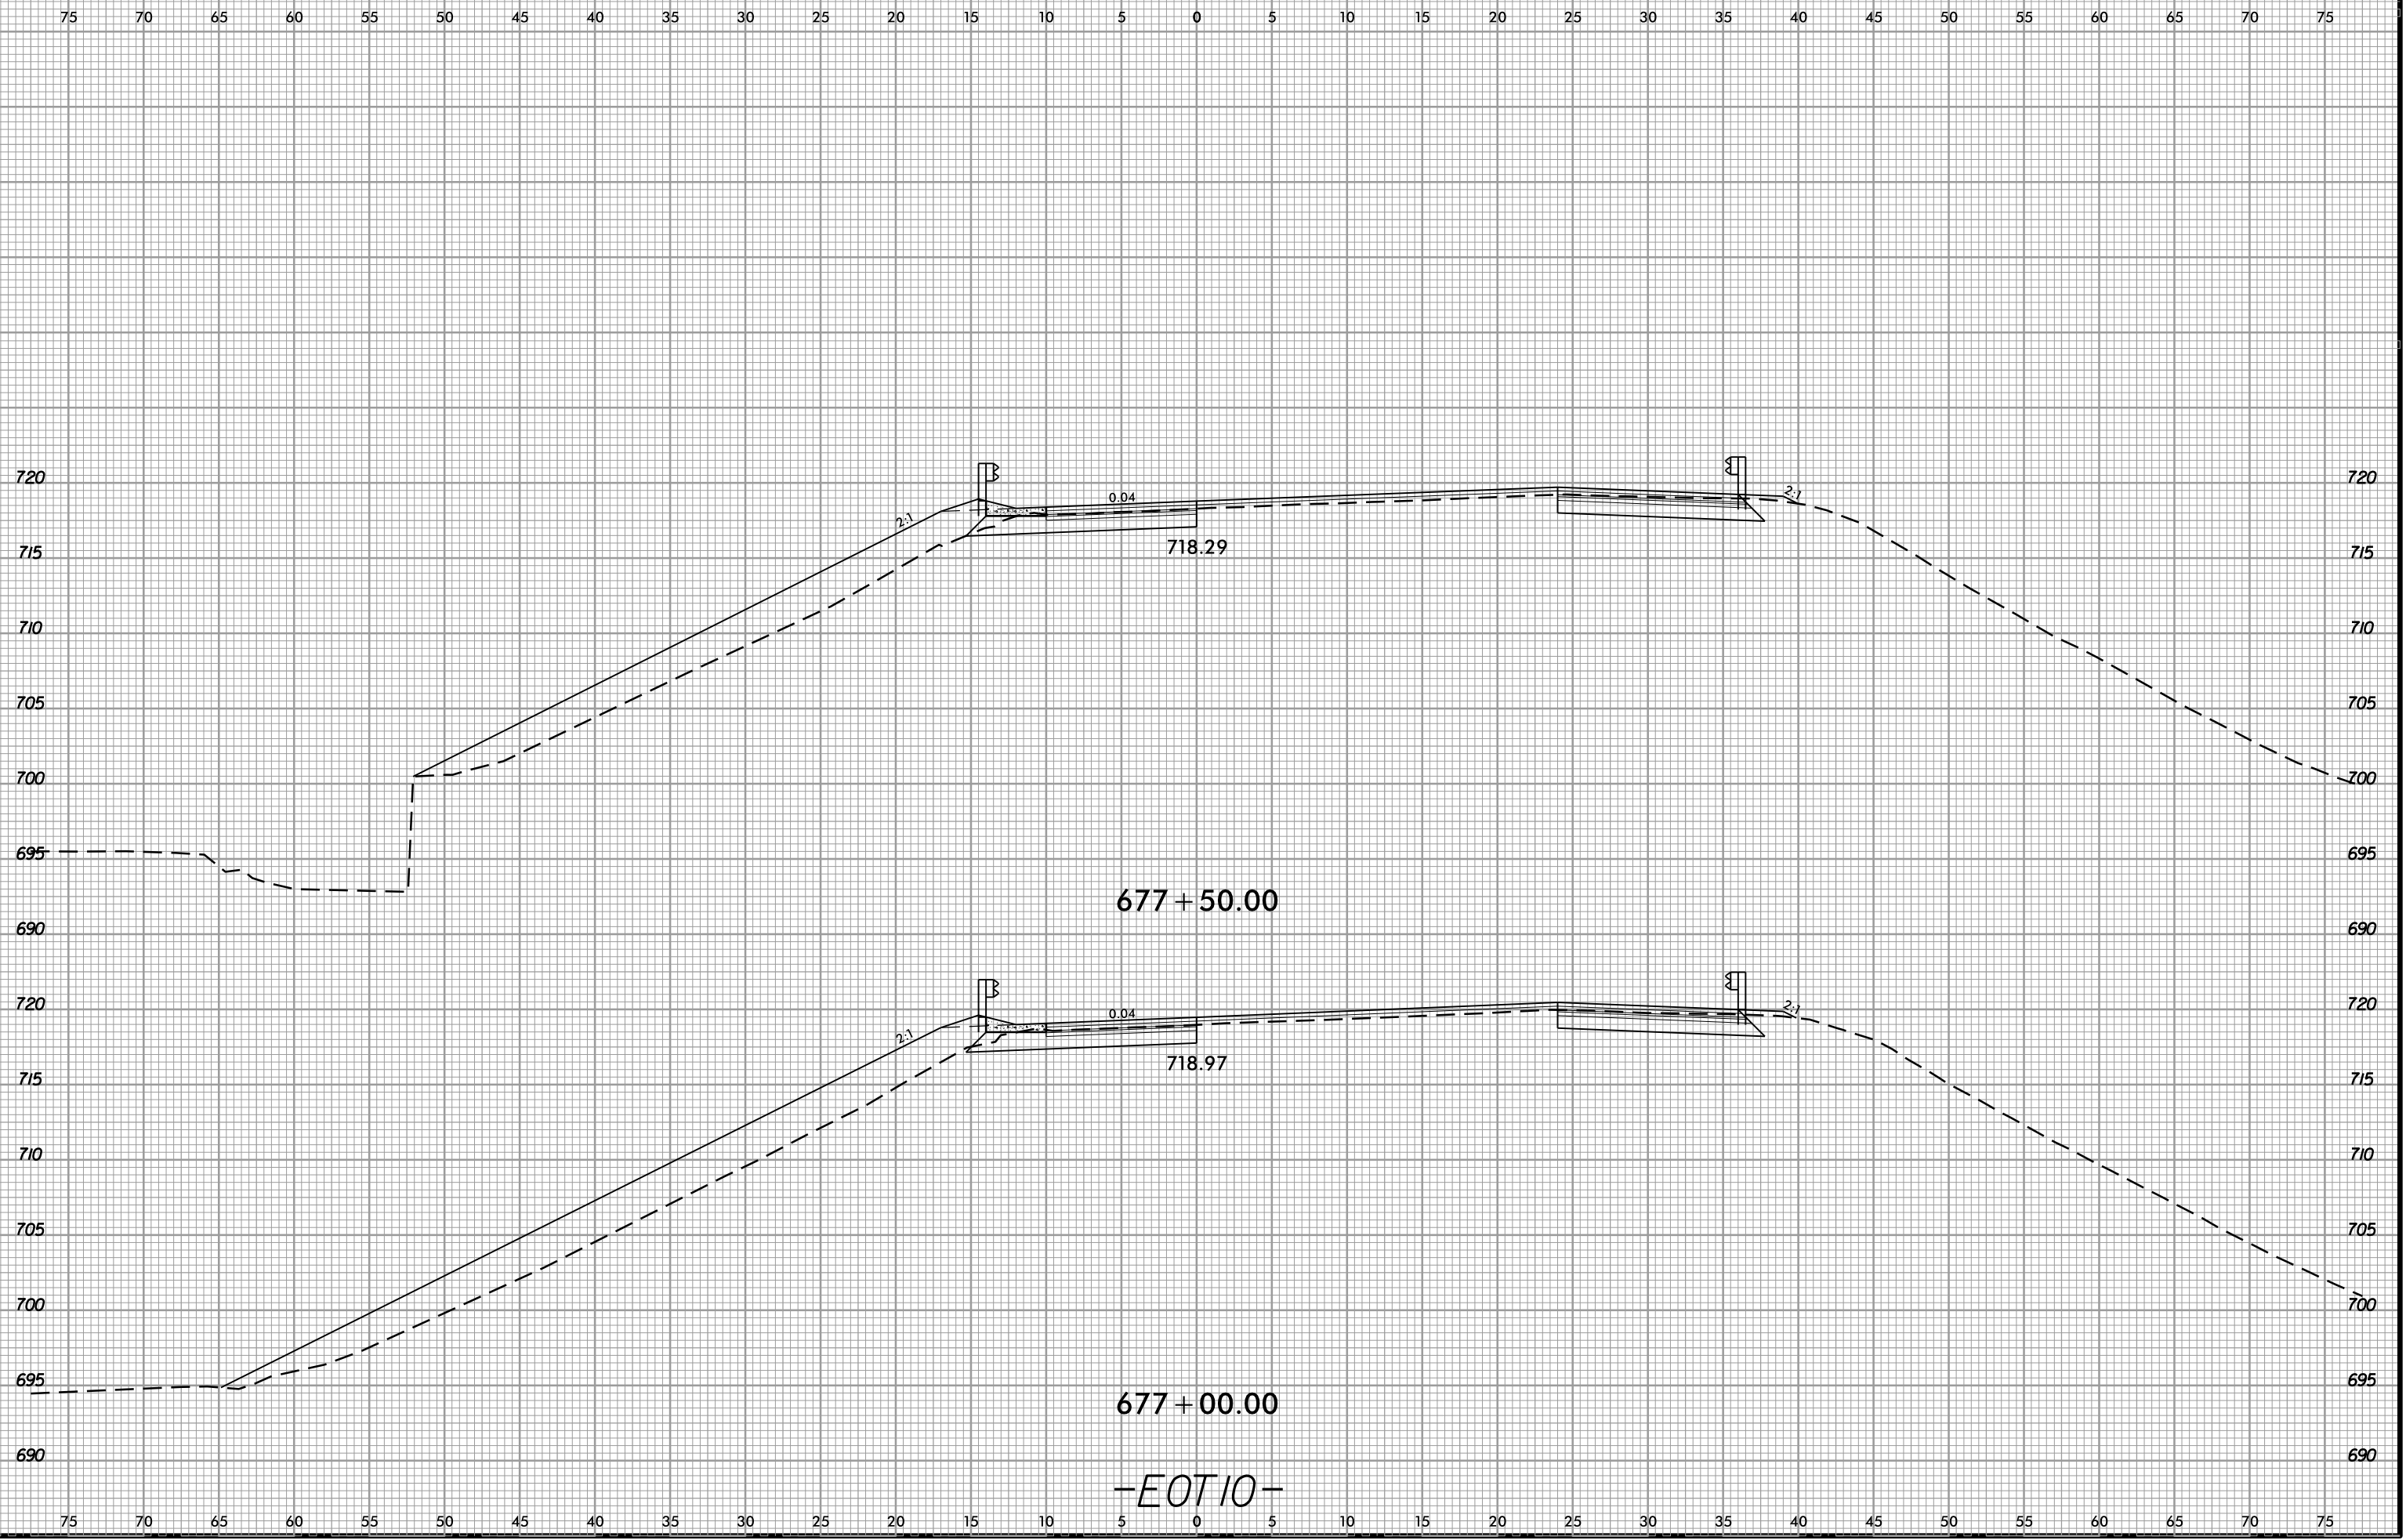

6/23/16  
02-NOV-2018 13:49  
S:\Project-Development\IP Projects\1-5823-140-Dave Roadway\DesignFiles\5823.ddc.xpl.EOT10.dgn  
Mikeston AT DIV 294550

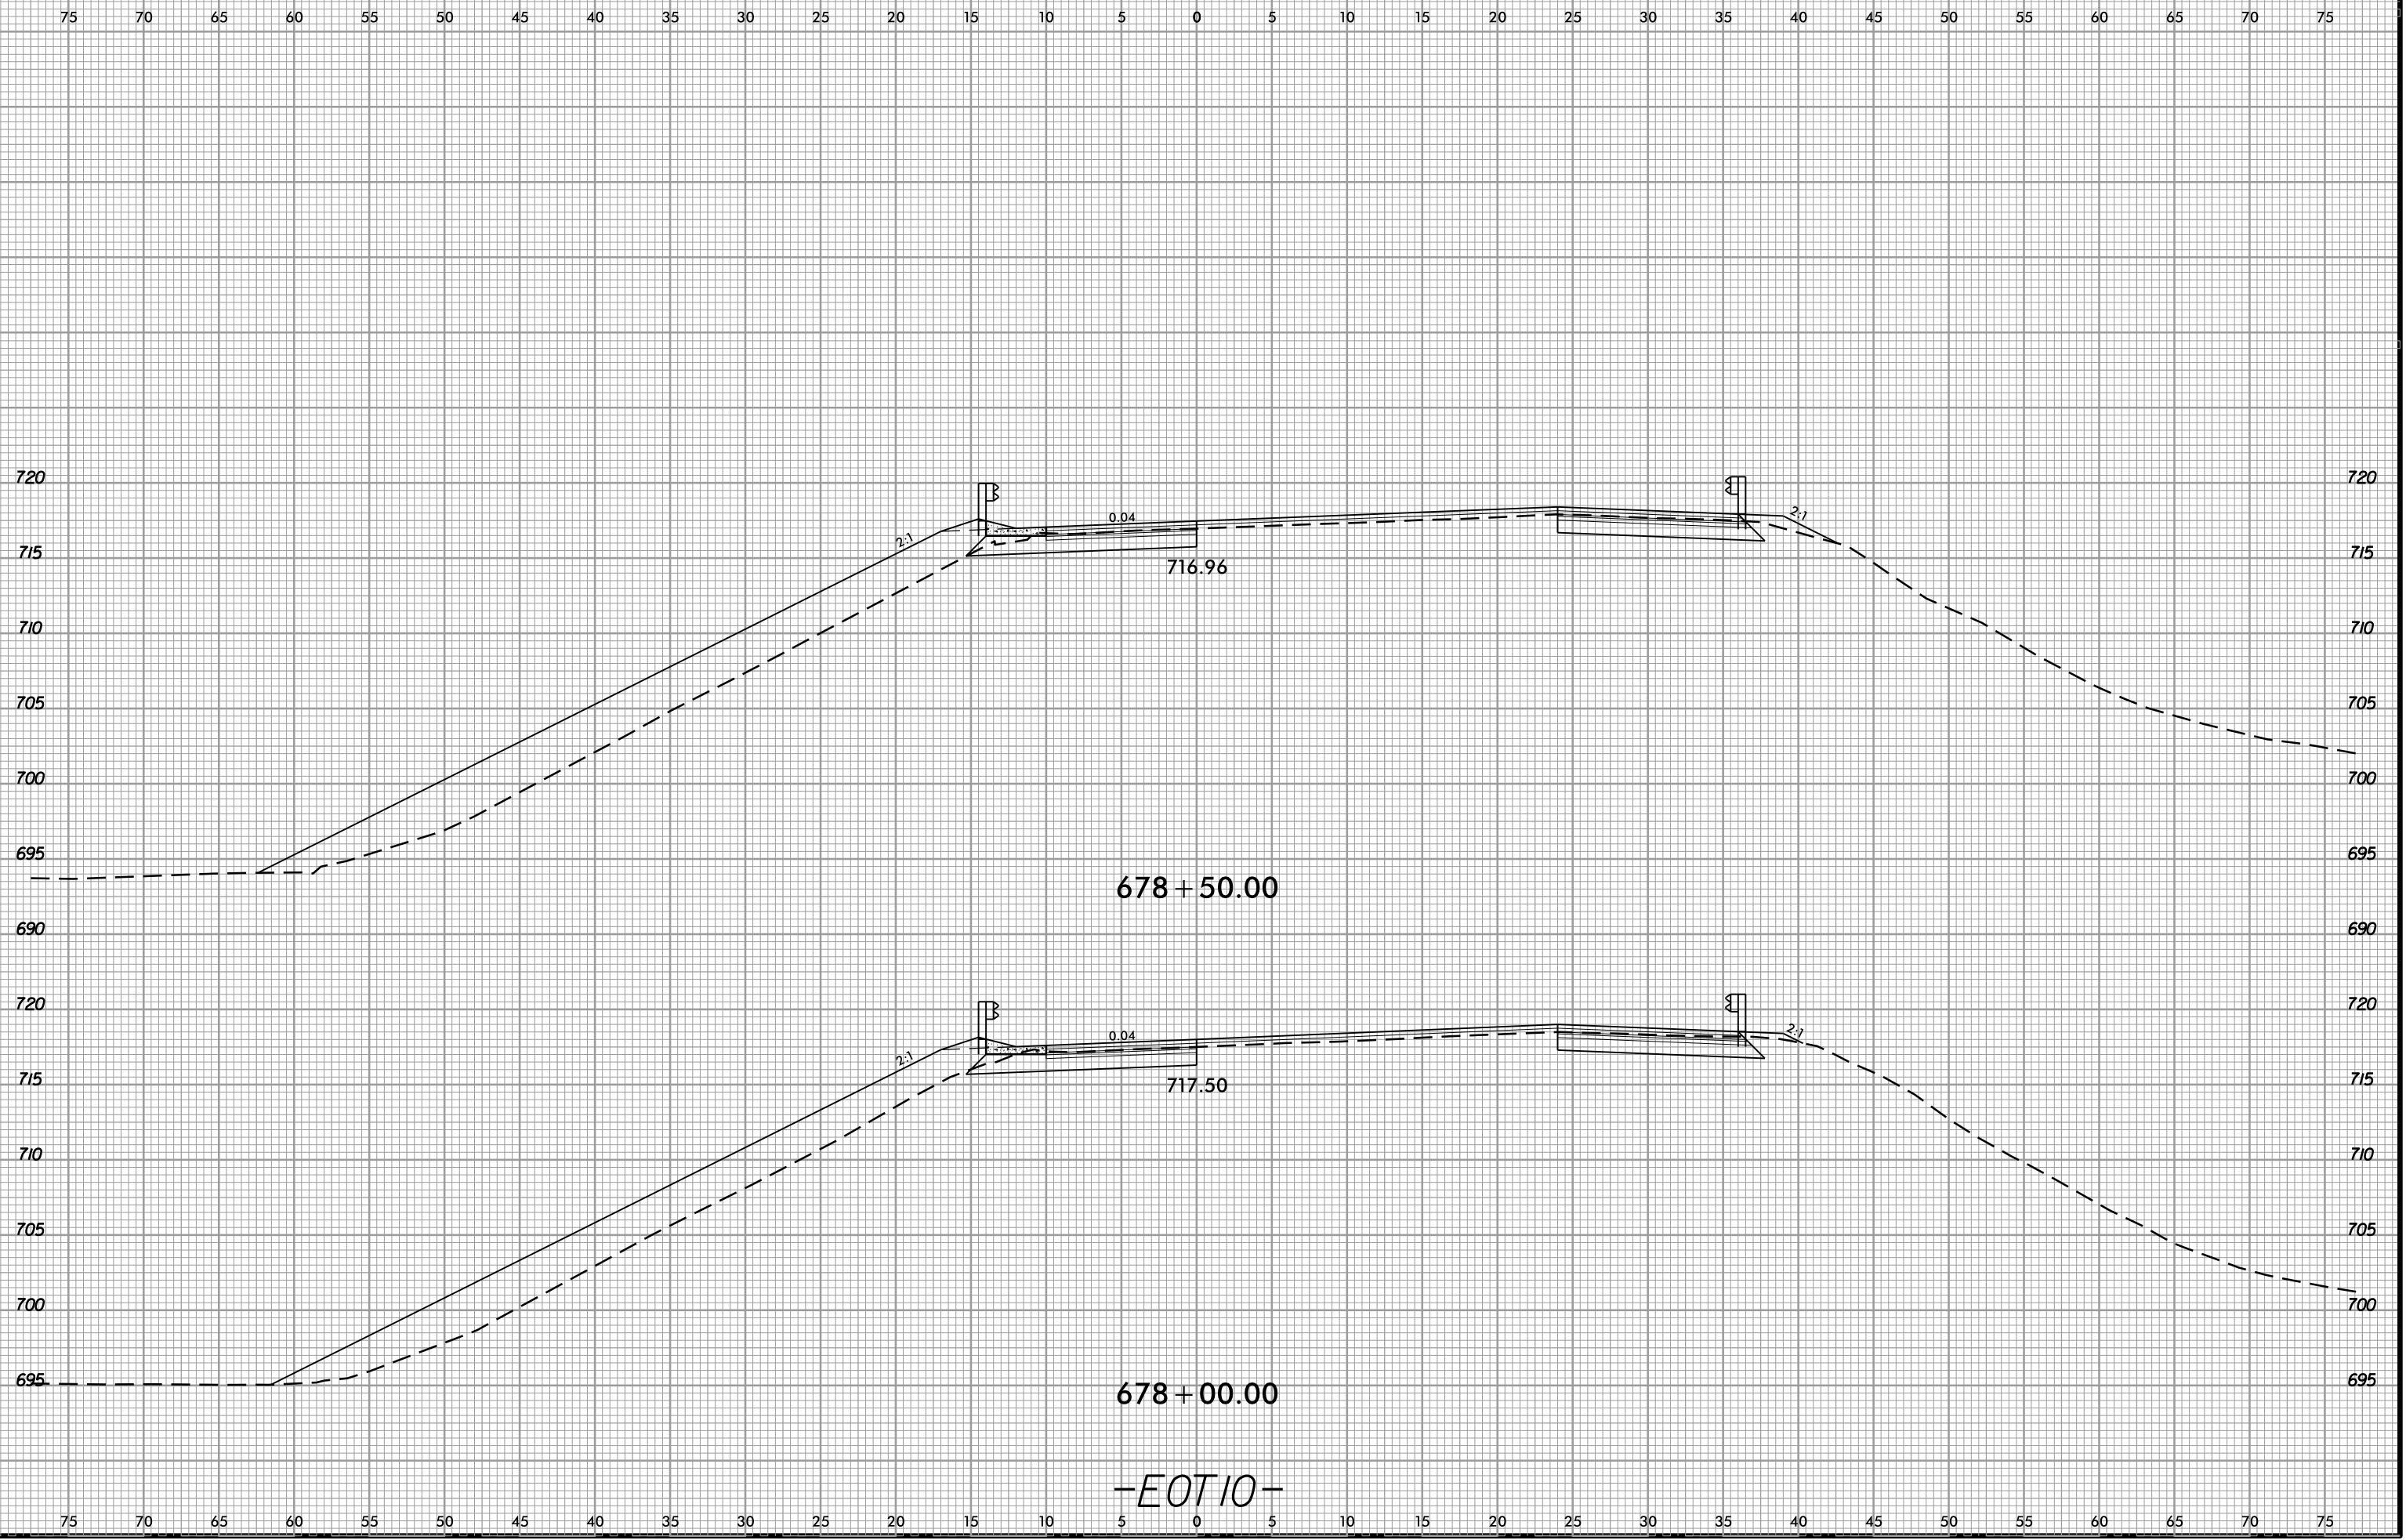


678 + 50.00


678 + 00.00

-EOT10-

02-NOV-2018 13:49  
S:\Project-Development\IP Projects\1-5823-140-Dave\Roadway\DesignFiles\5823.ddc.xpl.E0110.dgn  
Mike@ion AT DIV@294550

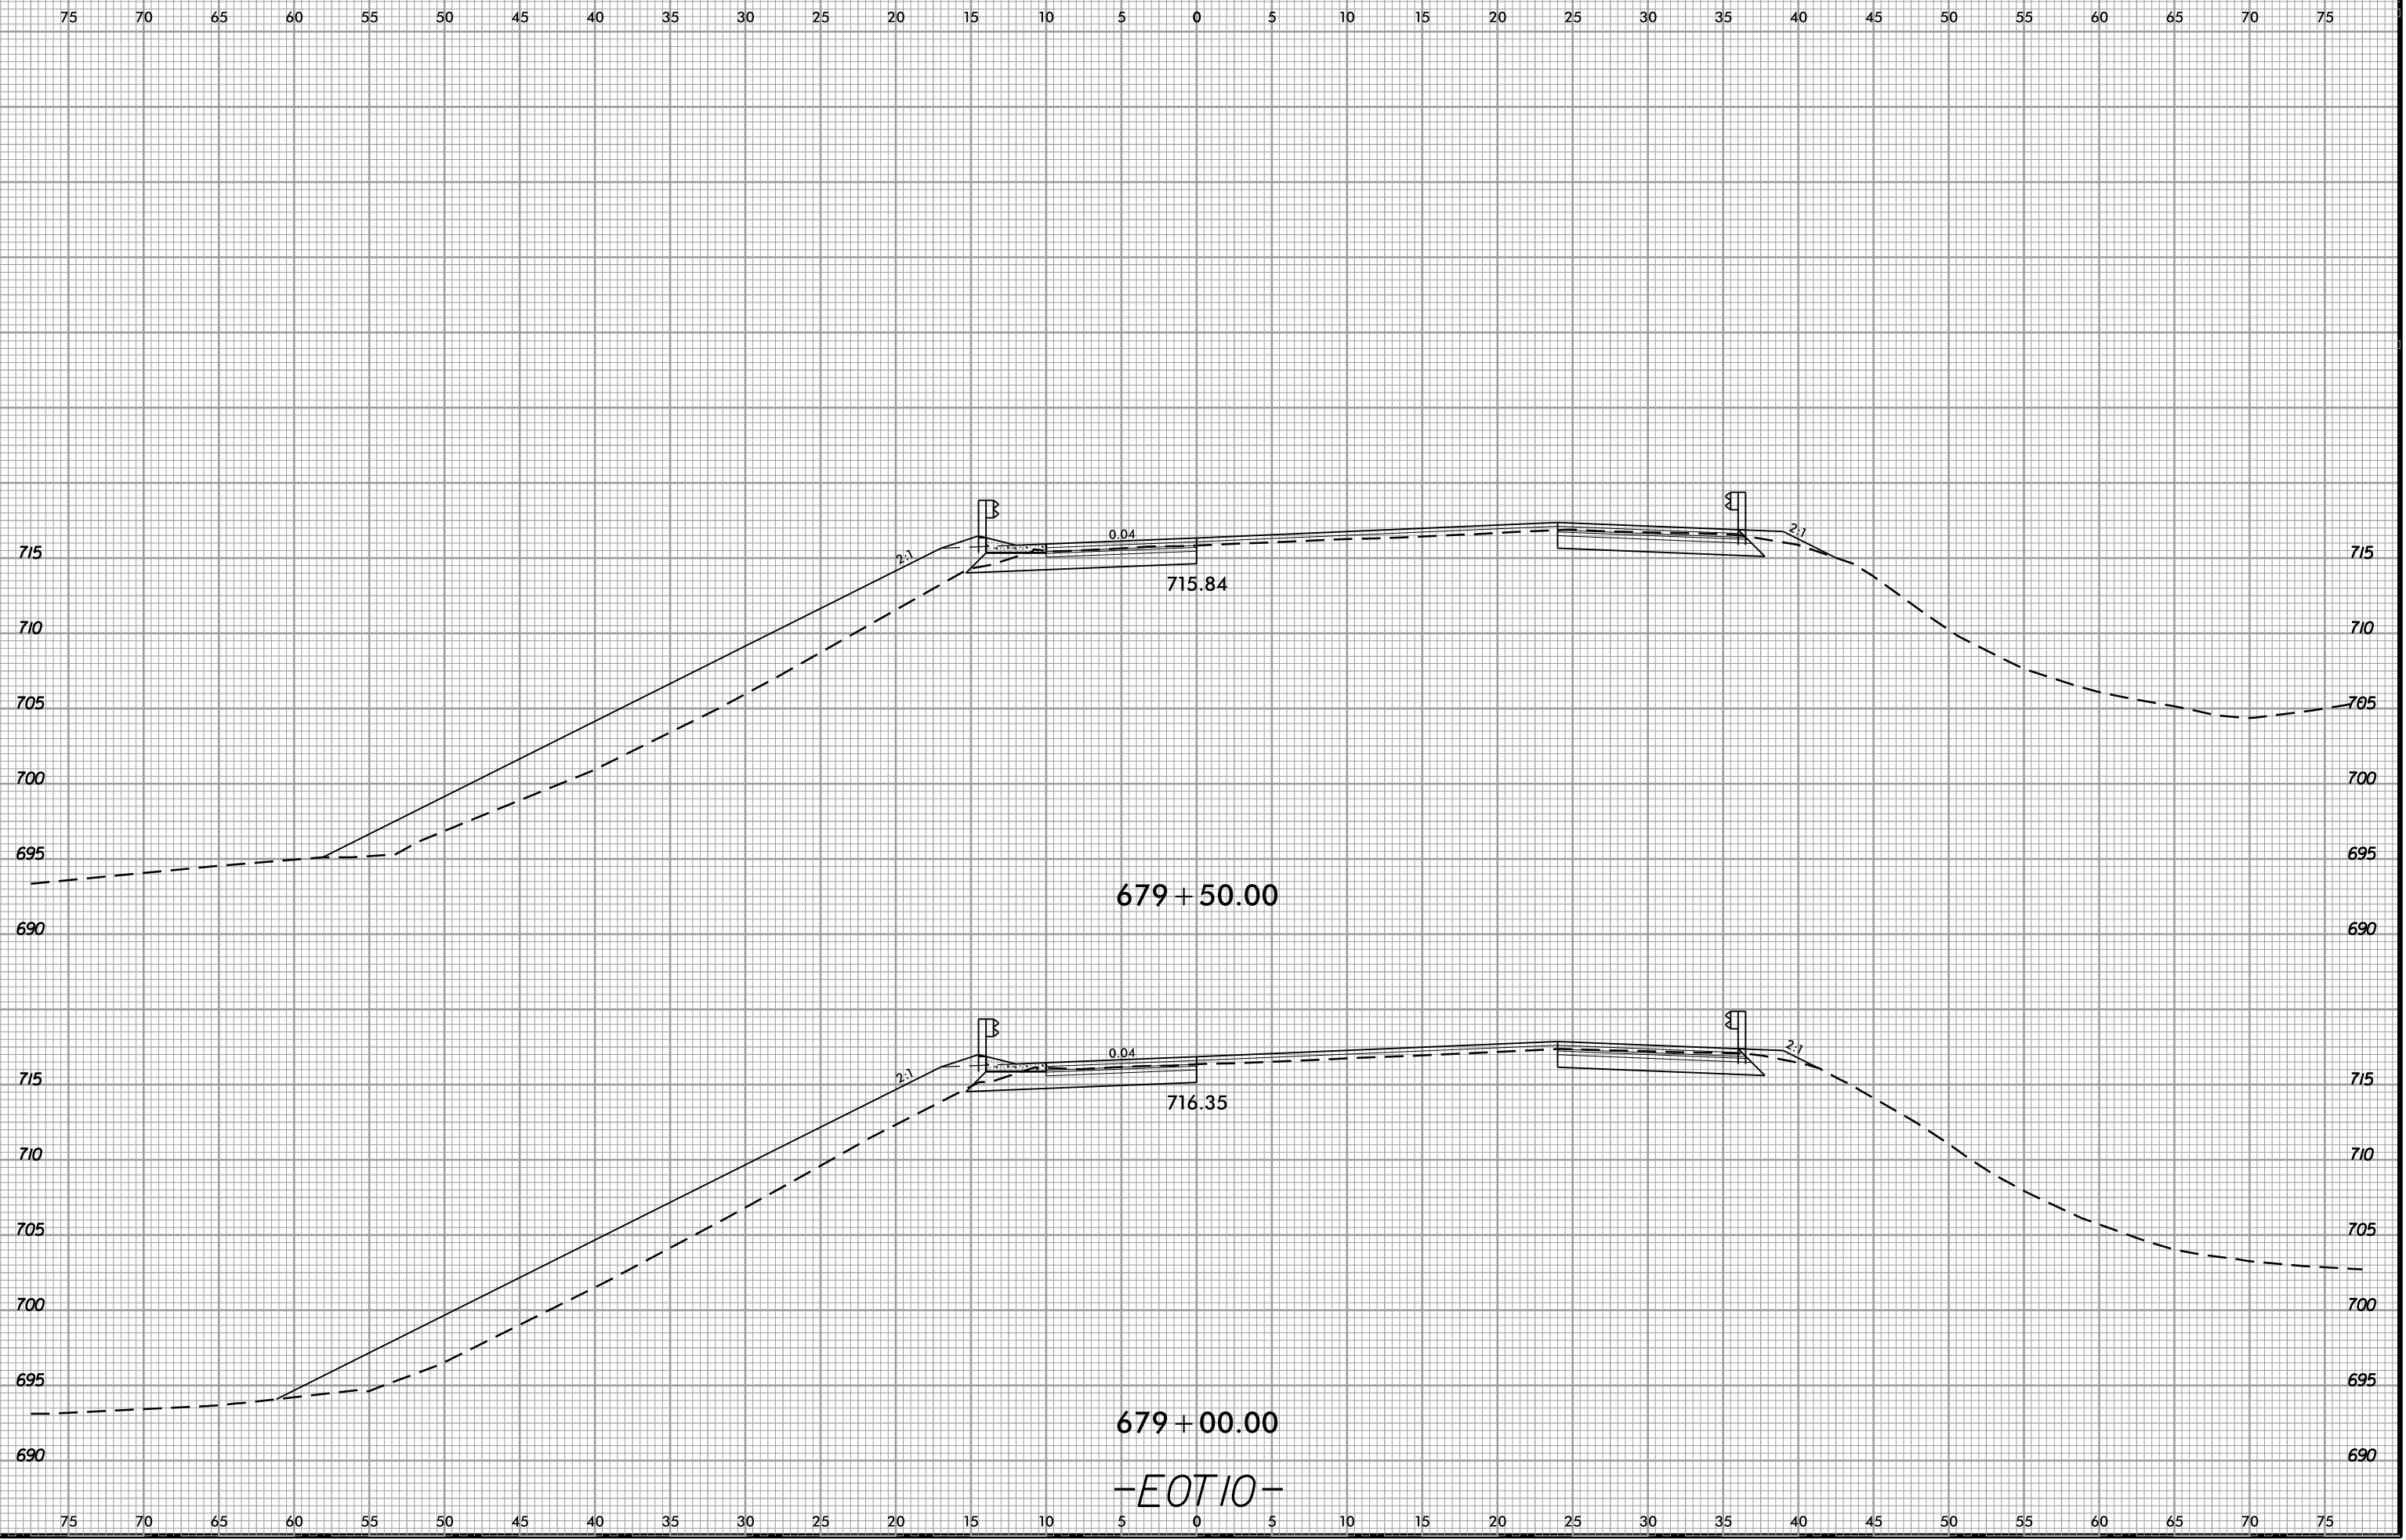


6/23/16  
02-NOV-2018 13:49  
S:\Projects-Development\IP Projects\1-5823-140-Dave Roadway\DesignFiles\5823.ddc.xpl.EOT10.dgn  
Mike  
AT DIV 29450

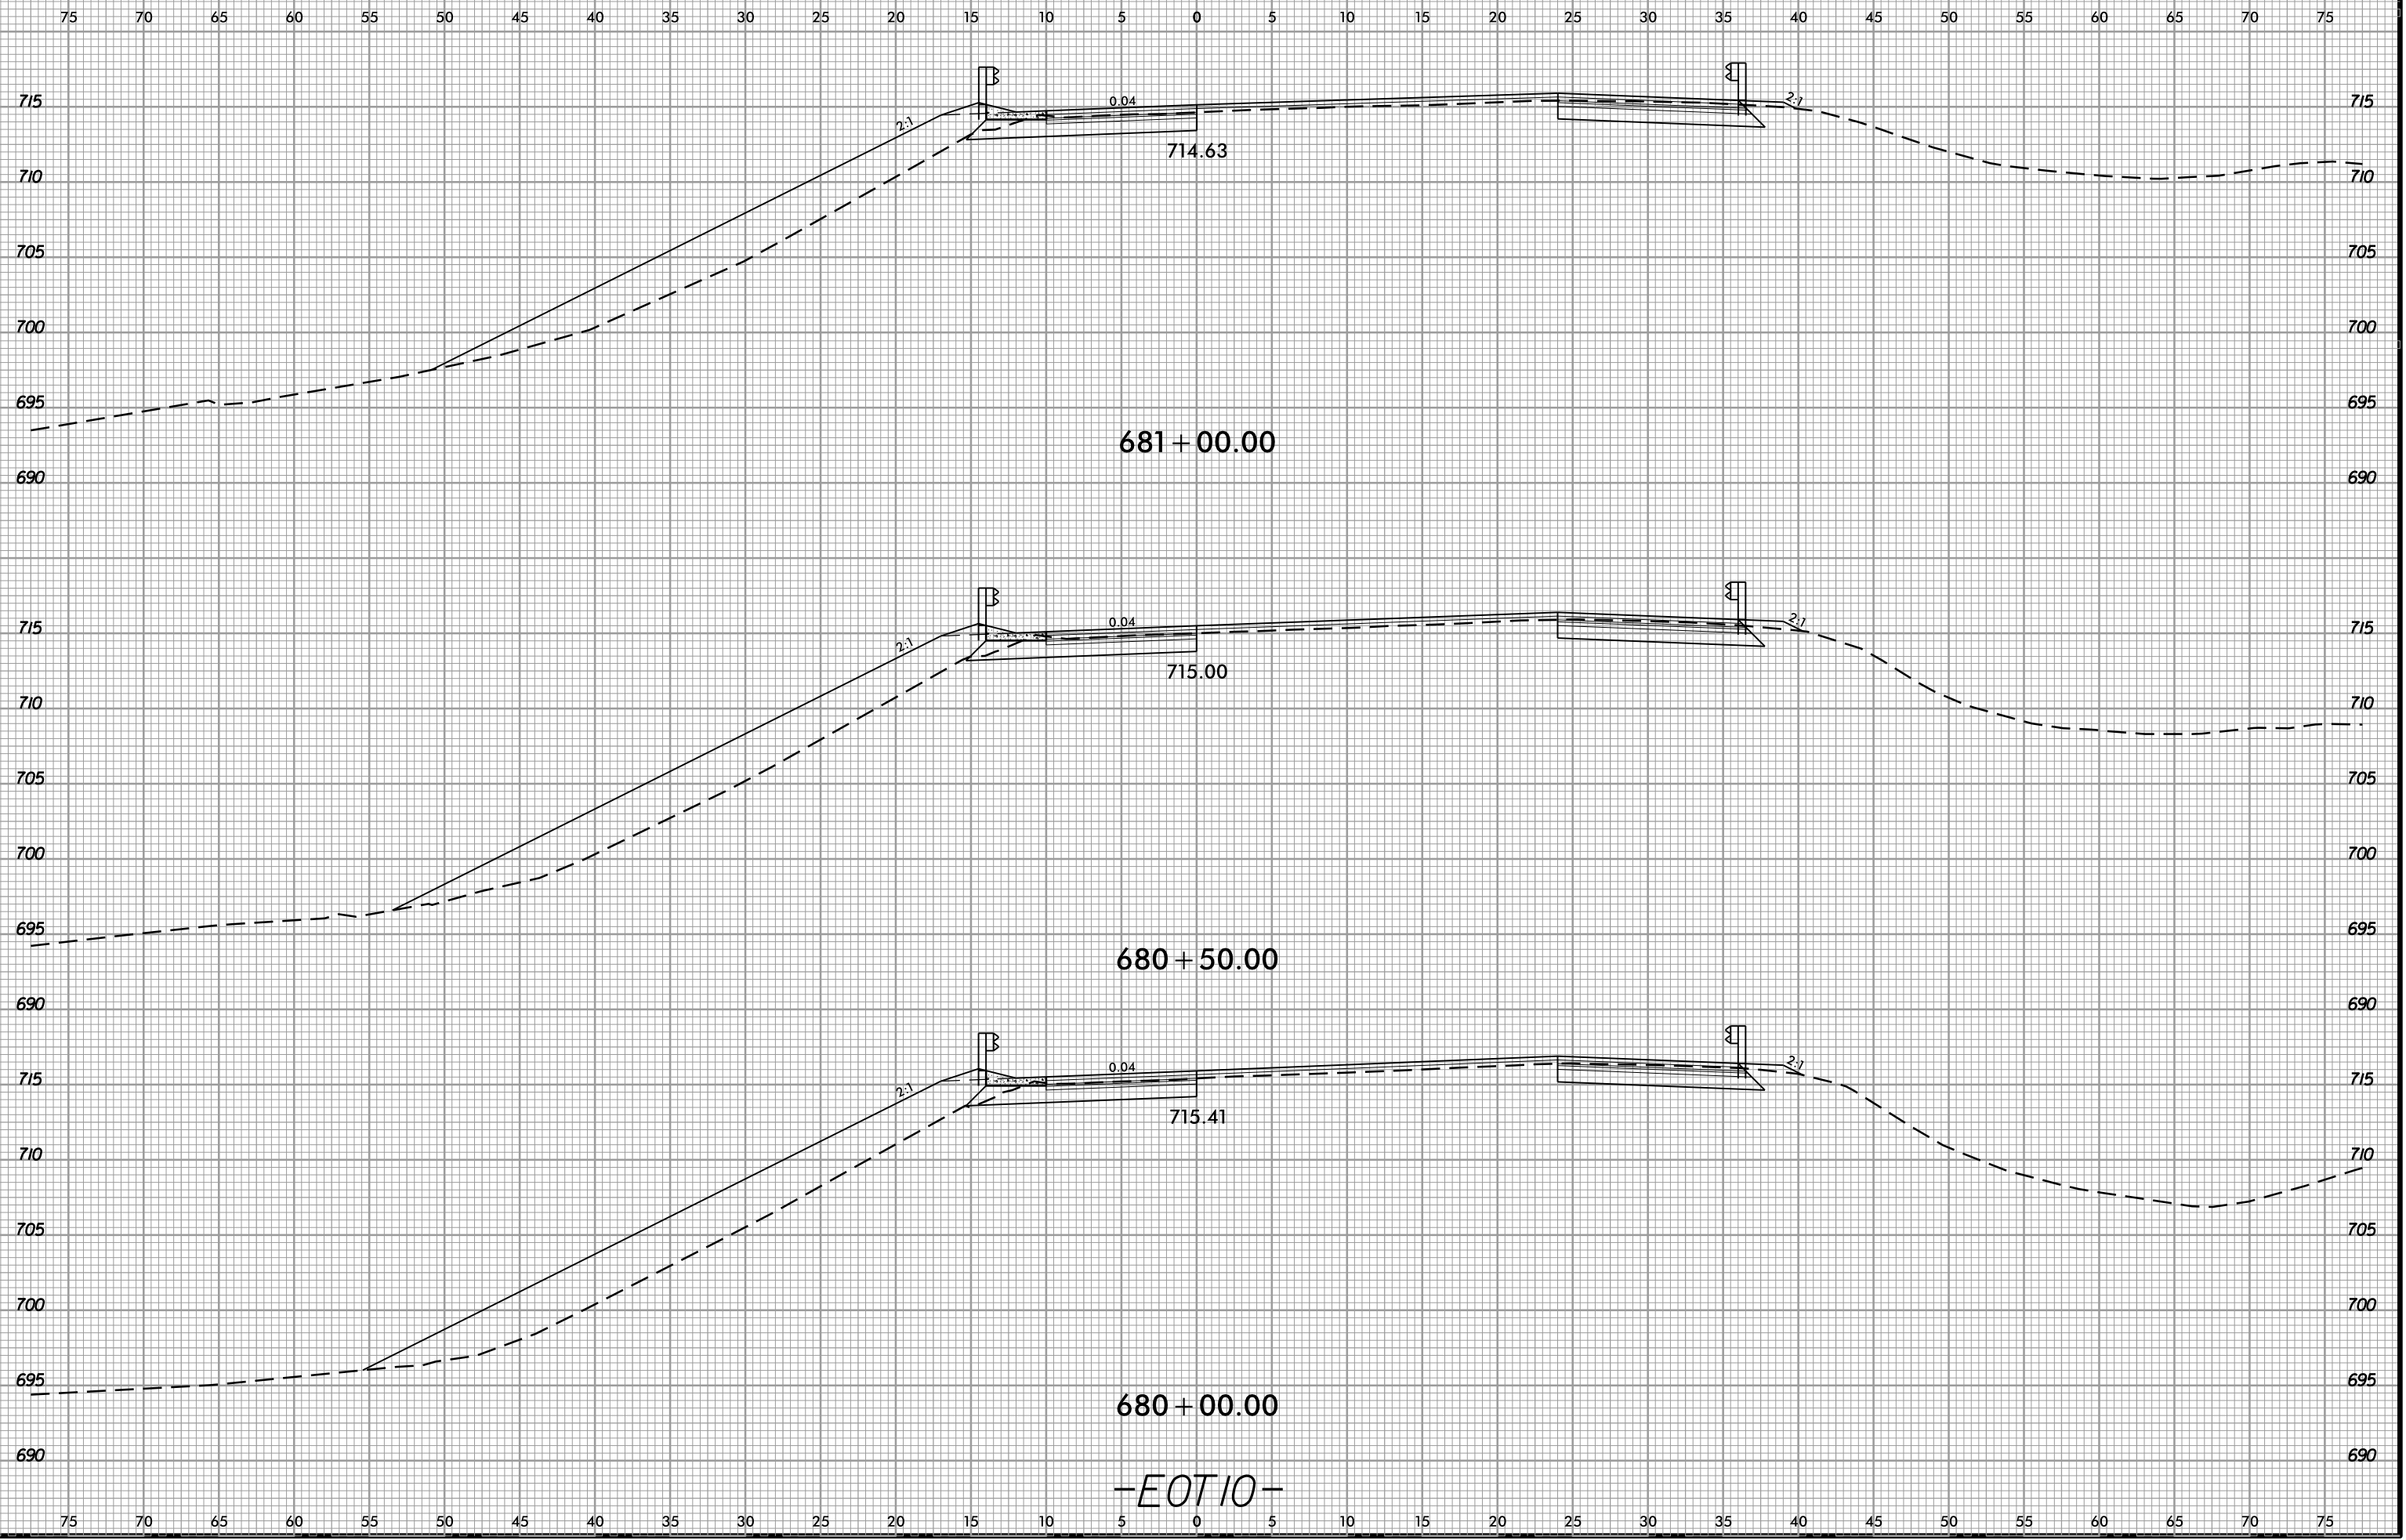







6/23/16  
02-NOV-2018 13:49  
S:\Project-Development\IP Projects\1-5823-140-Dave\Roadway\DesignFiles\5823.ddc.xpl.EOT10.dgn  
Mike@AT-DIV-29456

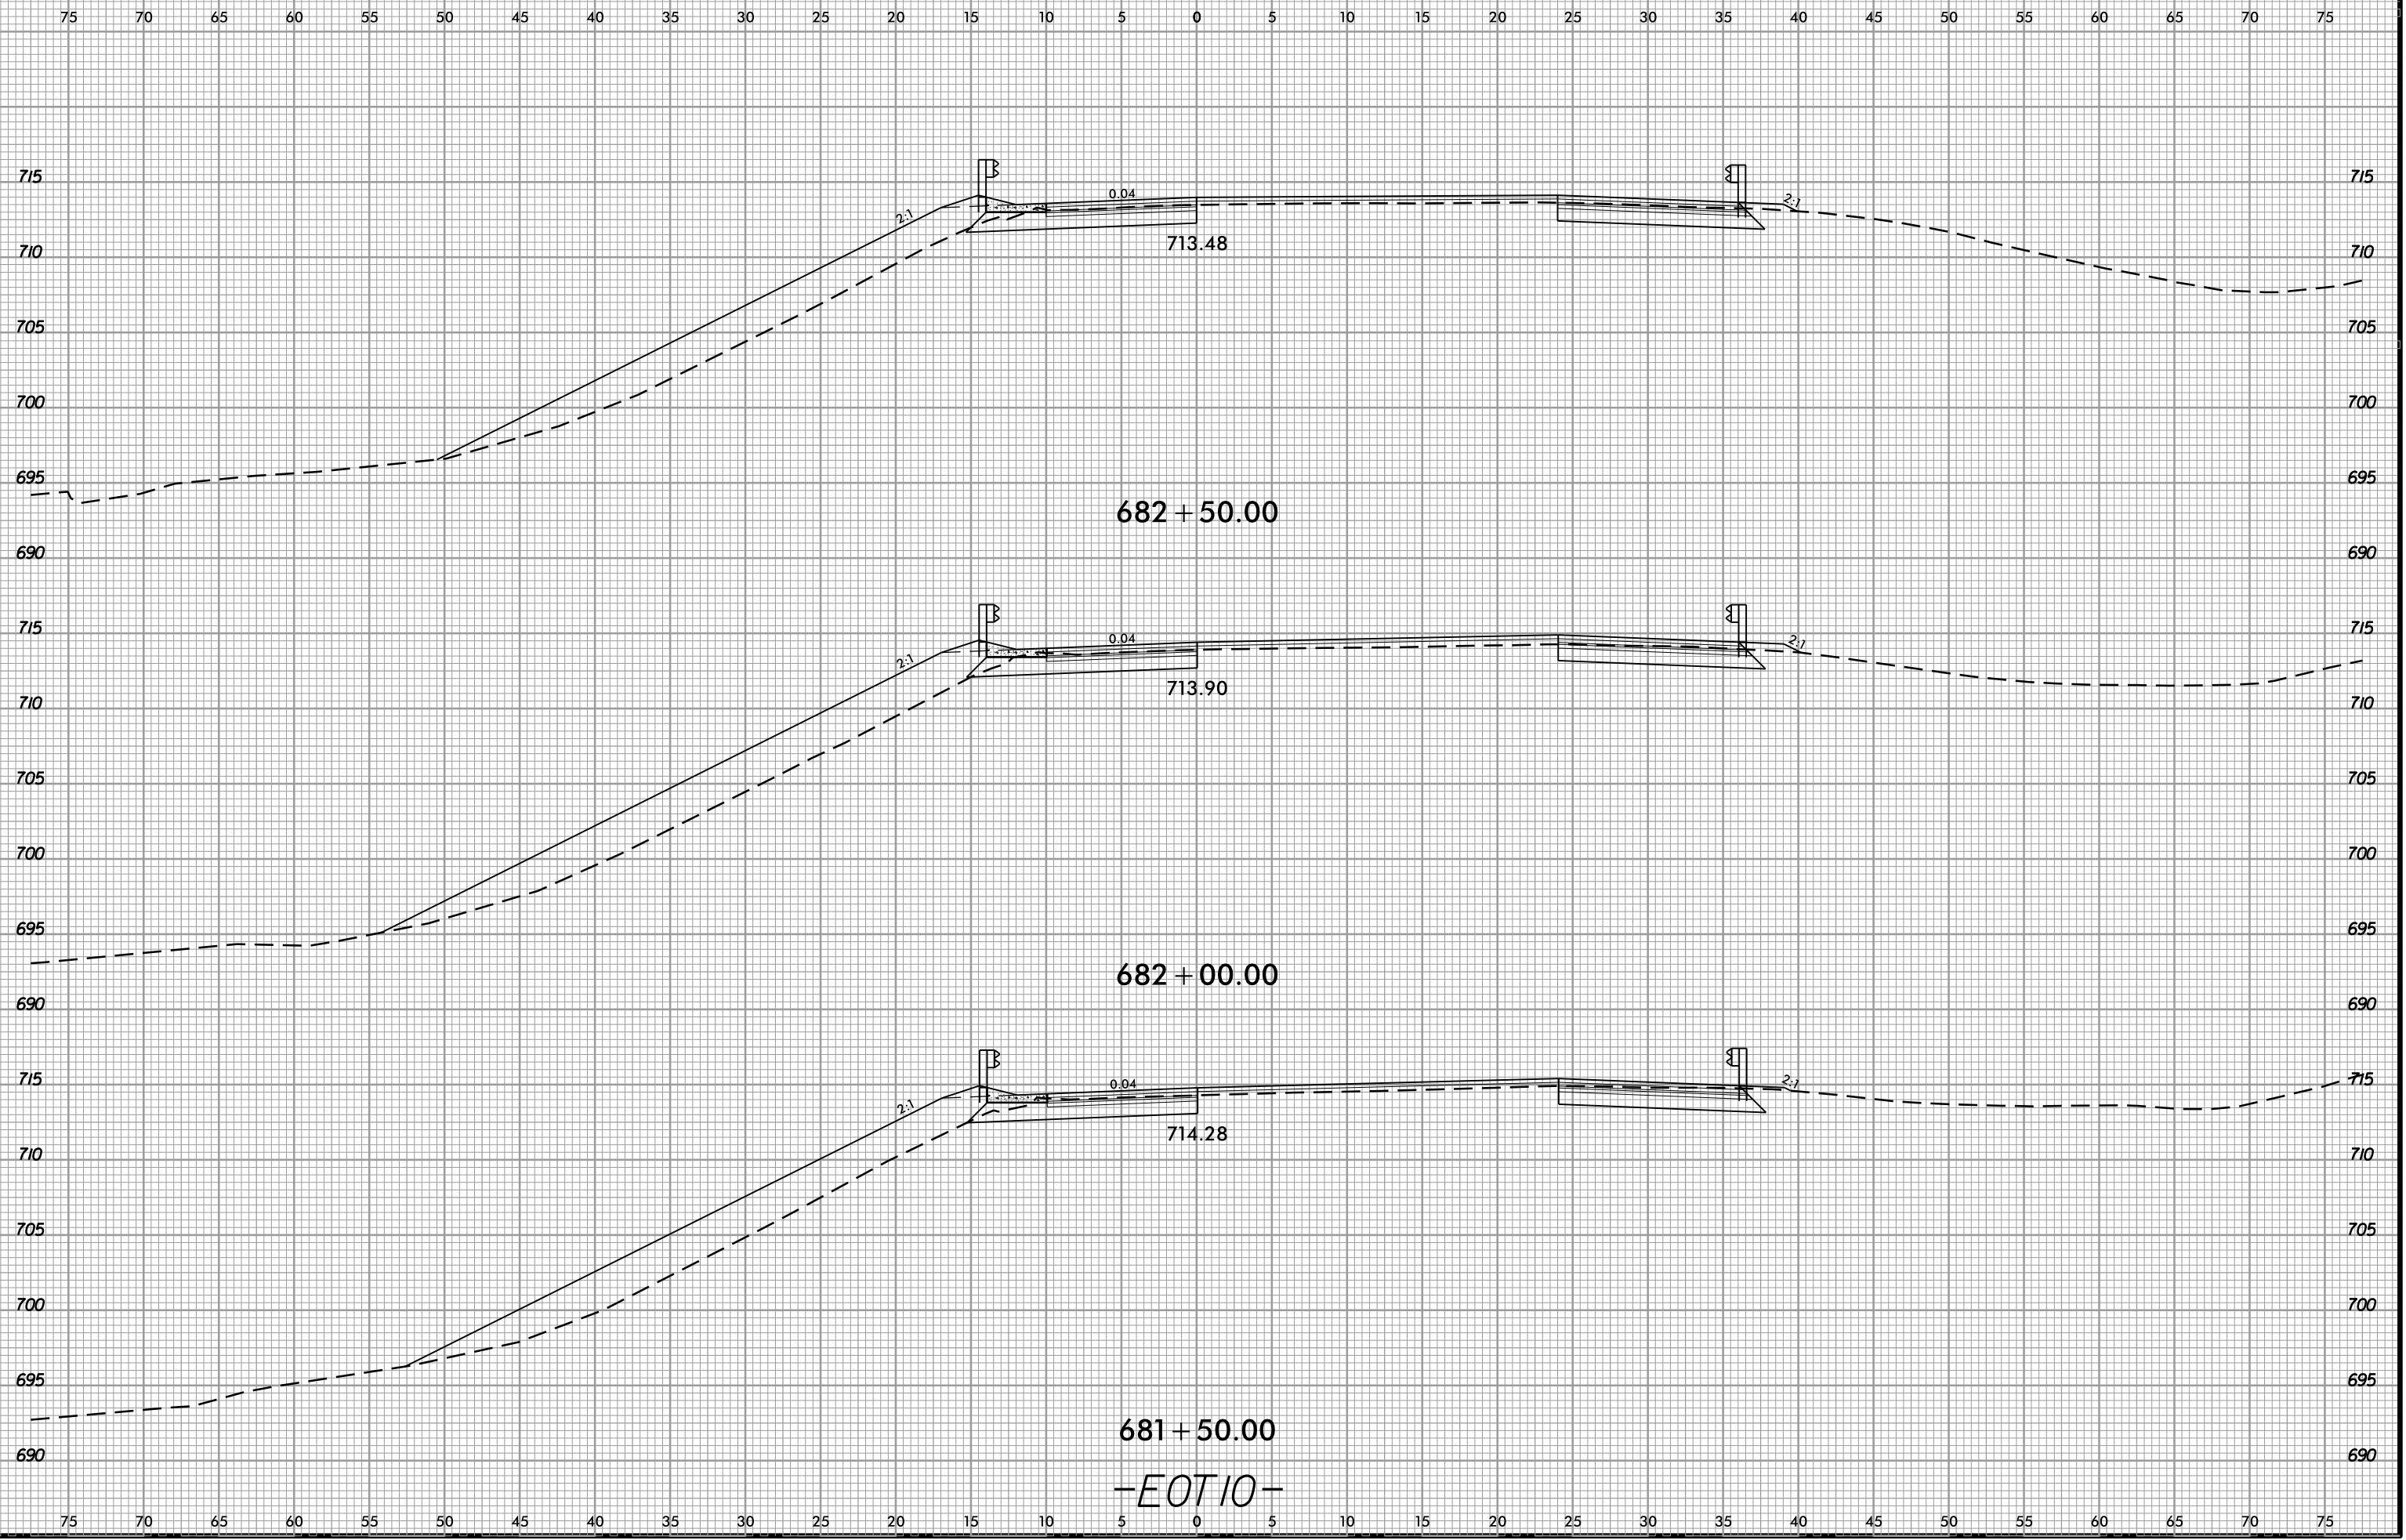

681+50.00  
-EOT10-

75 70 65 60 55 50 45 40 35 30 25 20 15 10 5 0 5 10 15 20 25 30 35 40 45 50 55 60 65 70 75

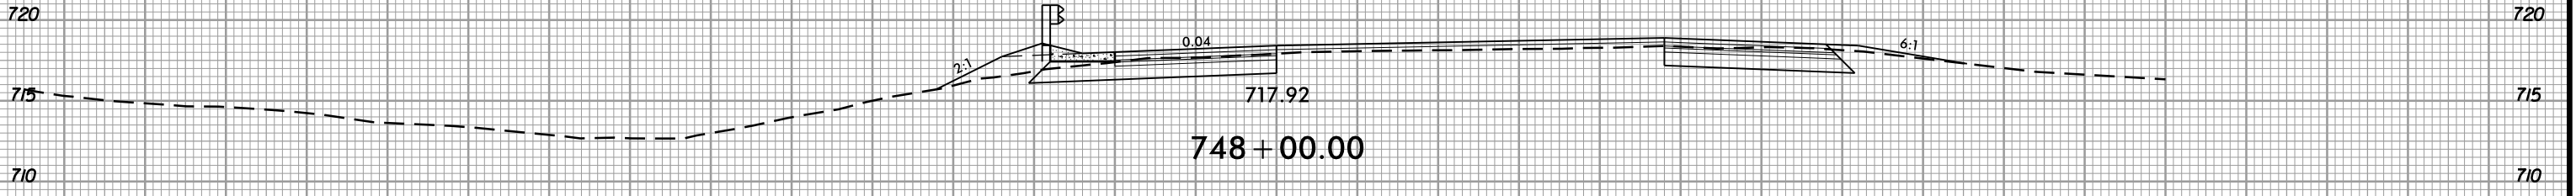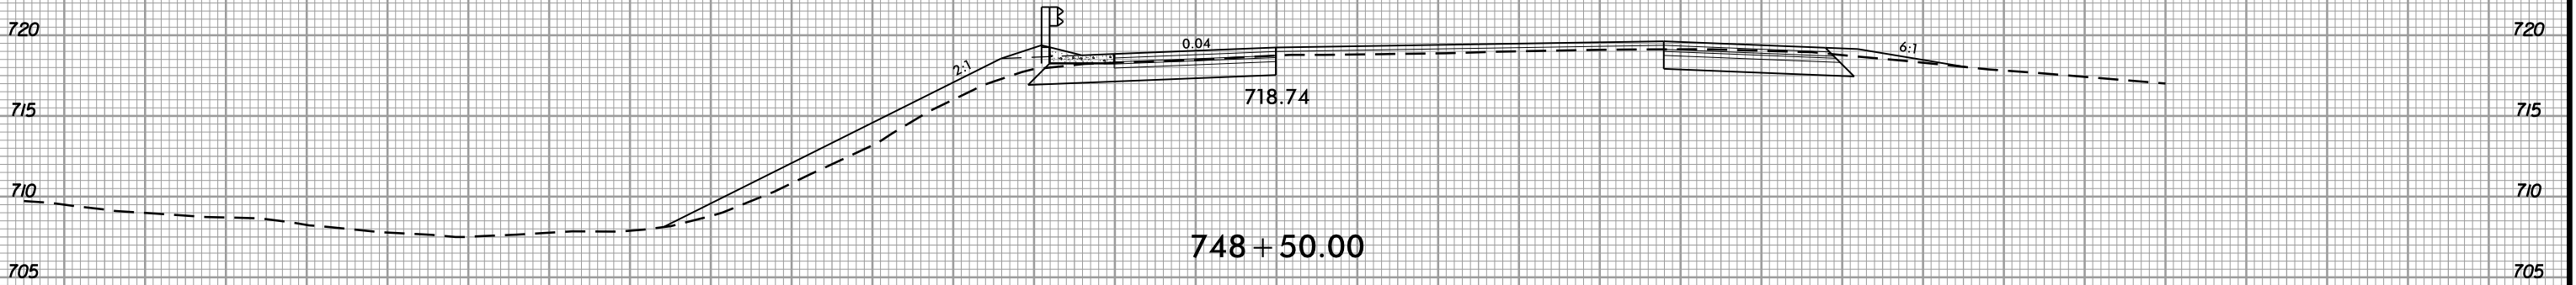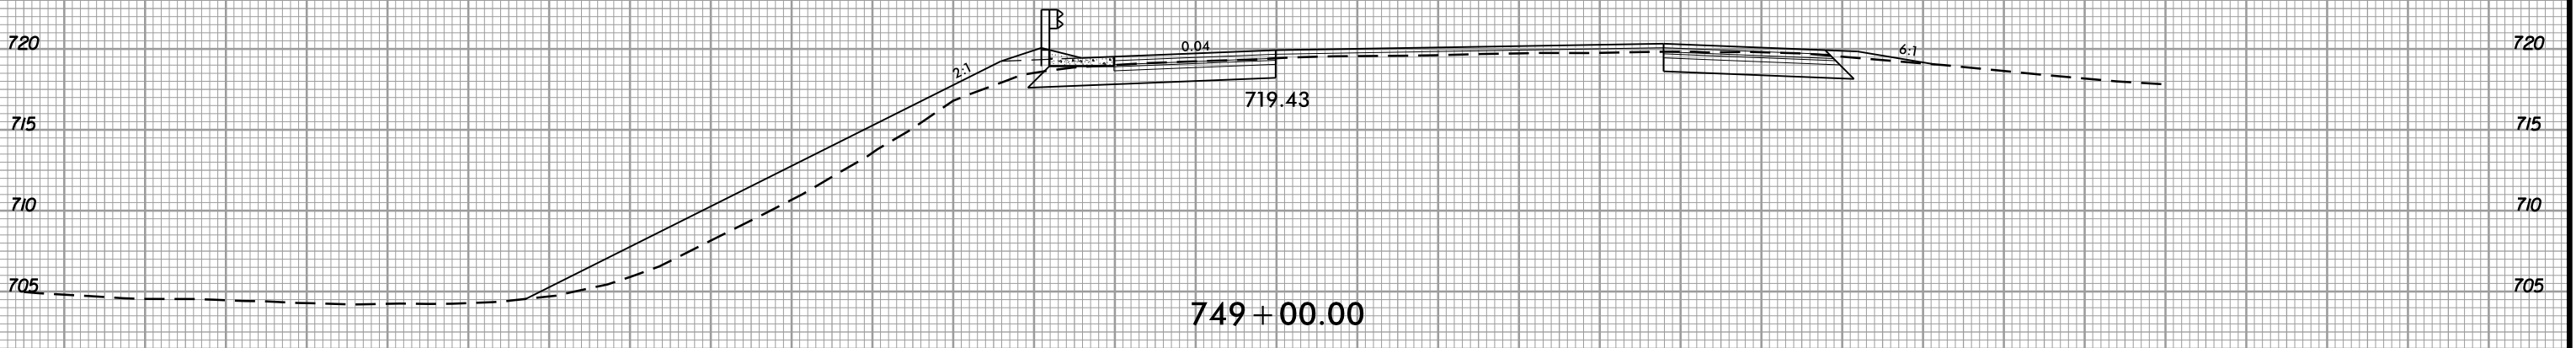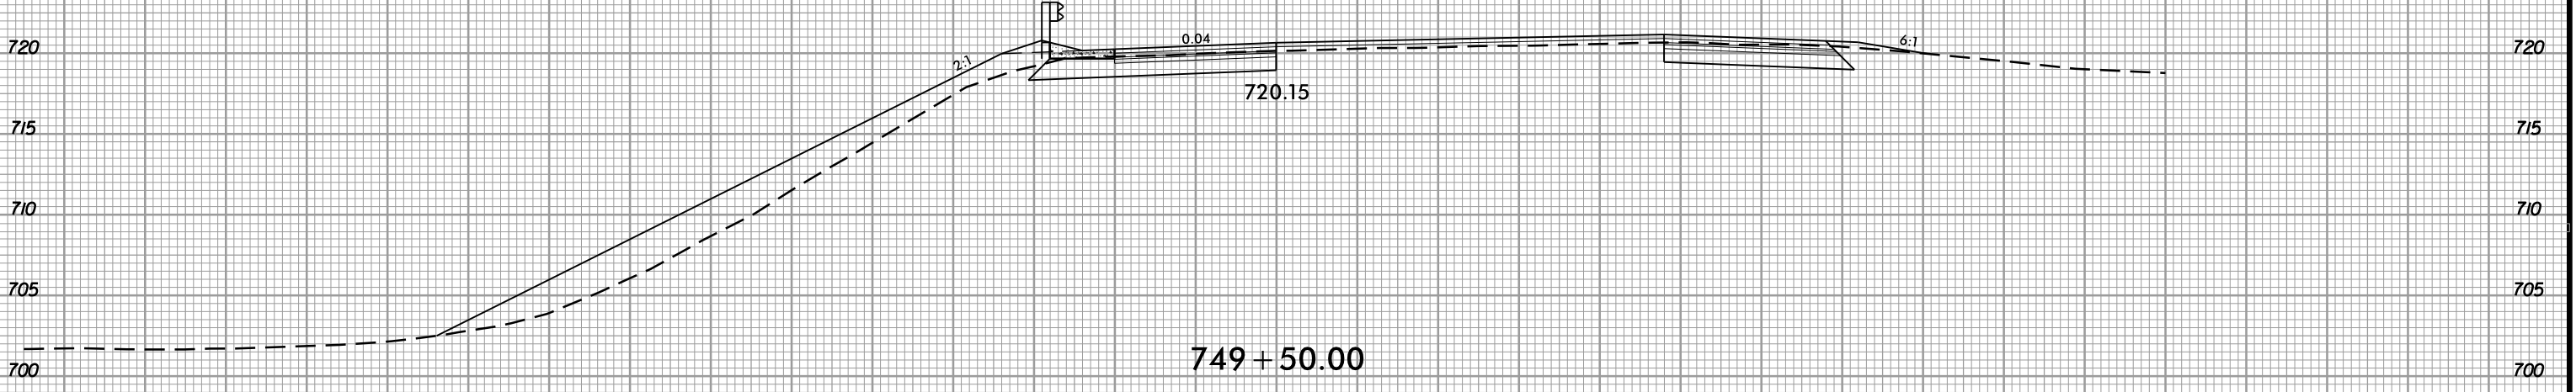

-EOTII-

75 70 65 60 55 50 45 40 35 30 25 20 15 10 5 0 5 10 15 20 25 30 35 40 45 50 55 60 65 70 75


6/23/16



PROJ. REFERENCE NO.  
I-5823

SHEET NO.  
X-58

75 70 65 60 55 50 45 40 35 30 25 20 15 10 5 0 5 10 15 20 25 30 35 40 45 50 55 60 65 70 75

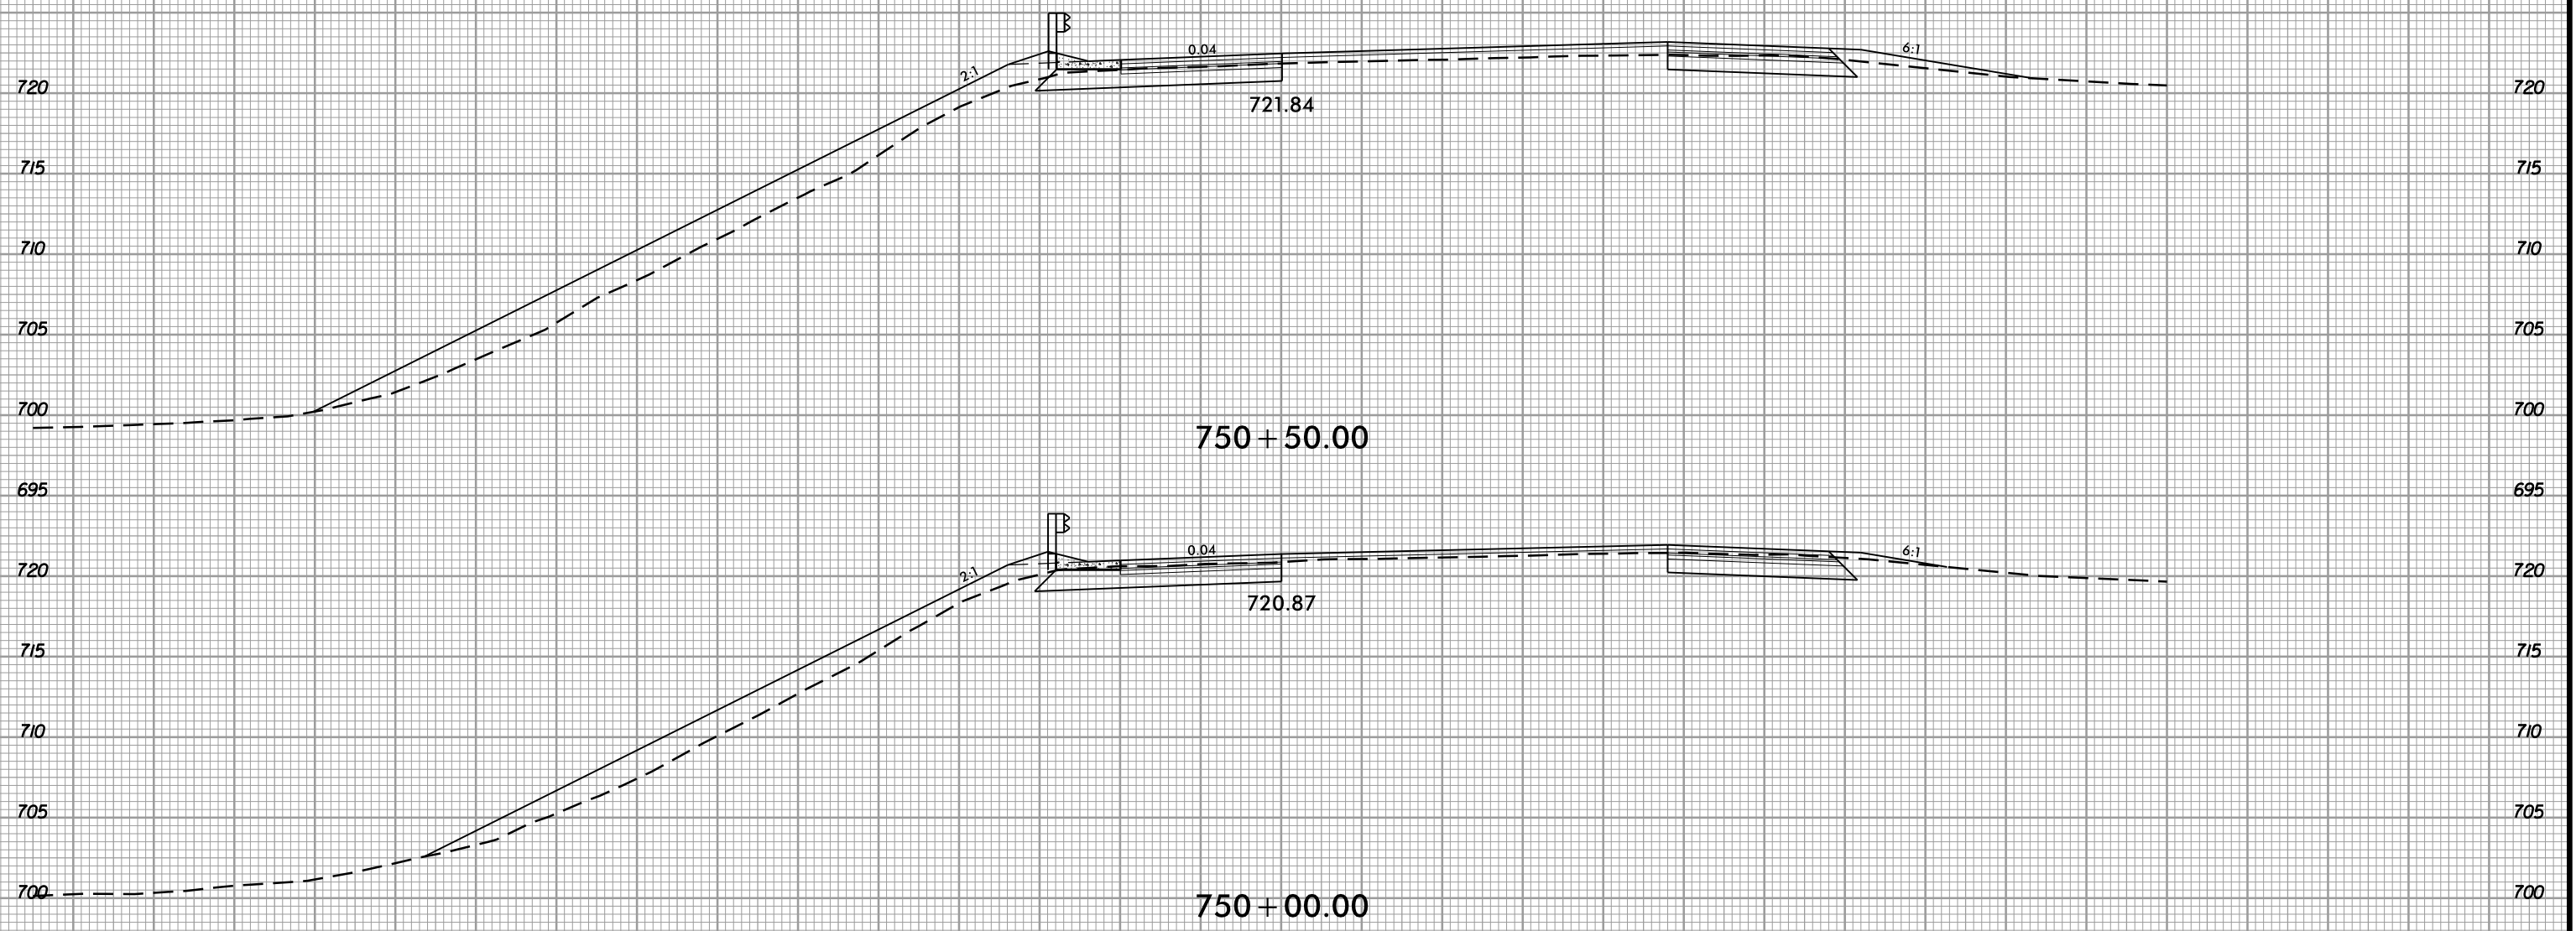


-EOTII-


75 70 65 60 55 50 45 40 35 30 25 20 15 10 5 0 5 10 15 20 25 30 35 40 45 50 55 60 65 70 75

02-NOV-2018 13:49  
 S:\Projects-Development\IP Projects\I-5823-140-Dave\Roadway\DesignFiles\5823.ddc.xpl.EOTII.dgn  
 I:\Users\AT\Documents\AT\DIV9-294550


02-NOV-2018 13:49  
S:\Project-Development\IP Projects\1-5823-140-Dave\Roadway\DesignFiles\5823.ddc.xpl.EOT11.dgn  
AT DIV 29450

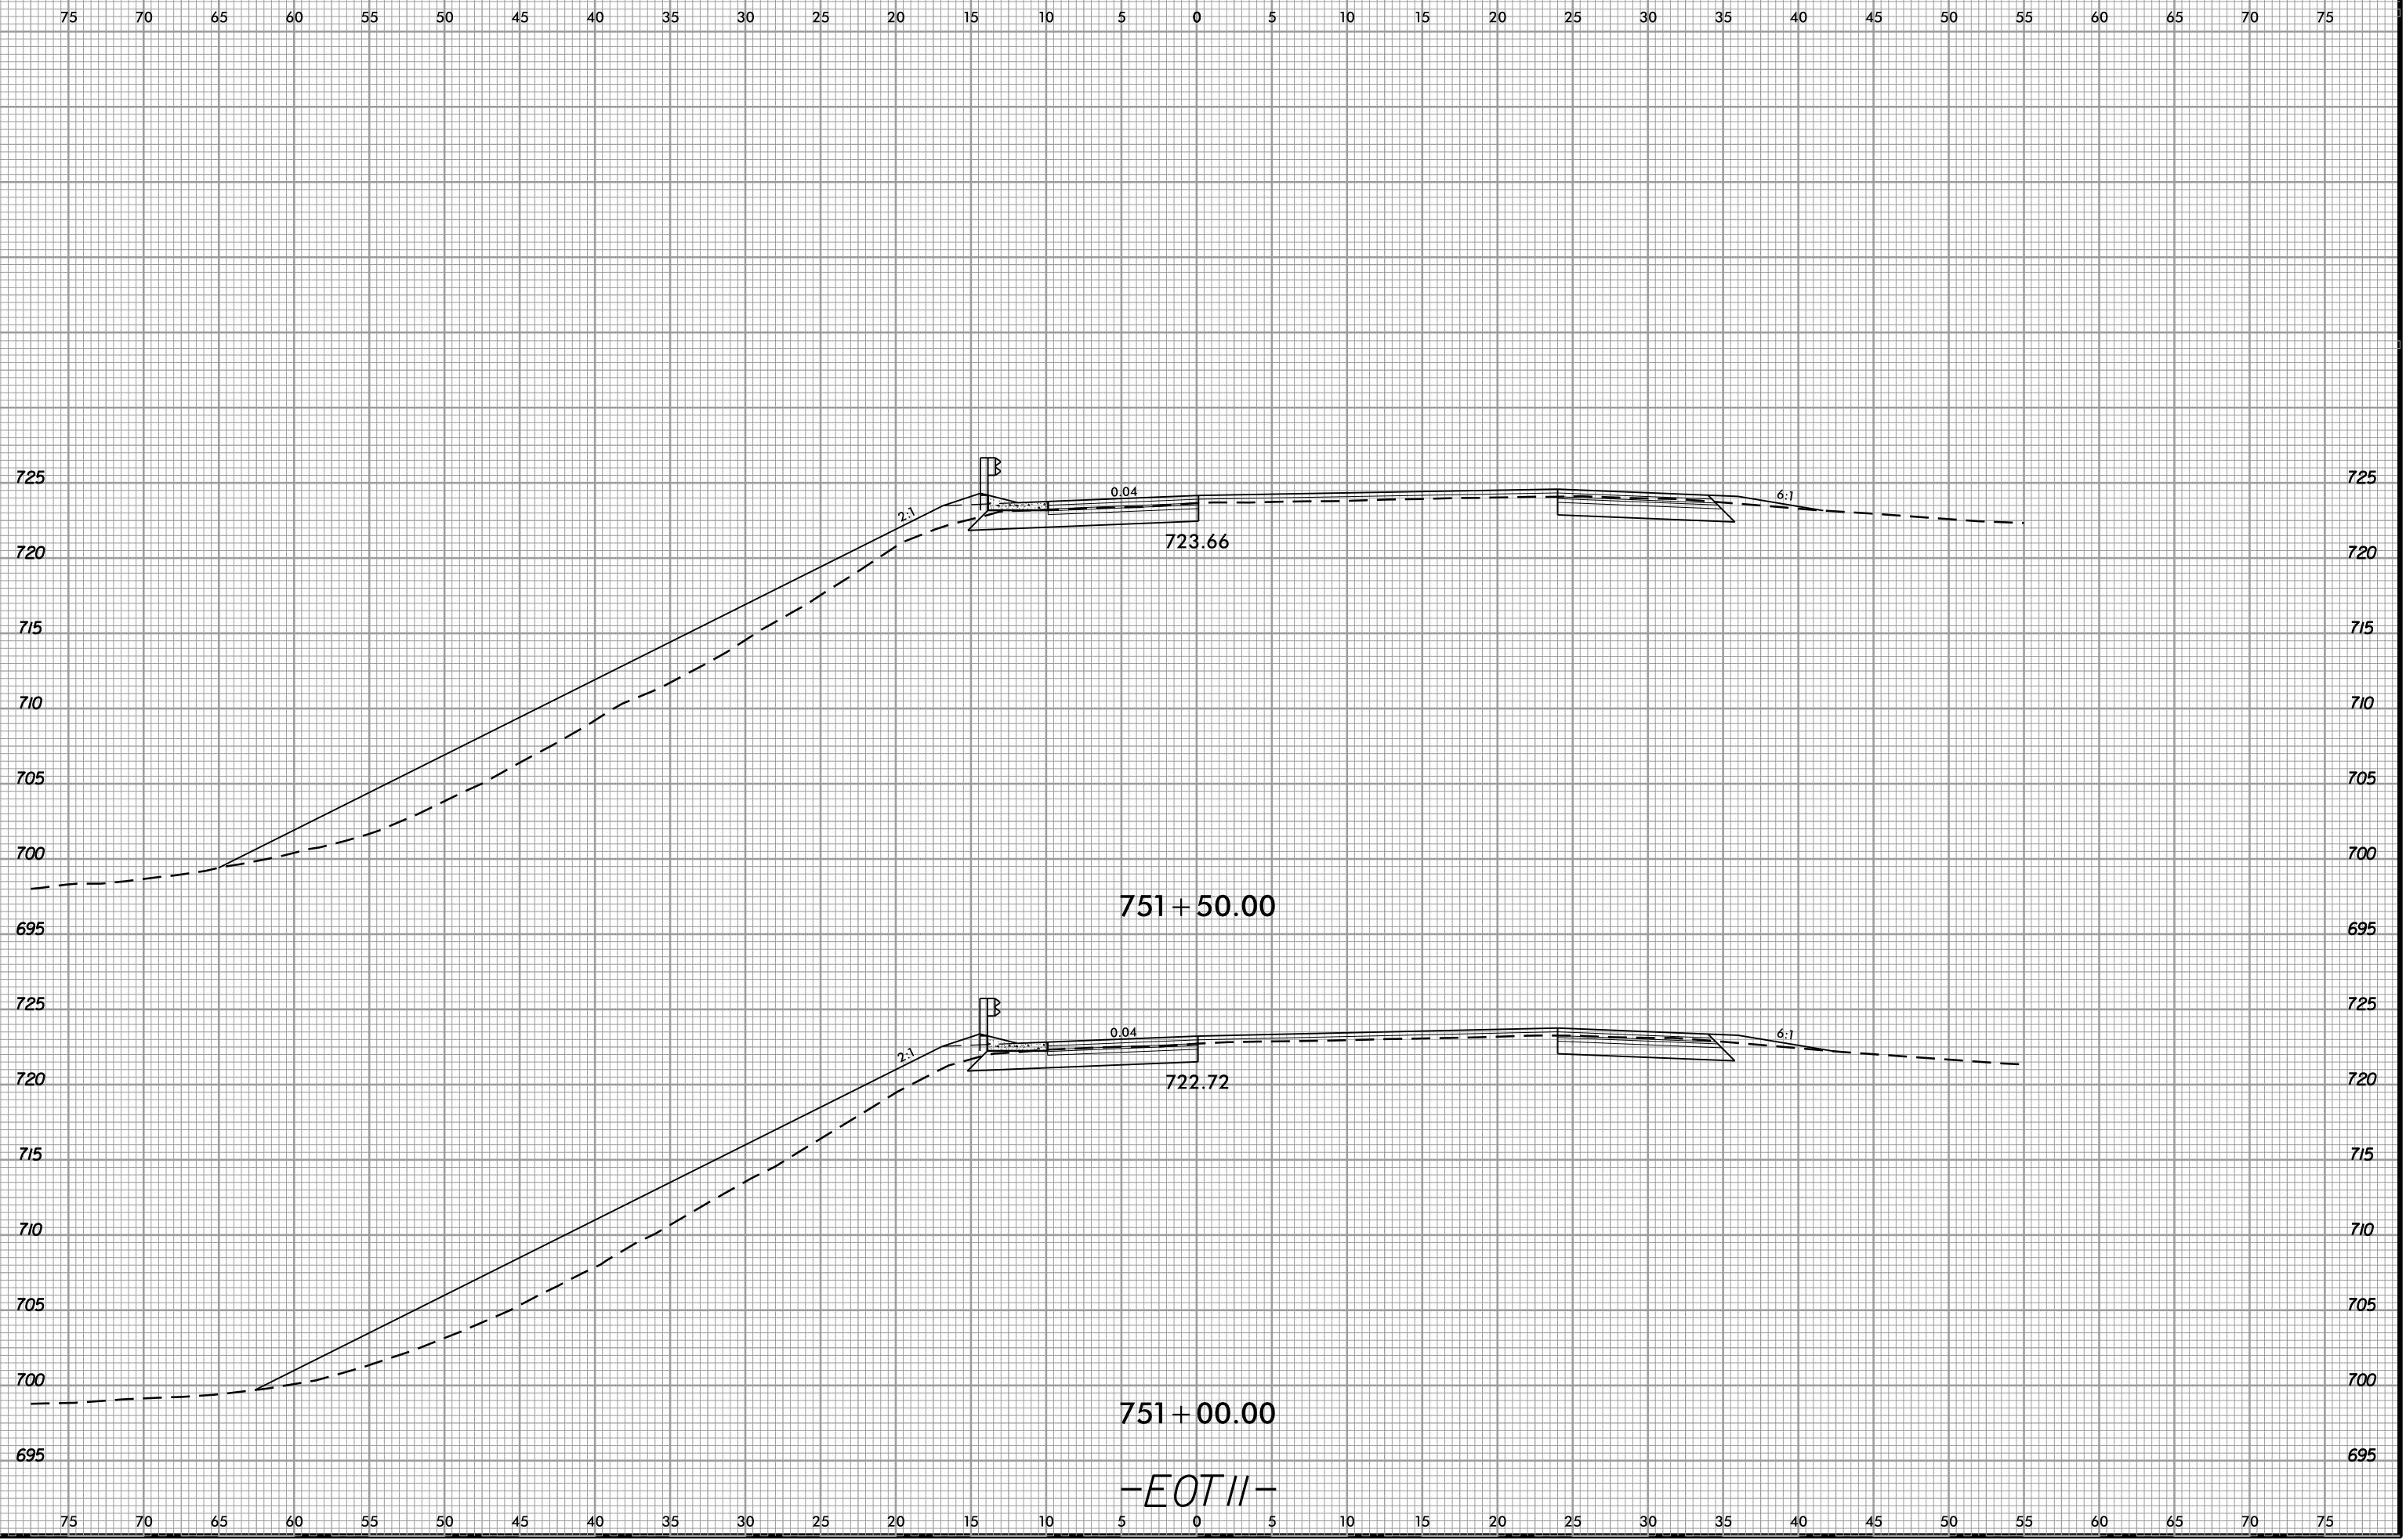

6/23/16  
02-NOV-2018 13:49  
S:\Projects-Development\11-5823-140-Dave\Roadway\DesignFiles\5823.dwg - xpl.EOT11.dgn  
AT DIV 2 450

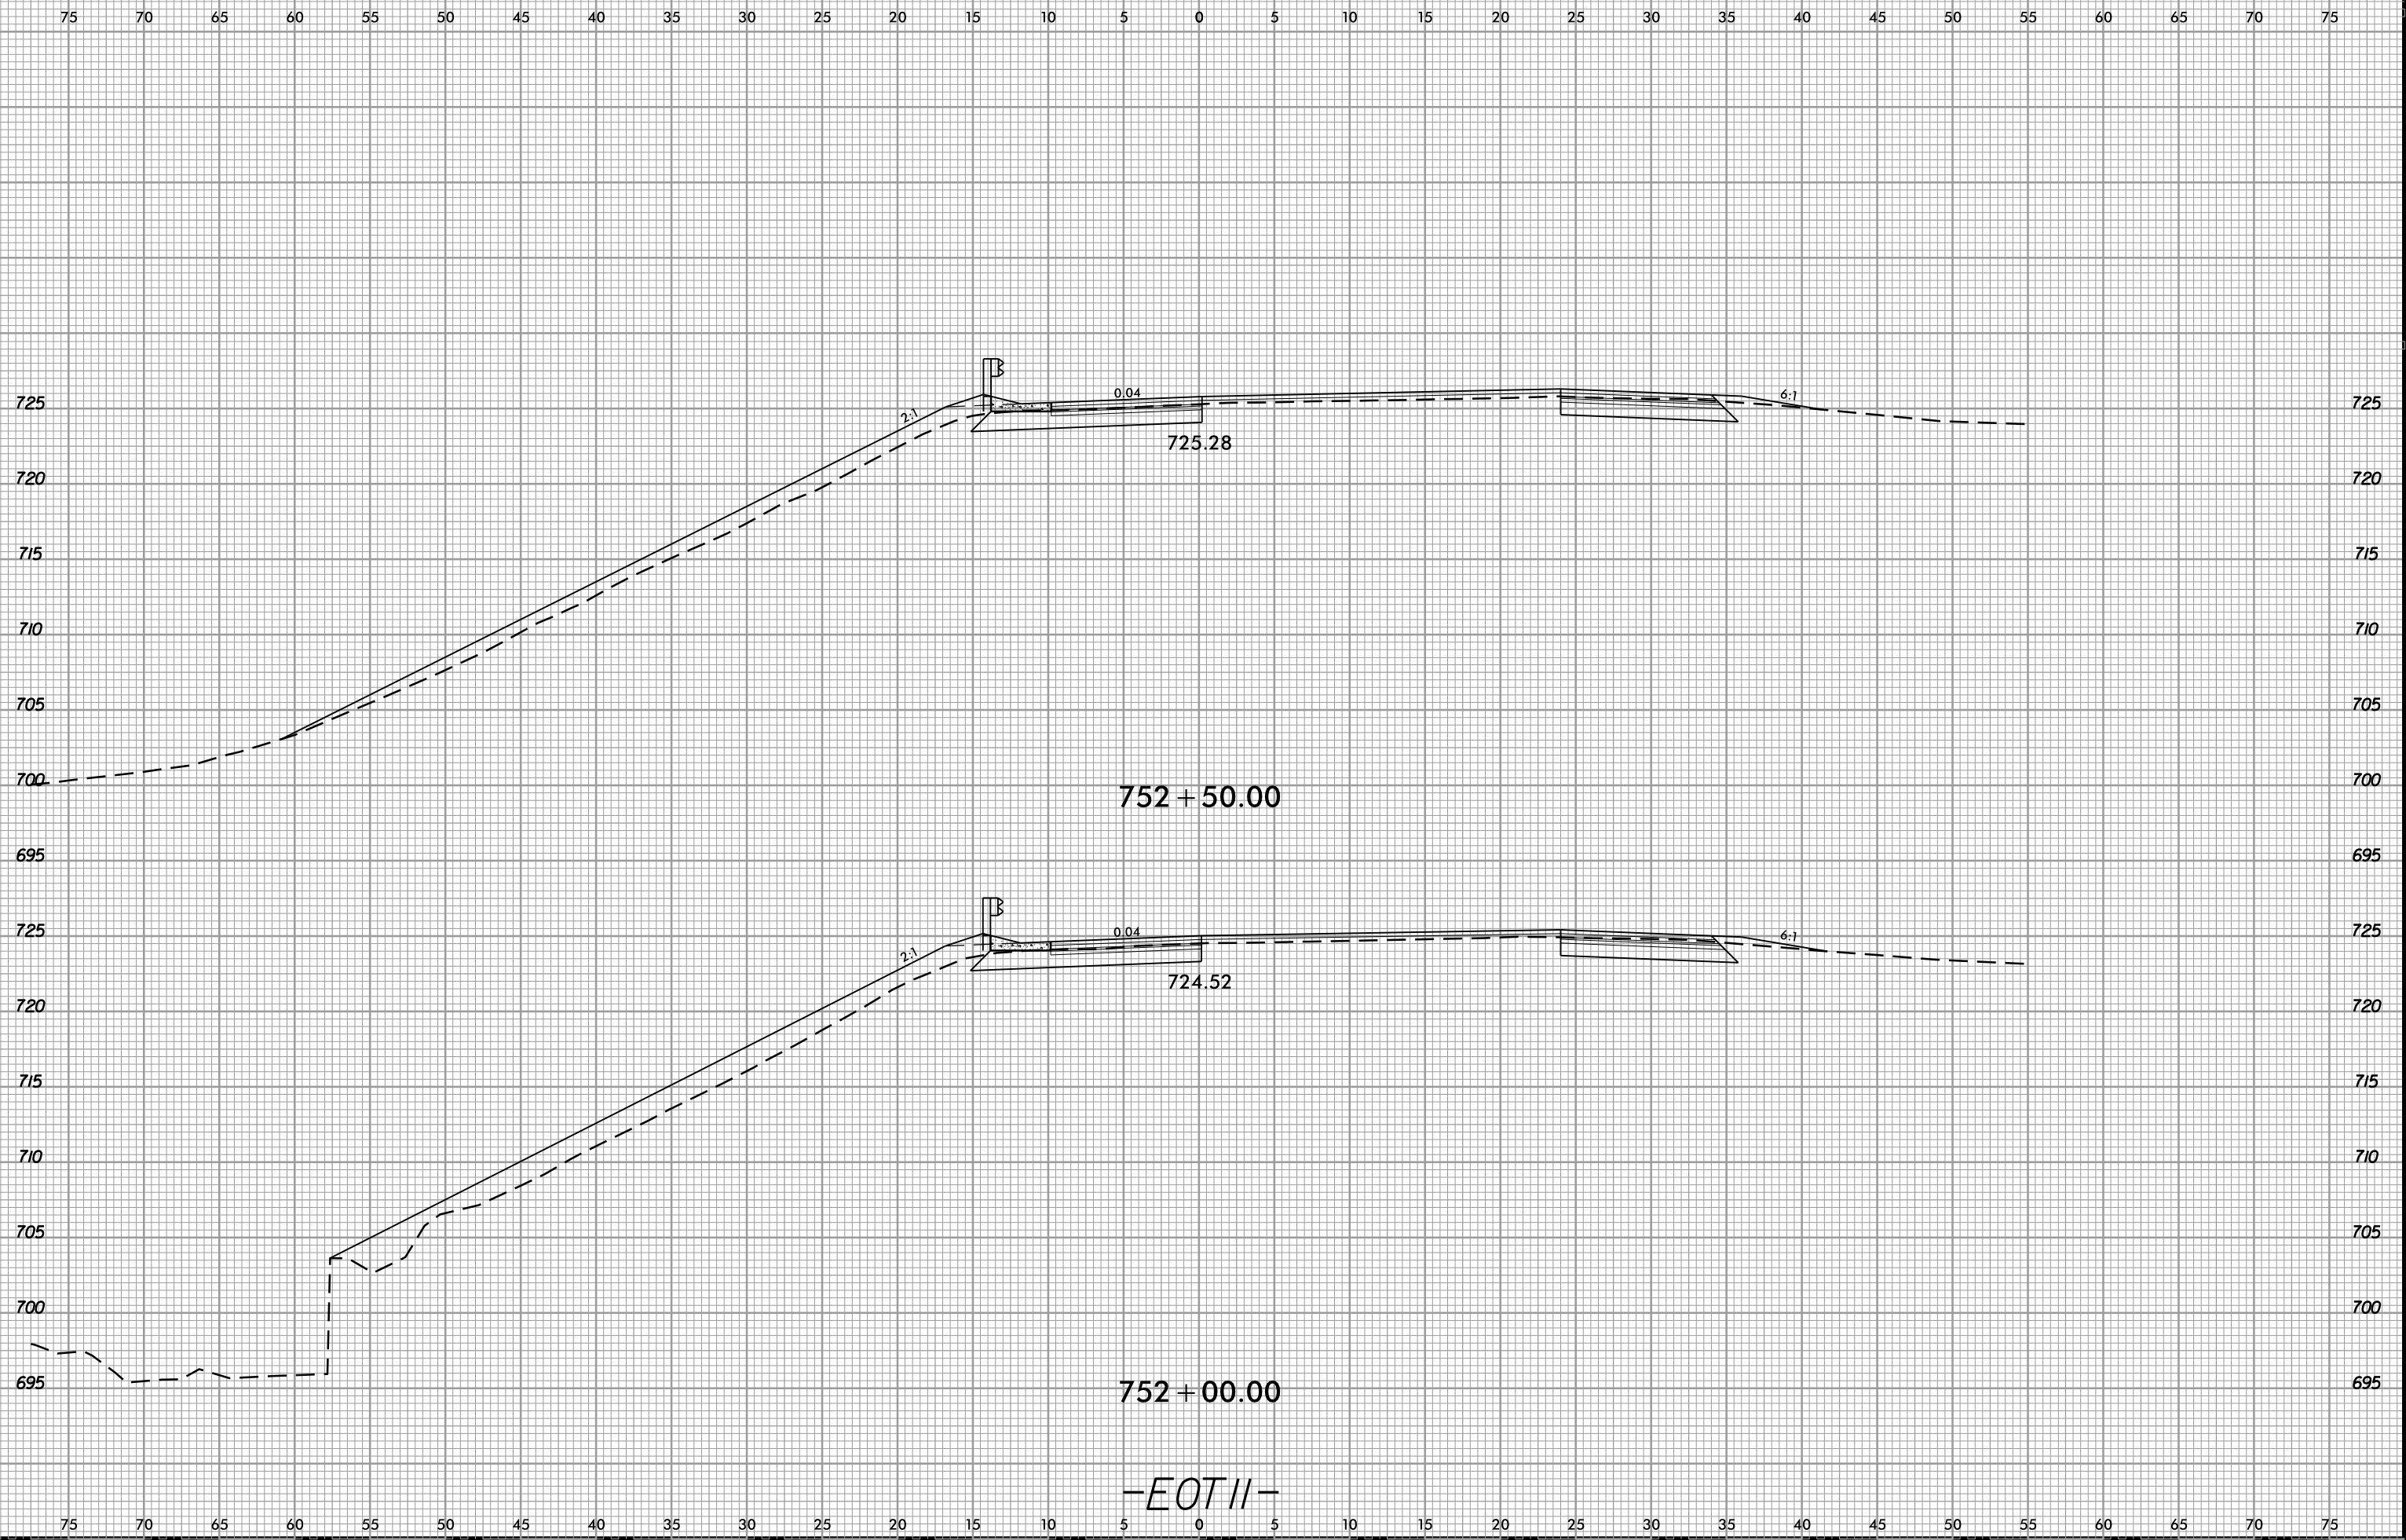


6/23/16  
02-NOV-2018 13:49  
S:\Projects-Development\IP Projects\1-5823-140-Dave Roadway\DesignFiles\5823.ddc.xpl.EOT11.dgn  
Mikeaion AT DIV 9-294550

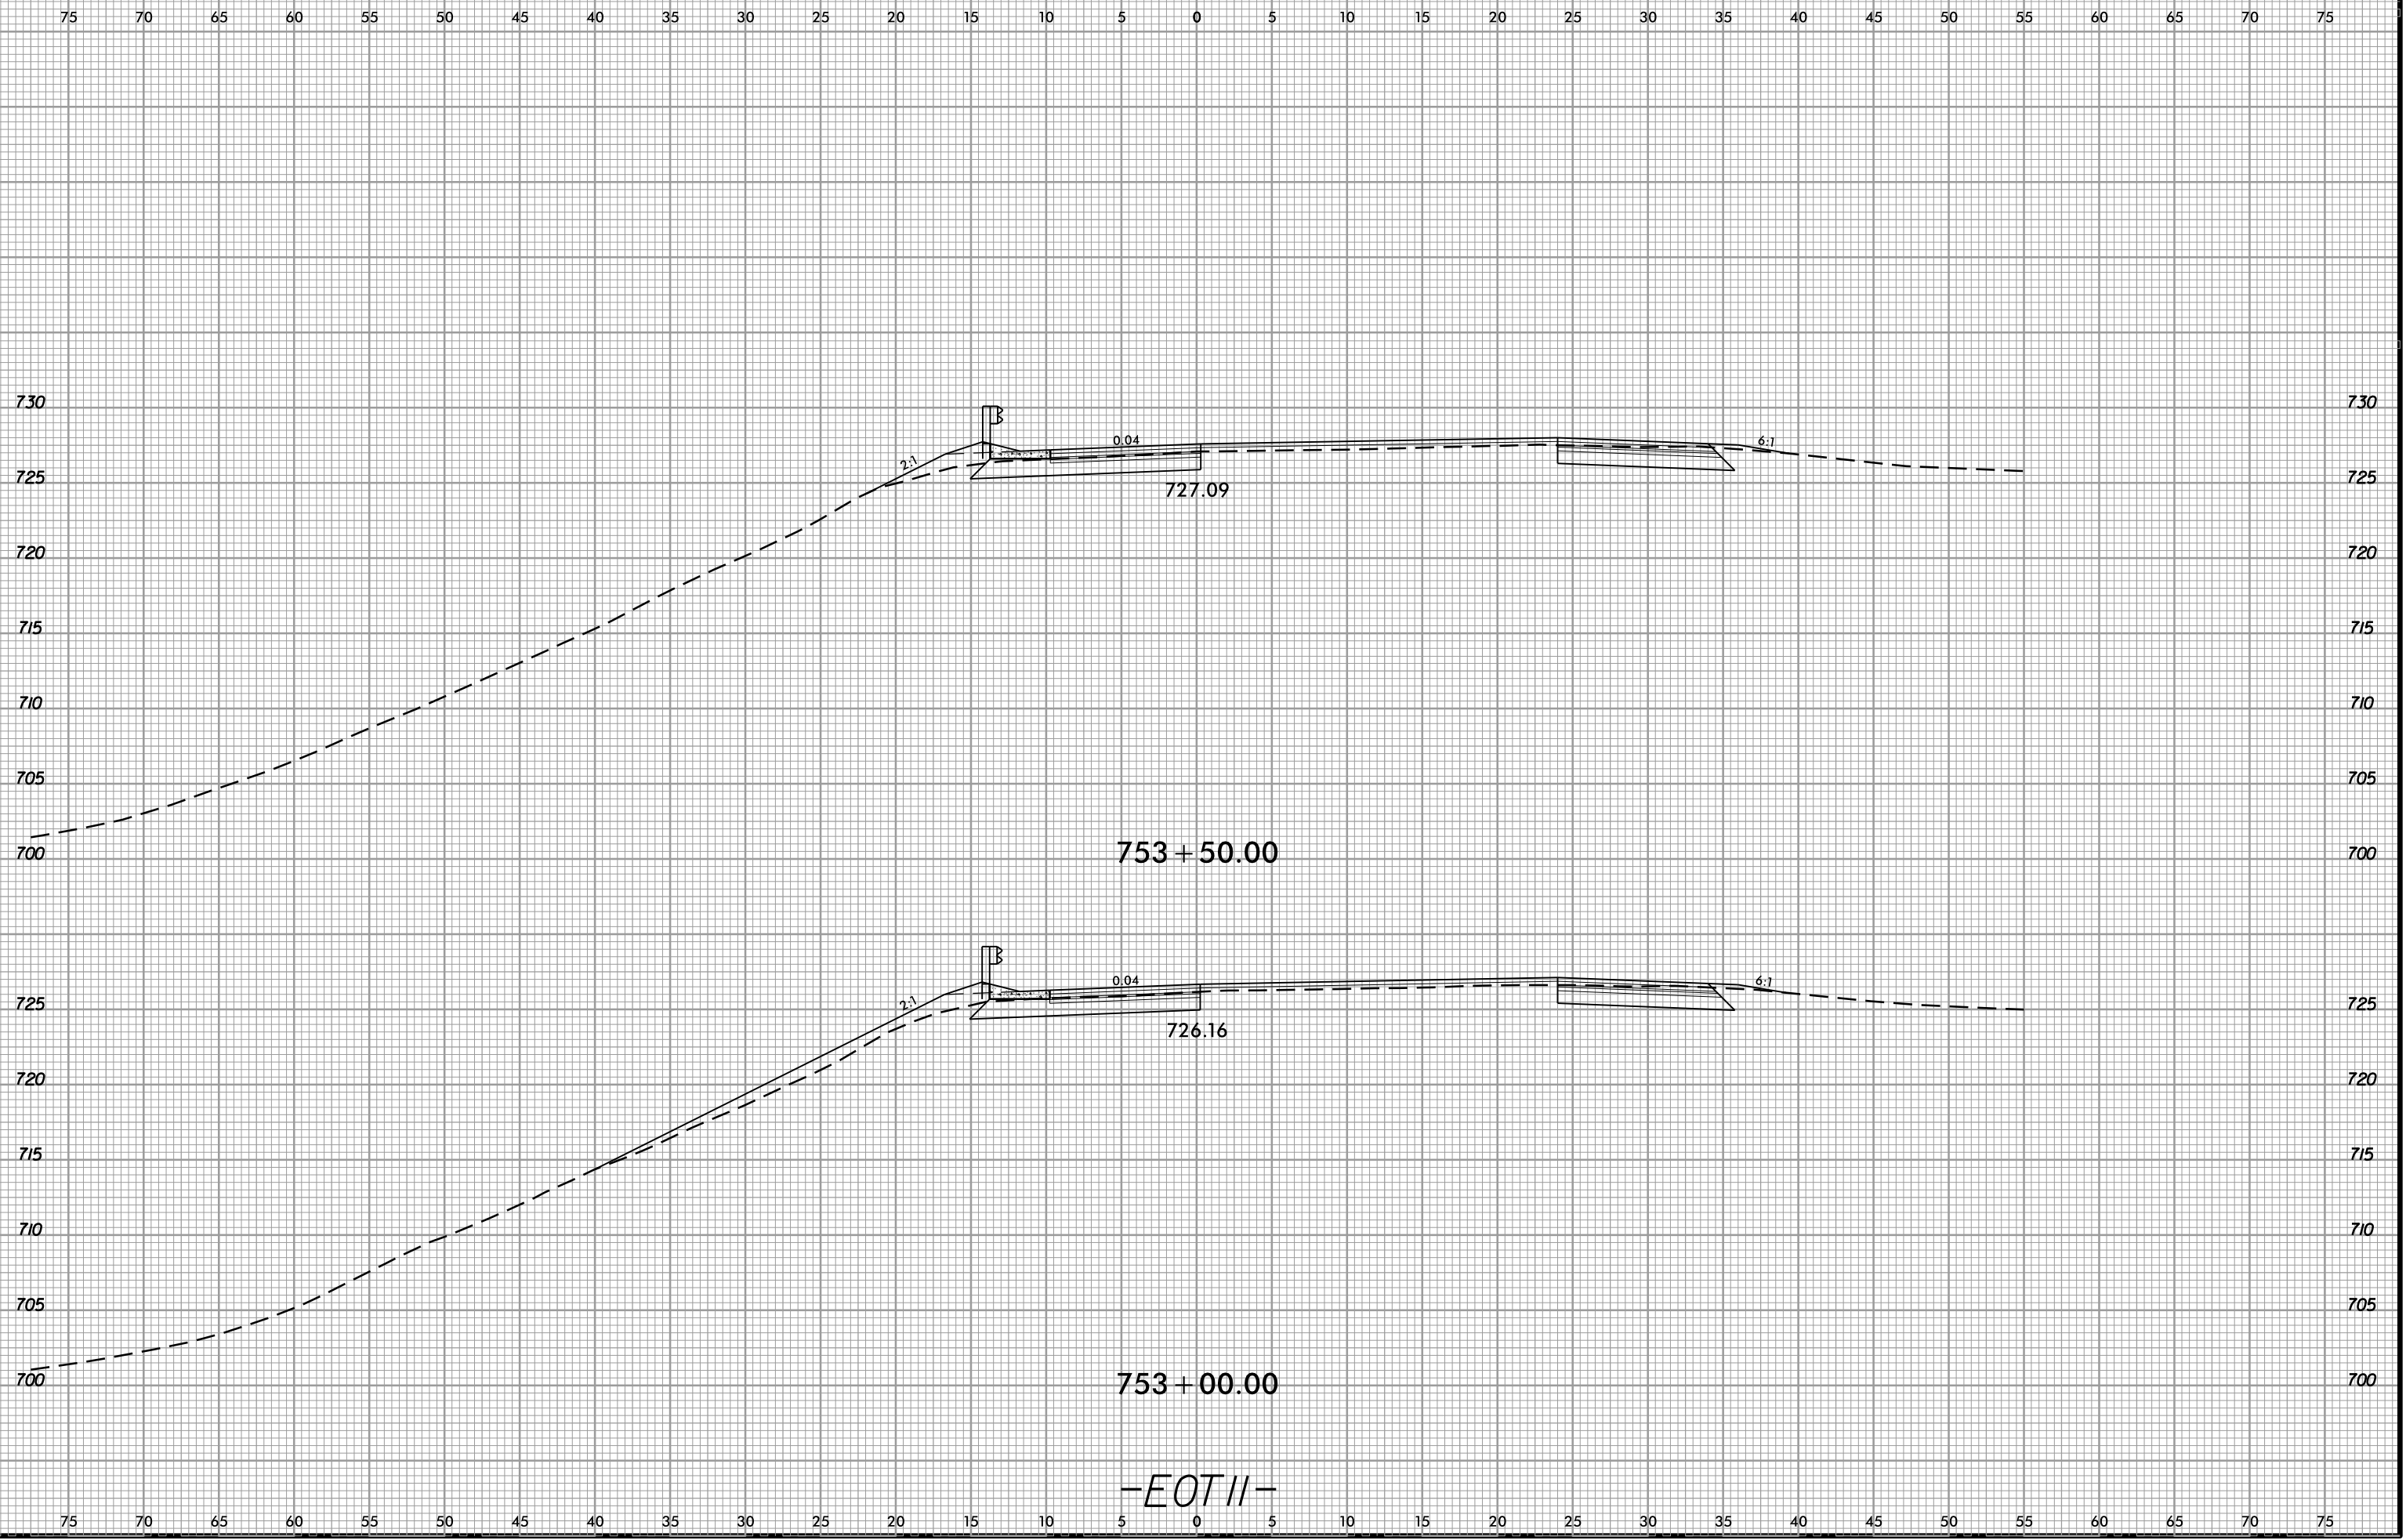


-EOT11-

6/23/16  
02-NOV-2018 13:49  
S:\Project-Development\IP Projects\1-5823-140-Dave\Roadway\DesignFiles\5823.ddc.xpl.EOT11.dgn  
Mikeston AT DIV 294550

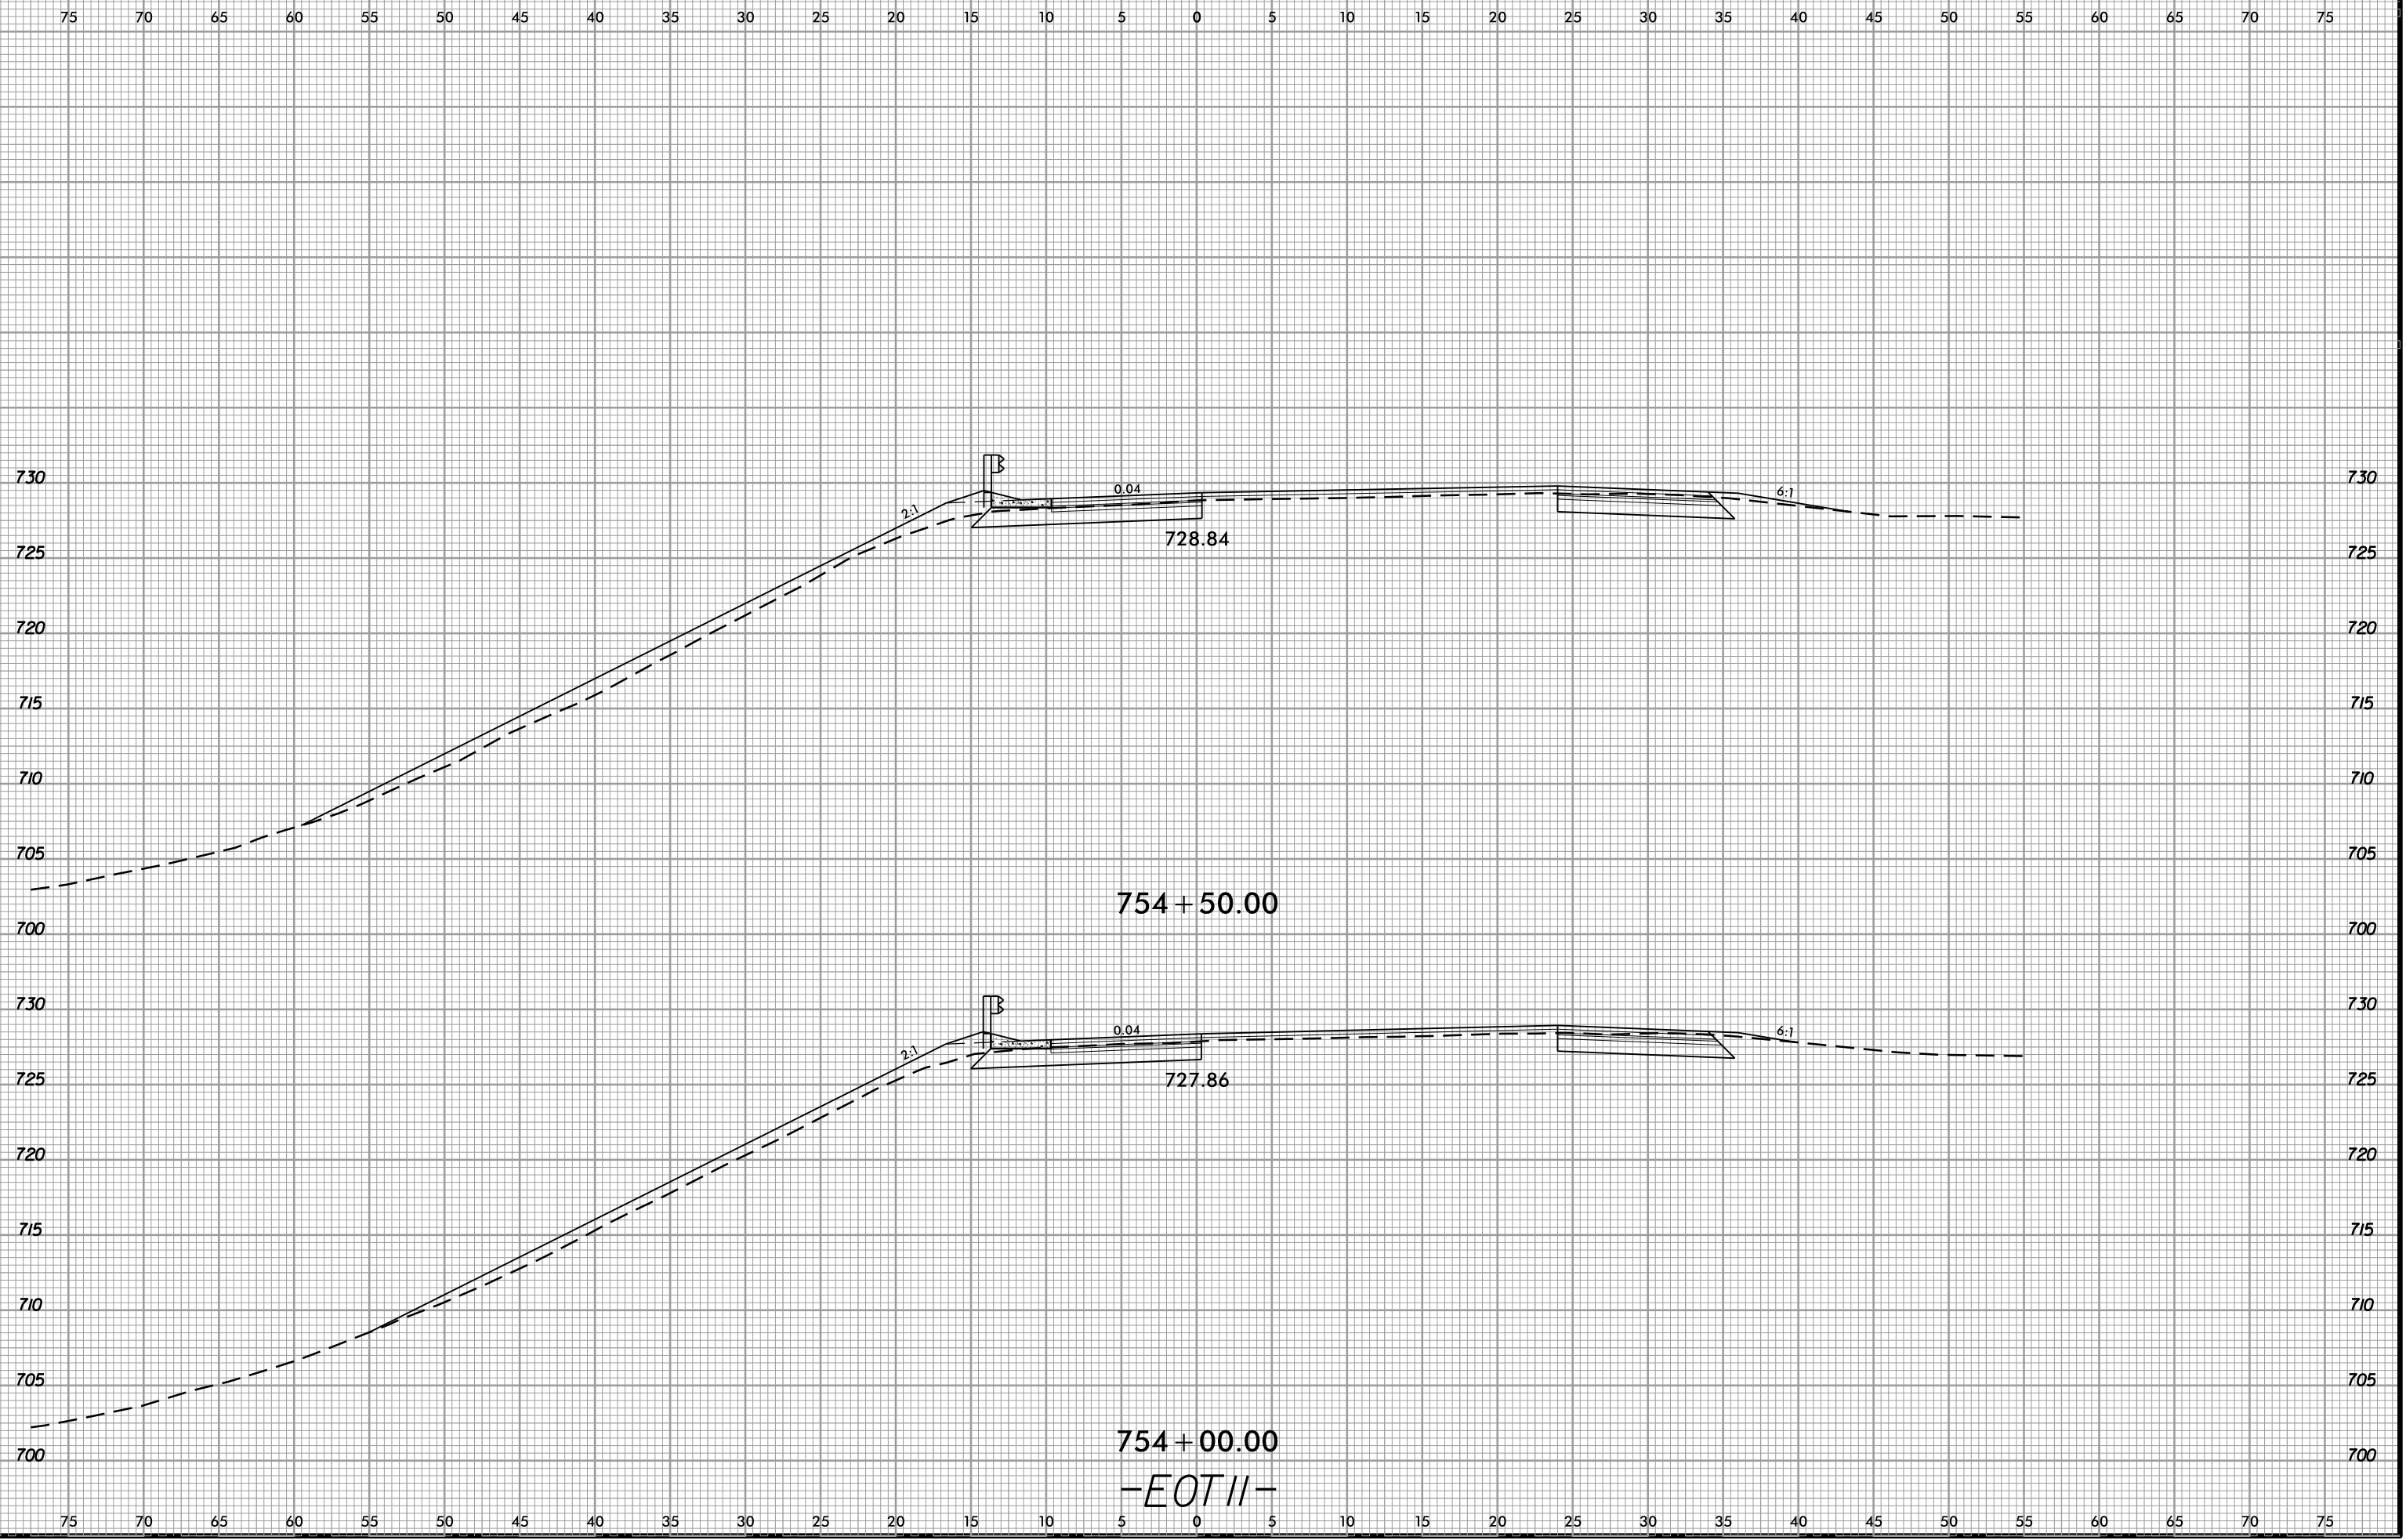


6/23/16  
02-NOV-2018 13:49  
S:\Projects-Development\IP Projects\1-5823-140-Dave\Roadway\DesignFiles\5823.ddc.xpl.EOT11.dgn  
Mikeston AT DIV 29450

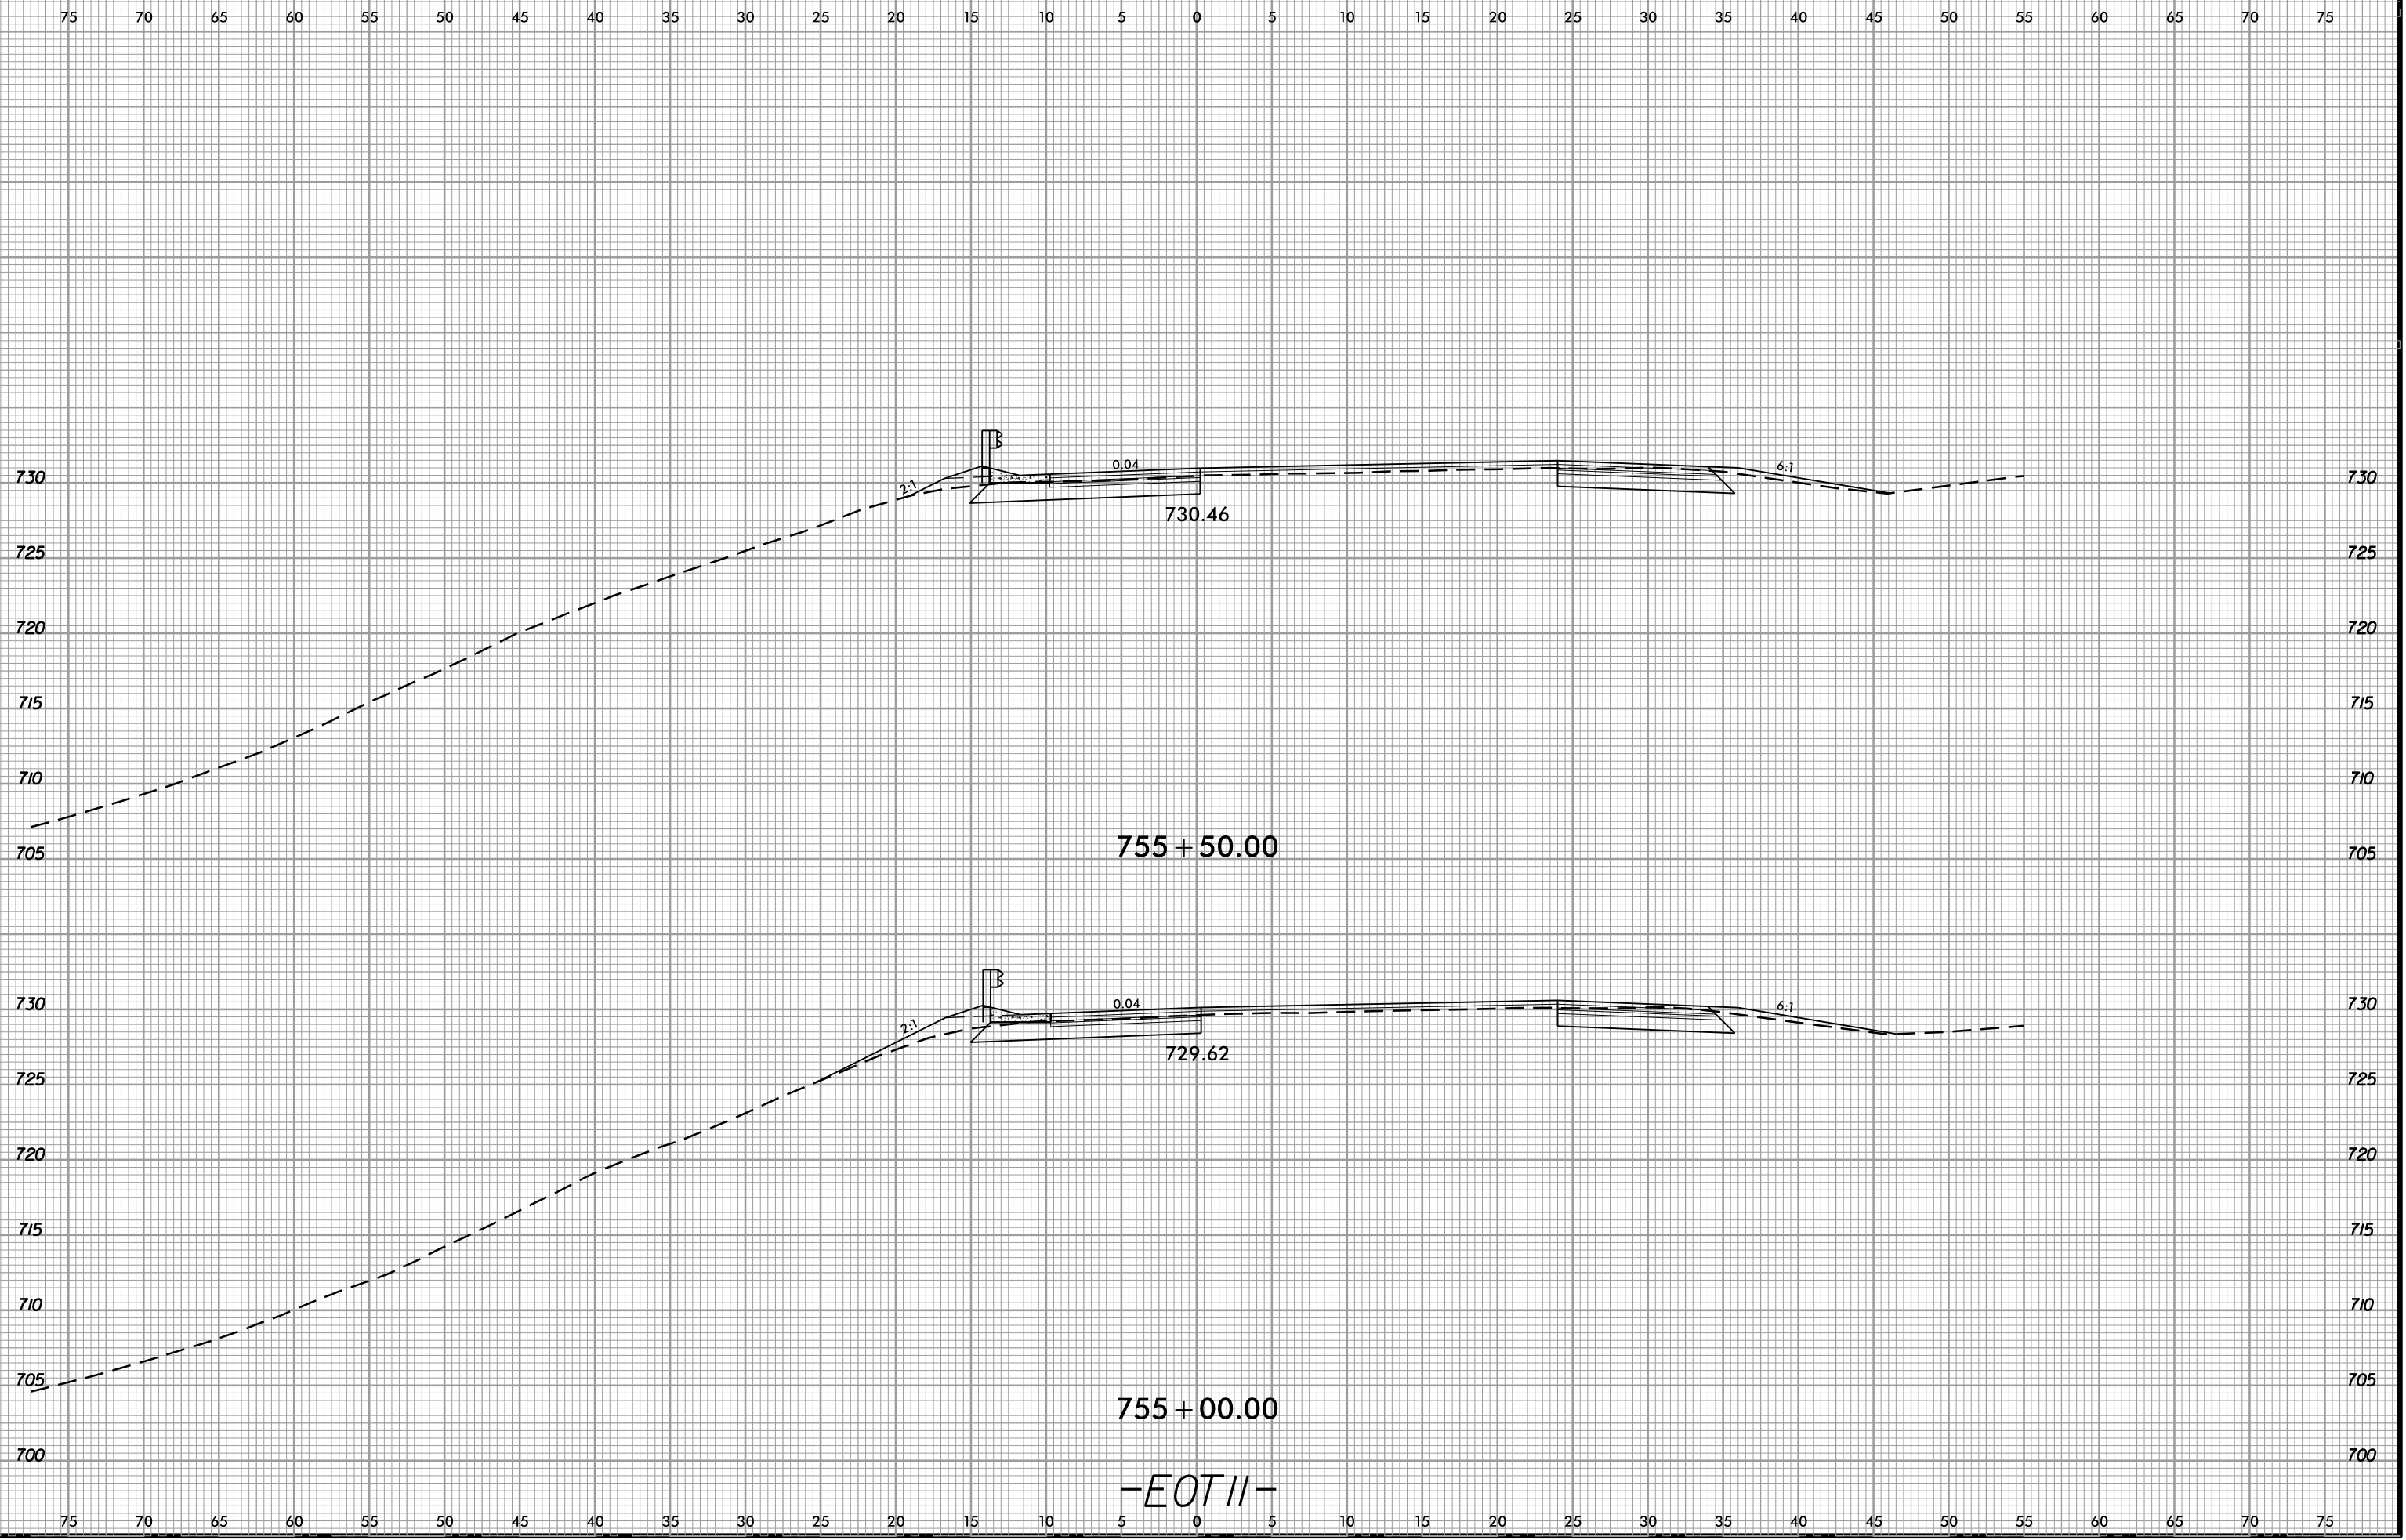


-EOT11-



6/23/16  
02-NOV-2018 13:49  
S:\Project-Development\IP Projects\1-5823-140-Dave Roadway\DesignFiles\5823.ddc.xpl.EOT12.dgn  
AT DIV 29450

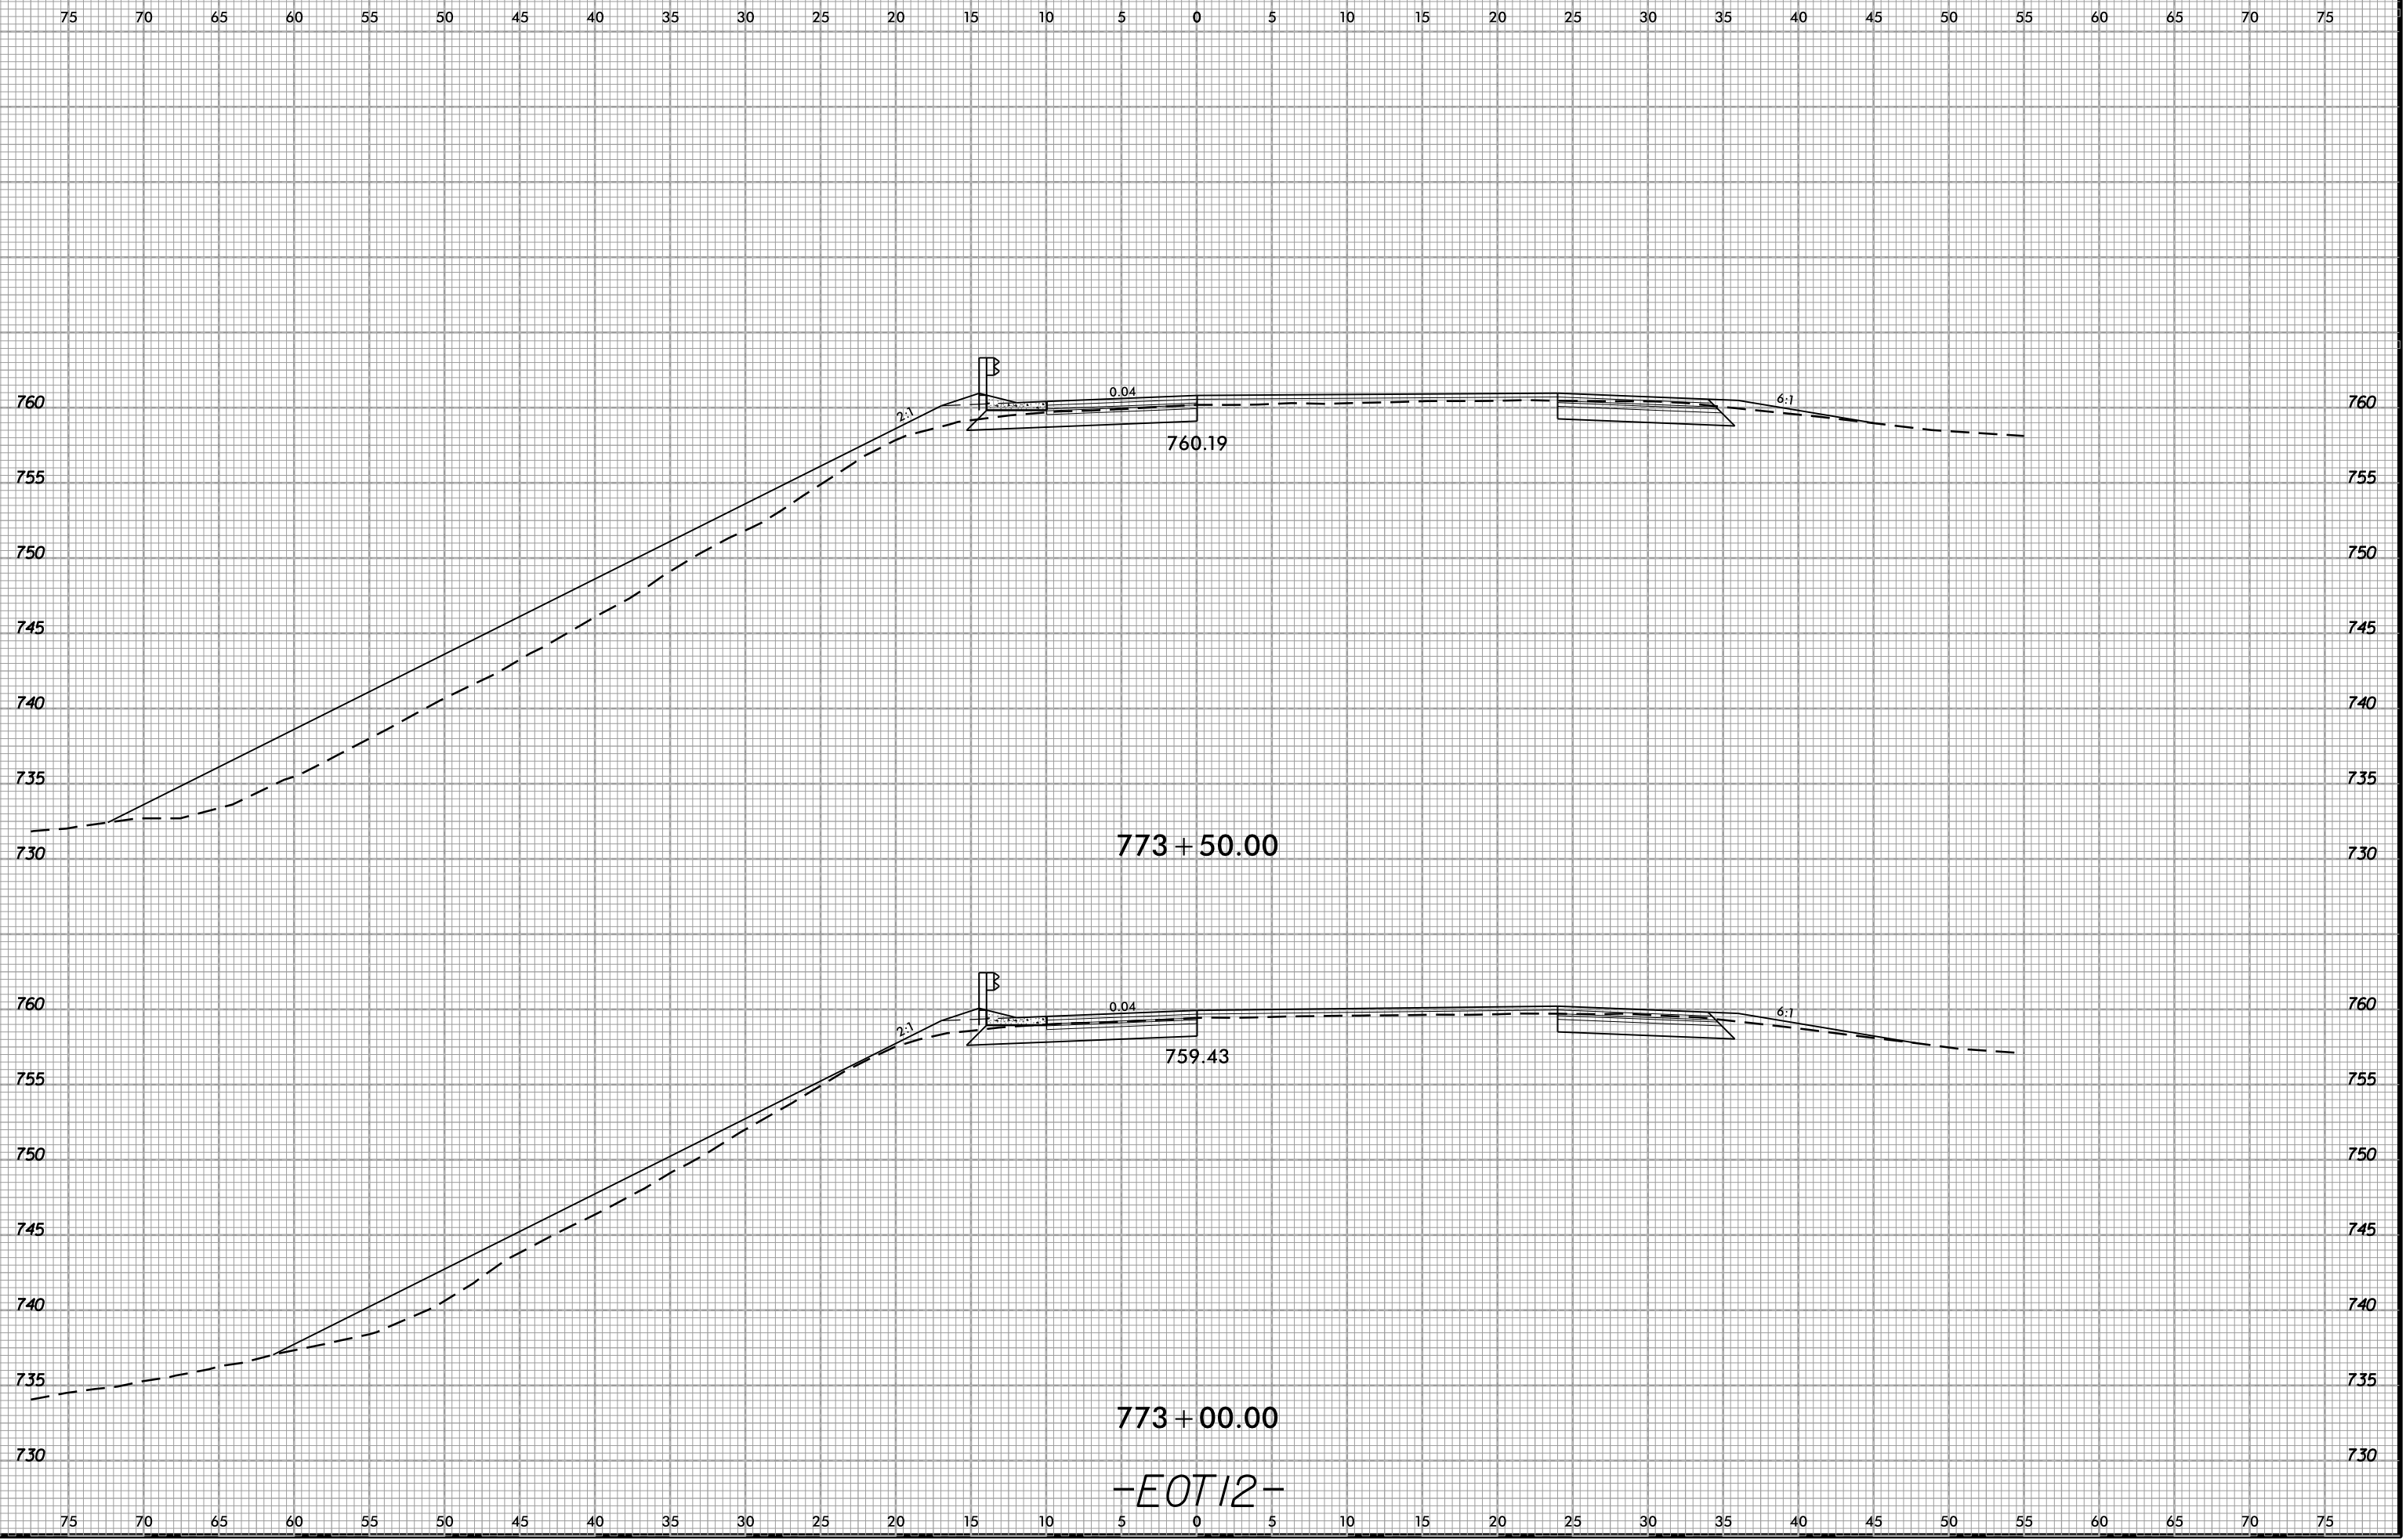


6/23/16  
02-NOV-2018 13:49  
S:\Project-Development\IP Projects\1-5823-140-Dave Roadway\DesignFiles\5823.ddc.xpl.EOT12.dgn  
AT DIV 29450

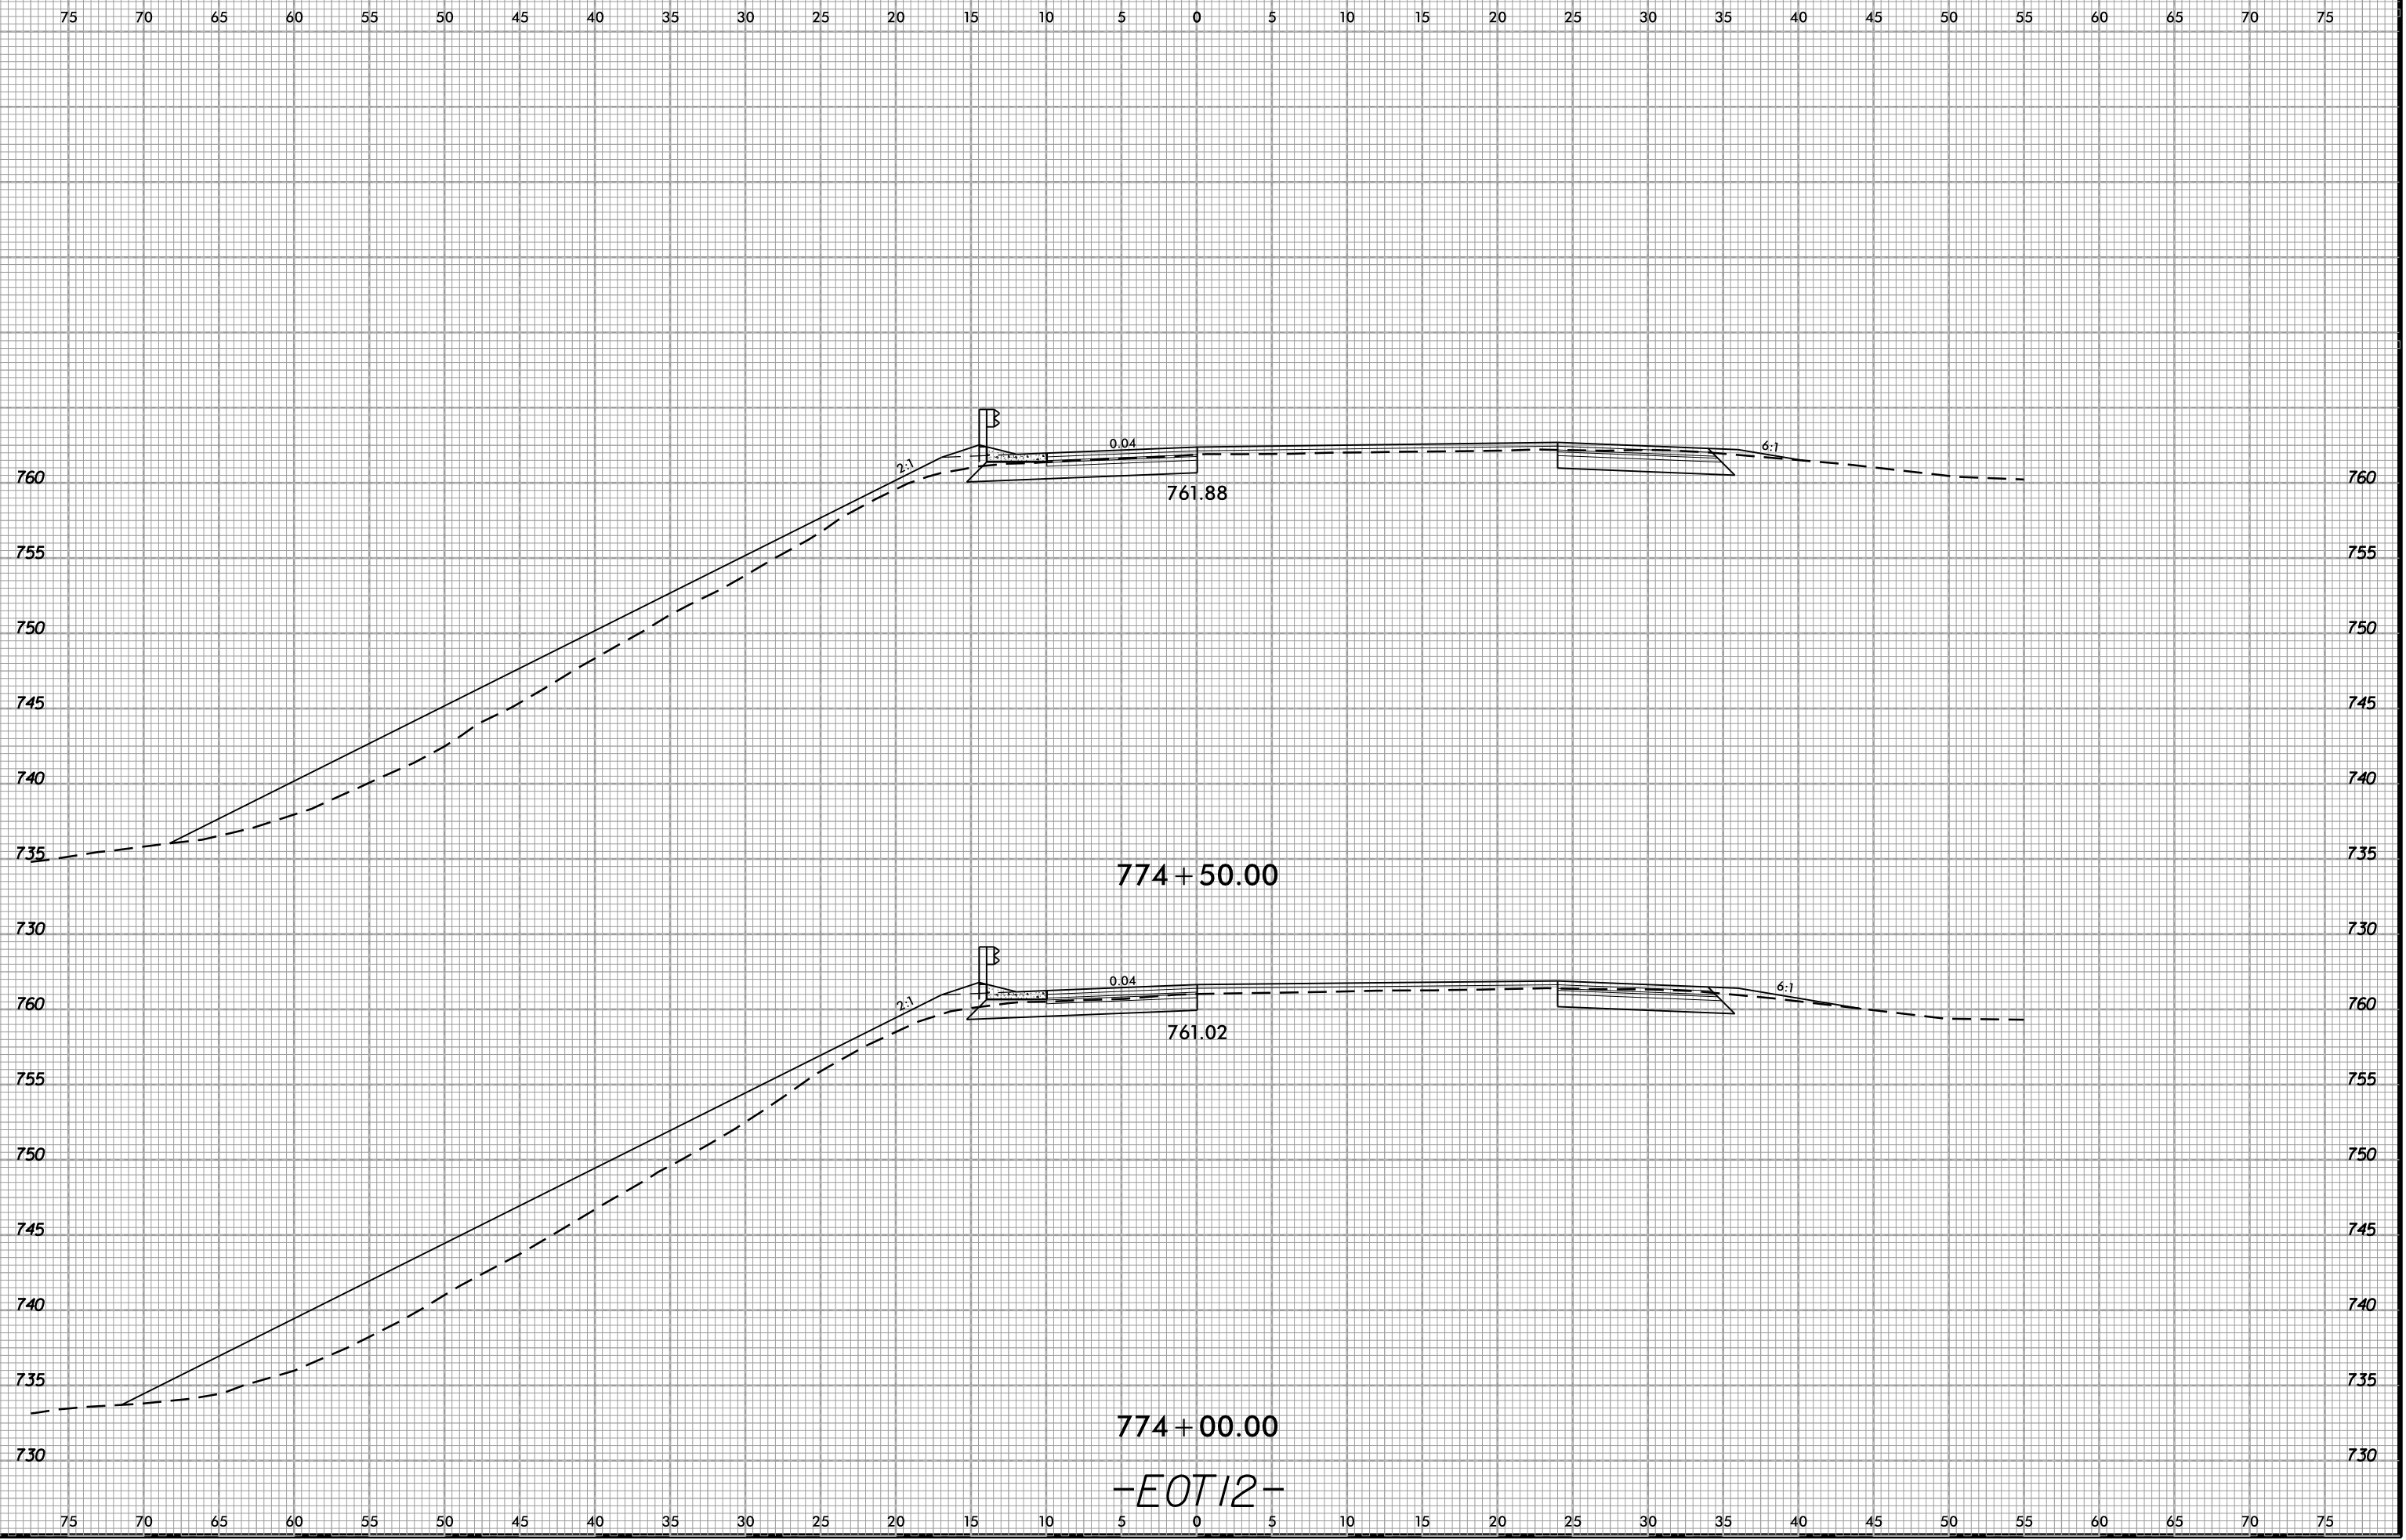


-EOT12-

6/23/16  
02-NOV-2018 13:49  
S:\Project-Development\IP Projects\1-5823-140-Dave\Roadway\DesignFiles\5823.ddc.xpl.EOT12.dgn  
AT DIV 29450

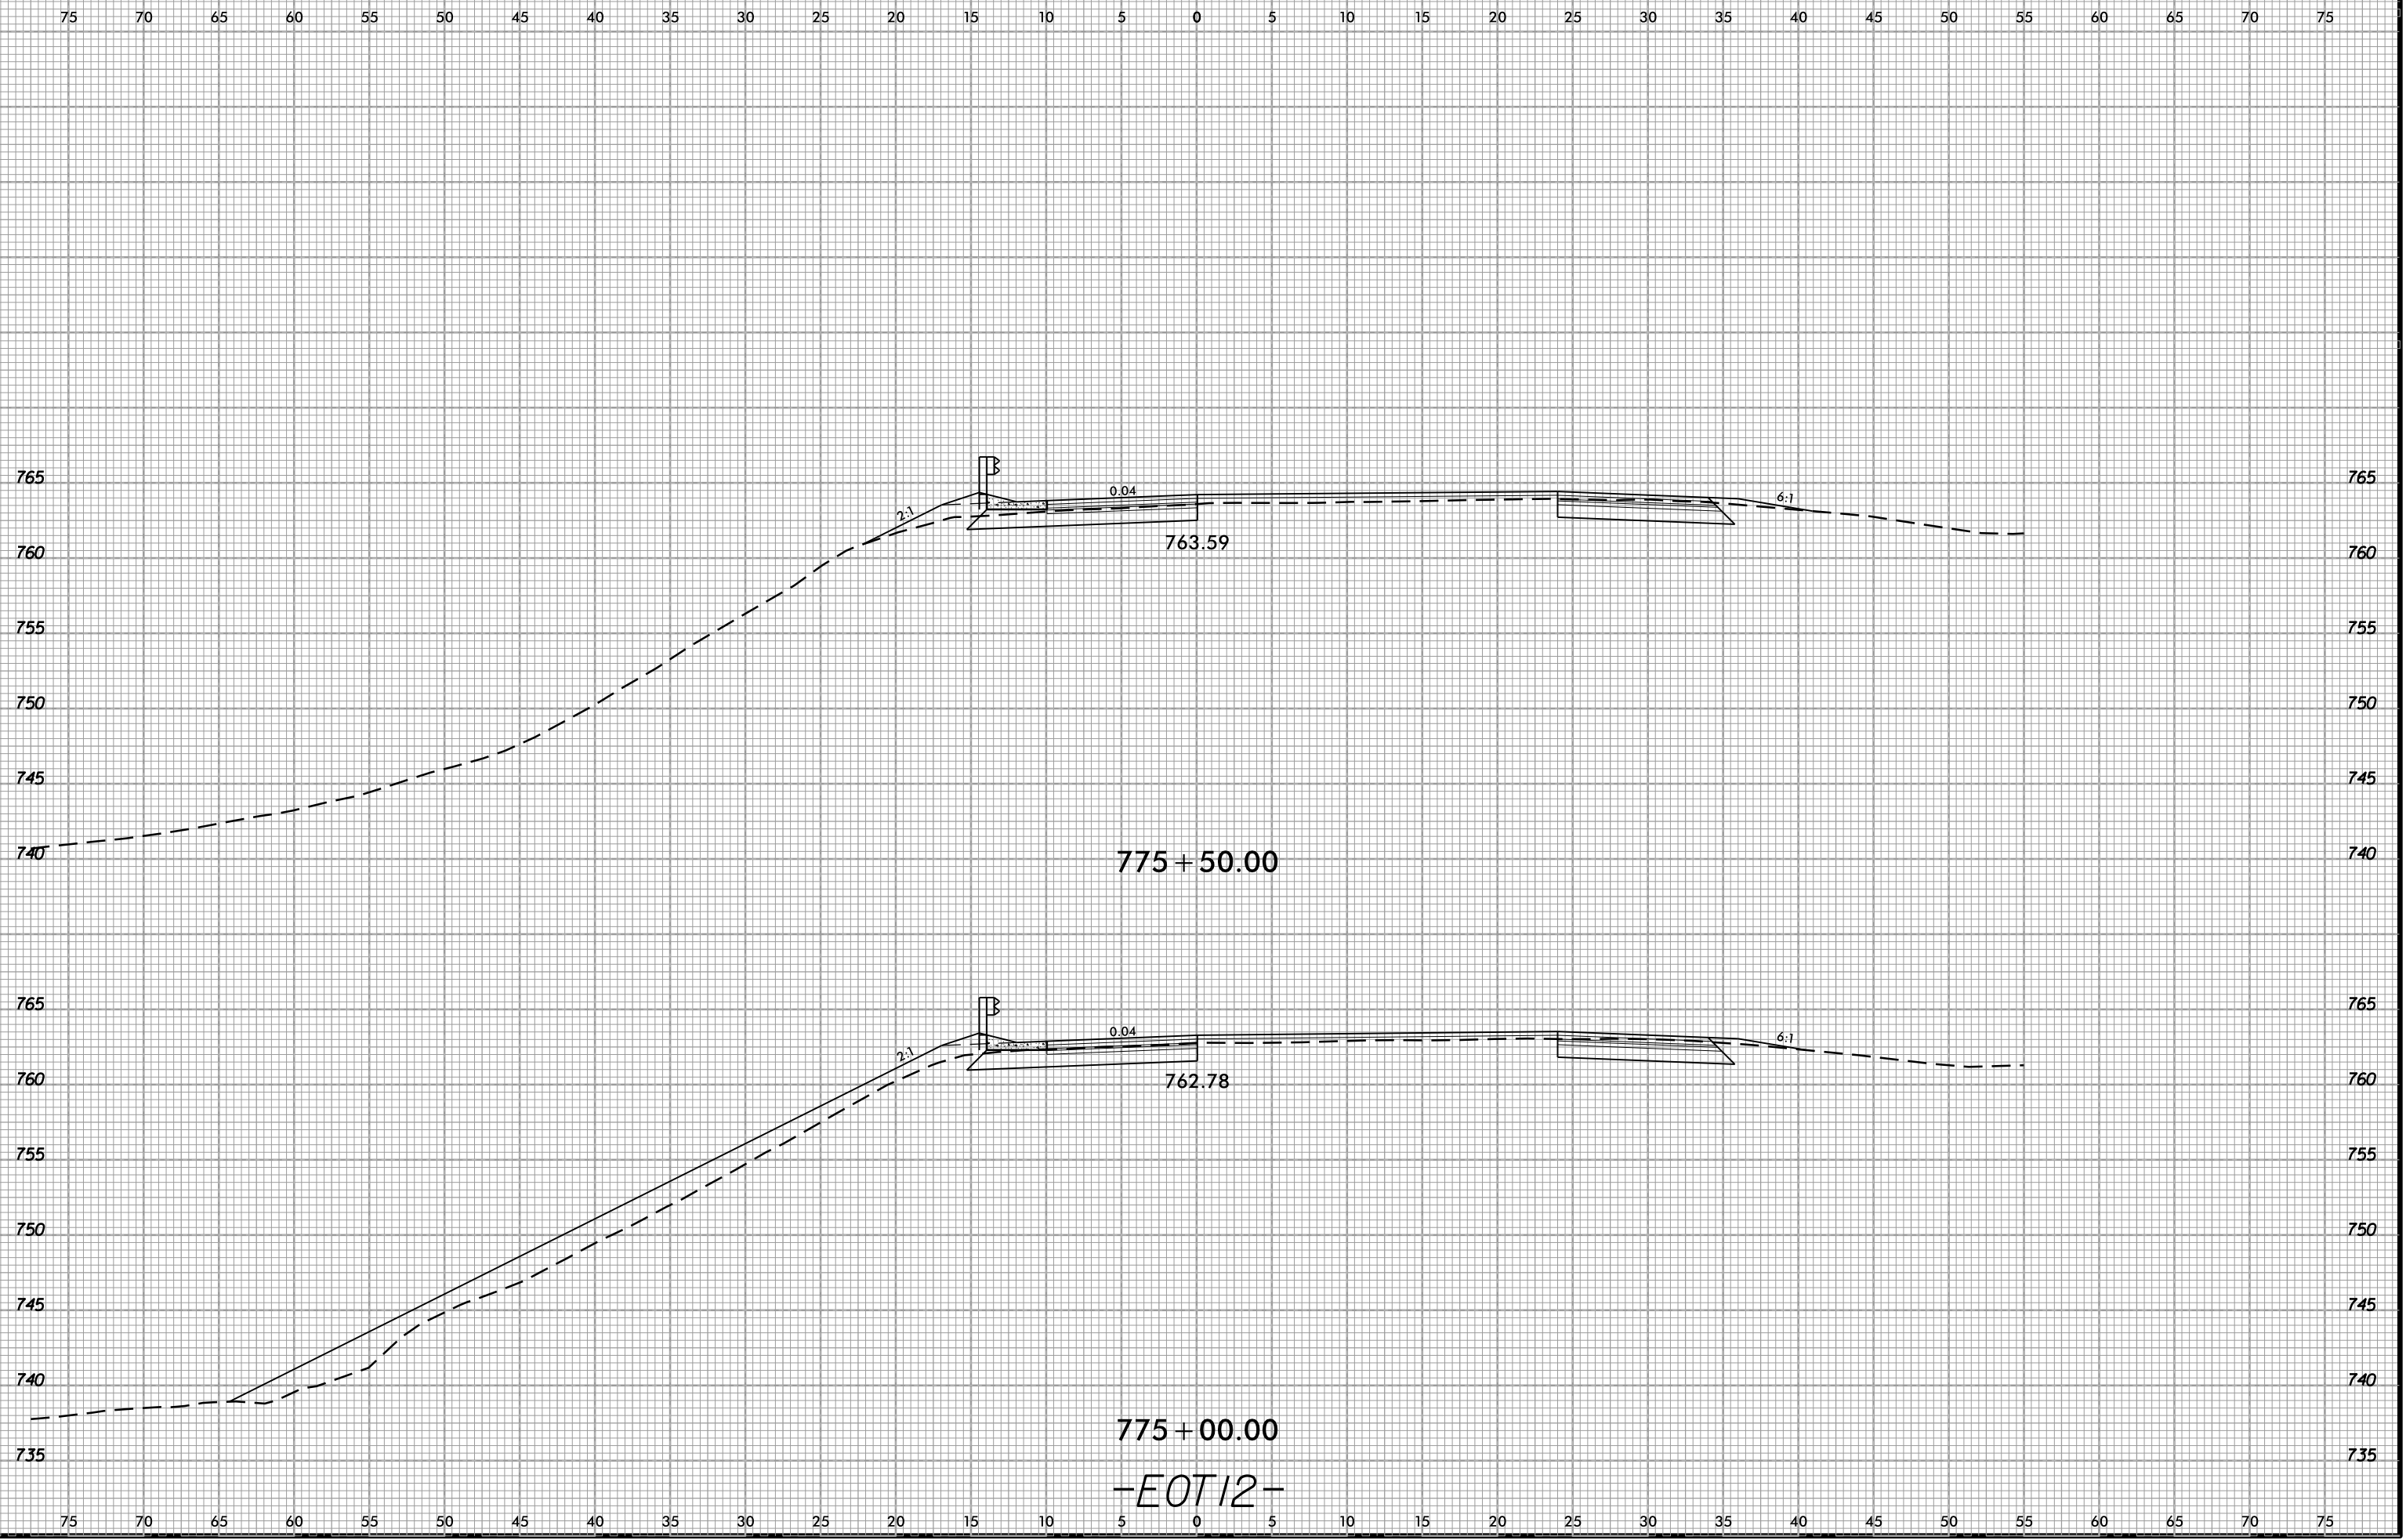


-EOT12-


6/23/16  
02-NOV-2018 13:49  
S:\Project-Development\IP Projects\1-5823-140-Dave\Roadway\DesignFiles\5823.ddc.xpl.EOT12.dgn  
Mike@on AT DIV@294550

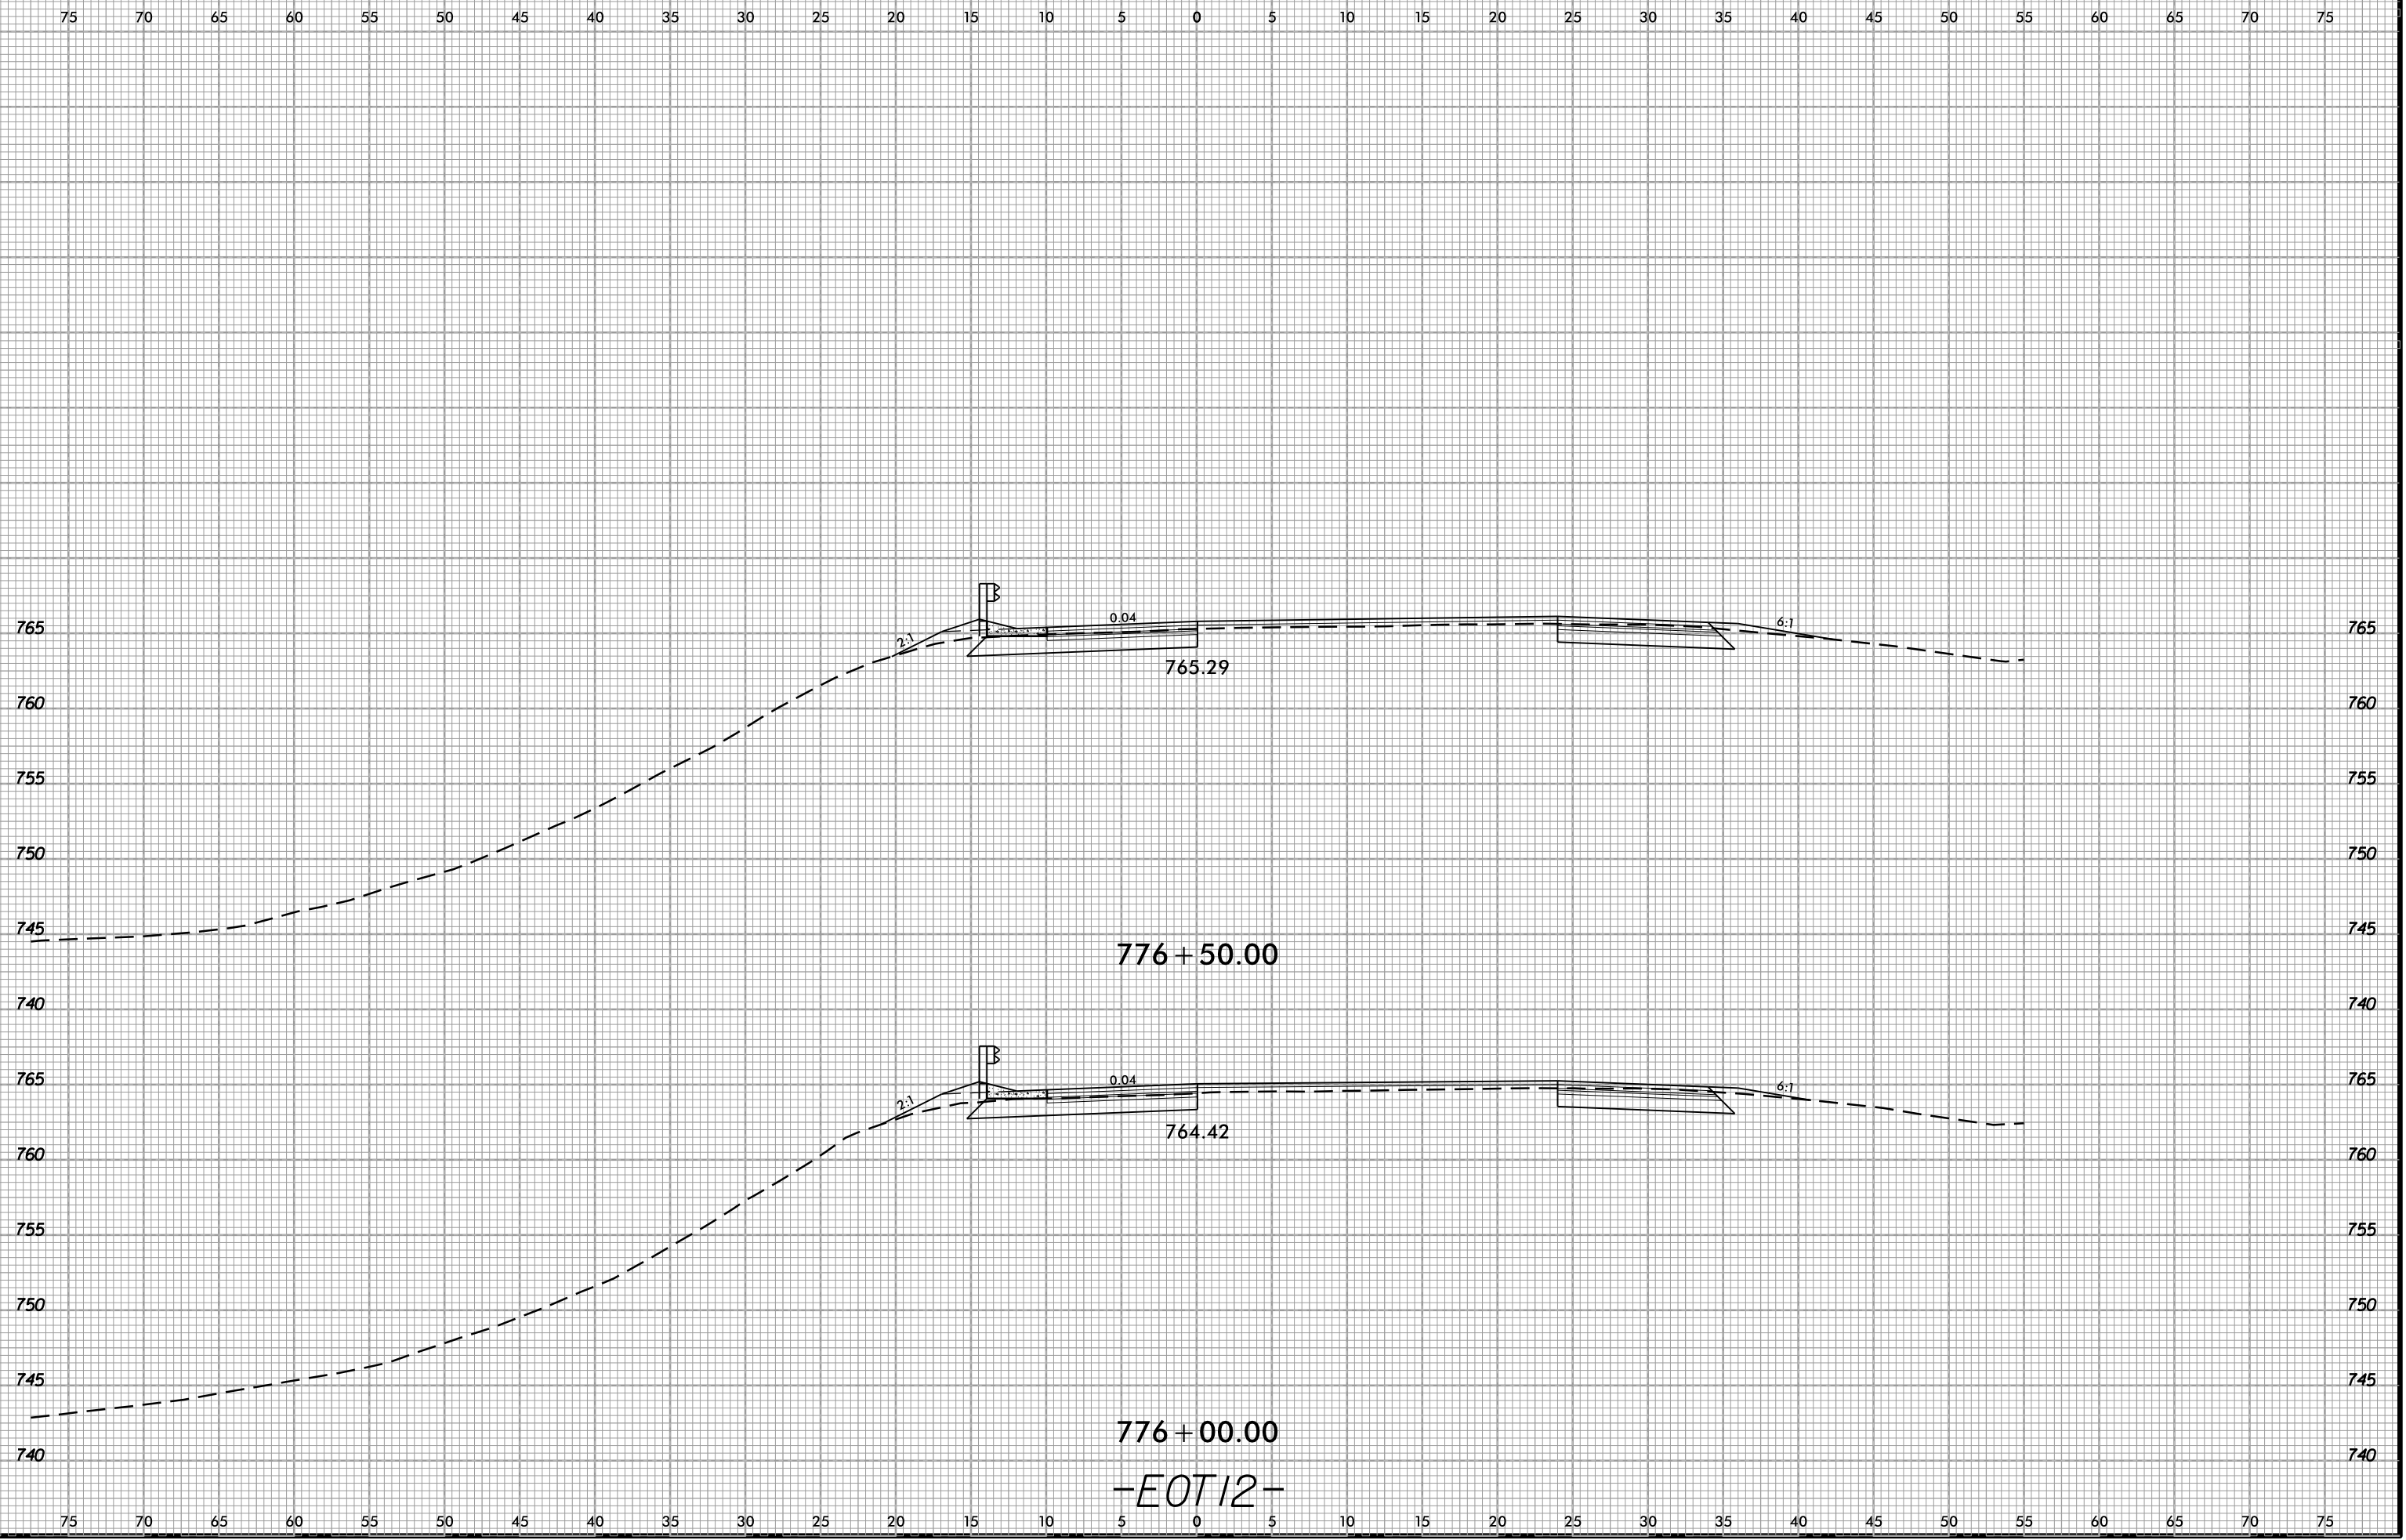


6/23/16  
02-NOV-2018 13:49  
S:\Project-Development\IP Projects\11-5823-140-Dave\Roadway\DesignFiles\5823.ddc.xpl.E012.dgn  
AT DIV 29450

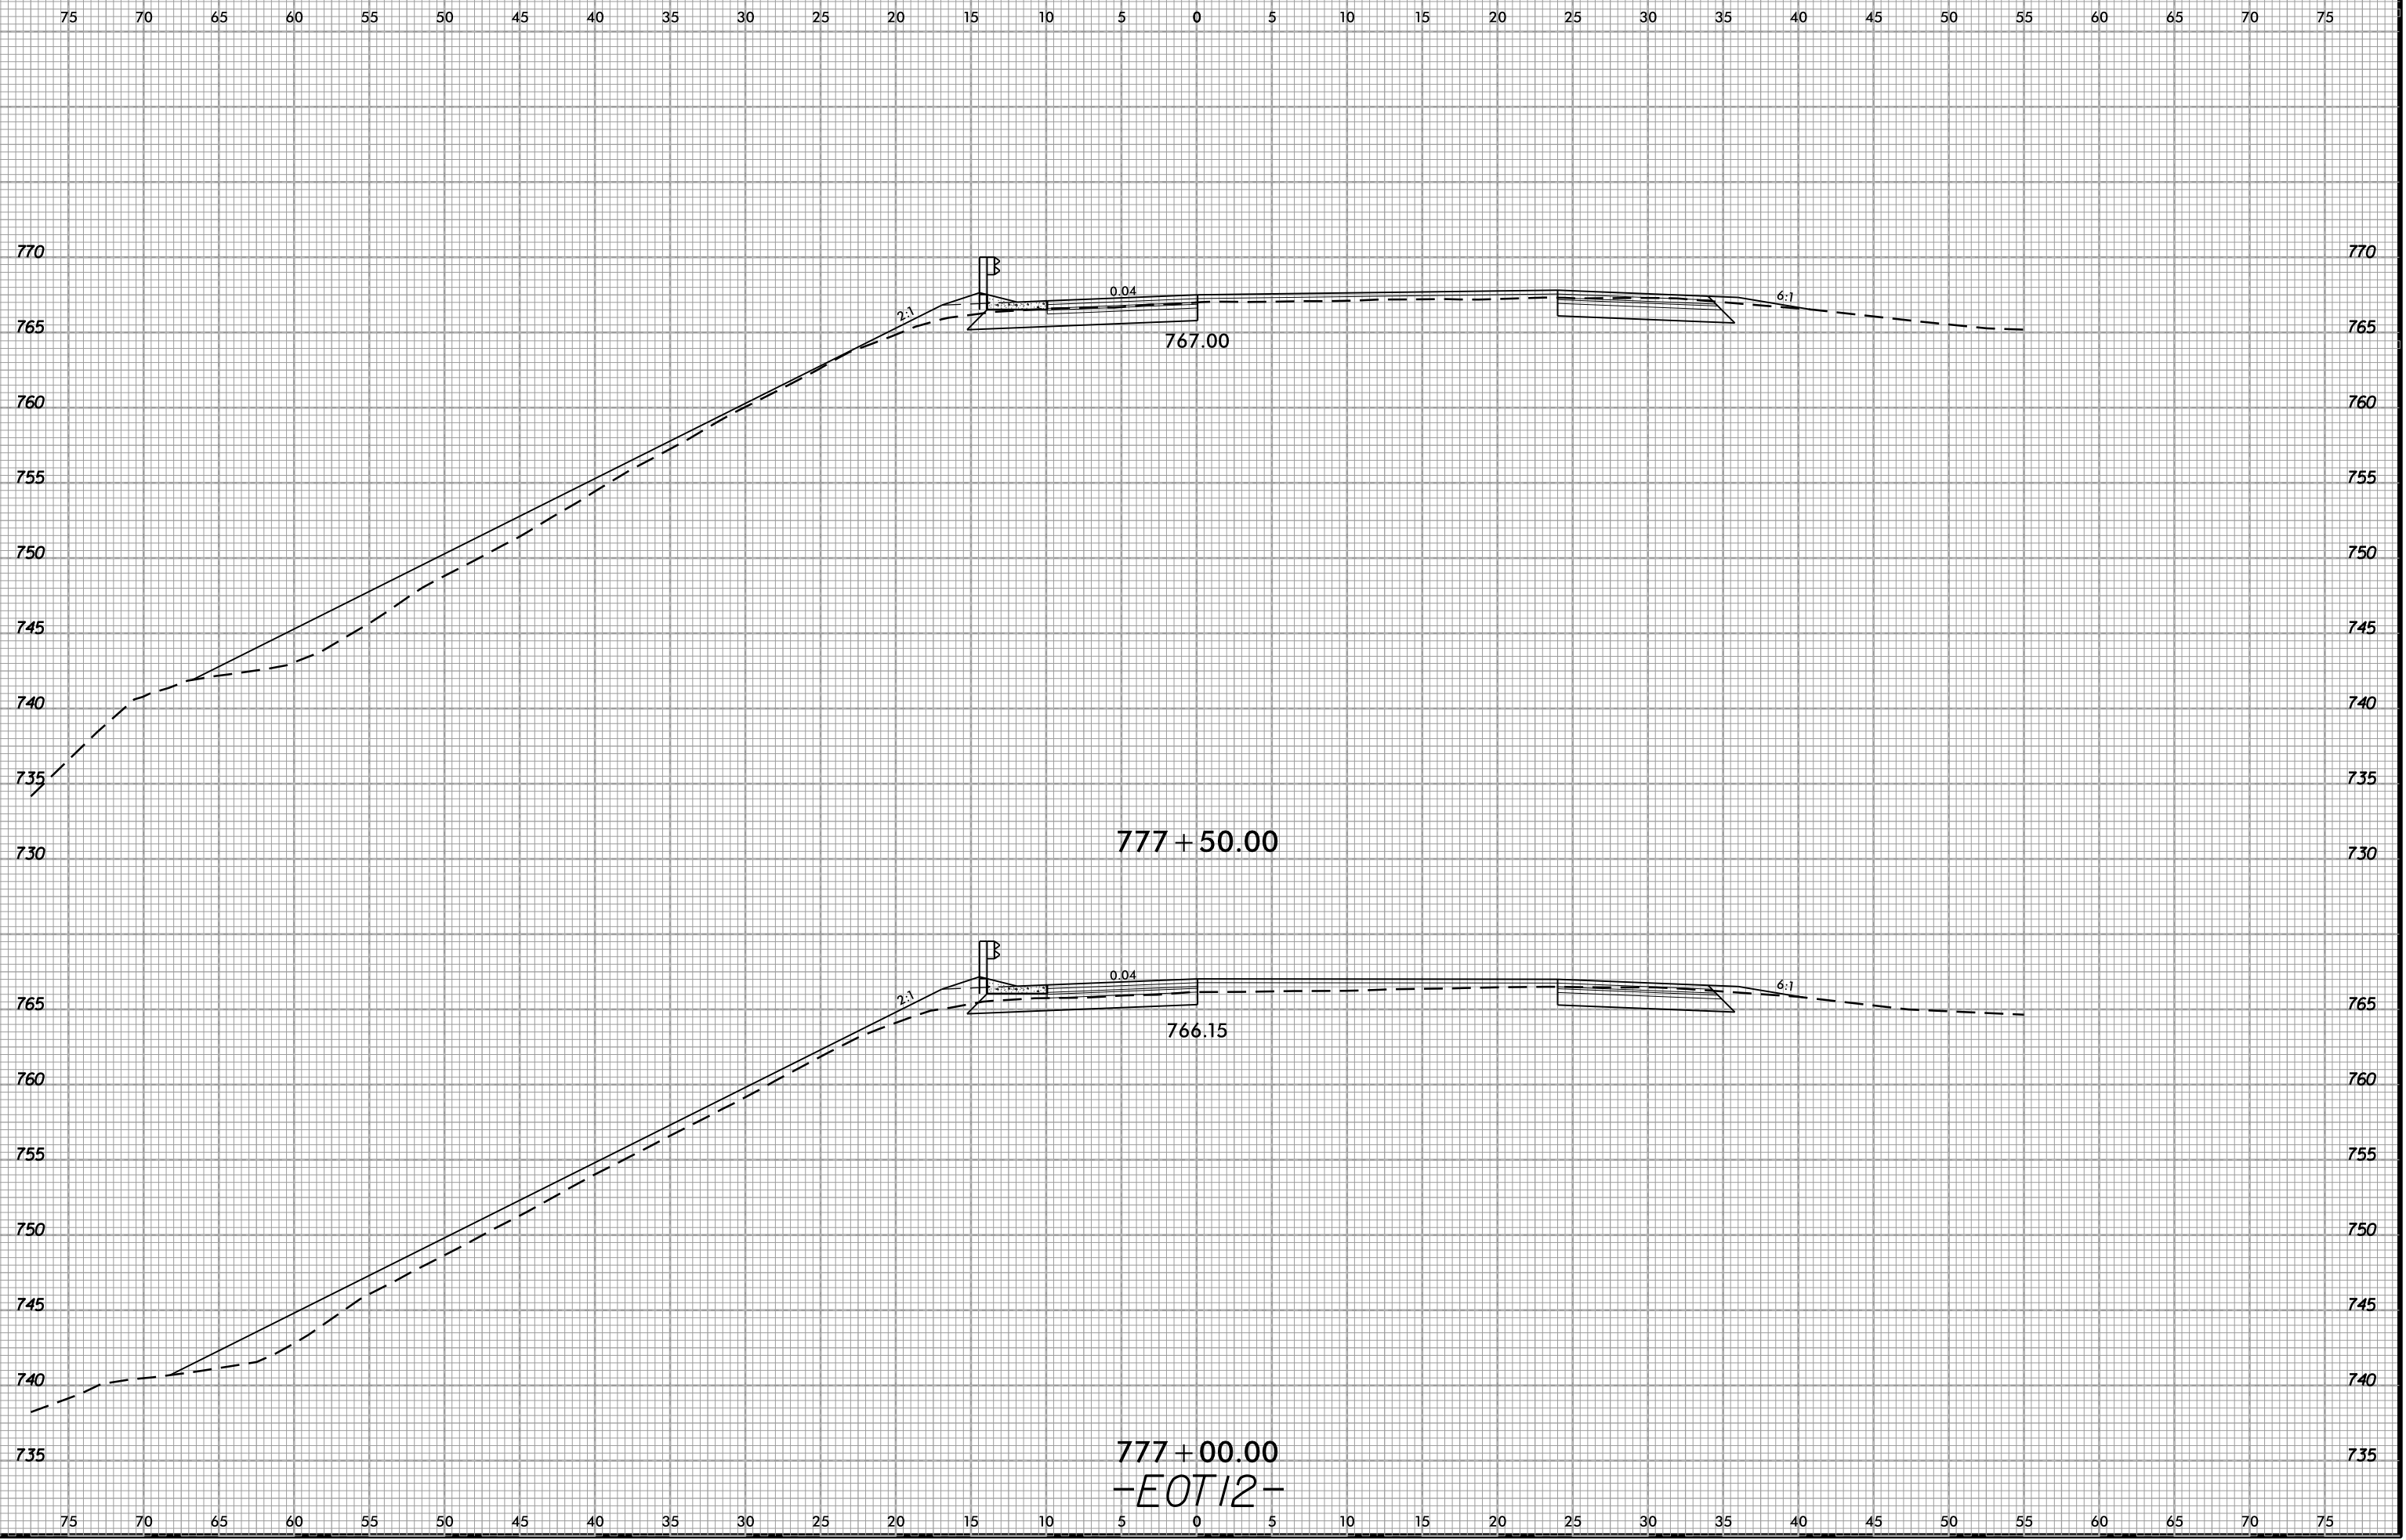


6/23/16  
02-NOV-2018 13:49  
S:\Project-Development\IP Projects\1-5823-140-Dave\Roadway\DesignFiles\5823.ddc.xpl.EOT12.dgn  
kleeion AT DIV 29450

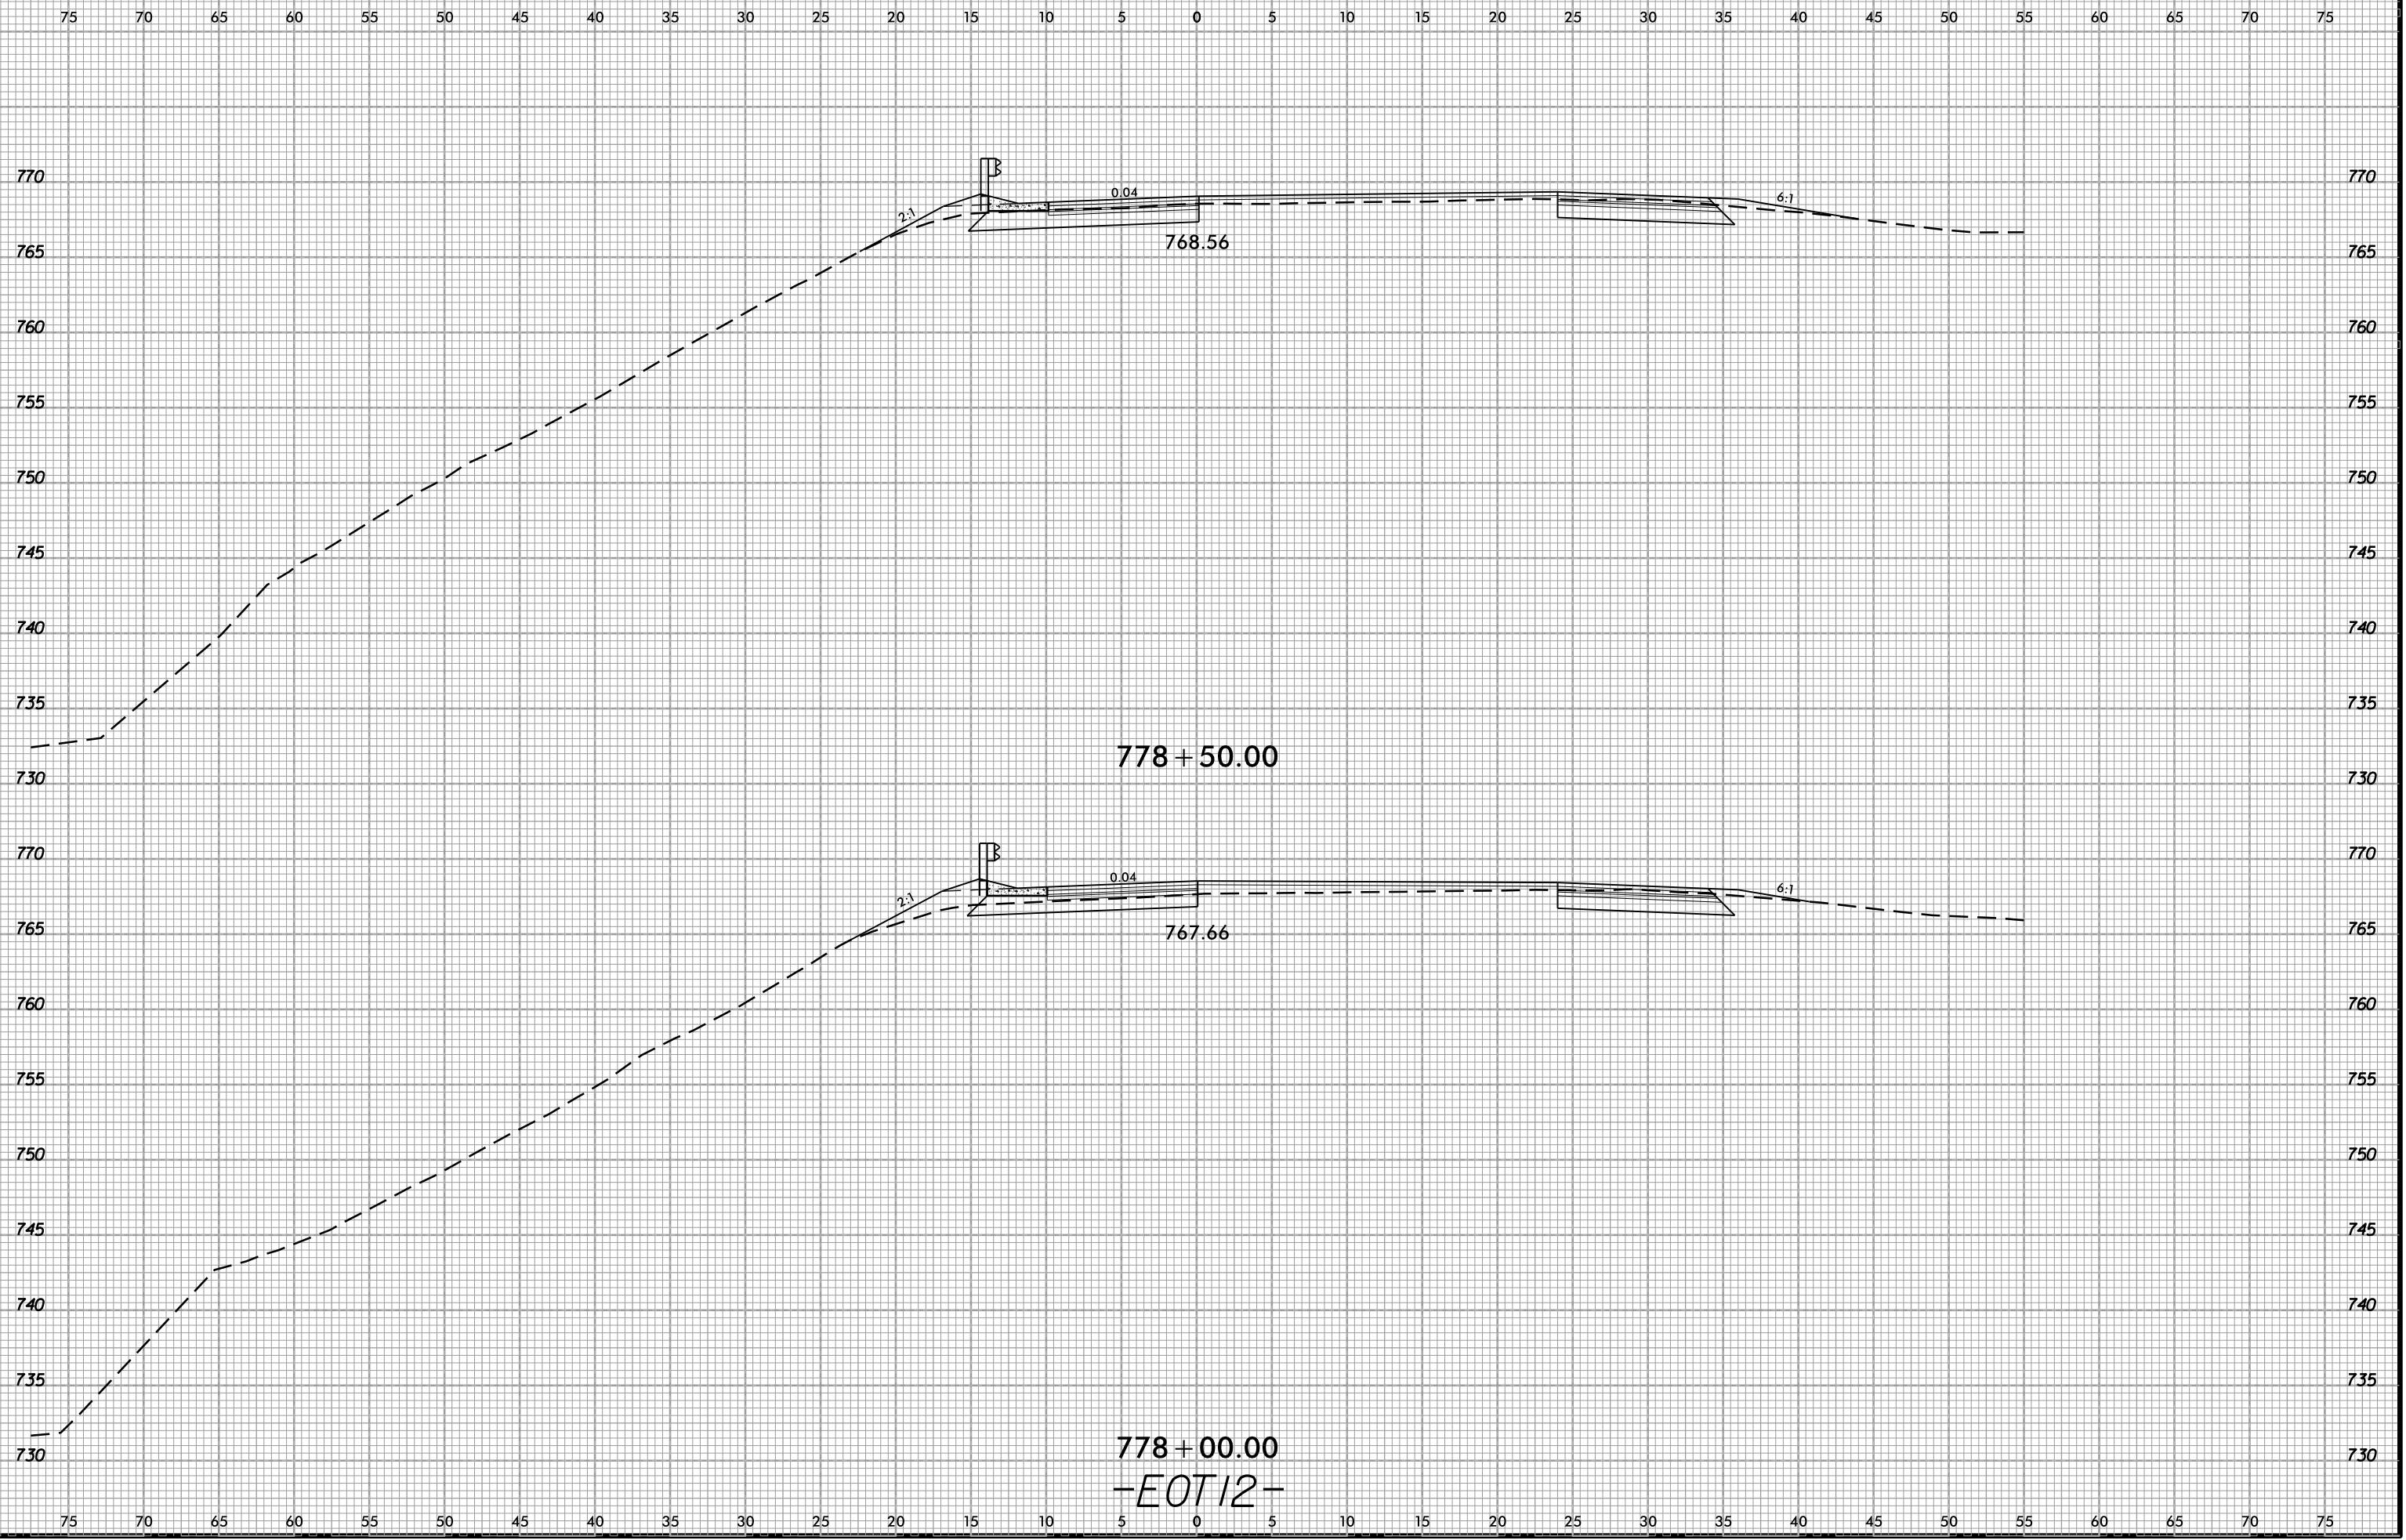

6/23/16  
02-NOV-2018 13:49  
S:\Projects-Development\JIP Projects\140-Dave\Roadway\DesignFiles\5823.ddc.xpl.EOT12.dgn  
AT DIV 29450

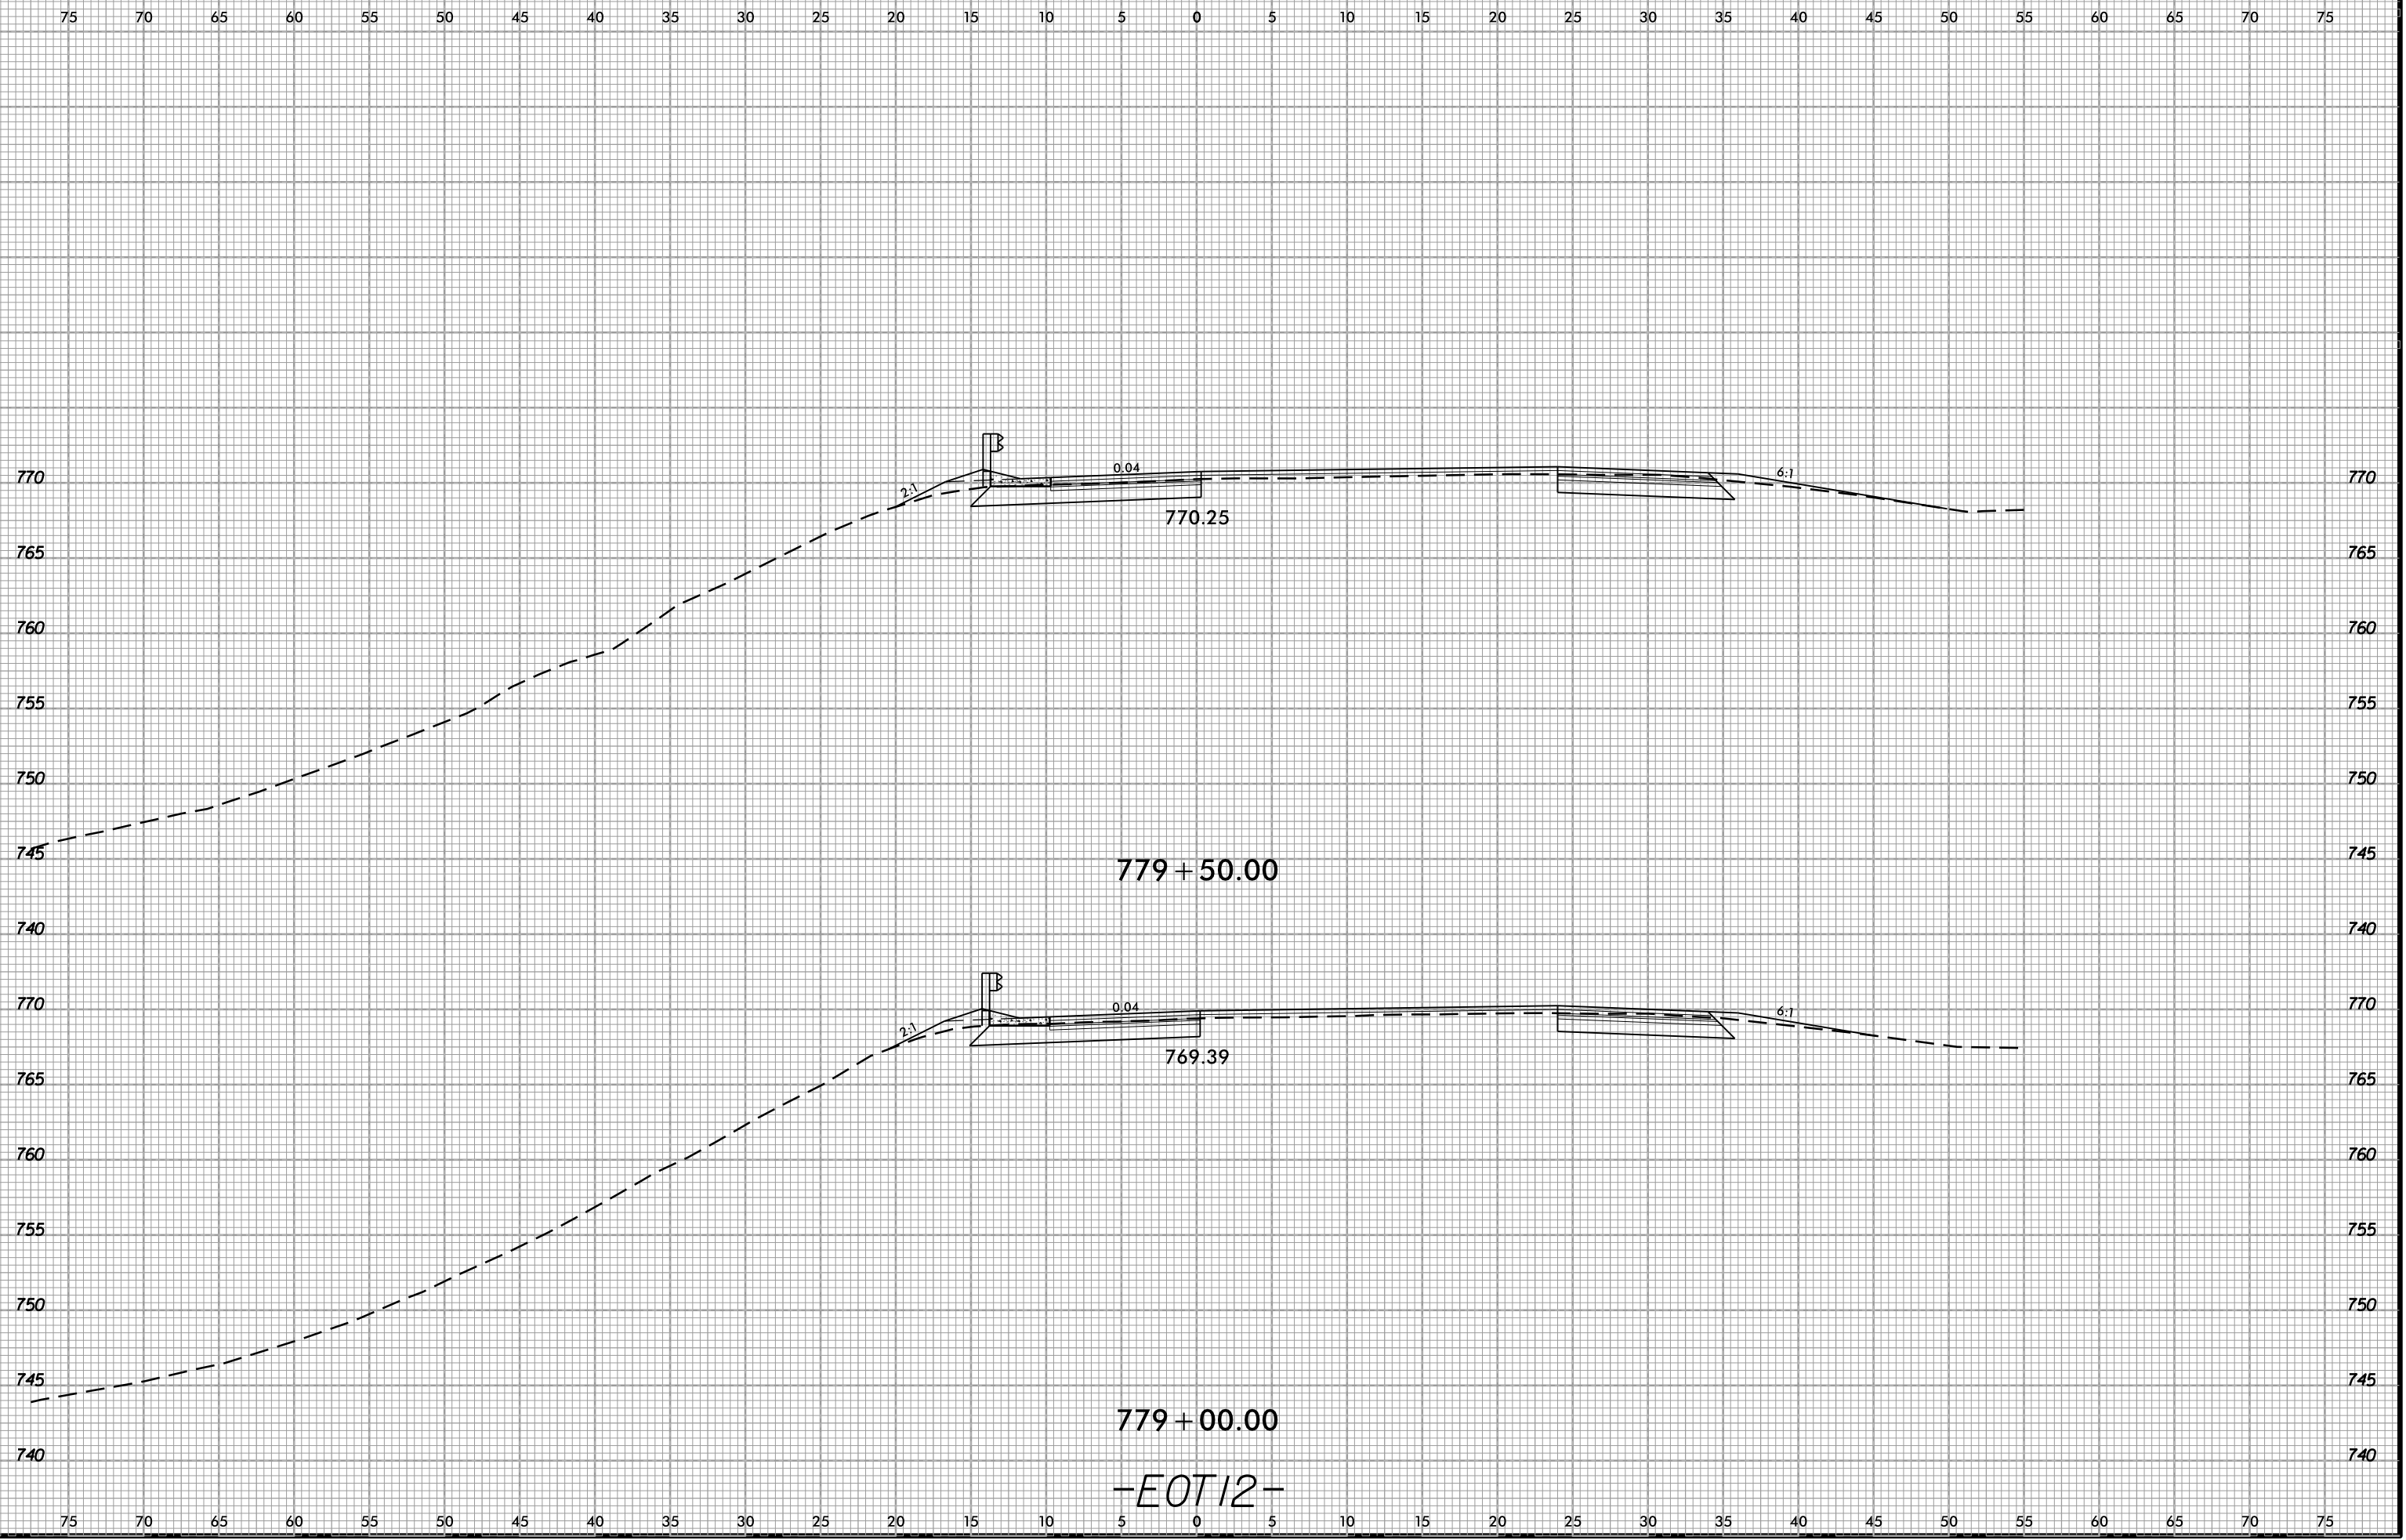

6/23/16  
02-NOV-2018 13:49  
S:\Projects-Development\IP Projects\140-Dave\Roadway\DesignFiles\5823.ddc.xpl.EOT12.dgn  
AT DIV 2450

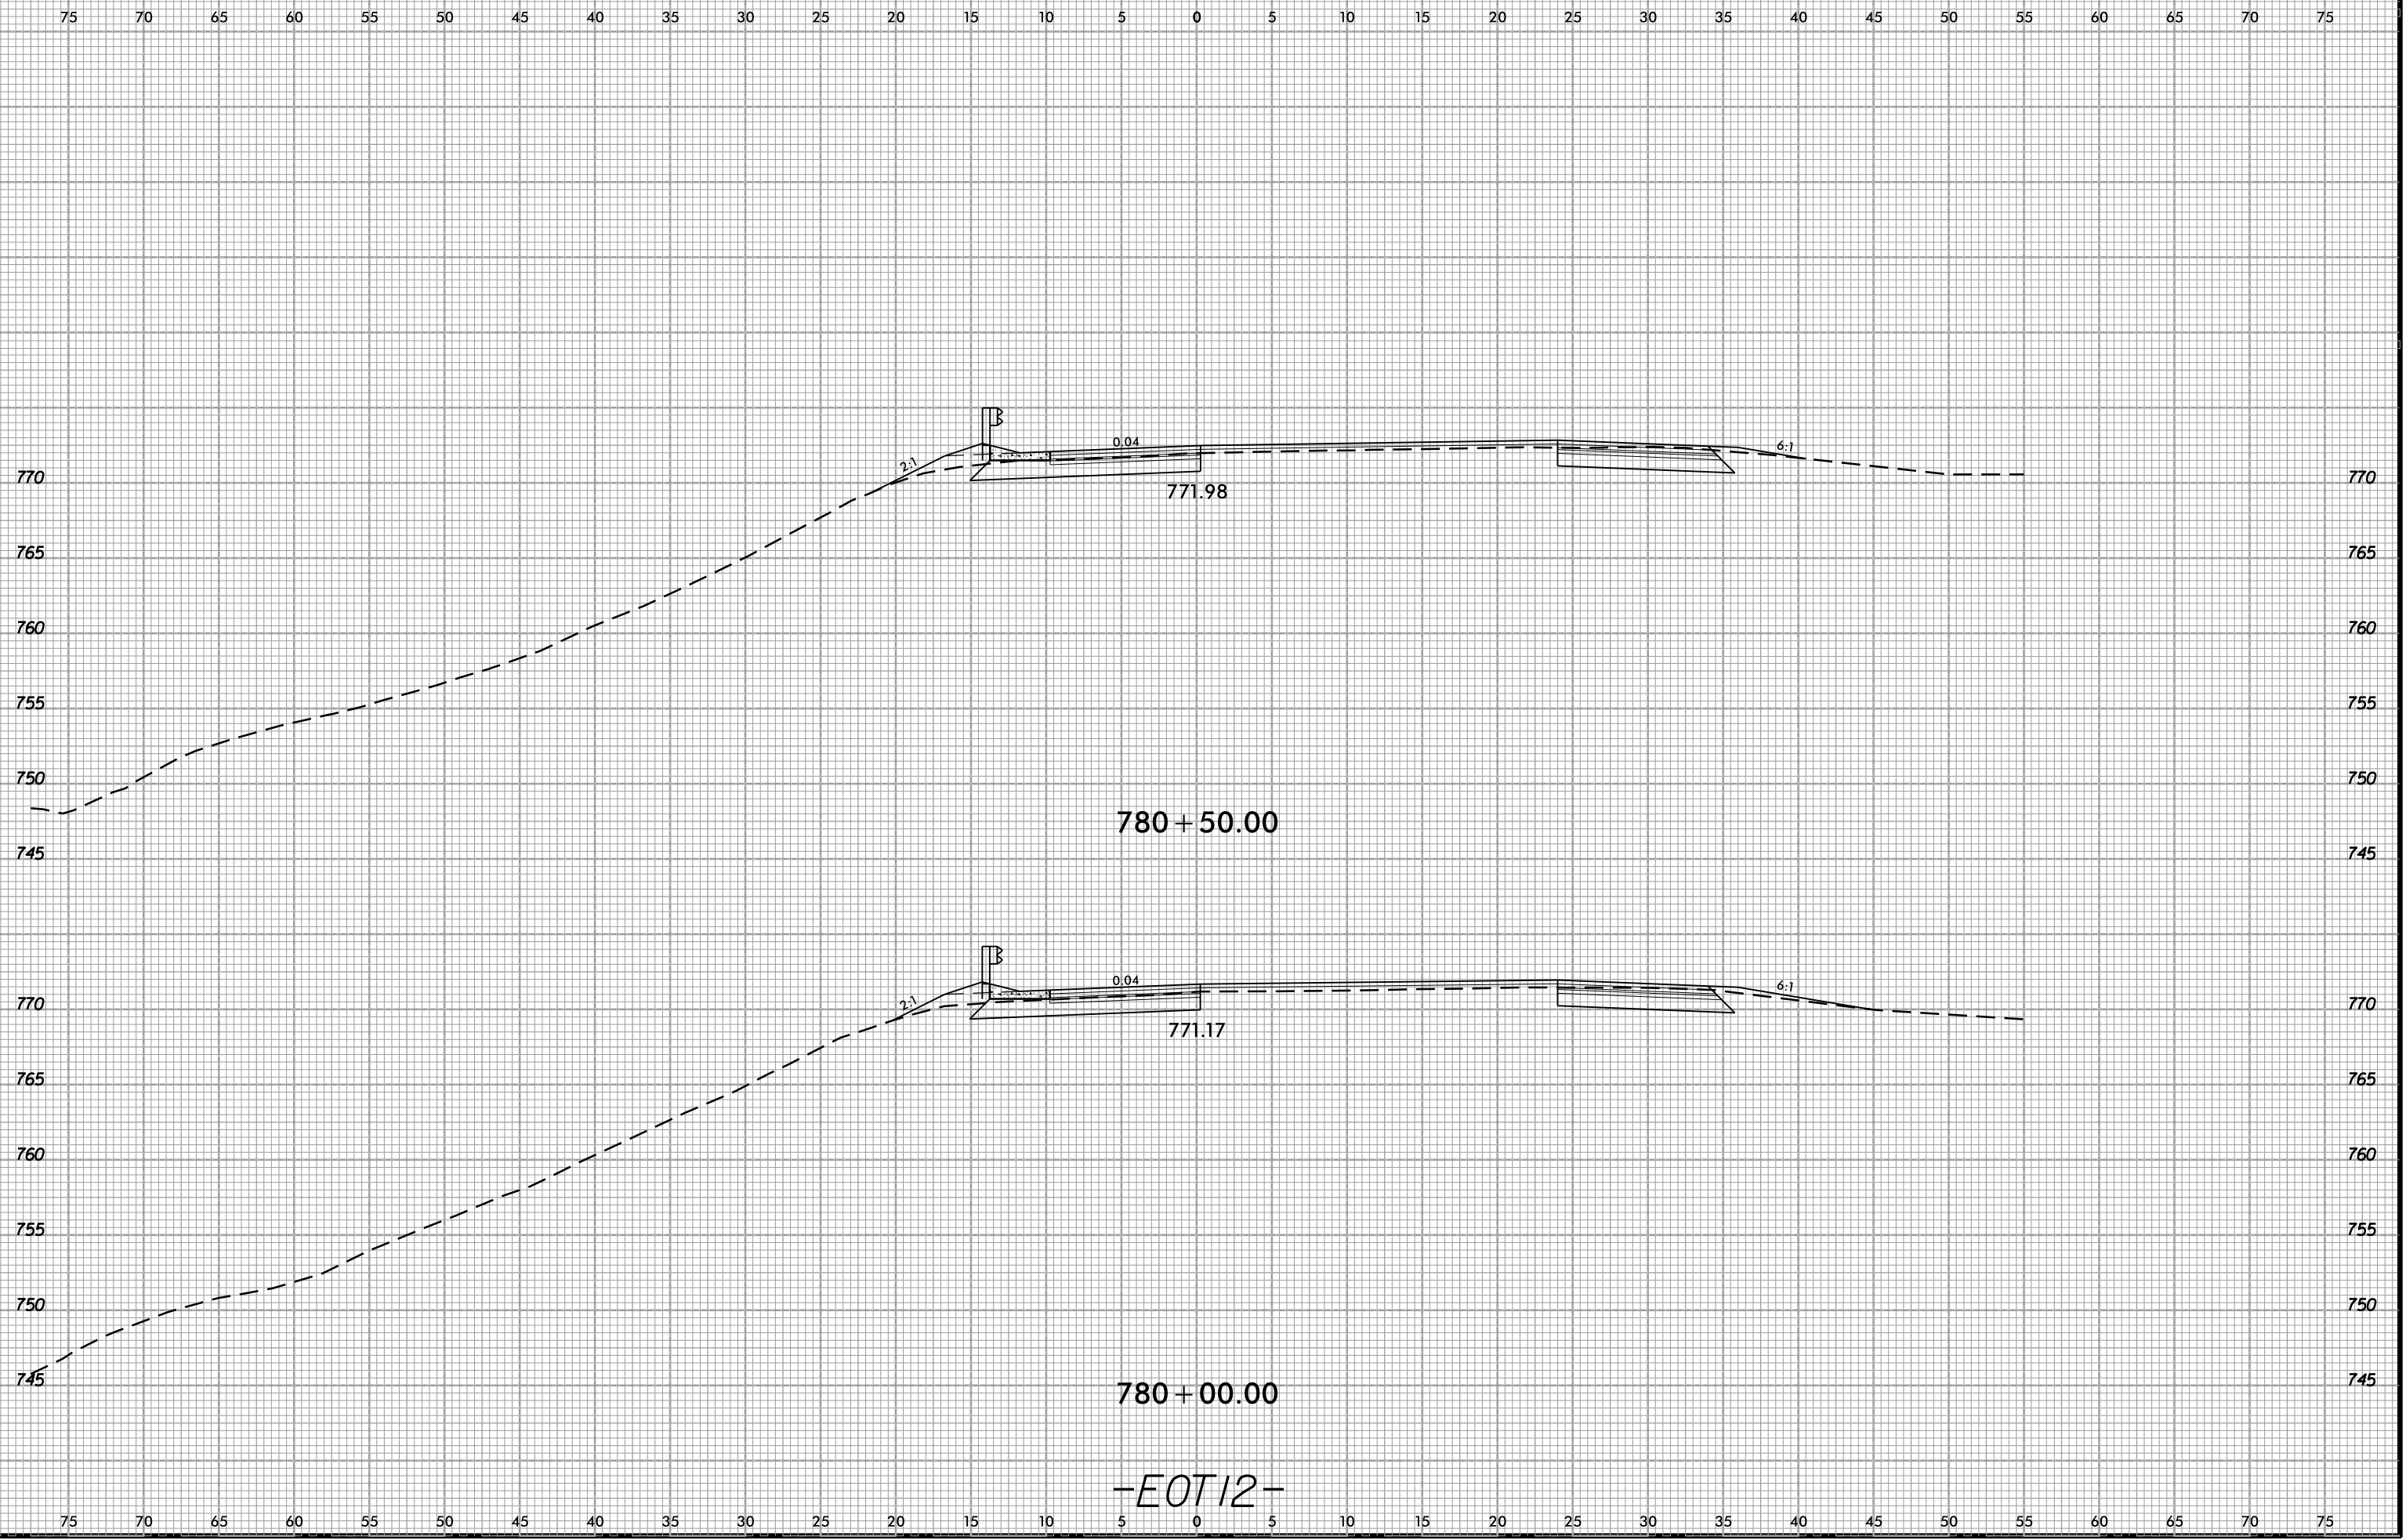

-EOT12-



02-NOV-2018 13:49  
S:\Project-Development\15823-140-Dave\Roadway\DesignFiles\15823.ddc.xpl.EOT12.dgn  
Ikeation AT DIV 29450

