


ALL REPORTS, PLANS SPECIFICATIONS AND COMPUTER FILES RELATING TO THIS PROJECT ARE THE PROPERTY OF CRABTREE, ROHRBAUGH & ASSOCIATES. CRABTREE, ROHRBAUGH & ASSOCIATES RETAINS ALL COMMON LAW, STATUTE AND OTHER RESERVED RIGHTS INCLUDING THE COPYRIGHT. THESE TO REPRODUCTION OF THE MATERIAL HEREIN OR SUBSTANTIAL USE WITHOUT WRITTEN PERMISSION OF CRABTREE, ROHRBAUGH & ASSOCIATES VIOLATES THE COPYRIGHT LAWS OF THE UNITED STATES AND WILL BE SUBJECT TO LEGAL PROSECUTION. © CRABTREE, ROHRBAUGH & ASSOCIATES, INC 2017

REVISIONS

NO.	DATE	BY	DESCRIPTION OF CHANGES

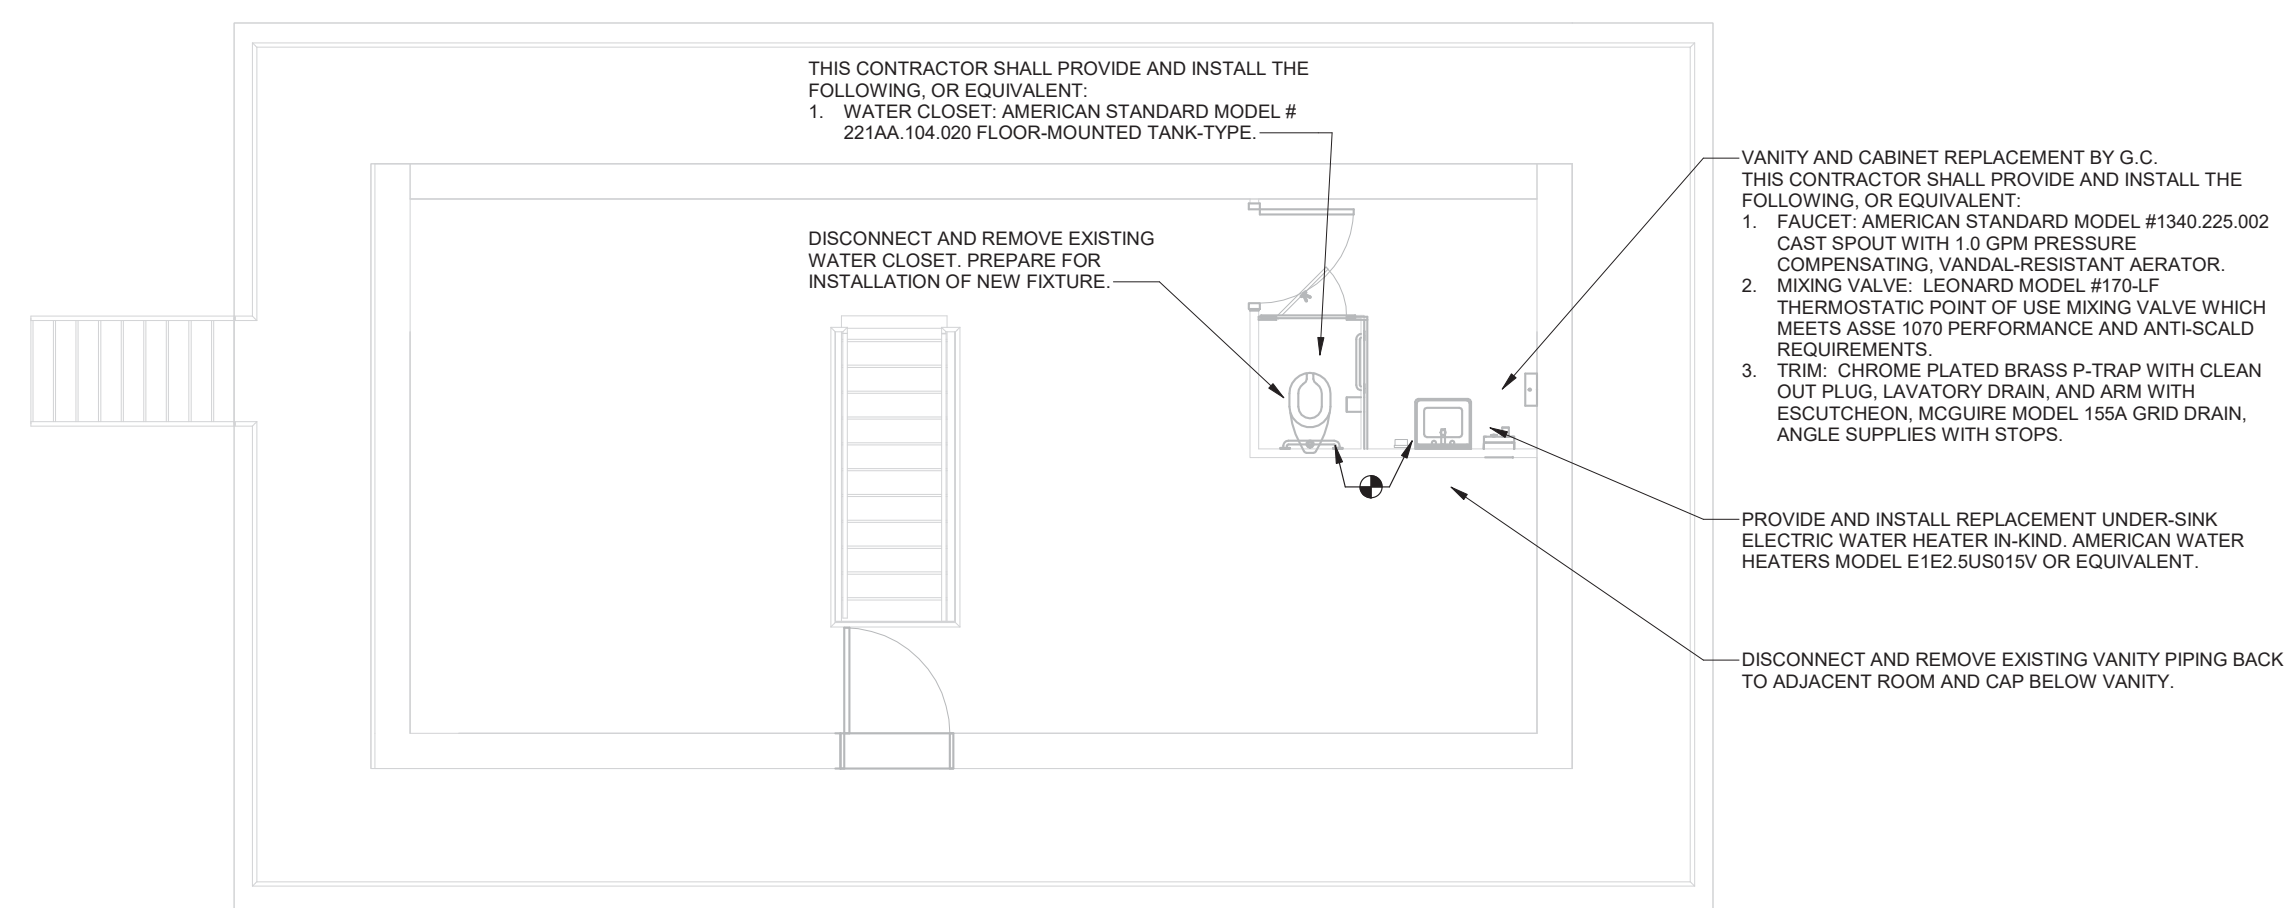

OVERALL CONTROL HOUSE LEVEL PLAN - PLUMBING
 2
 P1.1
 1/4" = 1'-0"

CRABTREE ROHRBAUGH & ASSOCIATES - ARCHITECTS
 401 EAST WINDING HILL ROAD
 MECHANICSBURG, PA 17055
 717-458-0272 FAX 717-458-0047
www.cra-architects.com



RENOVATIONS TO THE ISABEL HOLMES BRIDGE

OVERALL CONTROL HOUSE
 LEVEL AND ROOF PLANS -
 PLUMBING
 PLOT SCALE:
 1/4" = 1'-0"
 FILENAME:
 1876 Holmes Bridge NC Rev18
 PLUMB.rvt
 DATE:
 NOVEMBER 2, 2018

PROJECT
 3133
P1.1



610.398.0904
 barryisett.com