
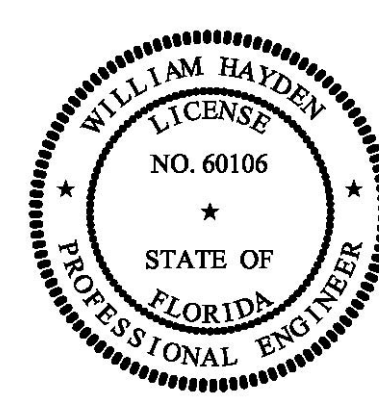
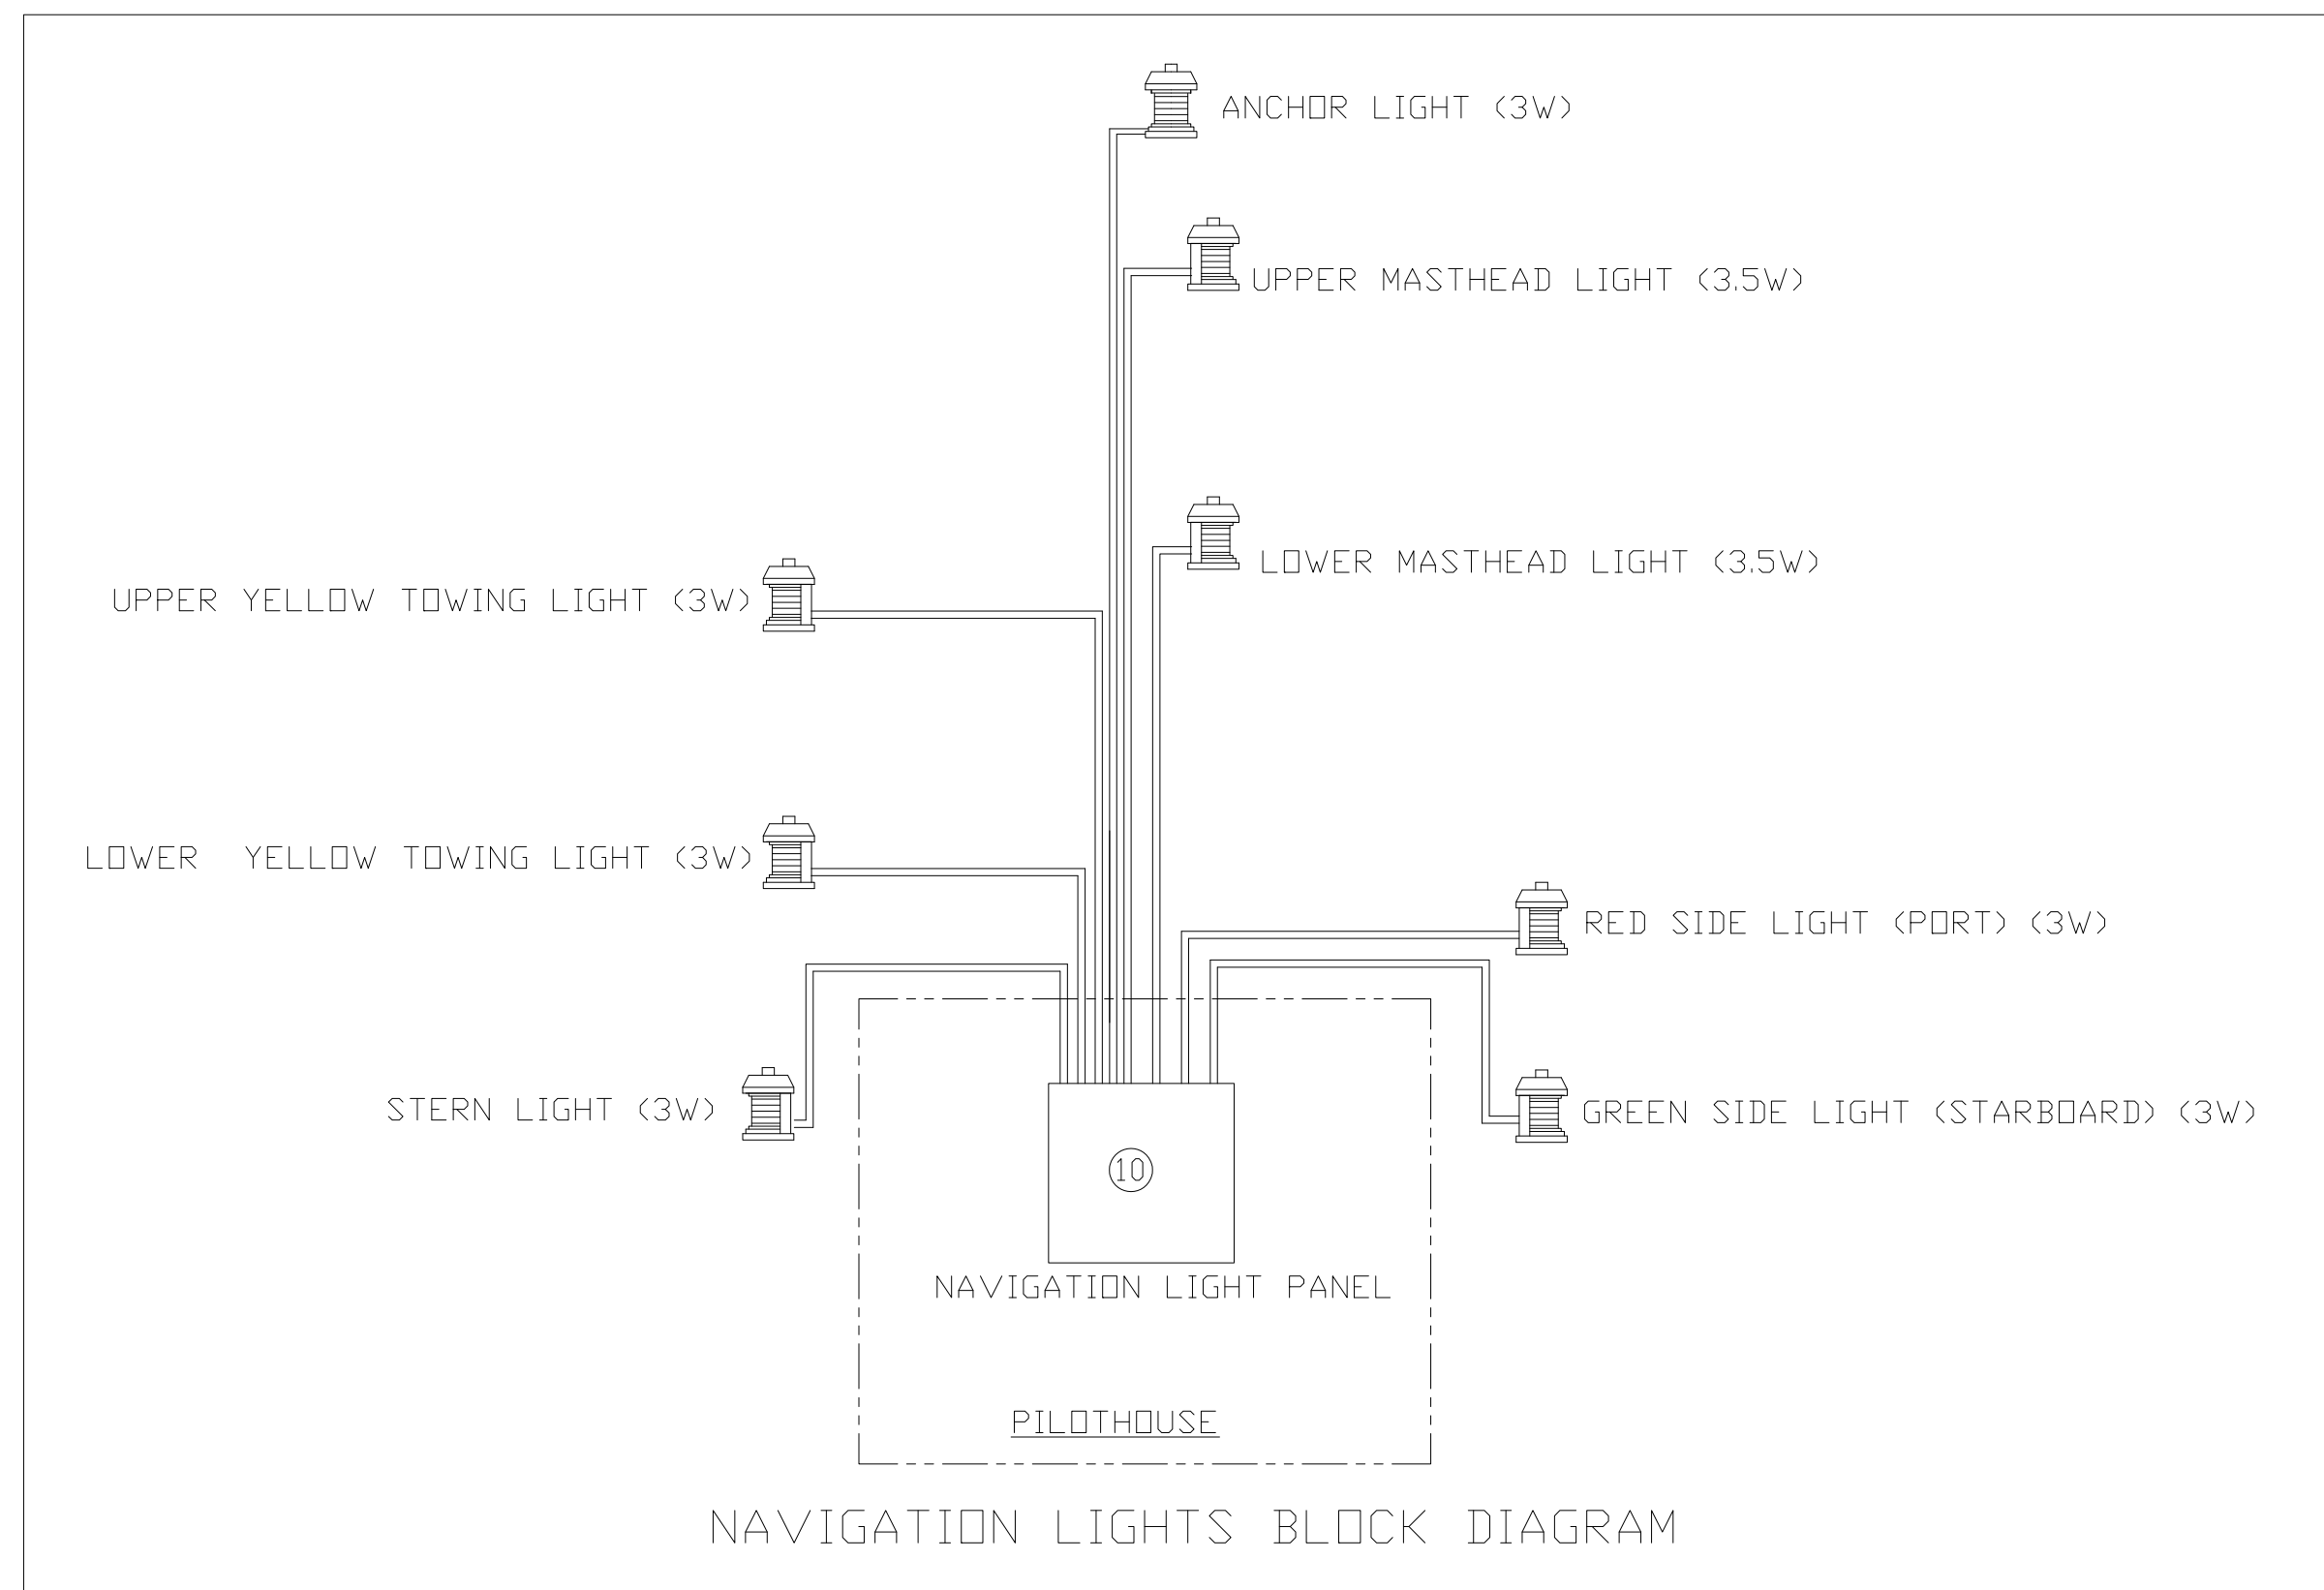


# BILL OF MATERIALS

## LIGHTING FIXTURE SCHEDULE

ITEM	QTY.	DESCRIPTION	MANUFACTURER #	ARC	VISIBILITY	REMARKS
1	1	ANCHOR LIGHT - WHT ALL AROUND	PERKD 0210SWBDP1	360°	2 MILES	OR EQUAL
2	1	UPPER MASTHEAD LIGHT, LED	PERKD 0210MBDDP1	225°	3 MILES	OR EQUAL
3	1	LOWER MASTHEAD LIGHT, LED	PERKD 0210MBDDP1	225°	3 MILES	OR EQUAL
4	1	GREEN SIDE LIGHT, LED	PERKD 0210SDBDP1	112.5°	2 MILES	OR EQUAL
5	1	RED SIDE LIGHT, LED	PERKD 0210PDBDP1	112.5°	2 MILES	OR EQUAL
6	2	YELLOW TOWING LIGHTS, SINGLE LENS ,LED	PERKD 0210PDBDP1	135°	2 MILES	OR EQUAL
7	1	WHITE STERN LIGHT, LED	PERKD 0210SNBDP1	135°	2 MILES	OR EQUAL
8	1	SEARCHLIGHT, 8", 12 VOLT, SEALED BEAM CHROME PLATED, LEVER CONTROL	PERKD 0314C0812V			
9	4	FLOODLIGHT, LED, 1000 LUMEN	LUMITEC 101334			OR EQUAL
10	1	NAVIGATION LIGHT PANEL, 8 SINGLE LAMP CIRCUITS	J-BOX NLFM8S12VDC-PFA			OR EQUAL
11	1	HORN LIGHT - WHT ALL AROUND	PERKD 0210SWBDP1	360°	2 MILES	OR EQUAL
12	1	FREEZE WARNING LT - BLUE ALL AROUND	-	360°	2 MILES	24 VDC

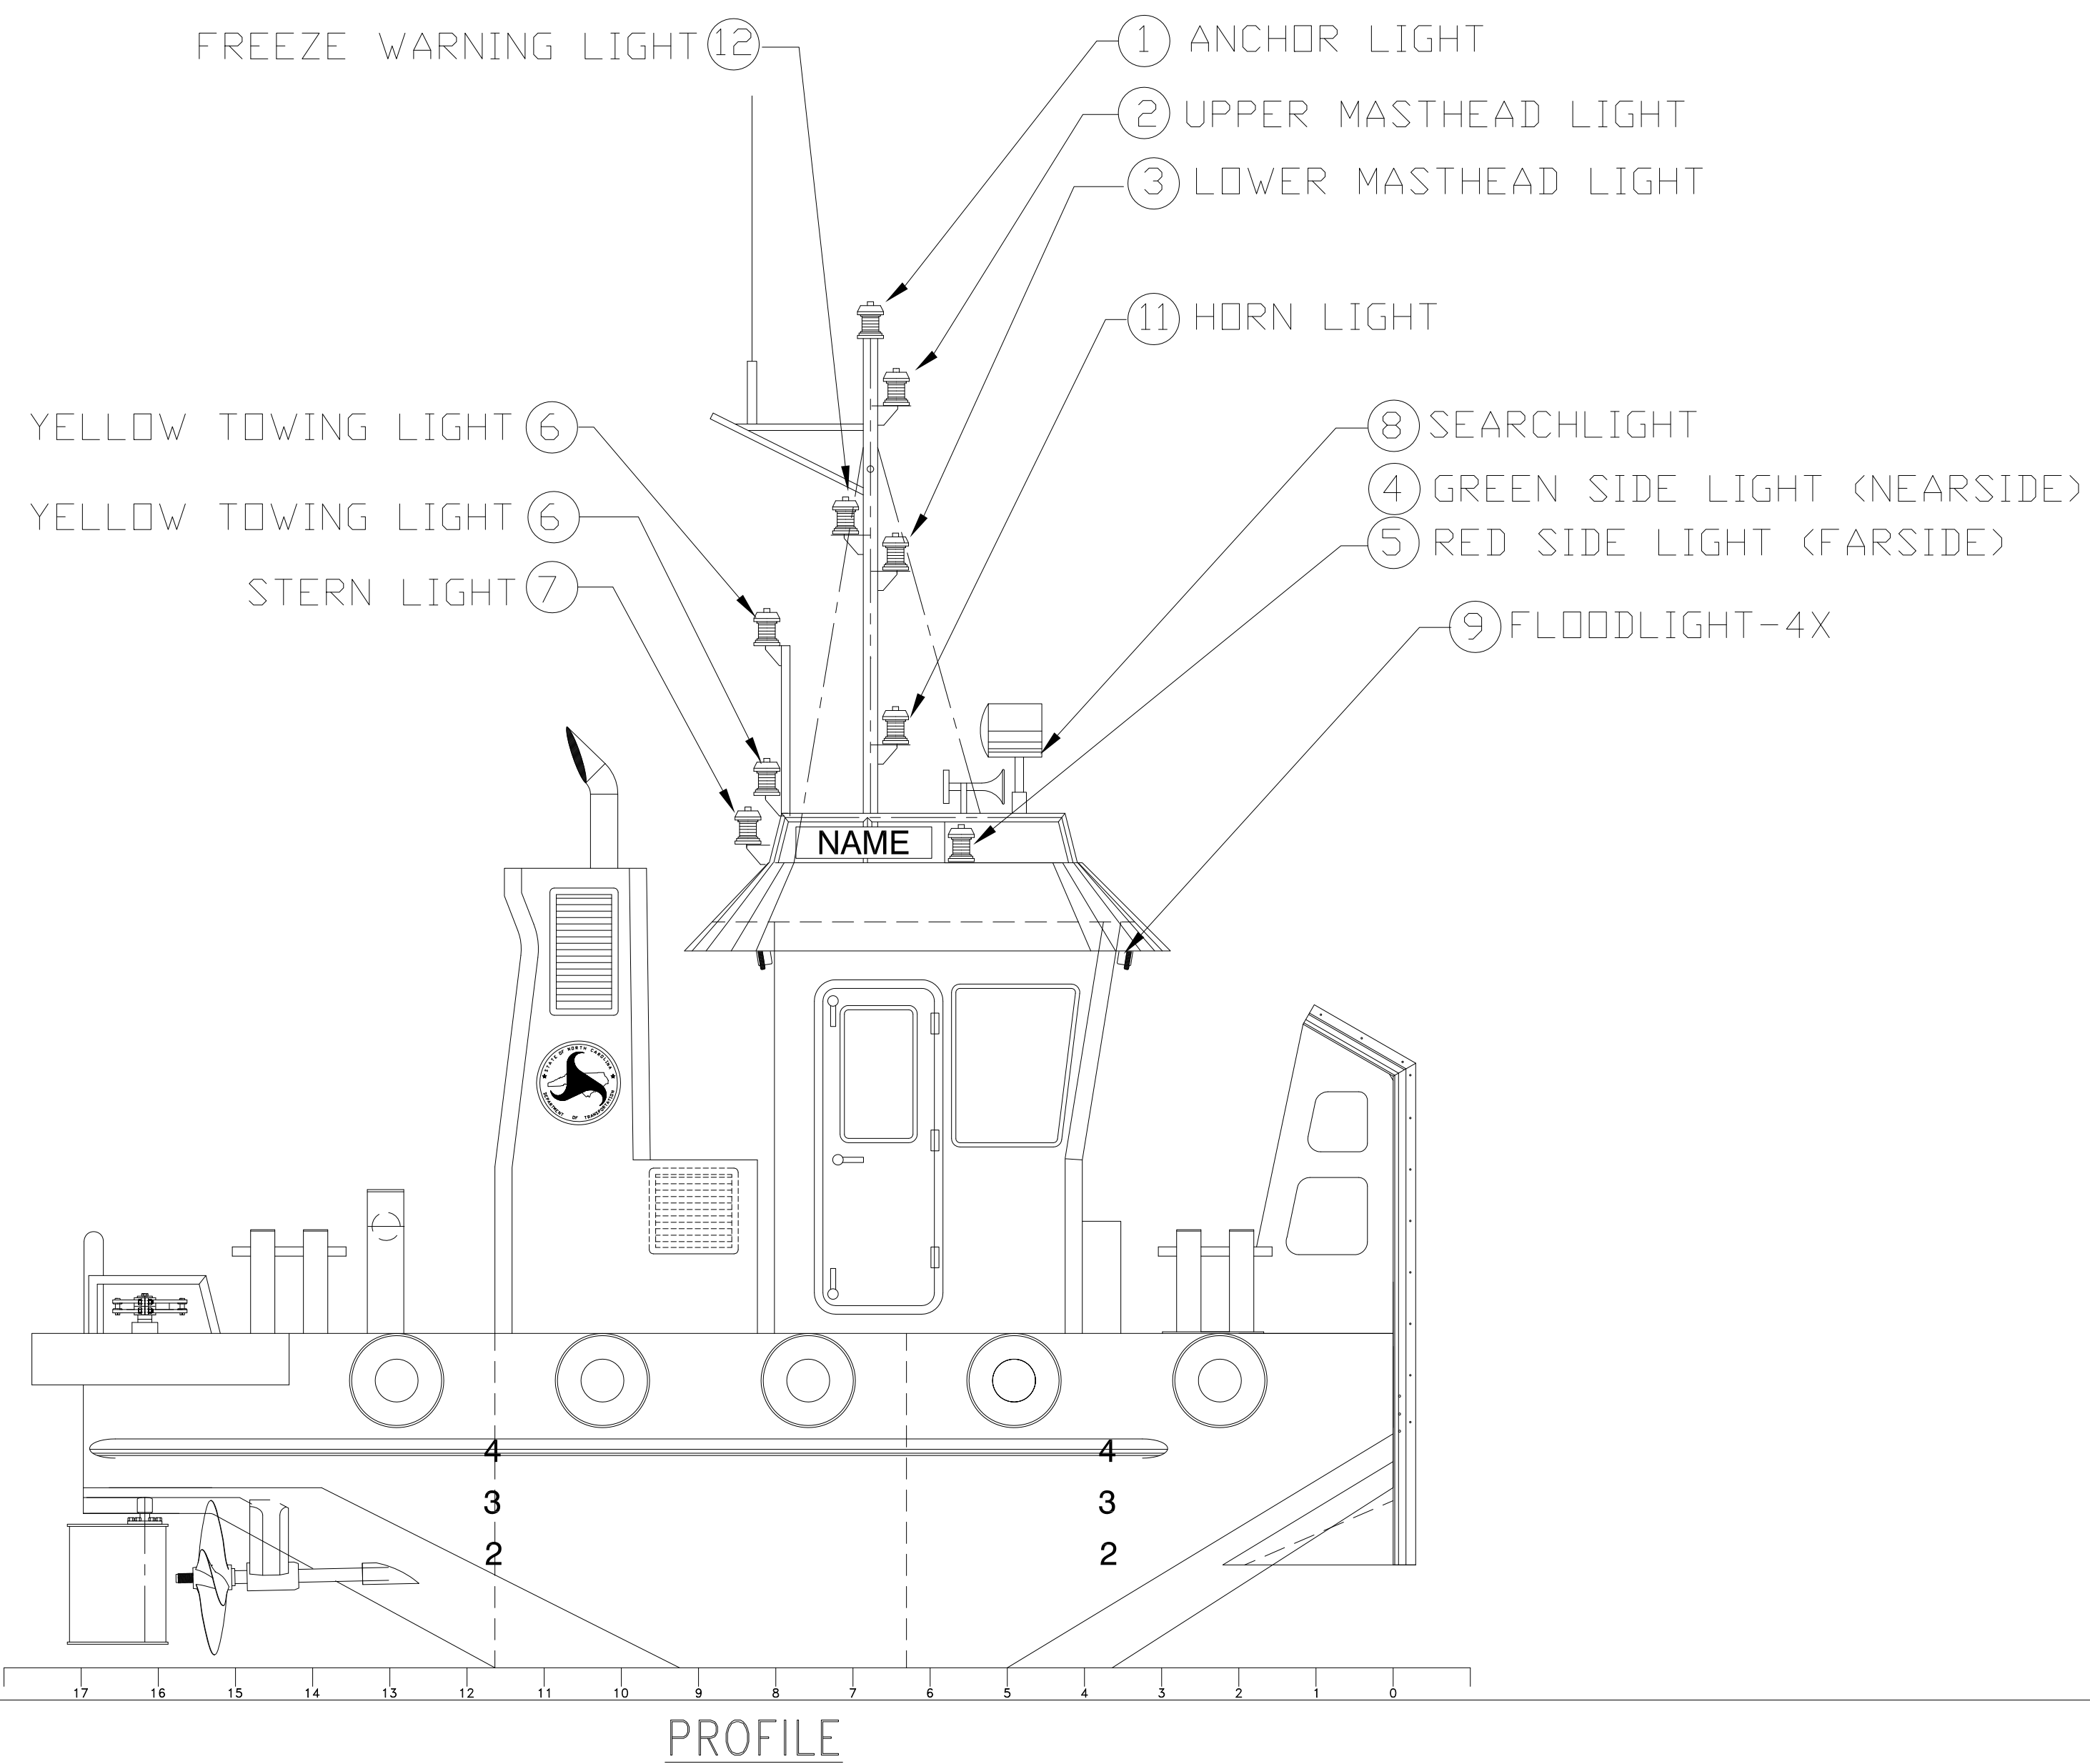

This document discloses neither in which DeJong & Lebet, Incorporated has proprietary rights, neither confers any possession thereof, neither on transfer nor right to reproduce, disclose or use in any manner this document in whole or in part or any information contained therein, except by written permission, or written agreement with DeJong & Lebet, Incorporated.

In the event of a purchase of this document the purchaser is authorized to contract no more than one device to occur herewith, unless otherwise agreed to in writing by DeJong & Lebet, Incorporated.

© 2018 by DeJong & Lebet, Inc.

**DeJong & Lebet, Inc.**  
 Naval Architects  
 Marine Engineers  
 Consultants  
 Surveyors

1724 Emerson Street  
 Jacksonville, Florida 32207  
 www.dejongandlebet.com

Phone: (904) 399-3673  
 Fax: (904) 399-1522  
 info@dejongandlebet.com

Title: 25.5'x16'x6.5' NCDOT PUSHBOAT

**NAVIGATION/SEARCH/FLOODLIGHTS  
 & NAV. LTS. BLOCK DIAGRAM**

Dwg. No. **1393B-422** Alt. No. 0  
 Sht. 1 of 1

Drawn By: **JACOB CONNALLY** Date: **JANUARY 2, 2019**  
 Checked By: \_\_\_\_\_ Date: \_\_\_\_\_  
 App'd By: \_\_\_\_\_ Scale: **1/2" = 1'-0"**  
 ABS App'l: \_\_\_\_\_ USCG App'l: \_\_\_\_\_