

**This electronic collection of documents is provided
for the convenience of the user
and is Not a Certified Document –**

**The documents contained herein were originally issued
and sealed by the individuals whose names and license
numbers appear on each page, on the dates appearing
with their signature on that page.**

**This file or an individual page
shall not be considered a certified document.**

09/08/09

TIP PROJECT: R-5707

STATE OF NORTH CAROLINA
DIVISION OF HIGHWAYS


T.I.P. NO.	SHEET NO.
R-5707	UO-1

NOTE:
ALL UTILITY WORK SHOWN ON THIS SHEET IS DONE BY OTHERS.
NO PAYMENT WILL BE MADE TO THE CONTRACTOR FOR UTILITY WORK SHOWN ON THIS SHEET.


GRANVILLE COUNTY UTILITIES BY OTHERS

LOCATION: NC 56 (W. LAKE ROAD & W. WILTON AVENUE)
AT US 15 (N. DURHAM AVENUE) AND NC 50 IN CREEDMOOR

TYPE OF WORK: POWER, GAS, AND COMMUNICATIONS RELOCATION

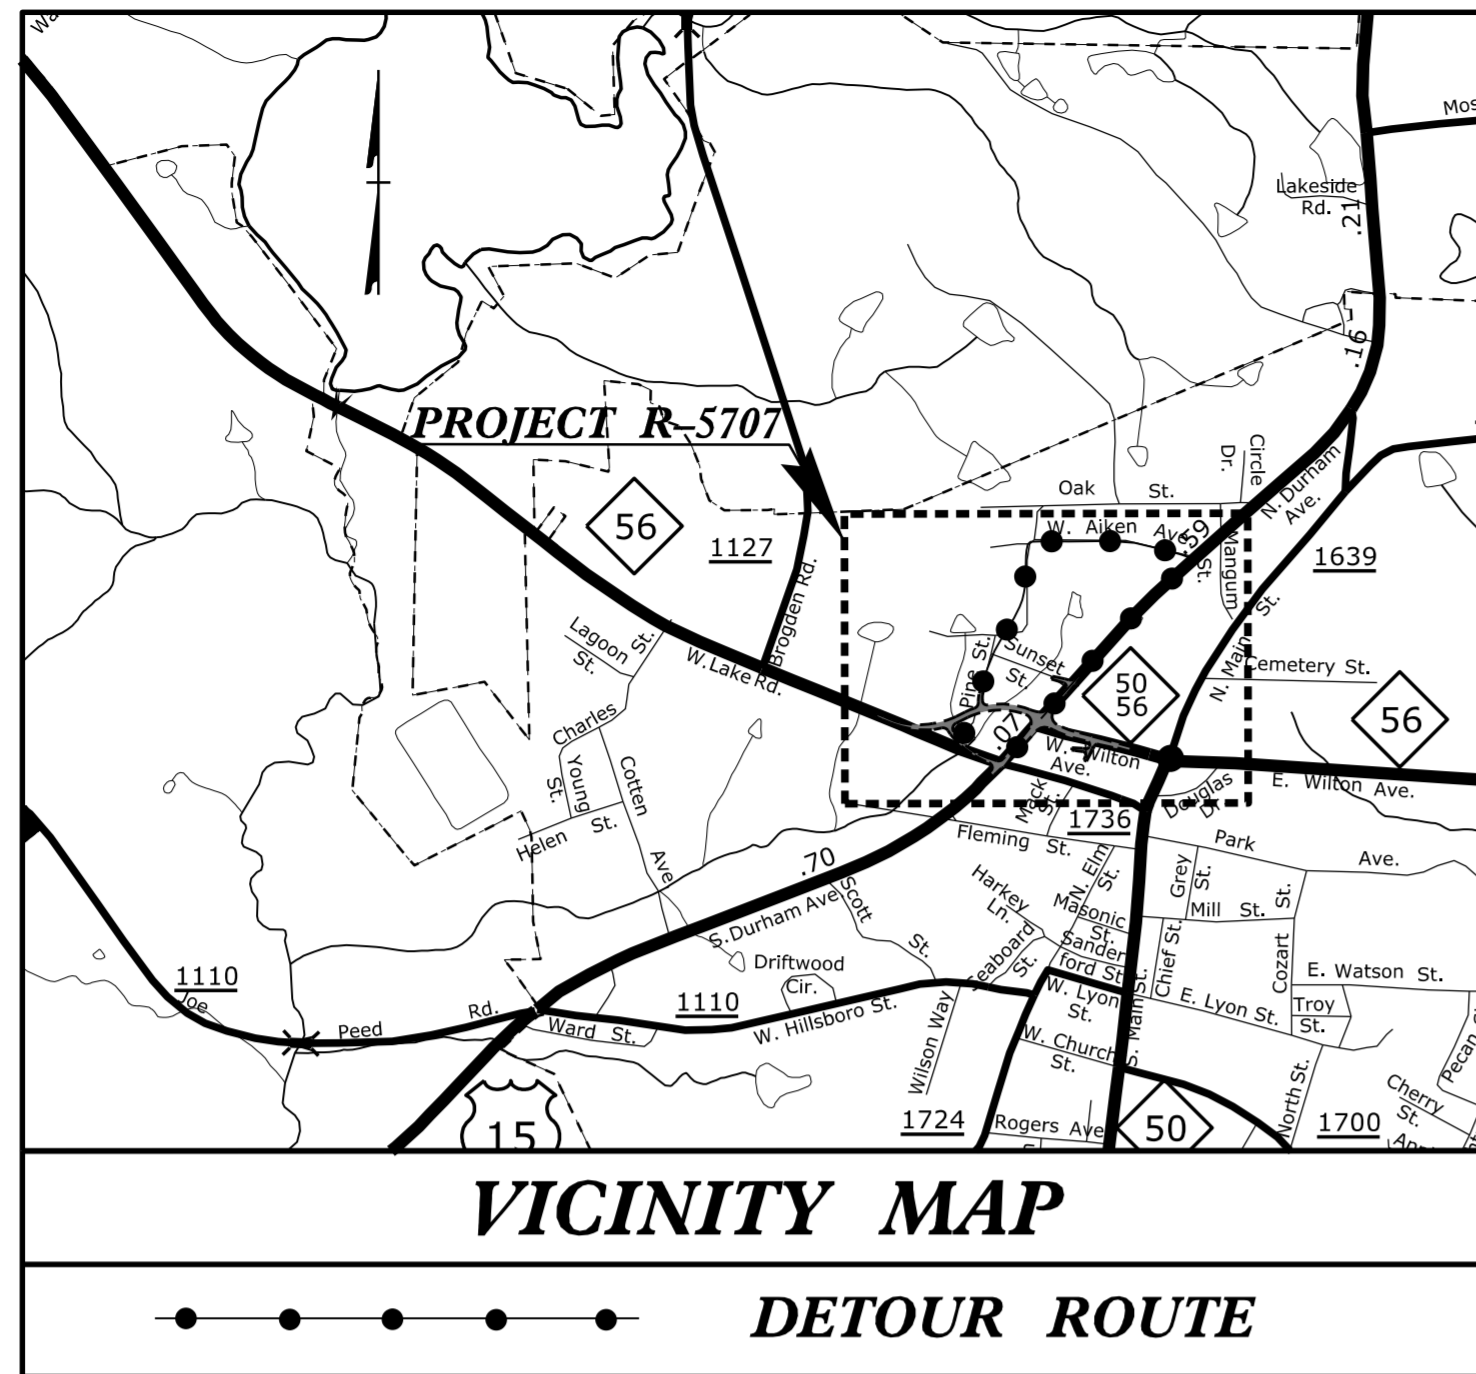


BEGIN TIP PROJECT R-5707
-L- STA. 16 + 30.00

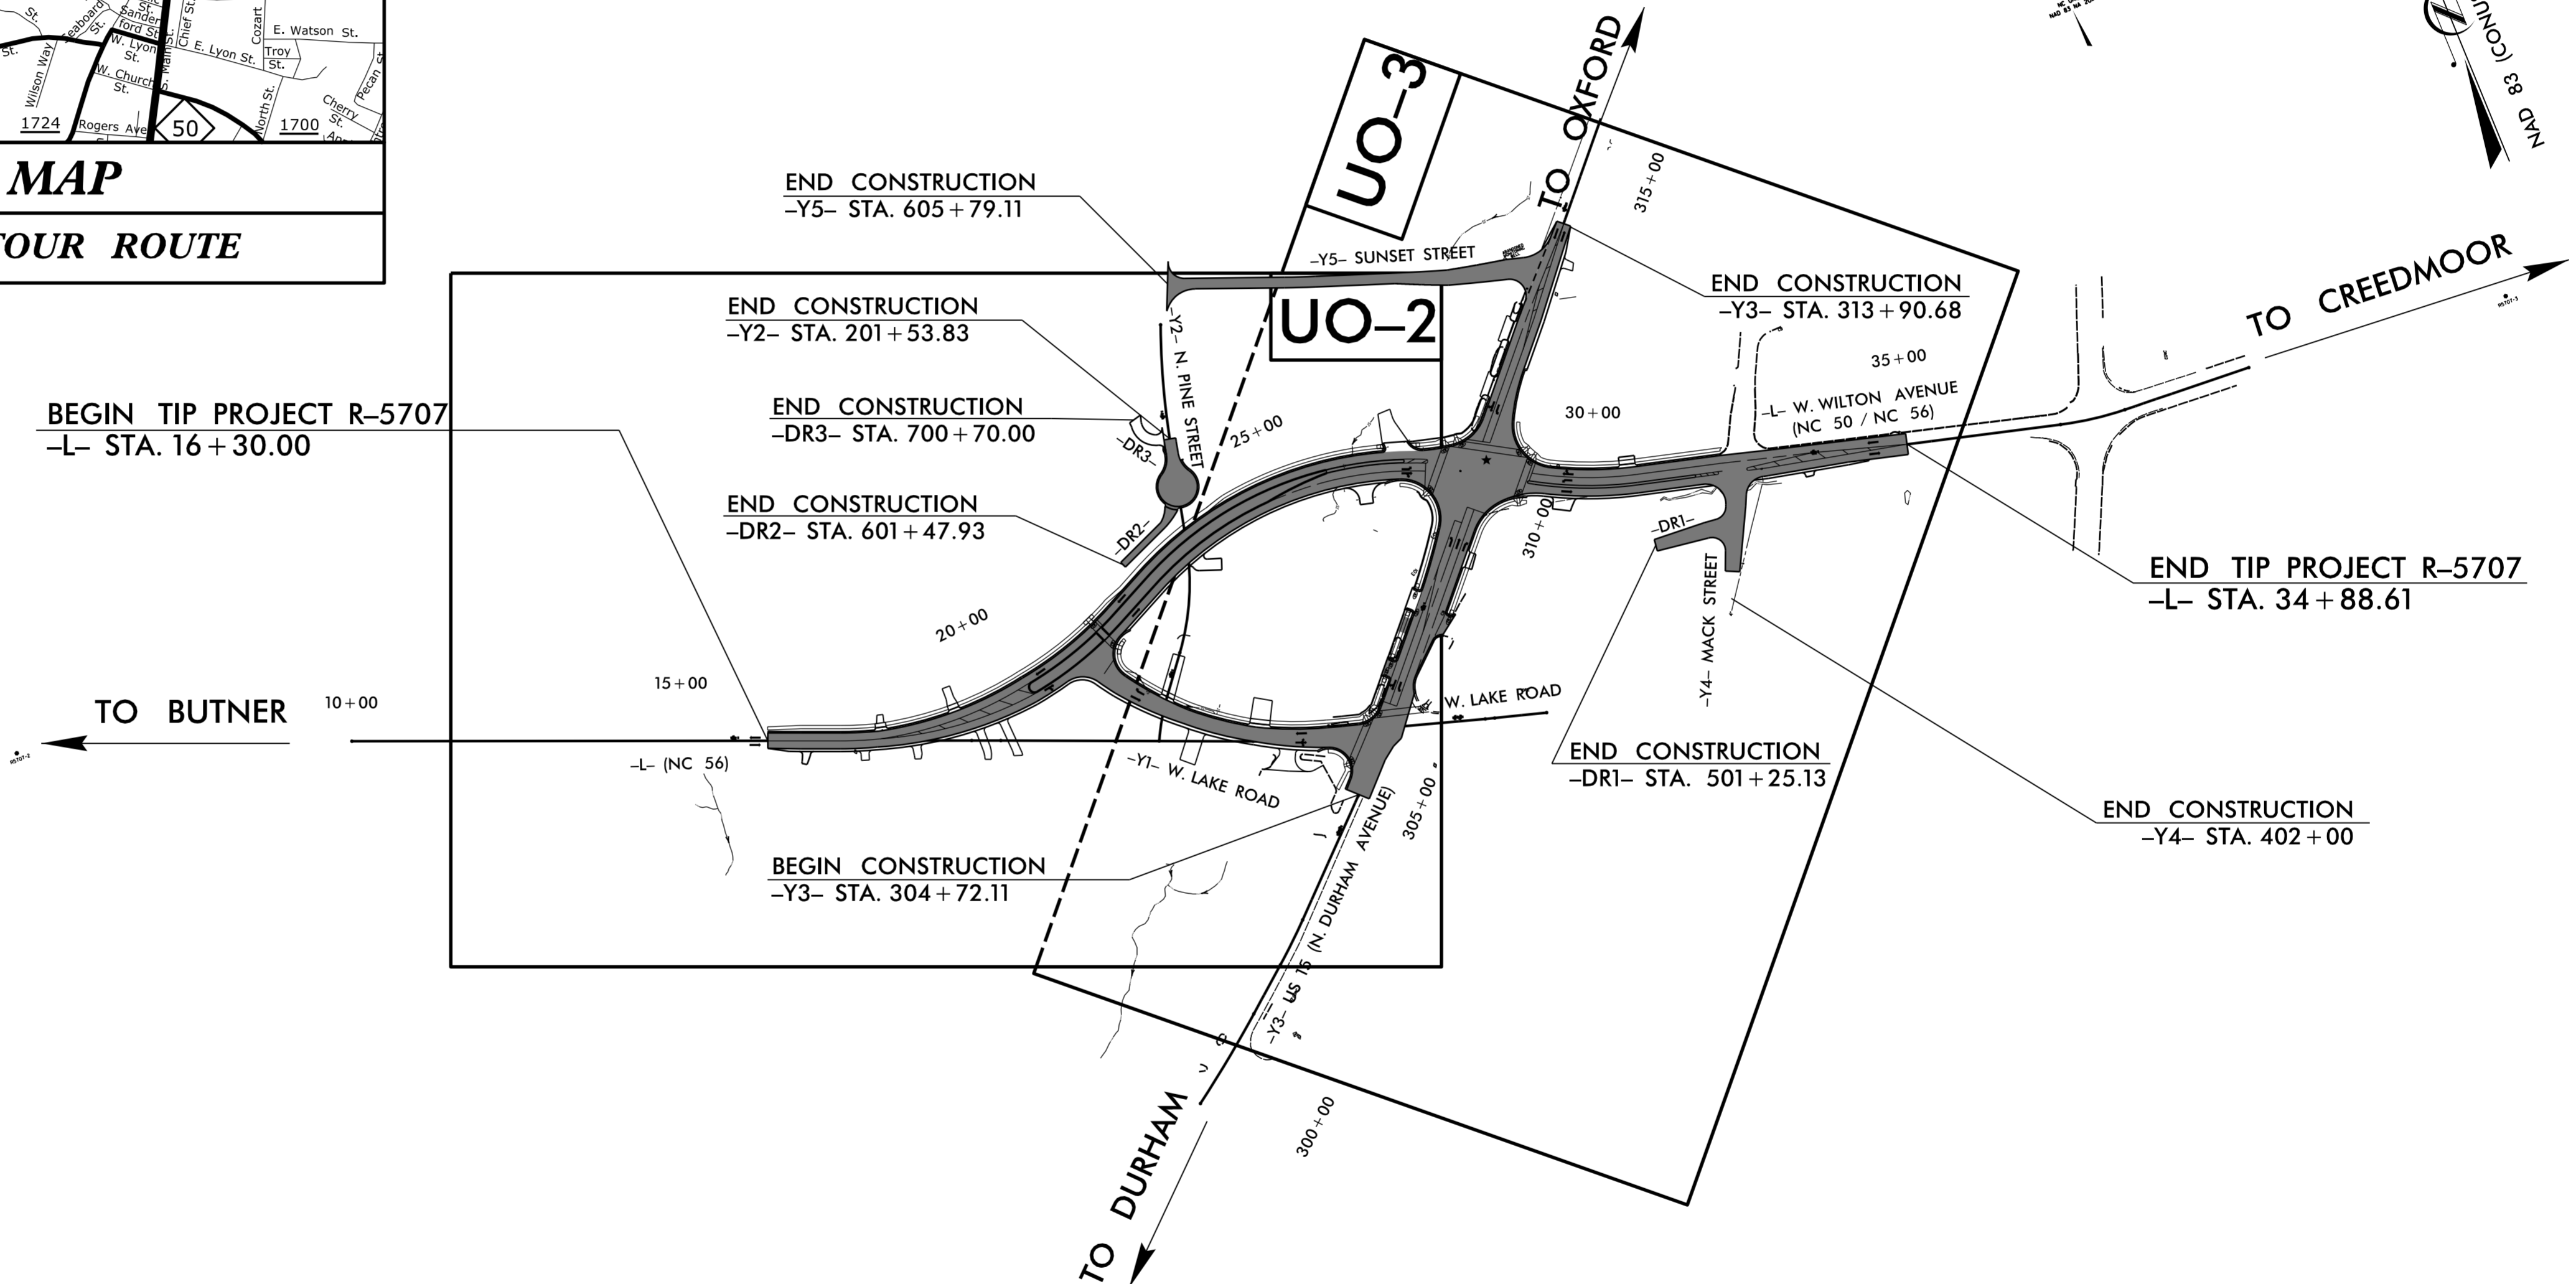

END TIP PROJECT R-5707
-L- STA. 34 + 88.61

THIS PROJECT IS WITHIN THE MUNICIPAL BOUNDARIES OF THE TOWN OF CREEDMOOR.

GRAPHIC SCALES

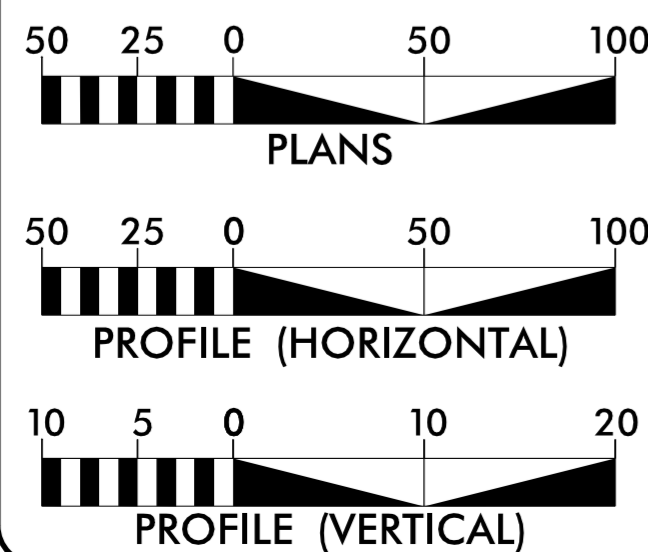

INDEX OF SHEETS

SHEET NO.:	DESCRIPTION:
UO-1	TITLE SHEET
UO-2 THRU UO-3	UBO PLAN SHEETS

UTILITY OWNERS WITH CONFLICTS

- (A) POWER - DUKE ENERGY
- (B) GAS - PSNC
- (C) CABLE - CHARTER
- (D) TELEPHONE - FRONTIER
- (E) WATER & SEWER - S. GRANVILLE WATER & SEWER AUTHORITY

PREPARED IN THE OFFICE OF:



3220 GLEN ROYAL RD. RALEIGH, NC 27617
TELE 919.788.0224 FAX 919.788.0232
NC LICENSE #P-0189

Mary Jo Lee UTILITY PROJECT MANAGER
Eric Tweed PROJECT UTILITY COORDINATOR



DIVISION OF HIGHWAYS
DIVISION 5
PROJECT DELIVERY UNIT
815 STADIUM DRIVE
DURHAM, NC 27704

Ben Upshaw, PE TEAM LEAD
S. Reid Davidson, PE DDC ENGINEER
Donald Proper DIVISION 5 UTILITIES ENGINEER
Monroe Brown UTILITY COORDINATOR

I:\21\2019\RA\Utilities\Engineering\UBO\Proj\R5707_ut_tsh_UO01_psh.dgn
USER:NAME

UTILITIES BY OTHERS




3220 GLEN ROYAL RD. RALEIGH, NC 27617
 TELE 919.788.0224 FAX 919.788.0232
 NC LICENSE #P-0189

NONADJ. 1683
 2011

MATCHLINE A
 STA. 25+00.00
 SEE SHEET UO-3

MATCHLINE B
 STA. 102+00.00
 SEE SHEET UO-3

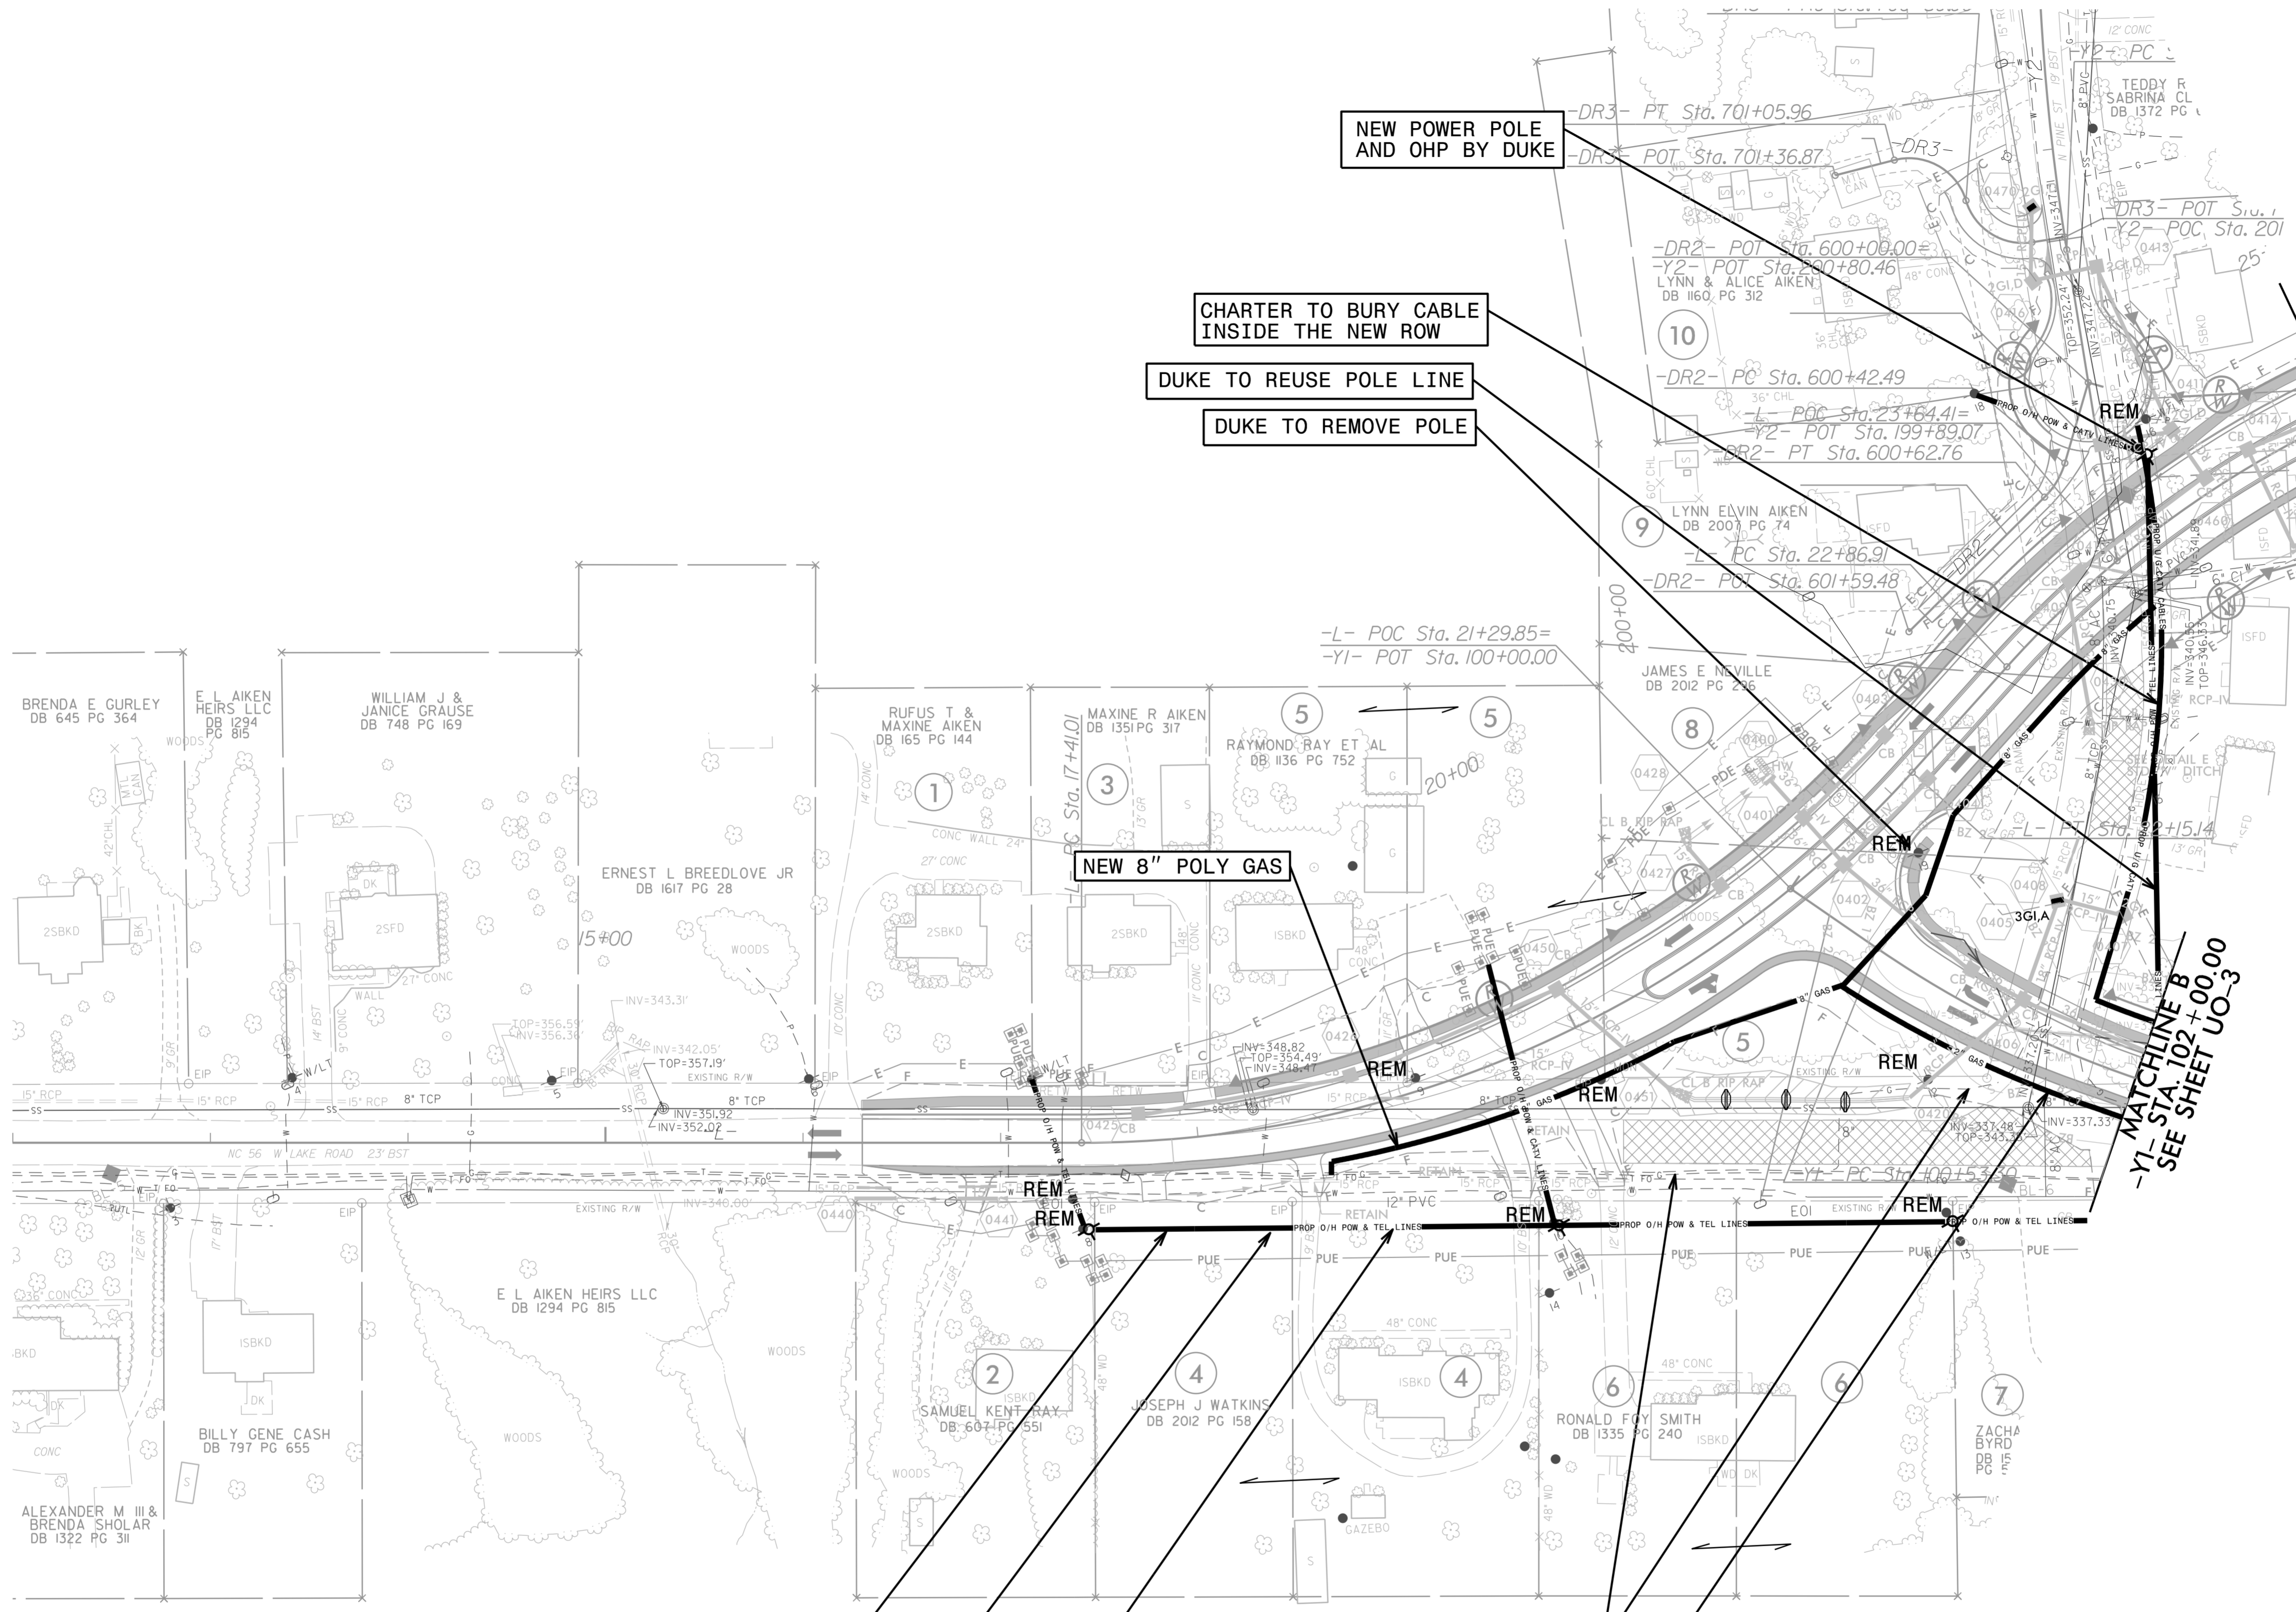

NEW POWER POLE AND OHP BY DUKE

CHARTER TO BURY CABLE INSIDE THE NEW ROW

DUKE TO REUSE POLE LINE

DUKE TO REMOVE POLE

NEW 8" POLY GAS

PSNC TO ABANDON EX. 8" POLY

NEW POWER POLE ALIGNMENT AND OHP BY DUKE

CHARTER TO RELOCATE TO DUKE'S POLES

FRONTIER TO RELOCATE TO DUKE'S POLES

NEW 2" POLY GAS


ALL PROPOSED GAS TO BE INSTALLED PER APPROVED ENCROACHMENT AGREEMENT

NOTE:
 ALL PROPOSED UTILITY WORK SHOWN ON THIS SHEET WILL BE DONE BY OTHERS. NO PAYMENT WILL BE MADE TO THE CONTRACTOR FOR PROPOSED UTILITY WORK SHOWN ON THIS SHEET.



8/17/09

K:\2018\Projects\Engineering\UBO\ProJ\R5707-ut.rdy\04_uc02.psh.dgn
 11/15/2018 11:58:11 AM

UTILITIES BY OTHERS

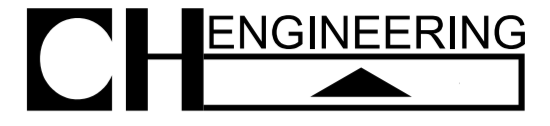

3220 GLEN ROYAL RD. RALEIGH, NC 27617
 TELE 919.788.0224 FAX 919.788.0232
 NC LICENSE #P-0189

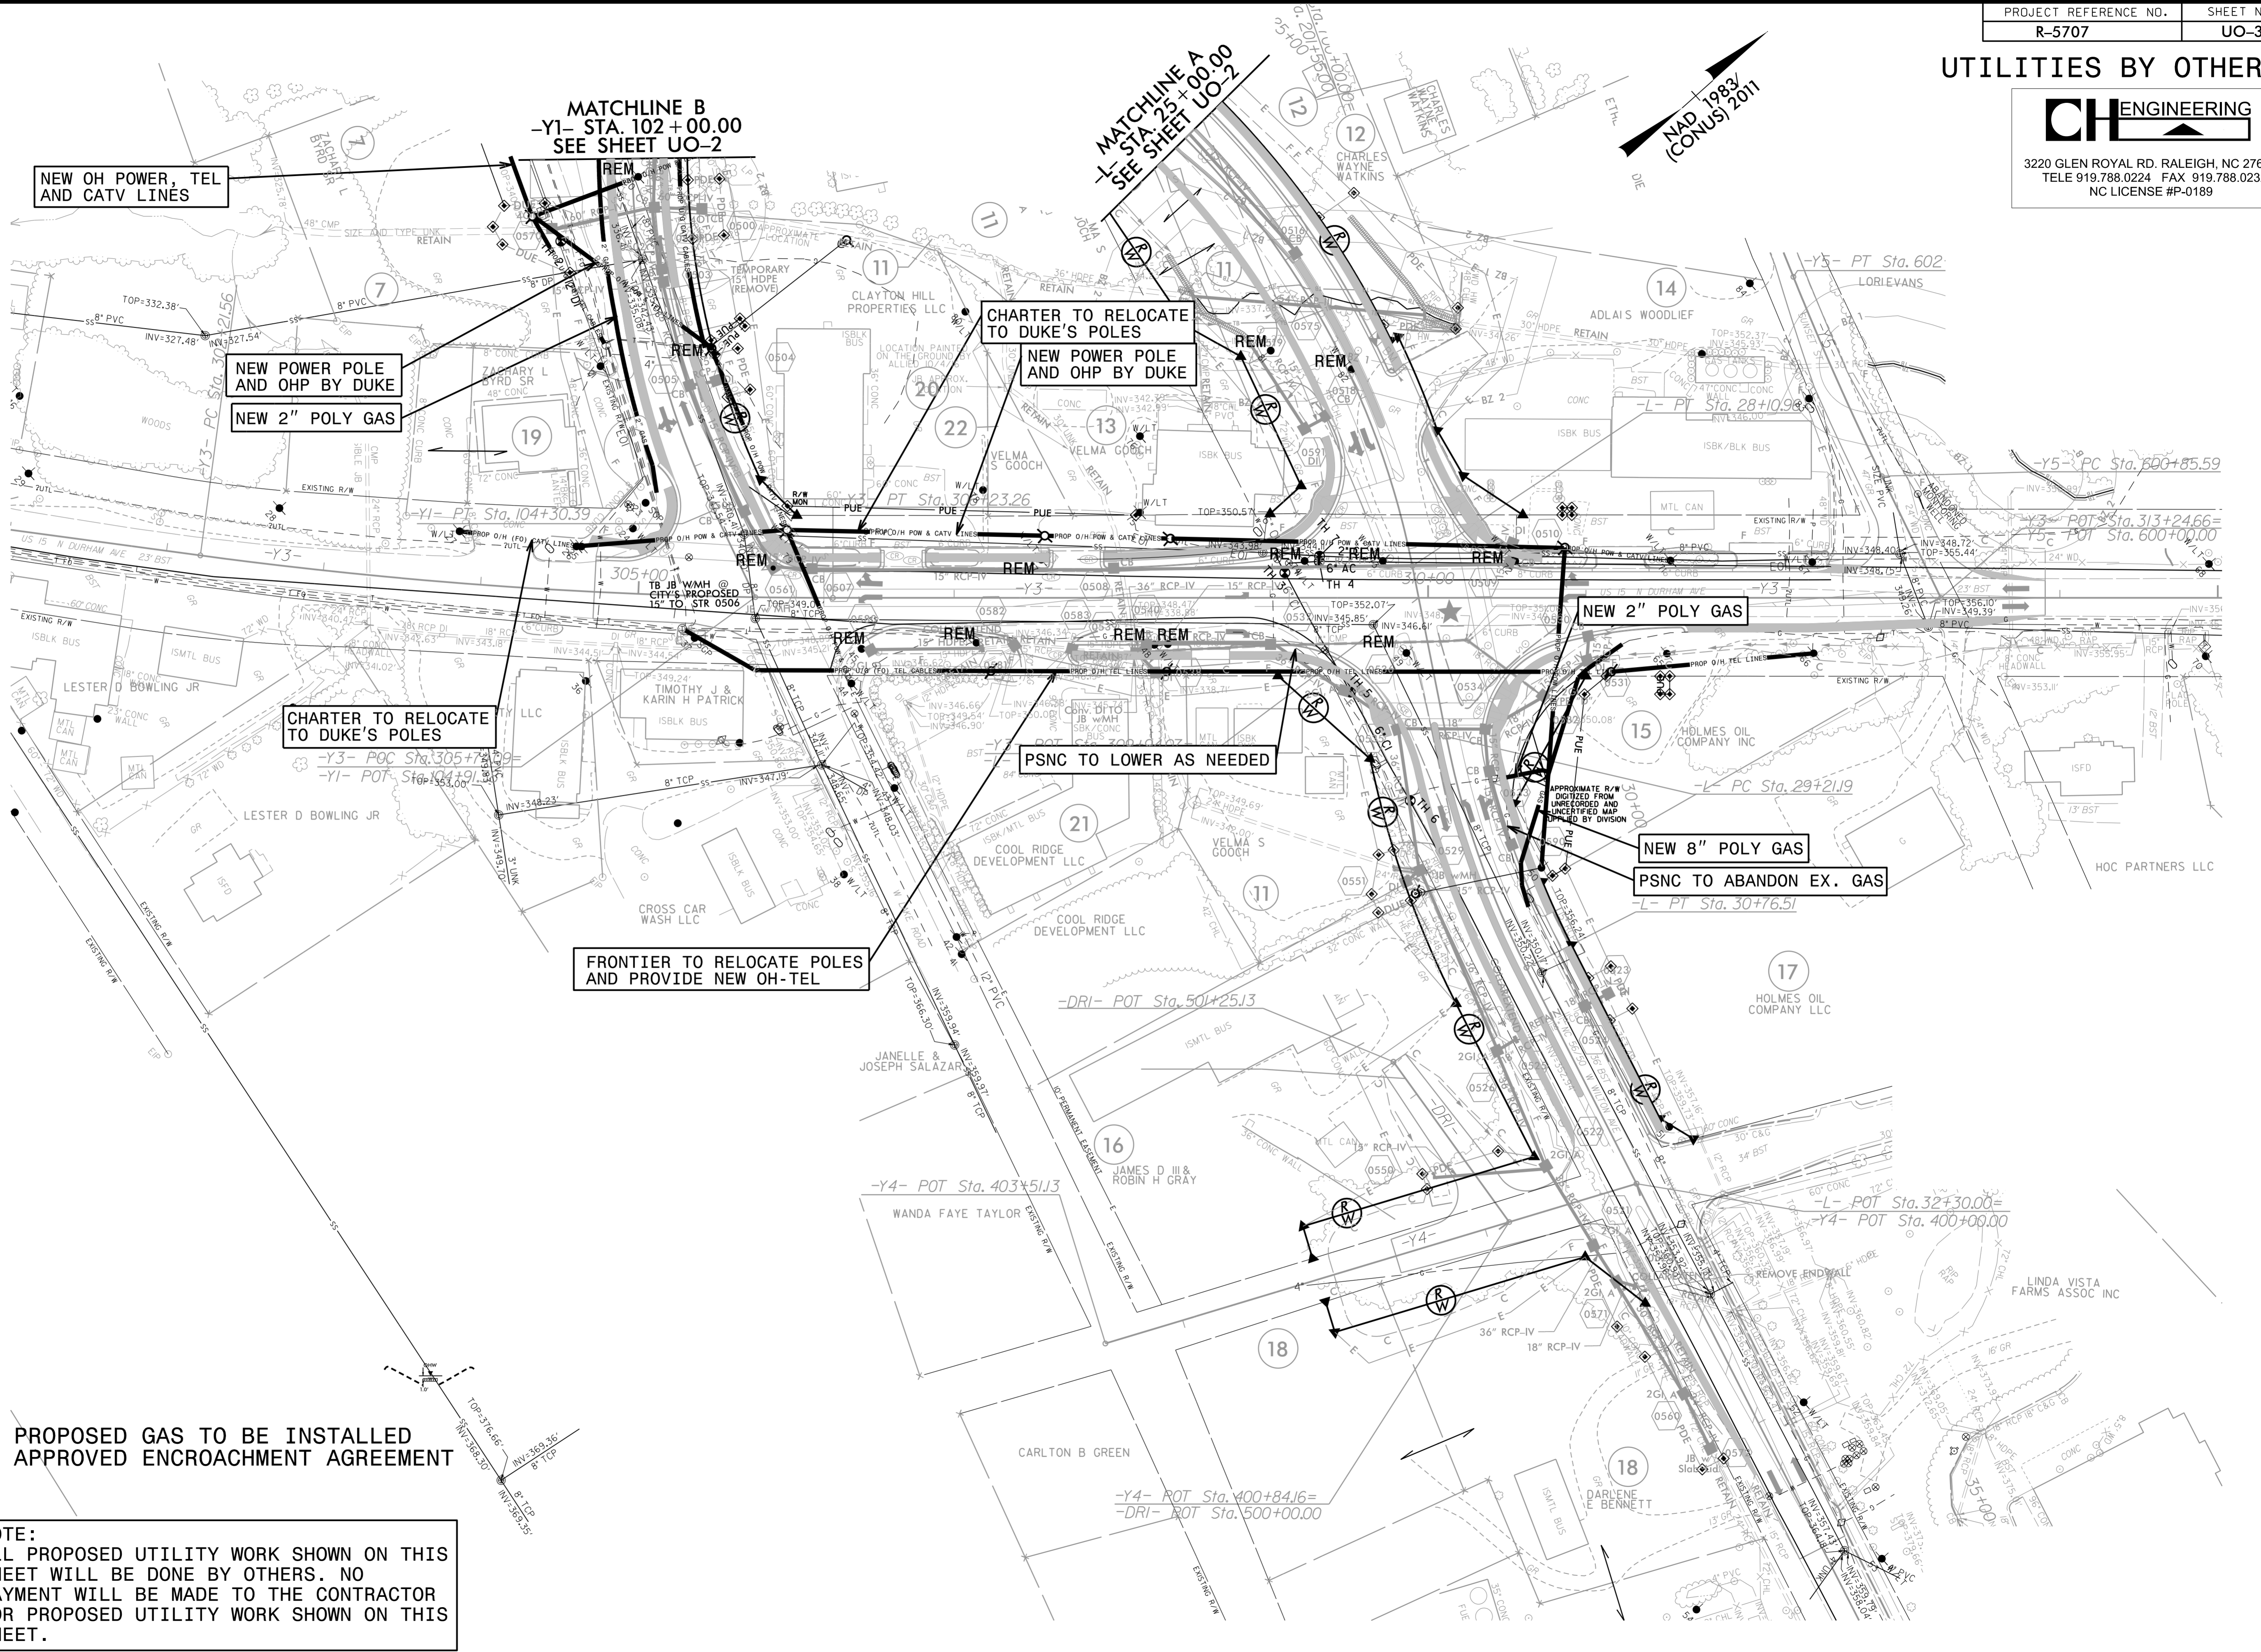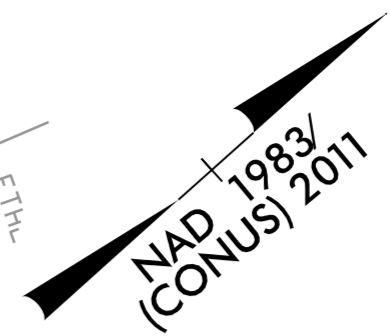

ALL PROPOSED GAS TO BE INSTALLED PER APPROVED ENCROACHMENT AGREEMENT

NOTE:
 ALL PROPOSED UTILITY WORK SHOWN ON THIS SHEET WILL BE DONE BY OTHERS. NO PAYMENT WILL BE MADE TO THE CONTRACTOR FOR PROPOSED UTILITY WORK SHOWN ON THIS SHEET.

2/1/2019 10:00 AM Proje\N5707\ut_r\dj05_w003_psh.dgn
 5/14/99