

PROJECT REFERENCE NO.	SHEET NO.
I-4400BB	U0-5
THIS SHEET CORRESPONDS TO RDY-14	


UTILITIES BY OTHERS

ALL PROPOSED UTILITY WORK SHOWN ON THIS SHEET WILL BE DONE BY OTHERS. NO PAYMENT WILL BE MADE TO THE CONTRACTOR FOR PROPOSED UTILITY WORK SHOWN ON THIS SHEET.

9/13/18
TRANSPORTATION\31733-02_I-4400BB\UTILITIES\I-4400BB_UT_U0-14.DGN


MATCHLINE SHEET 13
-L- STA 513 + 00.00

MATCHLINE SHEET 15
-L- STA 527 + 00.00

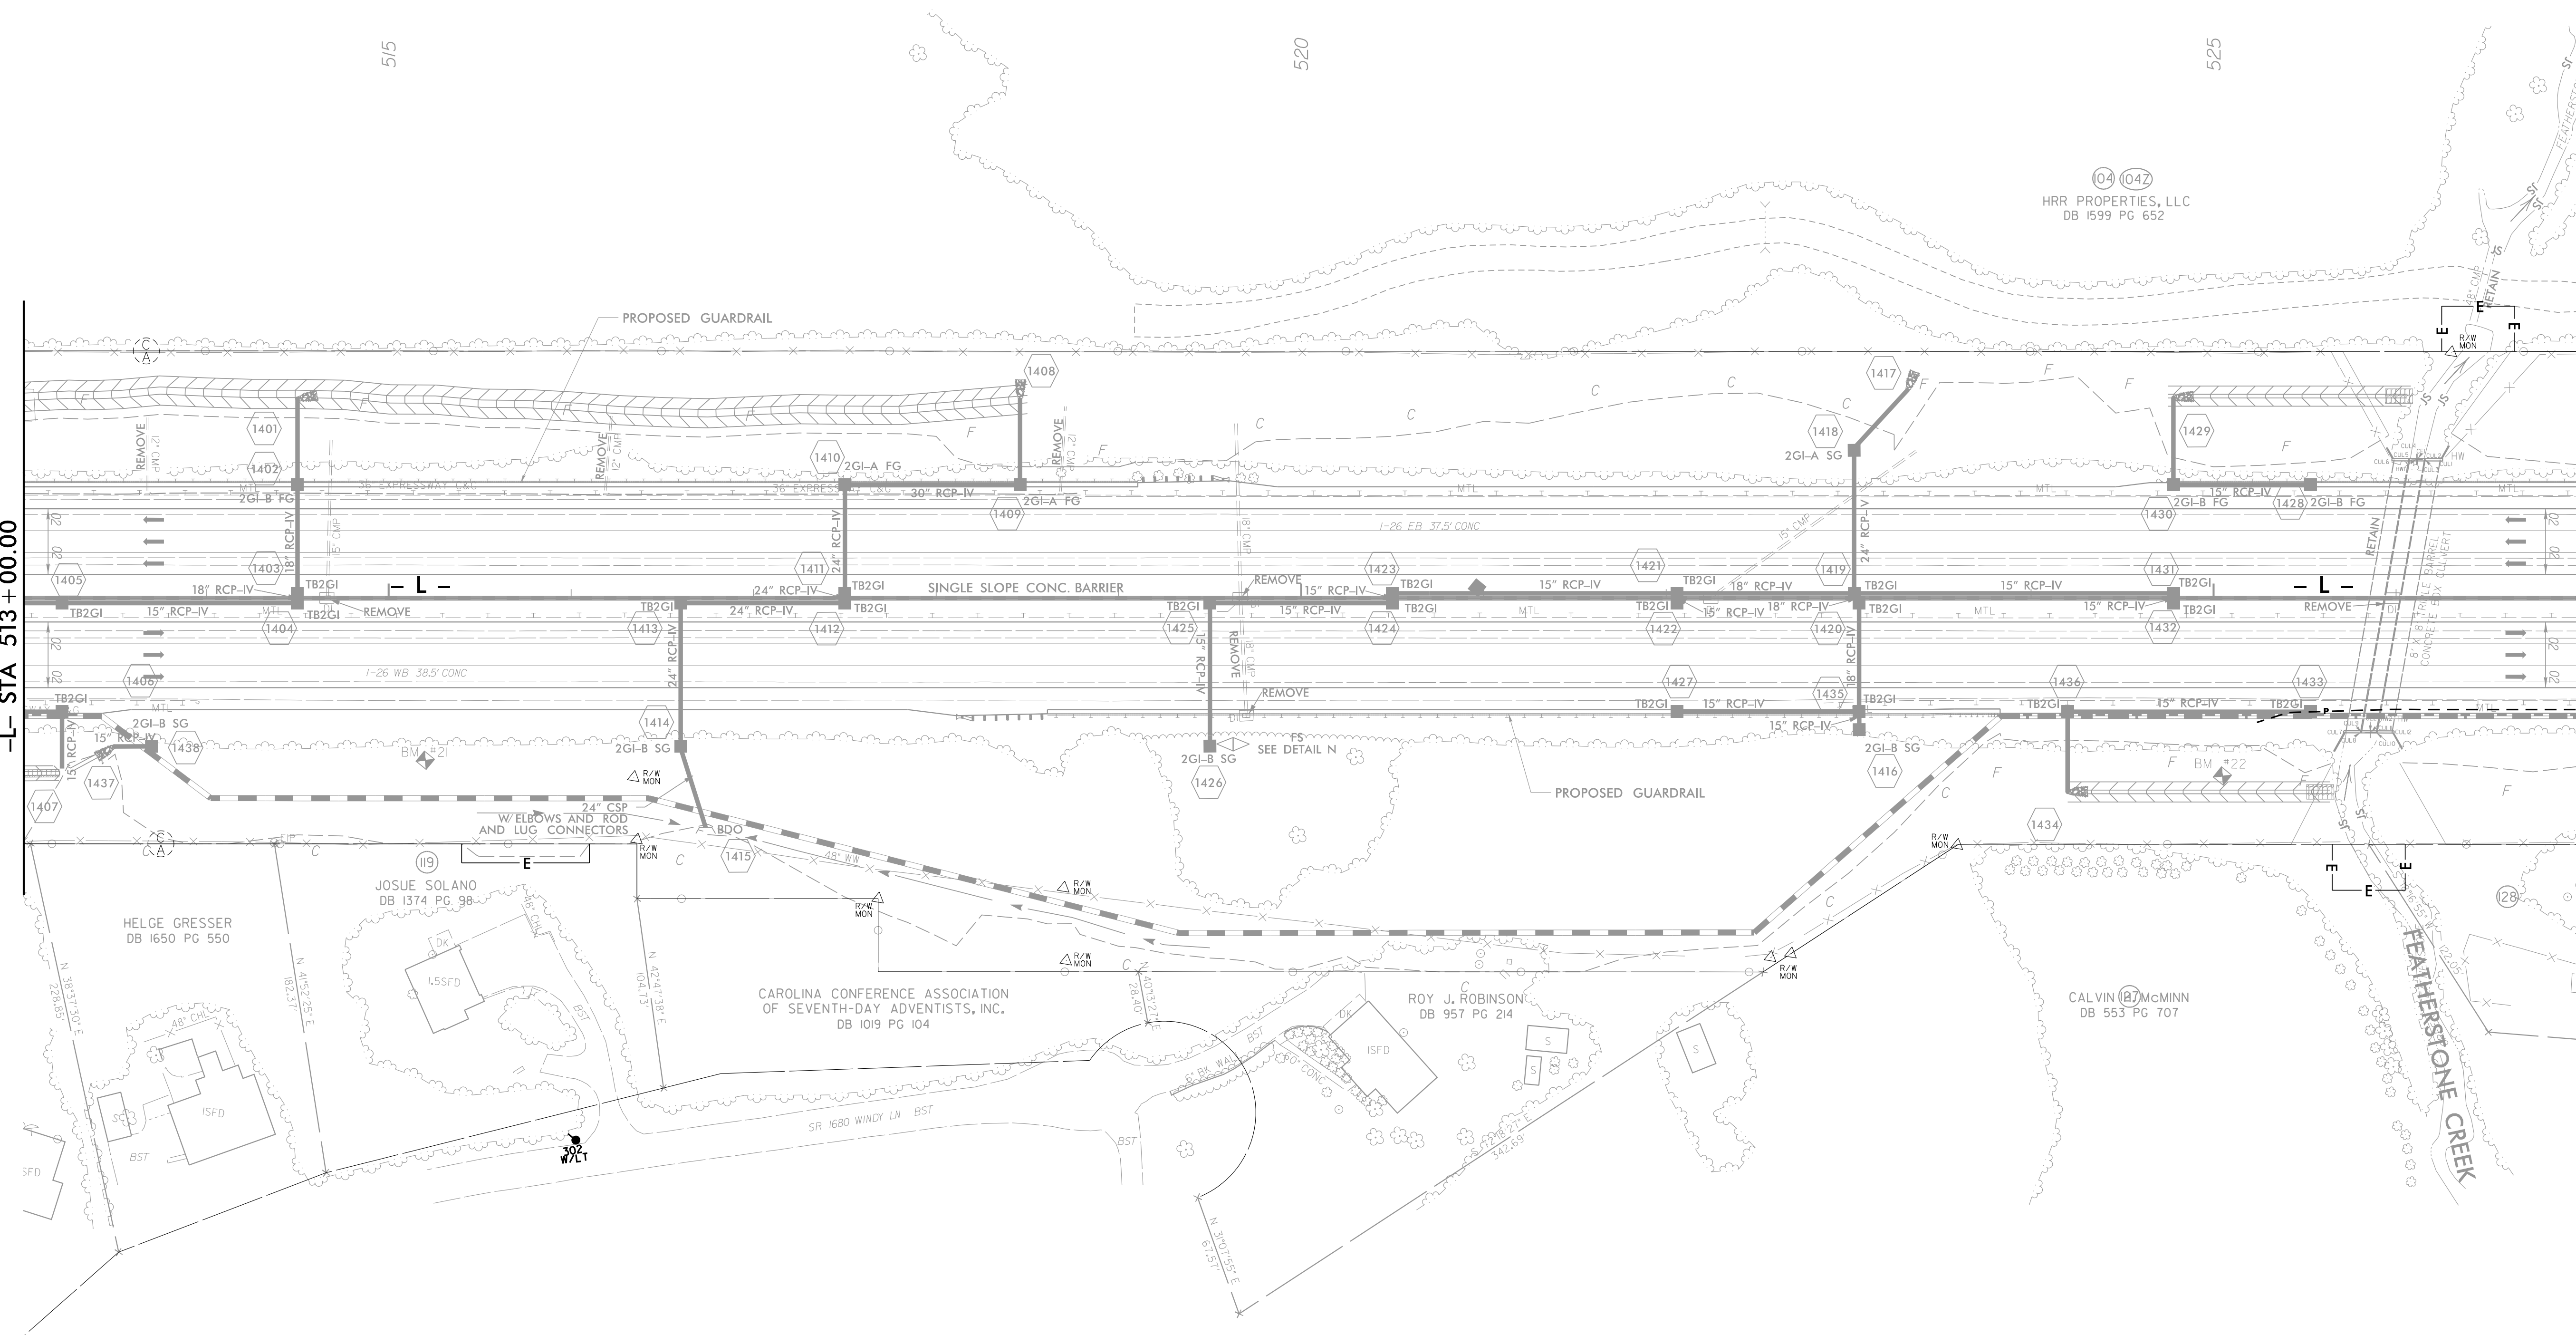

NO PROPOSED UTILITY RELOCATIONS ON THIS PLAN SHEET

UG POWER IS ASSOCIATED WITH INTERSTATE LIGHTING. PLEASE SEE LIGHTING PLANS FOR FURTHER INFORMATION

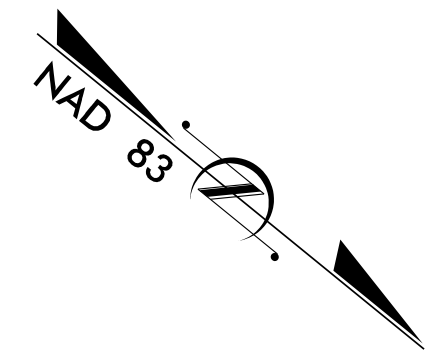

03 04Z
HRR PROPERTIES, LLC
DB 1599 PG 652

HELGE GRESSER
DB 1650 PG 550

JOSUE SOLANO
DB 1374 PG 98

CAROLINA CONFERENCE ASSOCIATION
OF SEVENTH-DAY ADVENTISTS, INC.
DB 1019 PG 104

ROY J. ROBINSON
DB 957 PG 214

CALVIN (B) McMINN
DB 553 PG 707

FEATHERSTONE CREEK