


TIP PROJECT: U-5827

STATE OF NORTH CAROLINA
DIVISION OF HIGHWAYS

T.I.P. NO.	SHEET NO.
U-5827	UO-1

NOTE:
ALL UTILITY WORK SHOWN ON THIS SHEET WILL BE DONE BY OTHERS.
NO PAYMENT WILL BE MADE TO THE CONTRACTOR FOR UTILITY WORK SHOWN ON THIS SHEET.


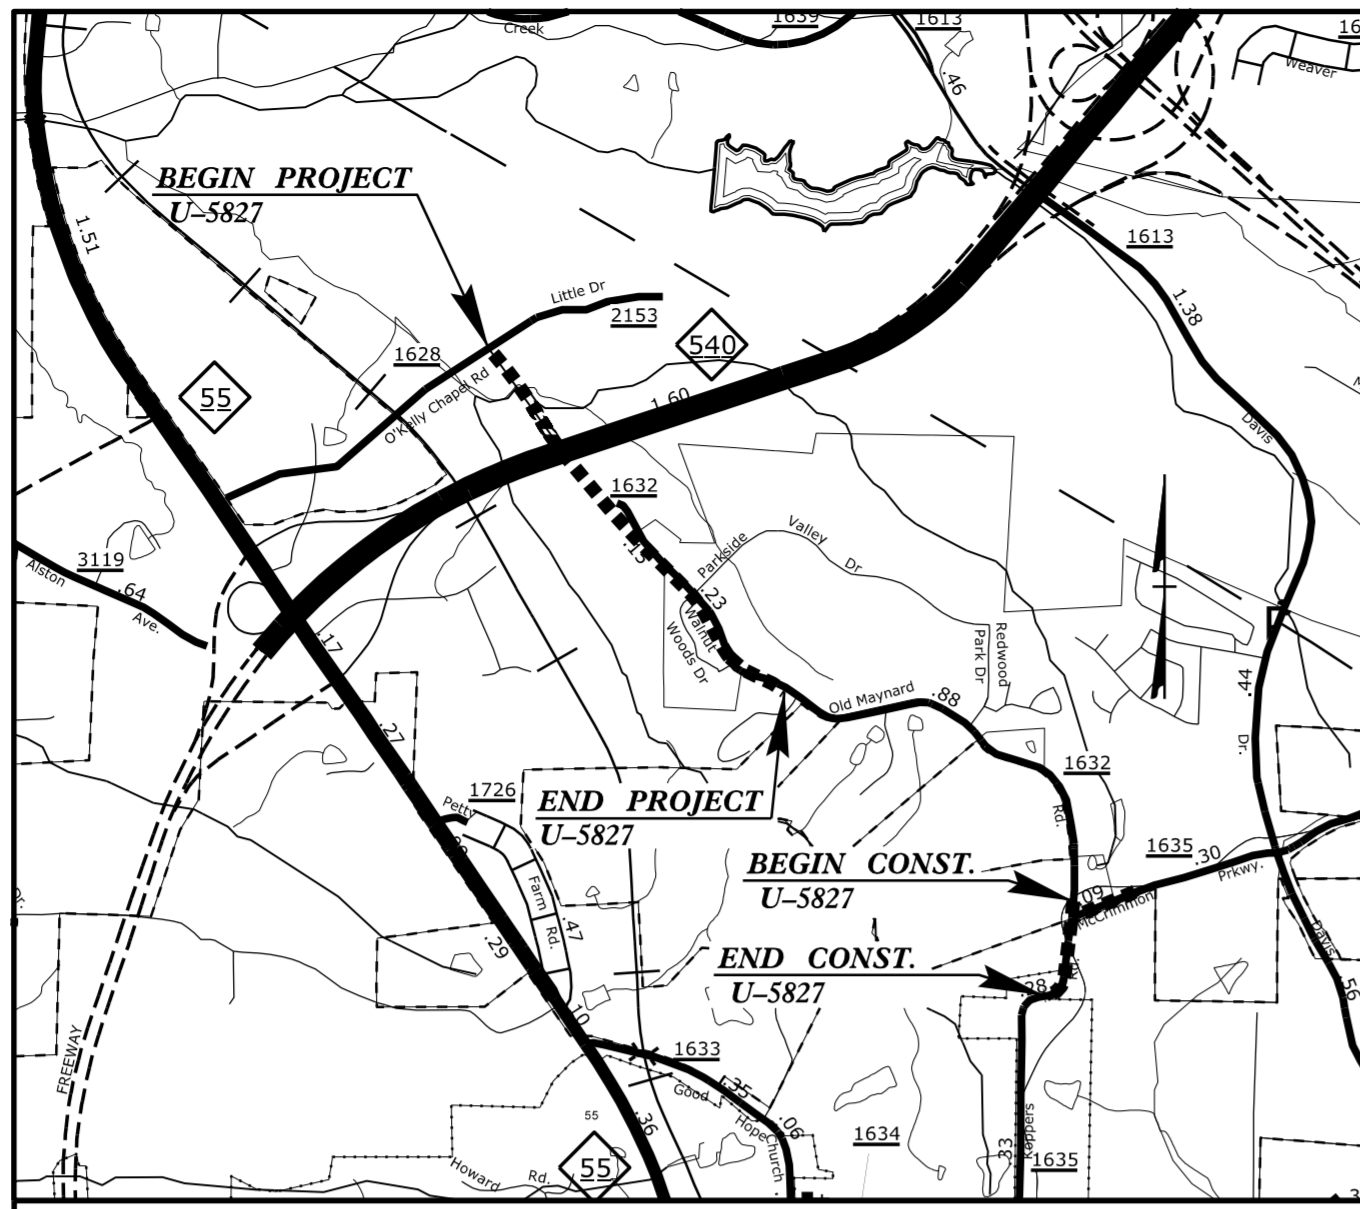


VICINITY MAP

UTILITIES BY OTHERS PLANS
WAKE COUNTY

LOCATION: LOUIS STEPHENS DRIVE EXTENSION (SR 1632)
FROM O'KELLY CHAPEL ROAD (SR 1628)/LITTLE DRIVE (SR 2153) IN RESEARCH TRIANGLE PARK
TO POPLAR PIKE LANE IN MORRISVILLE

TYPE OF WORK: UTILITY RELOCATION

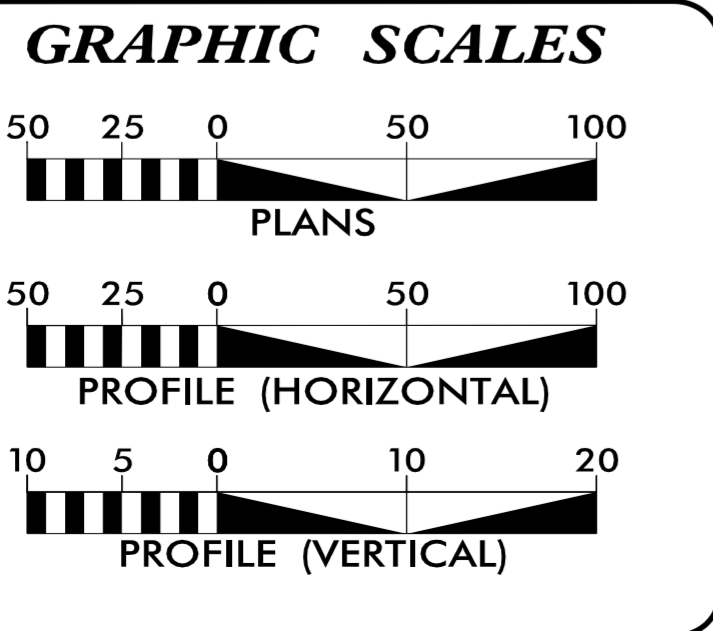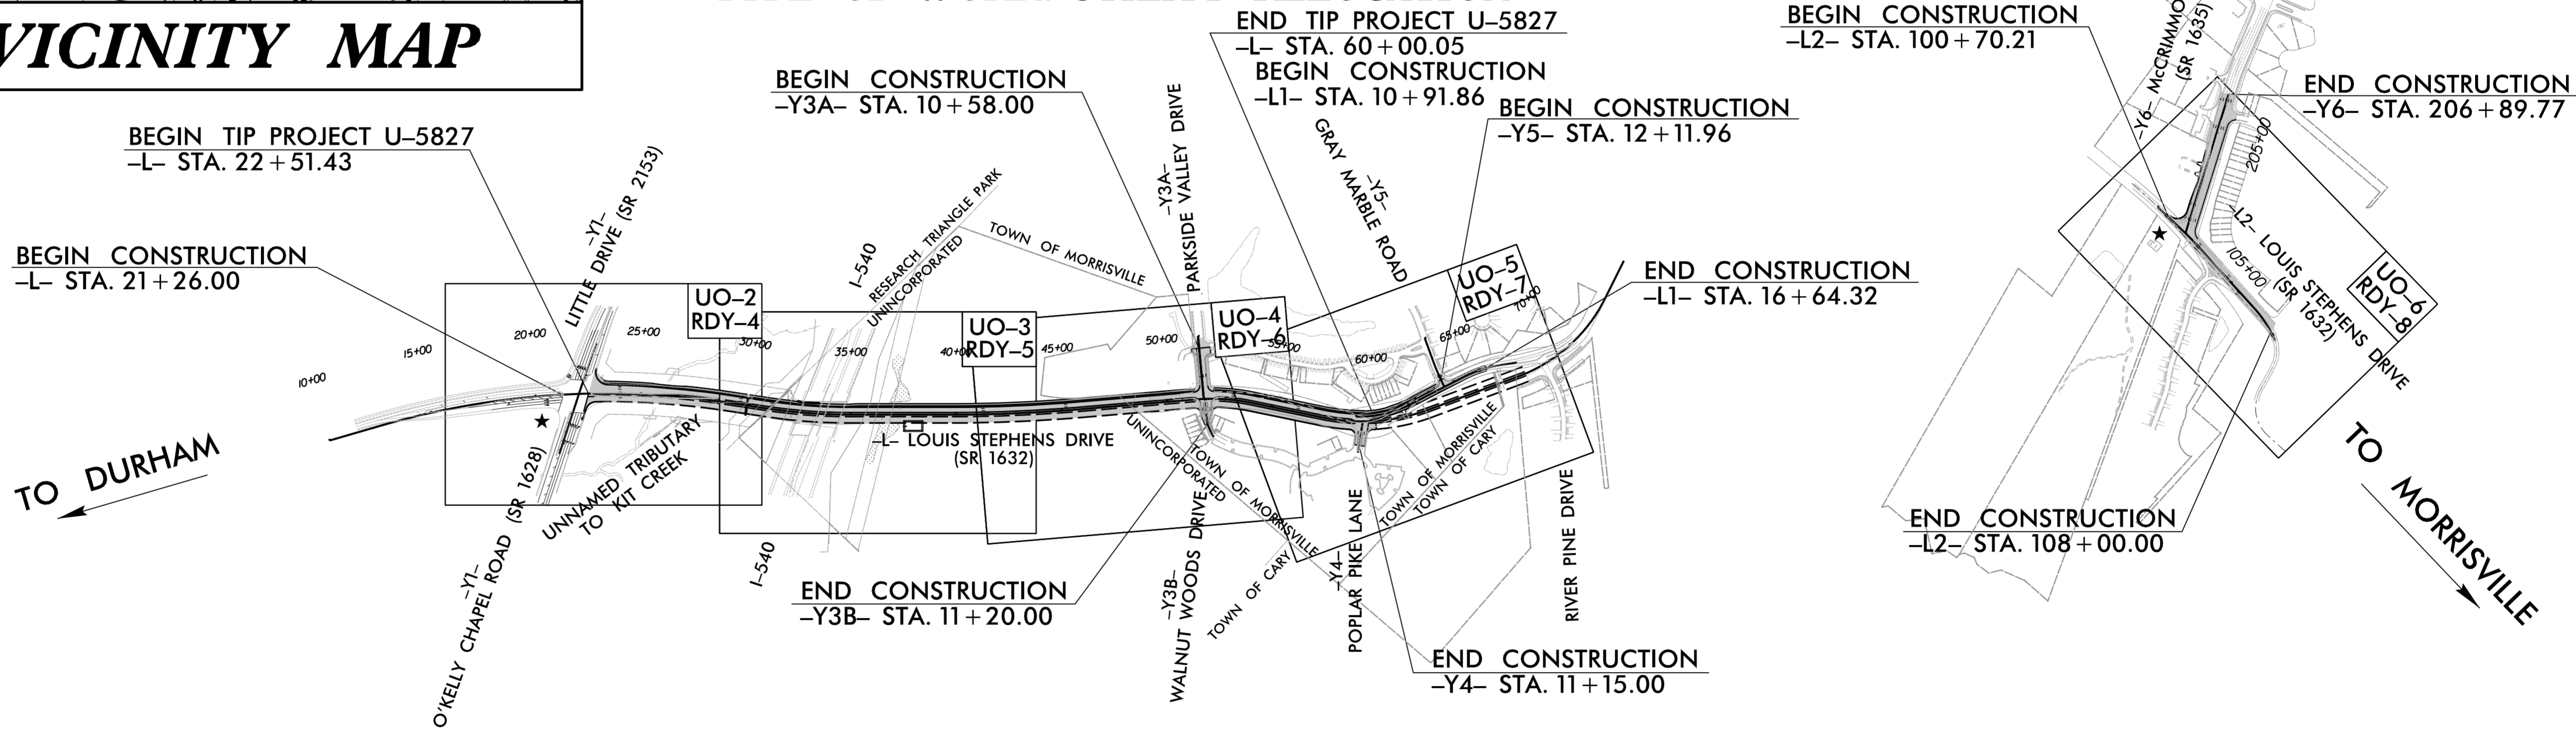

INDEX OF SHEETS

SHEET NO.:	DESCRIPTION:
UO-1	TITLE SHEET
UO-2 THRU UO-6	UBO PLAN SHEETS


- UTILITY OWNERS WITH CONFLICTS**
- (A) POWER - DUKE ENERGY (DISTRIBUTION)
 - (B) GAS - PSNC
 - (C) CABLE - CHARTER
 - (D) COMMUNICATIONS - GOOGLE FIBER
 - (E) COMMUNICATIONS - NCTA
 - (F) PHONE - AT&T
 - (G) WATER & SEWER - TOWN OF CARY

PREPARED IN THE OFFICE OF:

CH ENGINEERING

3220 GLEN ROYAL RD. RALEIGH, NC 27617
TELE 919.788.0224 FAX 919.788.0232
NC LICENSE #P-0189

UTILITIES PROJECT ENGINEER
Mary Jo Lee, P.E.



DIVISION OF HIGHWAYS
DIVISION 5
PROJECT DELIVERY UNIT
2612 N. DUKE STREET
DURHAM, 27704
P: 919-220-4600
F: 919-560-3371

Ben Upshaw, PE	TEAM LEAD
S. Reid Davidson	DDC ENGINEER
Donald Proper	DIVISION 5 UTILITIES ENGINEER
Monroe Brown	UTILITY COORDINATOR