

STATE OF NORTH CAROLINA  
DIVISION OF HIGHWAYS

**WAYNE COUNTY**


LOCATION: I-795 FROM WILSON COUNTY LINE TO SR 2075 (ASH ST.)

TYPE OF WORK: DRAINAGE, GRADING & GUARDRAIL

STATE	STATE PROJECT REFERENCE NO.	SHEET NO.	TOTAL SHEETS
N.C.	I-6047	1	
STATE PROJ. NO.	F.A. PROJ. NO.	DESCRIPTION	
47996.1.1		PE	
47996.3.GVI	NHPIM-0795(008)	CONST	


TIP PROJECT: I-6047

CONTRACT: C204377

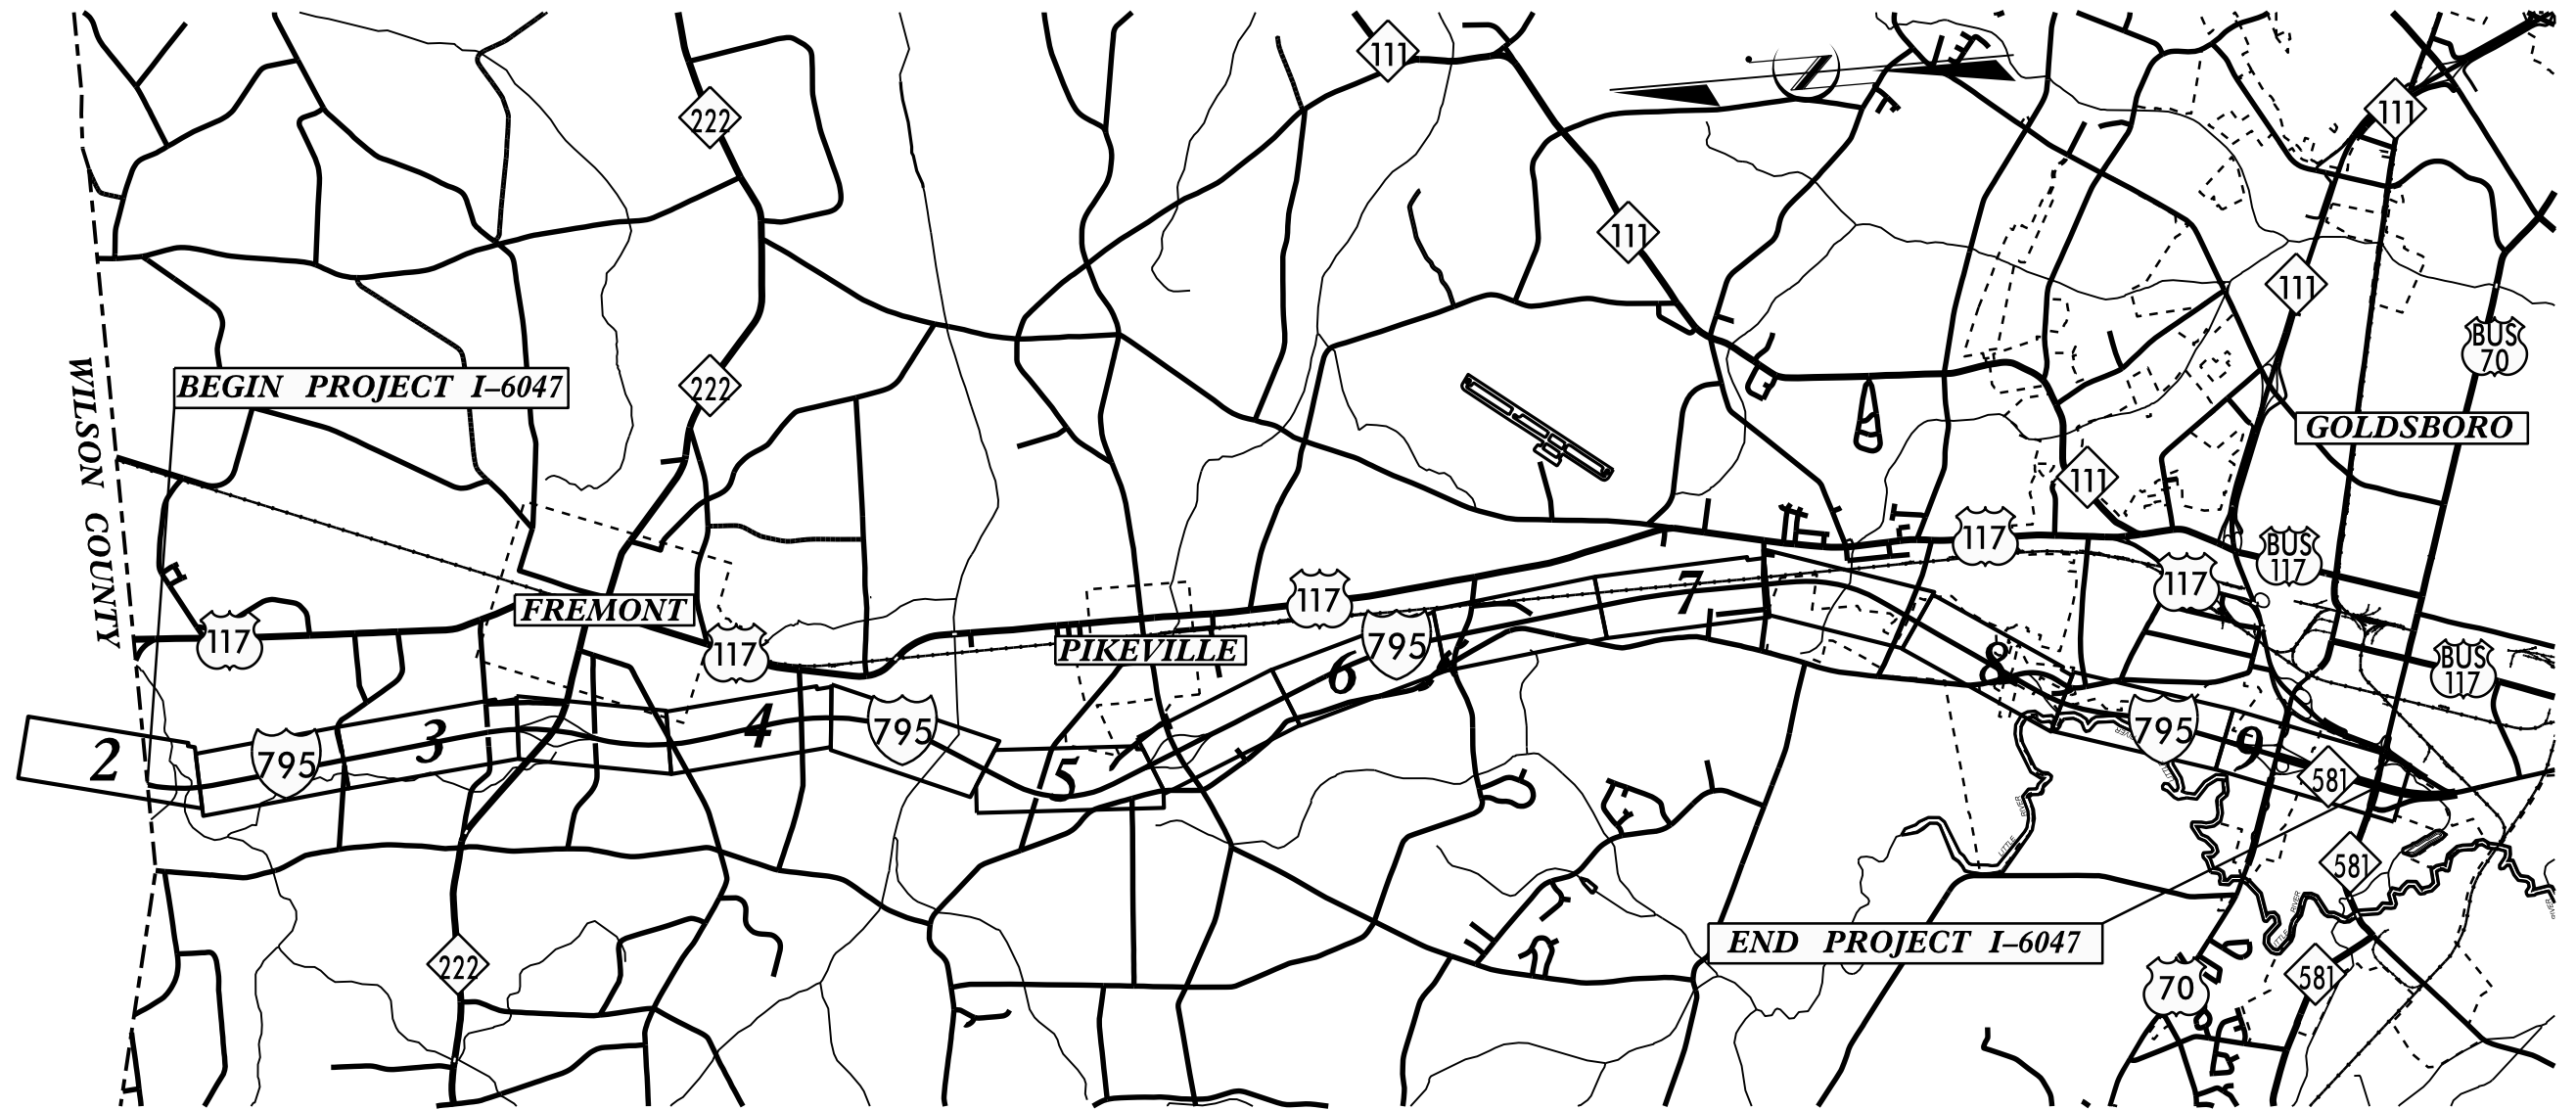

**VICINITY MAP AND PROJECT LAYOUT**

 GRAPHIC SCALES



DESIGN DATA

LENGTH ROADWAY TIP PROJECT I-6047 = 14.200 MILES  
TOTAL LENGTH TIP PROJECT I-6047 = 14.200 MILES

FUNCTIONAL CLASS  
INTERSTATE  
STATEWIDE TIER

Prepared In the Office of:  
**DIVISION OF HIGHWAYS**

Division 4 DDC  
509 Ward Blvd., Wilson NC, 27895

2018 STANDARD SPECIFICATIONS

RIGHT OF WAY DATE:  
N/A

LETTING DATE:  
DECEMBER 17, 2019

RONNIE KEETER, PE  
PROJECT ENGINEER

D.R. ETHRIDGE  
PROJECT DESIGN ENGINEER

