


26-AUG-2020 14:08
 \\dot\dfsroot\Groups-Div7CC\DDC\10-RESURFACING PROJECTS\2020 CR Resurfacing\Caswell\2020CPT.07.08.10171(US 29)\To Raleigh\2020CPT.07.08.10171 Title.dgn
 bicaudill AT DIV07-301313L

CONTRACT: C204284 **TIP PROJECT:**

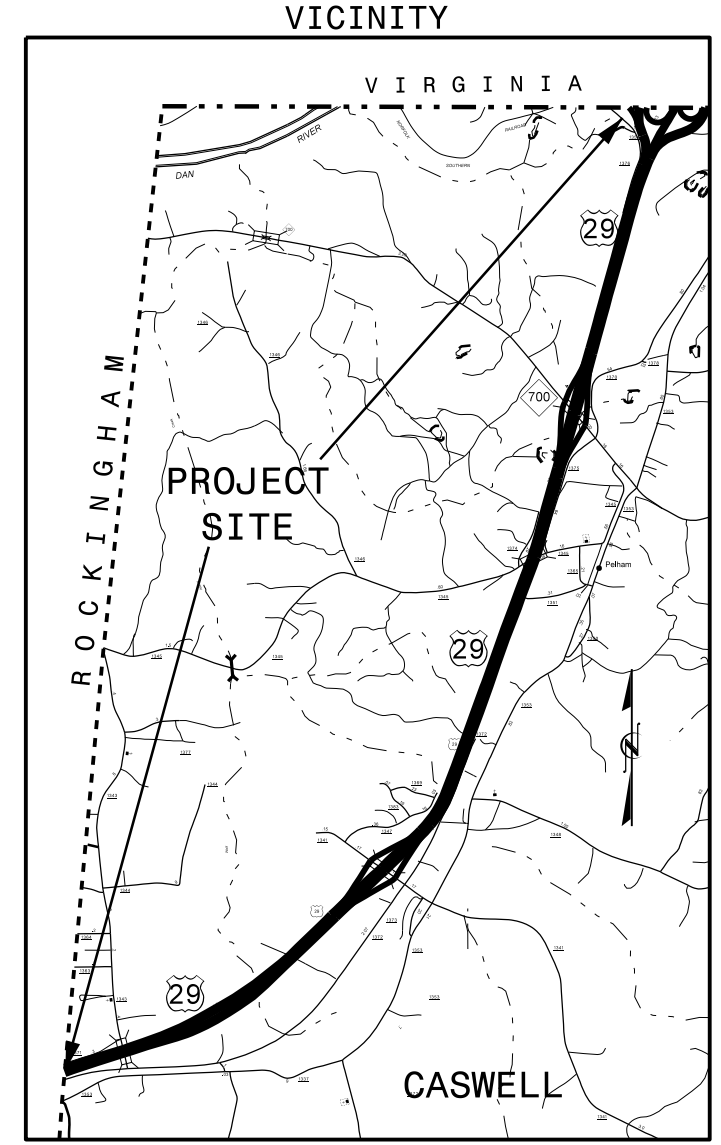


STATE OF NORTH CAROLINA
 DIVISION OF HIGHWAYS

CASWELL COUNTY

LOCATION: US 29 FROM ROCKINGHAM COUNTY
 LINE TO VIRGINIA STATE LINE

TYPE OF WORK: RESURFACING, MARKINGS
 AND MARKERS

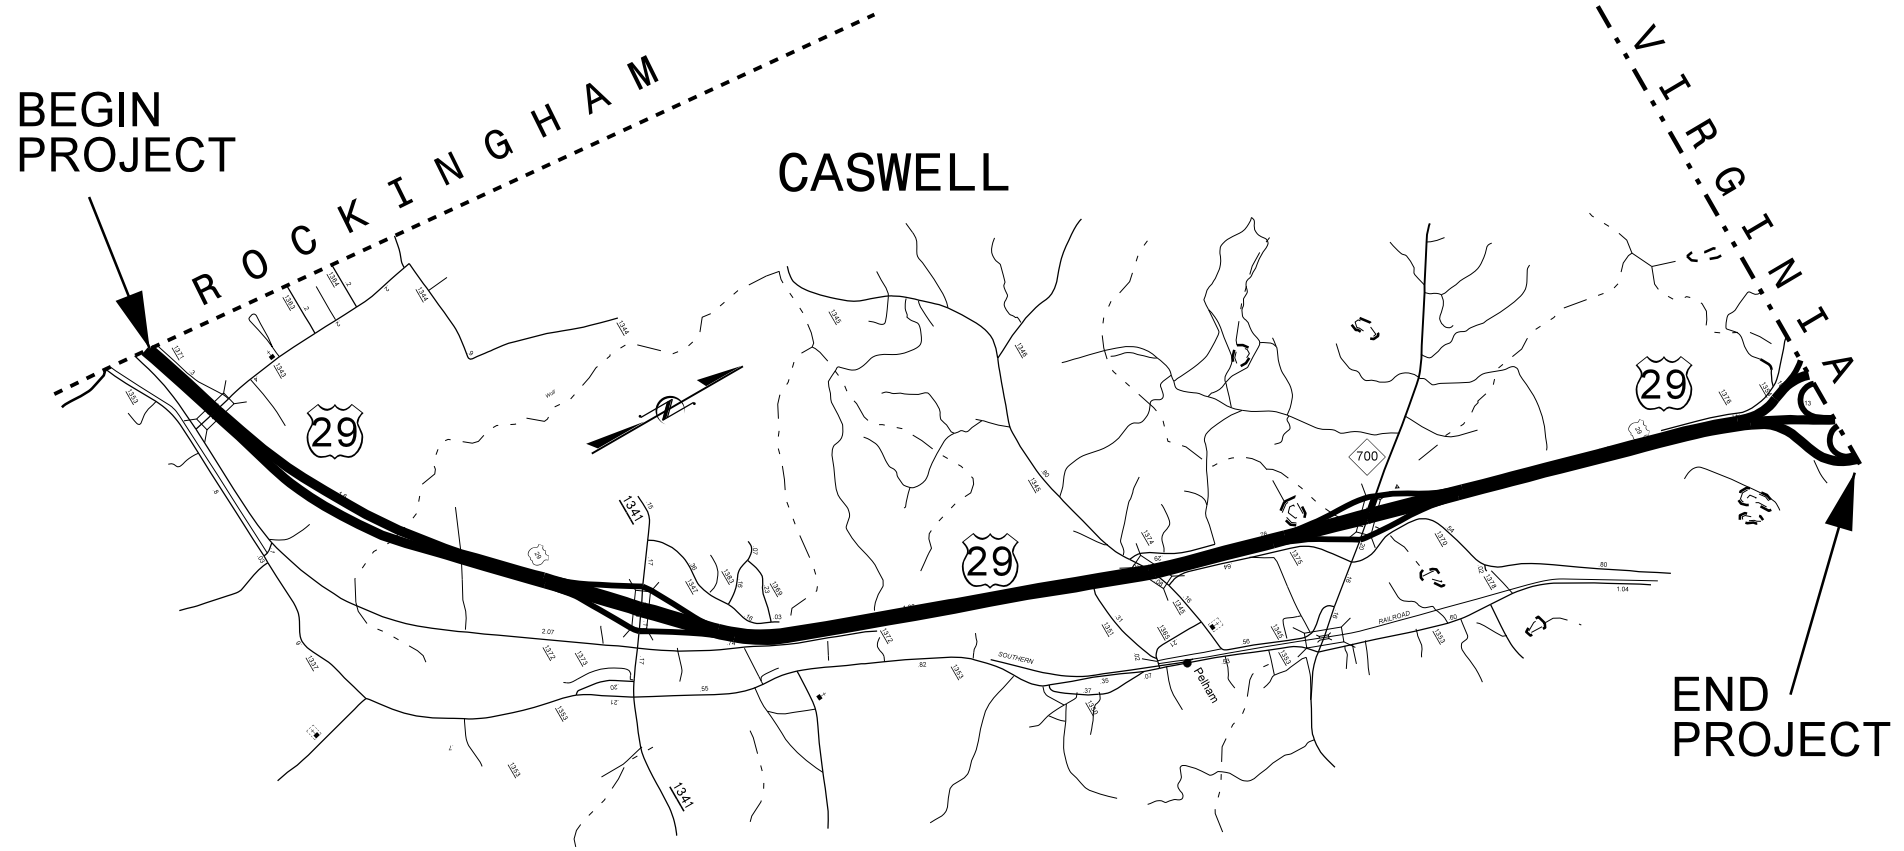

STATE	STATE PROJECT REFERENCE NO.	SHEET NO.	TOTAL SHEETS
N.C.	2021CPT.07.08.10171	1	
STATE PROJ. NO.	F.A. PROJ. NO.	DESCRIPTION	

GRAPHIC SCALES
 NOT TO SCALE

DESIGN DATA

PROJECT LENGTH
 2021CPT.07.08.10171 = 6.028 miles

Prepared In the Office of:
DIVISION OF HIGHWAYS
 1000 Birch Ridge Dr., Raleigh NC, 27610

LETTING DATE:
 November 17, 2020

