

09_08/99

TIP PROJECT: B-5662



T.I.P. NO.	SHEET NO.
B-5662	UC-1

STATE OF NORTH CAROLINA
DIVISION OF HIGHWAYS

HALIFAX COUNTY


LOCATION: REPLACE BRIDGE NO. 93 OVER
CONOCONNARA SWAMP ON NC 561

TYPE OF WORK: WATERLINE RELOCATION

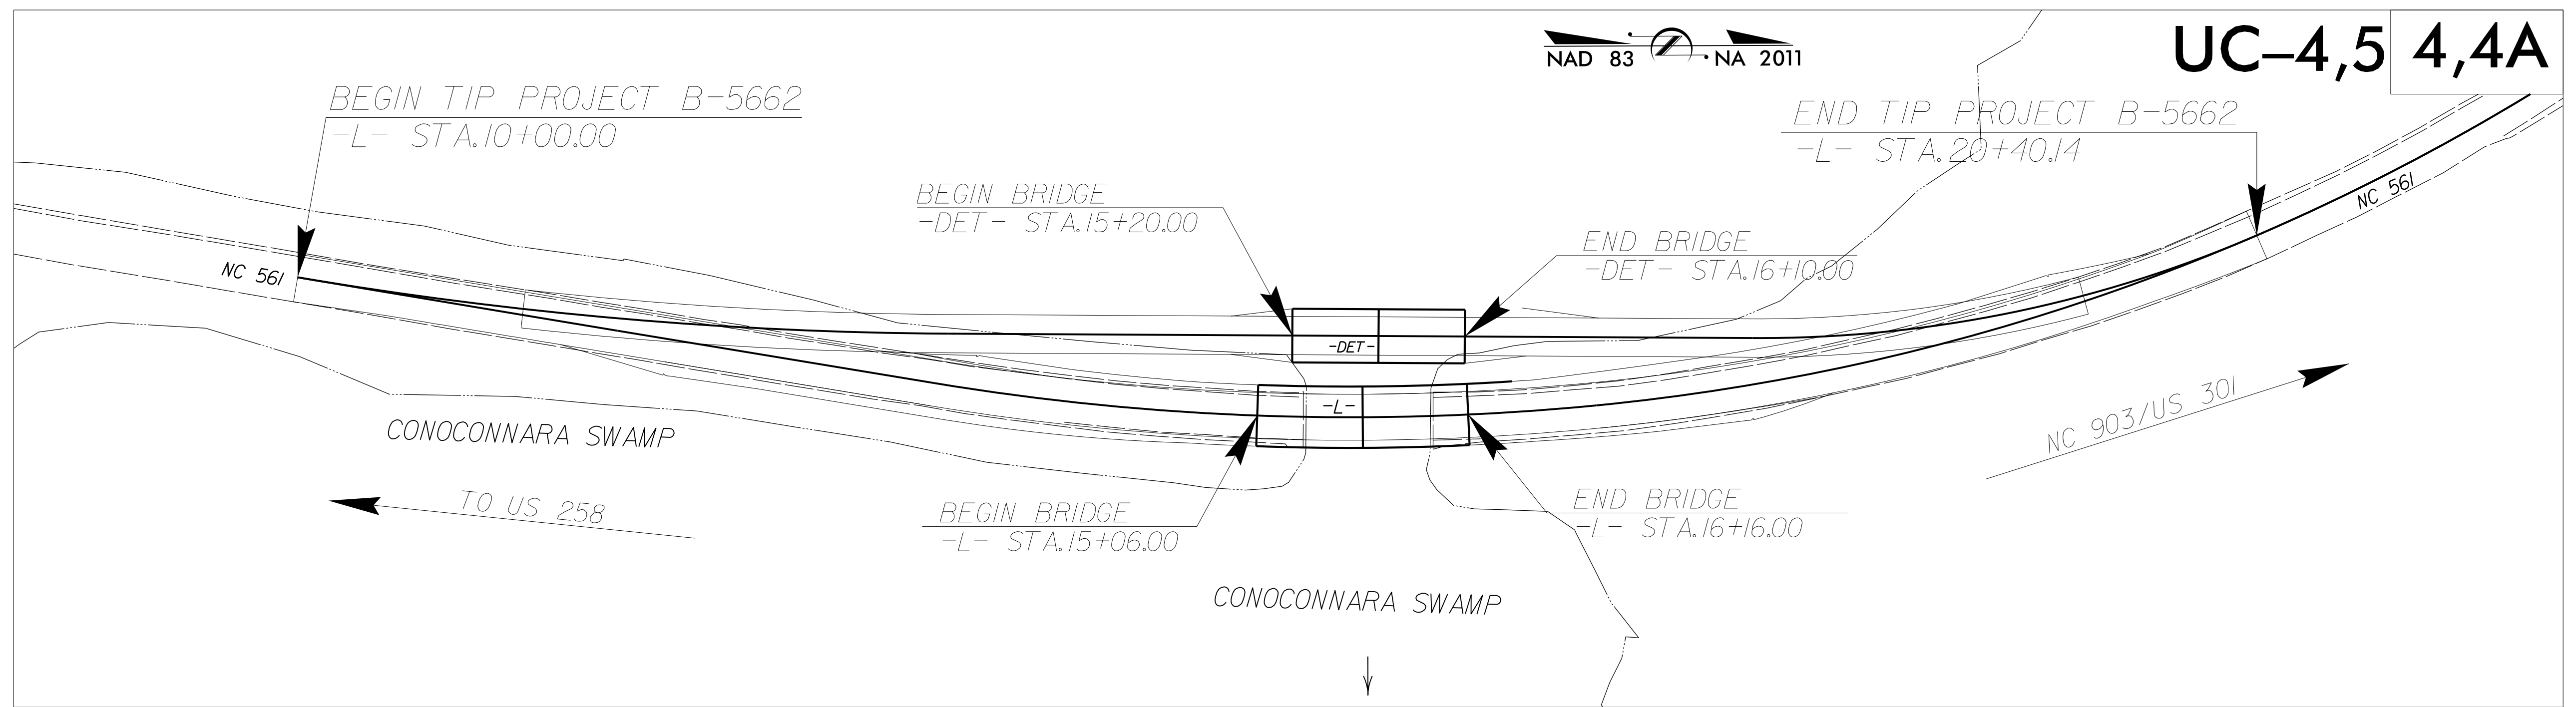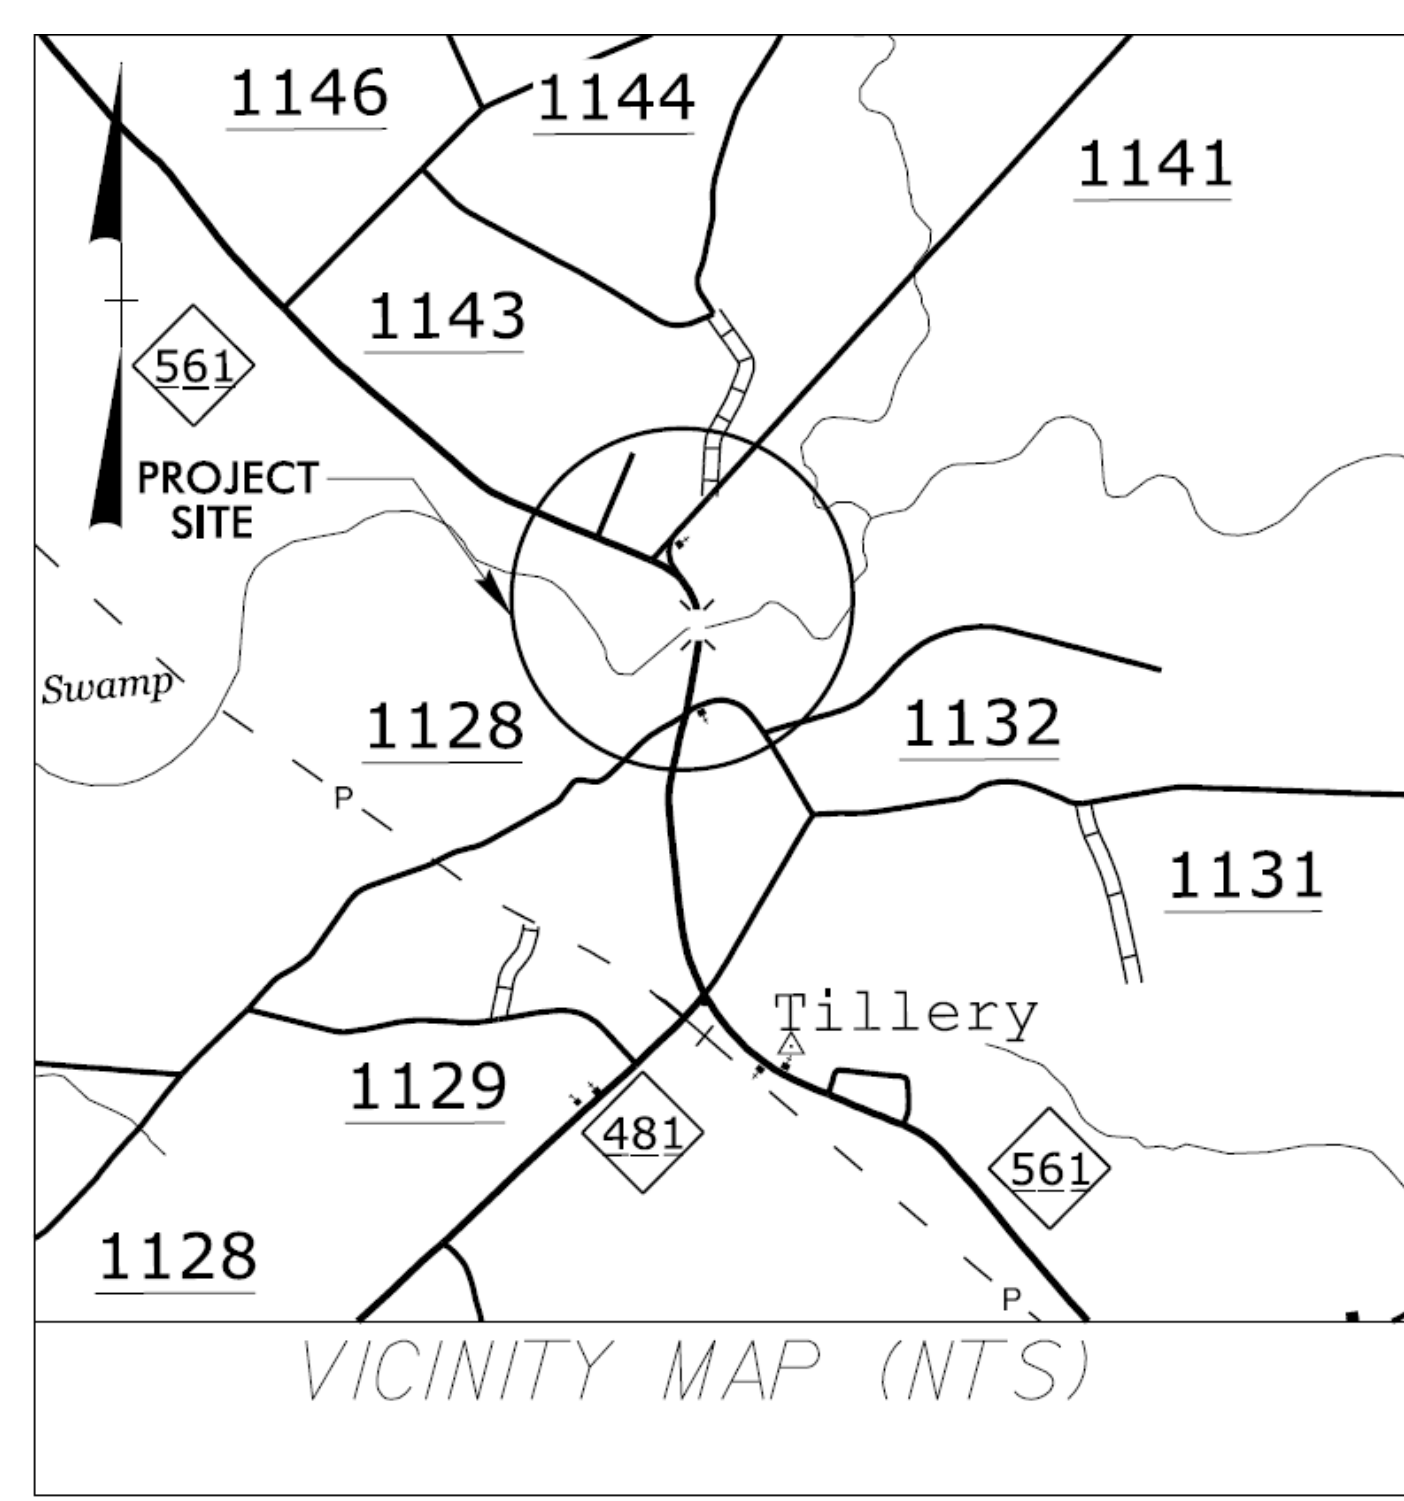

UC-4,5 4,4A

DOCUMENT NOT CONSIDERED FINAL
UNTIL ALL SIGNATURES ARE COMPLETED

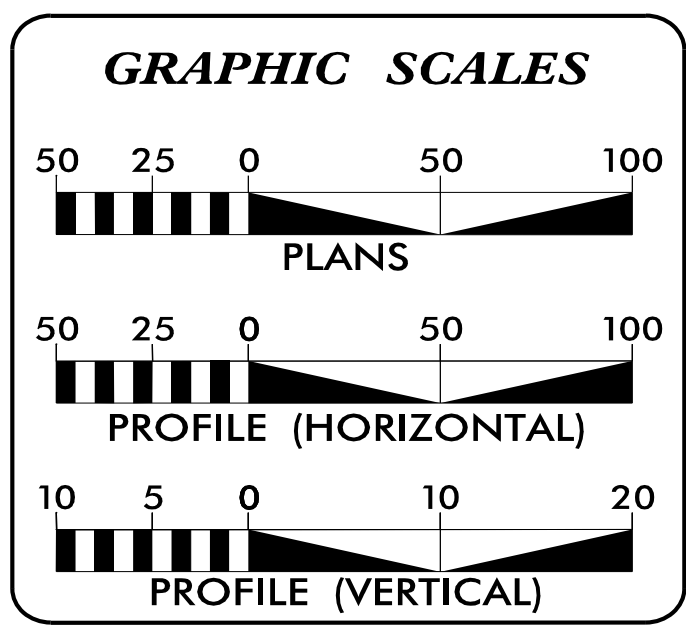

INDEX OF SHEETS

SHEET NO.:	DESCRIPTION:
UC-1	TITLE SHEET
UC-2	UTILITY SYMBOLOGY
UC-3	NOTES
UC-3A, 3B	DETAILS
UC-4, 5	UTILITY PLAN SHEETS
UC-6, 7	UTILITY PROFILE SHEETS

WATER AND SEWER OWNER ON PROJECT

A) WATER - HALIFAX COUNTY
PUBLIC UTILITIES

PREPARED IN THE OFFICE OF

Engineers • Planners • Scientists • Construction Managers
4505 Falls of Neuse Road, Suite 400
Raleigh, NC 27609
Phone (919) 783-9214 • Fax (919) 783-9266
License No. C-764

DINKISSA KEREYU, PE PROJECT ENGINEER
MARCO MENENDEZ, PE PROJECT MANAGER
CHARLES SHEARON PROJECT DESIGNER

SEAL

3/20/2020

DIVISION OF HIGHWAYS UTILITIES UNIT
1555 MAIL SERVICES CENTER
RALEIGH, NC 27699-1555
PHONE (919) 707-6690
FAX (919) 250-4151

NABIL HAMDAN UTILITIES REGIONAL ENGINEER
KIFAH KAMIL UTILITIES ENGINEER
KYLE PLEASANT UTILITIES AREA COORDINATOR
LARRY JAMES UTILITIES COORDINATOR

16-MAR-2020 16:05
M:\2018\1251501945\21B-5662\Water-Wastewater\B-5662-sew_tsh_UC01_psh.dgn
\$\$\$\$\$SERVNAME\$\$\$\$\$