


09.08/99

TIP PROJECT: BR-0047

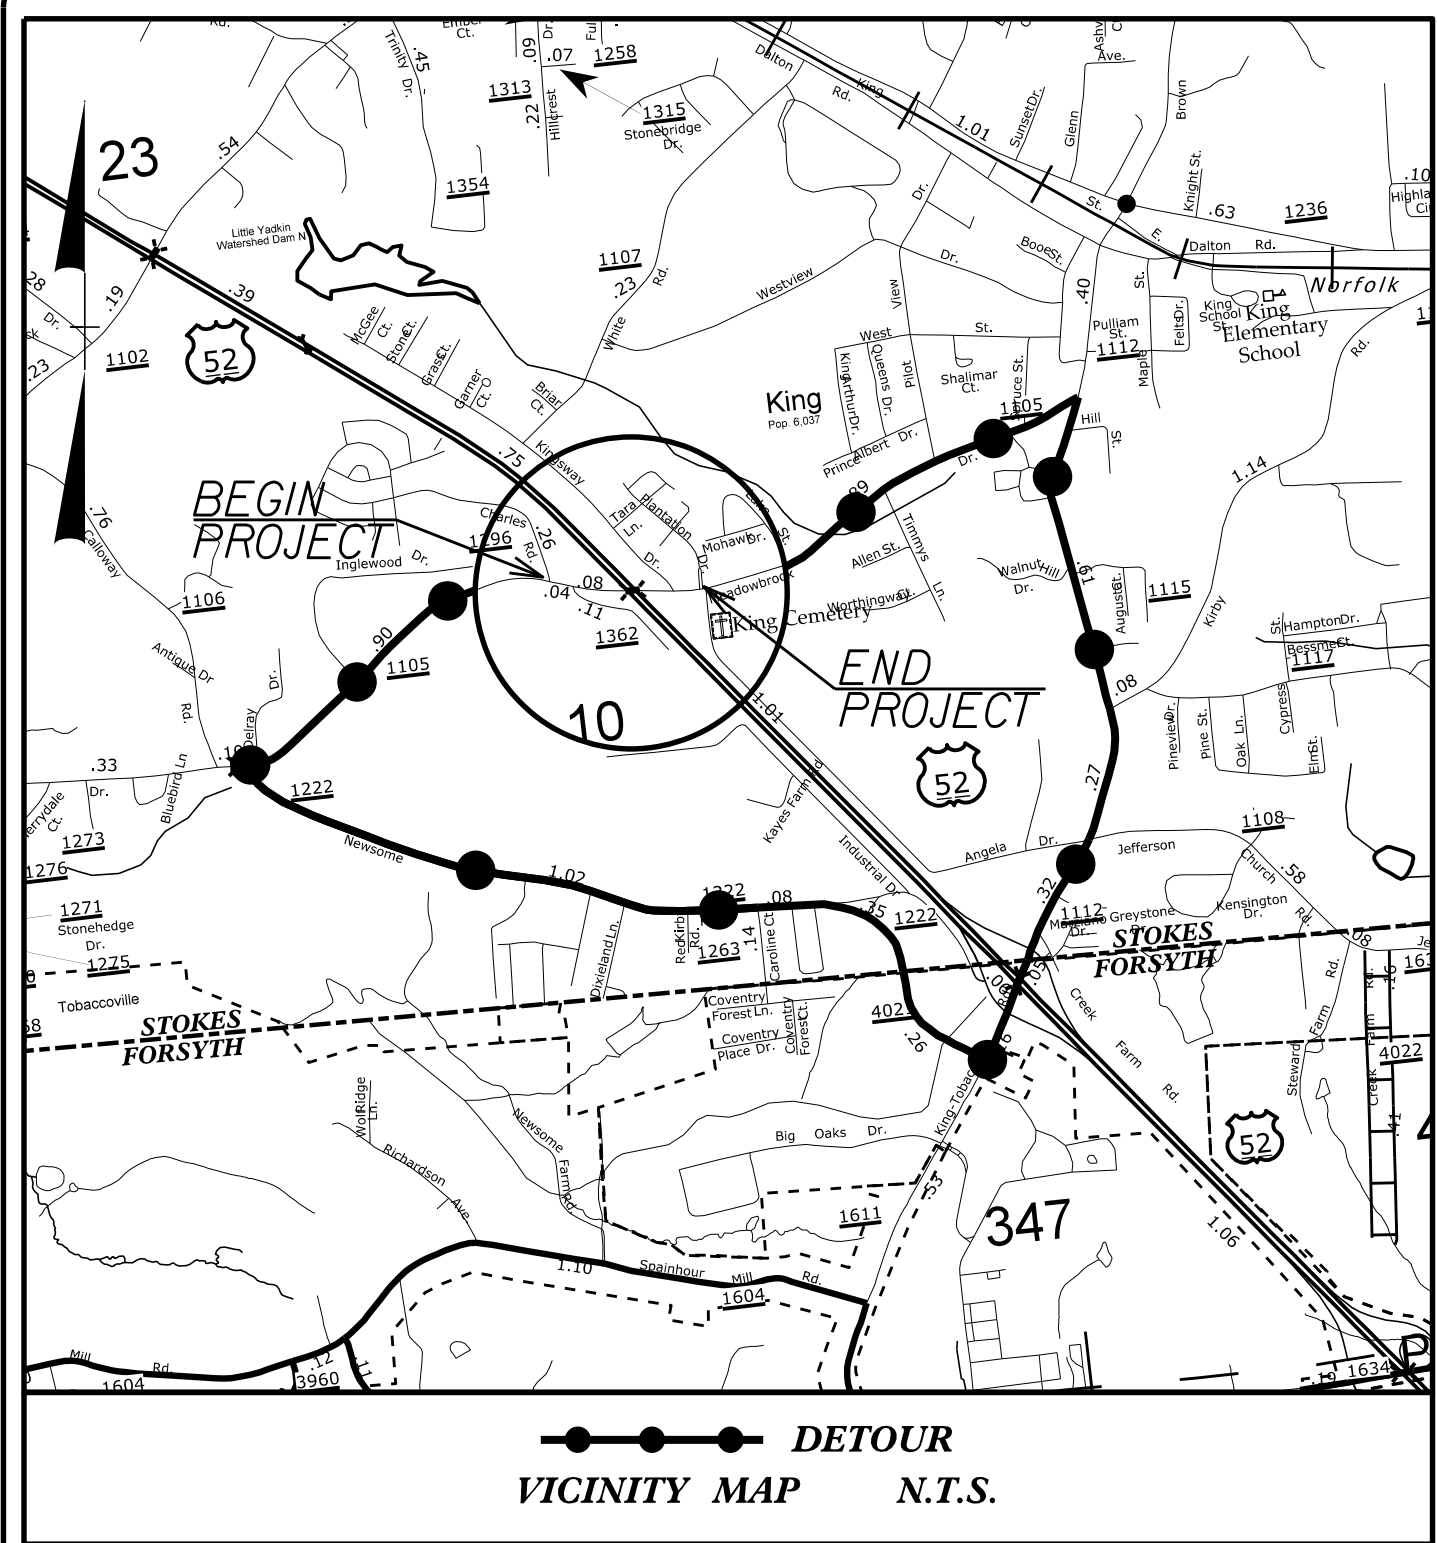

STATE OF NORTH CAROLINA  
DIVISION OF HIGHWAYS


**UTILITIES BY OTHERS PLANS  
STOKES COUNTY**

LOCATION: BRIDGE 10 ON SR 1105  
(MEADOWBROOK DR.) OVER U.S. 52


TYPE OF WORK: RELOCATION OF POWER, GAS AND  
COMMUNICATION UTILITIES

T.I.P. NO.	SHEET NO.
BR-0047	UO-1

NOTE:  
ALL UTILITY WORK SHOWN ON THIS SHEET WILL BE DONE BY OTHERS. NO PAYMENT WILL BE MADE TO THE CONTRACTOR FOR UTILITY WORK SHOWN ON THIS SHEET.

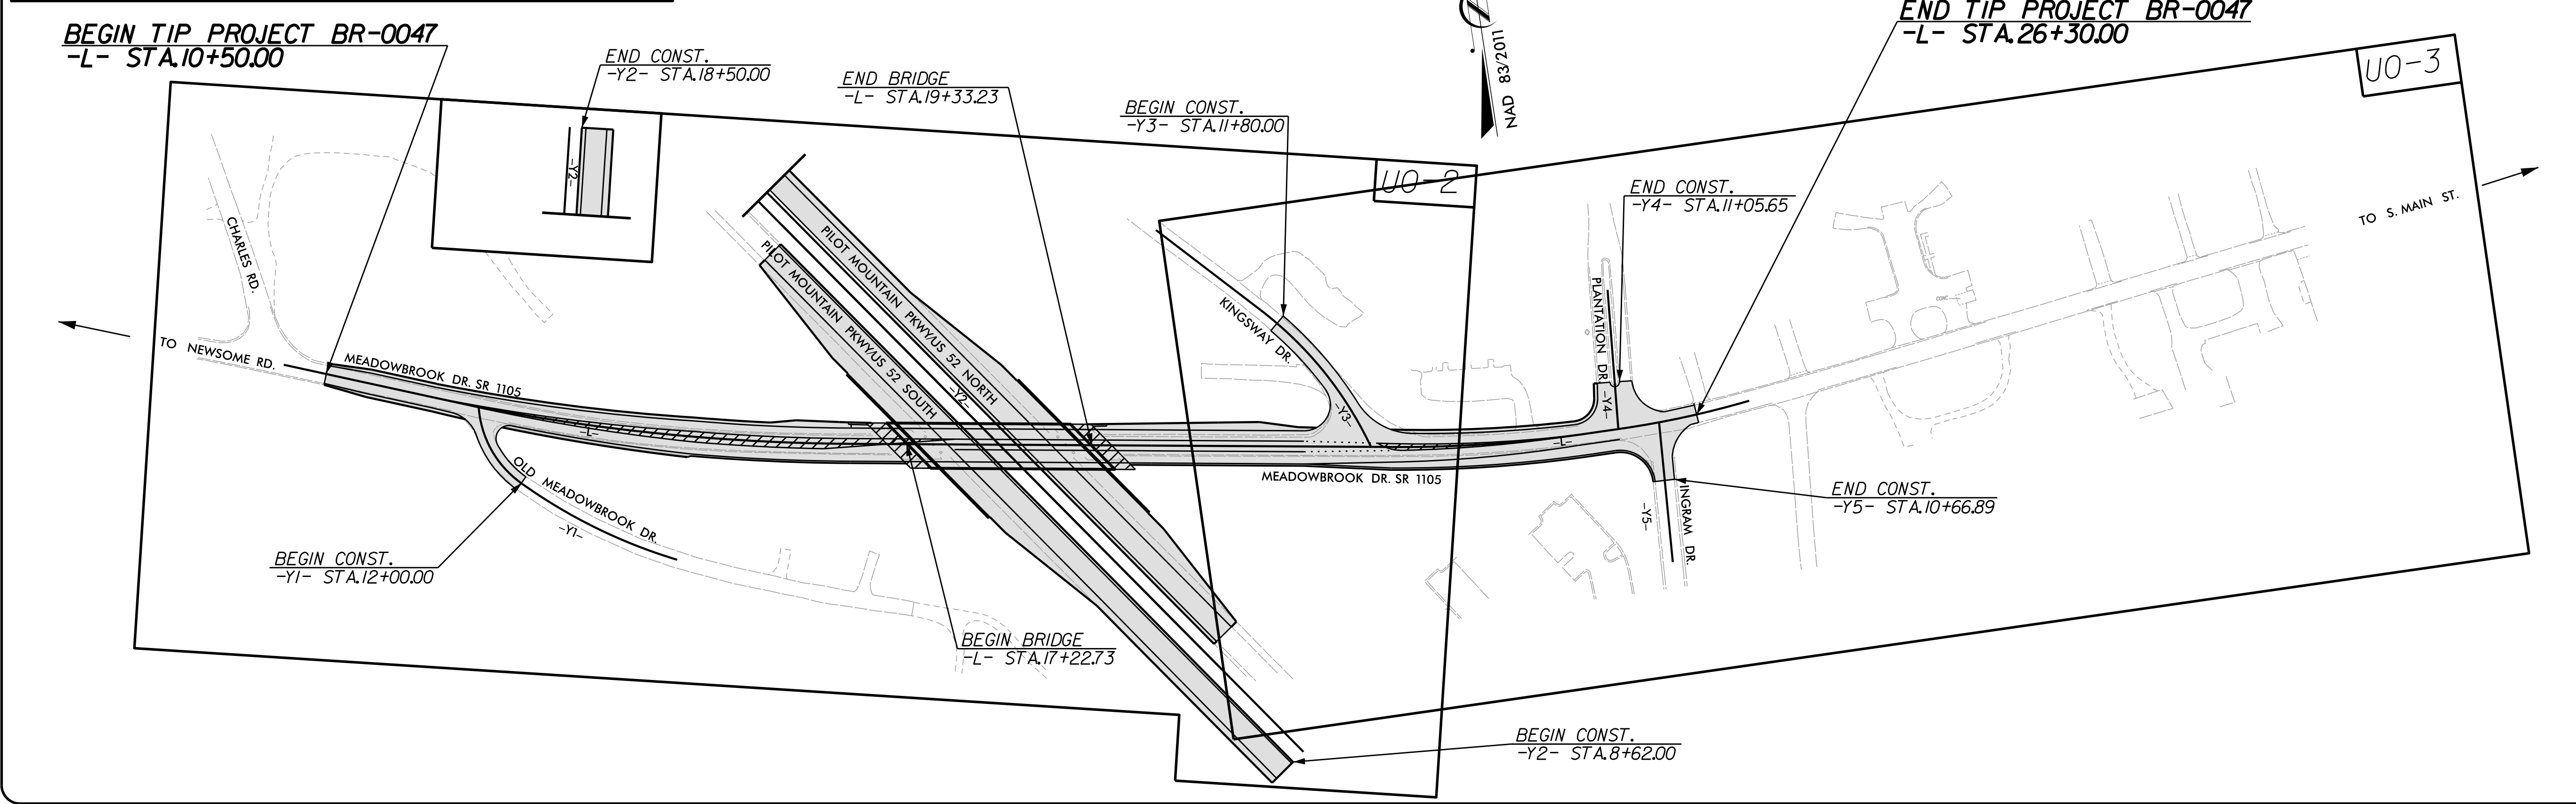

GRAPHIC SCALES

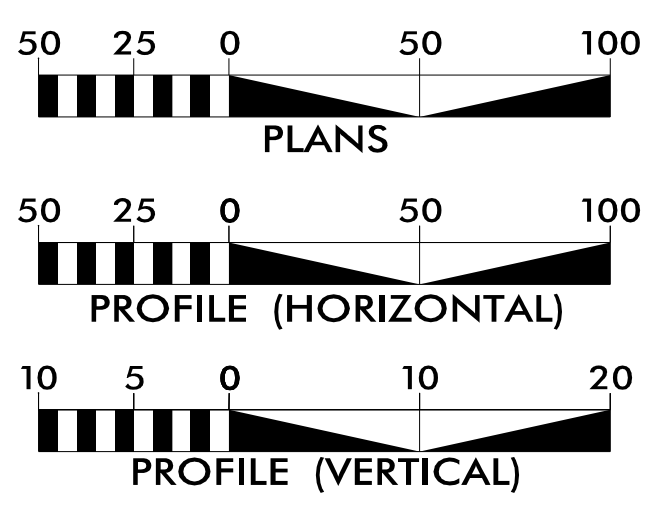

INDEX OF SHEETS

SHEET NO.:	DESCRIPTION:
UO-1	TITLE SHEET
UO-2 THRU UO-3	UO PLAN AND PROFILE SHEETS

UTILITY OWNERS WITH CONFLICTS


- (A) POWER DISTRIBUTION - DUKE ENERGY
- (B) GAS - PIEDMONT NATURAL GAS
- (C) COMMUNICATIONS - SPECTRUM, WINDSTREAM

PREPARED IN THE OFFICE OF:



11325 N COMMUNITY HOUSE RD. SUITE 260  
CHARLOTTE, NC 28277

CHAD ROGERS, PE UTILITY PROJECT MANAGER  
JIM CARLSON PROJECT UTILITY COORDINATOR

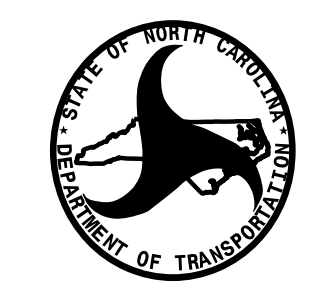

DIVISION OF HIGHWAYS  
UTILITIES UNIT  
1555 MAIL SERVICE CENTER  
RALEIGH, NC 27699-1555  
PHONE (919) 707-6609  
FAX (919) 250-4151

TUCKER MARTIN, PE	UTILITIES REGIONAL ENGINEER
JON LOUGHRY	UTILITIES ENGINEER
DAYTON MARTIN	UTILITIES REGIONAL COORDINATOR
JON GAILLARD	UTILITIES COORDINATOR

4/20/2020  
C:\BR0047\UTILITIES\UBO\_TSH.dgn  
2:47:45 PM