


NTS

**DOCUMENT NOT CONSIDERED FINAL
UNLESS ALL SIGNATURES COMPLETED**

USE FOR LIGHTING CONSTRUCTION ONLY

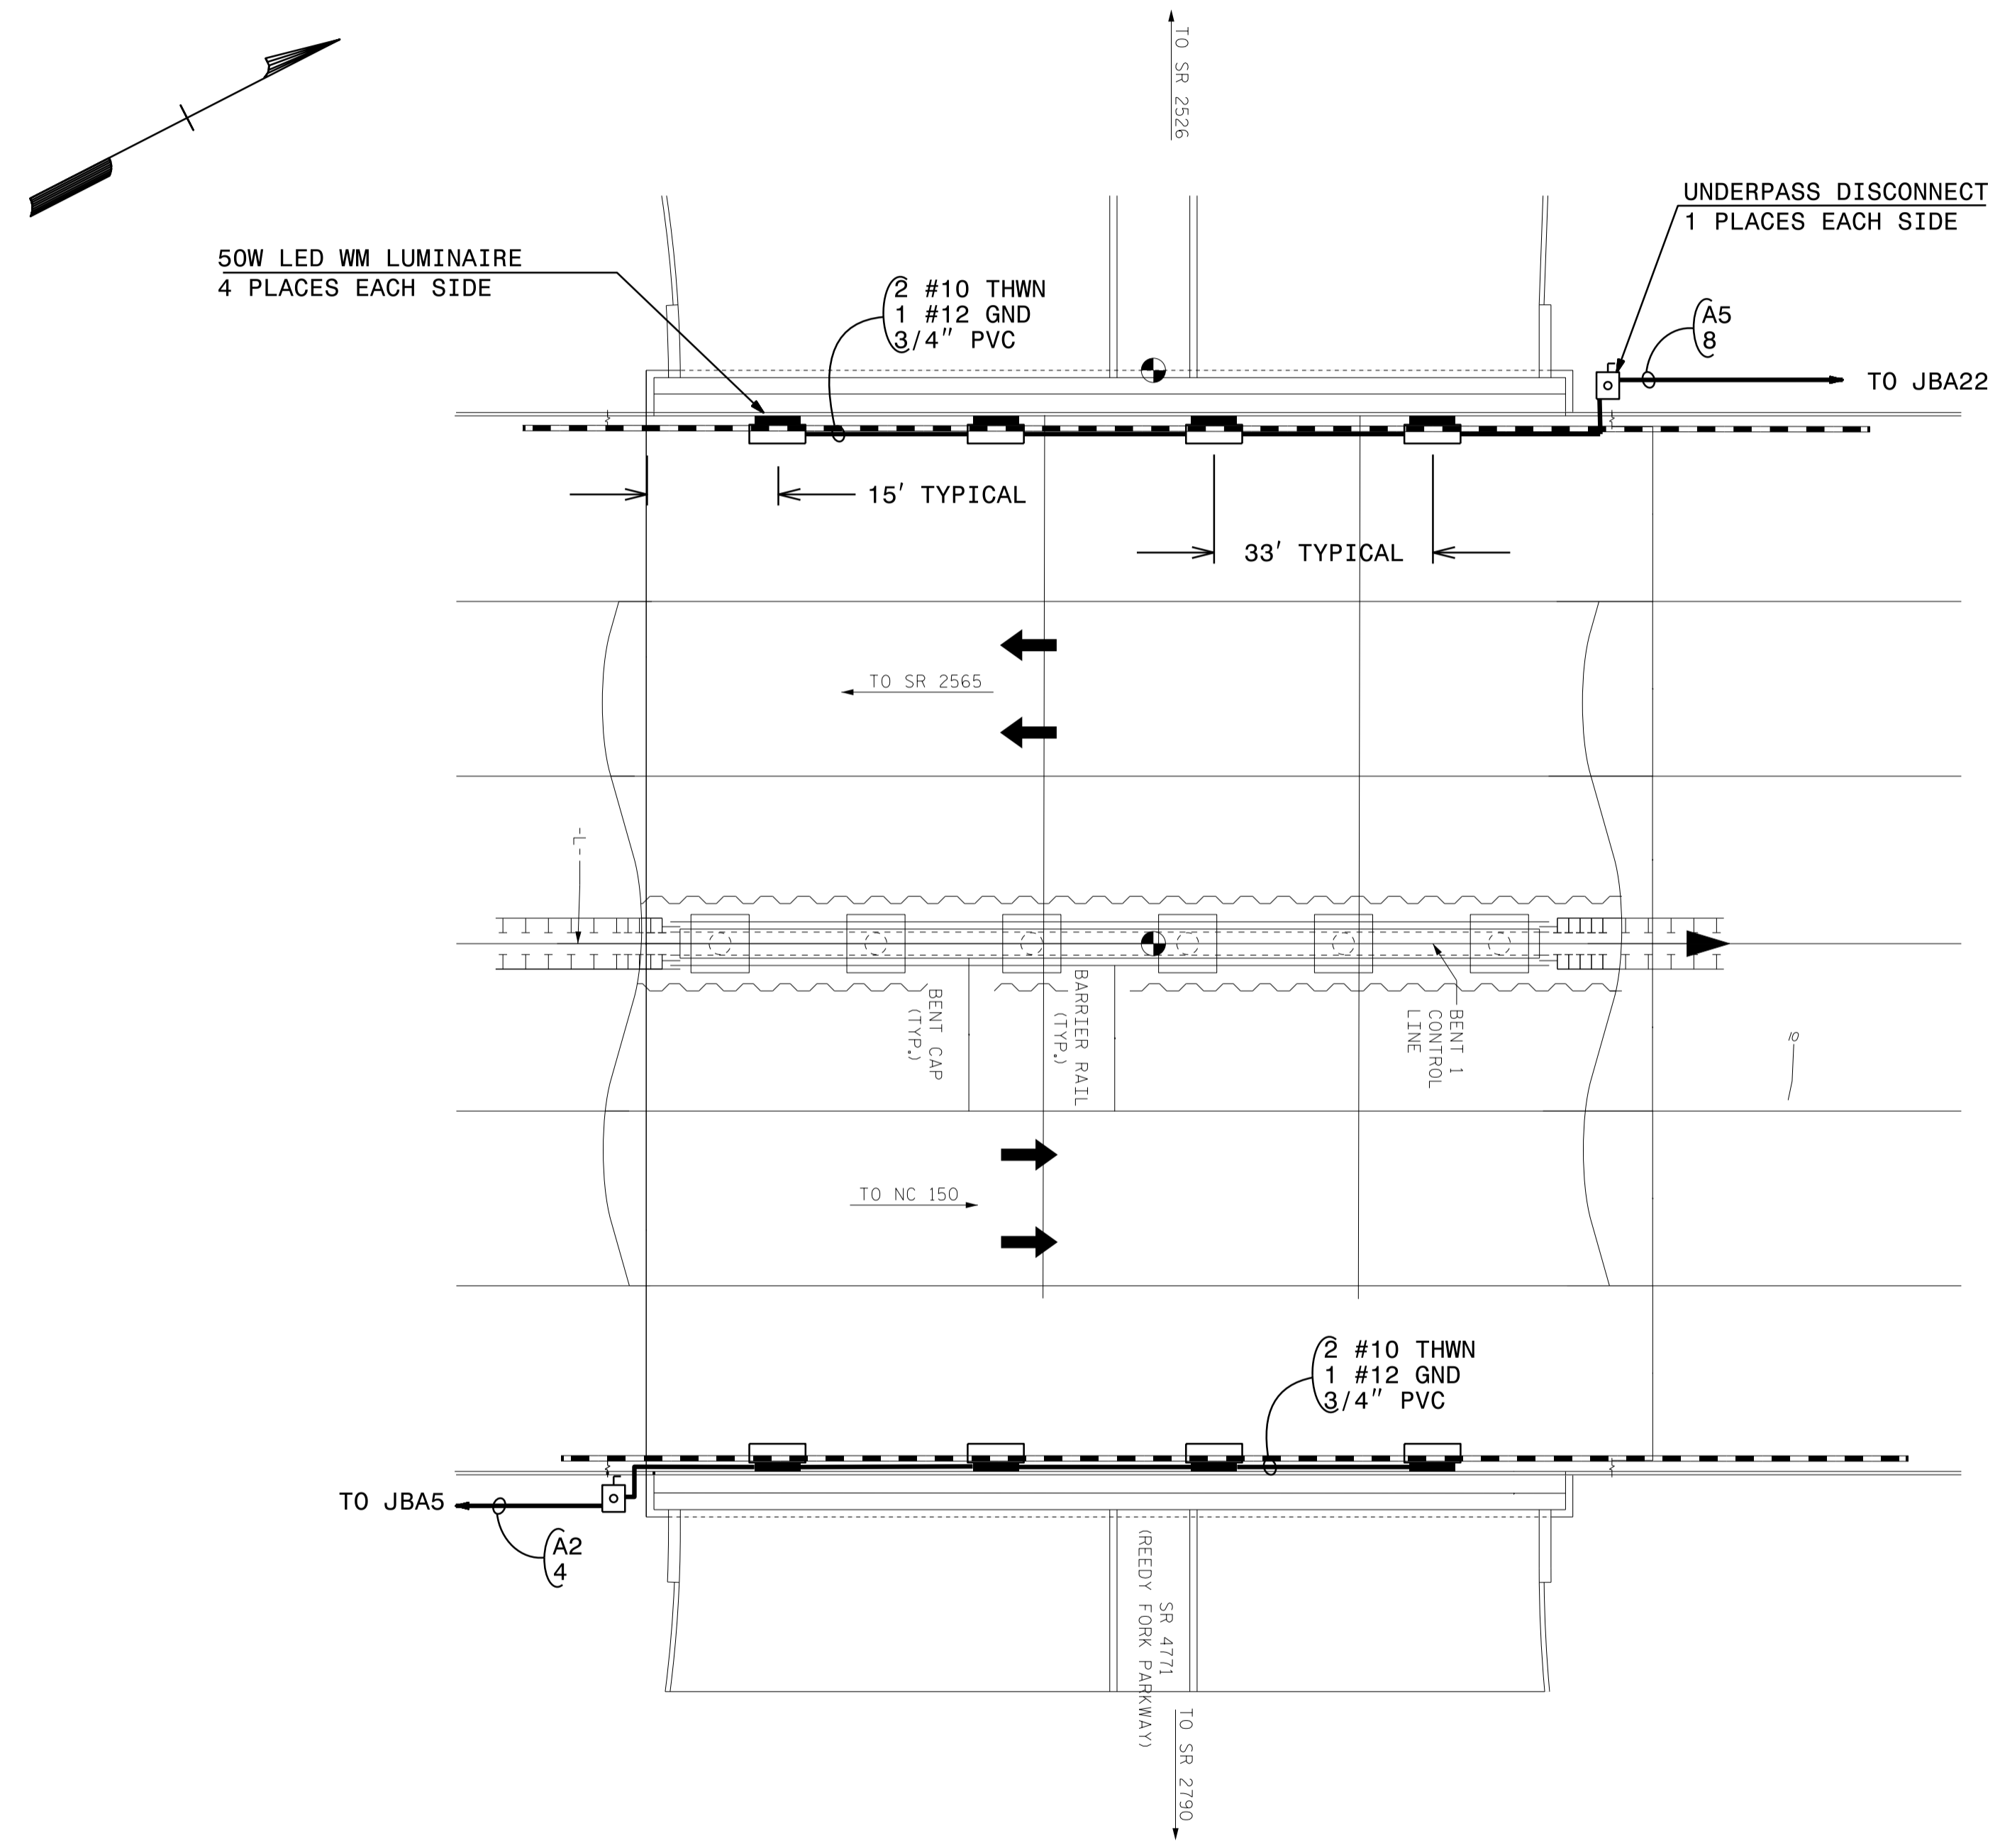

UNDERPASS LIGHTING LAYOUT
REEDY FORK PARKWAY BRIDGE OVER US 29
 (UPL-1 & UPL-2)

SEE SHEET "E1" FOR
 LEGEND & △ NOTES

2			
1			
Rev.	Date	Description	Approved

**NORTH CAROLINA
 DEPARTMENT OF TRANSPORTATION**
 ROADWAY DESIGN LIGHTING/ELECTRICAL SECTION

LIGHTING LAYOUT
 US 29/REEDY FORK PARKWAY
 INTERCHANGE

GUILFORD COUNTY
 Drawn By: SAM Approved By: RGH Dwg No.:

03-FEB-2020 10:38
 c:\workdir\ncdot\pwworking\shameen_malik\dms05922\R4707_LE_PSH_E4.dgn
 somaliki AT RD-304555