

5/14/99

342
338
334
330
326
322
318
314
310
306
302
298
294
290
286
282
278
274
270
266
262

SCALE: 1" = 20' HORIZONTAL
1" = 4' VERTICAL


NOTES:


1. LOCATION AND DEPTHS OF EXISTING UTILITIES ARE APPROXIMATE. CONTRACTOR TO FIELD VERIFY LOCATIONS AND DEPTHS PRIOR TO WATER LINE CONSTRUCTION.
2. CONTRACTOR TO NOTE THAT BETWEEN -WL1- STA.14+45 TO STA.21+50 (-L- STA.19+48.11 TO STA.26+47.75) AND -WL1- STA.23+40 TO STA.25+35 (L- STA.28+37.24 TO STA.30+30.06) PRE-GRADING WILL BE REQUIRED PRIOR TO WATER LINE INSTALLATION.CONTRACTOR SHALL PLAN CLEARING, GRADING AND EROSION CONTROL ACTIVITIES AS NECESSARY TO INSTALL PROPOSED WATER LINE.

PROP. 8" WATER LINE -WL1- NC-109

STV 100 Years
 STV Engineers, Inc.
 300 West Trade St., Suite 715
 Charlotte, NC 28202
 NC License Number F-0991

**DOCUMENT NOT CONSIDERED FINAL
 UNLESS ALL SIGNATURES COMPLETED**

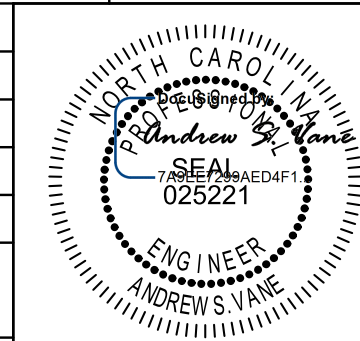PROJECT REFERENCE NO. B-5818	SHEET NO. UC-11
DESIGNED BY: PRJ	 NORTH CAROLINA DEPARTMENT OF TRANSPORTATION 11/19/2020 UTILITY CONSTRUCTION PLANS ONLY
DRAWN BY: PRJ	
CHECKED BY: ASV	
APPROVED BY:	
REVISED:	NORTH CAROLINA DEPARTMENT OF TRANSPORTATION UTILITY ENGINEERING SEC. PHONE: (919) 707-6690 FAX: (919) 250-4151
UTILITY CONSTRUCTION	

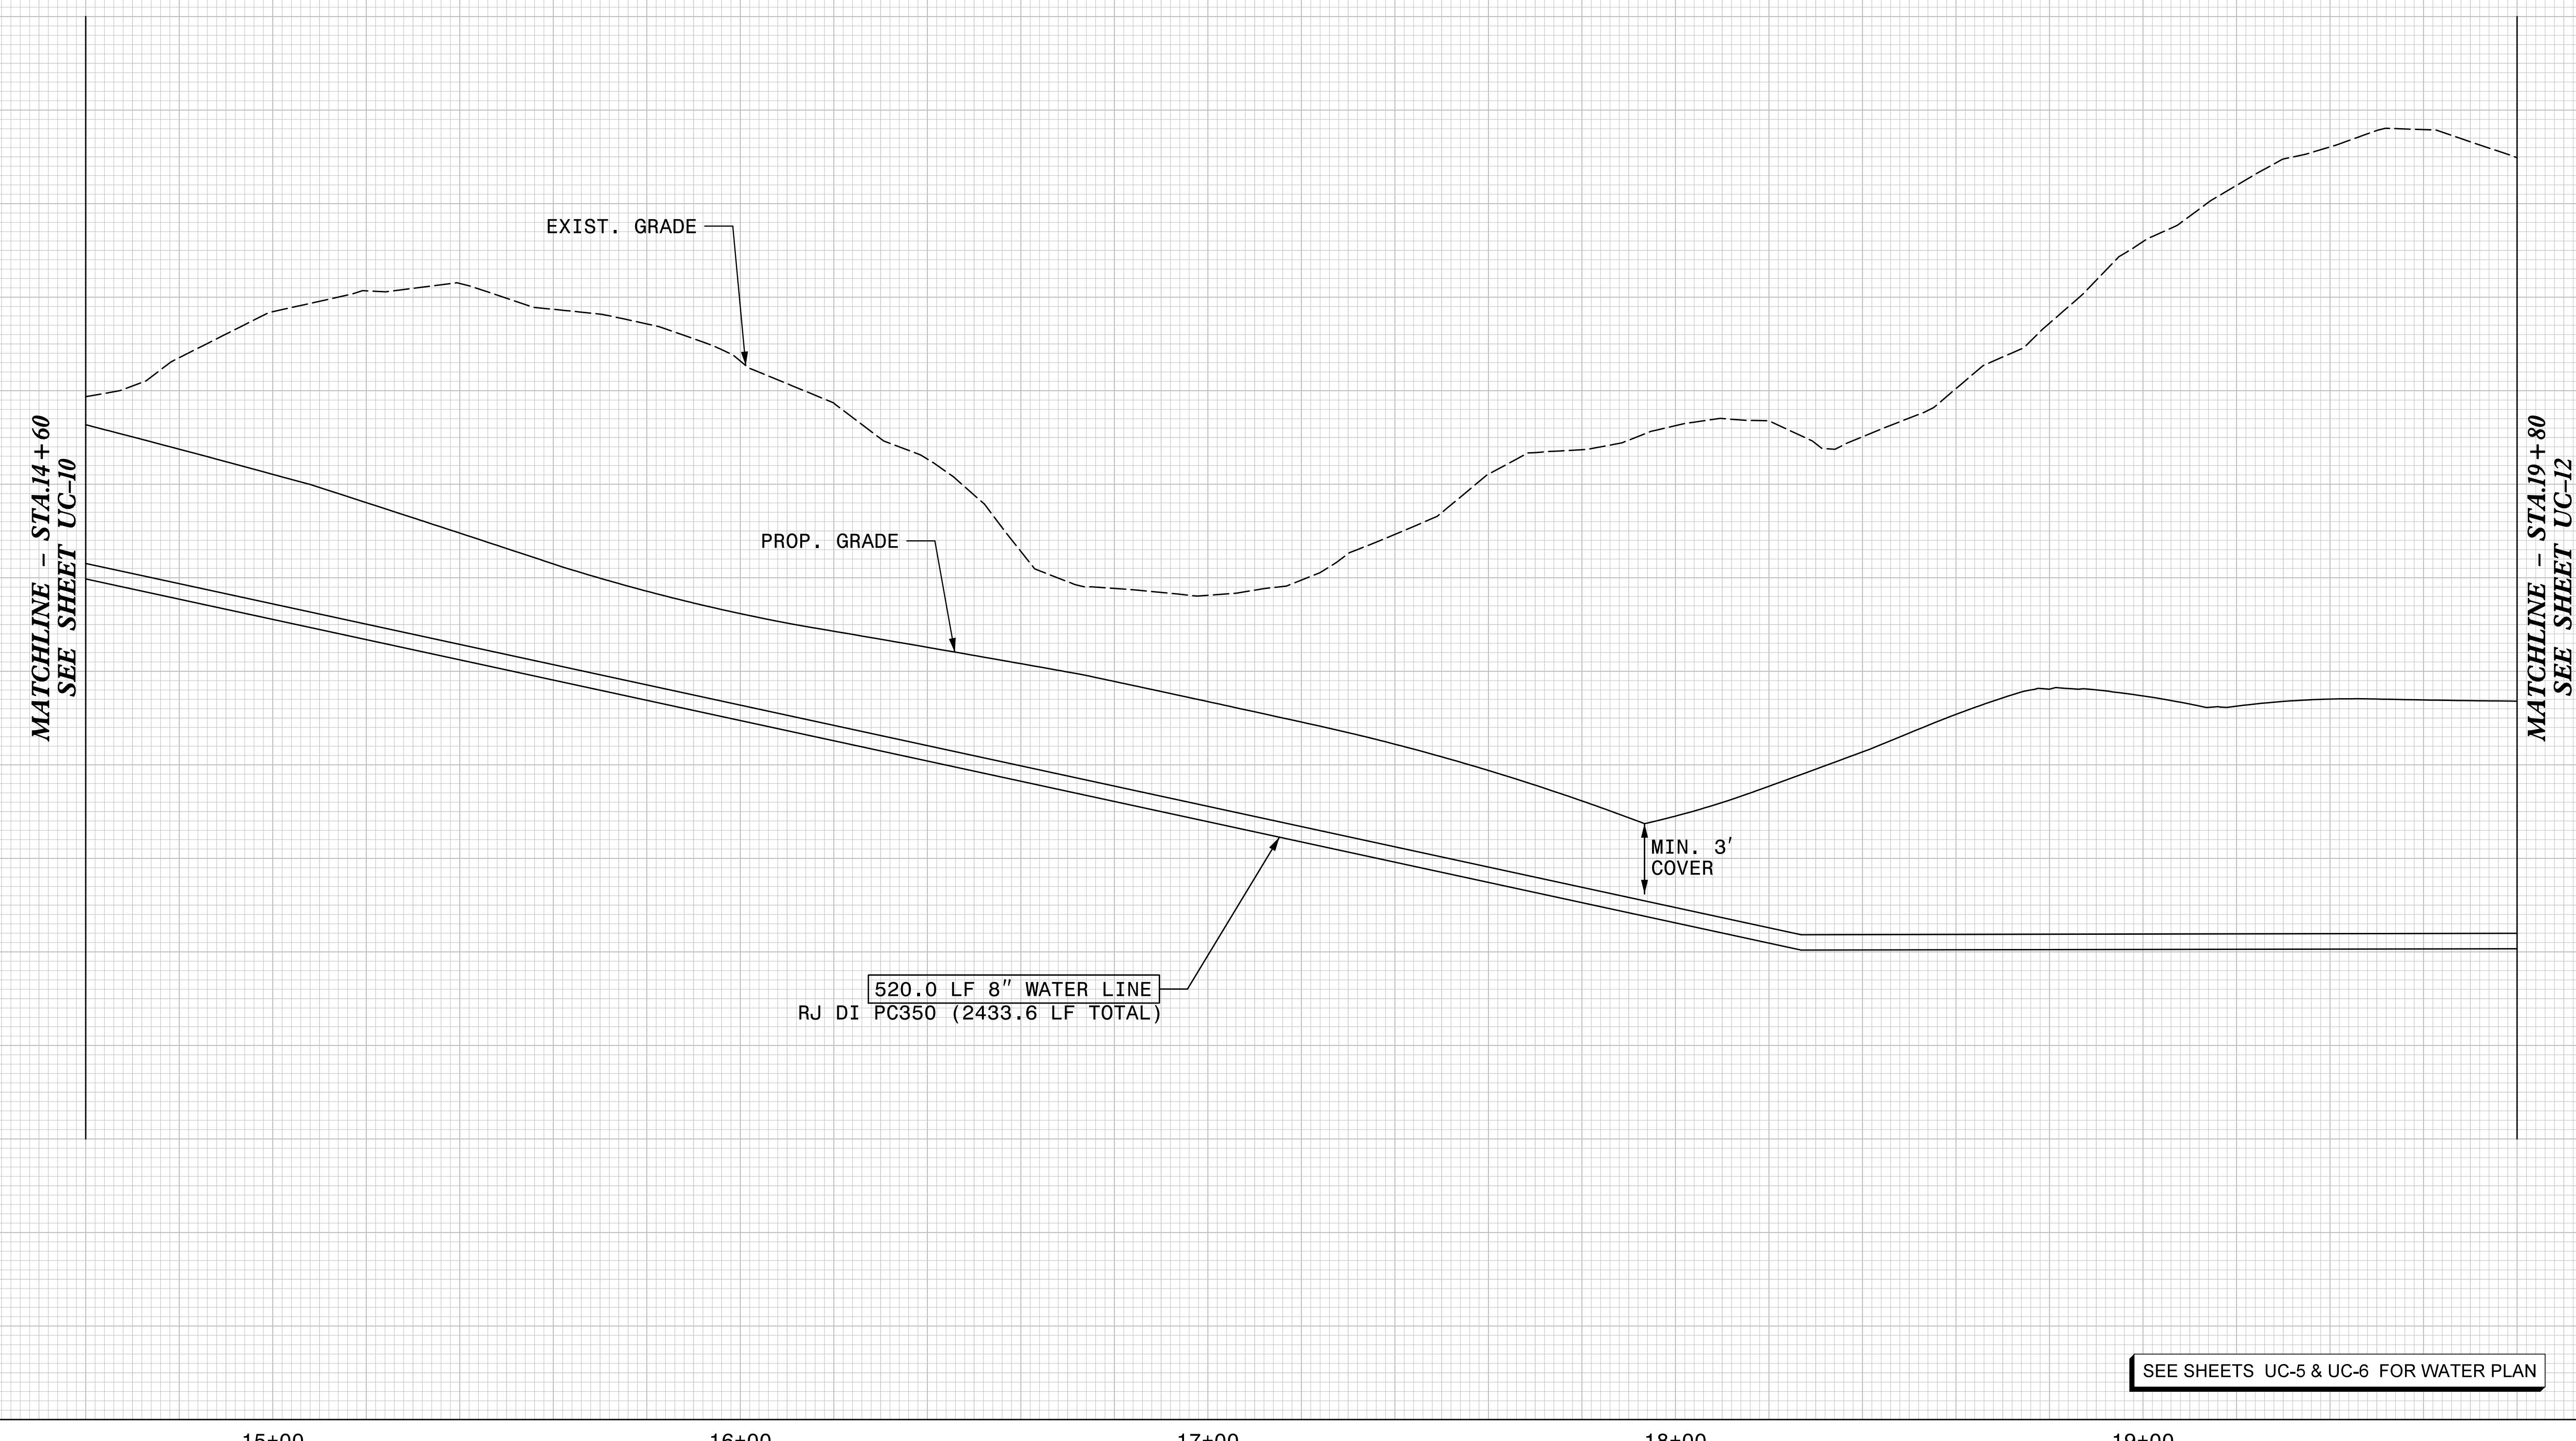

SEE SHEETS UC-5 & UC-6 FOR WATER PLAN

I:\18\2020\Projects\Utilities\Engineering\UC\Proj\Sheet\B5818.WS_UC11.dgn