



STATE OF NORTH CAROLINA
DIVISION OF HIGHWAYS

EDGECOMBE COUNTY


**LOCATION: REPLACE BRIDGE NO. 22 OVER
TOWN CREEK ON US 258**

TYPE OF WORK: WATERLINE RELOCATION

TIP PROJECT: B-4931

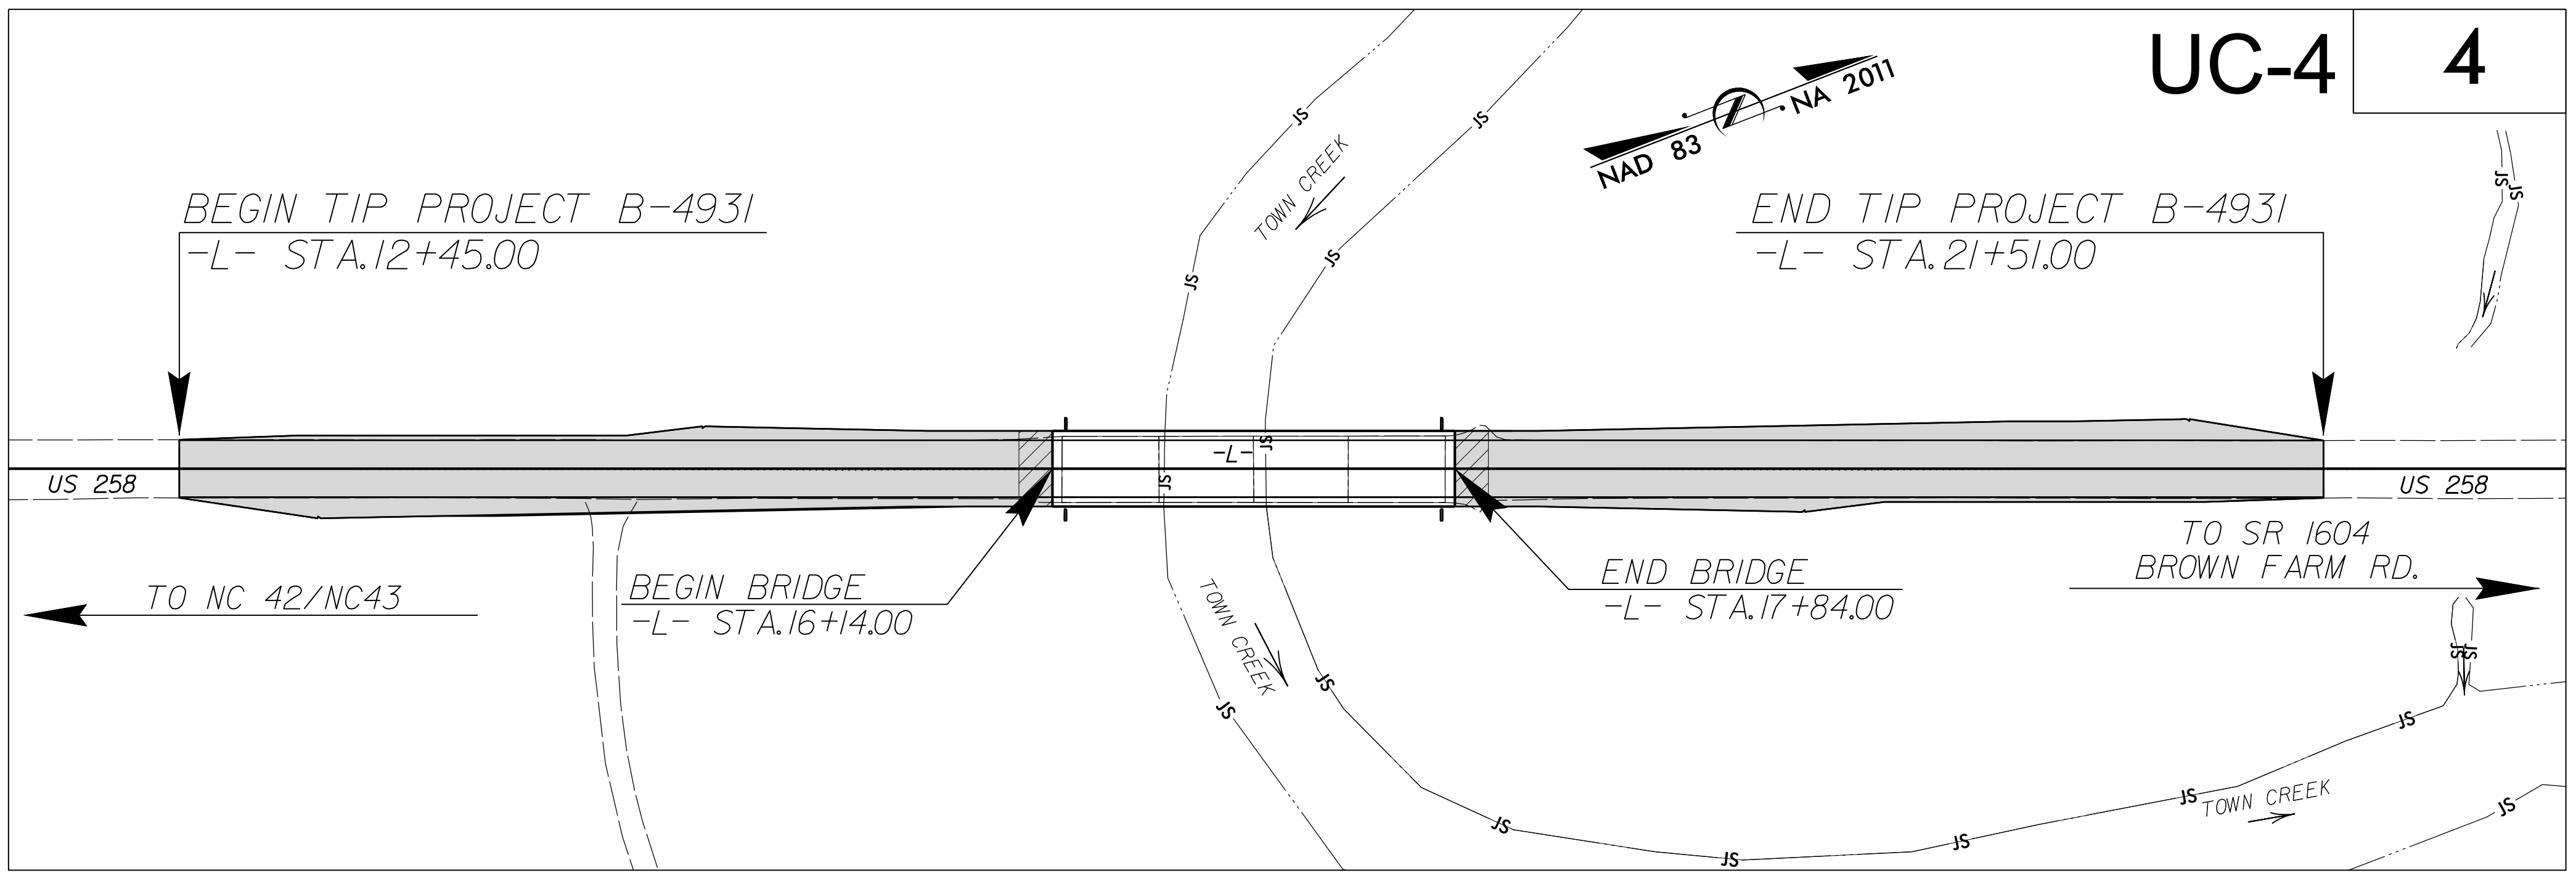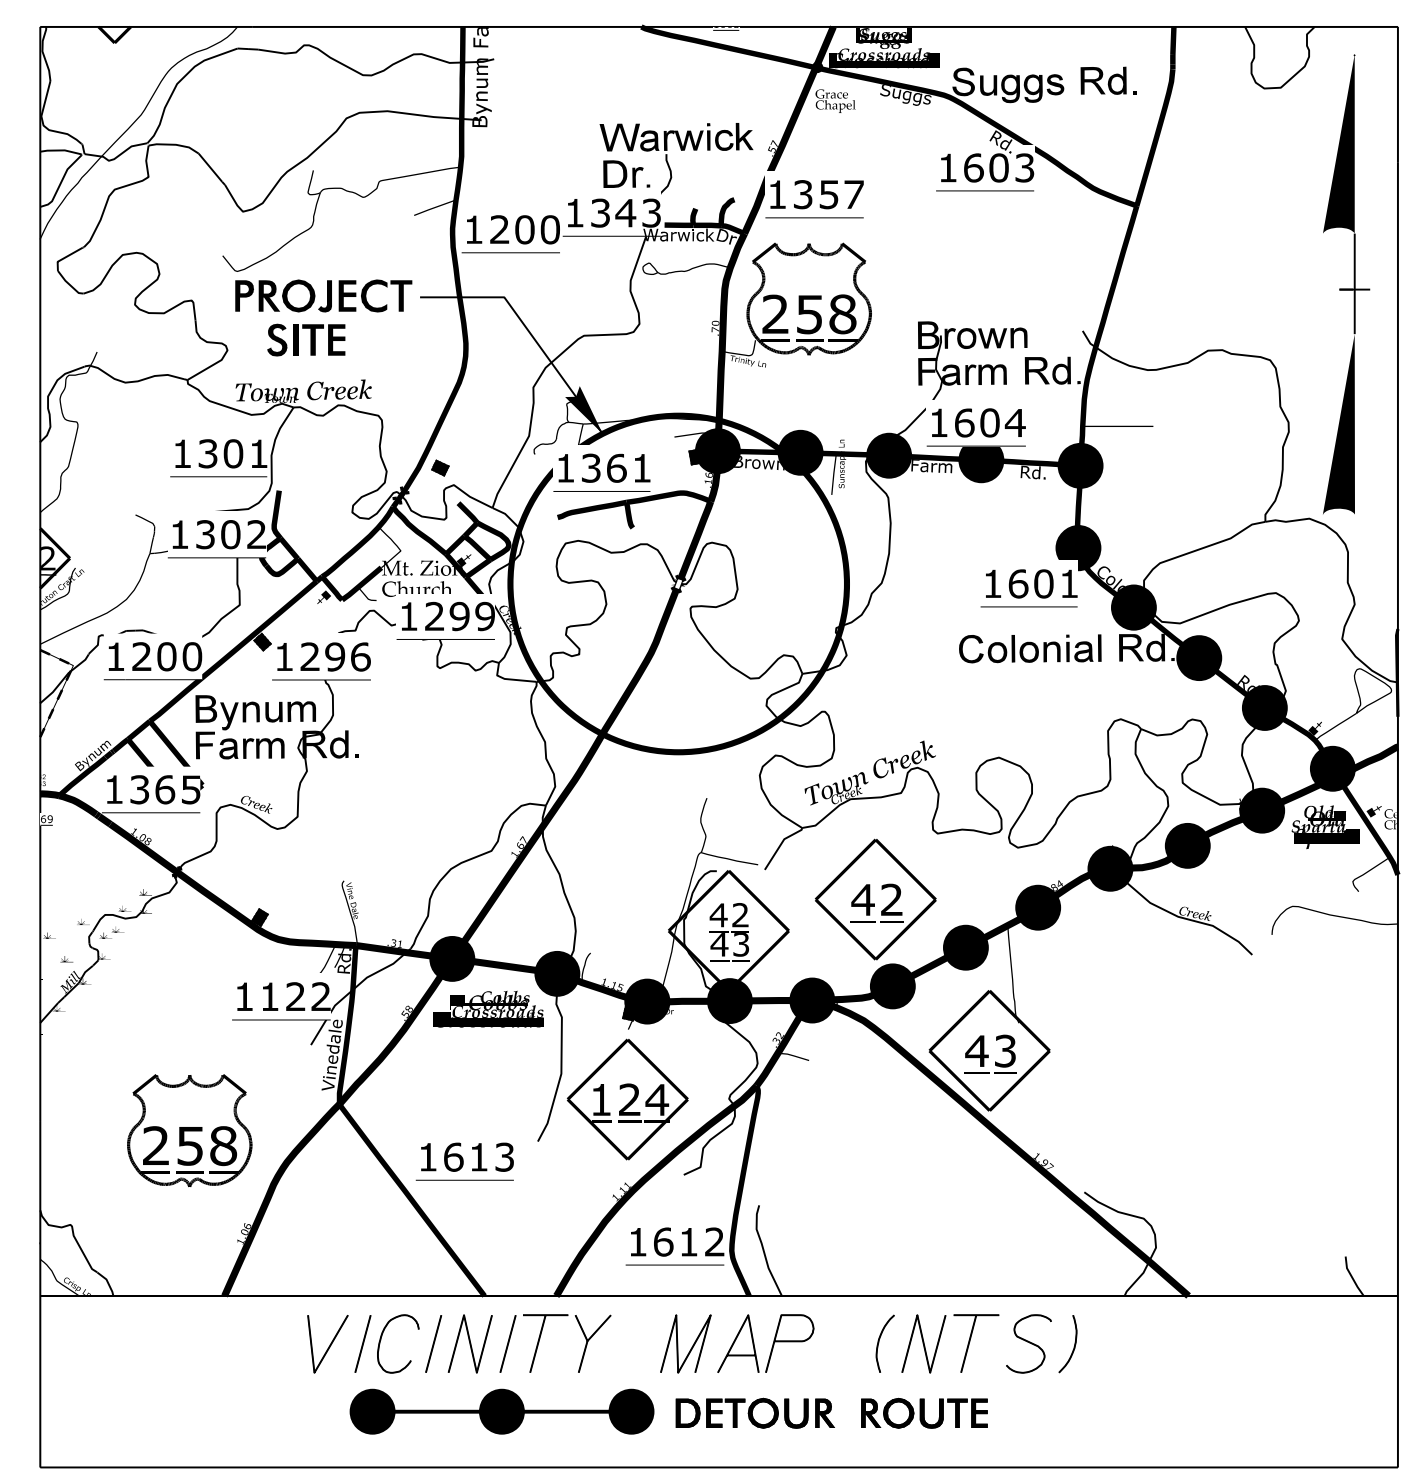

DOCUMENT NOT CONSIDERED FINAL
UNTIL ALL SIGNATURES ARE COMPLETED

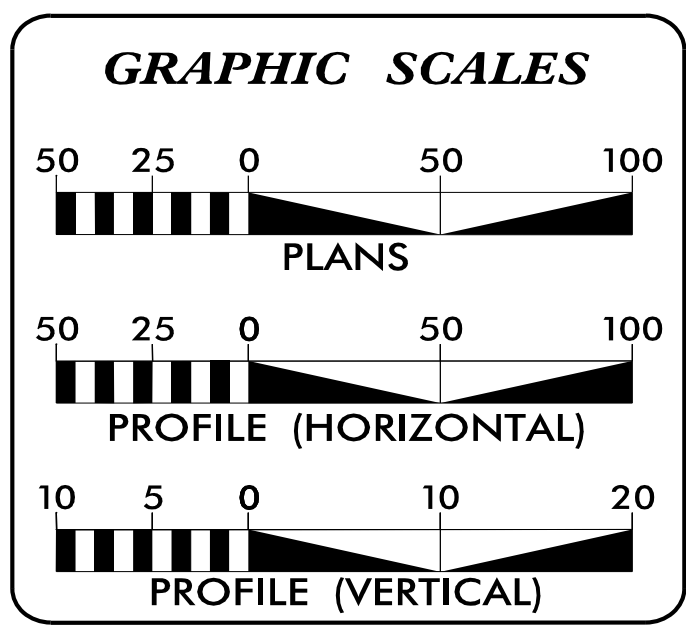

INDEX OF SHEETS

SHEET NO.:	DESCRIPTION:
UC-1	TITLE SHEET
UC-2	UTILITY SYMBOLOGY
UC-3	NOTES
UC-3A, UC-3B	DETAILS
UC-4	UTILITY PLAN SHEET
UC-5	UTILITY PROFILE SHEET

**WATER OWNER
ON PROJECT**

EDGECOMBE COUNTY WATER AND SEWER
201 SAINT ANDREW STREET
POST OFFICE BOX 10
TARBORO, NC 27886

PREPARED IN THE OFFICE OF

KCI
Engineers • Planners • Scientists • Construction Managers
4505 Falls of Neuse Road, Suite 400
Raleigh, NC 27609
Phone (919) 783-9214 • Fax (919) 783-9266
License No. C-764

DINKISSA KEREYU, PE PROJECT ENGINEER
MARCO MENENDEZ, PE PROJECT MANAGER
CHARLES SHEARON PROJECT DESIGNER

SEAL

Professional Engineer
MARCOS MENENDEZ
3/6/2020

**DIVISION OF HIGHWAYS
UTILITIES UNIT**
1555 MAIL SERVICES CENTER
RALEIGH, NC 27699-1555
PHONE (919) 707-6690
FAX (919) 250-4151

NABIL HAMDAN UTILITIES REGIONAL ENGINEER
KIFAH KAMIL UTILITIES ENGINEER
KYLE PLEASANT UTILITIES AREA COORDINATOR
LARRY JAMES UTILITIES COORDINATOR