


DOCUMENT NOT CONSIDERED FINAL
UNLESS ALL SIGNATURES COMPLETED

MATCHLINE - L1 - STA 47+92 SEE SHEET E3

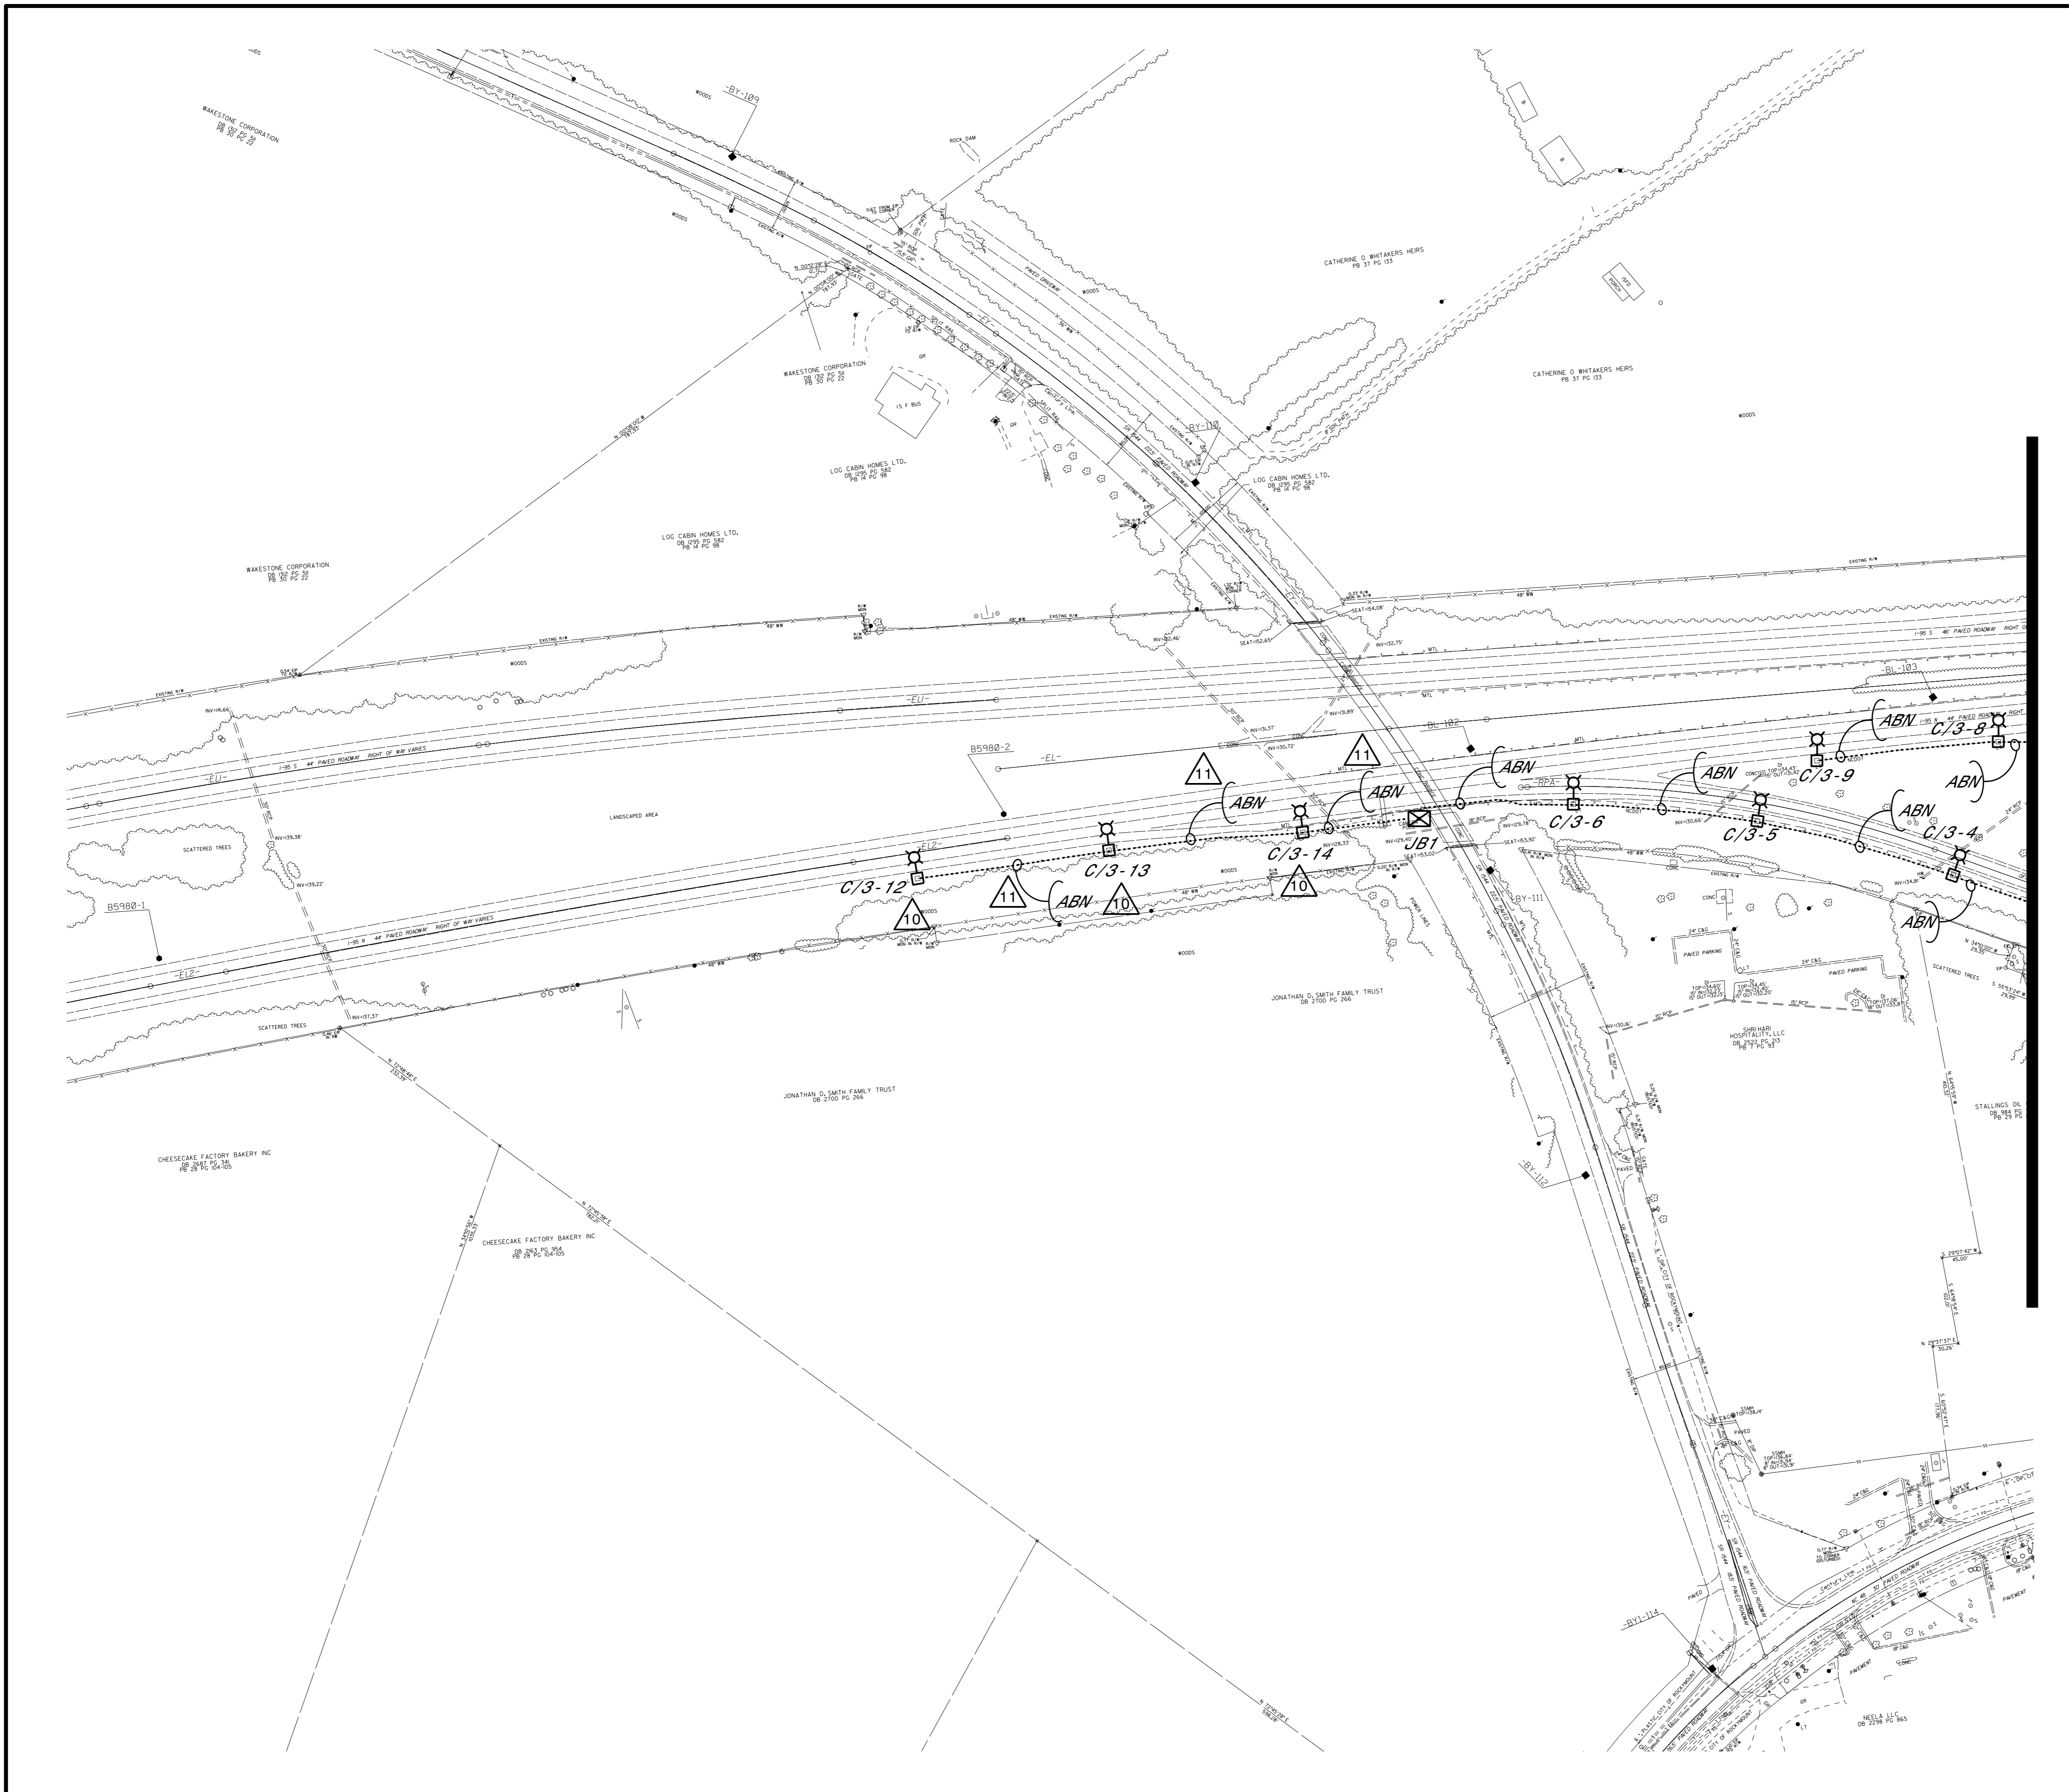

I5-MAR-2021 11:03
R:\Lighting\Lighting Design\B5980.LE.DSN.PSH.E2.dgn
rghe1 At RD-303042L

2			
1			
Rev.	Date	Description	Approved
NORTH CAROLINA DEPARTMENT OF TRANSPORTATION ROADWAY DESIGN LIGHTING/ELECTRICAL SECTION EXISTING LIGHTING LAYOUT I-95/NC 4 INTERCHANGE NASH COUNTY			
Drawn By:	TQ	Approved By:	RGH
Dwg No.:			