


DOCUMENT NOT CONSIDERED FINAL
UNLESS ALL SIGNATURES COMPLETED

MATCHLINE -L1- STA 47+92 - SEE SHEET E5

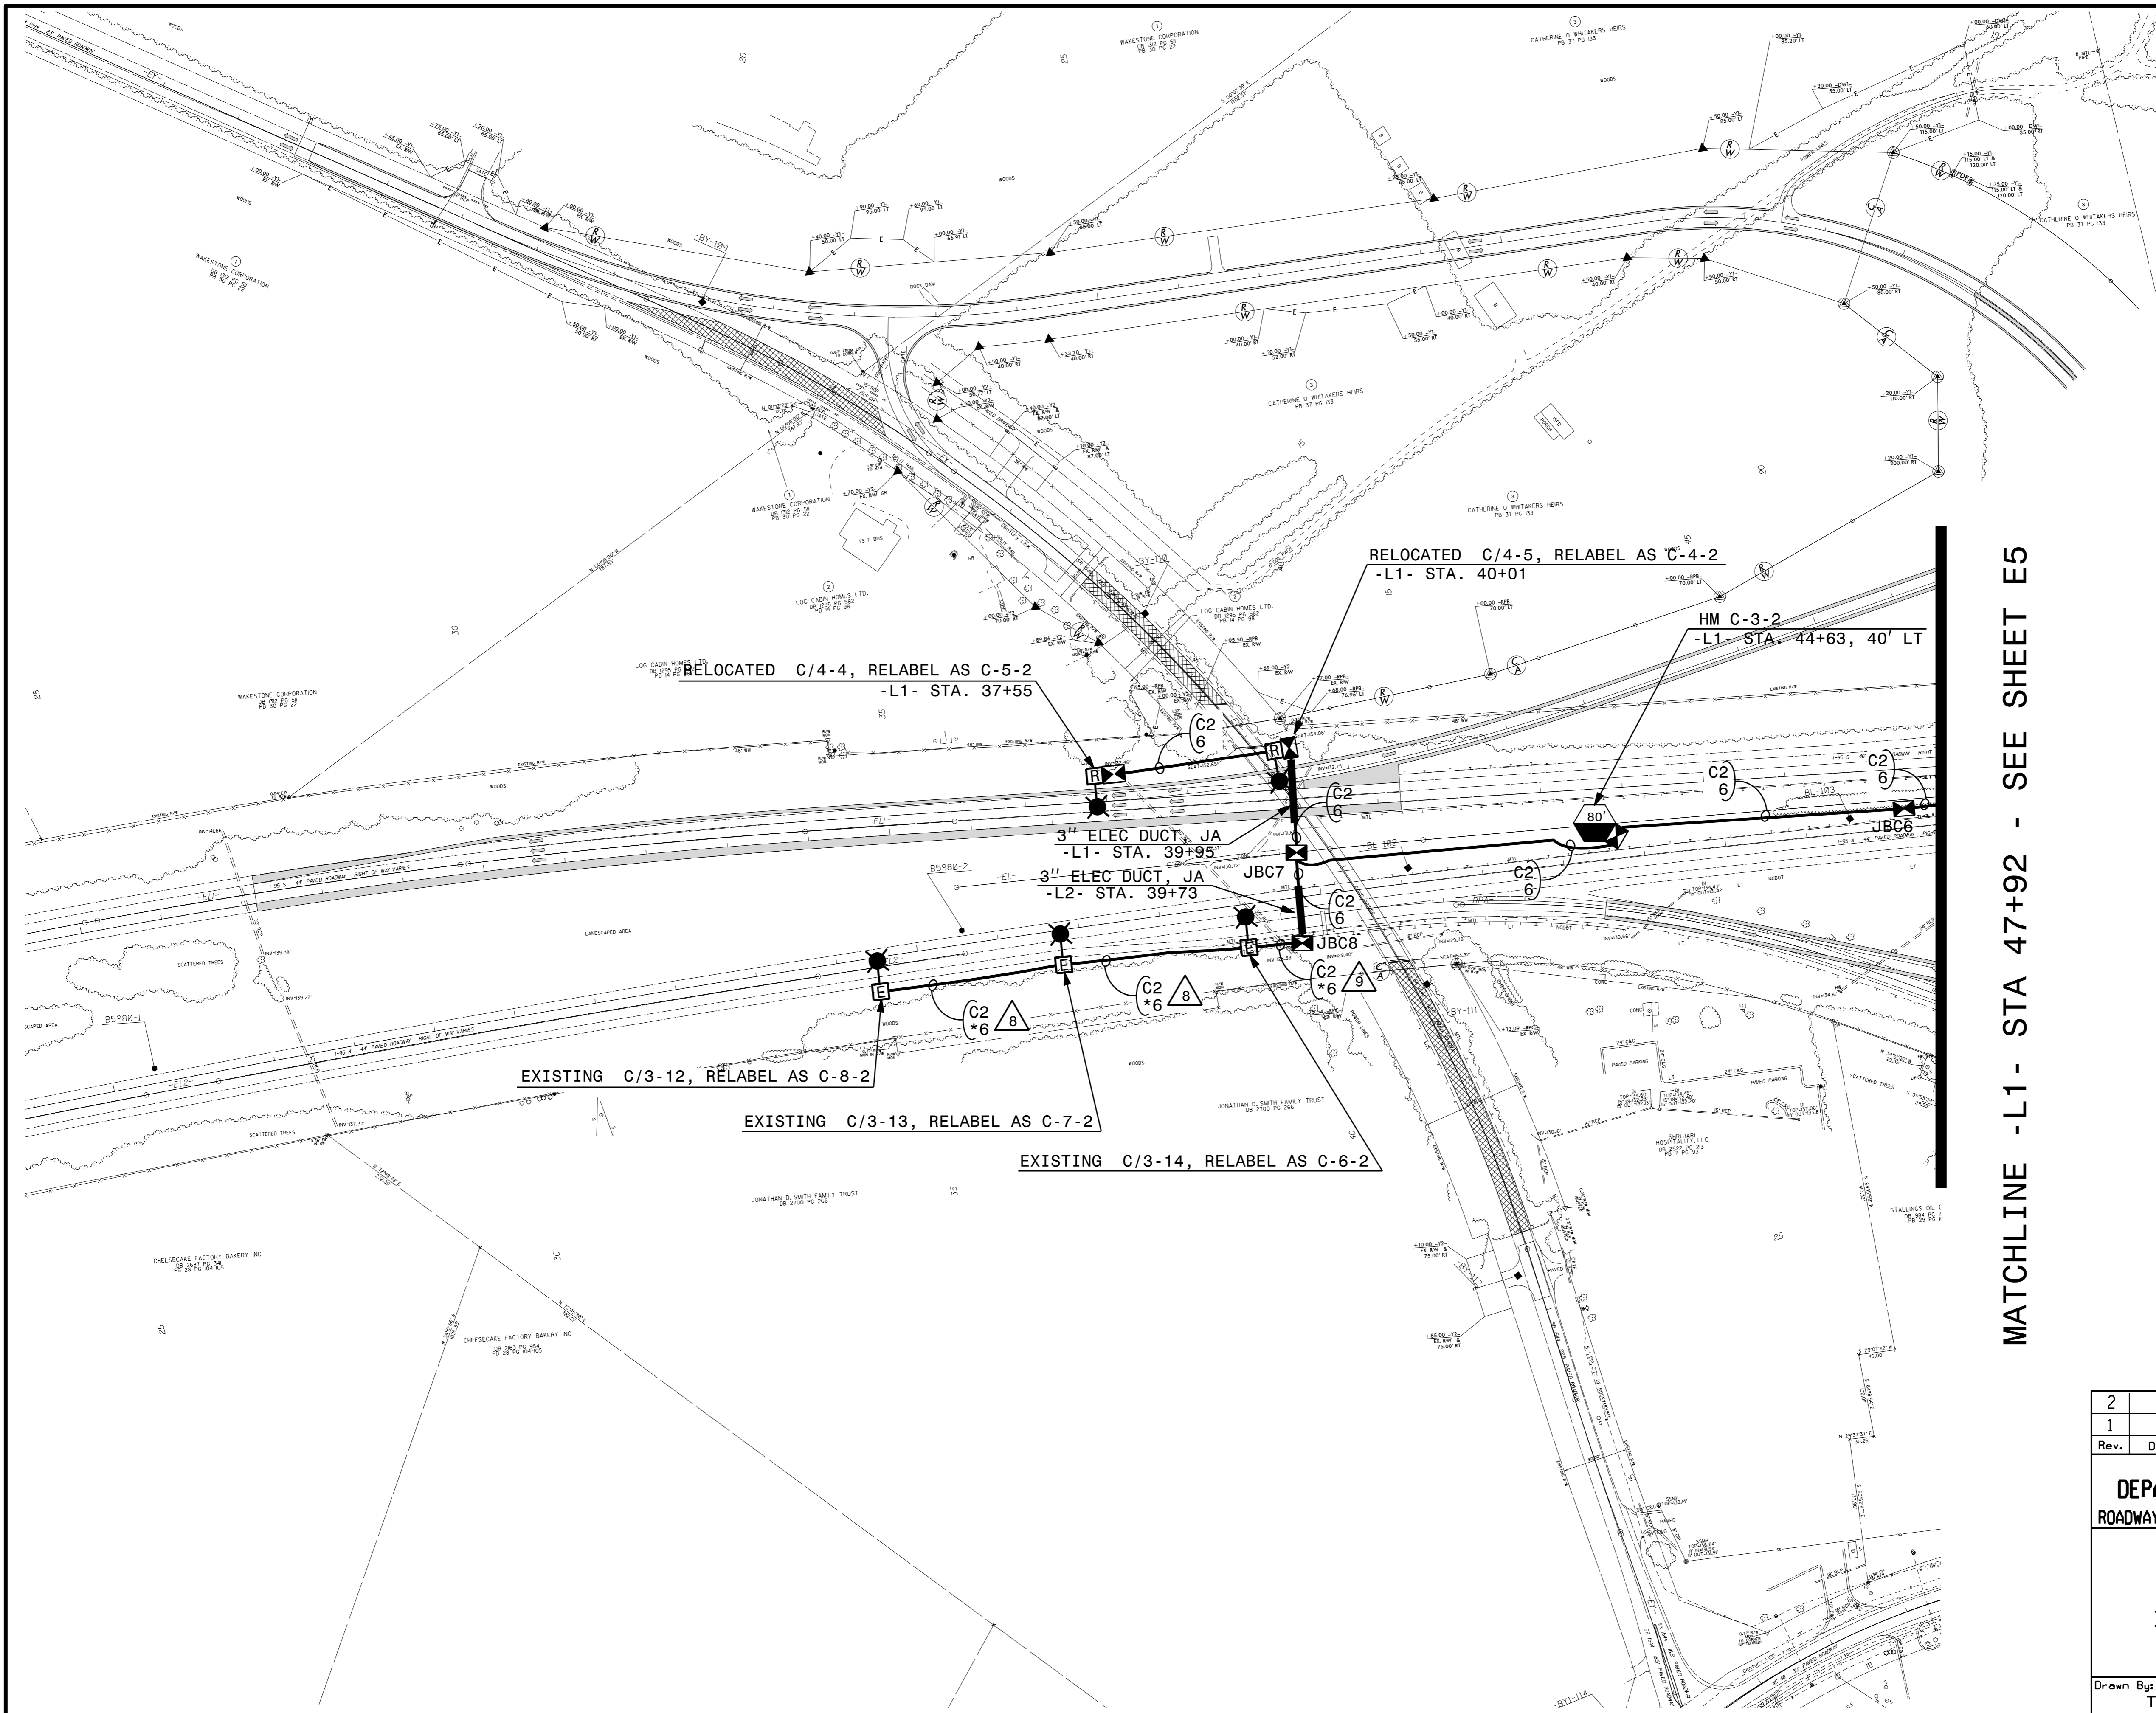

2			
1			
Rev.	Date	Description	Approved
NORTH CAROLINA DEPARTMENT OF TRANSPORTATION ROADWAY DESIGN LIGHTING/ELECTRICAL SECTION PROPOSED LIGHTING LAYOUT I-95/NC 4 INTERCHANGE NASH COUNTY			
Drawn By:	TQ	Approved By:	RGH
Dwg No.:			

I5-MAR-2021 10:48
R:\Lighting\Lighting Design\5980.LE.DSN.PSH.E4.dgn
rghe1 At RD-303048L