
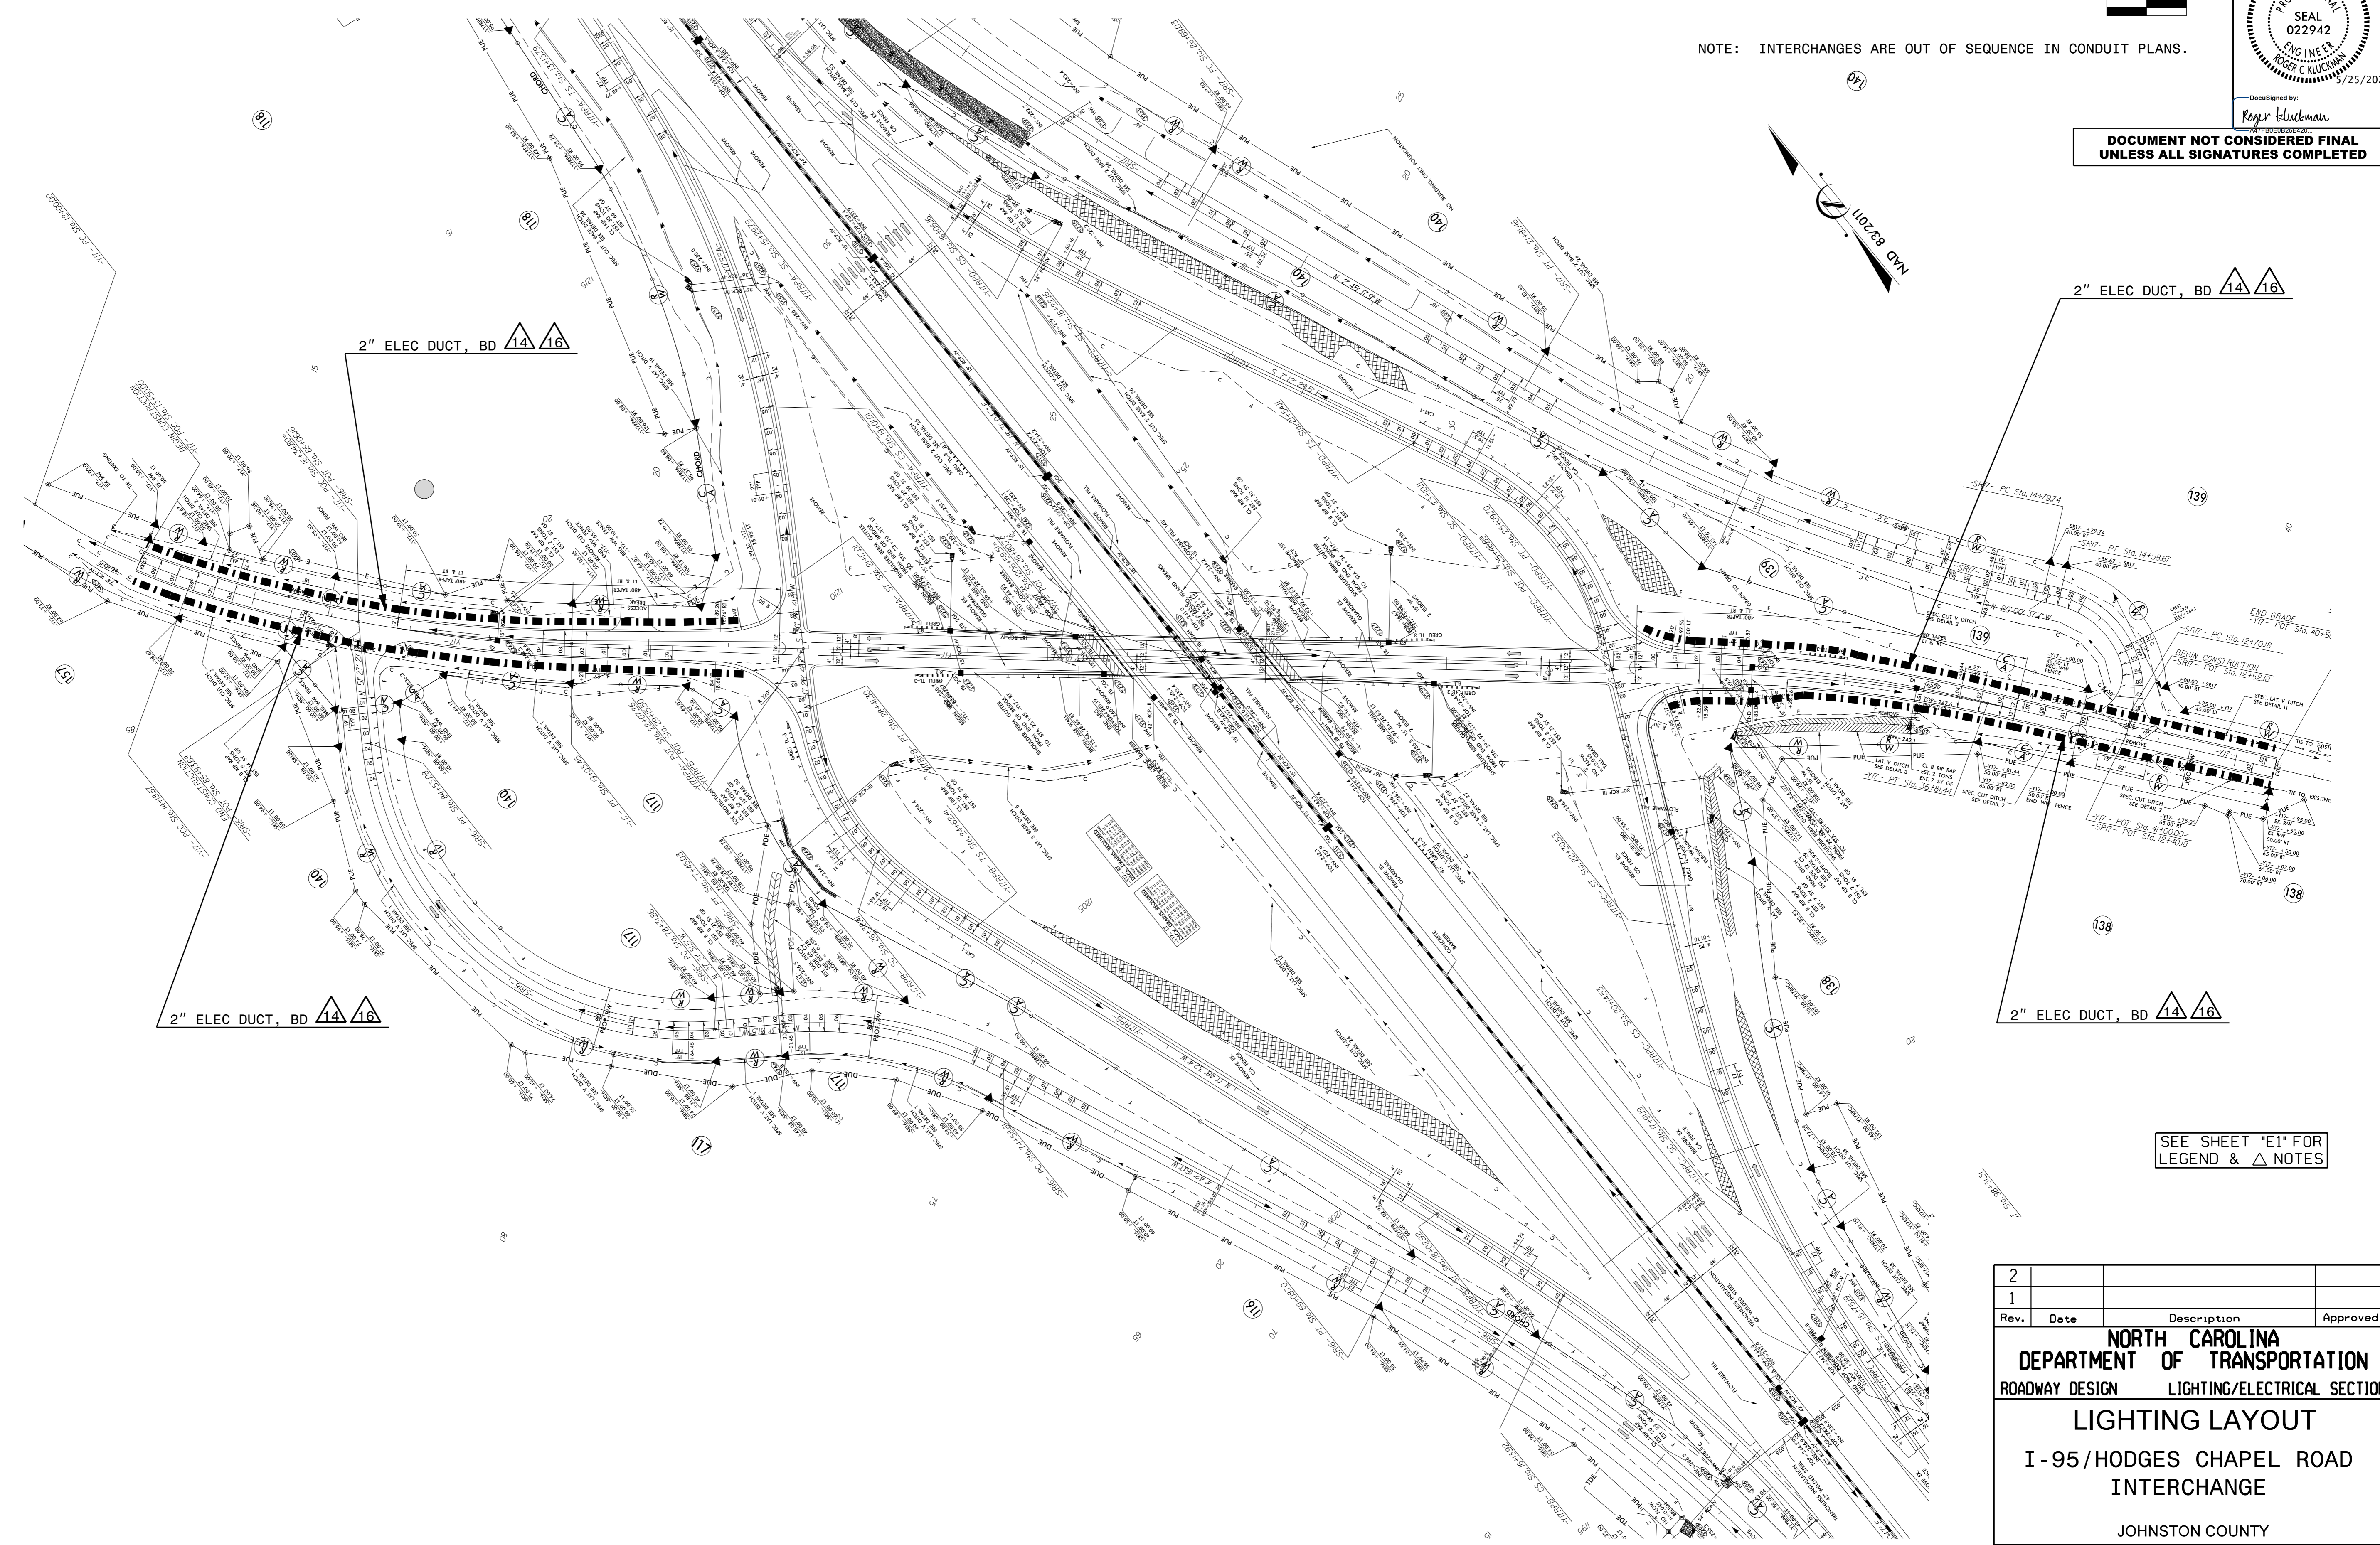


NOTE: INTERCHANGES ARE OUT OF SEQUENCE IN CONDUIT PLANS.

DocuSigned by:
Roger Kluckmann

**DOCUMENT NOT CONSIDERED FINAL
UNLESS ALL SIGNATURES COMPLETED**

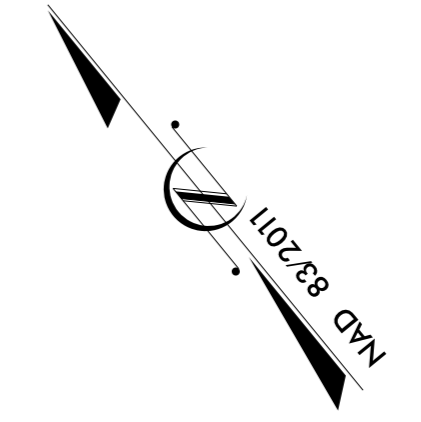

SEE SHEET "E1" FOR
LEGEND & Δ NOTES

| 2 | | | |
|---|------|-------------|----------|
| 1 | | | |
| Rev. | Date | Description | Approved |
| NORTH CAROLINA DEPARTMENT OF TRANSPORTATION ROADWAY DESIGN LIGHTING/ELECTRICAL SECTION LIGHTING LAYOUT I - 95/HODGES CHAPEL ROAD INTERCHANGE JOHNSTON COUNTY Drawn By: RGH Approved By: RCK Dwg No.: | | | |

20-MAY-2021 15:29
 R:\Lighting\Lighting Design\Design\I-59866B.LE.Conduit.dsn.E15.dgn
 rghal At: RD-303048L