
 
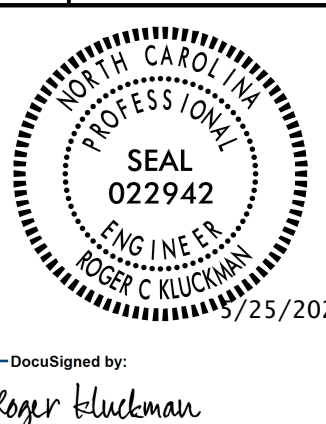



NOTE: INTERCHANGES ARE OUT OF SEQUENCE IN CONDUIT PLANS.

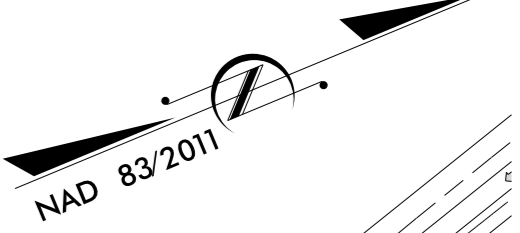

DocuSigned by:
Roger Kluckman
3/25/2021

**DOCUMENT NOT CONSIDERED FINAL
UNLESS ALL SIGNATURES COMPLETED**

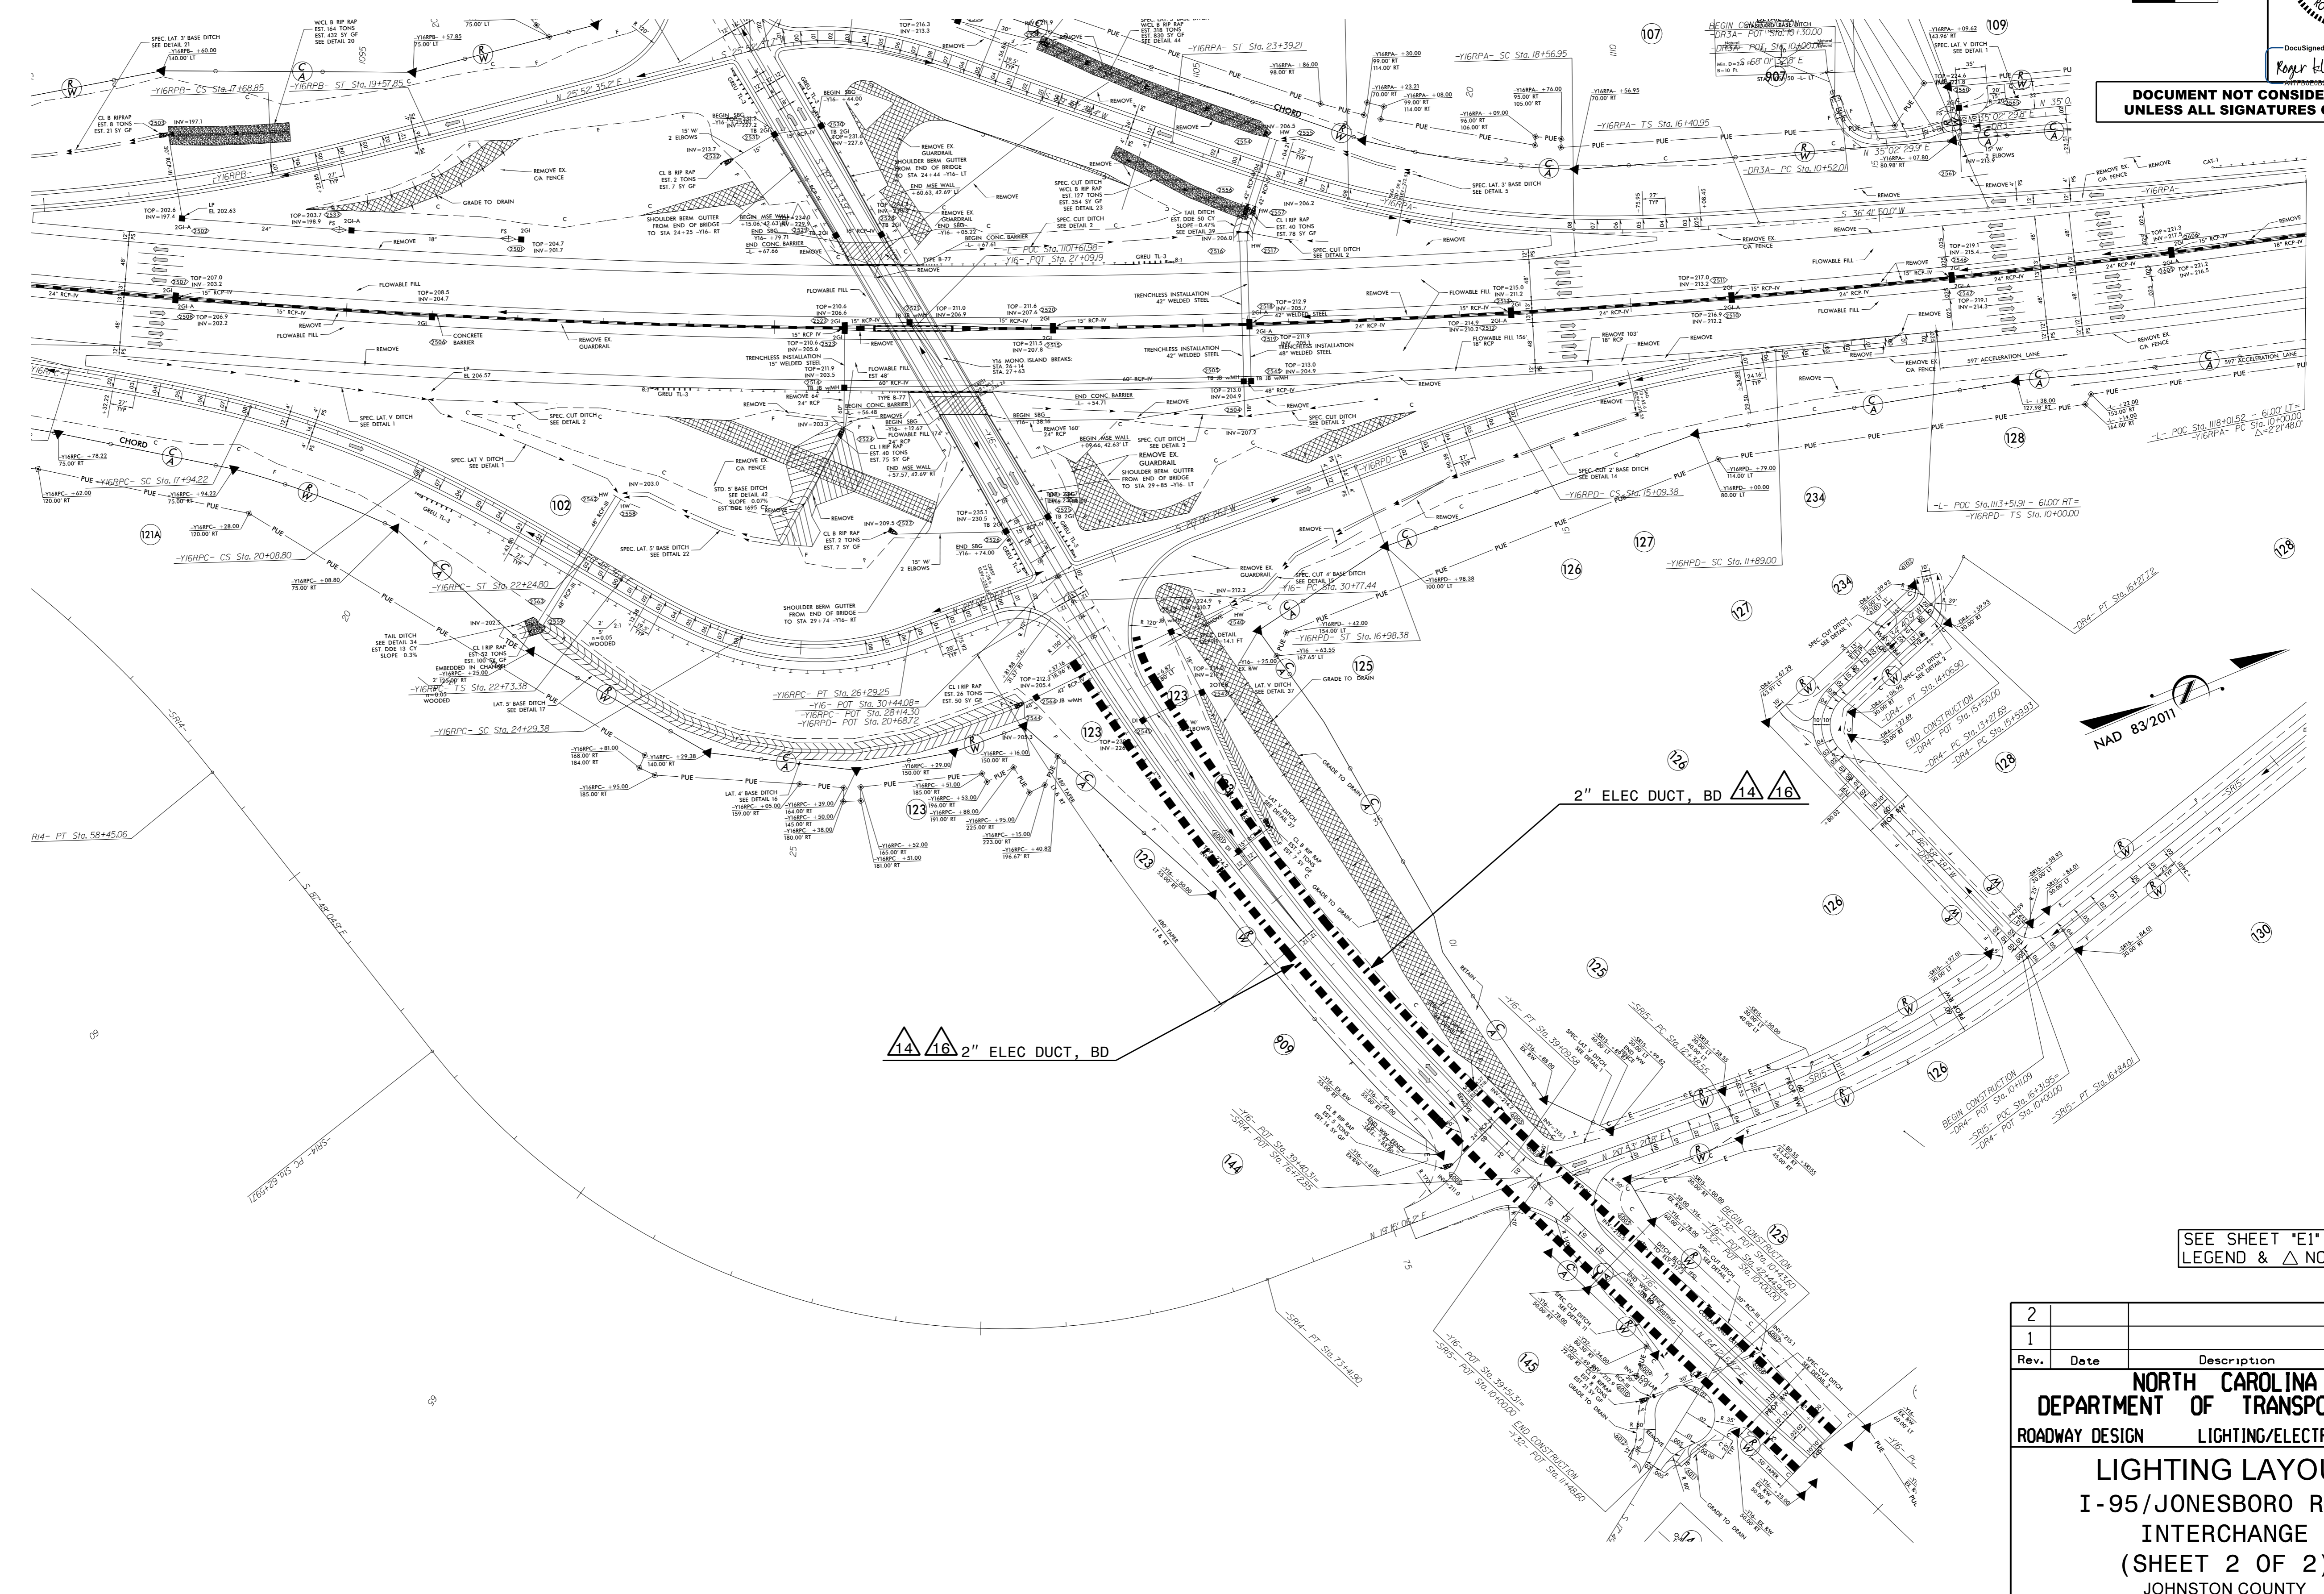

SEE SHEET "E1" FOR
LEGEND & △ NOTES

Rev.	Date	Description	Approved
2			
1			

**NORTH CAROLINA
DEPARTMENT OF TRANSPORTATION**

ROADWAY DESIGN LIGHTING/ELECTRICAL SECTION

**LIGHTING LAYOUT
I-95/JONESBORO ROAD
INTERCHANGE
(SHEET 2 OF 2)
JOHNSTON COUNTY**

Drawn By: RGH Approved By: RCK Dwg No.:

20-MAY-2021 15:26
R:\Lighting\Lighting Design\Design\I-59866B.LE.Conduit.dsn.E14.dgn
rgahl AT RD 303042L