


20-MAY-2021 15:26
R:\Lighting\Lighting Design\Design\I-5986B.LE.Conduit.dsn.E14.dgn
rgball AT RD 303048L

PROJECT REFERENCE NO.
1-5883

SHEET NO.
E14


NOTE: INTERCHANGES ARE OUT OF SEQUENCE IN CONDUIT PLANS.

0 50 100

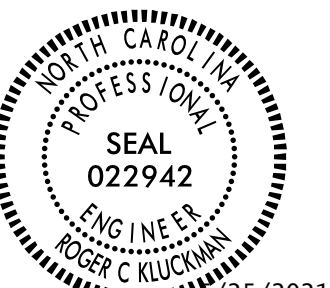

Documented by:
Roger Kluckman


DOCUMENT NOT CONSIDERED FINAL
UNLESS ALL SIGNATURES COMPLETED

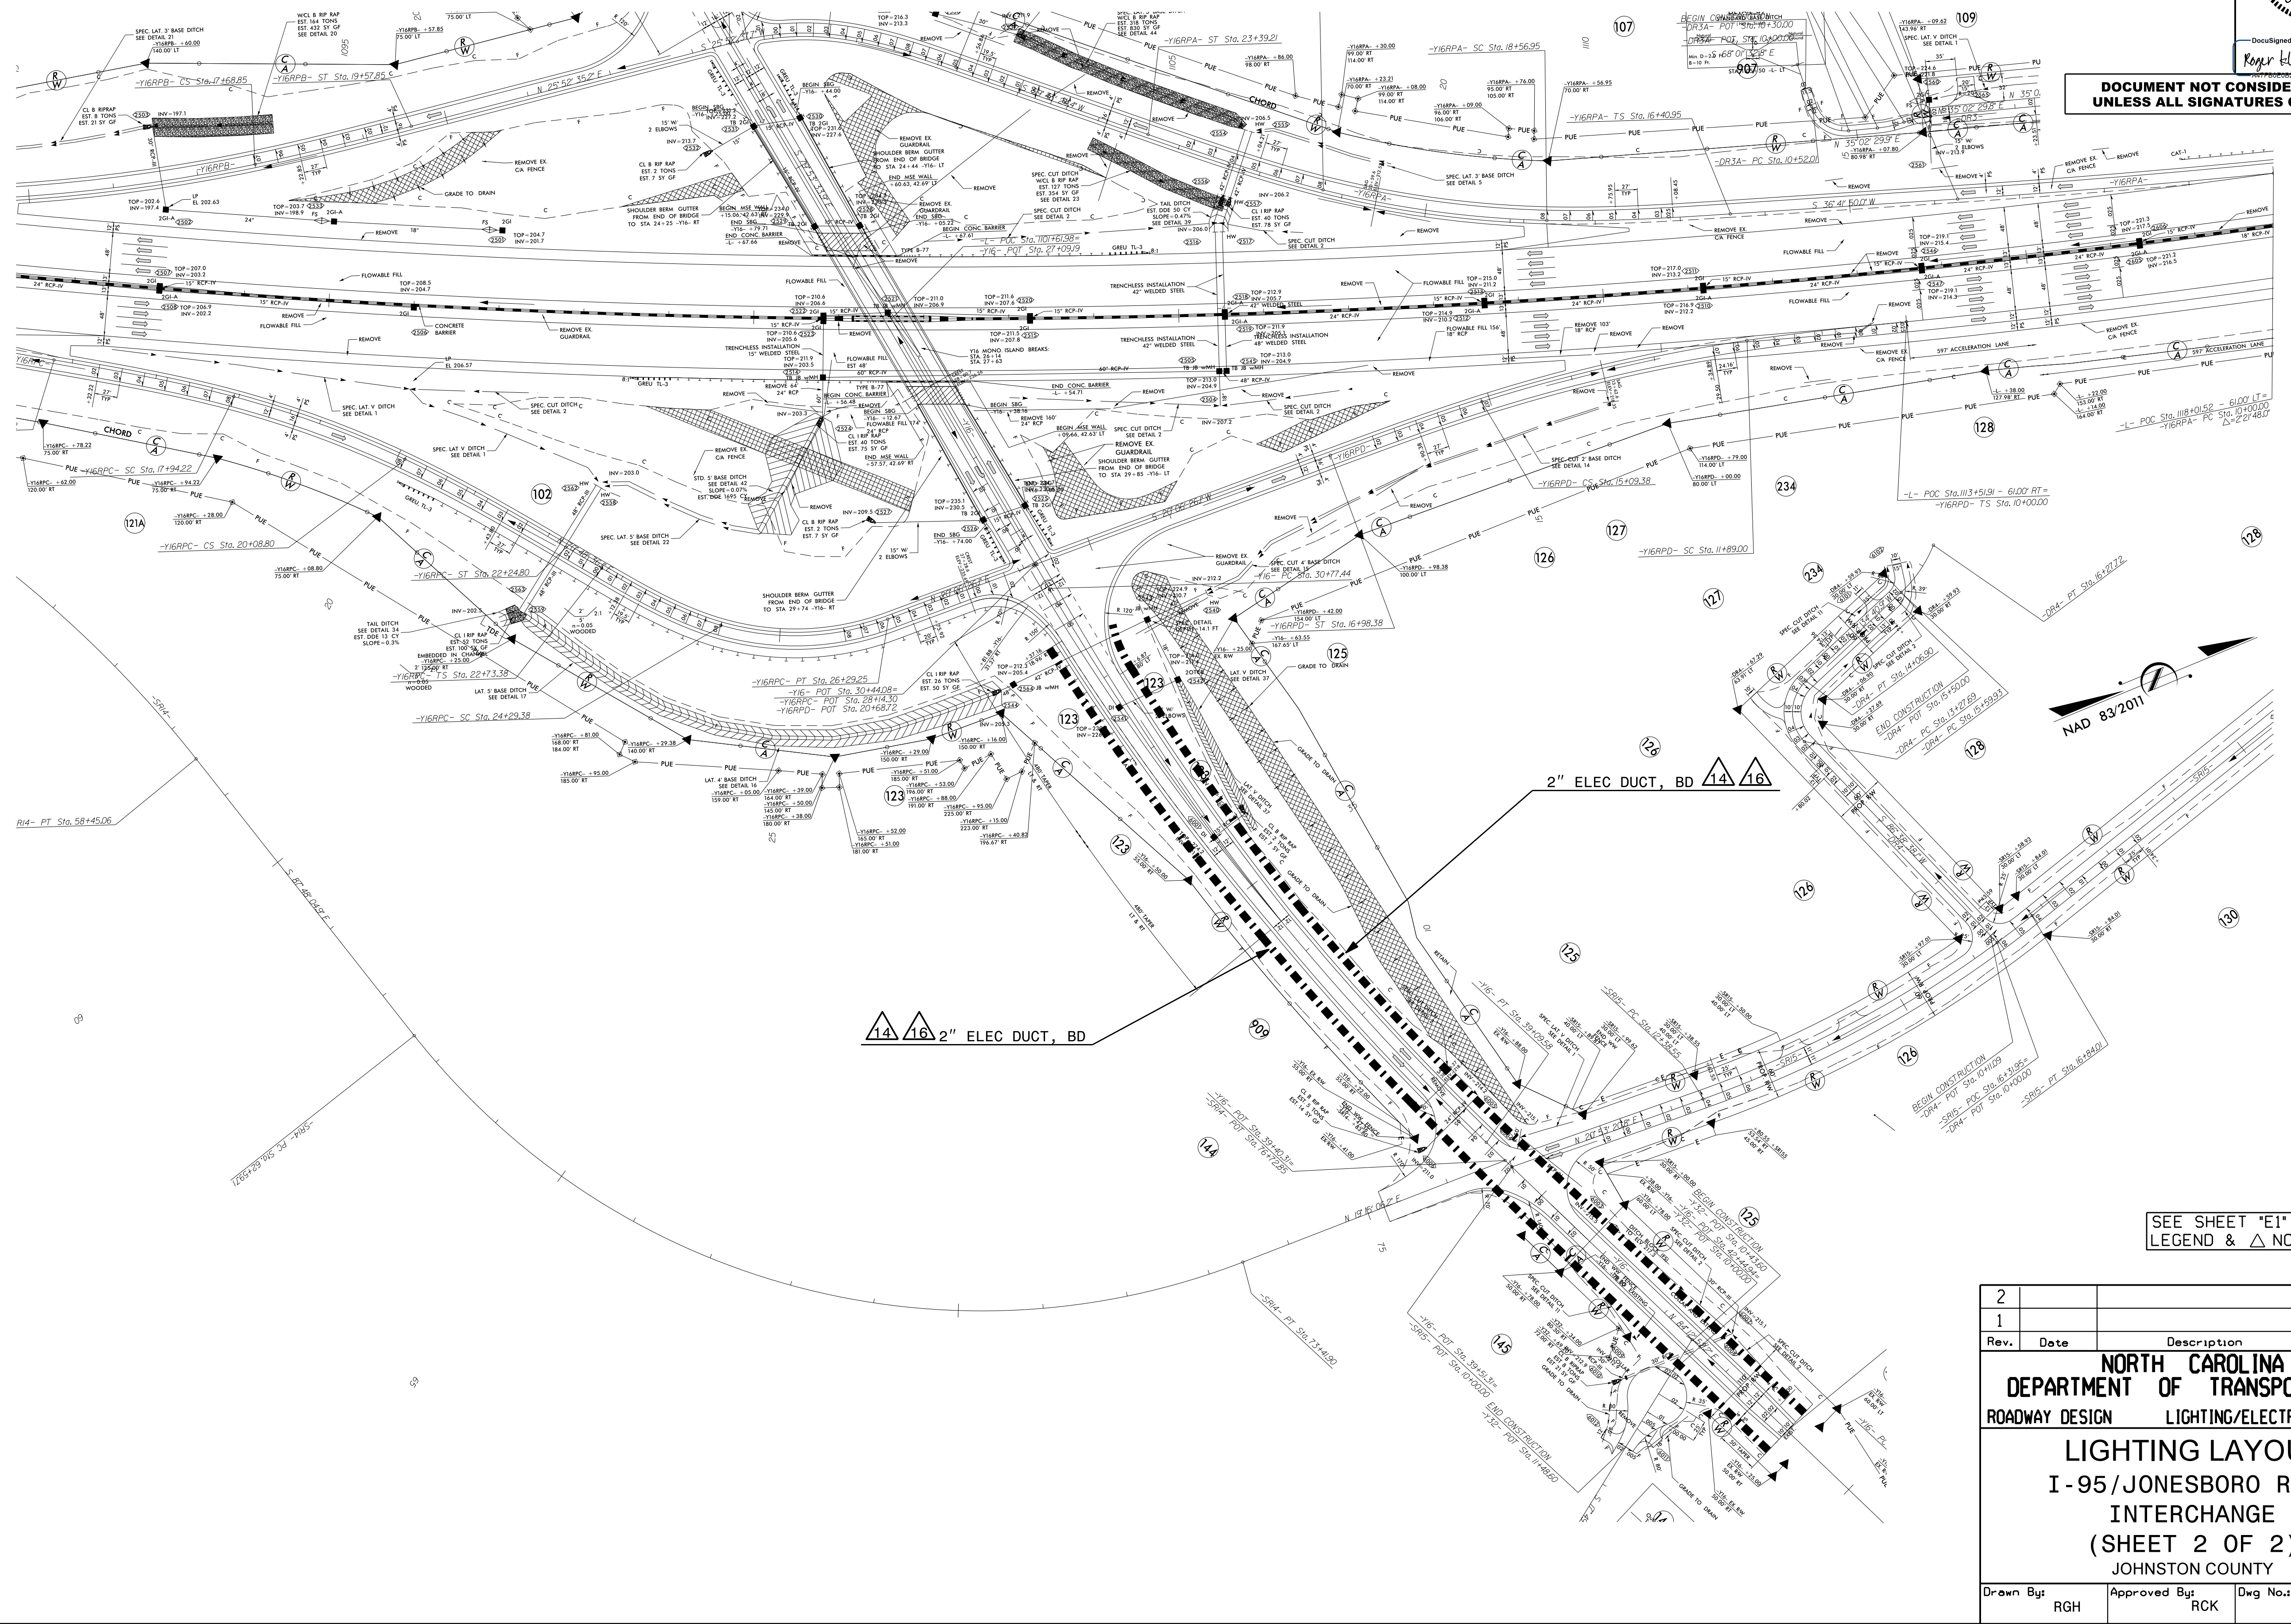

SEE SHEET "E1" FOR
LEGEND & △ NOTES

Rev.	Date	Description	Approved
2			
1			
NORTH CAROLINA DEPARTMENT OF TRANSPORTATION			
ROADWAY DESIGN LIGHTING/ELECTRICAL SECTION			
LIGHTING LAYOUT I-95/JONESBORO ROAD INTERCHANGE (SHEET 2 OF 2) JOHNSTON COUNTY			
Drawn By:	RGH	Approved By:	RCK
Dwg No.:			

 20-MAY-2021 15:29
R:\Lighting\Lighting Design\Design\I-5986B\LE-Conduit.dsn_E15.dgn
rgball AT RD-303048





Designed by:
Roger Kluckman

DOCUMENT NOT CONSIDERED FINAL
UNLESS ALL SIGNATURES COMPLETED

NOTE: INTERCHANGES ARE OUT OF SEQUENCE IN CONDUIT PLANS.

(P)

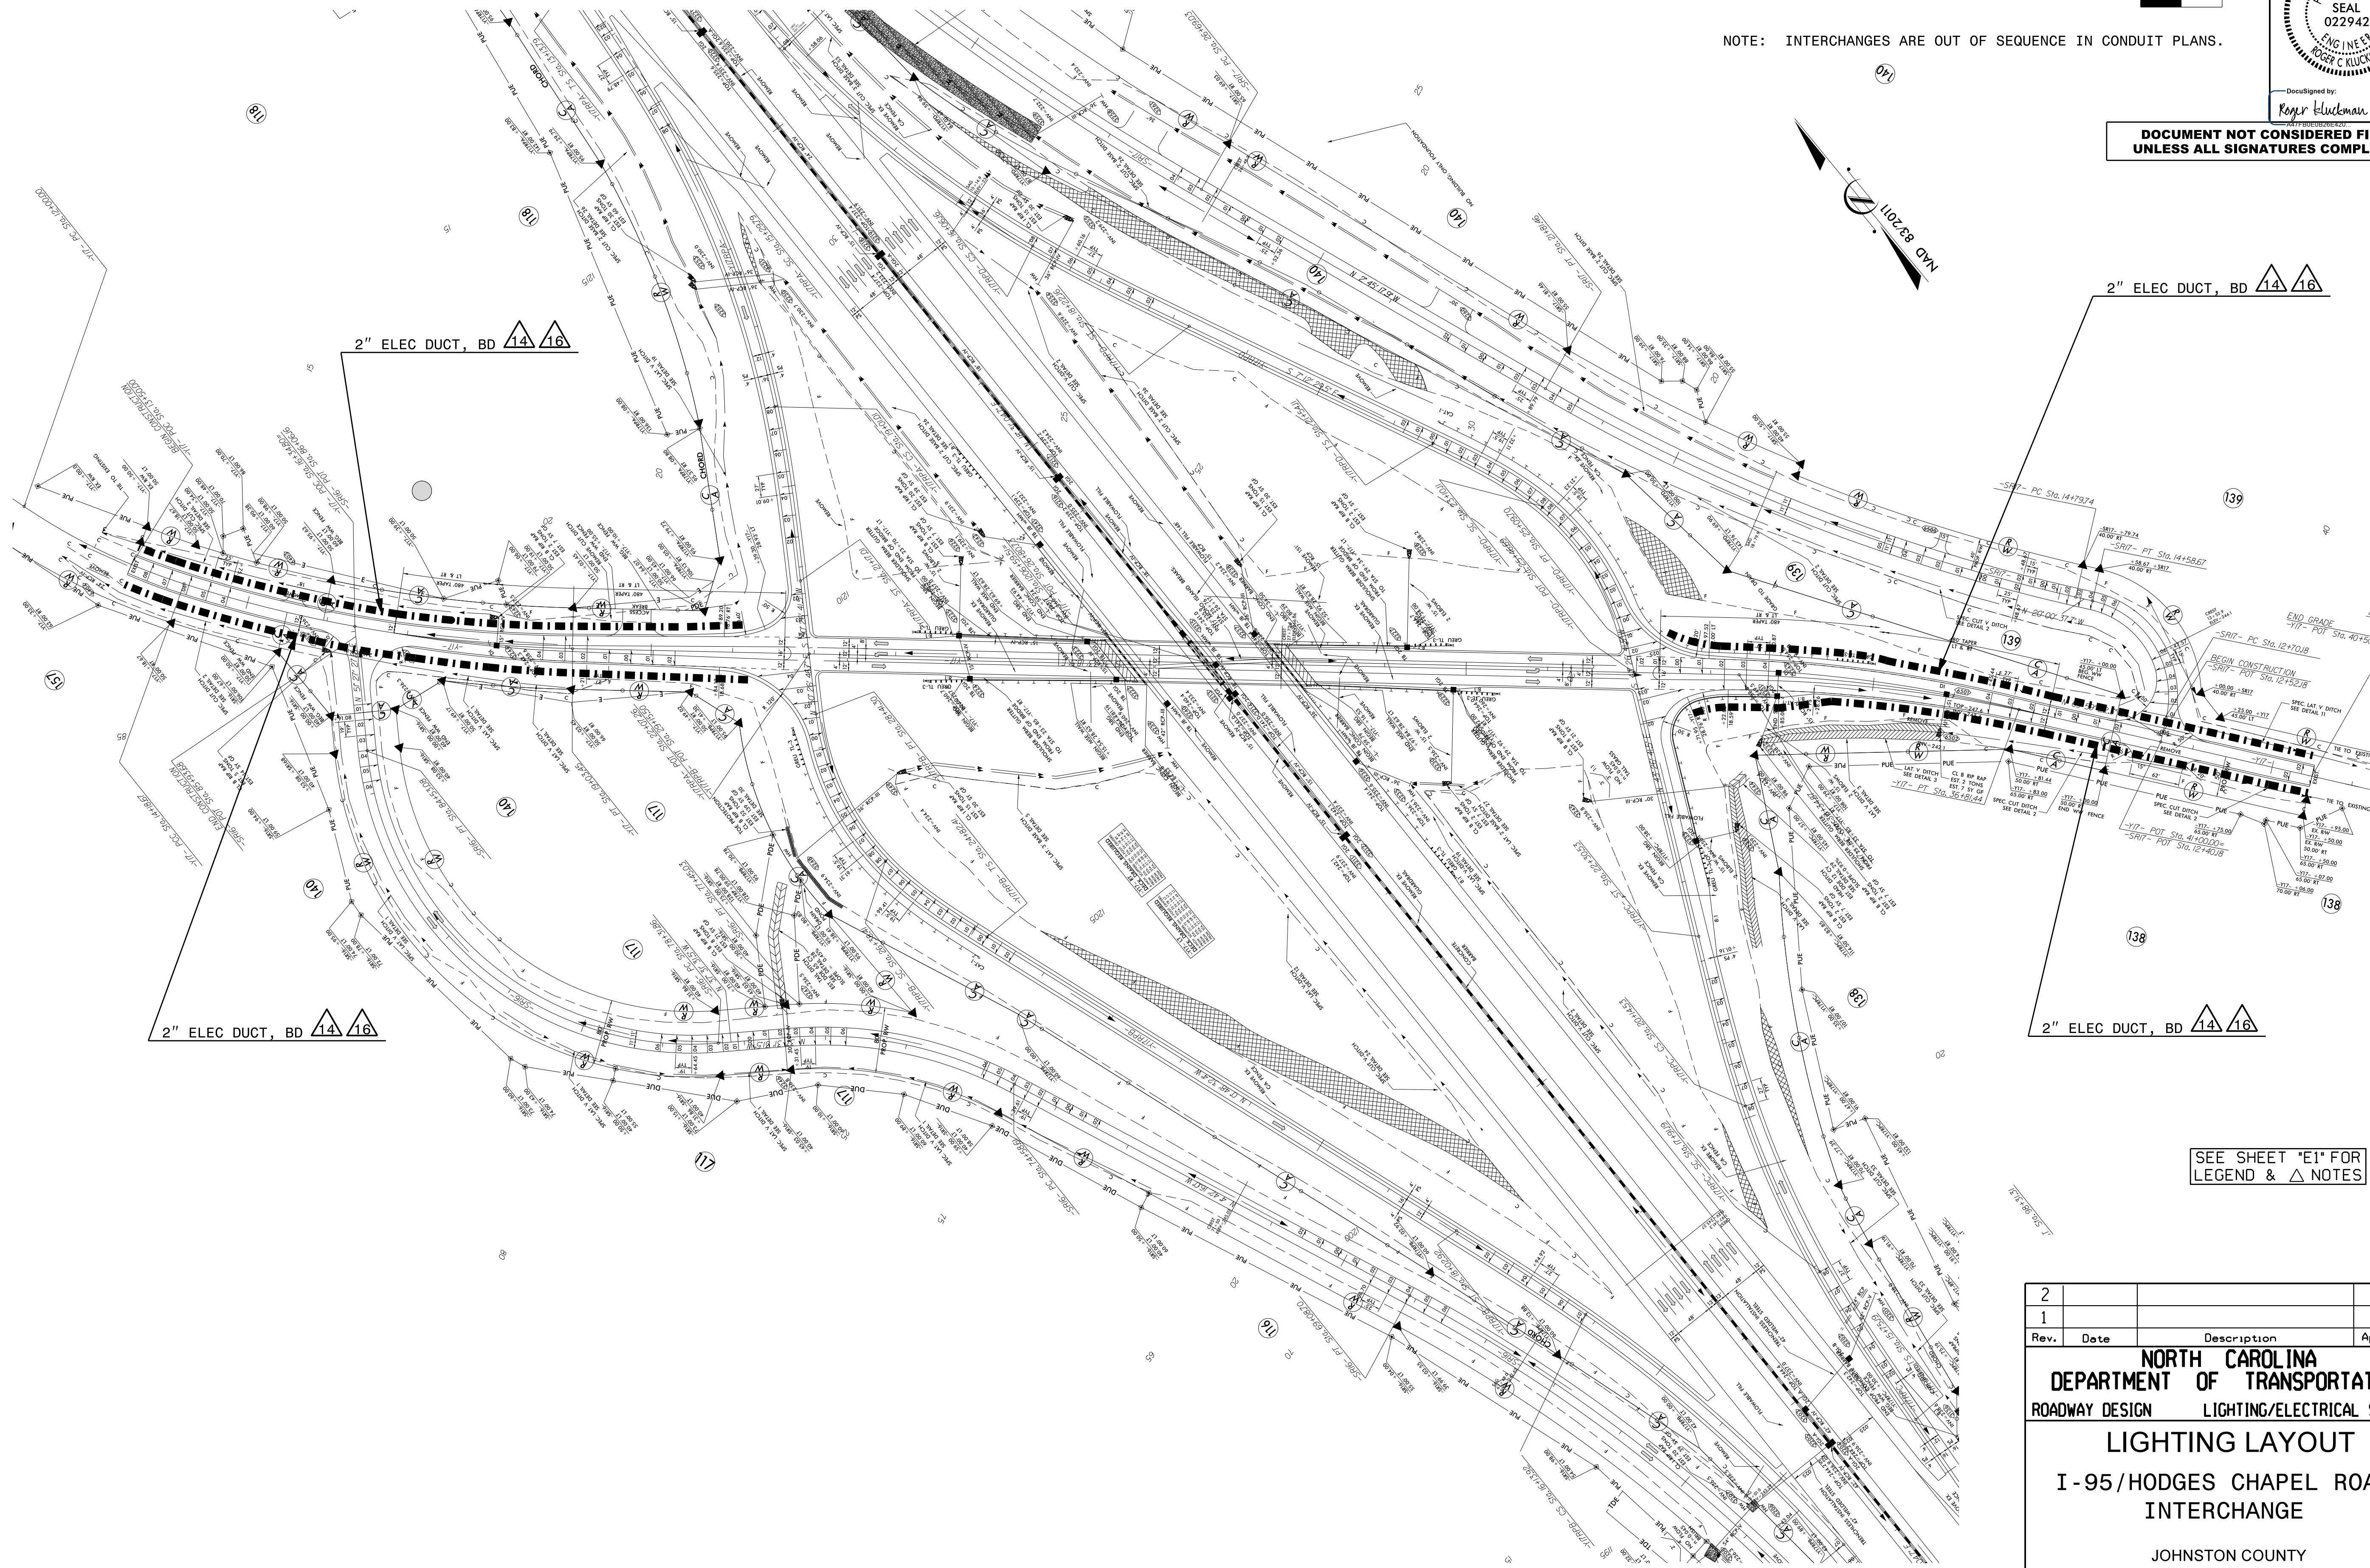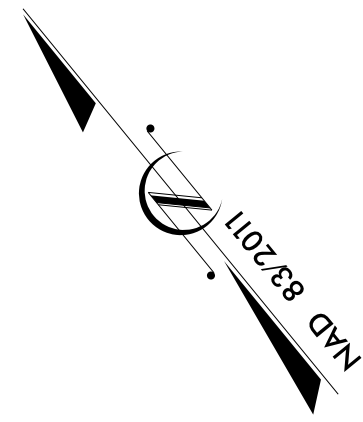

SEE SHEET "E1" FOR
LEGEND & Δ NOTES

2			
1			
Rev.	Date	Description	Approved
NORTH CAROLINA DEPARTMENT OF TRANSPORTATION ROADWAY DESIGN LIGHTING/ELECTRICAL SECTION			
LIGHTING LAYOUT I - 95/HODGES CHAPEL ROAD INTERCHANGE			
JOHNSTON COUNTY			
Drawn By:	RGH	Approved By:	RCK
Dwg No.:			