

T.I.P. NO.	SHEET NO.
B-5703	UC-1



STATE OF NORTH CAROLINA
DIVISION OF HIGHWAYS

**UTILITY CONSTRUCTION PLANS
CUMBERLAND COUNTY**


**LOCATION: BRIDGE NO. 60 OVER LOWER LITTLE RIVER
ON USE 401**

TYPE OF WORK: WATER LINE RELOCATION

TIP PROJECT: B-5703

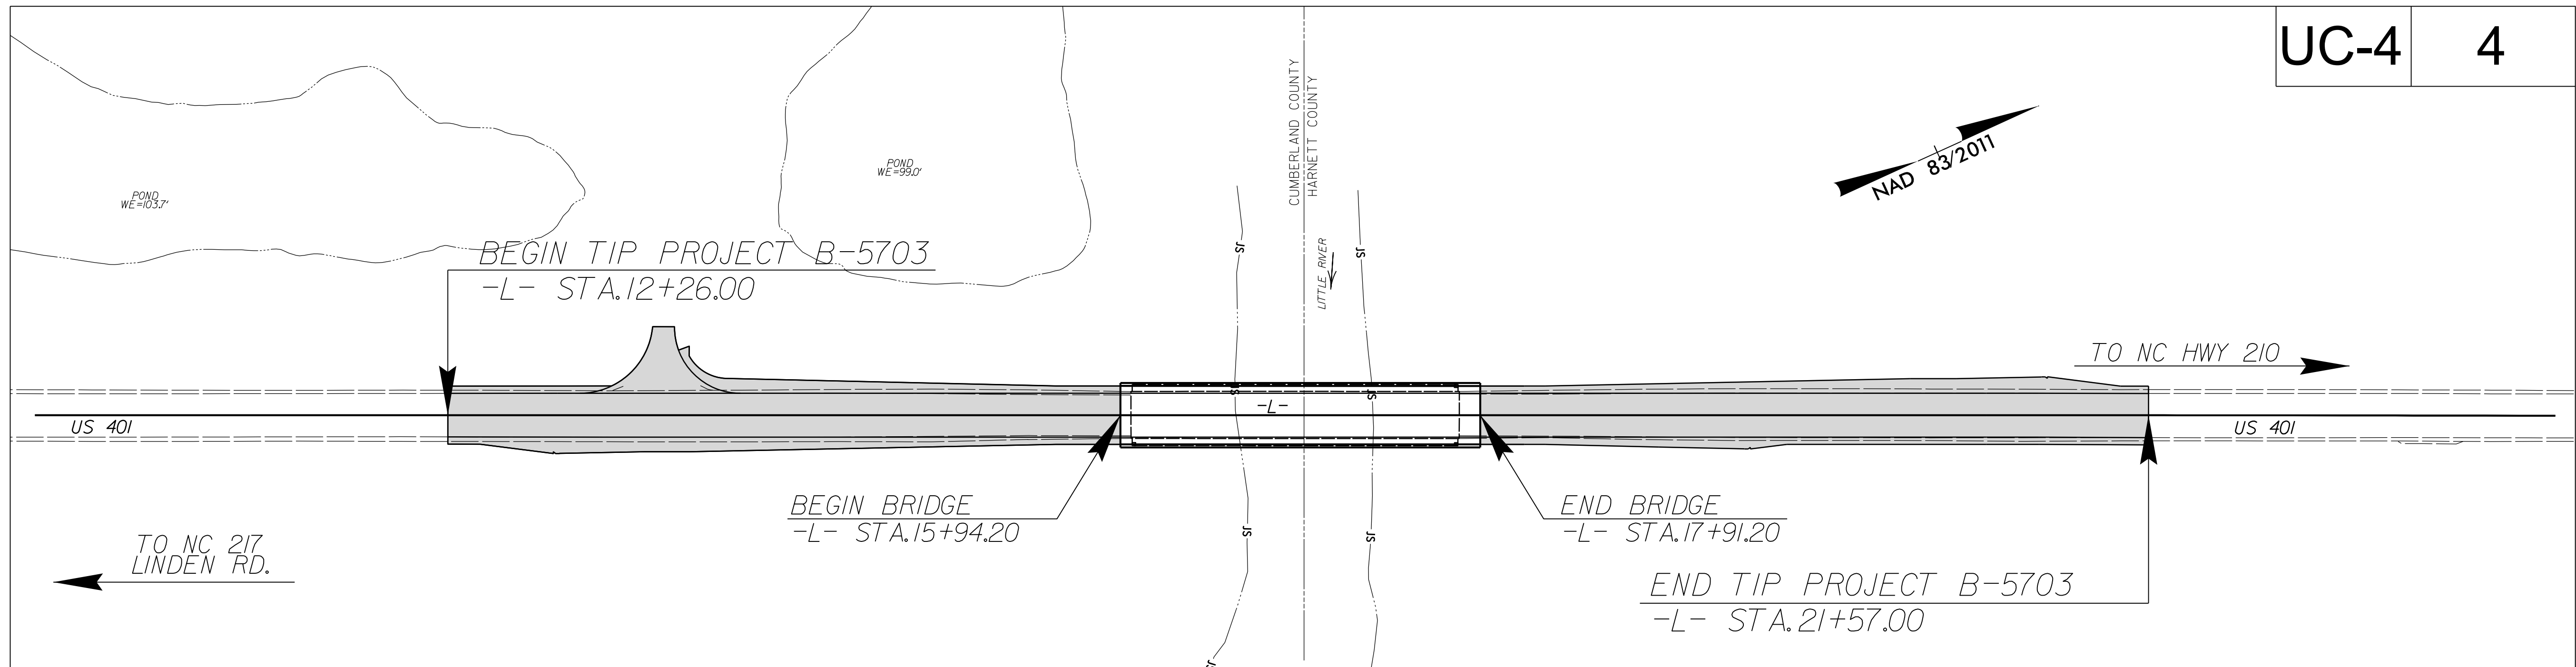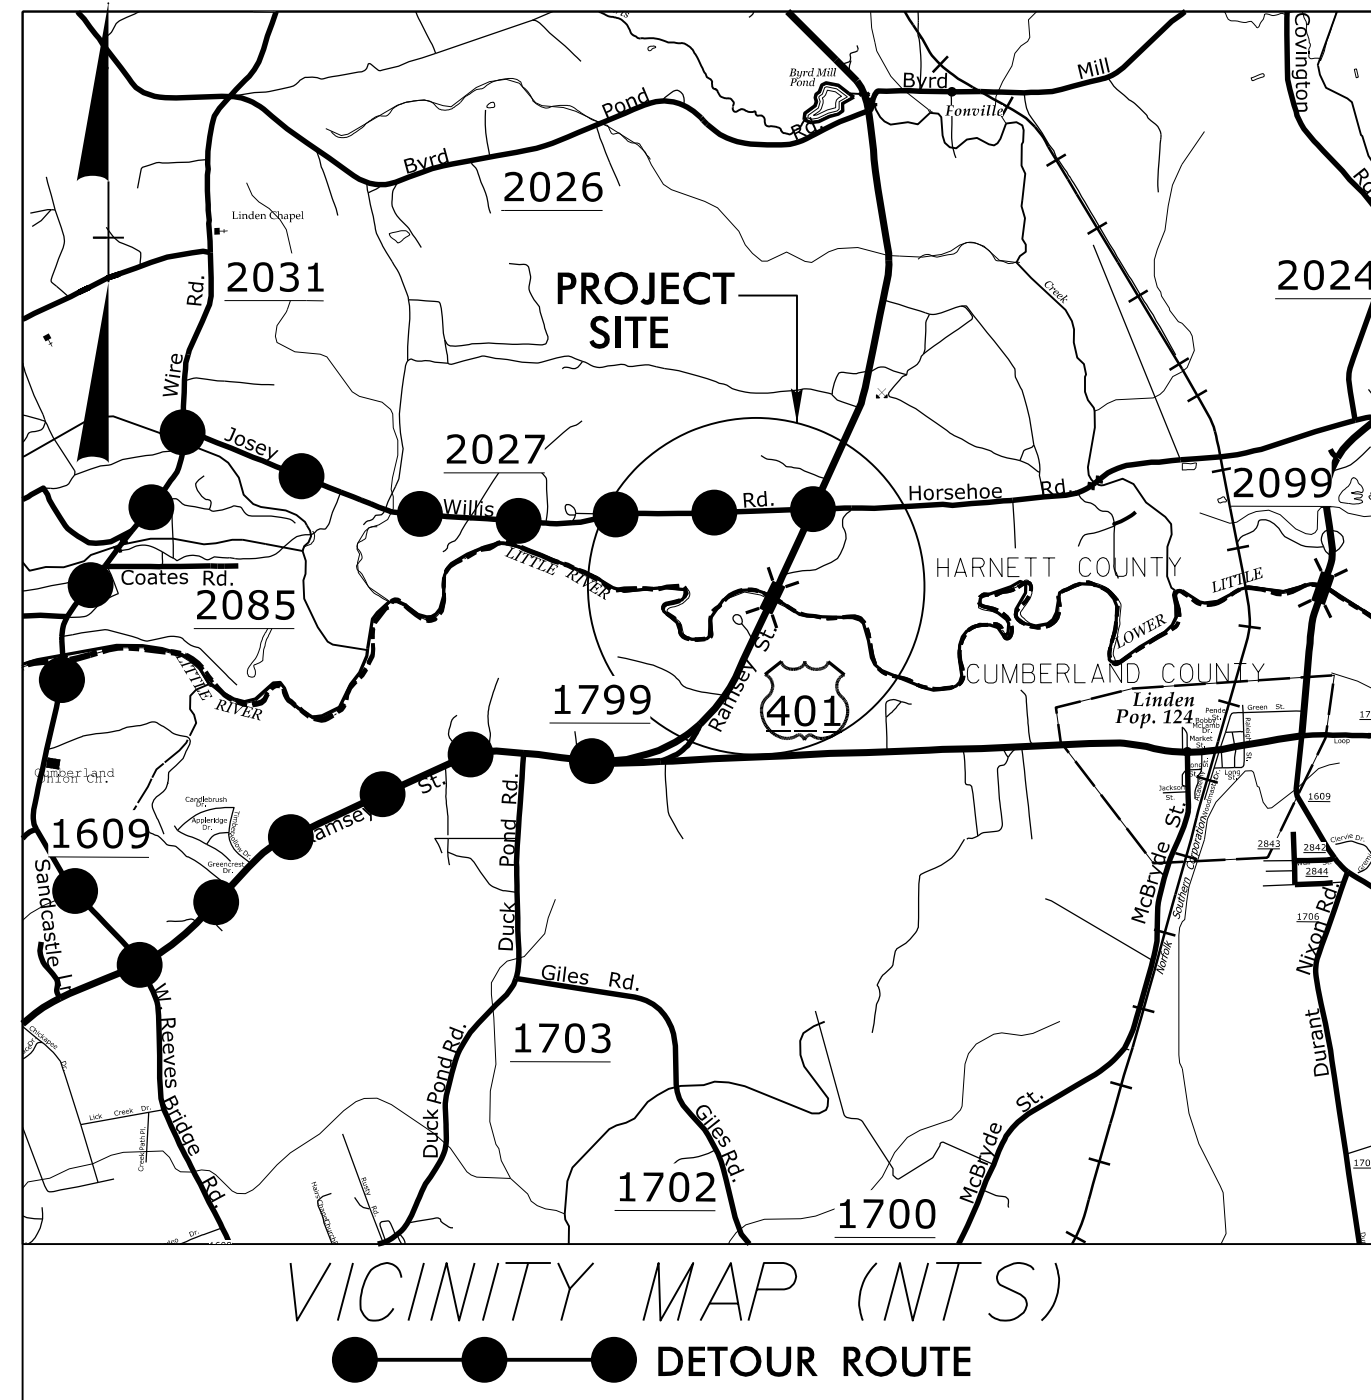

DOCUMENT NOT CONSIDERED FINAL
UNTIL ALL SIGNATURES ARE COMPLETED

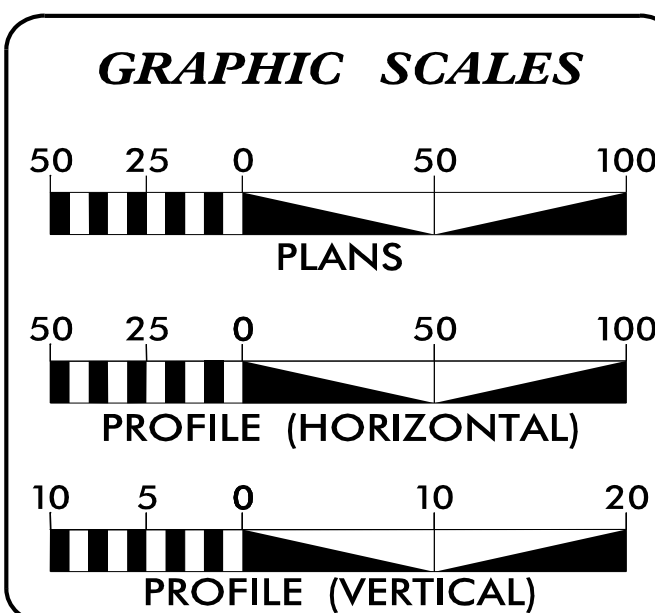


INDEX OF SHEETS	
SHEET NO.:	DESCRIPTION:
UC-1	TITLE SHEET
UC-2	UTILITY SYMBOLOGY
UC-3	NOTES
UC-3A THRU UC-3C	DETAIL SHEETS
UC-4	UTILITY PLAN SHEET
UC-5	UTILITY PROFILE SHEET

**WATER OWNER
ON PROJECT**

TOWN OF LINDEN
9456 ACADEMY STREET
POST OFFICE BOX 130
LINDEN, NC 28356-0130


PREPARED IN THE OFFICE OF




Engineers • Planners • Scientists • Construction Managers
4505 Falls of Neuse Road, Suite 400
Raleigh, NC 27609
Phone (919) 783-9214 • Fax (919) 783-9266
License No. C-764

MARCO MENENDEZ, PE PROJECT ENGINEER
MARCO MENENDEZ, PE PROJECT MANAGER
ANGELICA PURA PROJECT DESIGNER

SEAL

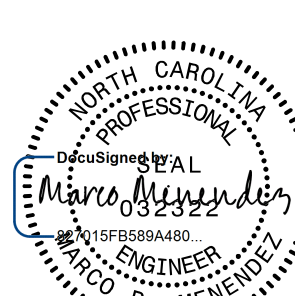

6/7/2021

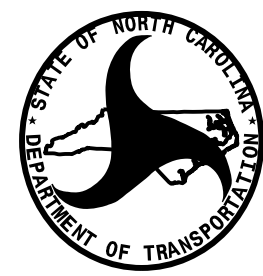

DIVISION OF HIGHWAYS
UTILITIES UNIT
1555 MAIL SERVICES CENTER
RALEIGH, NC 27699-1555
PHONE (919) 707-6690
FAX (919) 250-4151

NABIL HAMDAN UTILITIES REGIONAL ENGINEER
KELVIN MARTIN, EI UTILITIES ENGINEER
KYLE PLEASANT UTILITIES AREA COORDINATOR
KELVIN MARTIN, EI UTILITIES COORDINATOR

01-MAY-2020 16:21 M:\208\25501945\13 B-5703\Water-Wastewater\B-5703_sew_tsh_UC01.dgn \$\$\$USERNAME\$\$\$