


09/08/19

TIP PROJECT: I-6048

CONTRACT: C204441

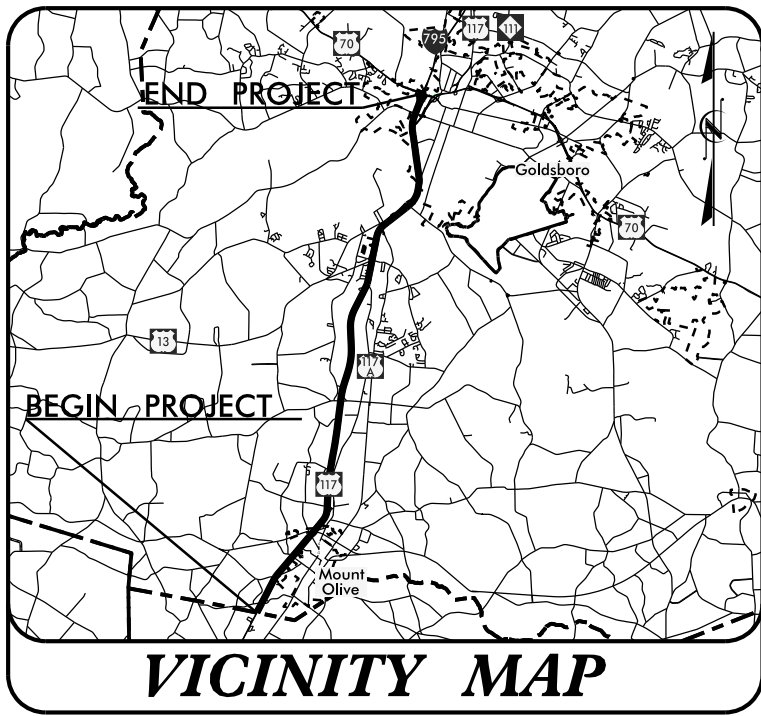


STATE OF NORTH CAROLINA
DIVISION OF HIGHWAYS

WAYNE COUNTY

LOCATION: US 117 (FUTURE I-795) FROM US 70 TO DUPLIN COUNTY LINE

TYPE OF WORK: PAVEMENT REHABILITATION

STATE	STATE PROJECT REFERENCE NO.	SHEET NO.	TOTAL SHEETS
N.C.	I-6048	1	
STATE PROJ. NO.	F.A. PROJ. NO.	DESCRIPTION	
47997.1.1		PE	
47997.3.1	NHPIM-0117(048)	CONST	

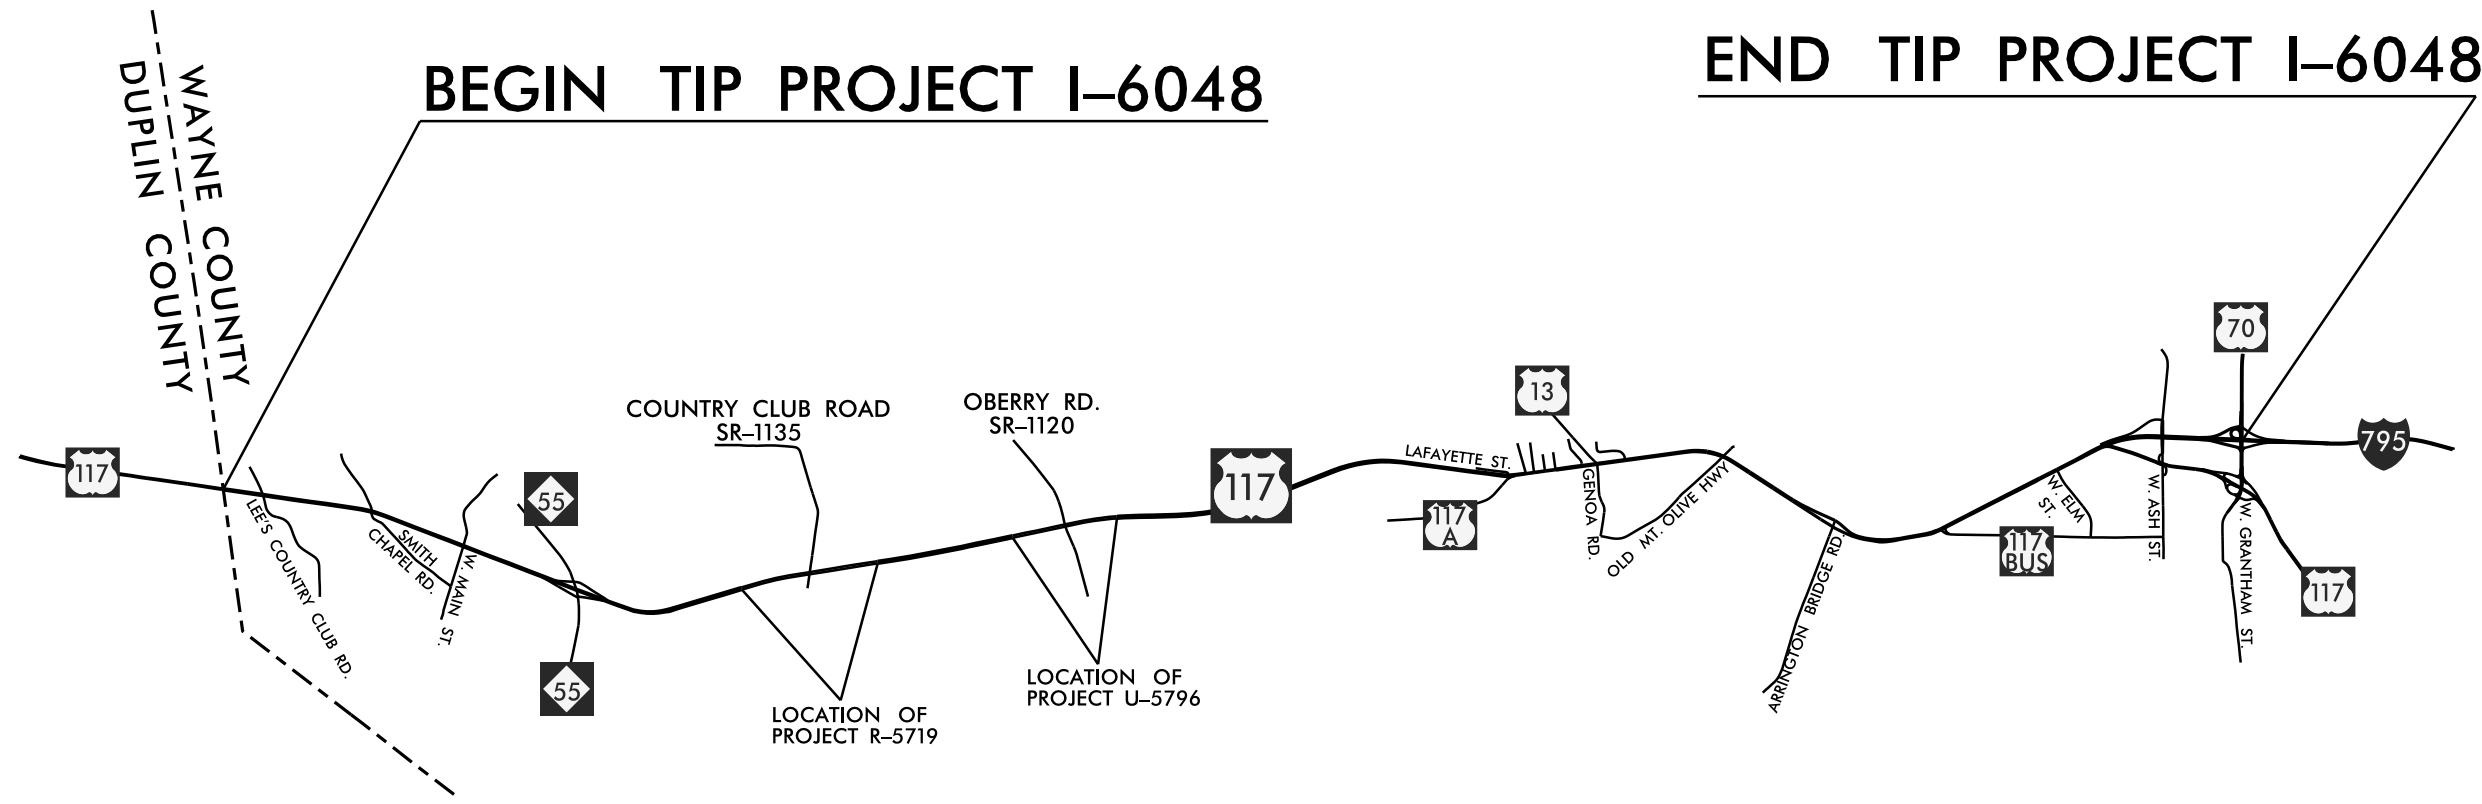

\$\$\$\$\$SYSTEM\$\$\$\$\$
\$\$\$\$\$CDGN\$\$\$\$\$
\$\$\$\$\$USERNAME\$\$\$\$\$

DESIGN DATA

ADT 2017	=	30,000
ADT	=	
K	=	%
D	=	%
T	=	% *
V	=	50 MPH
* TTST = DUAL		
FUNC CLASS =		
PRINCIPAL ARTERIAL		
TIER		

PROJECT LENGTH

LENGTH ROADWAY I-6048 (US-117 SBL)	=	14.72 MI
LENGTH ROADWAY I-6048 (US-117 NBL)	=	14.74 MI

Prepared In the Office of:
DIVISION 4 DDC
509 Ward Blvd., Wilson NC, 27893

2018 STANDARD SPECIFICATIONS	
RIGHT OF WAY DATE: N/A	K.G. BOWEN, PE PROJECT ENGINEER
LETTING DATE: AUGUST 17, 2021	N.A. GAINEY, PE PROJECT DESIGN ENGINEER

