



PROJECT REFERENCE NO. R-5709A	SHEET NO. EC-08/CONST.08
RW SHEET NO.	HYDRAULICS ENGINEER
ROADWAY DESIGN ENGINEER	

115 x 57 x 3  
2.5 inch Skimmer  
with 2.250 inch  
Orifice Diameter  
25 ft. weir  
ID 8.1

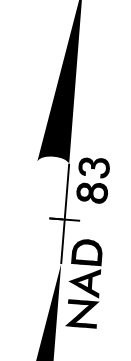


MATCHLINE -L- STA. 61 + 00.00  
SEE SHEET 7

MATCHLINE -L- STA. 74 + 00.00  
SEE SHEET 9

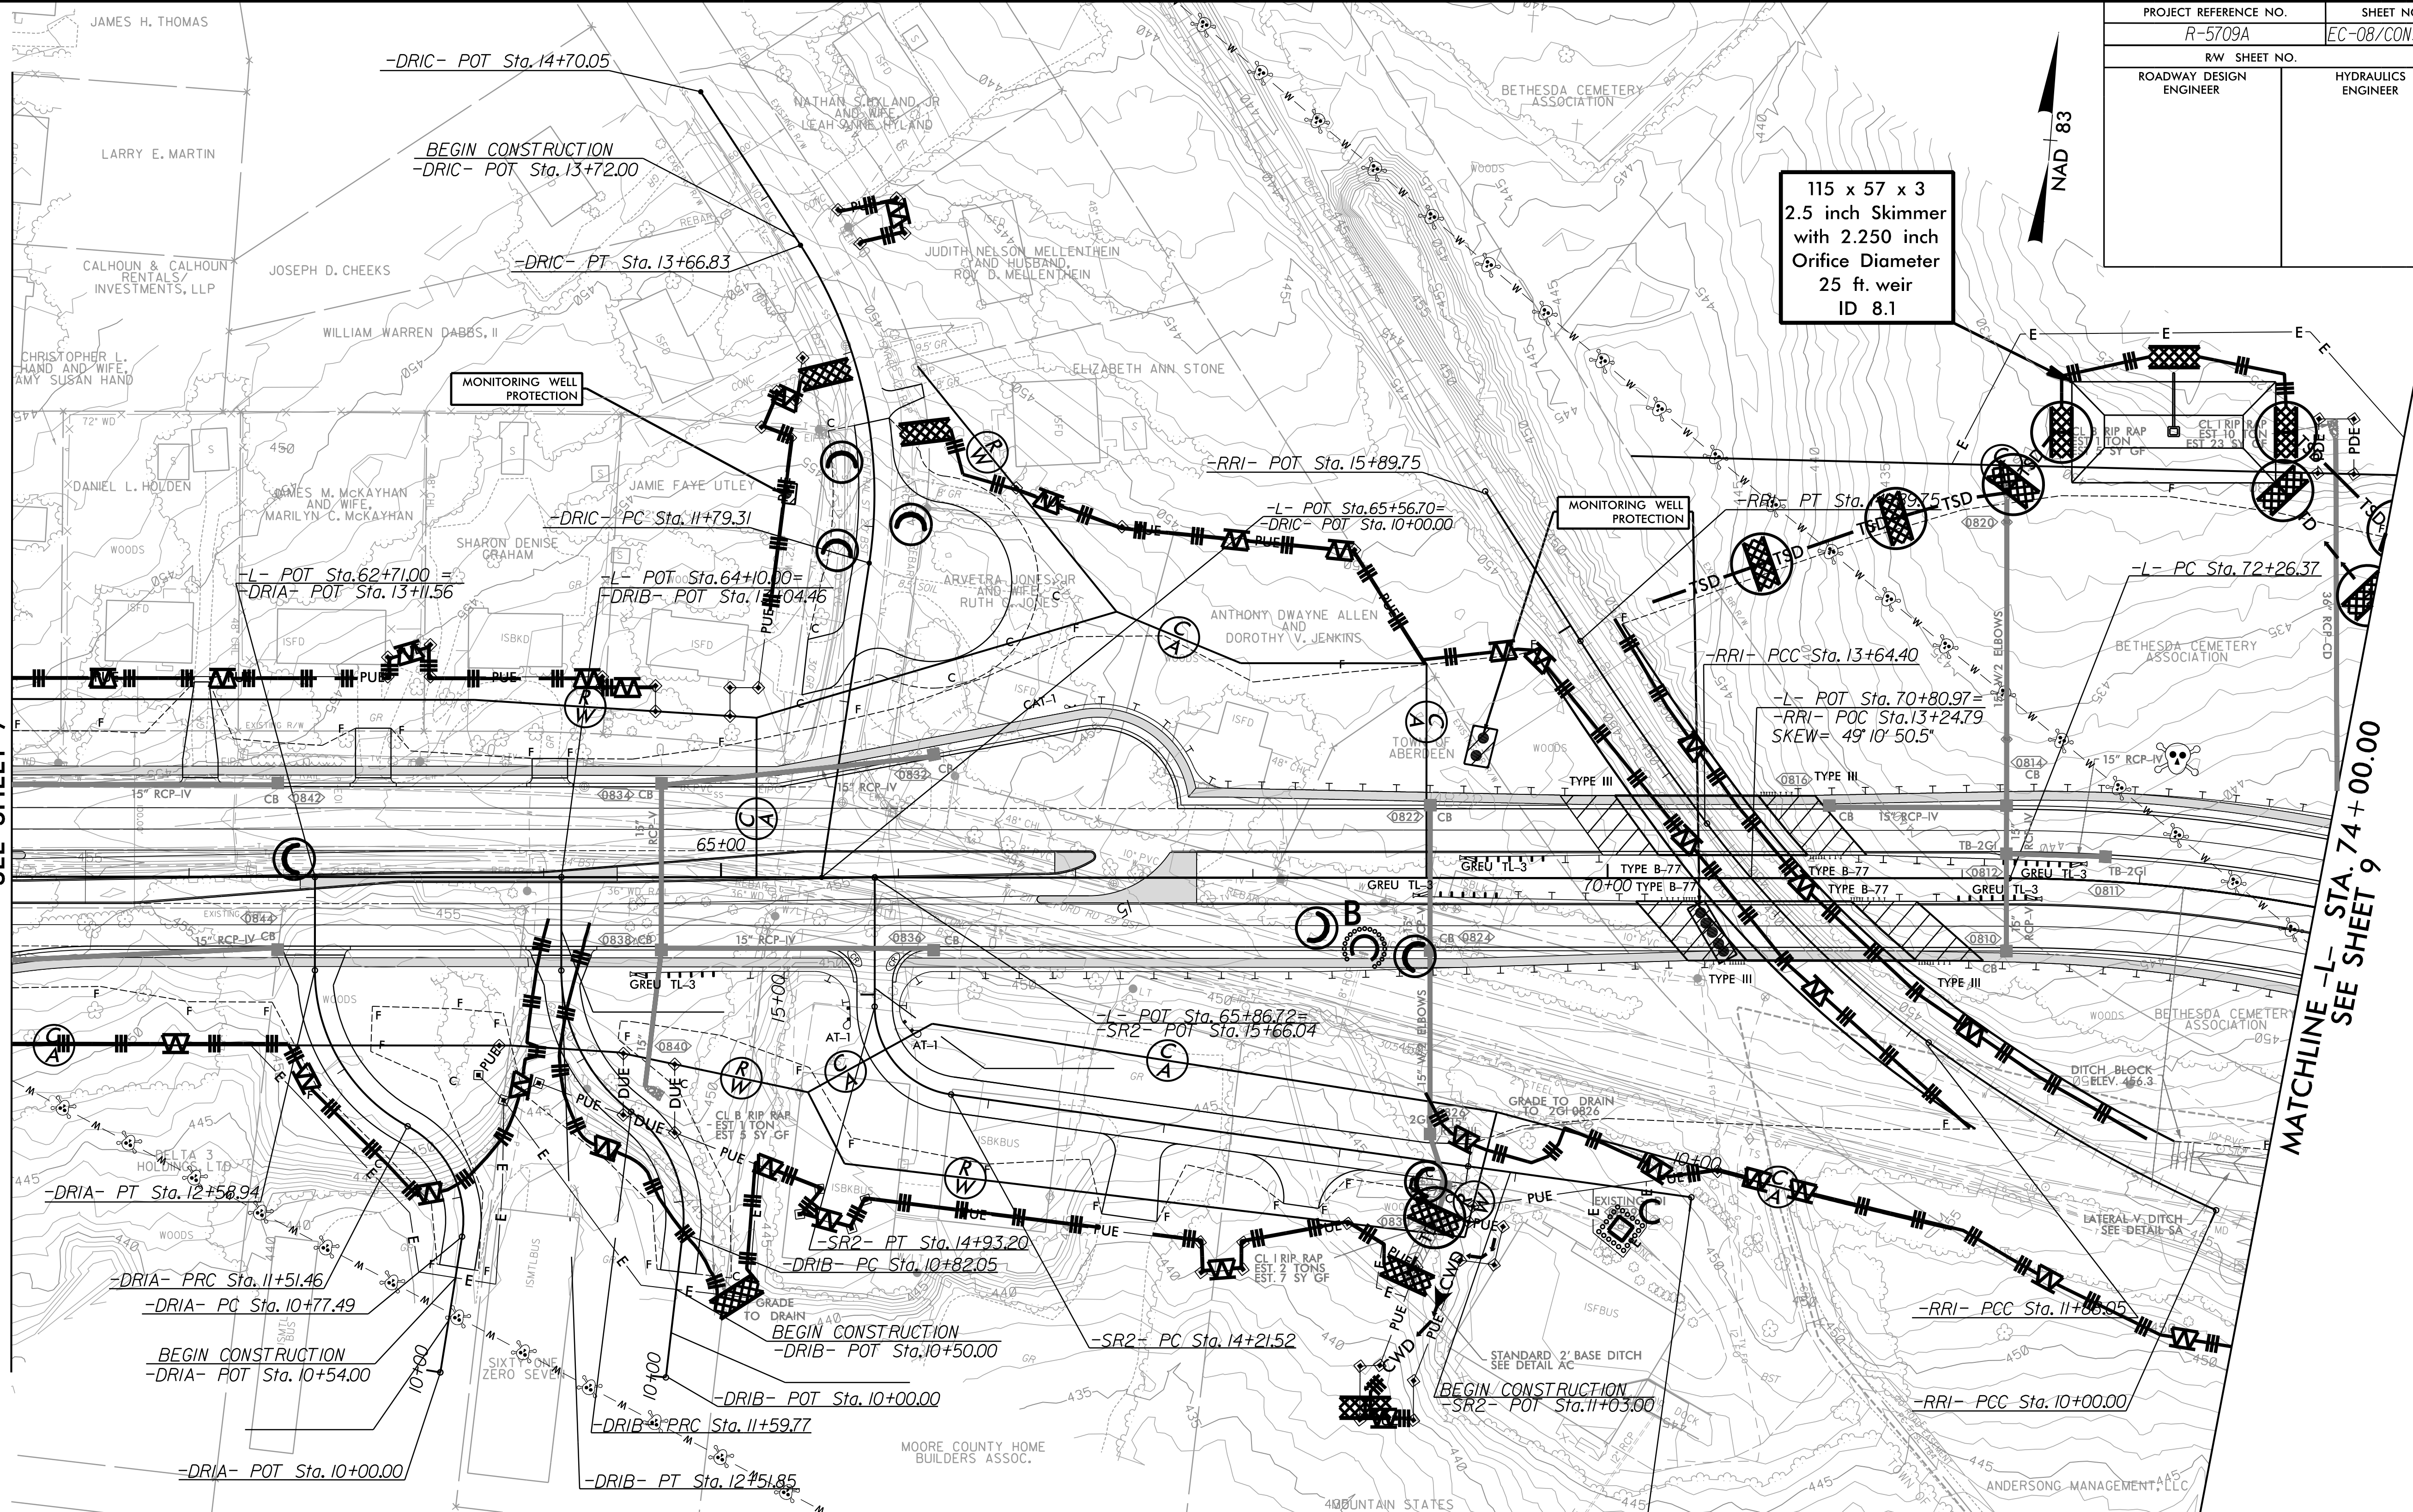

**CLEAN WATER DIVERSION**

(Not to Scale)

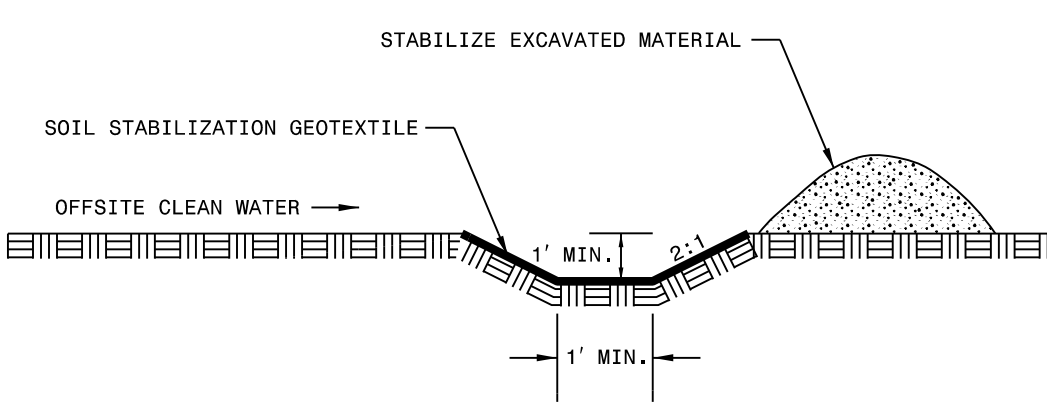

**CLEARING AND GRUBBING  
EROSION CONTROL FOR  
CONSTRUCTION SHEET 08**

**NOTE:**  
PLACE TEMPORARY ROCK SEDIMENT DAMS TYPE - B  
AND TEMPORARY ROCK SILT CHECKS TYPE - A AT  
DRAINAGE OUTLETS.

**SETH JONES, EI**  
LEVEL III NAME  
  
**4183**  
LEVEL III CERTIFICATION NO.

**RKK**  
P: (919) 978-9990  
8601 Six Forks Road, Forum 1 Suite 700  
Raleigh, North Carolina 27615-3990  
NC License No. F-0112  
Engineers | Construction Managers | Planners | Scientists  
www.rkk.com  
Responsive People | Creative Solutions