
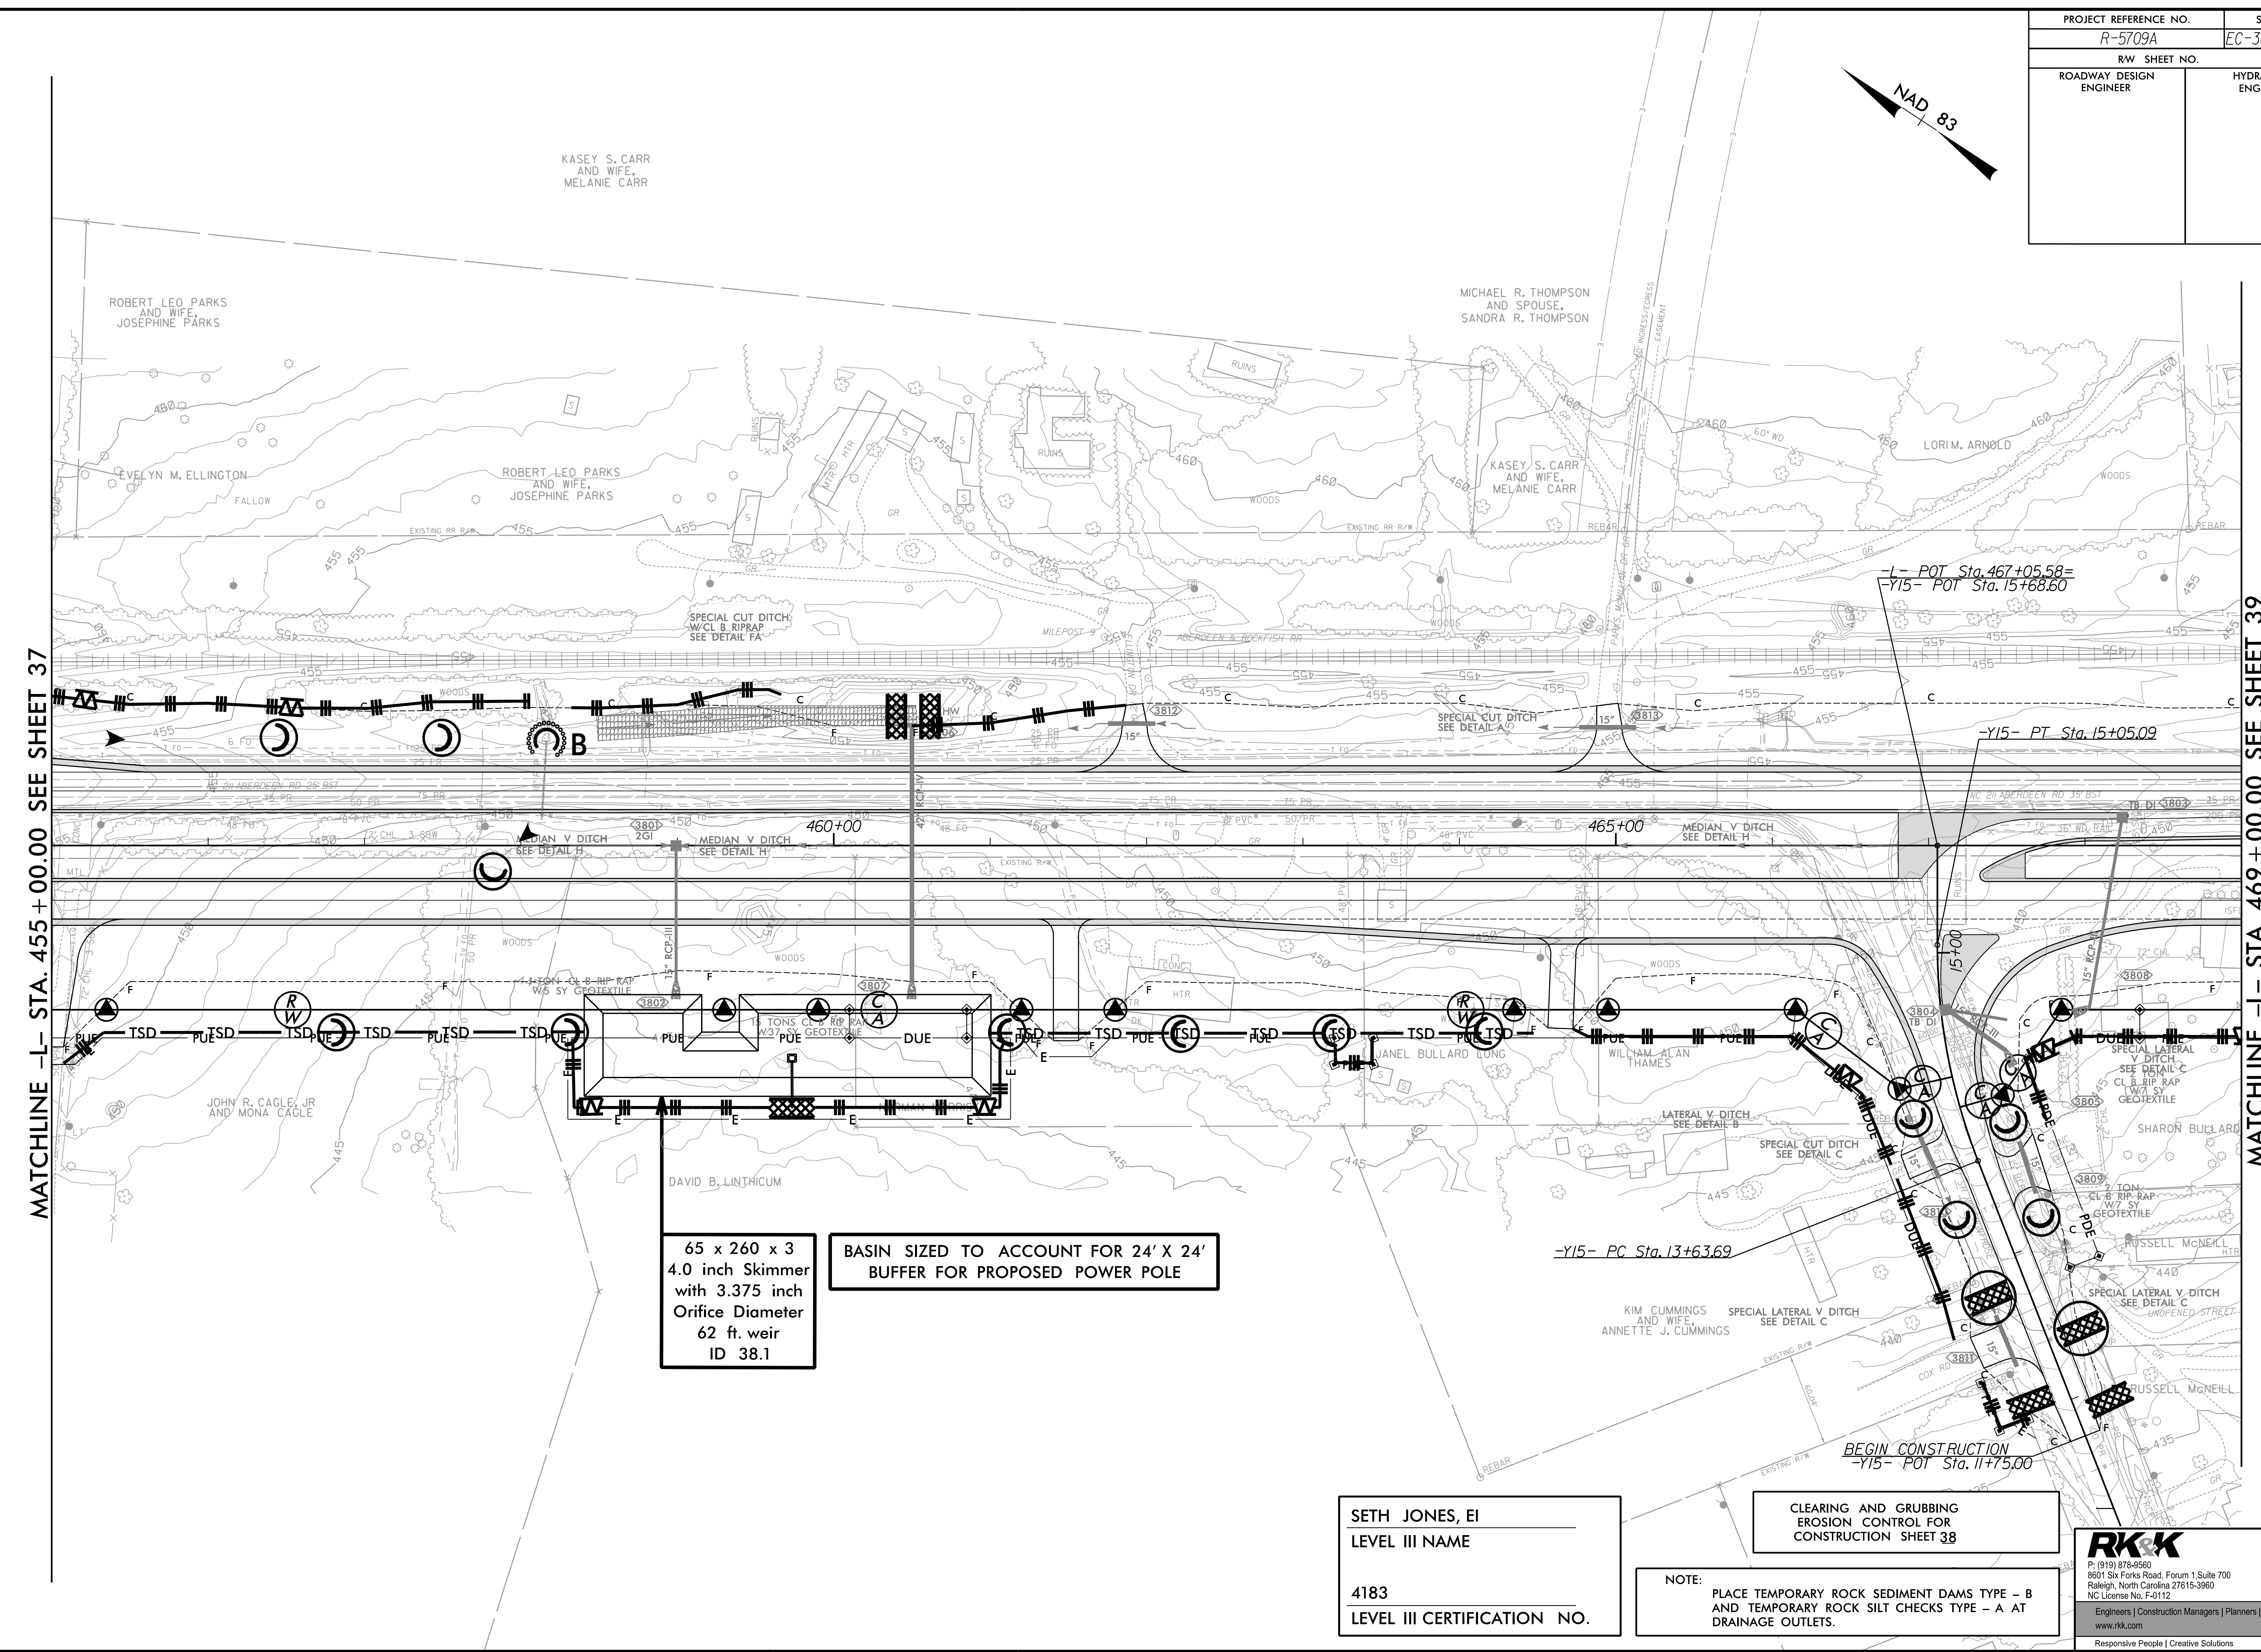


PROJECT REFERENCE NO. R-5709A	SHEET NO. EC-38/CONST.38
RW SHEET NO.	
ROADWAY DESIGN ENGINEER	HYDRAULICS ENGINEER

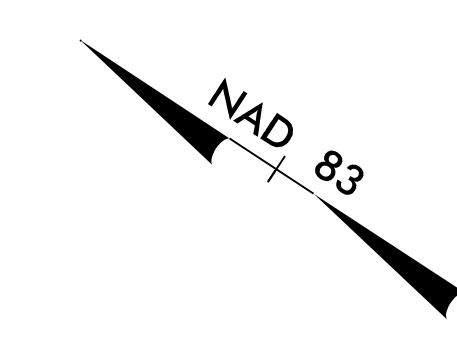

MATCHLINE -L- STA. 455 + 00.00 SEE SHEET 37

MATCHLINE -L- STA. 469 + 00.00 SEE SHEET 39

65 x 260 x 3
4.0 inch Skimmer
with 3.375 inch
Orifice Diameter
62 ft. weir
ID 38.1

BASIN SIZED TO ACCOUNT FOR 24' X 24'
BUFFER FOR PROPOSED POWER POLE

SETH JONES, EI
LEVEL III NAME

4183
LEVEL III CERTIFICATION NO.

CLEARING AND GRUBBING
EROSION CONTROL FOR
CONSTRUCTION SHEET 38

NOTE:
PLACE TEMPORARY ROCK SEDIMENT DAMS TYPE - B
AND TEMPORARY ROCK SILT CHECKS TYPE - A AT
DRAINAGE OUTLETS.

RK&K
P: (919) 978-9990
8601 Six Forks Road, Forum 1, Suite 700
Raleigh, North Carolina 27615-3990
NC License No. F-0112
Engineers | Construction Managers | Planners | Scientists
www.rk.com
Responsive People | Creative Solutions

8/17/99
7/23/2021
R:\CH\Projects\CADD\PSH\EC - Early\Start C&S\Section 2\AR5709_EC_ESCG_psh38.dgn