
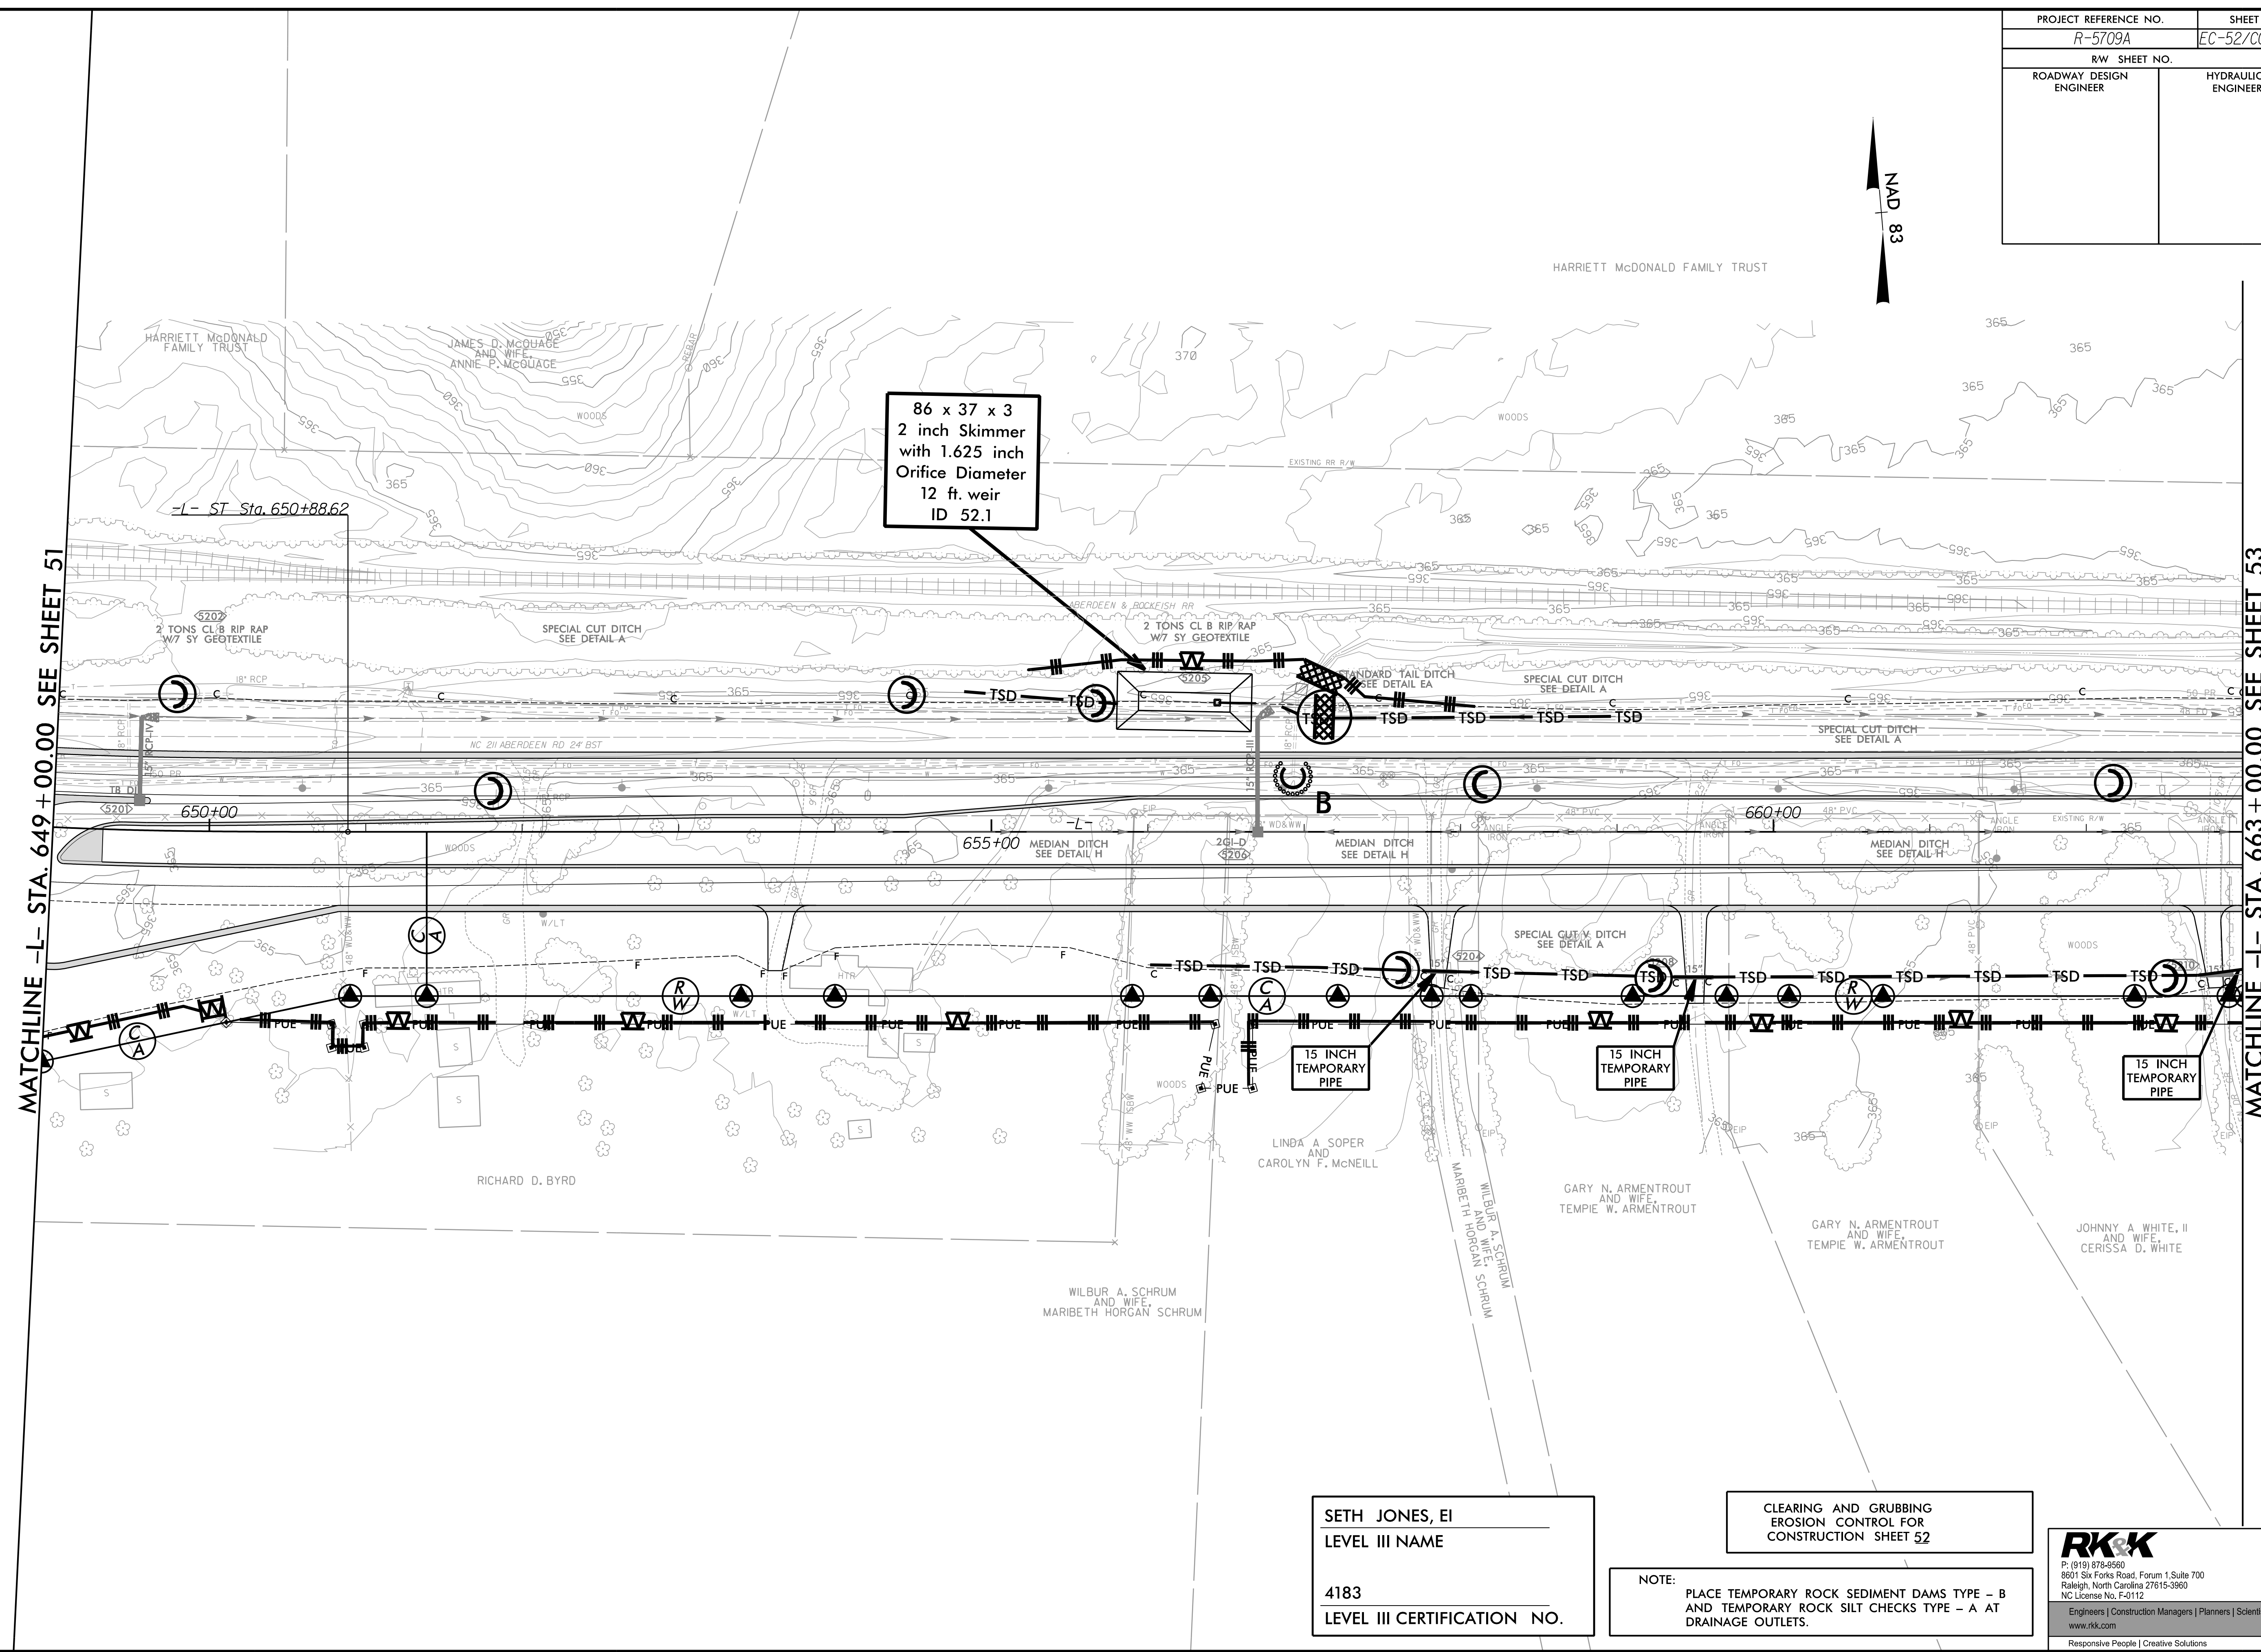


PROJECT REFERENCE NO.	SHEET NO.
R-5709A	EC-52/CONST.52
RW SHEET NO.	HYDRAULICS ENGINEER
ROADWAY DESIGN ENGINEER	

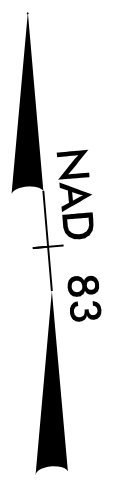

86 x 37 x 3
2 inch Skimmer
with 1.625 inch
Orifice Diameter
12 ft. weir
ID 52.1

15 INCH
TEMPORARY
PIPE

15 INCH
TEMPORARY
PIPE

15 INCH
TEMPORARY
PIPE

MATCHLINE -L- STA. 649 + 00.00 SEE SHEET 51

MATCHLINE -L- STA. 663 + 00.00 SEE SHEET 53

SETH JONES, EI
LEVEL III NAME

4183
LEVEL III CERTIFICATION NO.

CLEARING AND GRUBBING
EROSION CONTROL FOR
CONSTRUCTION SHEET 52

NOTE:
PLACE TEMPORARY ROCK SEDIMENT DAMS TYPE - B
AND TEMPORARY ROCK SILT CHECKS TYPE - A AT
DRAINAGE OUTLETS.

RKK
P: (919) 978-9990
8601 Six Forks Road, Forum 1, Suite 700
Raleigh, North Carolina 27615-3990
NC License No. F-0112
Engineers | Construction Managers | Planners | Scientists
www.rkk.com
Responsive People | Creative Solutions

8/17/99

7/21/2021 R:\CH\Projects\2021\202109\2\N\5709_EC_ESCG_psf52.dgn