



USE FOR LIGHTING CONSTRUCTION ONLY

PROJECT REFERENCE NO. R-5737 SHEET NO. E3

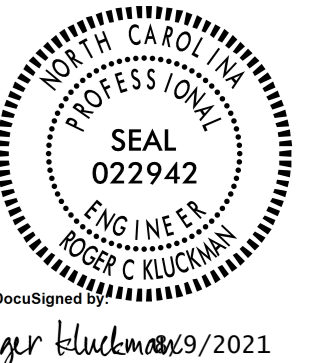

DOCUMENT NOT CONSIDERED FINAL UNLESS ALL SIGNATURES COMPLETED

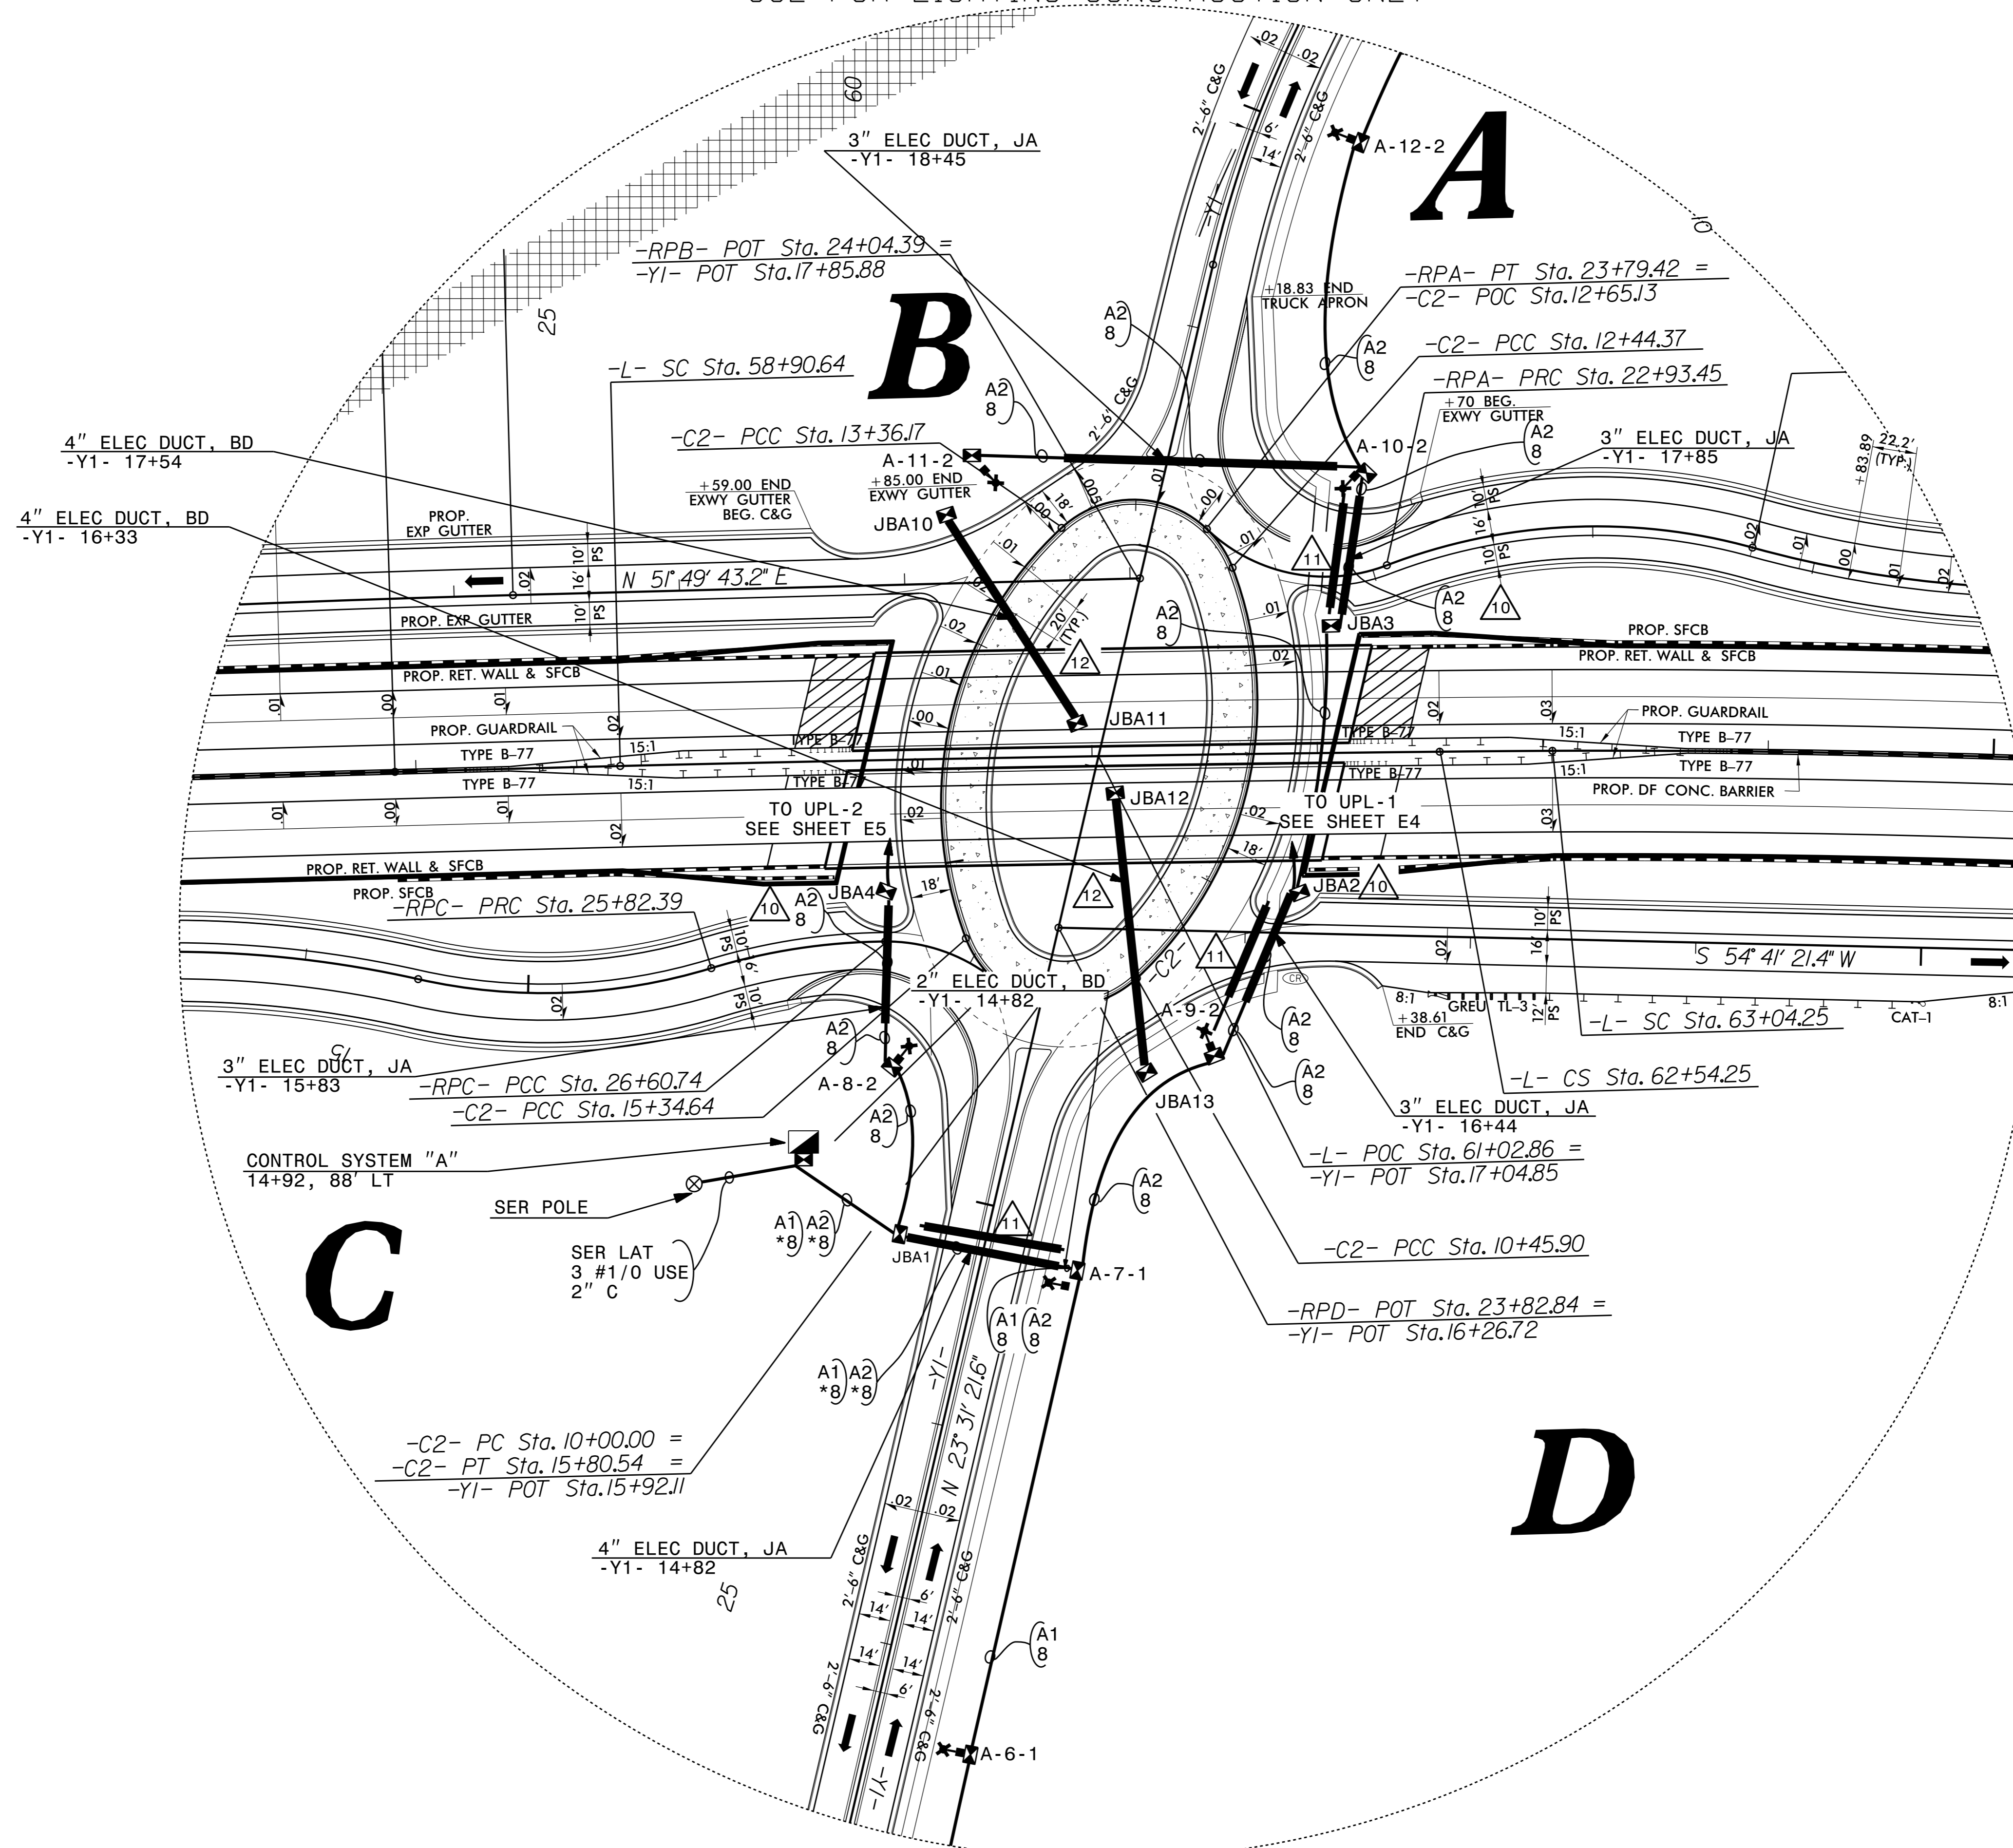

SEE SHEET "E1" FOR LEGEND & △ NOTES

2			
1			
Rev.	Date	Description	Approved
NORTH CAROLINA DEPARTMENT OF TRANSPORTATION ROADWAY DESIGN LIGHTING/ELECTRICAL SECTION LIGHTING LAYOUT FOR US-29/US-70/BUS 85 AT OLD GREENSBORO RD INTERCHANGE DAVIDSON COUNTY			
Drawn By:	MSQ	Approved By:	RGH
Dwg No.:			

28-JUL-2021 13:57
 Z:\Div\Proj\Division09\R5737\Lighting\Design\Lighting\R5737_LE.DSN E2 and E3.dgn
 msquadr1 AT RD-303073