

**This electronic collection of documents is provided
for the convenience of the user
and is Not a Certified Document –**


**The documents contained herein were originally issued
and sealed by the individuals whose names and license
numbers appear on each page, on the dates appearing
with their signature on that page.**

**This file or an individual page
shall not be considered a certified document.**

**STATE OF NORTH CAROLINA
DEPARTMENT OF TRANSPORTATION**

**SIGNING PLAN
DAVIDSON COUNTY**

LOCATION: US 29 /US 70 AT OLD GREENSBORO ROAD /DCCC ROAD

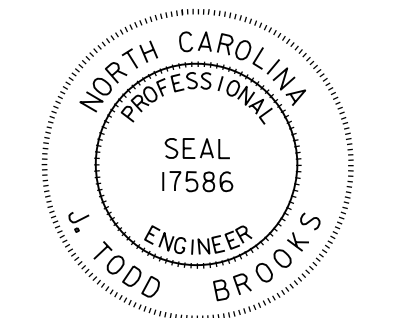TIP NO. R-5737	SHEET NO. SIGN - 1
APPROVED: _____	
DATE: _____	
SEAL	
	
DOCUMENT NOT CONSIDERED FINAL UNLESS ALL SIGNATURES COMPLETED	

ROADWAY STANDARD DRAWING

THE FOLLOWING ROADWAY STANDARDS AS APPEAR IN "ROADWAY STANDARD DRAWINGS" - PROJECT SERVICES UNIT - N.C. DEPARTMENT OF TRANSPORTATION - RALEIGH, N.C., DATED JANUARY 2018, INCLUDING REVISIONS THERETO, ARE APPLICABLE TO THIS PROJECT AND BY REFERENCE HEREBY ARE CONSIDERED A PART OF THESE PLANS:

STD. NO.	TITLE
901D10	TYPE 'A' SIGNS
901D20	TYPE 'B' SIGNS
901.50	ARROWS AND SHIELDS
901.70	SIGN STRINGERS AND SUPPORT SPACING
901.80	SIGN MOUNTING DETAILS - TYPE A AND TYPE B SIGNS
903.10	GROUND MOUNTED SIGN SUPPORTS
903.40	MEDIAN BARRIER SIGN SUPPORT AND ANCHORAGE
904.10	ORIENTATION OF GROUND MOUNTED SIGNS
904.50	MOUNTING OF TYPE 'D', 'E', AND 'F' SIGNS ON 'U' CHANNEL POSTS
910.40	ROUNDBOUT SIGNING WITH PEDESTRIANS

PAY ITEM NOTES

1. DISPOSAL OF SIGN SYSTEM, U-CHANNEL
2. DISPOSAL OF SIGN SYSTEM, WOOD
3. SIGN ERECTION, TYPE A (GROUND MOUNTED)
4. SIGN ERECTION, TYPE B (GROUND MOUNTED)
5. SIGN ERECTION, TYPE D, E, AND F
6. SUPPORTS, BARRIER MOUNTED, SMALL
7. STREET NAME SIGN SYSTEM TO BE REMOVED/RELOCATED BY OTHERS
8. WAYFINDING SIGN SYSTEM TO BE REMOVED/RELOCATED BY OTHERS

GENERAL NOTES

- . SIGNS FURNISHED BY STATE
- . CONFIRM IN WRITING AT LEAST 4 MONTHS IN ADVANCE, THE ACTUAL DATE THE DEPARTMENT FURNISHED SIGNS WILL BE REQUIRED.
- . ALL TYPE 'D' SIGNS SHALL BE MOUNTED ON TWO U-CHANNEL POSTS UNLESS OTHERWISE INDICATED ON THE PLANS.
- . IF REMOVAL OR RELOCATION OF SIGNS ON PRIVATE STREET (NON-STATE MAINTAINED) IS REQUIRED DUE TO CONSTRUCTION, THE CONTRACTOR SHALL INFORM THE ENGINEER. THE WORK WILL BE COMPLETED BY OTHERS.
- . SIGNING PLANS DO NOT INCLUDE TEMPORARY CONSTRUCTION SIGNING OR TEMPORARY PAVEMENT MARKINGS. SEE THE TRANSPORTATION MANAGEMENT PLAN (TMP).
- . WHEN NOT STATIONED OR DIMENSIONED ON PLANS, ALL 'E' AND 'F' SIGNS SHALL BE FIELD LOCATED BY THE ENGINEER
- . ALL EXISTING SIGNS ON "U" CHANNEL POST WITHIN THE PROJECT LIMITS SHALL BE REMOVED AND DISPOSED OF UNLESS OTHERWISE NOTED ON PLANS.
- . WHEN EXISTING SIGNS ARE REMOVED AND INSTALLED ON NEW SUPPORTS, THE RE-ERECTION SHALL IMMEDIATELY FOLLOW THE REMOVAL.
- . THE BACKGROUND FOR TYPE E & F SIGNS SHALL BE TYPE C REFLECTIVE SHEETING.
- . SEE ROADWAY PLANS FOR GUARD/GUIDE RAIL DETAILS.

SUMMARY OF QUANTITIES


ITEM NO.		ITEM DESCRIPTION	QUANTITY	UNIT
DESC. NO.	SECT. NO.			
4048000000	902	REINFORCED CONCRETE SIGN FOUNDATION	7	C.Y.
4060000000	903	SUPPORTS, BREAKAWAY STEEL BEAM	2736	LB
4066000000	903	SUPPORTS, SIMPLE STEEL BEAM	1360	LB
4072000000	903	SUPPORTS, 3 LB STEEL U-CHANNEL	1422	L.F
4079000000	903	SUPPORTS, BARRIER (SMALL)	2	EA.
4096000000	904	SIGN ERECTION, TYPE D	5	EA.
4102000000	904	SIGN ERECTION, TYPE E	80	EA.
4108000000	904	SIGN ERECTION, TYPE F	11	EA.
4110000000	904	SIGN ERECTION, TYPE A (GROUND MOUNTED)	8	EA.
4110000000	904	SIGN ERECTION, TYPE B (GROUND MOUNTED)	4	EA.
4155000000	907	DISPOSAL OF SIGN SYSTEM, U-CHANNEL	70	EA.
4158000000	907	DISPOSAL OF SIGN SYSTEM, WOOD	3	EA.

INDEX

SHEET NO.	DESCRIPTION
SIGN-1	TITLE SHEET
SIGN-2	SUPPORT INFORMATION
SIGN-2A	REVISED SIGNING ROADWAY STANDARD DRAWING 901D10
SIGN-2B	REVISED SIGNING ROADWAY STANDARD DRAWING 901D20
SIGN-3-3D	SIGN DESIGNS
SIGN-3E-3F	TYPE E AND F SIGNS
SIGN-4-6	EXISTING SIGNS
SIGN-7-14	PROPOSED SIGNING

PLAN REVIEWED BY: N.C.D.O.T. SIGNING AND DELINEATION UNIT

KELVIN L. JORDAN SIGNING & DELINEATION REGIONAL ENGINEER
ERIC E. WARD SIGNING & DELINEATION DESIGN ENGINEER

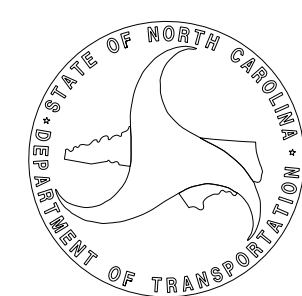

PLAN PREPARED BY: Dewberry Engineers Inc.


J. TODD BROOKS, P.E. SIGNING PROJECT MANAGER
PETER G. PADILLA, P.E. SIGNING PROJECT ENGINEER



2610 WYCLIFF ROAD
SUITE 410
RALEIGH, NC 27607
PHONE: 919.881.9939
NC COA No. F-0829

T.I.P.: R-5737


CONTRACT: C204399

TIP NO.	SHEET NO.
R-5737	DocuSign SIGN - 2A
APPROVED: <i>Matthew V. Springer</i>	DATE: 3/21/2019
BC60F6E8B584403...	
SEAL	
	


STATE OF NORTH CAROLINA
 DEPT. OF TRANSPORTATION
 DIVISION OF HIGHWAYS
 RALEIGH, N.C.

2-19

ENGLISH DETAIL DRAWING FOR
TYPE 'A' SIGNS
 WELDED STUD CONSTRUCTION

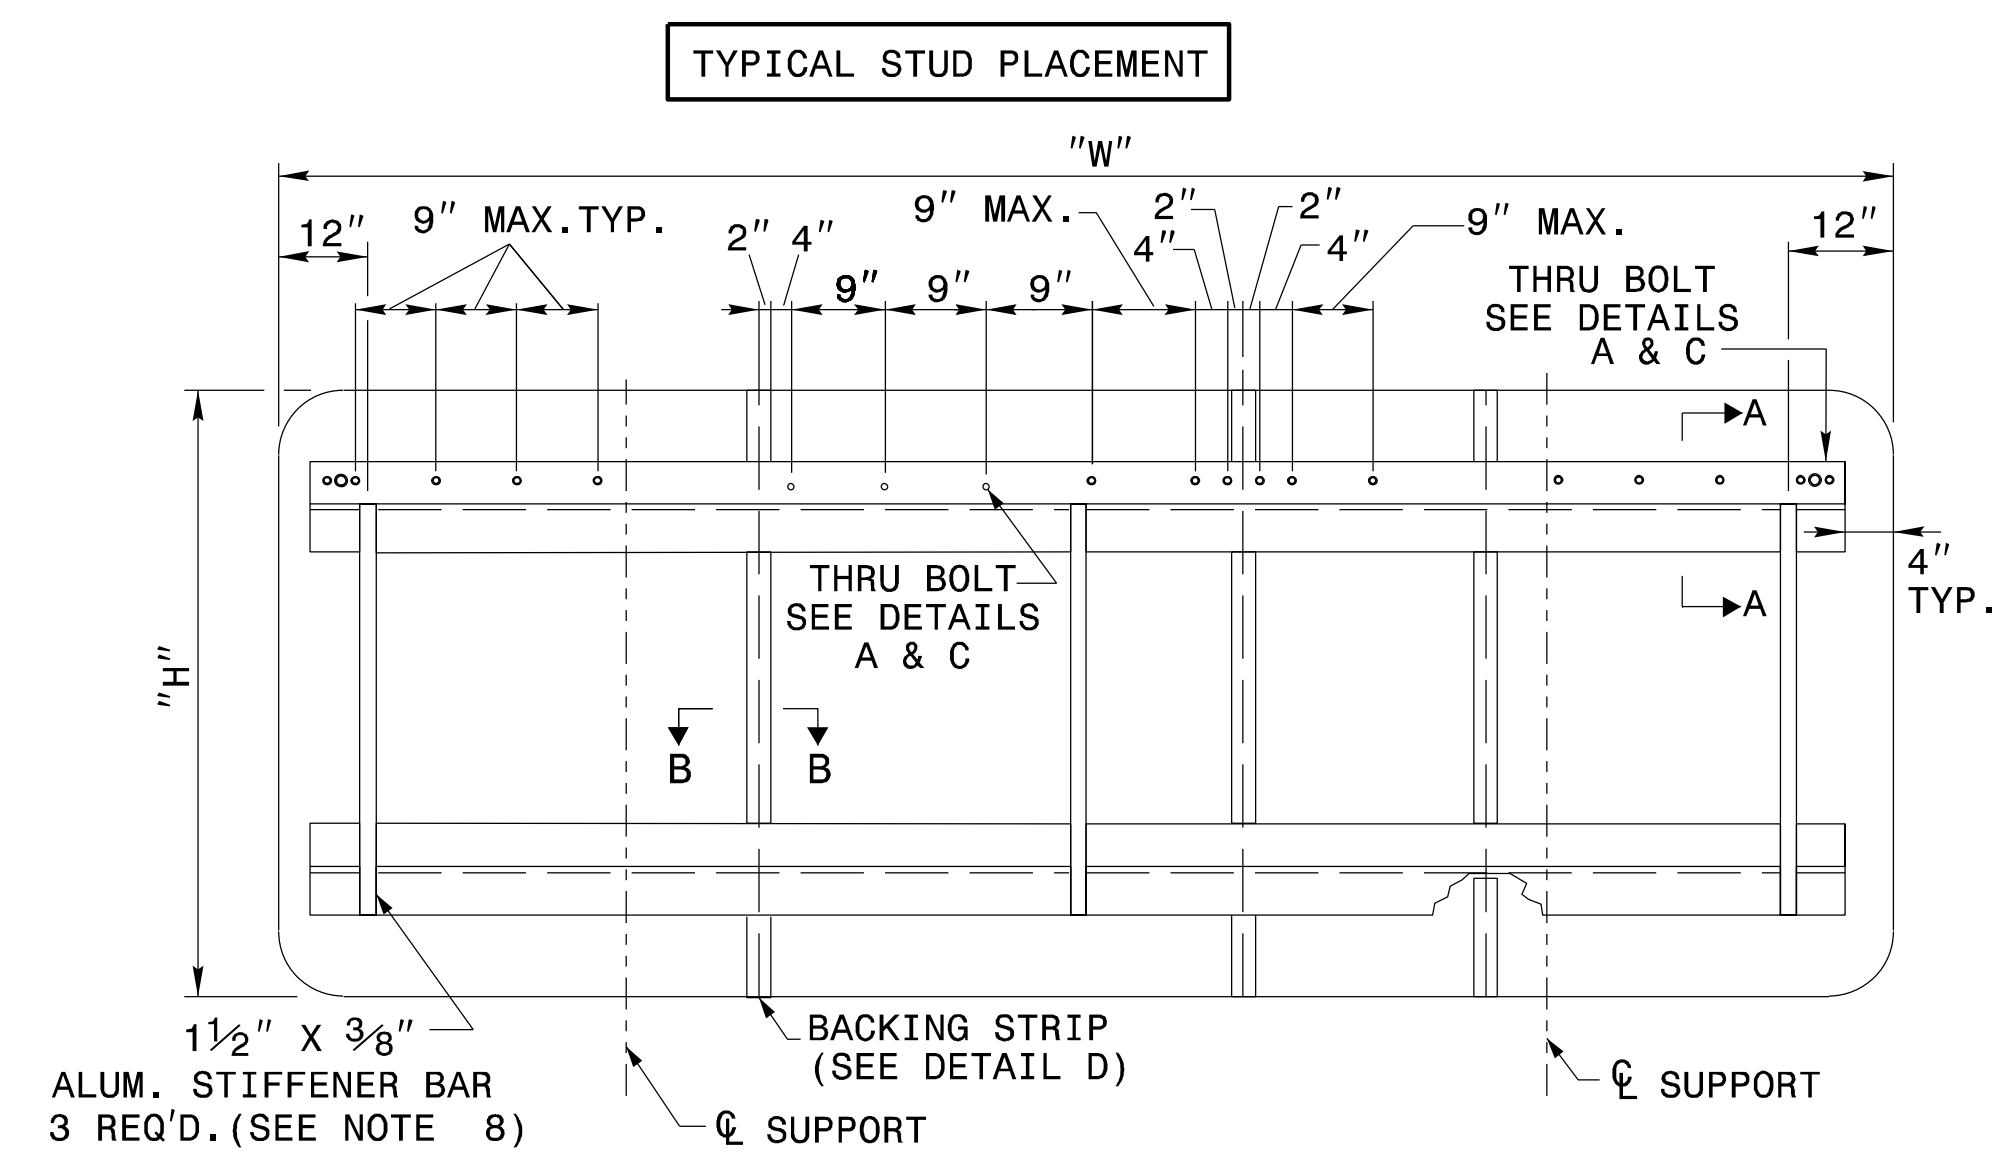

HORIZONTAL BACKING STRIP

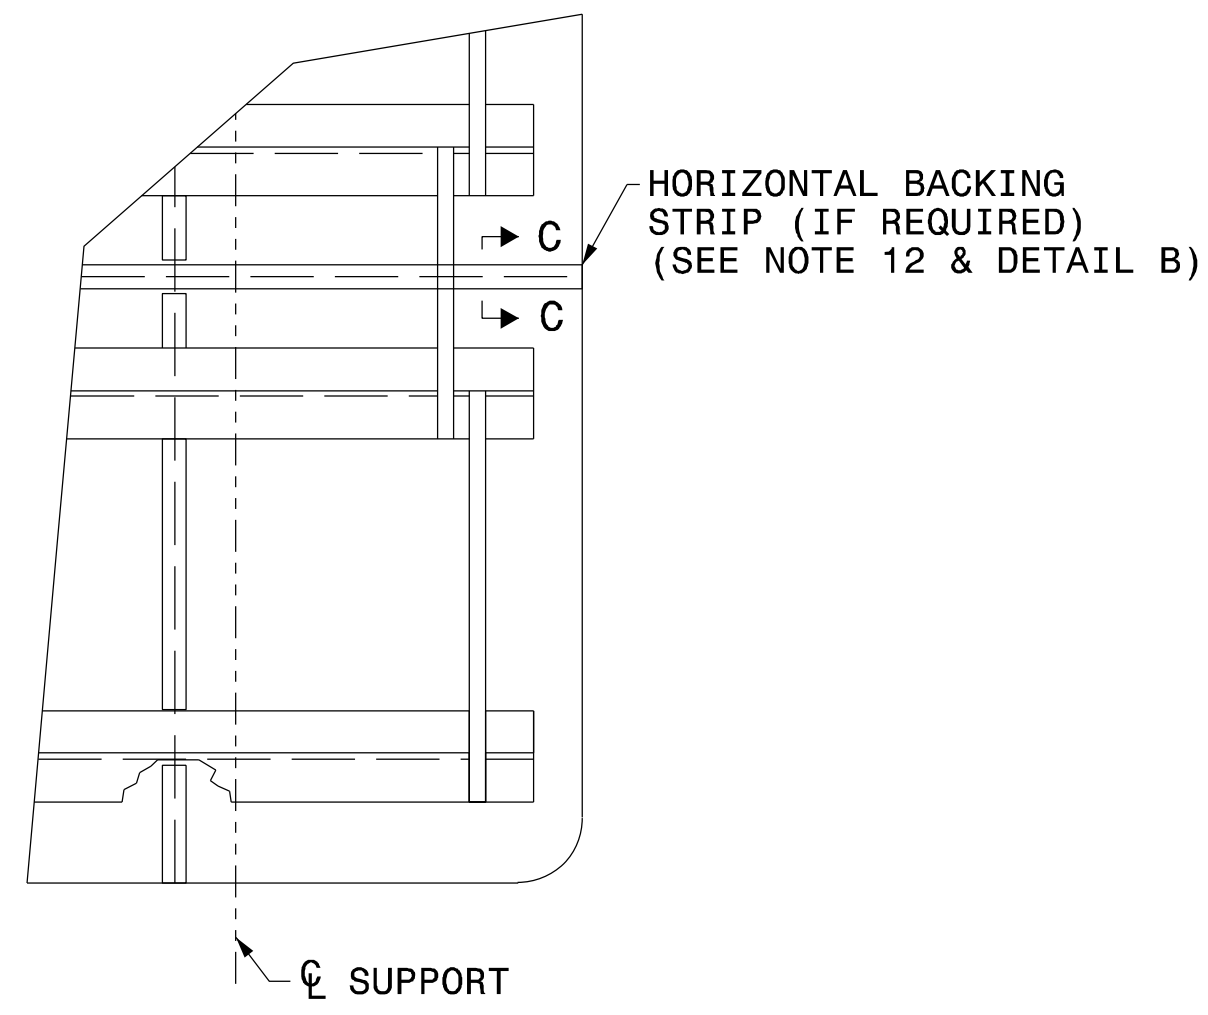

NOTES:

1. USE THE NUMBER AND SIZE OF SUPPORTS SHOWN ON THE SUPPORT CHART IN PROJECT PLANS.
2. FABRICATE SIGN PANEL SECTIONS WITH SHEETS 4'-0" WIDE. WHEN FABRICATING SIGNS WHICH ARE NOT MULTIPLES OF 4'-0" IN WIDTH, DO NOT CUT MORE THAN TWO SHEETS TO LESS THAN 4'-0" IN WIDTH. THESE PANELS SHALL NOT BE LESS THAN 1'-0" IN WIDTH.
3. SEE NCDOT STANDARD SPECIFICATIONS FOR ROADS AND STRUCTURES, FOR TYPE OF MATERIAL TO BE USED FOR SIGN PANELS, HANGER ASSEMBLIES, AND SUPPORTS.
4. USE GALVANIZED STEEL FOR BACKING PLATES AND MOUNTING BOLTS.
5. SEE ROADWAY STANDARD 904.20 WHEN TYPE "B" SECONDARY SIGN MOUNTING IS REQUIRED.
6. DETAILS FOR TYPE "A" SECONDARY SIGNS SHALL BE THE SAME AS FOR TYPE "A" SIGNS.
7. THE VERTICAL DIMENSION BETWEEN PRIMARY AND SECONDARY SIGNS IS TWO (2) INCHES.
8. ADJUST STIFFENERS TO AVOID CONFLICT WITH SUPPORTS.
9. SEE ROADWAY STANDARD 901.70 FOR SUPPORT AND "Z" BAR SPACING.
10. FABRICATE SIGNS TALLER THAN 12'-0" AS TWO SEPARATE SIGNS WITH A HORIZONTAL SPLICE. LOCATE STRINGERS ON EACH SECTION OF THE SIGN BY THE SIGN STRINGER CHART. (SEE ROADWAY STANDARD 901.70)
11. FABRICATE SIGNS TALLER THAN 12'-0" BUT SHORTER THAN 14'-6" WITH A HORIZONTAL SPLICE LOCATED 7'-0" FROM BOTTOM OF SIGN.
12. FABRICATE SIGNS 14'-6" TALL AND TALLER WITH A HORIZONTAL SPLICE. LOCATE THE SPLICE AT LEAST HALF OF THE SIGN HEIGHT FROM THE BOTTOM AND AT LEAST 7'-0" FROM THE TOP.
13. THERE SHALL ONLY BE A 1/8" GAP BETWEEN THE VERTICAL BACKING STRIP AND THE "Z" BAR.
14. SEE ROADWAY STANDARD 901.80 FOR DETAILS SHOWING SIGN MOUNTING TO SUPPORTS.
15. PLACE NYLON WASHER UNDER HEAD OF 3/8" THRU BOLTS.
16. FABRICATE EACH SIGN WITH 3/8" DIA. THRU BOLT, 4" FROM EACH END OF EACH "Z" BAR THRU SIGN PANEL AND "Z" BAR. SEE DETAILS A & C.
17. FABRICATE EACH SIGN WITH 3/8" DIA. THRU BOLT CENTERED IN EACH PANEL THRU THE TOP AND BOTTOM "Z" BAR. CENTERED THRU BOLT REQUIRED IN END PANELS GREATER THAN 2'-0" WIDE. SEE DETAILS A & C.
18. THRU BOLTS WILL HAVE A MINIMUM 1/16" TO MAXIMUM 1/8" GAP

STATE OF NORTH CAROLINA
 DEPT. OF TRANSPORTATION
 DIVISION OF HIGHWAYS
 RALEIGH, N.C.

2-19

ENGLISH DETAIL DRAWING FOR
TYPE 'A' SIGNS
 WELDED STUD CONSTRUCTION


SHEET 1 OF 2

901D10

REVISED SIGNING
ROADWAY STANDARD DRAWING

03/20/19 S:\3&DU\Standards and Drawings\Drawings\2018 Standard Dwg\Division 9 Final\0901\0_sgn_sht01_type a_sgn_2-19.dgn User:RSTONES

TIP NO.	SHEET NO.
R-5737	DocuSign SIGN - 2B
APPROVED:	<i>Matthew V. Springer</i>
DATE:	3/21/2019
SEAL	BC60F6E8B584403...



STATE OF NORTH CAROLINA
 DEPT. OF TRANSPORTATION
 DIVISION OF HIGHWAYS
 RALEIGH, N.C.


2-19

ENGLISH DETAIL DRAWING FOR
TYPE 'B' SIGNS
 WELDED STUD CONSTRUCTION


STATE OF NORTH CAROLINA
 DEPT. OF TRANSPORTATION
 DIVISION OF HIGHWAYS
 RALEIGH, N.C.

2-19


ENGLISH DETAIL DRAWING FOR
TYPE 'B' SIGNS
 WELDED STUD CONSTRUCTION

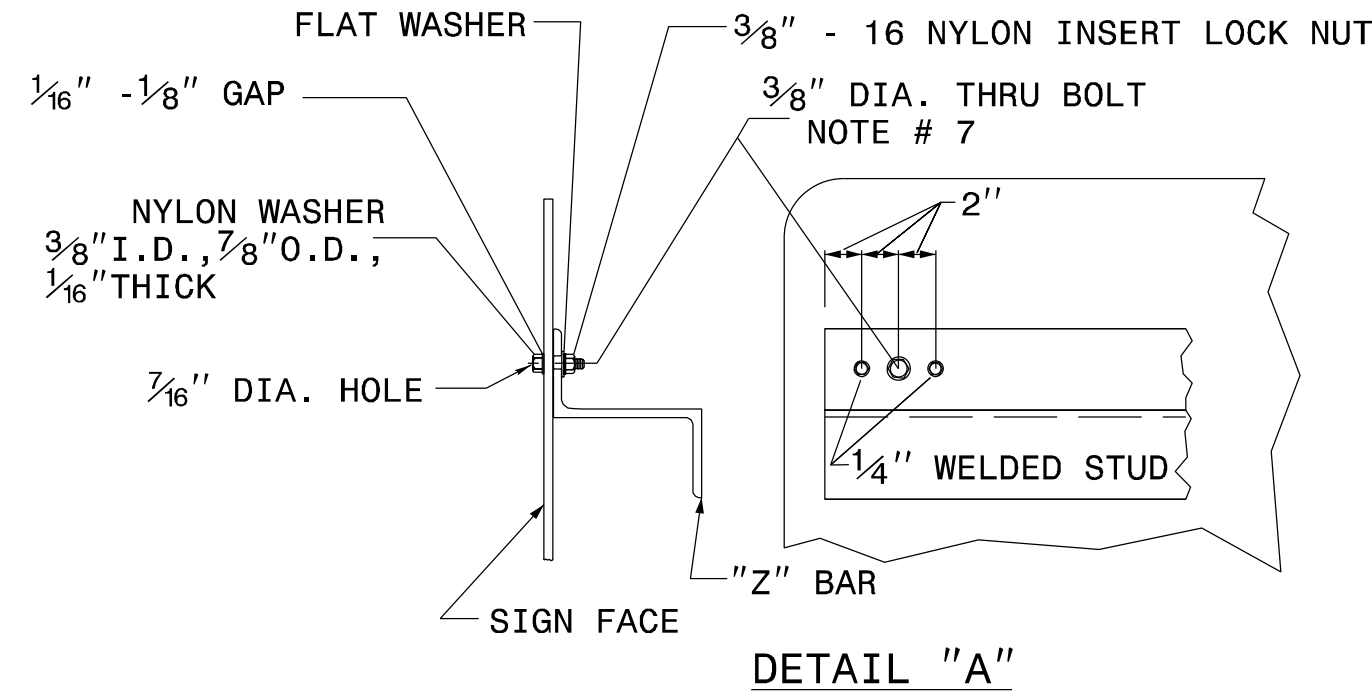


DETAIL "A"

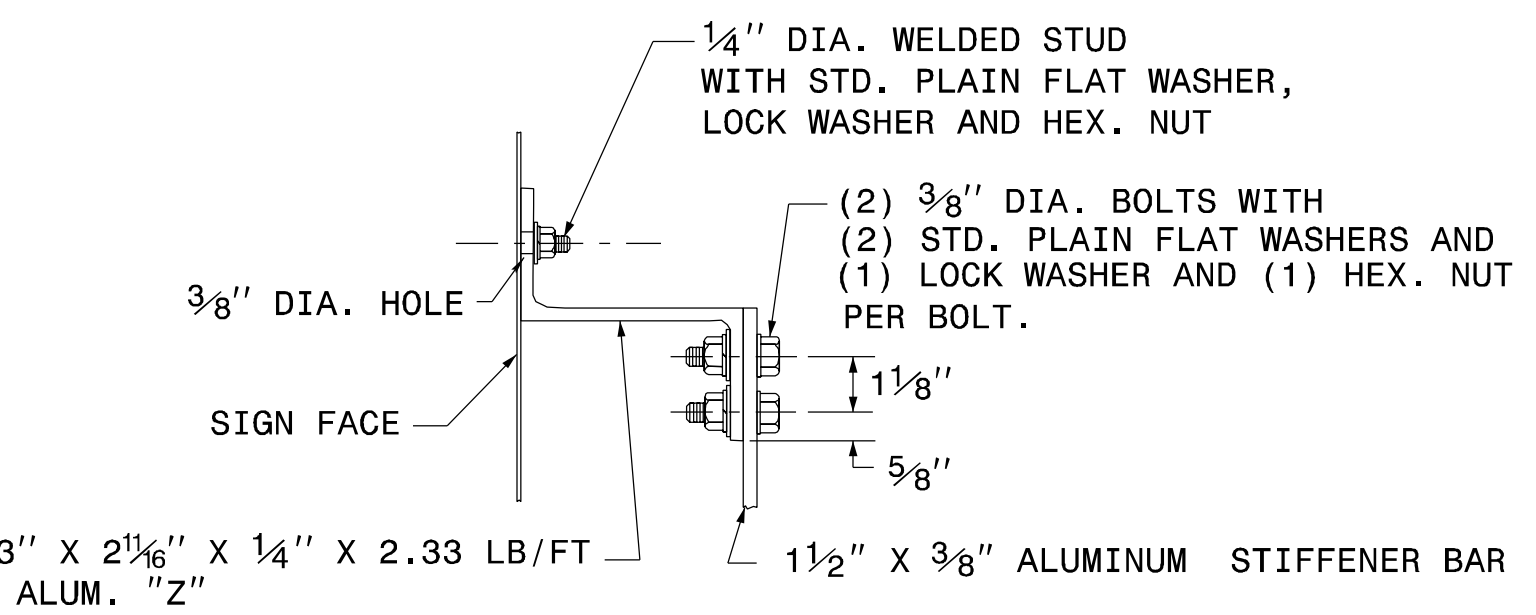

SECTION A-A
STIFFENER DETAIL

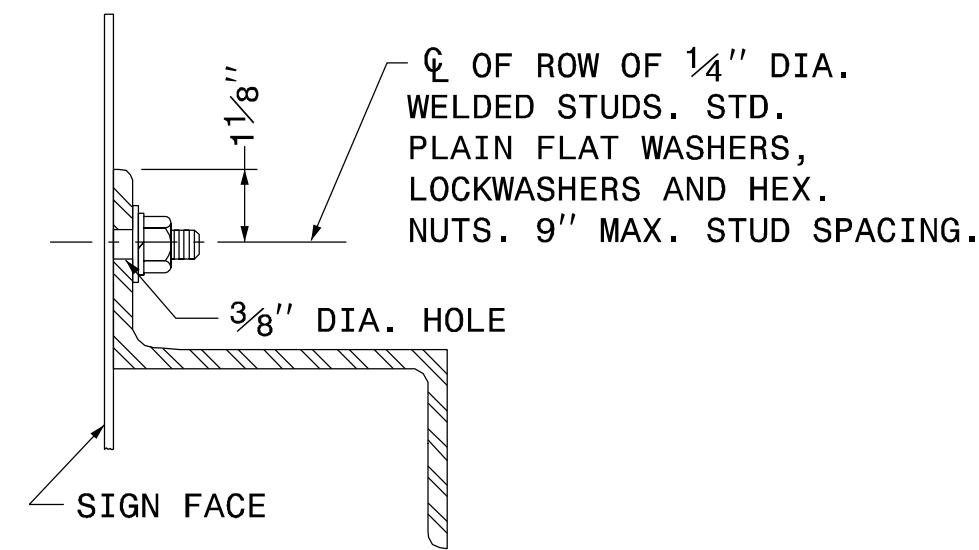

SECTION B-B

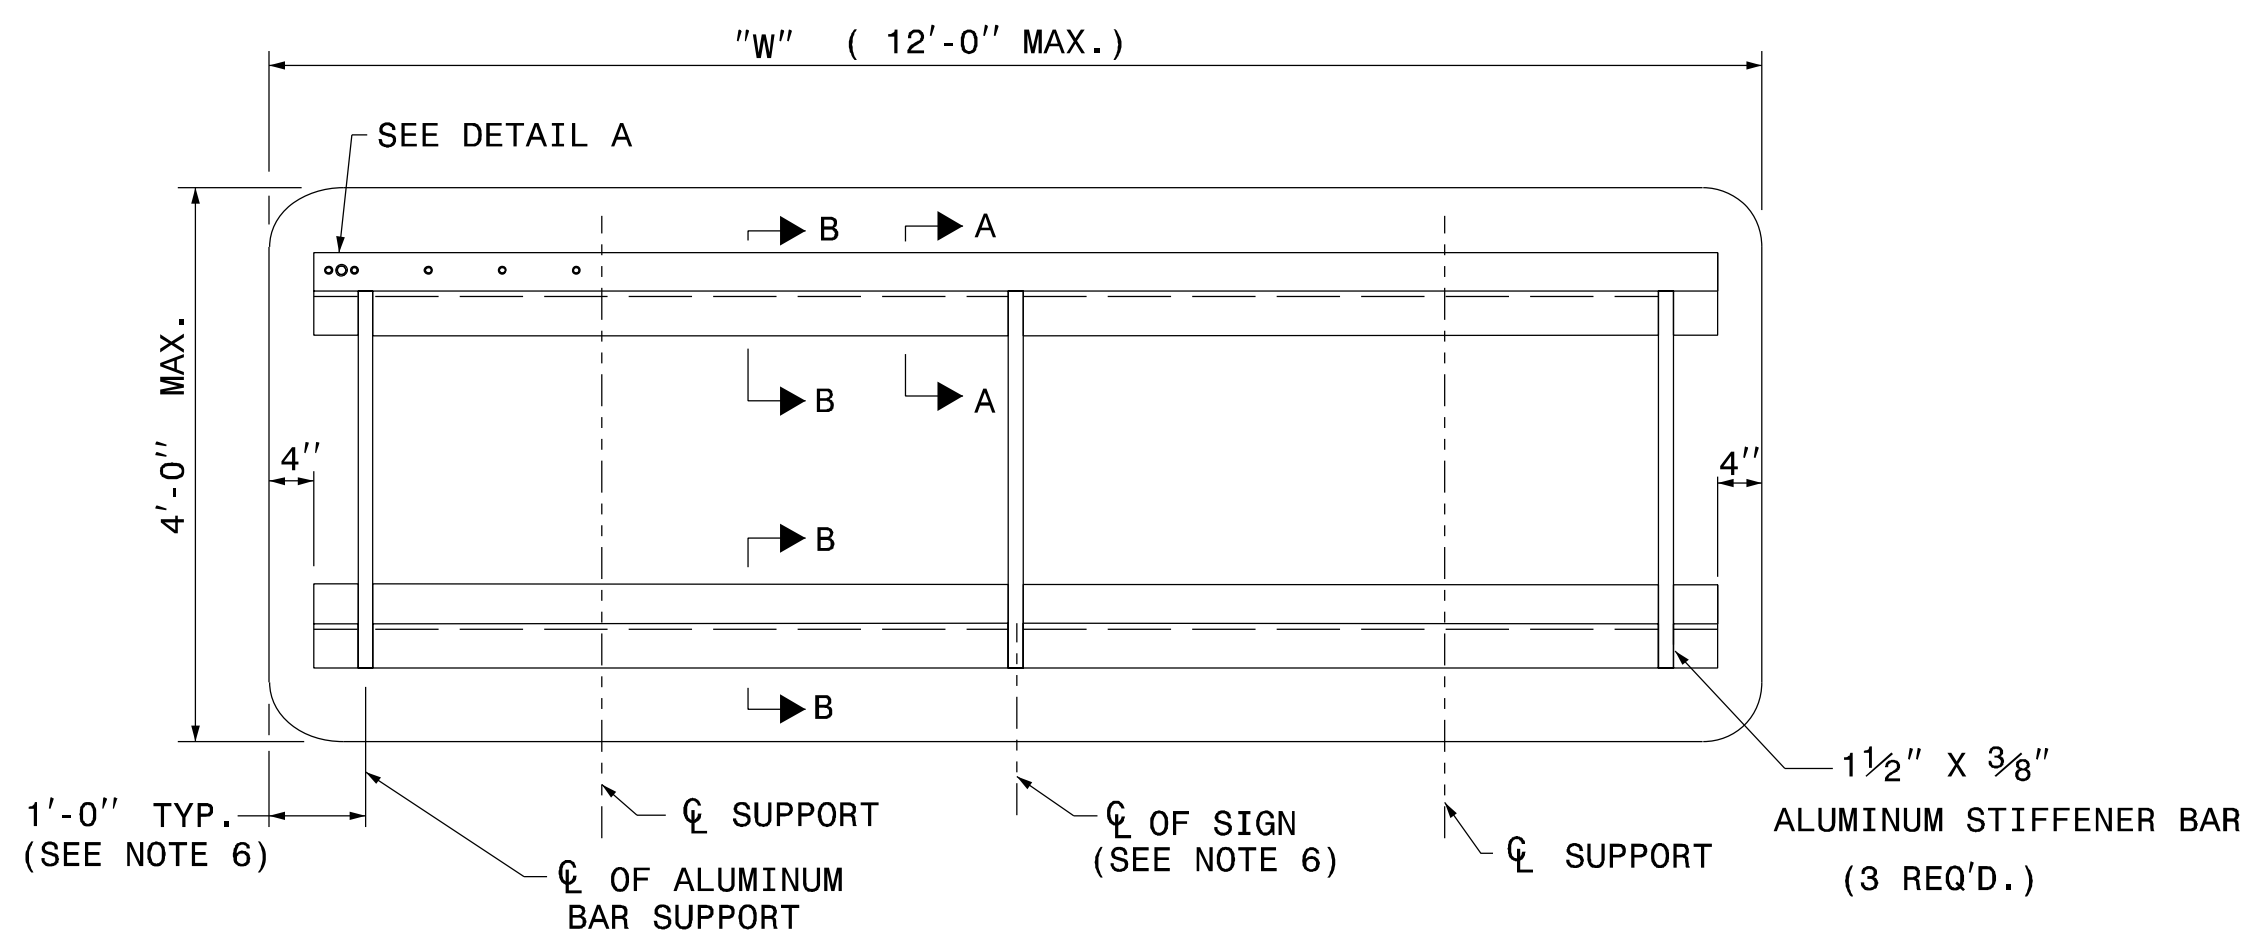

NOTES:

1. USE NUMBER AND SIZE OF SUPPORTS SHOWN ON SUPPORT CHART IN PROJECT PLAN SHEETS.
2. SEE NCDOT STANDARD SPECIFICATIONS FOR ROADS AND STRUCTURES FOR THE TYPE OF MATERIAL TO BE USED FOR SIGN PANELS, HANGER ASSEMBLIES AND SUPPORTS.
3. FURNISH ALL MOUNTING HARDWARE.
4. USE GALVANIZED STEEL FOR BACKING PLATES AND MOUNTING BOLTS.
5. THE VERTICAL DIMENSION BETWEEN PRIMARY AND SECONDARY SIGNS IS TWO (2) INCHES.
6. ADJUST STIFFENERS TO AVOID CONFLICT WITH SUPPORTS.
7. FABRICATE EACH SIGN WITH A 3/8" DIA. BOLT 4" FROM EACH END OF EACH "Z" BAR THRU SIGN PANEL AND "Z" BAR.
8. SEE ROADWAY STANDARD 901.70 FOR SUPPORT AND "Z" BAR SPACING.
9. SEE ROADWAY STANDARD 901.80 FOR DETAILS SHOWING SIGN MOUNTING TO SUPPORTS.
10. PLACE NYLON WASHER UNDER HEAD OF 3/8" THRU BOLT.
11. THRU BOLTS WILL HAVE A MINIMUM 1/16" TO MAXIMUM 1/8" GAP.

SHEET 1 OF 1
901D20

SHEET 1 OF 1
901D20

**REVISED SIGNING
ROADWAY STANDARD DRAWING**

03/20/19 S:\S&DU\Standards and Drawings\Drawings\2018 Standard Dwgs\Division 9 Final\0901d20.sgn_type b sign_2-19.dgn User:dstokes

3-14-19

SIGN NUMBER: 101, 110 TYPE: A QUANTITY: 2
 BACKG COLOR: Green COPY COLOR: Black
 SIGN WIDTH: 18'-6" HEIGHT: 5'-6" TOTAL AREA: 101.8 Sq.Ft.
 DESIGN BY: PGPADILLA CHECKED BY: JTBROOKS Feb 26, 2021
 PROJECT ID: R-5737 LOCATION: DAVIDSON CO. DIV: 9

SYMBOL	X	Y	WID	HT

BORDER TYPE: FLUSH RECESS: 0" WIDTH: 2" RADII: 9" MAT'L: 0.125" (3.2 mm) ALUMINUM
 NO. Z BARS: 2 LENGTH: 214.0

USE NOTES:
 1. Legend and border shall be direct applied Grade C sheeting.
 2. Background shall be Grade C reflective sheeting.

Panel Style: guide_exp_advance_a.ssi M.U.T.C.D.: 2009 Edition
 Spacing Factor is 1 unless specified otherwise

LETTER POSITIONS

Letter spacings are to start of next letter

Series/Size	Text Length
EM 2000	196.8
E 2000	70.1

FILENAME: DCCC Signing NORTH CAROLINA D.O.T. SIGN DETAIL

SIGN NUMBER: 102, 109 TYPE: A QUANTITY: 2
 BACKG COLOR: Green COPY COLOR: White
 SIGN WIDTH: 15'-6" HEIGHT: 7'-0" TOTAL AREA: 108.5 Sq.Ft.
 DESIGN BY: PGPADILLA CHECKED BY: JTBROOKS Feb 26, 2021
 PROJECT ID: R-5737 LOCATION: DAVIDSON CO. DIV: 9

SYMBOL	X	Y	WID	HT

BORDER TYPE: FLUSH RECESS: 0" WIDTH: 2" RADII: 11" MAT'L: 0.125" (3.2 mm) ALUMINUM
 NO. Z BARS: 2 LENGTH: 178.0

USE NOTES:
 1. Legend and border shall be direct applied Grade C sheeting.
 2. Background shall be Grade C reflective sheeting.

Panel Style: guide_exp_advance_a.ssi M.U.T.C.D.: 2009 Edition
 Spacing Factor is 1 unless specified otherwise

LETTER POSITIONS

Letter spacings are to start of next letter

Series/Size	Text Length
EM 2000	162.5
EM 2000	6.7
EM 2000	149
E 2000	88.8

FILENAME: DCCC Signing NORTH CAROLINA D.O.T. SIGN DETAIL

SIGN NUMBER: 103, 108 TYPE: A QUANTITY: 2
 BACKG COLOR: Green COPY COLOR: White
 SIGN WIDTH: 18'-6" HEIGHT: 6'-6" TOTAL AREA: 120.3 Sq.Ft.
 DESIGN BY: PGPADILLA CHECKED BY: JTBROOKS Feb 26, 2021
 PROJECT ID: R-5737 LOCATION: DAVIDSON CO. DIV: 9

SYMBOL	X	Y	WID	HT
AR_Type A	98.3	13.8	19	29.9

BORDER TYPE: FLUSH RECESS: 0" WIDTH: 2" RADII: 10" MAT'L: 0.125" (3.2 mm) ALUMINUM
 NO. Z BARS: 2 LENGTH: 214.0

USE NOTES:
 1. Legend and border shall be direct applied Grade C sheeting.
 2. Background shall be Grade C reflective sheeting.
 3. Arrow shall be on .032" aluminum, white Grade C reflective sheeting and demountable.

Panel Style: guide_exp_advance_a.ssi M.U.T.C.D.: 2009 Edition
 Spacing Factor is 1 unless specified otherwise

LETTER POSITIONS

Letter spacings are to start of next letter

Series/Size	Text Length
EM 2000	196.8

FILENAME: DCCC Signing NORTH CAROLINA D.O.T. SIGN DETAIL

SIGN NUMBER: 104 TYPE: B QUANTITY: 1
 BACKG COLOR: Green COPY COLOR: White
 SIGN WIDTH: 7'-0" HEIGHT: 1'-6" TOTAL AREA: 10.5 Sq.Ft.
 DESIGN BY: PGPADILLA CHECKED BY: JTBROOKS Feb 26, 2021
 PROJECT ID: R-5737 LOCATION: DAVIDSON CO. DIV: 9

SYMBOL	X	Y	WID	HT
AR_Type D	7.7	4.5	6	9

BORDER TYPE: FLUSH RECESS: 0" WIDTH: 0.75" RADII: 2.25" MAT'L: 0.125" (3.2 mm) ALUMINUM
 NO. Z BARS: 2 LENGTH:

USE NOTES:
 1. Legend and border shall be direct applied Grade C sheeting.
 2. Background shall be Grade C reflective sheeting.
 3. Arrow shall be on 0.032" aluminum, white Grade C reflective sheeting and demountable.

Panel Style: R5737.ssi M.U.T.C.D.: 2009 Edition
 Spacing Factor is 1 unless specified otherwise

LETTER POSITIONS

Letter spacings are to start of next letter

Series/Size	Text Length
D 2000	53.8

FILENAME: DCCC Signing NORTH CAROLINA D.O.T. SIGN DETAIL

APPROVED: _____
 DATE: _____
 SEAL

 DOCUMENT NOT CONSIDERED FINAL UNLESS ALL SIGNATURES COMPLETED

invold_expresing10737_Sign_3.dgn USER: abesneors



2610 WYCLIFF ROAD
 SUITE 410
 RALEIGH, NC 27607
 PHONE: 919.881.9939
 NC COA No. F-0929

SIGN DESIGNS

SIGN NUMBER: 105 BACKG COLOR: Green
TYPE: B COPY COLOR: White
QUANTITY: 1

SYMBOL	X	Y	WID	HT
AR_Type D	74.9	6	6	9

SIGN WIDTH: 8'-0"
HEIGHT: 1'-6"
TOTAL AREA: 12.0 Sq.Ft.

BORDER TYPE: FLUSH
RECESS: 0"
WIDTH: 0.75"
RADII: 2.25"

NO. Z BARS: MAT'L: 0.125" (3.2 mm) ALUMINUM
LENGTH:

DESIGN BY: PGPADILLA CHECKED BY: JT Brooks Feb 26, 2021
PROJECT ID: R-5737 LOCATION: DAVIDSON CO. DIV: 9

USE NOTES:
1. Legend and border shall be direct applied Grade C sheeting.
2. Background shall be Grade C reflective sheeting.
3. Arrow shall be on 0.032" aluminum, white Grade C reflective sheeting and demountable.

Panel Style: guide_con_circular.ssi
M.U.T.C.D.: 2009 Edition

Spacing Factor is 1 unless specified otherwise

LETTER POSITIONS

Letter spacings are to start of next letter

Series/Size	Text Length
D 2000	53.8

FILENAME: DCCC Signing NORTH CAROLINA D.O.T. SIGN DETAIL

SIGN NUMBER: 106 BACKG COLOR: Green
TYPE: B COPY COLOR: White
QUANTITY: 1

SYMBOL	X	Y	WID	HT
AR_Type D	76.7	12	6	9

SIGN WIDTH: 8'-0"
HEIGHT: 2'-6"
TOTAL AREA: 20.0 Sq.Ft.

BORDER TYPE: FLUSH
RECESS: 0"
WIDTH: 0.75"
RADII: 2.25"

NO. Z BARS: MAT'L: 0.125" (3.2 mm) ALUMINUM
LENGTH:

DESIGN BY: PGPADILLA CHECKED BY: JT Brooks Feb 26, 2021
PROJECT ID: R-5737 LOCATION: DAVIDSON CO. DIV: 9

USE NOTES:
1. Legend and border shall be direct applied Grade C sheeting.
2. Background shall be Grade C reflective sheeting.
3. Arrow shall be .032" aluminum, white Grade C reflective sheeting and demountable.

Panel Style: guide_con_destination.ssi
M.U.T.C.D.: 2009 Edition

Spacing Factor is 1 unless specified otherwise

LETTER POSITIONS

Letter spacings are to start of next letter

Series/Size	Text Length
D 2000	57.4
D 2000	3
D 2000	54.7

FILENAME: DCCC Signing NORTH CAROLINA D.O.T. SIGN DETAIL

SIGN NUMBER: 107 BACKG COLOR: Green
TYPE: B COPY COLOR: White
QUANTITY: 1

SYMBOL	X	Y	WID	HT
AR_Type D	10.3	12	6	9

SIGN WIDTH: 8'-0"
HEIGHT: 2'-6"
TOTAL AREA: 20.0 Sq.Ft.

BORDER TYPE: FLUSH
RECESS: 0"
WIDTH: 0.75"
RADII: 2.25"

NO. Z BARS: MAT'L: 0.125" (3.2 mm) ALUMINUM
LENGTH:

DESIGN BY: PGPADILLA CHECKED BY: JT Brooks Feb 26, 2021
PROJECT ID: R-5737 LOCATION: DAVIDSON CO. DIV: 9

USE NOTES:
1. Legend and border shall be direct applied Grade C sheeting.
2. Background shall be Grade C reflective sheeting.
3. Arrow shall be .032" aluminum, white Grade C reflective sheeting and demountable.

Panel Style: guide_con_destination.ssi
M.U.T.C.D.: 2009 Edition

Spacing Factor is 1 unless specified otherwise

LETTER POSITIONS

Letter spacings are to start of next letter

Series/Size	Text Length
D 2000	57.4
D 2000	3
D 2000	54.7

FILENAME: DCCC Signing NORTH CAROLINA D.O.T. SIGN DETAIL

SIGN NUMBER: 201, 202 BACKG COLOR: Green
TYPE: A COPY COLOR: White
QUANTITY: 2

SYMBOL	X	Y	WID	HT
AR_Type A	24.8	7	17.9	28.1

SIGN WIDTH: 6'-0"
HEIGHT: 5'-0"
TOTAL AREA: 30.0 Sq.Ft.

BORDER TYPE: FLUSH
RECESS: 0"
WIDTH: 1.5"
RADII: 6"

NO. Z BARS: 2 MAT'L: 0.125" (3.2 mm) ALUMINUM
LENGTH: 64.0

DESIGN BY: PGPADILLA CHECKED BY: JT Brooks Jul 20, 2020
PROJECT ID: R-5737 LOCATION: DAVIDSON CO. DIV: 9

USE NOTES:
1. Legend and border shall be direct applied Grade C sheeting.
2. Background shall be Grade C reflective sheeting.
3. Arrow shall be .032" aluminum, white Grade C reflective sheeting and demountable.

Panel Style: guide_fwy_gore.ssi
M.U.T.C.D.: 2009 Edition

Spacing Factor is 1 unless specified otherwise

LETTER POSITIONS

Letter spacings are to start of next letter

Series/Size	Text Length
EM 2000	44.9

FILENAME: DCCC Signing NORTH CAROLINA D.O.T. SIGN DETAIL

APPROVED: _____
DATE: _____

SEAL

DOCUMENT NOT CONSIDERED FINAL
UNLESS ALL SIGNATURES COMPLETED

invld: expressign... sheets\0737_Sign_3A.dgn
USER: abe@ncdps



2610 WYCLIFF ROAD
SUITE 410
RALEIGH, NC 27607
PHONE: 919.881.9939
NC COA No. F-0929

SIGN DESIGNS

SIGN NUMBER: 301 TYPE: D QUANTITY: 1
 BACKG COLOR: Green COPY COLOR: White
 DESIGN BY: PGPADILLA CHECKED BY: JTBROOKS
 PROJECT ID: R-5737 LOCATION: DAVIDSON CO. FEB 26, 2021 DIV: 9

SYMBOL	X	Y	WID	HT
AR_FISHOOK	7.4	3.6	10.1	10.8

SIGN WIDTH: 8'-6" HEIGHT: 1'-6" TOTAL AREA: 12.8 Sq.Ft.
 BORDER TYPE: FLUSH RECESS: 0" WIDTH: 0.75" RADII: 2.25"
 NO. Z BARS: LENGTH:

MAT'L: 0.125" (3.2 mm) ALUMINUM

BORDER R=2.25" TH=0.75"
 Panel Style: R 2.25.ssi
 M.U.T.C.D.: 2009 Edition

USE NOTES:
 1. Legend and border shall be direct applied Grade C sheeting.
 2. Background shall be Grade C reflective sheeting.
 3. Arrow shall be on 0.032" aluminum, white Grade C reflective sheeting and demountable.

Spacing Factor is 1 unless specified otherwise

LETTER POSITIONS

Letter spacings are to start of next letter

Series/Size	Text Length
D 2000	71.2

FILENAME: DCCC Signing NORTH CAROLINA D.O.T. SIGN DETAIL

SIGN NUMBER: 302 TYPE: D QUANTITY: 1
 BACKG COLOR: Green COPY COLOR: White
 DESIGN BY: PGPADILLA CHECKED BY: JTBROOKS
 PROJECT ID: R-5737 LOCATION: DAVIDSON CO. JUL 21, 2020 DIV: 9

SYMBOL	X	Y	WID	HT
AR_Type D	85.1	6	6	9

SIGN WIDTH: 8'-6" HEIGHT: 1'-6" TOTAL AREA: 12.8 Sq.Ft.
 BORDER TYPE: FLUSH RECESS: 0" WIDTH: 0.75" RADII: 2.25"
 NO. Z BARS: LENGTH:

MAT'L: 0.125" (3.2 mm) ALUMINUM

BORDER R=2.25" TH=0.75"
 Panel Style: guide_con_destination.ssi
 M.U.T.C.D.: 2009 Edition

USE NOTES:
 1. Legend and border shall be direct applied Grade C sheeting.
 2. Background shall be Grade C reflective sheeting.
 3. Arrow shall be on .032" aluminum, white Grade C reflective sheeting and demountable.

Spacing Factor is 1 unless specified otherwise

LETTER POSITIONS

Letter spacings are to start of next letter

Series/Size	Text Length
D 2000	71.2

FILENAME: DCCC Signing NORTH CAROLINA D.O.T. SIGN DETAIL

SIGN NUMBER: 303 TYPE: D QUANTITY: 1
 BACKG COLOR: Green COPY COLOR: White
 DESIGN BY: PGPADILLA CHECKED BY: JTBROOKS
 PROJECT ID: R-5737 LOCATION: DAVIDSON CO. FEB 26, 2021 DIV: 9

SYMBOL	X	Y	WID	HT
AR_FISHOOK	6.7	16.9	10.1	10.8
AR_Type D	68.5	4.8	6	8.9

SIGN WIDTH: 7'-0" HEIGHT: 2'-6" TOTAL AREA: 17.5 Sq.Ft.
 BORDER TYPE: FLUSH RECESS: 0" WIDTH: 0.75" RADII: 2.25"
 NO. Z BARS: LENGTH:

MAT'L: 0.125" (3.2 mm) ALUMINUM

BORDER R=2.25" TH=0.75"
 Panel Style: R5737.ssi
 M.U.T.C.D.: 2009 Edition

USE NOTES:
 1. Legend and border shall be direct applied Grade C sheeting.
 2. Background shall be Grade C reflective sheeting.
 3. Arrow shall be on 0.032" aluminum, white Grade C reflective sheeting and demountable.

Spacing Factor is 1 unless specified otherwise

LETTER POSITIONS

Letter spacings are to start of next letter

Series/Size	Text Length
D 2000	35.2
D 2000	39.6

FILENAME: DCCC Signing NORTH CAROLINA D.O.T. SIGN DETAIL

SIGN NUMBER: 304 TYPE: D QUANTITY: 1
 BACKG COLOR: Green COPY COLOR: White
 DESIGN BY: PGPADILLA CHECKED BY: JTBROOKS
 PROJECT ID: R-5737 LOCATION: DAVIDSON CO. FEB 26, 2021 DIV: 9

SYMBOL	X	Y	WID	HT
AR_FISHOOK	6.6	17	10.1	10.7
AR_Type D	68.5	4.8	6	8.9

SIGN WIDTH: 7'-0" HEIGHT: 2'-6" TOTAL AREA: 17.5 Sq.Ft.
 BORDER TYPE: FLUSH RECESS: 0" WIDTH: 0.75" RADII: 2.25"
 NO. Z BARS: LENGTH:

MAT'L: 0.125" (3.2 mm) ALUMINUM

BORDER R=2.25" TH=0.75"
 Panel Style: R5737.ssi
 M.U.T.C.D.: 2009 Edition

USE NOTES:
 1. Legend and border shall be direct applied Grade C sheeting.
 2. Background shall be Grade C reflective sheeting.
 3. Arrow shall be on 0.032" aluminum, white Grade C reflective sheeting and demountable.

Spacing Factor is 1 unless specified otherwise

LETTER POSITIONS

Letter spacings are to start of next letter

Series/Size	Text Length
D 2000	39.6
D 2000	35.2

FILENAME: DCCC Signing NORTH CAROLINA D.O.T. SIGN DETAIL

APPROVED: _____
 DATE: _____
 SEAL

 DOCUMENT NOT CONSIDERED FINAL UNLESS ALL SIGNATURES COMPLETED

inv\old_express\sign\sheet\10737_Sign_3B.dgn USER: abes@ncors




2610 WYCLIFF ROAD
 SUITE 410
 RALEIGH, NC 27607
 PHONE: 919.881.9939
 NC COA No. F-0929

SIGN DESIGNS

APPROVED: _____

DATE: _____

SEAL

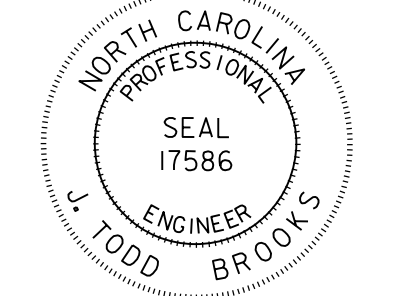

DOCUMENT NOT CONSIDERED FINAL UNLESS ALL SIGNATURES COMPLETED

SIGN NUMBER: 104 FUTURE TYPE: B	BACKG COLOR: Green COPY COLOR: White	DESIGN BY: PGPADILLA PROJECT ID: R-5737	CHECKED BY: JT Brooks LOCATION: DAVIDSON CO.	Feb 26, 2021 DIV: 9
------------------------------------	---	--	---	------------------------

SYMBOL	X	Y	WID	HT
AR_Type D	7.7	29.8	6	9
AR_FISHOOK	7.7	7.5	10.1	10.8

QUANTITY: 1
SIGN WIDTH: 7'-0"
HEIGHT: 3'-6"
TOTAL AREA: 24.5 Sq.Ft.

BORDER TYPE: FLUSH
RECESS: 0"
WIDTH: 0.75"
RADII: 2.25"

NO. Z BARS: _____
LENGTH: _____

MAT'L: 0.125" (3.2 mm) ALUMINUM

USE NOTES:
1. Legend and border shall be direct applied Grade C sheeting.
2. Background shall be Grade C reflective sheeting.
3. Arrow shall be on 0.032" aluminum, white Grade C reflective sheeting and demountable.

Panel Style: R5737.ssi
M.U.T.C.D.: 2009 Edition
Spacing Factor is 1 unless specified otherwise

LETTER POSITIONS

Letter spacings are to start of next letter

	C	a	i	d	c	l	e	u	g	h	R	d	Series/Size Text Length
22.6	5	4.6	1.9	4.6	4.3	1.9	4.3	4.5	4.8	3.5	6	4.7	D 2000 53.8
41.6	D	D	C	C									D 2000 20
26.8	L	i	n	k	C	a	m	p	u	s			D 2000 49.5

FILENAME: DCCC Signing
NORTH CAROLINA D.O.T. SIGN DETAIL

SIGN NUMBER: 105 FUTURE TYPE: B	BACKG COLOR: GREEN COPY COLOR: WHITE	DESIGN BY: PGPADILLA PROJECT ID: R-5737	CHECKED BY: JT Brooks LOCATION: DAVIDSON CO.	Feb 26, 2021 DIV: 9
------------------------------------	---	--	---	------------------------

SYMBOL	X	Y	WID	HT
AR_FISHOOK	6.4	23.7	10.1	10.8
AR_Type D	74.9	4.8	6	9

QUANTITY: 1
SIGN WIDTH: 8'-0"
HEIGHT: 3'-6"
TOTAL AREA: 28.0 Sq.Ft.

BORDER TYPE: FLUSH
RECESS: 0"
WIDTH: 0.75"
RADII: 2.25"

NO. Z BARS: _____
LENGTH: _____

MAT'L: 0.125" (3.2 mm) ALUMINUM

USE NOTES:
1. Legend and border shall be direct applied Grade C sheeting.
2. Background shall be Grade C reflective sheeting.
3. Arrow shall be on 0.032" aluminum, white Grade C reflective sheeting and demountable.

Panel Style: guide_con_circular.ssi
M.U.T.C.D.: 2009 Edition
Spacing Factor is 1 unless specified otherwise

LETTER POSITIONS

Letter spacings are to start of next letter

	D	D	C	C									Series/Size Text Length	
46.6	5.4	5.3	5.3	4.1	29.4								D 2000 20	
23.4	D	a	v	i	d	s	o	n	C	a	m	p	u	s
12.1	C	a	m	p	u	s	R	d					D 2000 53.8	

FILENAME: DCCC Signing
NORTH CAROLINA D.O.T. SIGN DETAIL

SIGN NUMBER: 106 FUTURE TYPE: B	BACKG COLOR: GREEN COPY COLOR: WHITE	DESIGN BY: PGPADILLA PROJECT ID: R-5737	CHECKED BY: JT Brooks LOCATION: DAVIDSON CO.	Feb 26, 2021 DIV: 9
------------------------------------	---	--	---	------------------------

SYMBOL	X	Y	WID	HT
AR_FISHOOK	13.7	15.6	10.1	10.8
AR_Type D	81	4.2	6	9

QUANTITY: 1
SIGN WIDTH: 8'-0"
HEIGHT: 3'-6"
TOTAL AREA: 28.0 Sq.Ft.

BORDER TYPE: FLUSH
RECESS: 0"
WIDTH: 0.75"
RADII: 2.25"

NO. Z BARS: _____
LENGTH: _____

MAT'L: 0.125" (3.2 mm) ALUMINUM

USE NOTES:
1. Legend and border shall be direct applied Grade C sheeting.
2. Background shall be Grade C reflective sheeting.
3. Arrow shall be .032" aluminum, white Grade C reflective sheeting and demountable.

Panel Style: guide_con_circular.ssi
M.U.T.C.D.: 2009 Edition
Spacing Factor is 1 unless specified otherwise

LETTER POSITIONS

Letter spacings are to start of next letter

	D	D	C	C									Series/Size Text Length	
38	5.4	5.3	5.3	4.1	38								D 2000 20	
32.8	L	i	n	k	C	a	m	p	u	s			D 2000 49.5	
6	D	a	v	i	d	s	o	n	C	a	m	p	u	s

FILENAME: DCCC Signing
NORTH CAROLINA D.O.T. SIGN DETAIL

SIGN NUMBER: 107 FUTURE TYPE: B	BACKG COLOR: GREEN COPY COLOR: WHITE	DESIGN BY: PGPADILLA PROJECT ID: R-5737	CHECKED BY: JT Brooks LOCATION: DAVIDSON CO.	Feb 26, 2021 DIV: 9
------------------------------------	---	--	---	------------------------

SYMBOL	X	Y	WID	HT
AR_FISHOOK	6	15.6	10.1	10.8
AR_Type D	71.3	4.2	6	9

QUANTITY: 1
SIGN WIDTH: 8'-0"
HEIGHT: 3'-6"
TOTAL AREA: 28.0 Sq.Ft.

BORDER TYPE: FLUSH
RECESS: 0"
WIDTH: 0.75"
RADII: 2.25"

NO. Z BARS: _____
LENGTH: _____

MAT'L: 0.125" (3.2 mm) ALUMINUM

USE NOTES:
1. Legend and border shall be direct applied Grade C sheeting.
2. Background shall be Grade C reflective sheeting.
3. Arrow shall be .032" aluminum, white Grade C reflective sheeting and demountable.

Panel Style: guide_con_circular.ssi
M.U.T.C.D.: 2009 Edition
Spacing Factor is 1 unless specified otherwise

LETTER POSITIONS

Letter spacings are to start of next letter

	D	D	C	C									Series/Size Text Length	
38	5.4	5.3	5.3	4.1	38								D 2000 20	
23.8	D	a	v	i	d	s	o	n	C	a	m	p	u	s
15.8	L	i	n	k	C	a	m	p	u	s			D 2000 49.5	



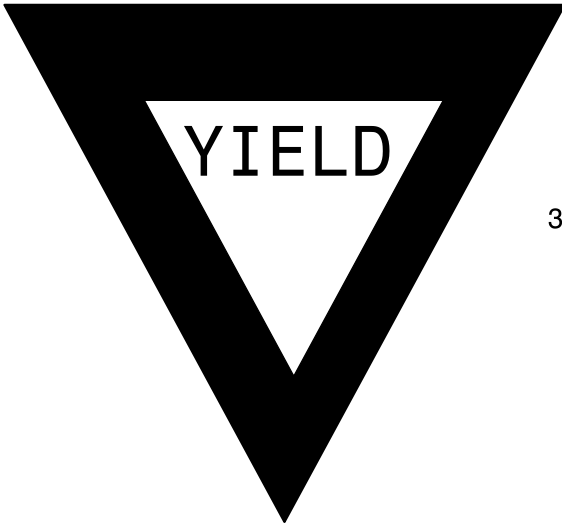









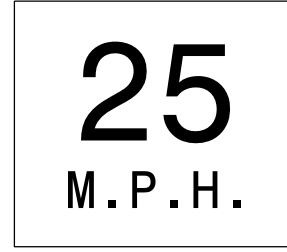
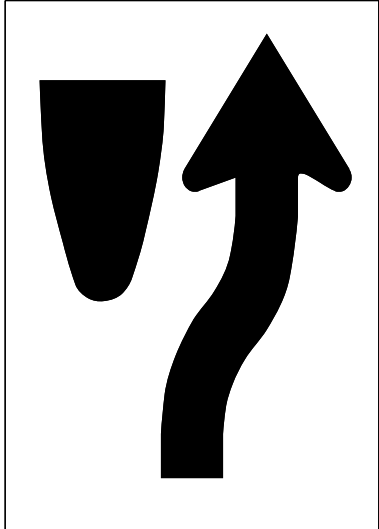

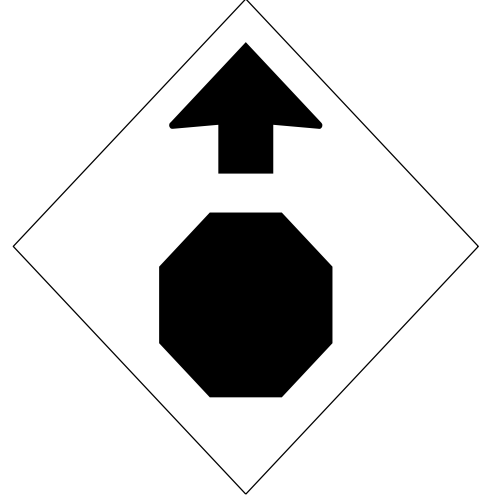
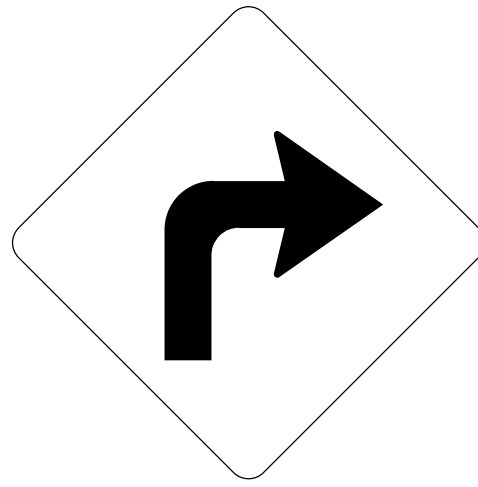
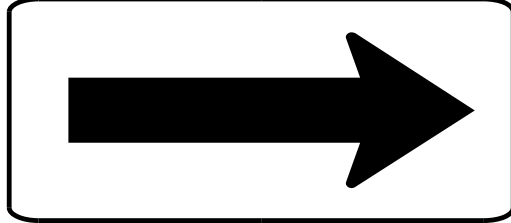
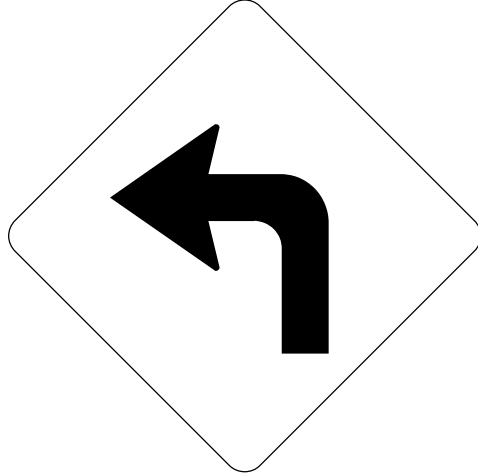




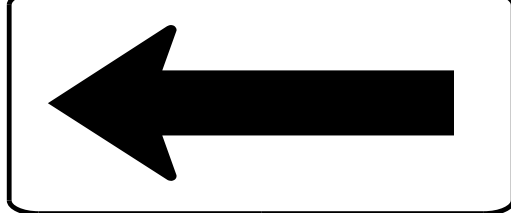
FILENAME: DCCC Signing
NORTH CAROLINA D.O.T. SIGN DETAIL


invold_expressing sheets 10737_Sign_3D.dgn USER: abes@ncors

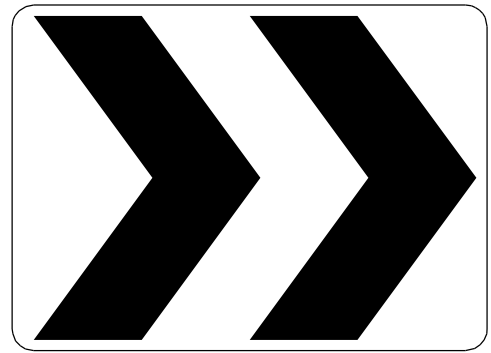

2610 WYCLIFF ROAD
SUITE 410
RALEIGH, NC 27607
PHONE: 919.881.9939
NC COA No. F-0929

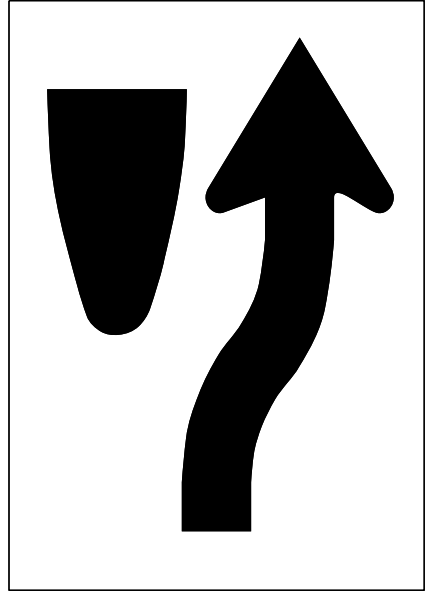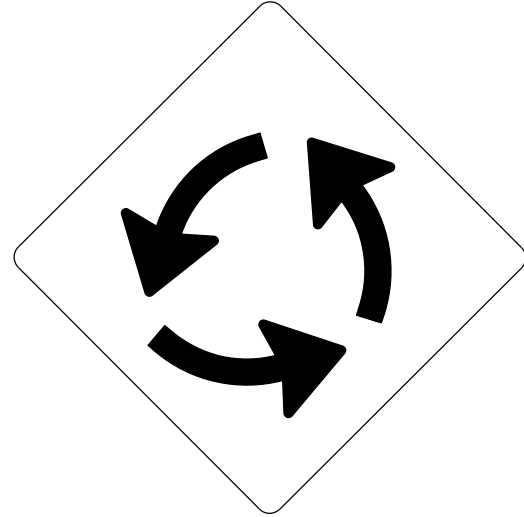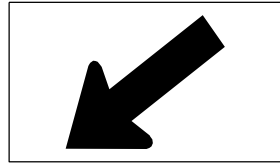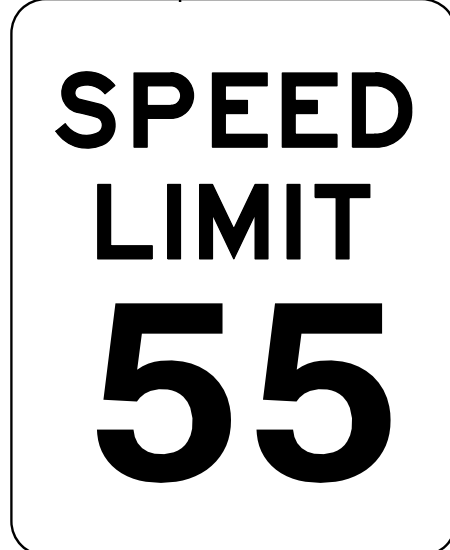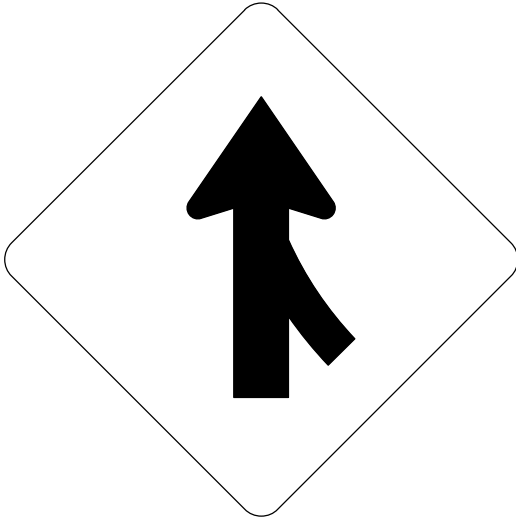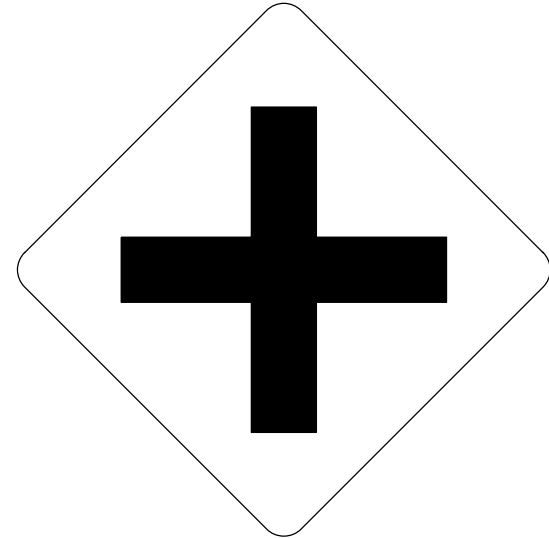SIGN DESIGNS
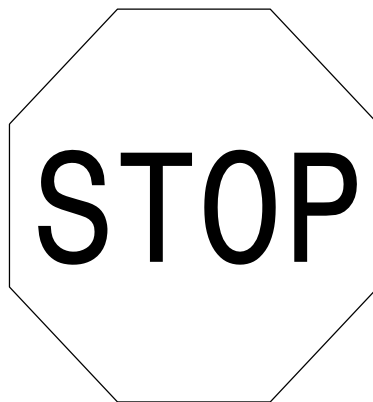
<p>401 QUANTITY REQ'D 10</p>  <p>30 X 24 R6-4</p> <p>ONE "U" POST PER SIGN</p>	<p>402 QUANTITY REQ'D 6</p>  <p>36 X 24 R5-1a</p> <p>ONE "U" POST PER SIGN</p>	<p>403 QUANTITY REQ'D 12</p>  <p>36 X 36 X 36 R1-2</p> <p>ONE "U" POST PER SIGN</p>	<p>404 QUANTITY REQ'D 5</p>  <p>30 X 30 R5-1</p> <p>ONE "U" POST PER SIGN</p>	<p>405 QUANTITY REQ'D 4</p>  <p>30 X 30 W11-2</p> <p>FLUORESCENT YELLOW/GREEN REFLECTIVE SHEETING</p> <p>ONE "U" POST PER SIGN</p>	<p>406 QUANTITY REQ'D 1</p>  <p>24 X 30 R4-7R</p> <p>ONE "U" POST PER SIGN</p>
<p>407 QUANTITY REQ'D 5</p>  <p>30 X 30 W2-6</p> <p>ONE "U" POST PER SIGN</p>	<p>408 QUANTITY REQ'D 4</p>  <p>24 X 12 W16-7</p> <p>FLUORESCENT YELLOW/GREEN REFLECTIVE SHEETING</p> <p>MOUNT BELOW SIGN 405 IN 4 INSTALLATIONS</p>	<p>409 QUANTITY REQ'D 2</p>  <p>36 X 48 R2-1</p> <p>TWO "U" POSTS PER SIGN</p>	<p>410 QUANTITY REQ'D 4</p>  <p>36 X 36 W4-1</p> <p>MOUNTED ON ONE "U" POST PER SIGN IN 2 INSTALLMENTS MOUNTED ON CONCRETE BARRIER PER RSD NO. 903.40 IN 2 INSTALLMENTS</p>	<p>411 QUANTITY REQ'D 1</p>  <p>36 X 36 W2-1</p> <p>ONE "U" POST PER SIGN</p>	<p>412 QUANTITY REQ'D 2</p>  <p>54 X 18 R6-1L</p> <p>TWO "U" POSTS PER SIGN</p>
<p>413 QUANTITY REQ'D 2</p>  <p>24 X 24 W13-1P</p> <p>MOUNTED BELOW SIGNS 417 & 419 IN 2 INSTALLATIONS</p>	<p>414 QUANTITY REQ'D 1</p>  <p>36 X 48 R4-7R</p> <p>TWO "U" POSTS PER SIGN</p>	<p>415 QUANTITY REQ'D 2</p>  <p>36 X 36 W42-7</p> <p>ONE "U" POST PER SIGN</p>	<p>416 QUANTITY REQ'D 1</p>  <p>30 X 30 W3-1</p> <p>ONE "U" POST PER SIGN</p>	<p>417 QUANTITY REQ'D 2</p>  <p>30 X 30 W1-1R</p> <p>ONE "U" POST PER SIGN</p>	<p>418 QUANTITY REQ'D 2</p>  <p>48 X 24 W1-6R</p> <p>TWO "U" POSTS PER SIGN</p>
<p>419 QUANTITY REQ'D 1</p>  <p>30 X 30 W1-1L</p> <p>ONE "U" POST PER SIGN</p>	<p>420 QUANTITY REQ'D 2</p>  <p>36 X 12 R6-1 (R)</p> <p>ONE "U" POST PER SIGN</p>	<p>421 QUANTITY REQ'D 2</p>  <p>36 X 12 R6-1 (L)</p> <p>MOUNT BACK-TO-BACK WITH SIGN 420 IN 2 INSTALLATIONS</p>	<p>422 QUANTITY REQ'D 2</p>  <p>36 X 36 R1-1</p> <p>MOUNT BELOW SIGN 420 IN 2 INSTALLATIONS</p>	<p>423 QUANTITY REQ'D 6</p>  <p>24 X 24 W13-1P</p> <p>MOUNTED BELOW SIGN 417 IN 1 INSTALLATION. MOUNTED BELOW SIGN 407 IN 5 INSTALLATIONS.</p>	<p>424 QUANTITY REQ'D 1</p>  <p>48 X 24 W1-6L</p> <p>TWO "U" POSTS PER SIGN</p>

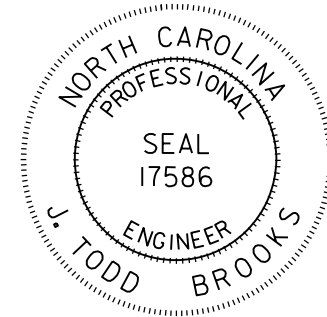TIP NO. R-5737	SHEET NO. SIGN - 3E
APPROVED: _____	
DATE: _____	
SEAL	
	
DOCUMENT NOT CONSIDERED FINAL UNLESS ALL SIGNATURES COMPLETED	

inv\old_express\signs\sheet\10737_Sign_3E.dgn
 USER: abeshears



2610 WYCLIFF ROAD
 SUITE 410
 RALEIGH, NC 27607
 PHONE: 919.881.9939
 NC COA No. F-0929

TYPE E SIGNS

501 505

M4-5
24" x 12"

M1-4
2 - 24" x 24"

M5-3
21" x 15"

ONE "U" POST PER ASSEMBLY

502

M3-3
24" x 12"

M1-4
24" x 24"

M3-4
24" x 12"

M1-4
24" x 24"

M6-2
21" x 15"

ONE "U" POST PER ASSEMBLY

503

M4-5
24" x 12"

M1-4
24" x 24"

M1-4
24" x 24"

M6-2
21" x 15"

ONE "U" POST PER ASSEMBLY

504

M4-5
24" x 12"

M1-4
24" x 24"

M1-4
24" x 24"

M6-1
21" x 15"

ONE "U" POST PER ASSEMBLY

506

M4-5
24" x 12"

M1-4
24" x 24"

M1-4
24" x 24"

M5-3
21" x 15"

ONE "U" POST PER ASSEMBLY

507

M3-1
24" x 12"

M1-4
24" x 24"

M3-2
24" x 12"

M1-4
24" x 24"

M6-2
21" x 15"

ONE "U" POST PER ASSEMBLY

APPROVED: _____

DATE: _____

SEAL

DOCUMENT NOT CONSIDERED FINAL
UNLESS ALL SIGNATURES COMPLETED

508

M3-3/M3-1
24" x 12"

M1-4
24" x 24"

M3-4/M3-2
24" x 12"

M1-4
24" x 24"

M5-3/M6-1
21" x 15"

TWO "U" POSTS PER ASSEMBLY

509

M3-3/M3-1
24" x 12"

M1-4
24" x 24"

M3-4/M3-2
24" x 12"

M1-4
24" x 24"

M5-3/M6-1
21" x 15"

TWO "U" POSTS PER ASSEMBLY

510

M3-3/M3-2
36" x 18"

M1-4
2-36" x 36"

TWO "U" POSTS PER ASSEMBLY

511

M3-3/M3-4
36" x 18"

M1-4
2-36" x 36"

TWO "U" POSTS PER ASSEMBLY

inv\old_express\signsheets\R5737_Sign_3F.dgn
 USER: abeshears




2610 WYCLIFF ROAD
SUITE 410
RALEIGH, NC 27607
PHONE: 919.881.9939
NC COA No. F-0929



TYPE F SIGNS

APPROVED: _____

DATE: _____

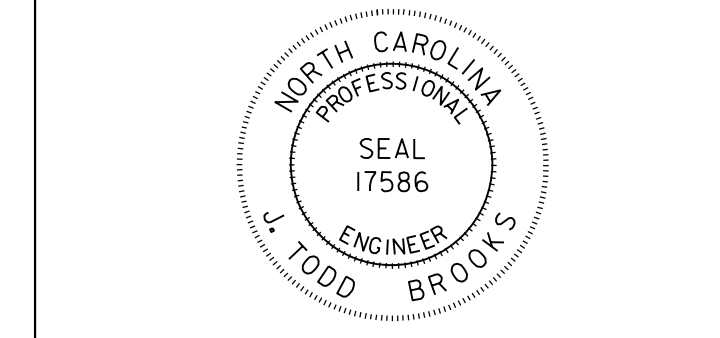

**DOCUMENT NOT CONSIDERED FINAL
UNLESS ALL SIGNATURES COMPLETED**

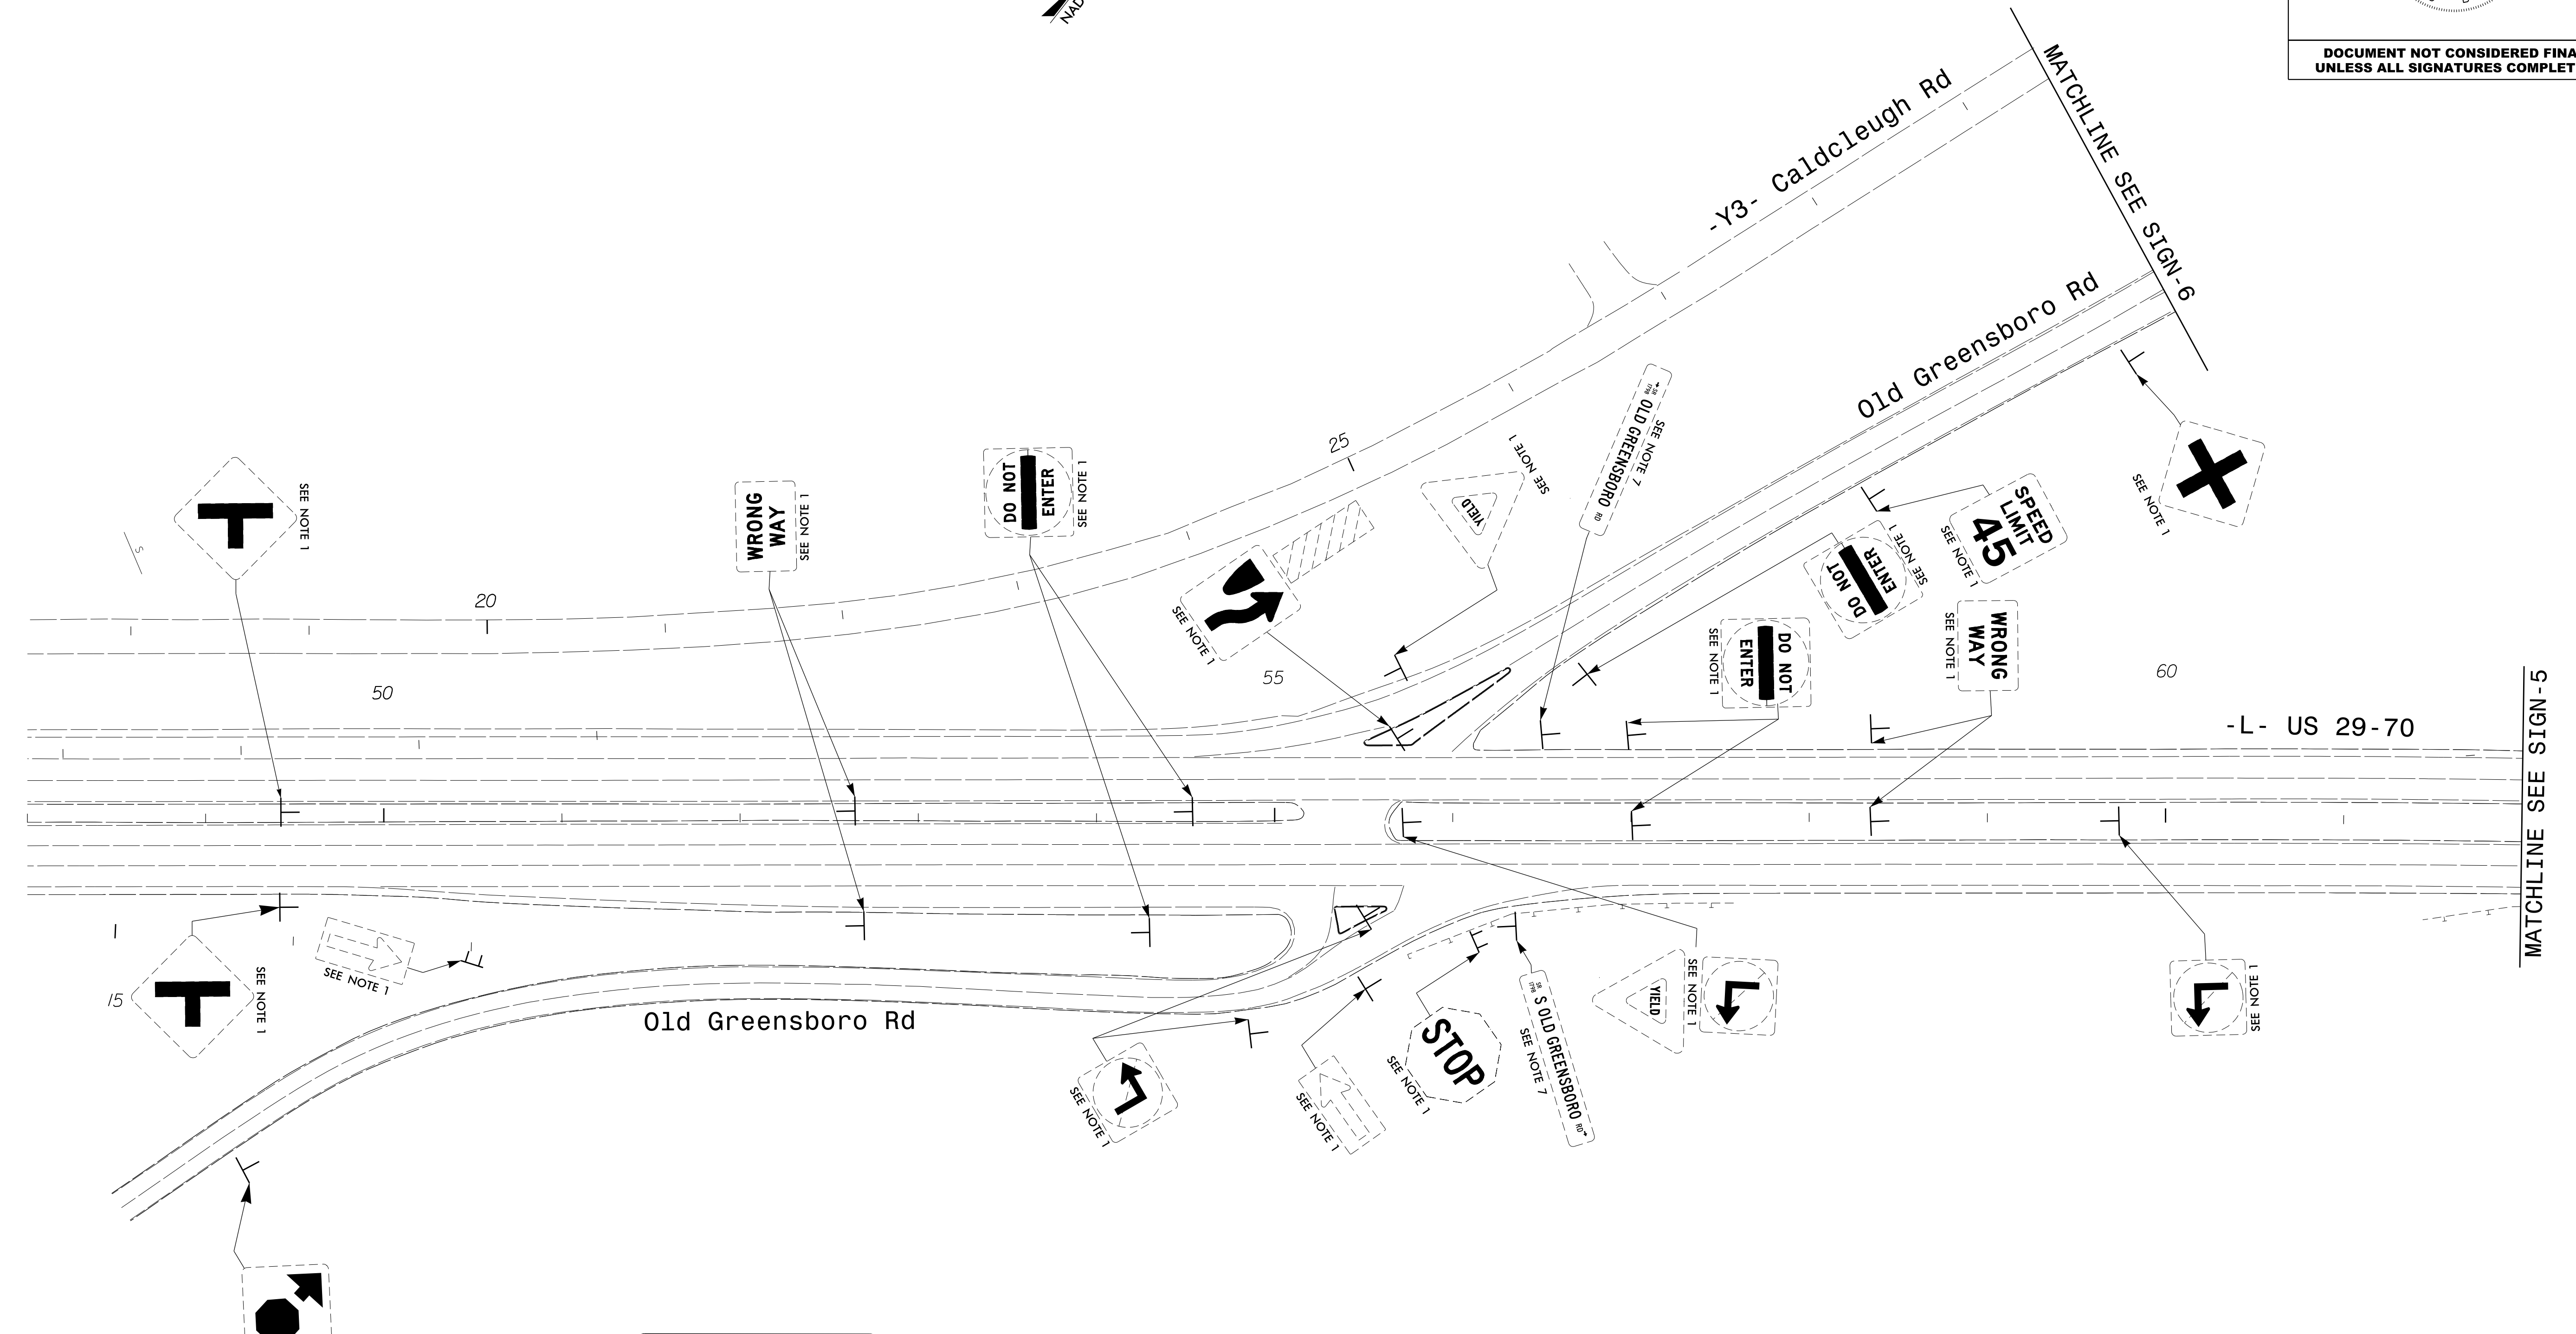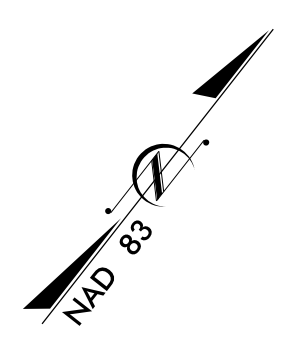

- PAY ITEM NOTES**
1. DISPOSAL OF SIGN SYSTEM, U-CHANNEL
 2. DISPOSAL OF SIGN SYSTEM, WOOD
 3. SIGN ERECTION, TYPE A (GROUND MOUNTED)
 4. SIGN ERECTION, TYPE B (GROUND MOUNTED)
 5. SIGN ERECTION, TYPE D, E, AND F
 6. SUPPORTS, BARRIER MOUNTED, SMALL
 7. STREET NAME SIGN SYSTEM TO BE REMOVED/RELOCATED BY OTHERS
 8. WAYFINDING SIGN SYSTEM TO BE REMOVED/RELOCATED BY OTHERS



2610 WYCLIFF ROAD
SUITE 410
RALEIGH, NC 27607
PHONE: 919.881.9339
NC COA No. P-0929


EXISTING SIGNS

inv:\old_express\gg\projects\10737_Sign_4.dgn
 USER: abesha@ors



APPROVED: _____

DATE: _____

SEAL

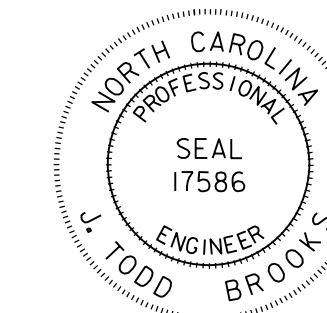

**DOCUMENT NOT CONSIDERED FINAL
UNLESS ALL SIGNATURES COMPLETED**

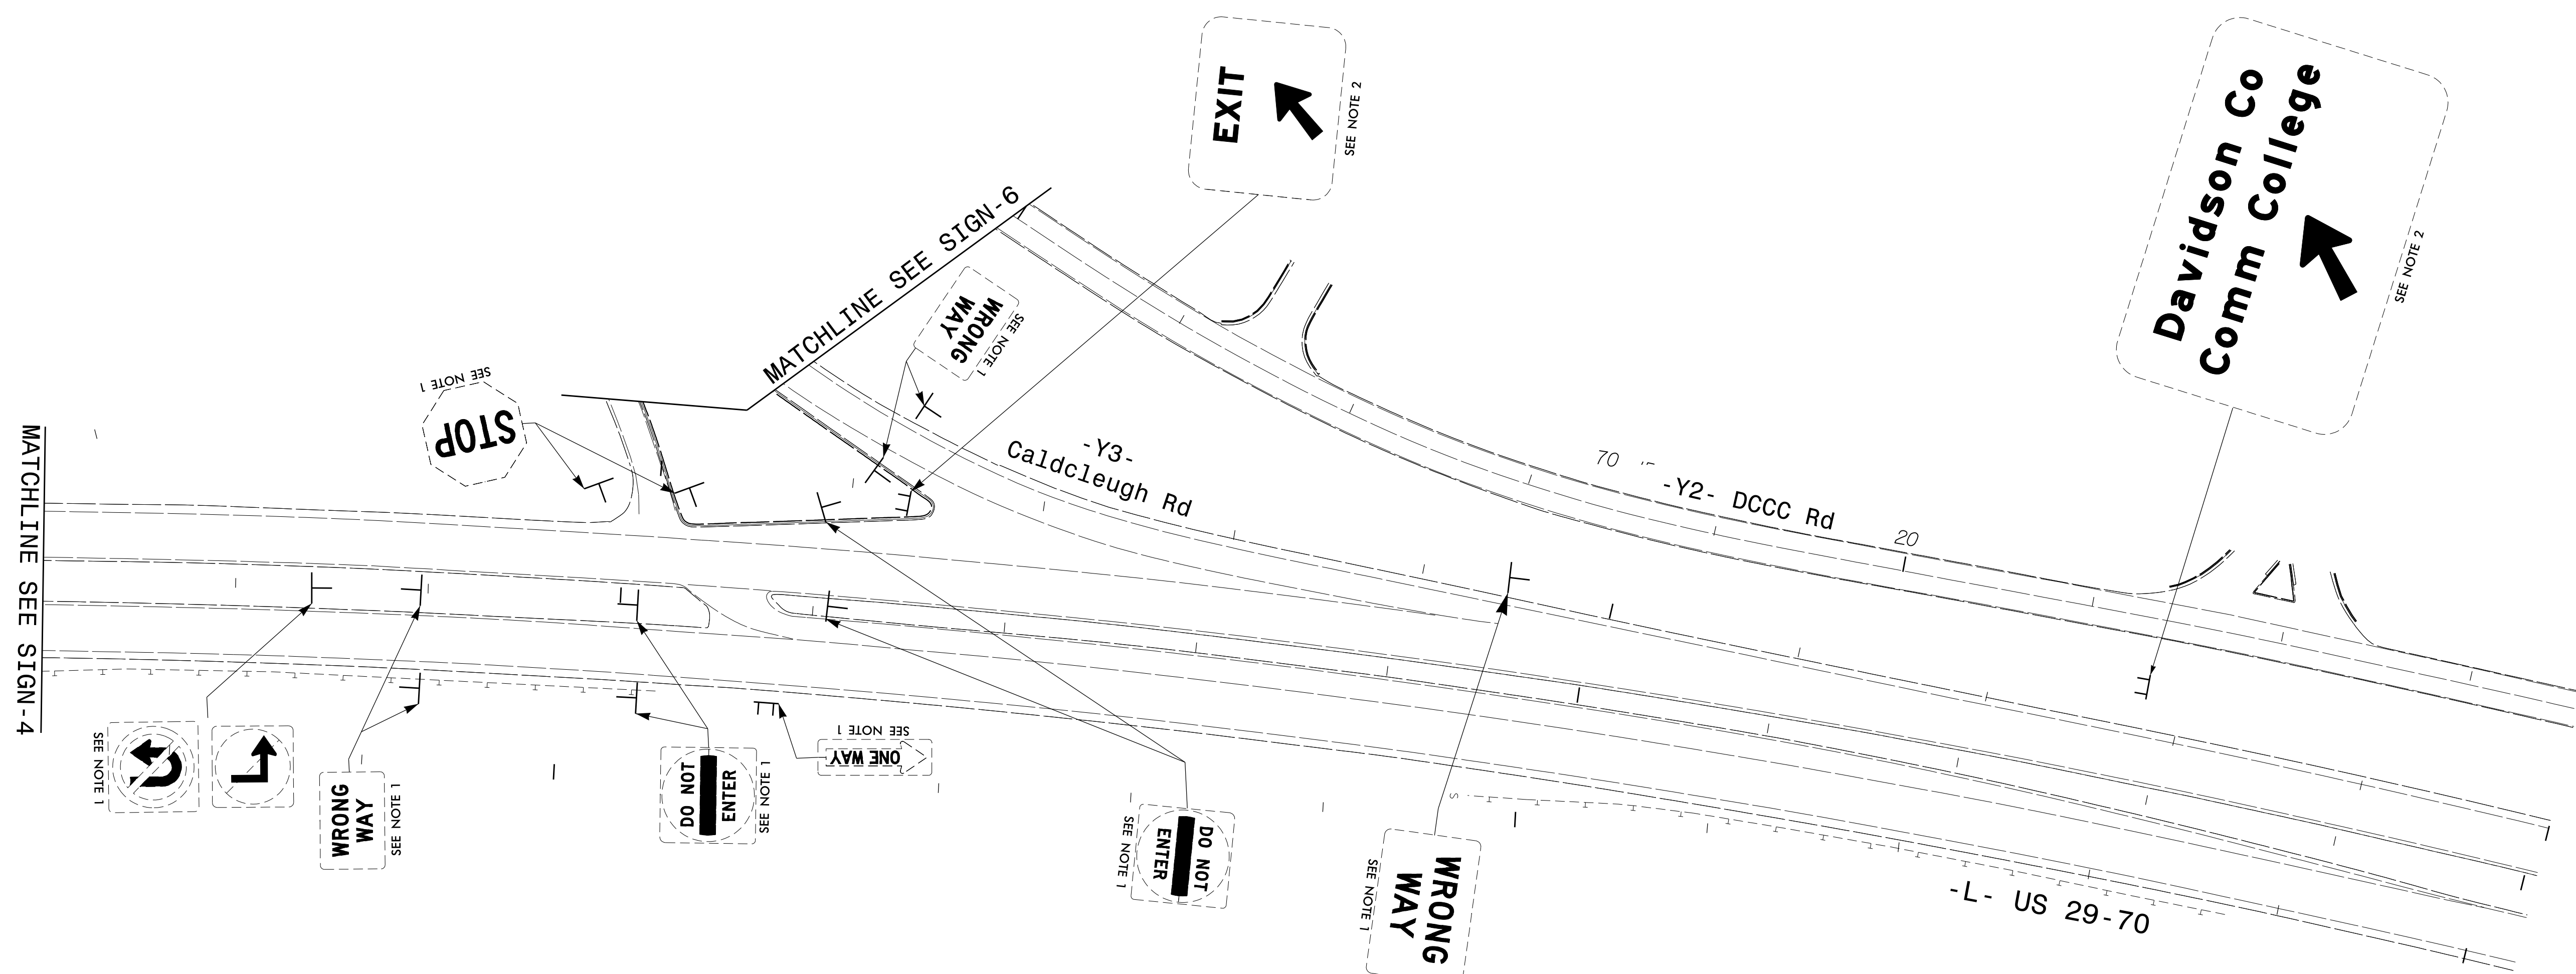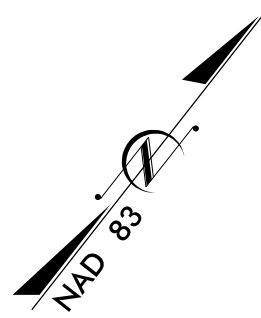

- PAY ITEM NOTES**
1. DISPOSAL OF SIGN SYSTEM, U-CHANNEL
 2. DISPOSAL OF SIGN SYSTEM, WOOD
 3. SIGN ERECTION, TYPE A (GROUND MOUNTED)
 4. SIGN ERECTION, TYPE B (GROUND MOUNTED)
 5. SIGN ERECTION, TYPE D, E, AND F
 6. SUPPORTS, BARRIER MOUNTED, SMALL
 7. STREET NAME SIGN SYSTEM TO BE REMOVED/RELOCATED BY OTHERS
 8. WAYFINDING SIGN SYSTEM TO BE REMOVED/RELOCATED BY OTHERS



2610 WYCLIFF ROAD
SUITE 410
RALEIGH, NC 27607
PHONE: 919.881.9939
NC COA No. F-0929


EXISTING SIGNS

inv\old_express\gg...737_Sign_5.dgn
 USER: abesha@ars

APPROVED: _____


DATE: _____

SEAL

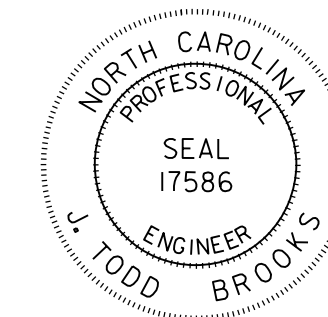

**DOCUMENT NOT CONSIDERED FINAL
UNLESS ALL SIGNATURES COMPLETED**

- PAY ITEM NOTES**
1. DISPOSAL OF SIGN SYSTEM, U-CHANNEL
 2. DISPOSAL OF SIGN SYSTEM, WOOD
 3. SIGN ERECTION, TYPE A (GROUND MOUNTED)
 4. SIGN ERECTION, TYPE B (GROUND MOUNTED)
 5. SIGN ERECTION, TYPE D, E, AND F
 6. SUPPORTS, BARRIER MOUNTED, SMALL
 7. STREET NAME SIGN SYSTEM TO BE REMOVED/RELOCATED BY OTHERS
 8. WAYFINDING SIGN SYSTEM TO BE REMOVED/RELOCATED BY OTHERS

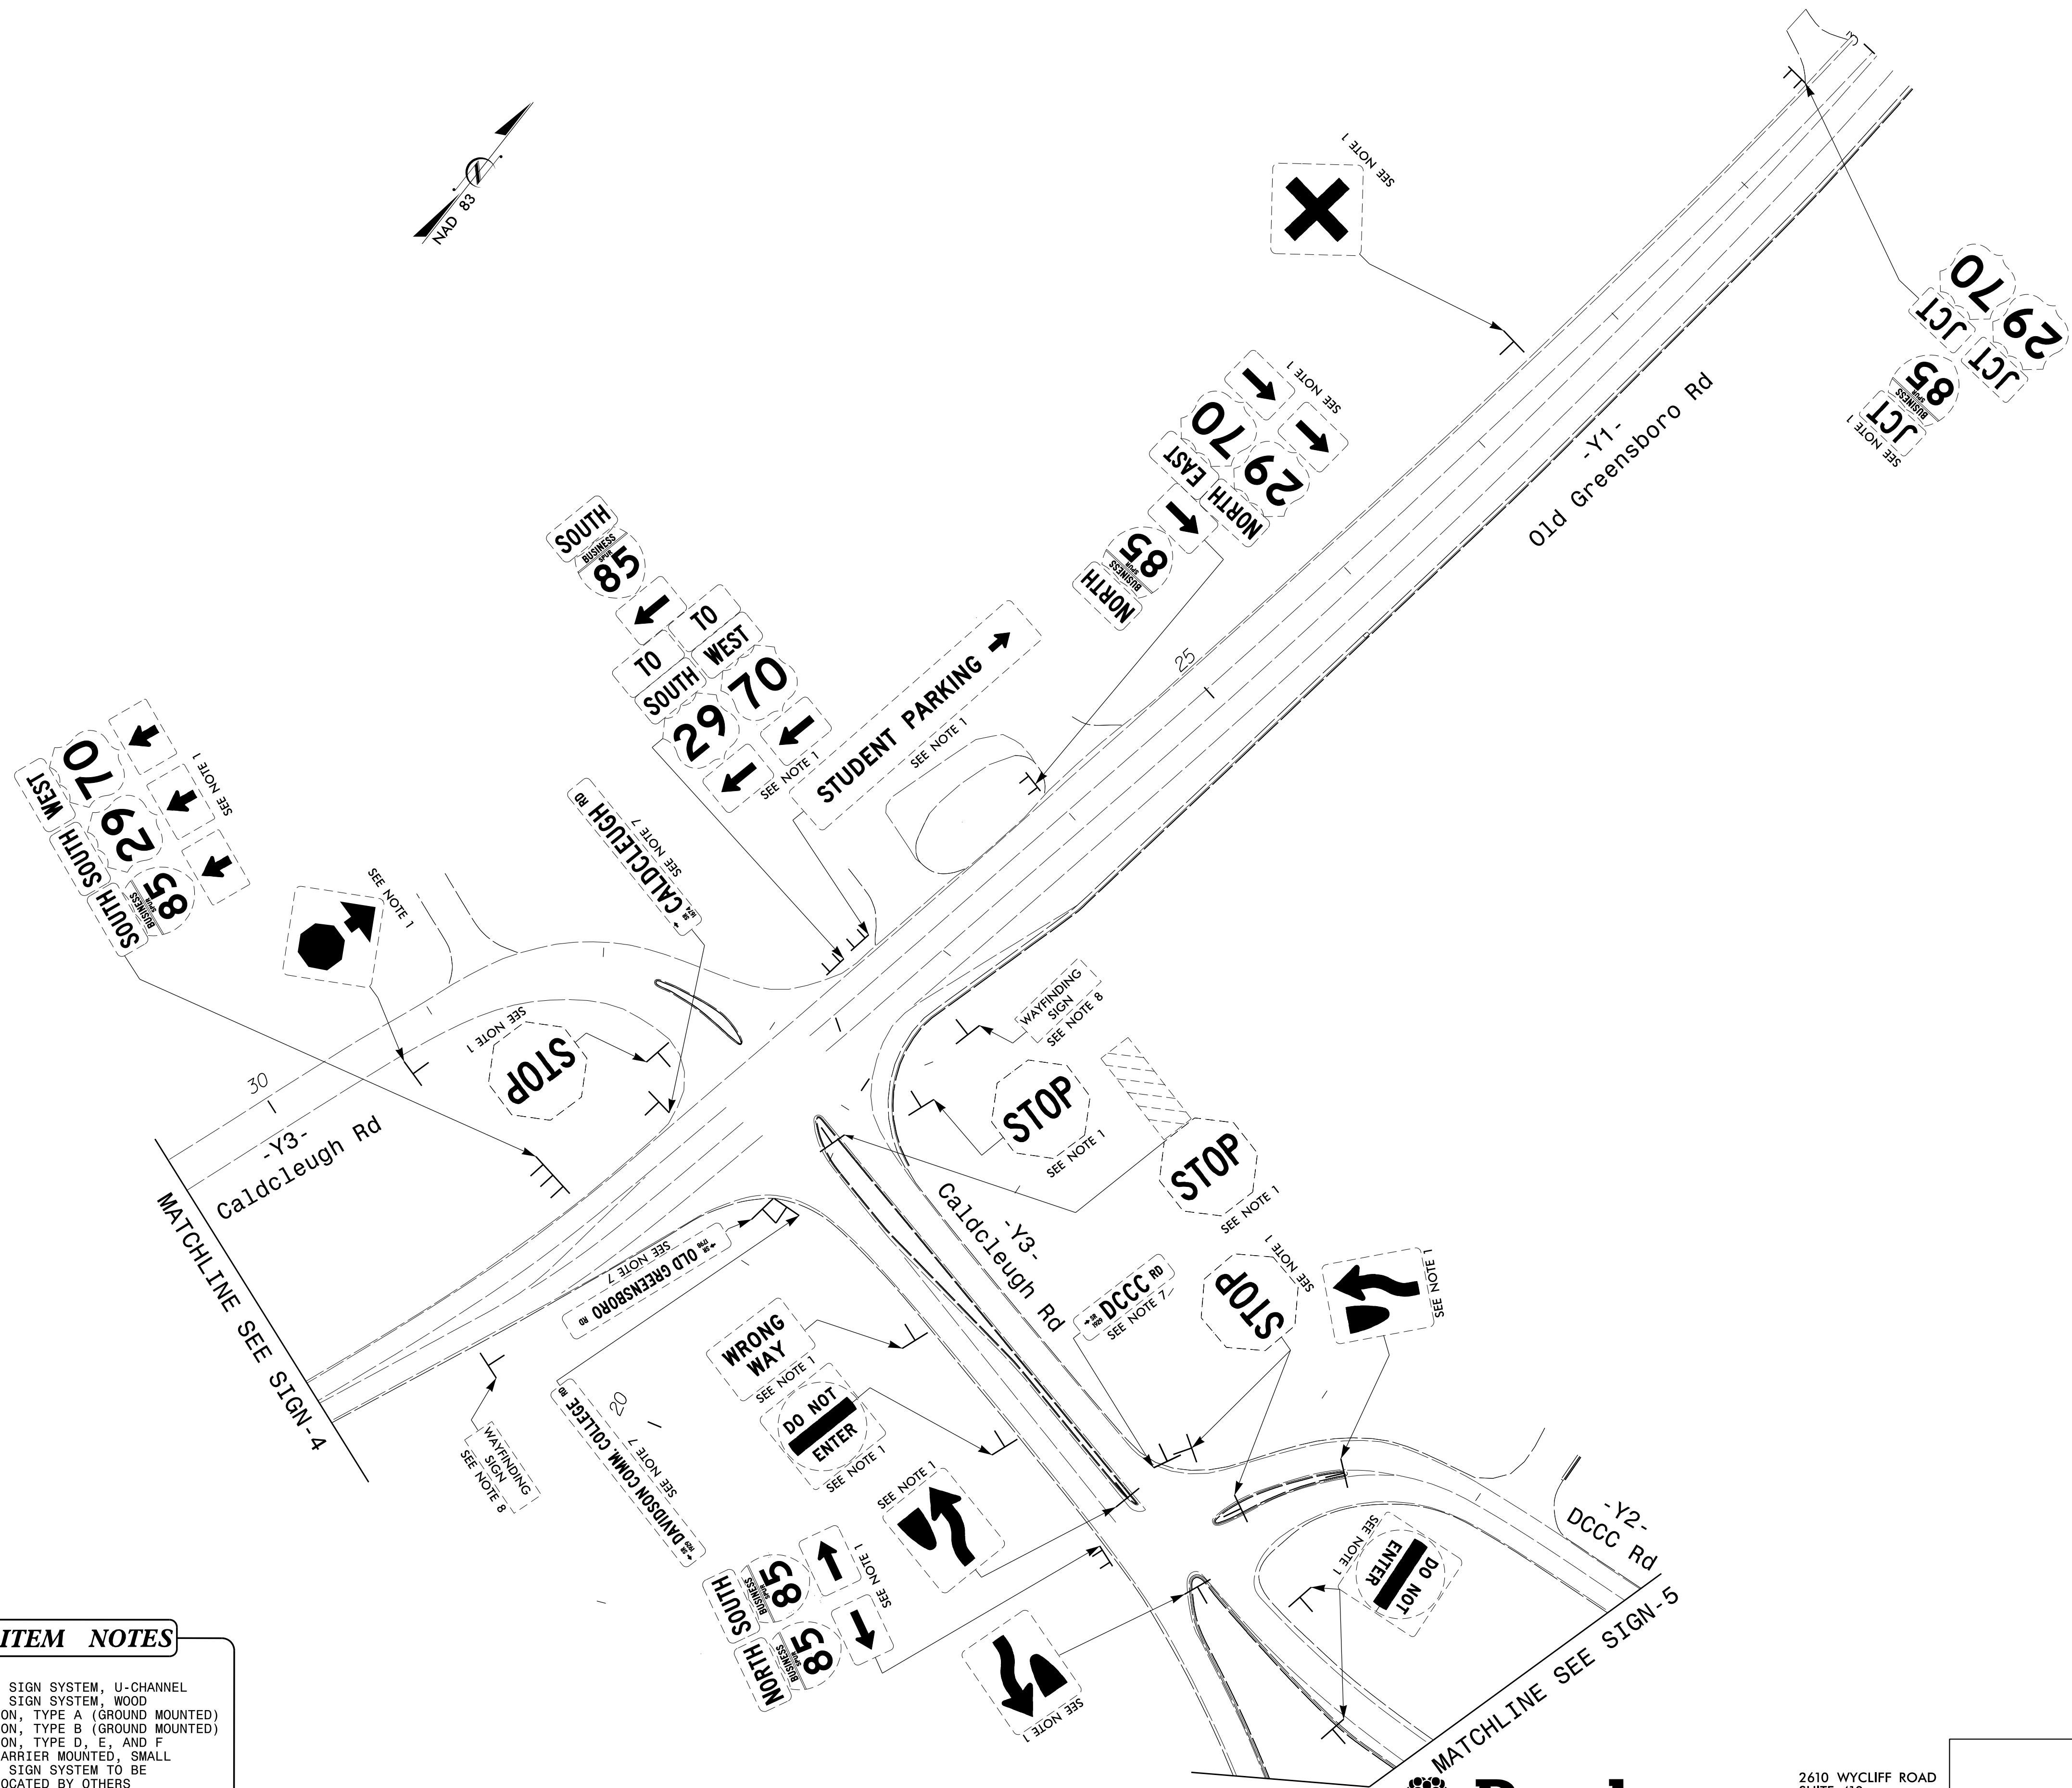

2410 WYCLIFF ROAD
SUITE 410
RALEIGH, NC 27607
PHONE: 919.881.9939
NC COA No. F-0929


EXISTING SIGNS

inv\old_express\gg\737_Sign_6.dgn
 USER: abeshears



APPROVED: _____

DATE: _____

SEAL

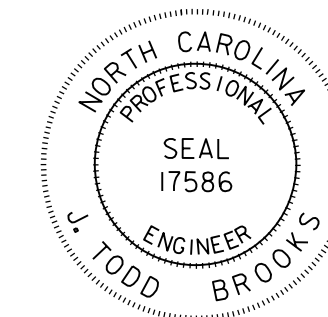

**DOCUMENT NOT CONSIDERED FINAL
UNLESS ALL SIGNATURES COMPLETED**

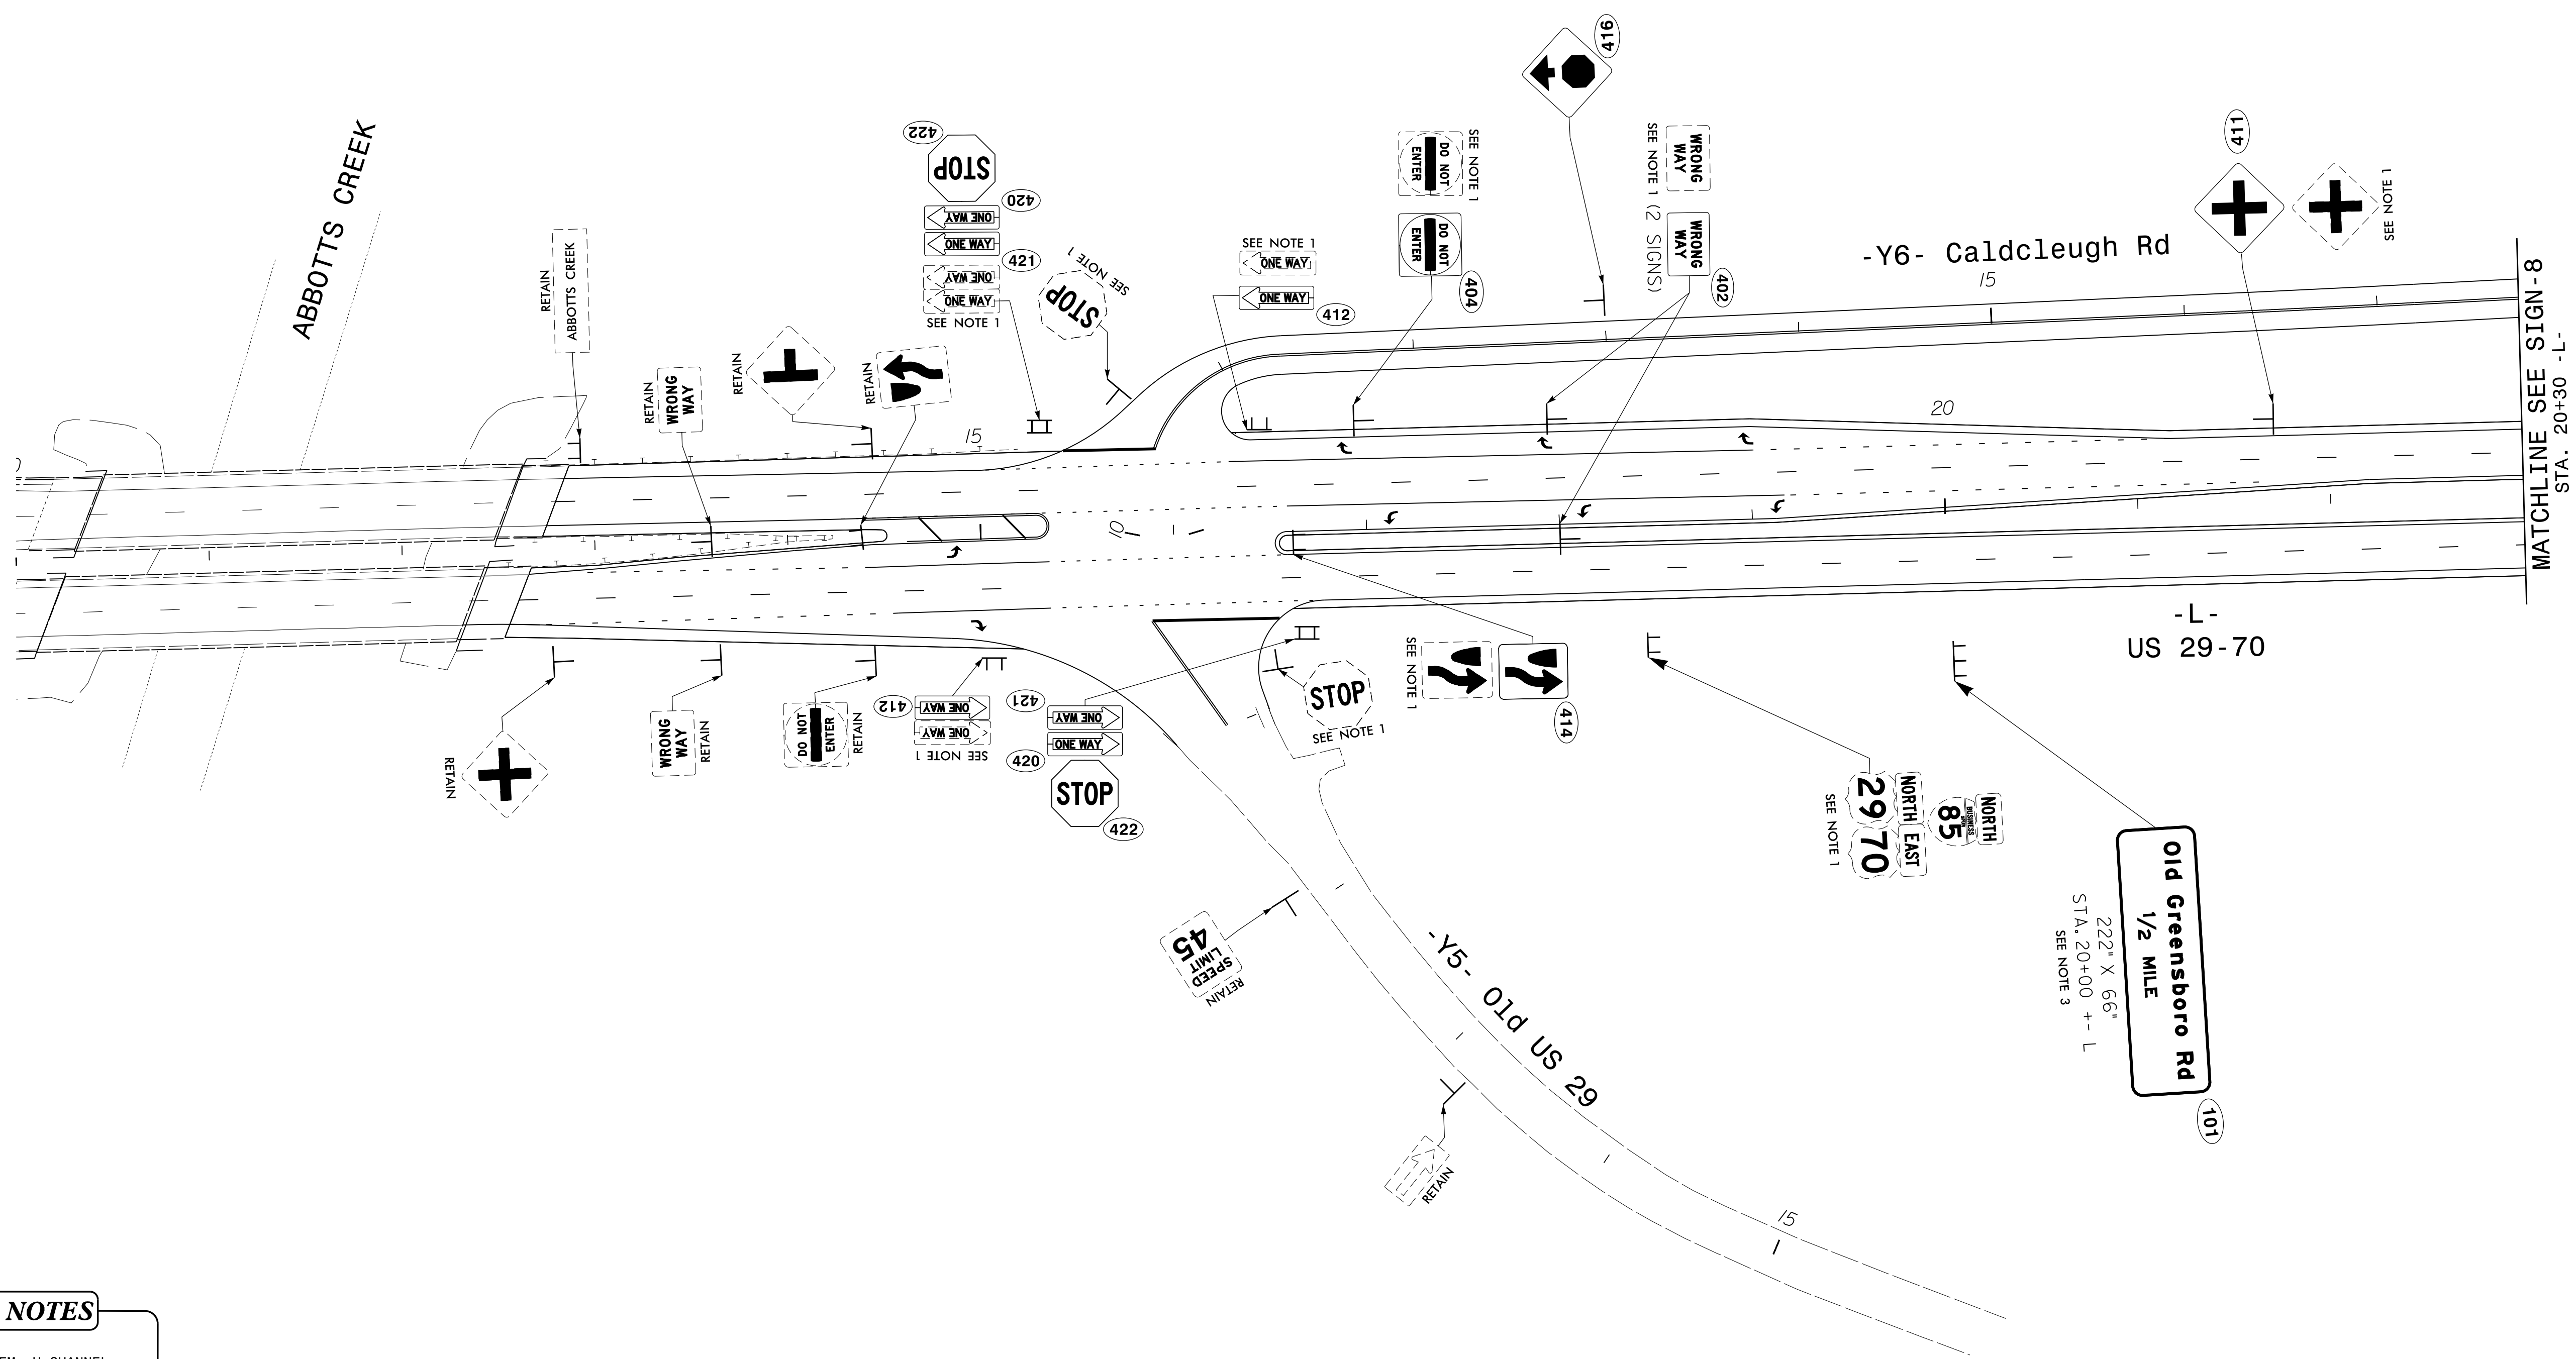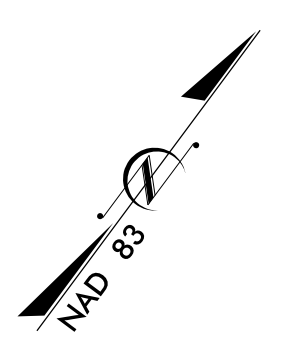

PAY ITEM NOTES




1. DISPOSAL OF SIGN SYSTEM, U-CHANNEL
2. DISPOSAL OF SIGN SYSTEM, WOOD
3. SIGN ERECTION, TYPE A (GROUND MOUNTED)
4. SIGN ERECTION, TYPE B (GROUND MOUNTED)
5. SIGN ERECTION, TYPE D, E, AND F
6. SUPPORTS, BARRIER MOUNTED, SMALL
7. STREET NAME SIGN SYSTEM TO BE REMOVED/RELOCATED BY OTHERS
8. WAYFINDING SIGN SYSTEM TO BE REMOVED/RELOCATED BY OTHERS

invold_expressign
 users\jbs\737_Sign_7.dgn
 USER: jbs\737



2610 WYCLIFF ROAD
 SUITE 410
 RALEIGH, NC 27607
 PHONE: 919.881.9939
 NC COA No. F-0929

**EXISTING &
 PROPOSED SIGNS**
 -L- STA. 10+00 TO 23+00

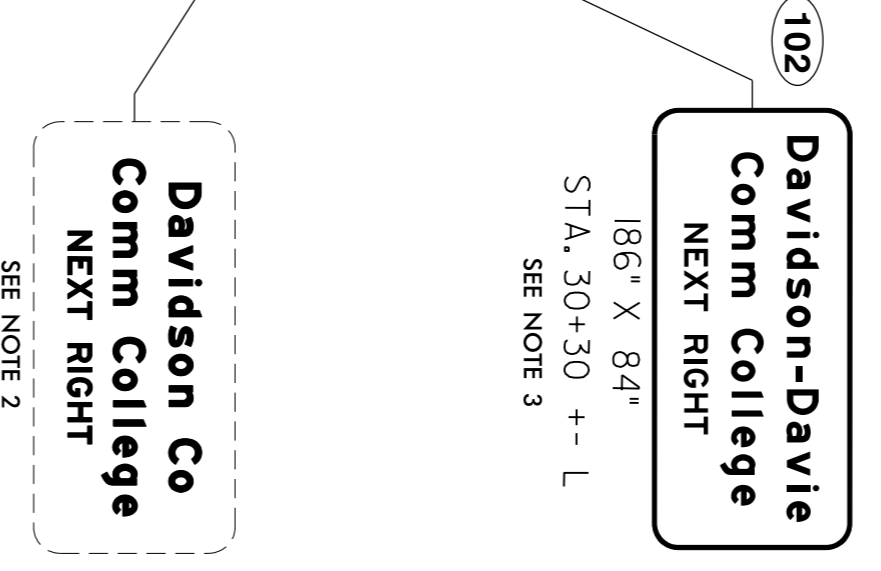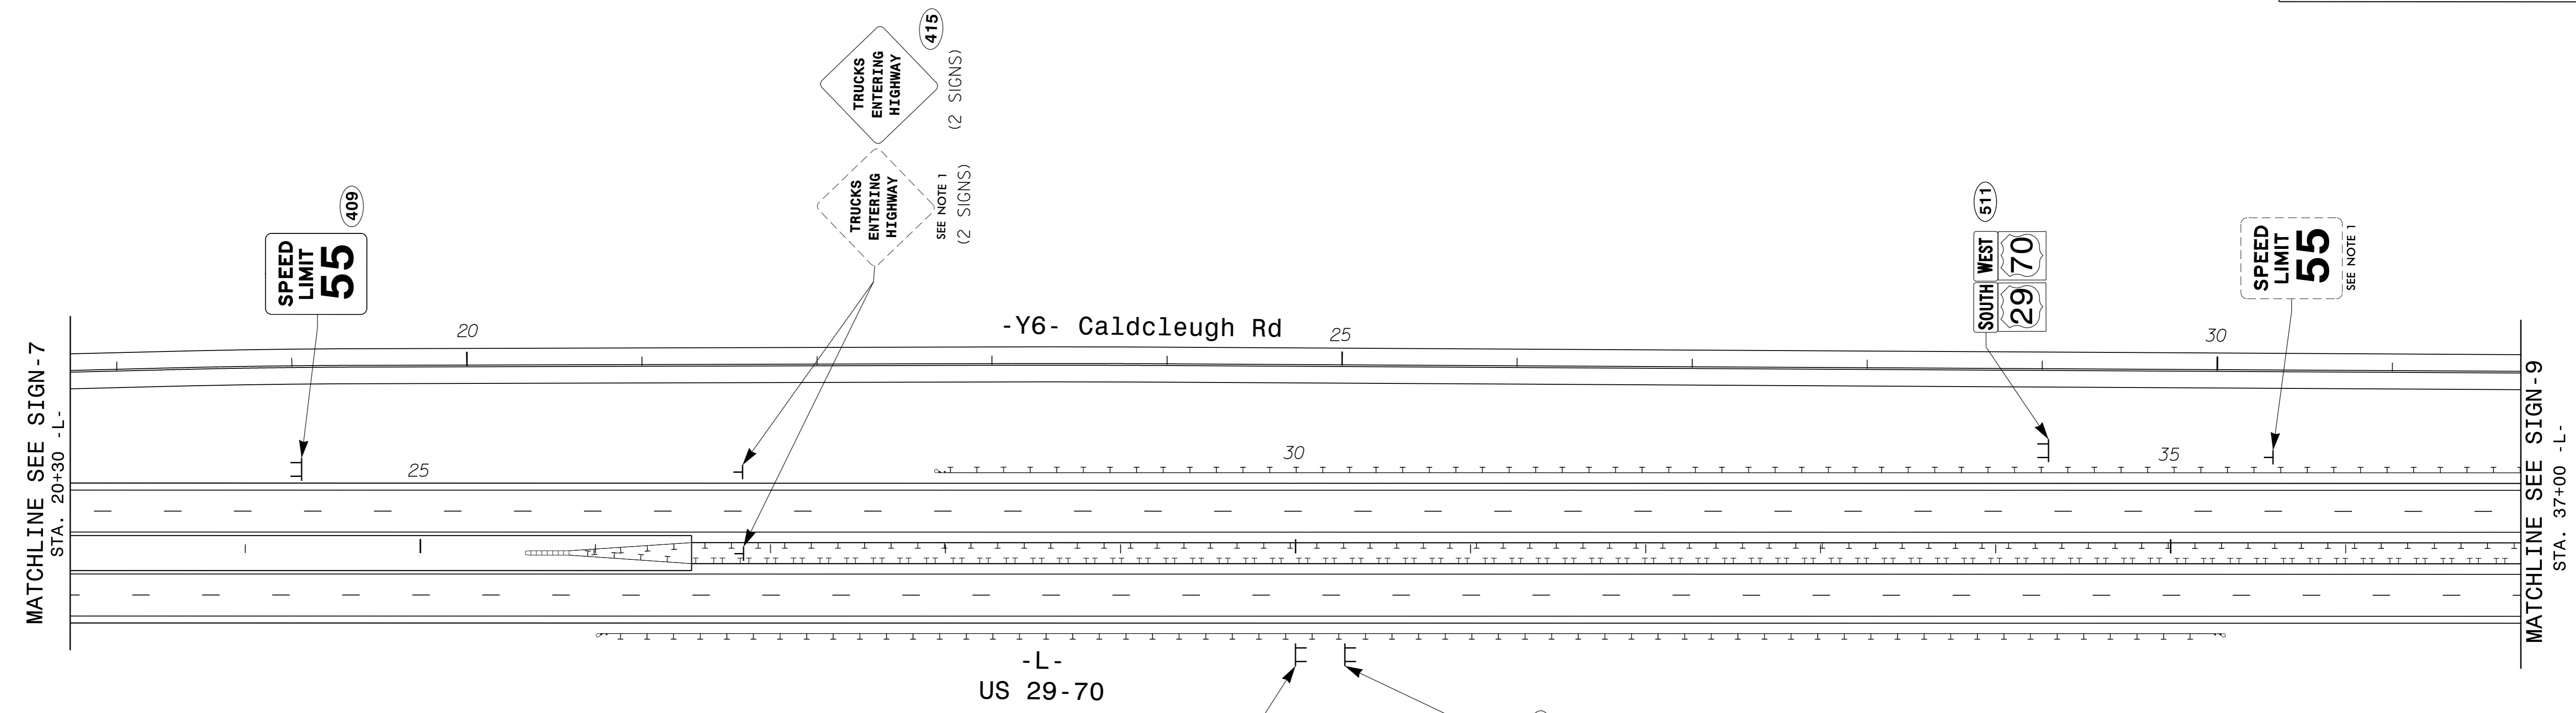
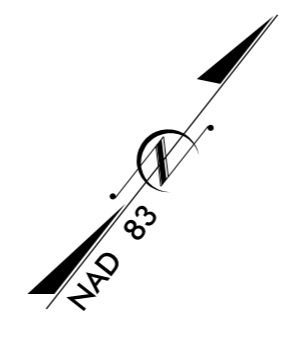


- PAY ITEM NOTES**
1. DISPOSAL OF SIGN SYSTEM, U-CHANNEL
 2. DISPOSAL OF SIGN SYSTEM, WOOD
 3. SIGN ERECTION, TYPE A (GROUND MOUNTED)
 4. SIGN ERECTION, TYPE B (GROUND MOUNTED)
 5. SIGN ERECTION, TYPE D, E, AND F
 6. SUPPORTS, BARRIER MOUNTED, SMALL
 7. STREET NAME SIGN SYSTEM TO BE REMOVED/RELOCATED BY OTHERS
 8. WAYFINDING SIGN SYSTEM TO BE REMOVED/RELOCATED BY OTHERS

invp\jld_exp\express\gd\737_Sign_8.dgn
 USER: abeshears



**EXISTING &
PROPOSED SIGNS**
-L- STA. 23+00 TO 37+00

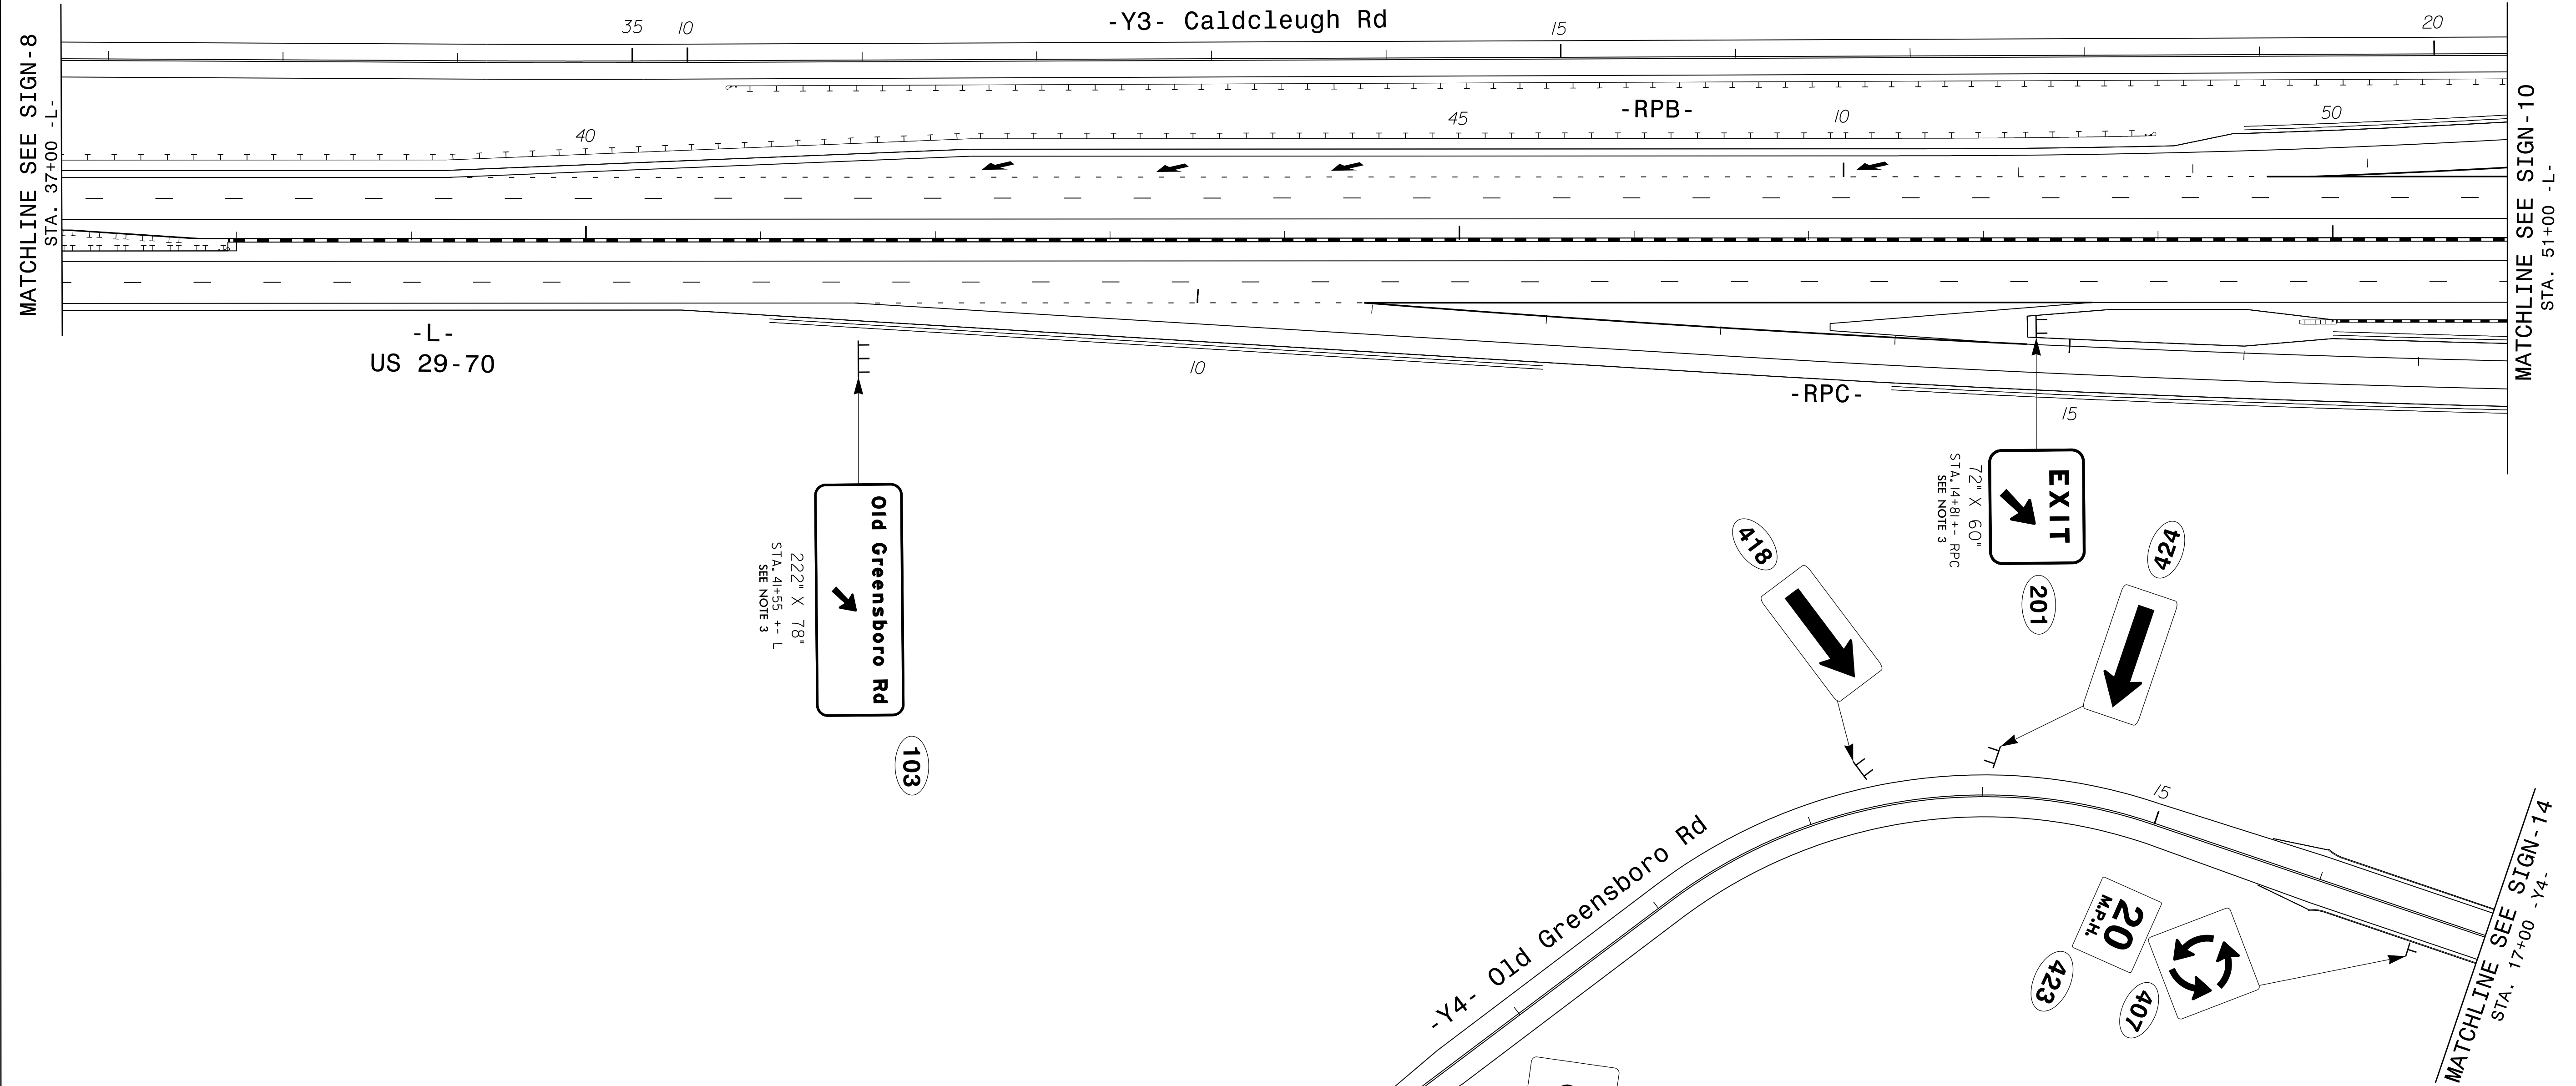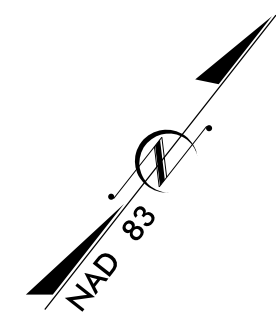


- PAY ITEM NOTES**
1. DISPOSAL OF SIGN SYSTEM, U-CHANNEL
 2. DISPOSAL OF SIGN SYSTEM, WOOD
 3. SIGN ERECTION, TYPE A (GROUND MOUNTED)
 4. SIGN ERECTION, TYPE B (GROUND MOUNTED)
 5. SIGN ERECTION, TYPE D, E, AND F
 6. SUPPORTS, BARRIER MOUNTED, SMALL
 7. STREET NAME SIGN SYSTEM TO BE REMOVED/RELOCATED BY OTHERS
 8. WAYFINDING SIGN SYSTEM TO BE REMOVED/RELOCATED BY OTHERS

invold_expressign
 c:\projects\10737_Sign_9.dgn
 USER: abeshears



2610 WYCLIFF ROAD
 SUITE 410
 RALEIGH, NC 27607
 PHONE: 919.881.9939
 NC COA No. F-0929

PROPOSED SIGNING
-L- STA. 37+00 TO 51+00

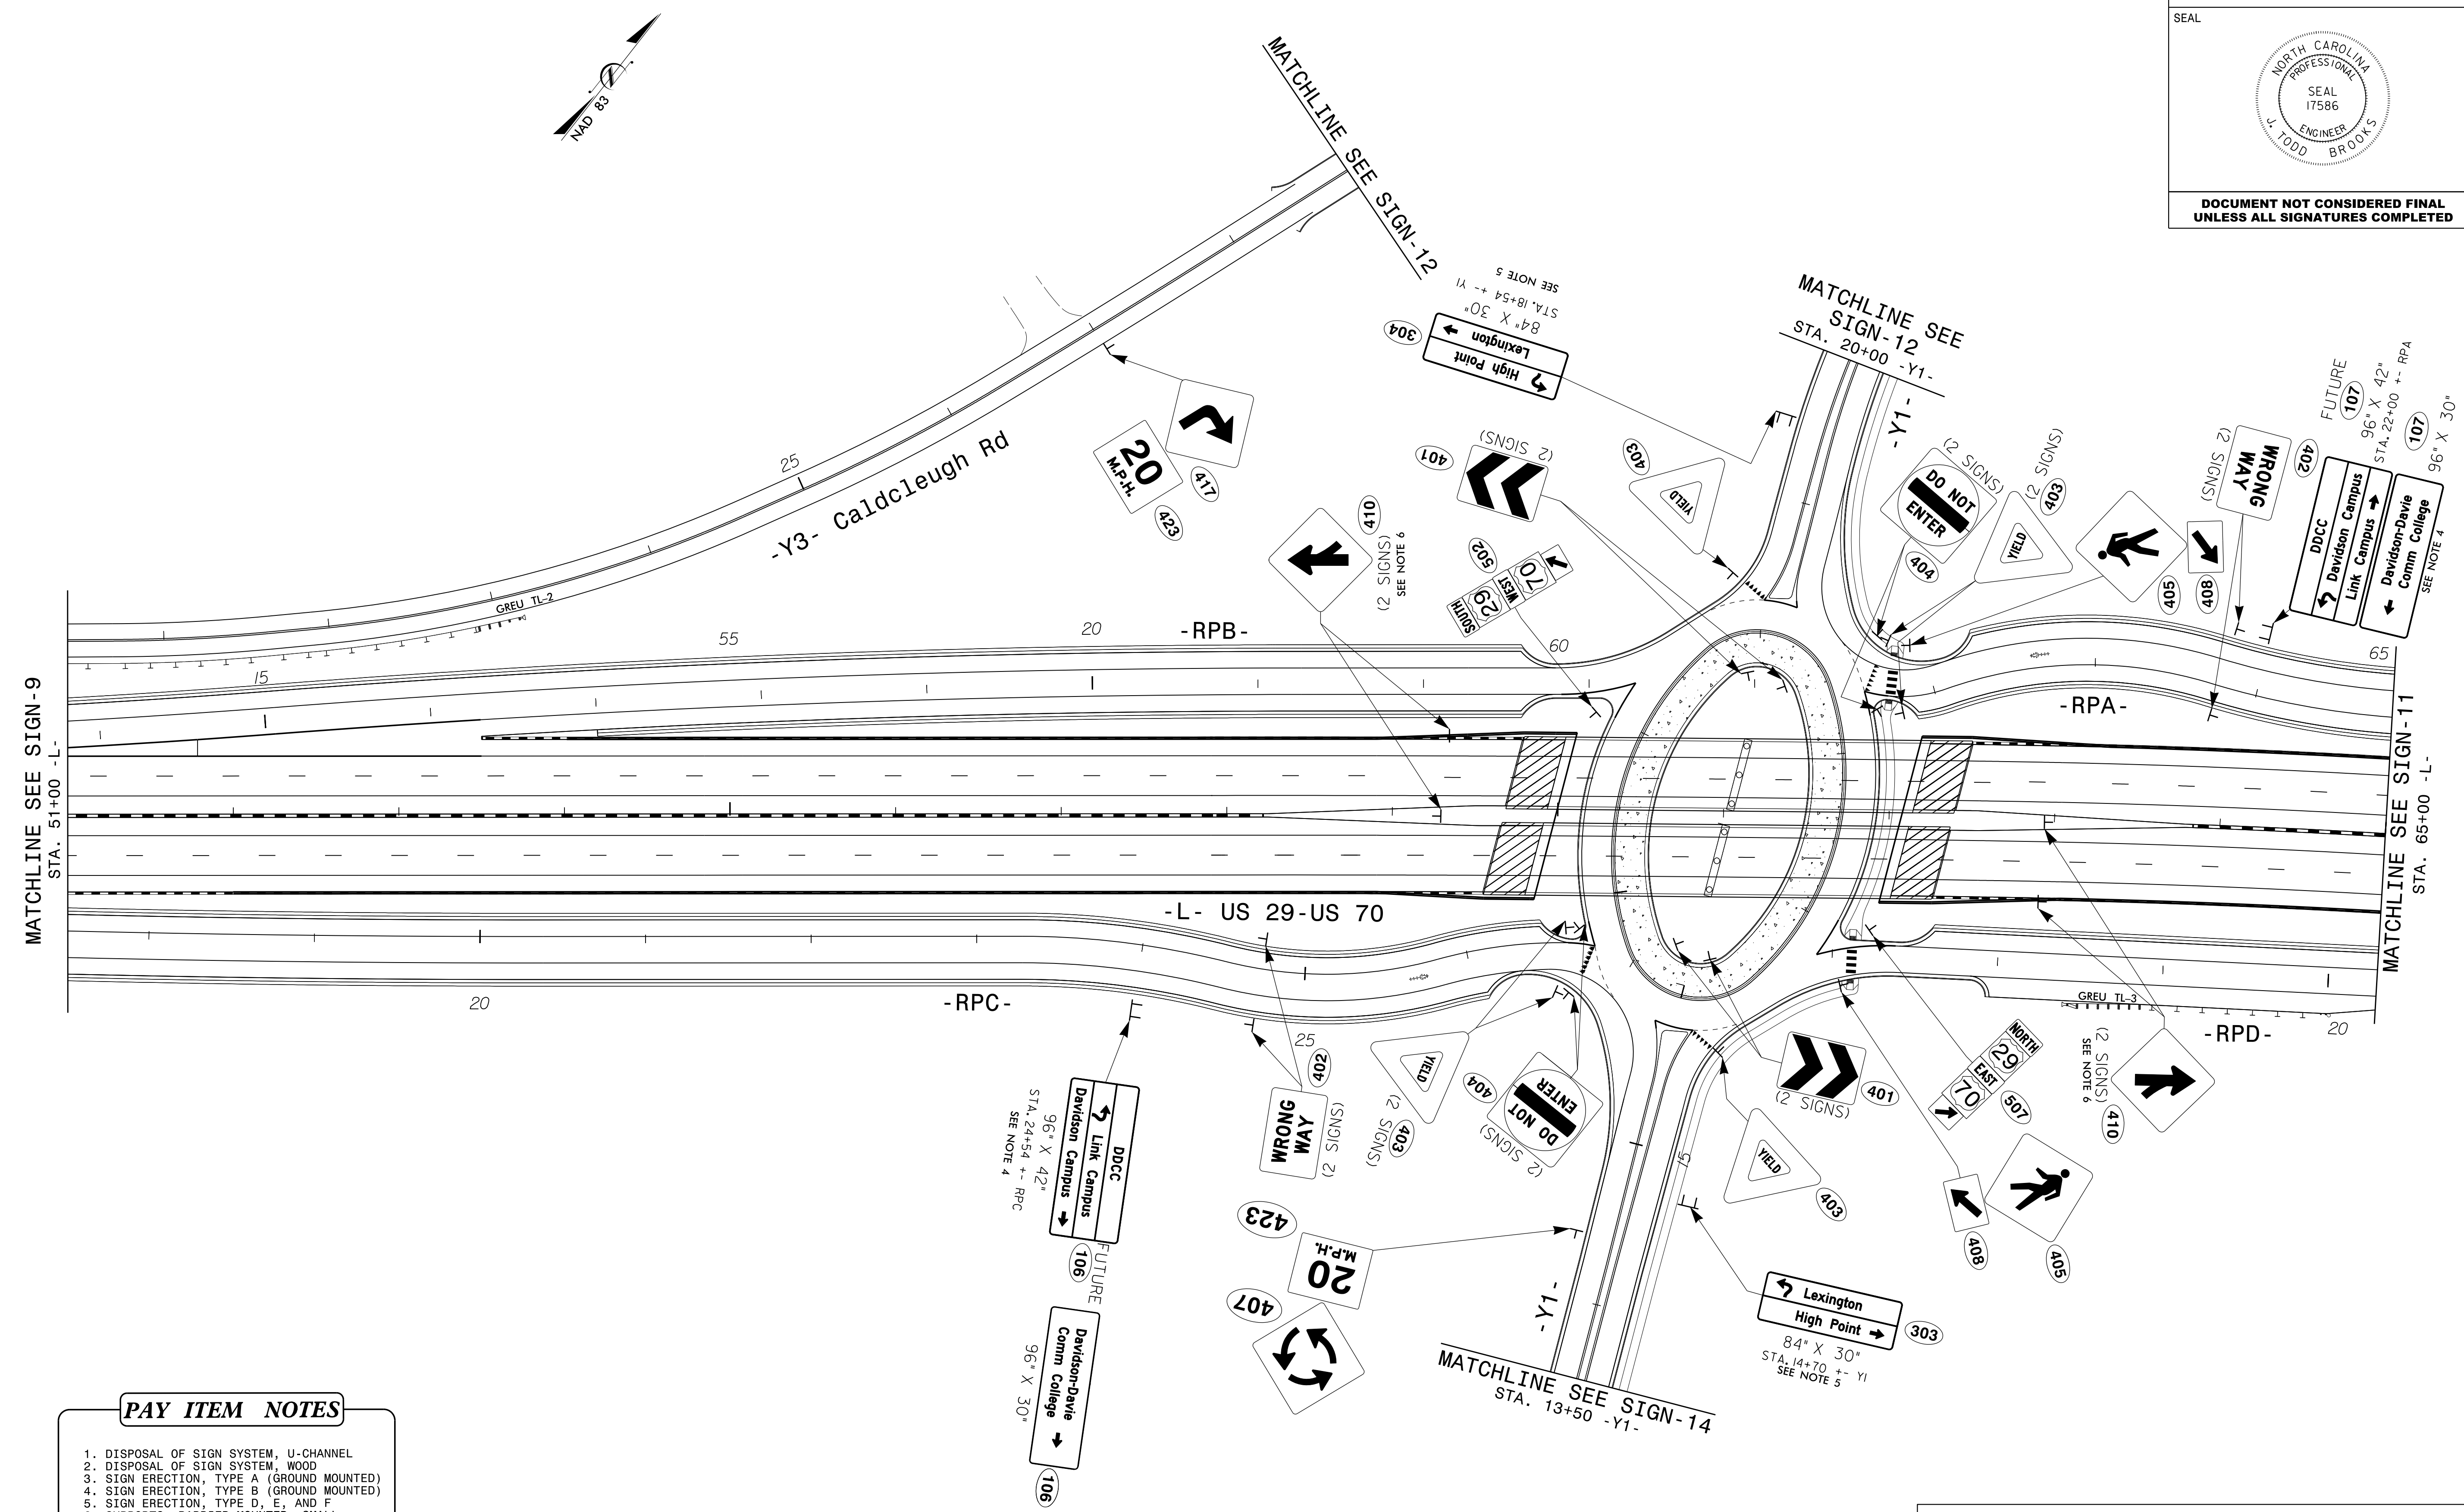

PAY ITEM NOTES

1. DISPOSAL OF SIGN SYSTEM, U-CHANNEL
2. DISPOSAL OF SIGN SYSTEM, WOOD
3. SIGN ERECTION, TYPE A (GROUND MOUNTED)
4. SIGN ERECTION, TYPE B (GROUND MOUNTED)
5. SIGN ERECTION, TYPE D, E, AND F
6. SUPPORTS, BARRIER MOUNTED, SMALL
7. STREET NAME SIGN SYSTEM TO BE REMOVED/RELOCATED BY OTHERS
8. WAYFINDING SIGN SYSTEM TO BE REMOVED/RELOCATED BY OTHERS



2610 WYCLIFF ROAD
SUITE 410
RALEIGH, NC 27607
PHONE: 919.881.9939
NC COA No. F-0929


PROPOSED SIGNING
-L- STA. 51+00 TO 65+00

invld: expressign sheets\0737_Sign_10.dgn
USER: abash@ors


APPROVED: _____

DATE: _____

SEAL

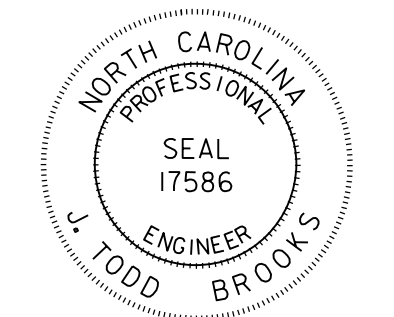

**DOCUMENT NOT CONSIDERED FINAL
UNLESS ALL SIGNATURES COMPLETED**

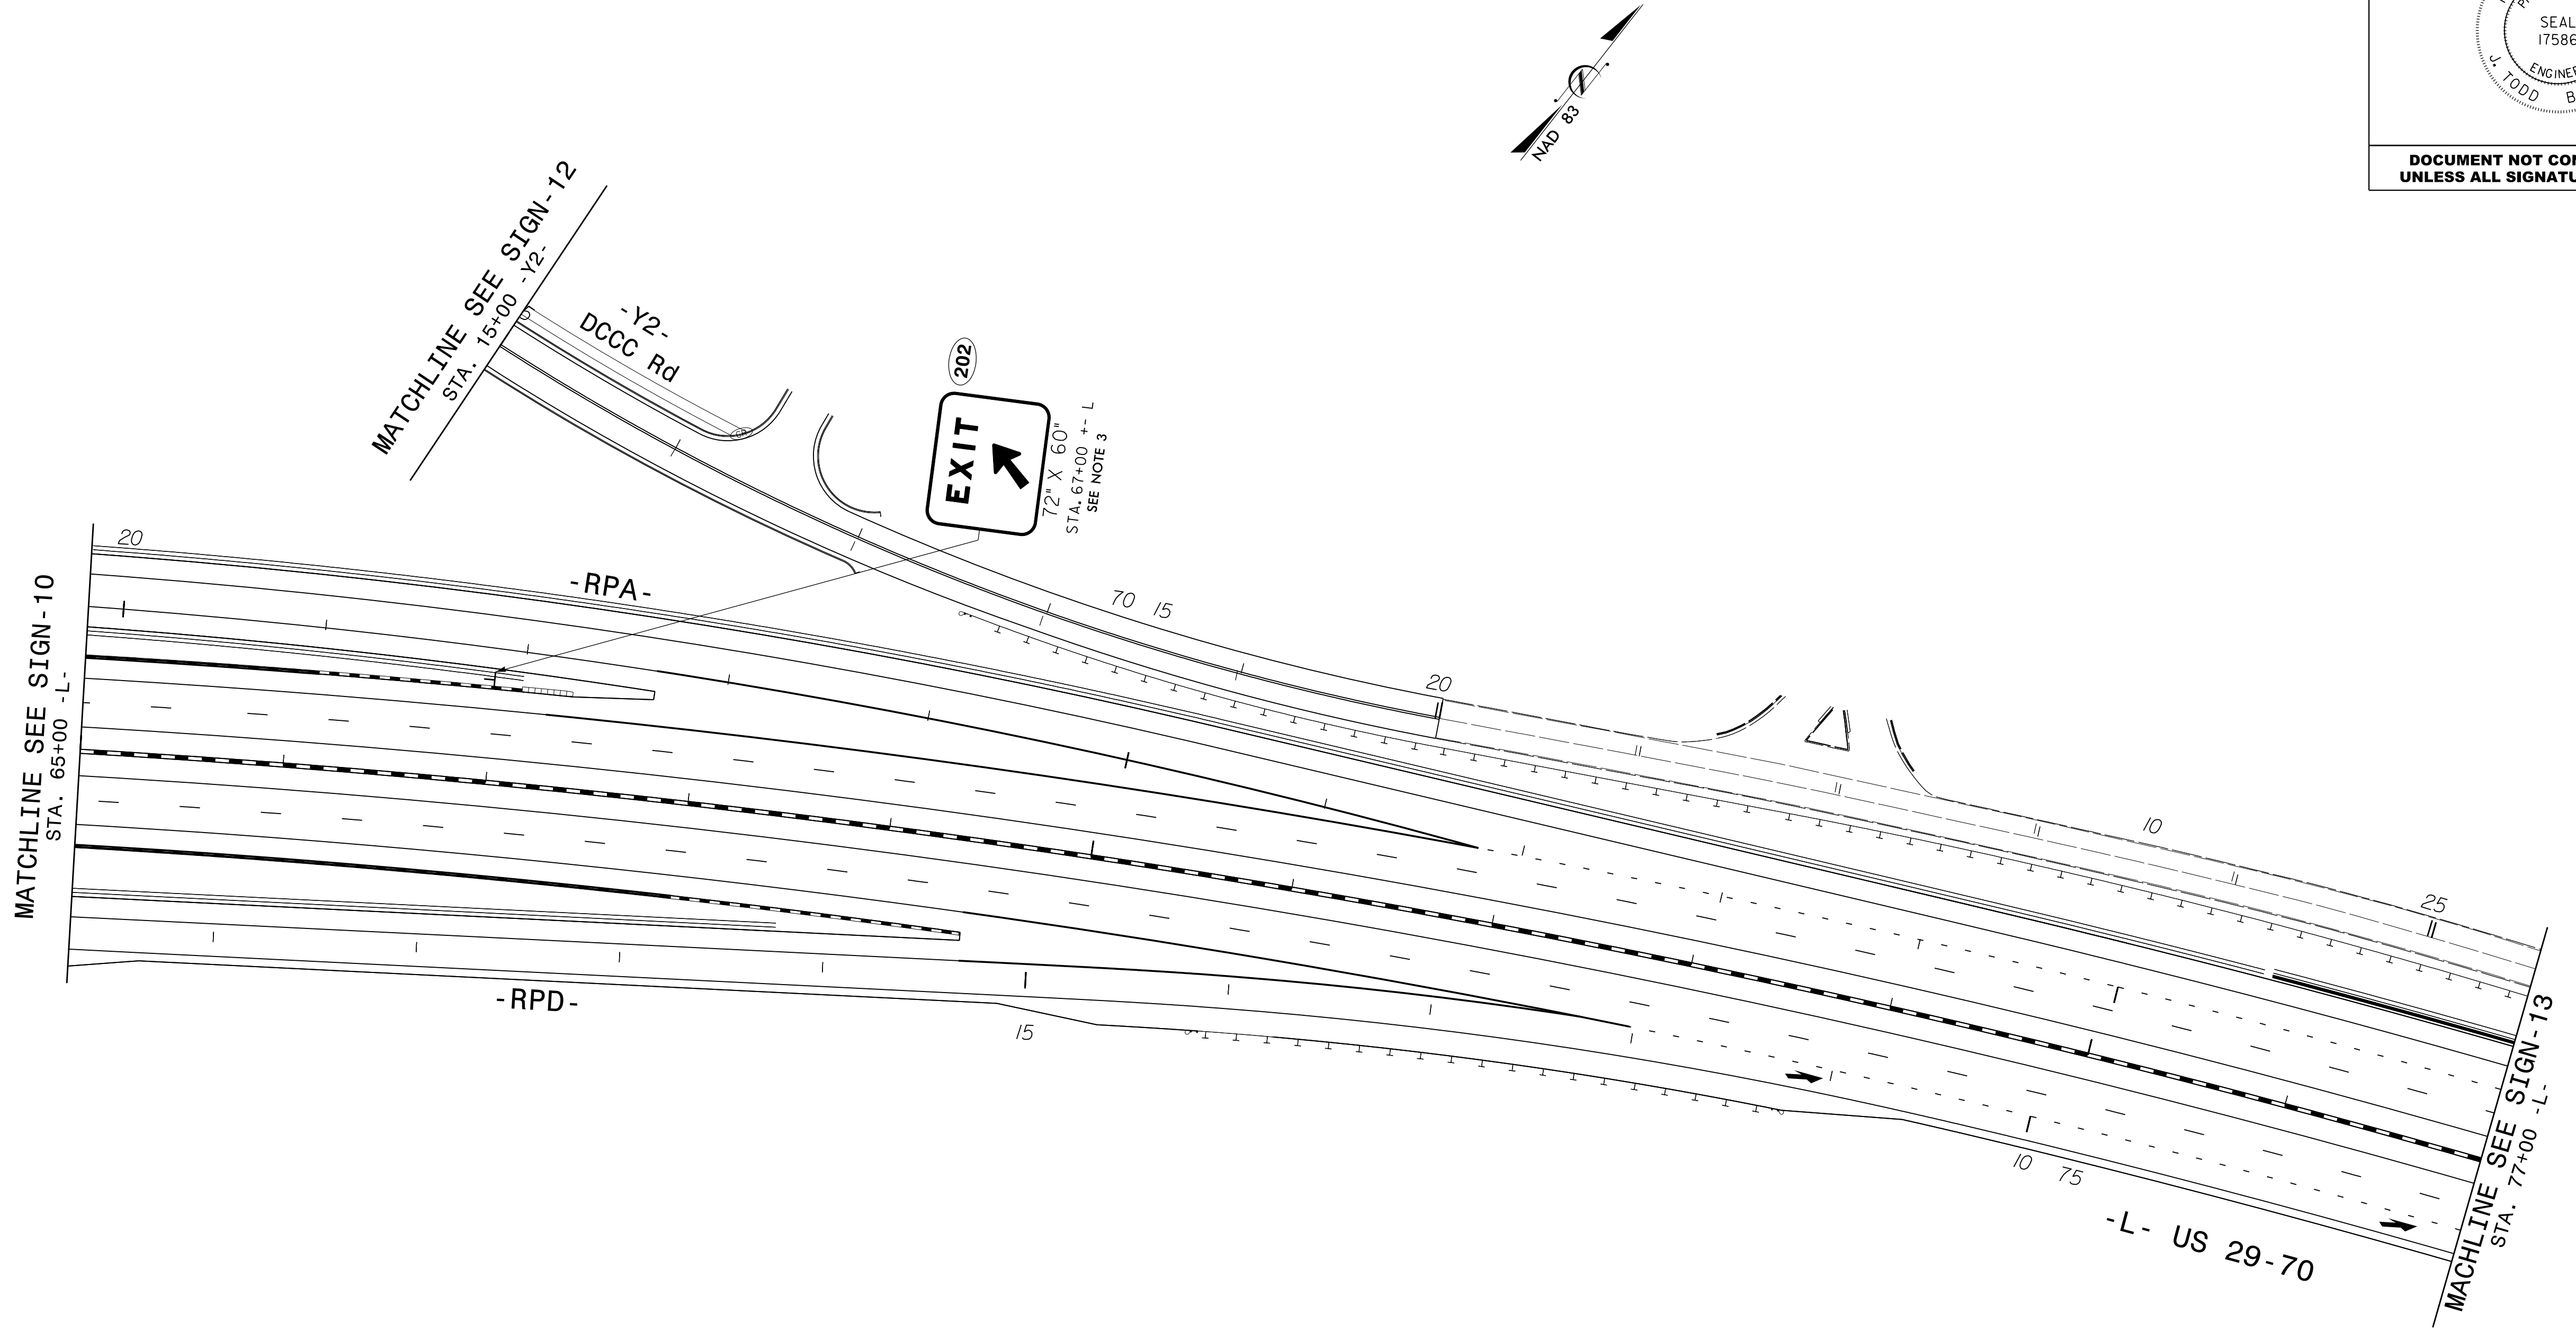

PAY ITEM NOTES


1. DISPOSAL OF SIGN SYSTEM, U-CHANNEL
2. DISPOSAL OF SIGN SYSTEM, WOOD
3. SIGN ERECTION, TYPE A (GROUND MOUNTED)
4. SIGN ERECTION, TYPE B (GROUND MOUNTED)
5. SIGN ERECTION, TYPE D, E, AND F
6. SUPPORTS, BARRIER MOUNTED, SMALL
7. STREET NAME SIGN SYSTEM TO BE REMOVED/RELOCATED BY OTHERS
8. WAYFINDING SIGN SYSTEM TO BE REMOVED/RELOCATED BY OTHERS



2610 WYCLIFF ROAD
SUITE 410
RALEIGH, NC 27607
PHONE: 919.881.9939
NC COA No. F-0929

PROPOSED SIGNING
-L- STA. 65+00 TO 77+00

inv\old_exp\pressing\11\110737_Sign_11.dgn
 USER: abeshe@ars

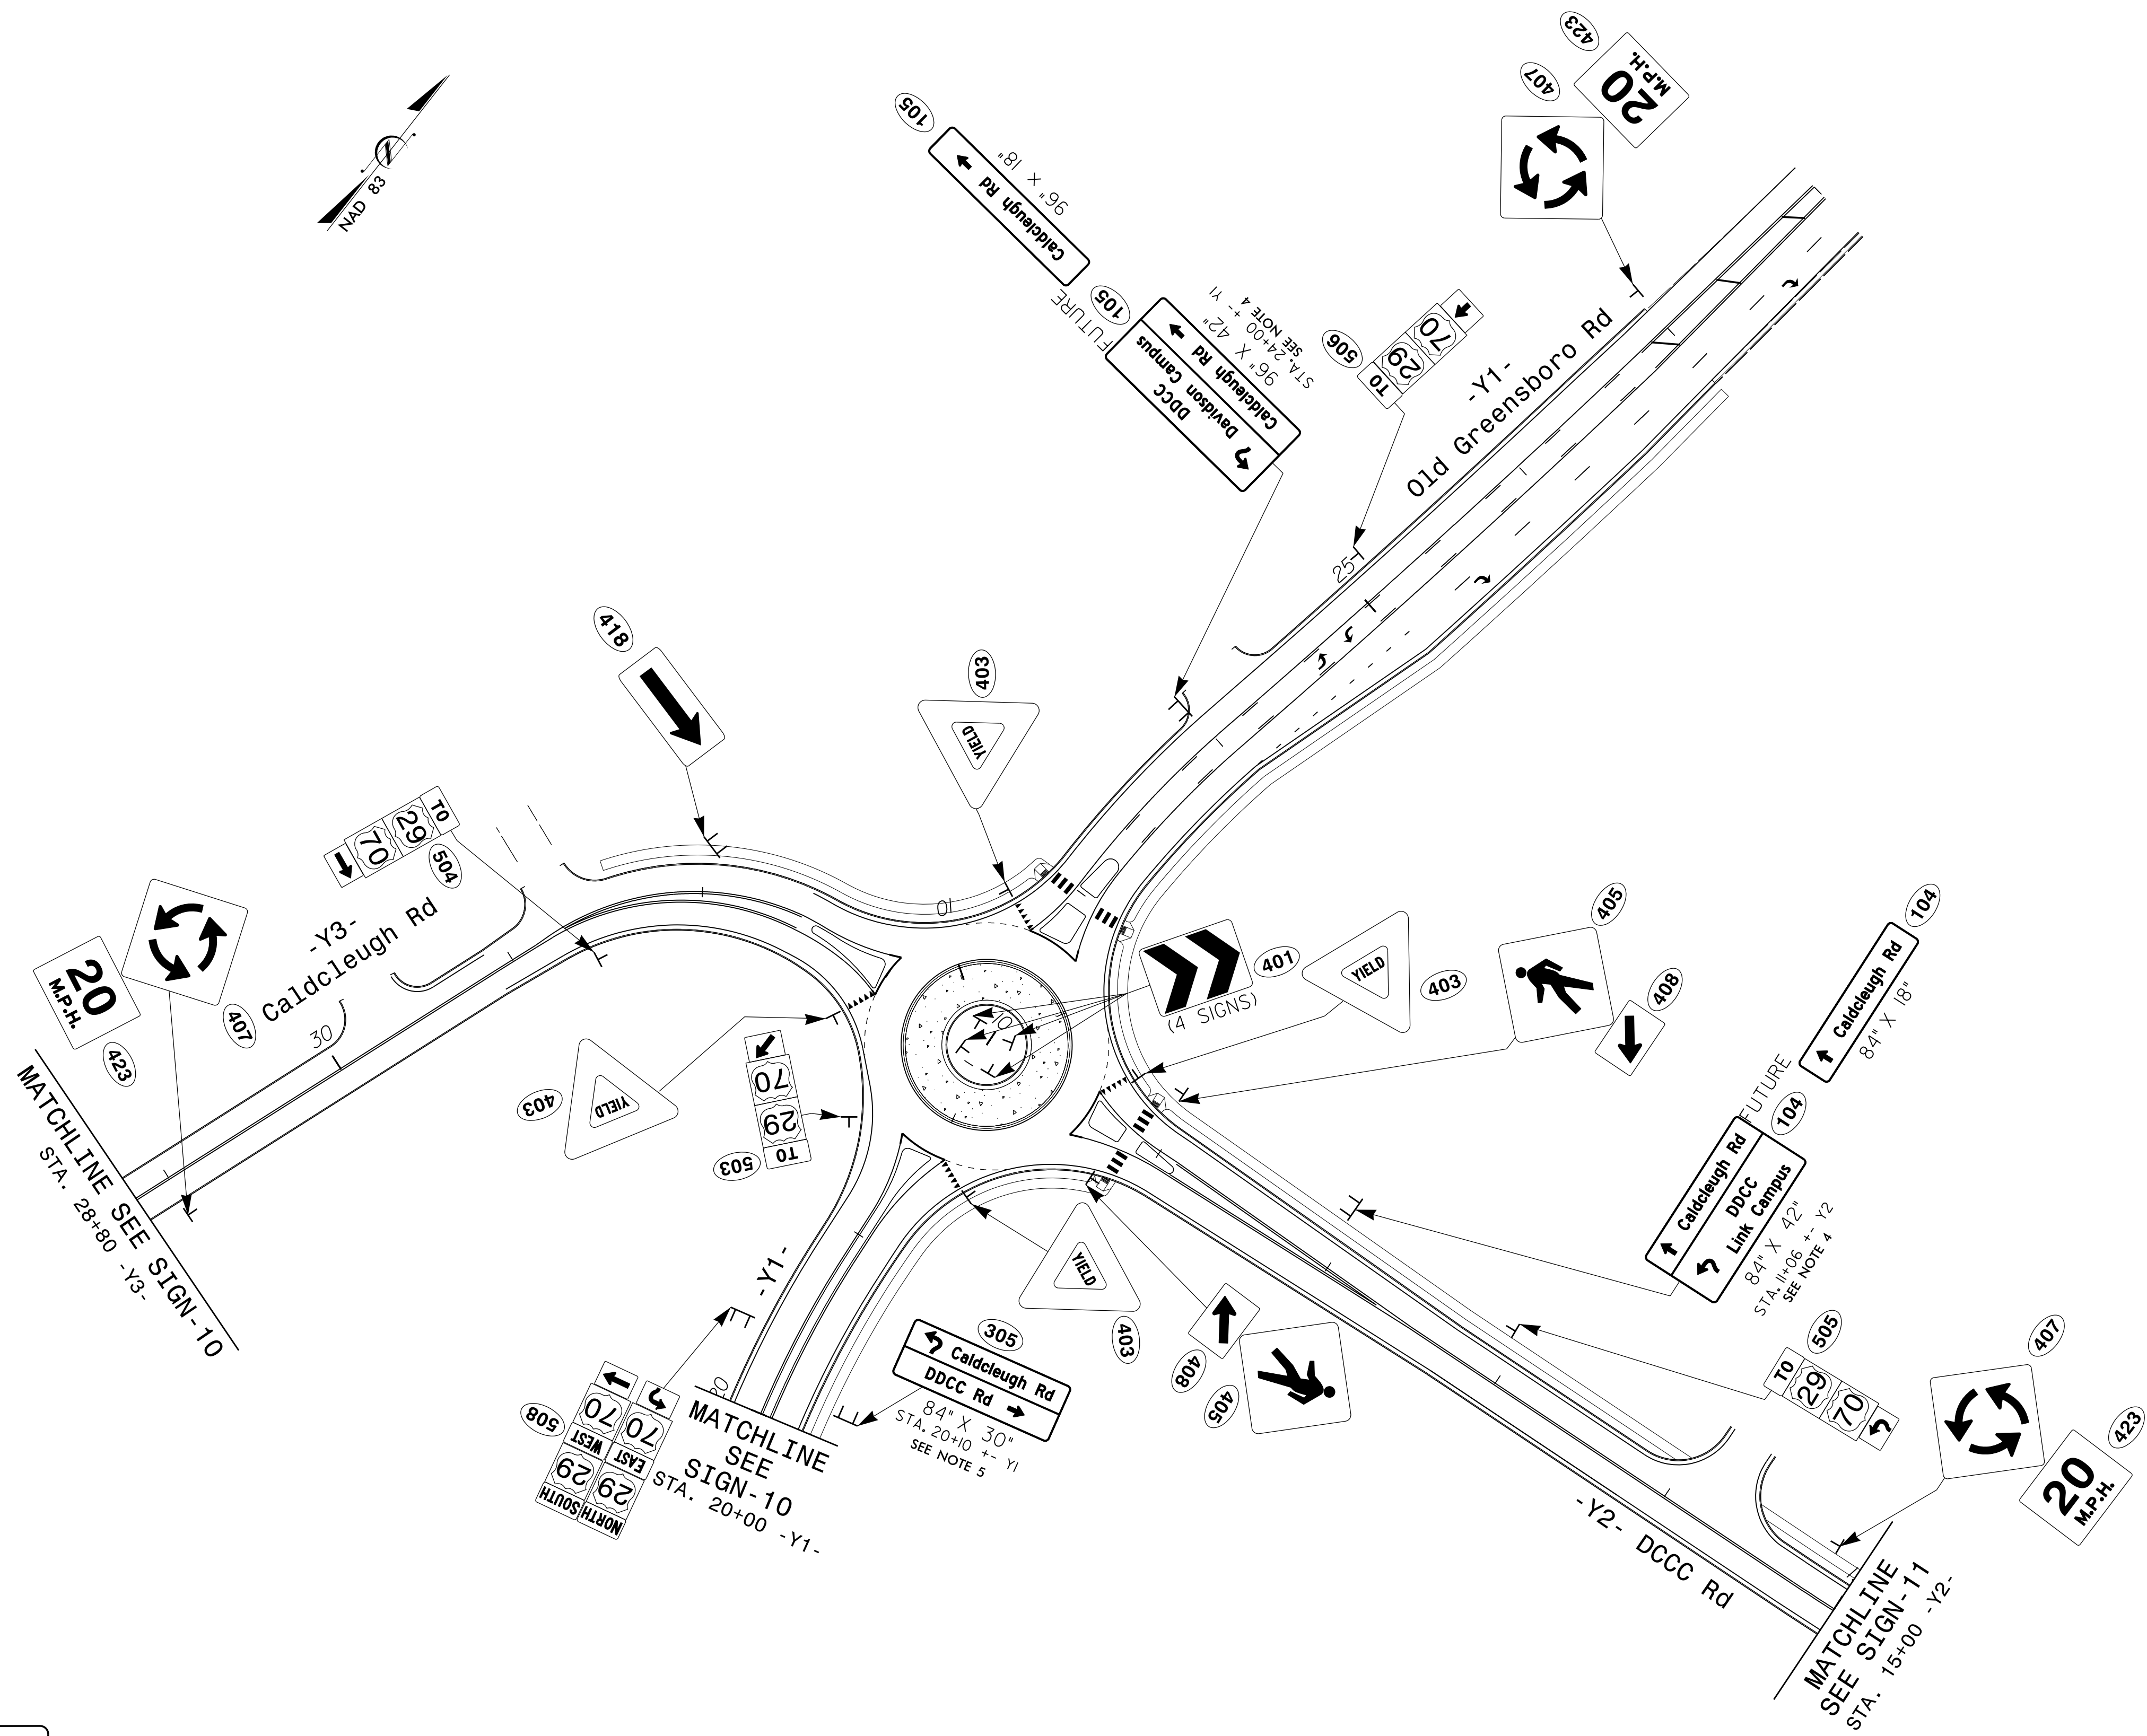

PAY ITEM NOTES


1. DISPOSAL OF SIGN SYSTEM, U-CHANNEL
2. DISPOSAL OF SIGN SYSTEM, WOOD
3. SIGN ERECTION, TYPE A (GROUND MOUNTED)
4. SIGN ERECTION, TYPE B (GROUND MOUNTED)
5. SIGN ERECTION, TYPE D, E, AND F
6. SUPPORTS, BARRIER MOUNTED, SMALL
7. STREET NAME SIGN SYSTEM TO BE REMOVED/RELOCATED BY OTHERS
8. WAYFINDING SIGN SYSTEM TO BE REMOVED/RELOCATED BY OTHERS



2610 WYCLIFF ROAD
SUITE 410
RALEIGH, NC 27607
PHONE: 919.881.9939
NC COA No. F-0929

PROPOSED SIGNING
-Y1- STA. 20+00 TO 28+00

invold_expressign...USER: abesheors

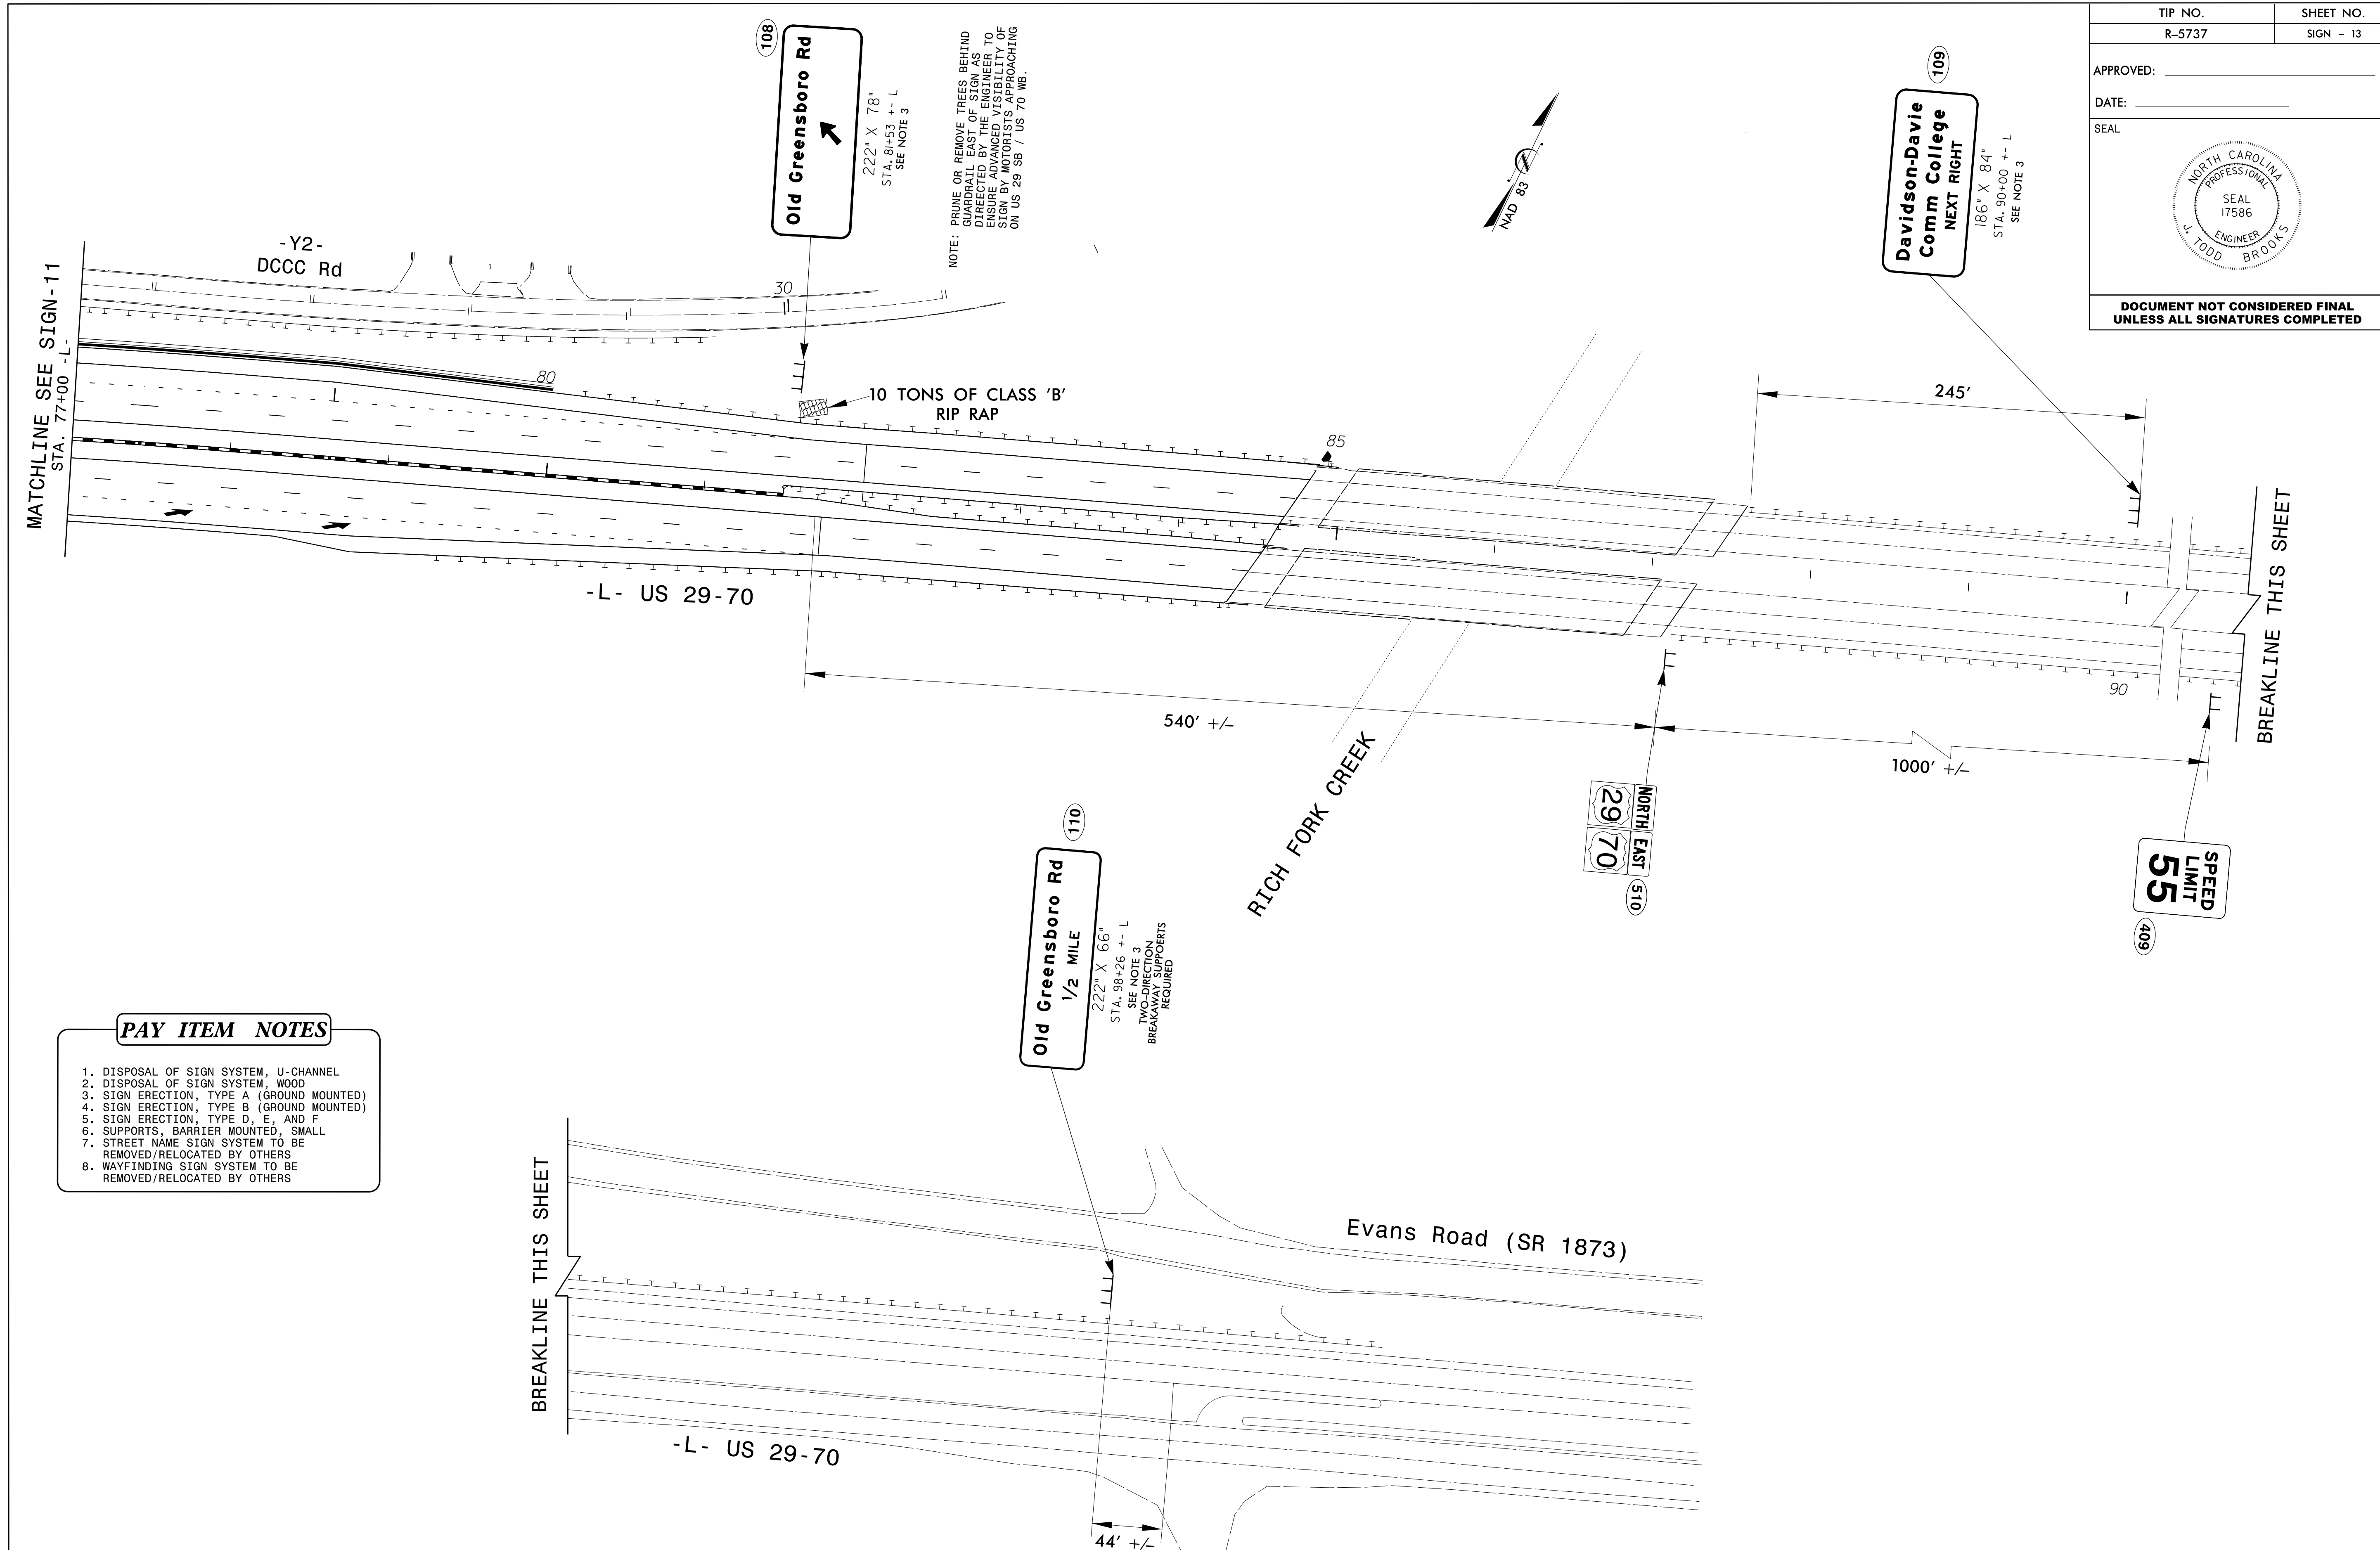

NOTE: PRUNE OR REMOVE TREES BEHIND SIGN. ALL EAST OF SIGN AS DIRECTED. THE ENGINEER TO ENSURE ADVANCE NOTICE OF SIGN BY MOTORISTS APPROACHING ON US 29 SB / US 70 WB.

- PAY ITEM NOTES**
1. DISPOSAL OF SIGN SYSTEM, U-CHANNEL
 2. DISPOSAL OF SIGN SYSTEM, WOOD
 3. SIGN ERECTION, TYPE A (GROUND MOUNTED)
 4. SIGN ERECTION, TYPE B (GROUND MOUNTED)
 5. SIGN ERECTION, TYPE D, E, AND F
 6. SUPPORTS, BARRIER MOUNTED, SMALL
 7. STREET NAME SIGN SYSTEM TO BE REMOVED/RELOCATED BY OTHERS
 8. WAYFINDING SIGN SYSTEM TO BE REMOVED/RELOCATED BY OTHERS

inv\old_express\igs\projects\10737_Sign_13.dgn
 USER: abes@ncs.com




2610 WYCLIFF ROAD
 SUITE 410
 RALEIGH, NC 27607
 PHONE: 919.881.9939
 NC COA No. F-0929

PROPOSED SIGNING
-L- STA. 77+00 TO 91+00


APPROVED: _____

DATE: _____

SEAL

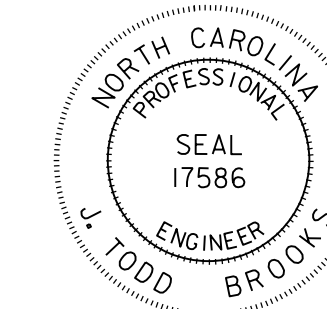

**DOCUMENT NOT CONSIDERED FINAL
UNLESS ALL SIGNATURES COMPLETED**

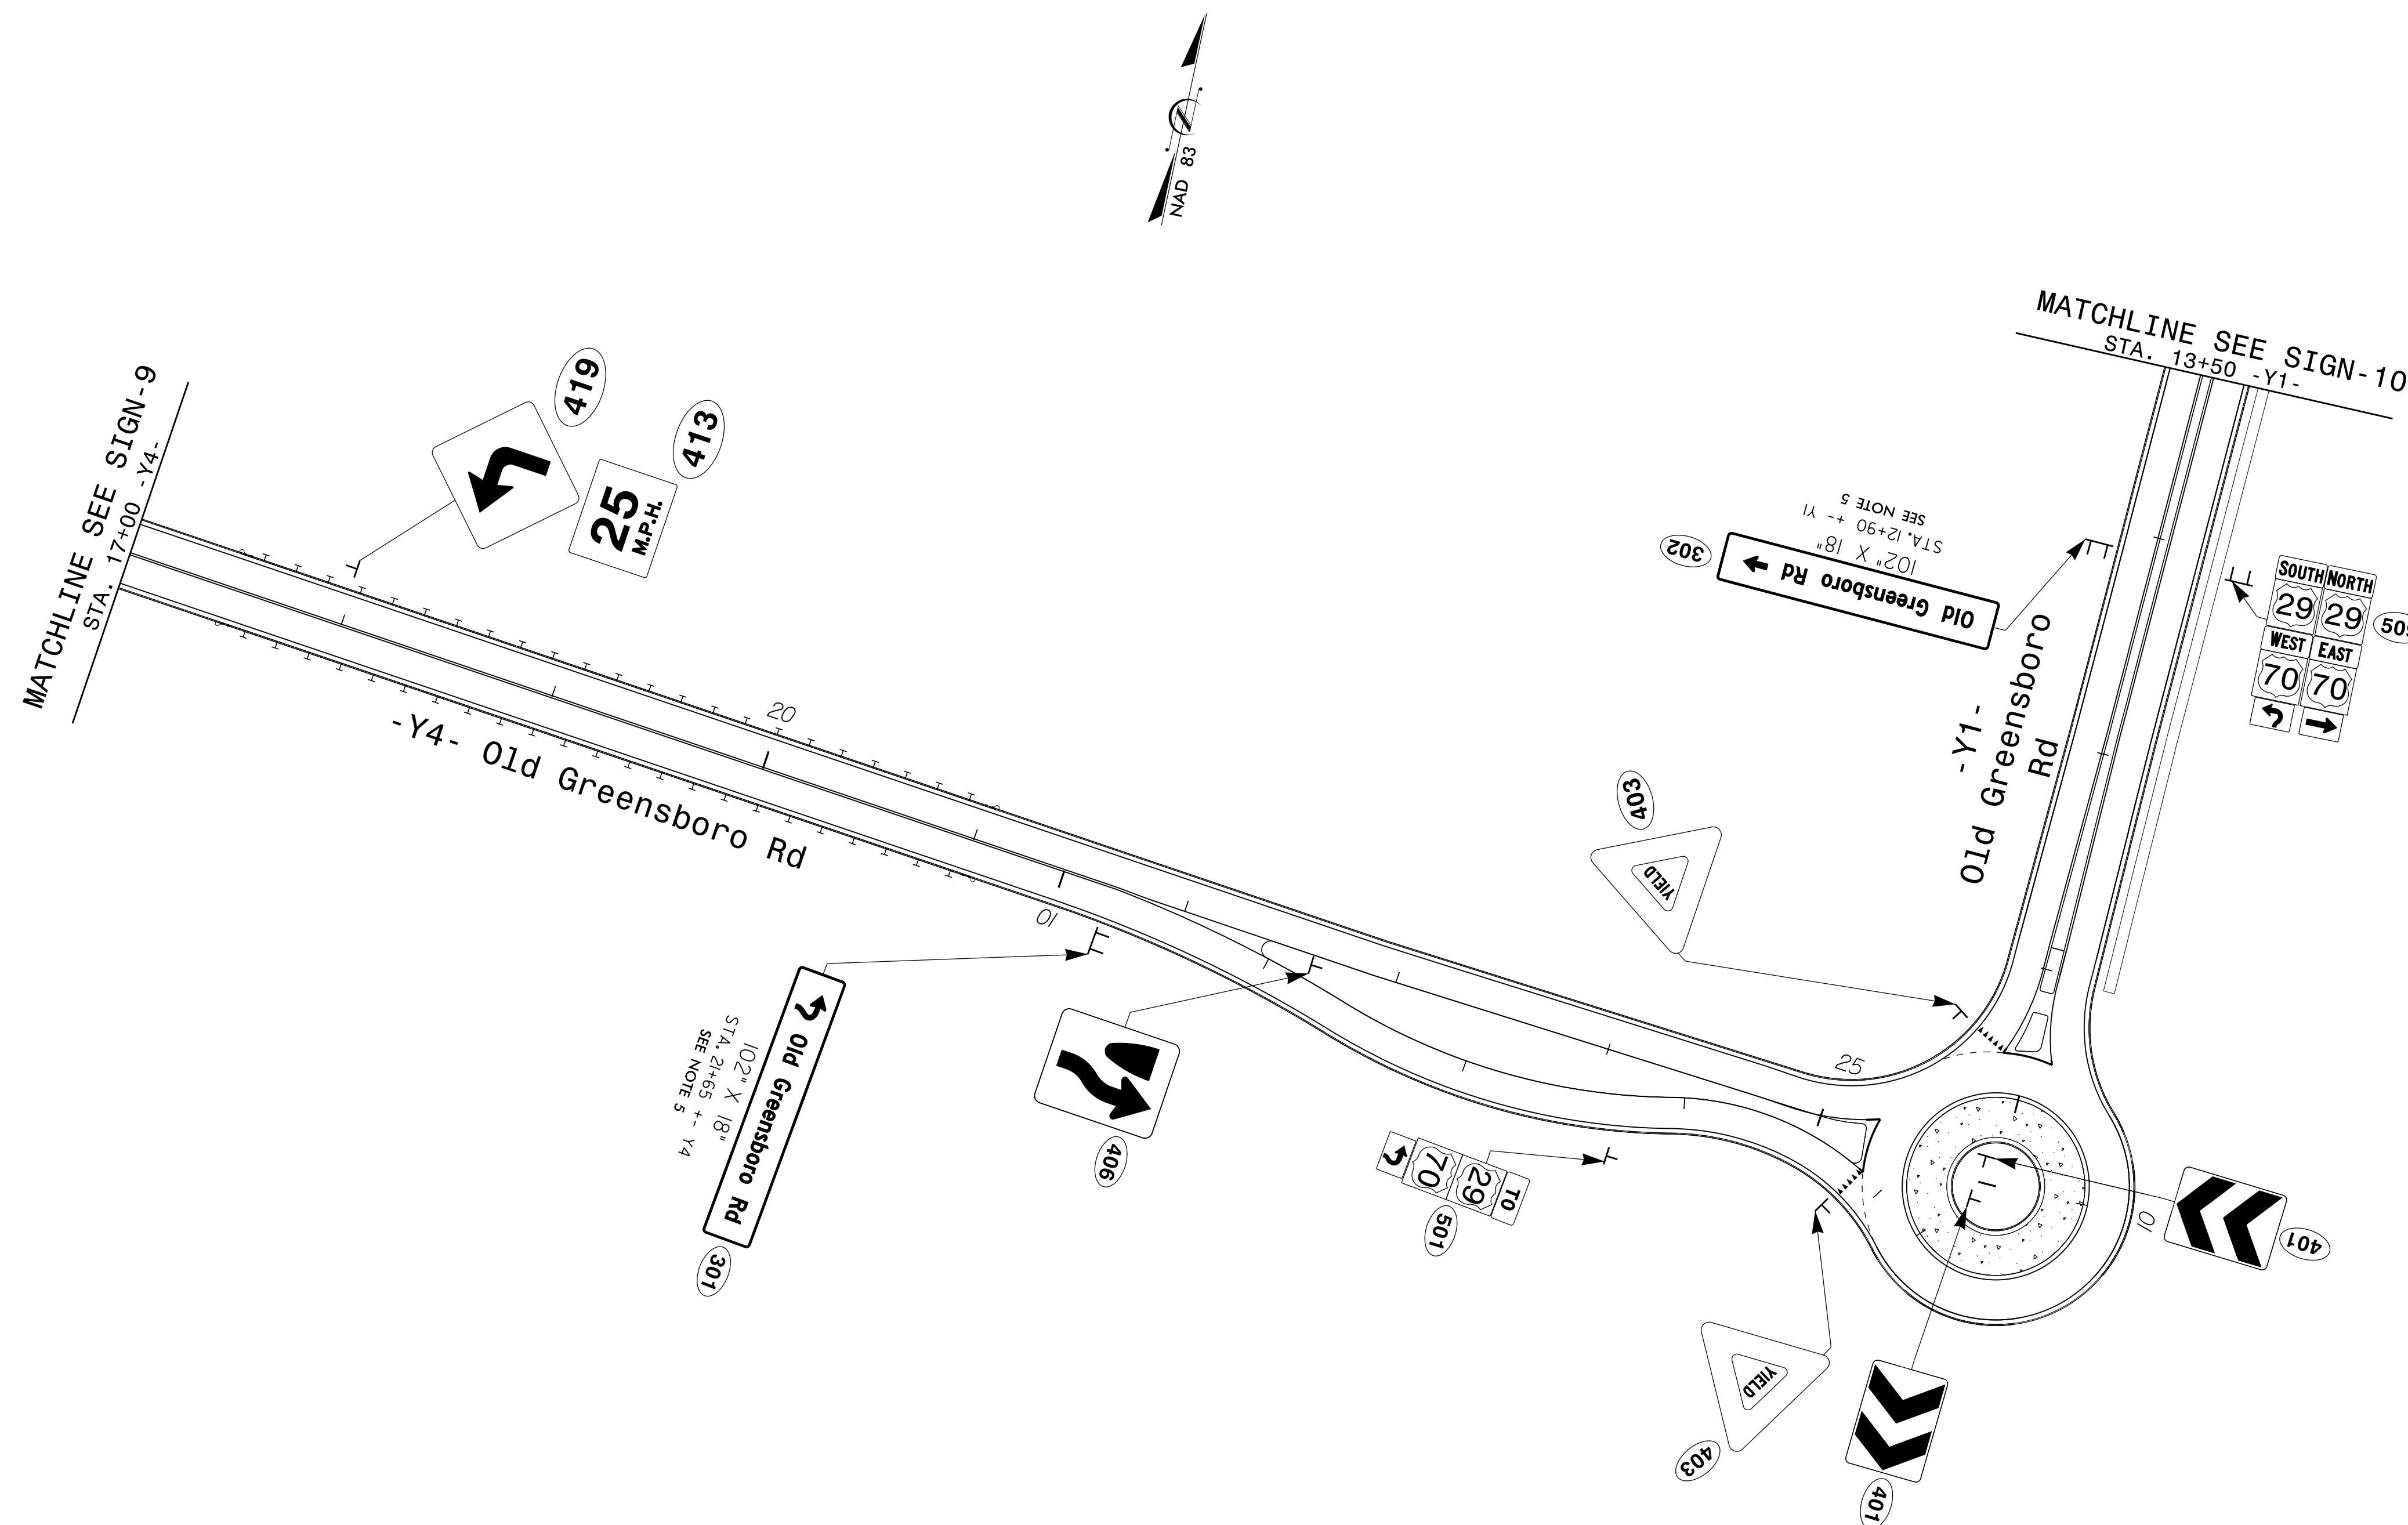

PAY ITEM NOTES

1. DISPOSAL OF SIGN SYSTEM, U-CHANNEL
2. DISPOSAL OF SIGN SYSTEM, WOOD
3. SIGN ERECTION, TYPE A (GROUND MOUNTED)
4. SIGN ERECTION, TYPE B (GROUND MOUNTED)
5. SIGN ERECTION, TYPE D, E, AND F
6. SUPPORTS, BARRIER MOUNTED, SMALL
7. STREET NAME SIGN SYSTEM TO BE REMOVED/RELOCATED BY OTHERS
8. WAYFINDING SIGN SYSTEM TO BE REMOVED/RELOCATED BY OTHERS



2610 WYCLIFF ROAD
SUITE 410
RALEIGH, NC 27607
PHONE: 919.881.9939
NC COA No. F-0929

PROPOSED SIGNING
-Y4- / -Y1-

inv\old_express\jtb\10737_Sign_14.dgn
USER: abeshears