

02-DEC-2019 15:37 S:\Server_Files\PROJECTS\2016\A2016703.00_TGS_Div-2 LIB Replacement\A2016703.00_TGS_Div-2 LIB B-4788\Design\Utilities\Engineering\UC\Proj\NB-4788_UT_tsh_UC1_psh.dgn

TIP PROJECT: 17BP.2.R.92



T.I.P. NO.	SHEET NO.
17BP.2.R.92	UC-1
DOCUMENT NOT CONSIDERED FINAL UNLESS ALL SIGNATURES COMPLETED	

STATE OF NORTH CAROLINA
DIVISION OF HIGHWAYS



**UTILITY CONSTRUCTION PLANS
PITT COUNTY**

**LOCATION: BRIDGE NO. 171 OVER JOHNSON MILL RUN
ON SR 1418 (STATION HOUSE RD.)**

TYPE OF WORK: WATER RELOCATIONS

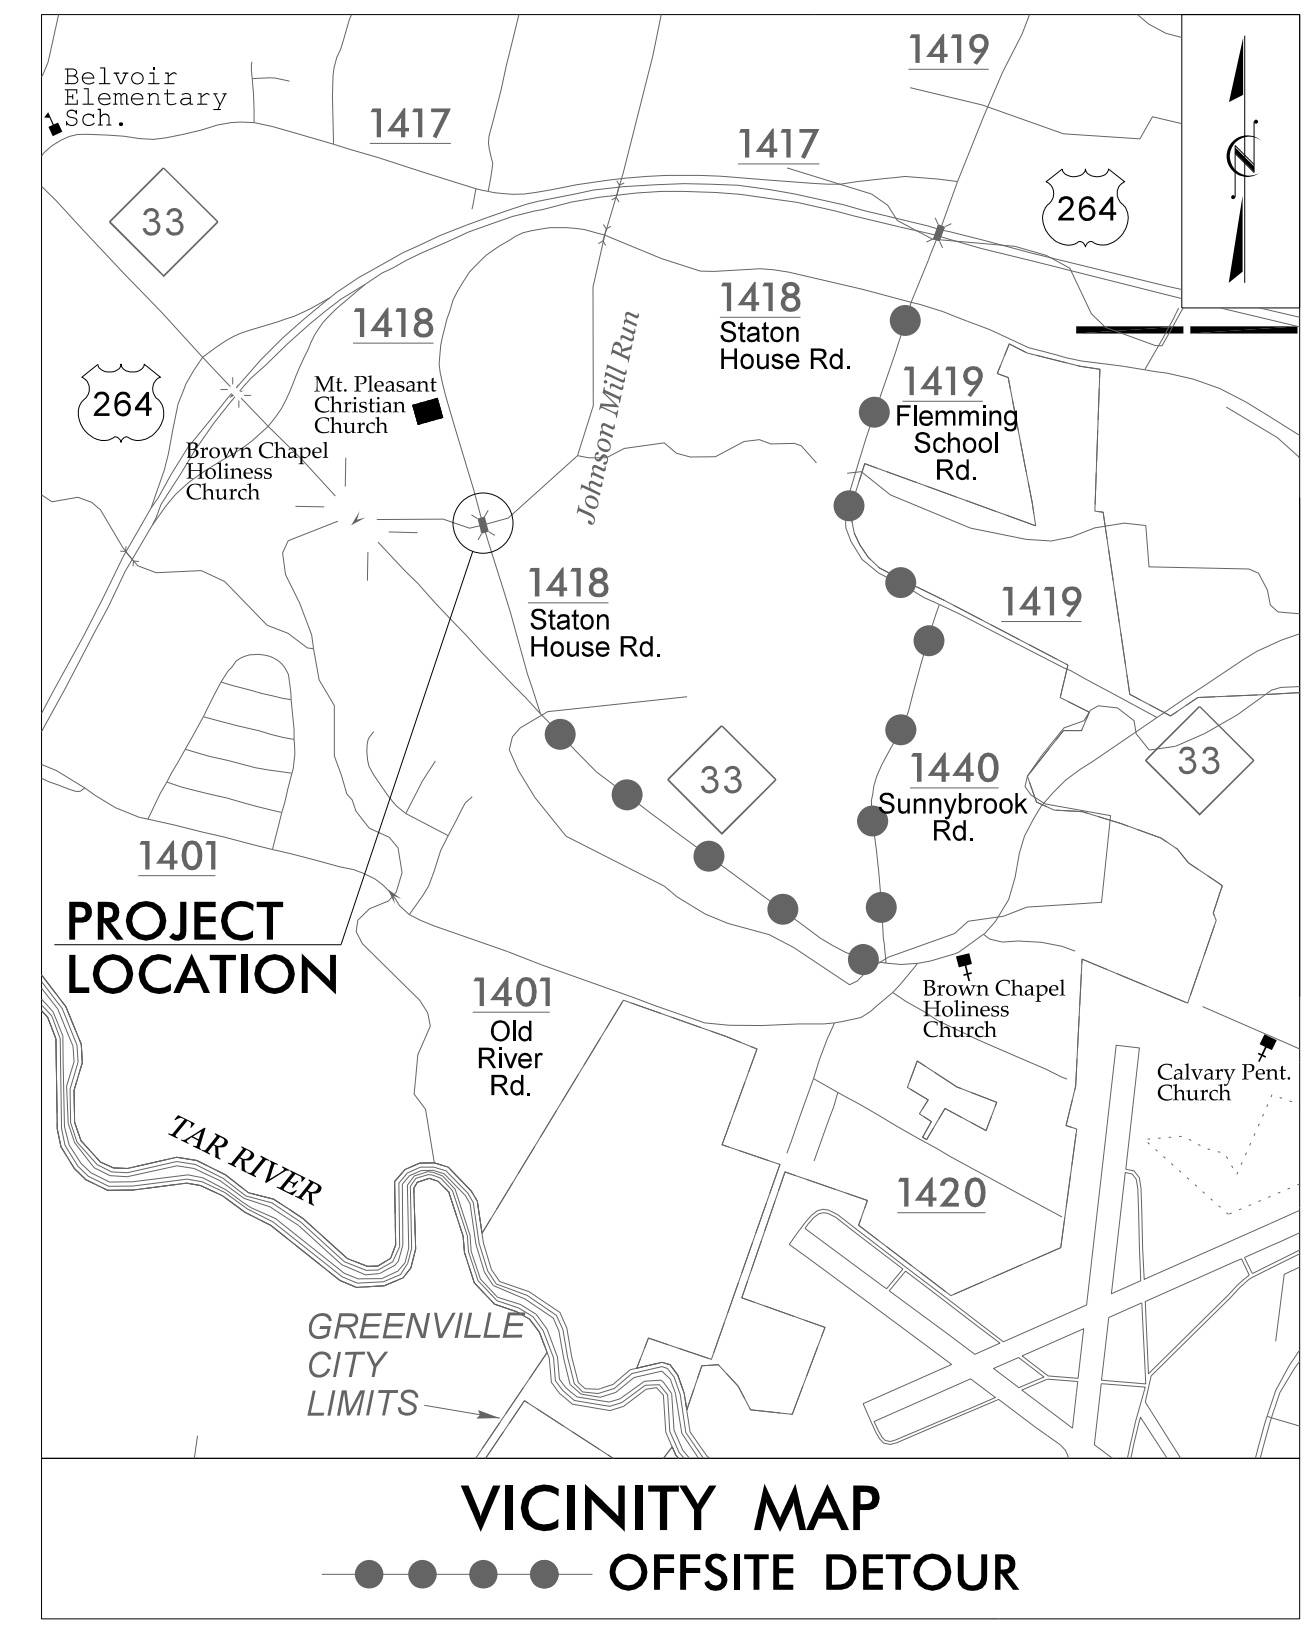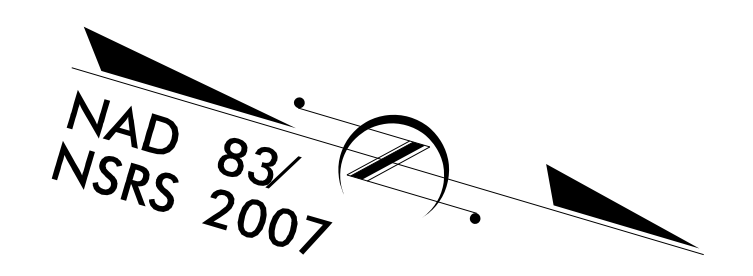

BEGIN STATE PROJECT 17BP.2.R.92
-L- STA. 10 + 65.00

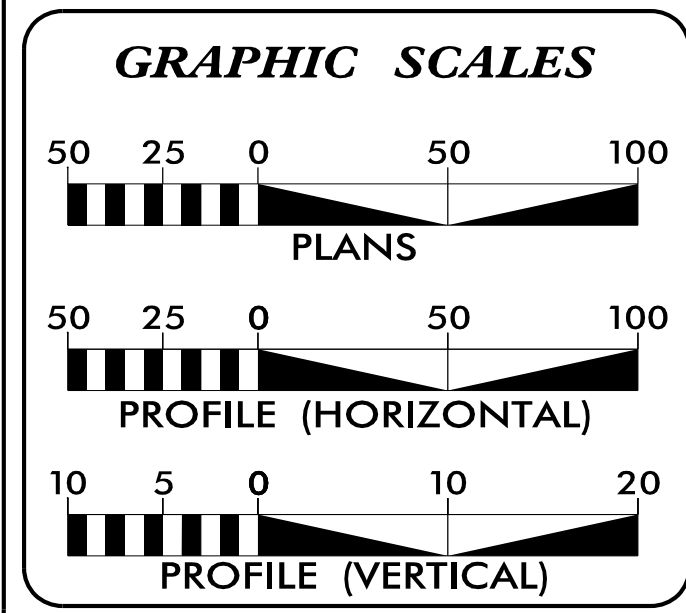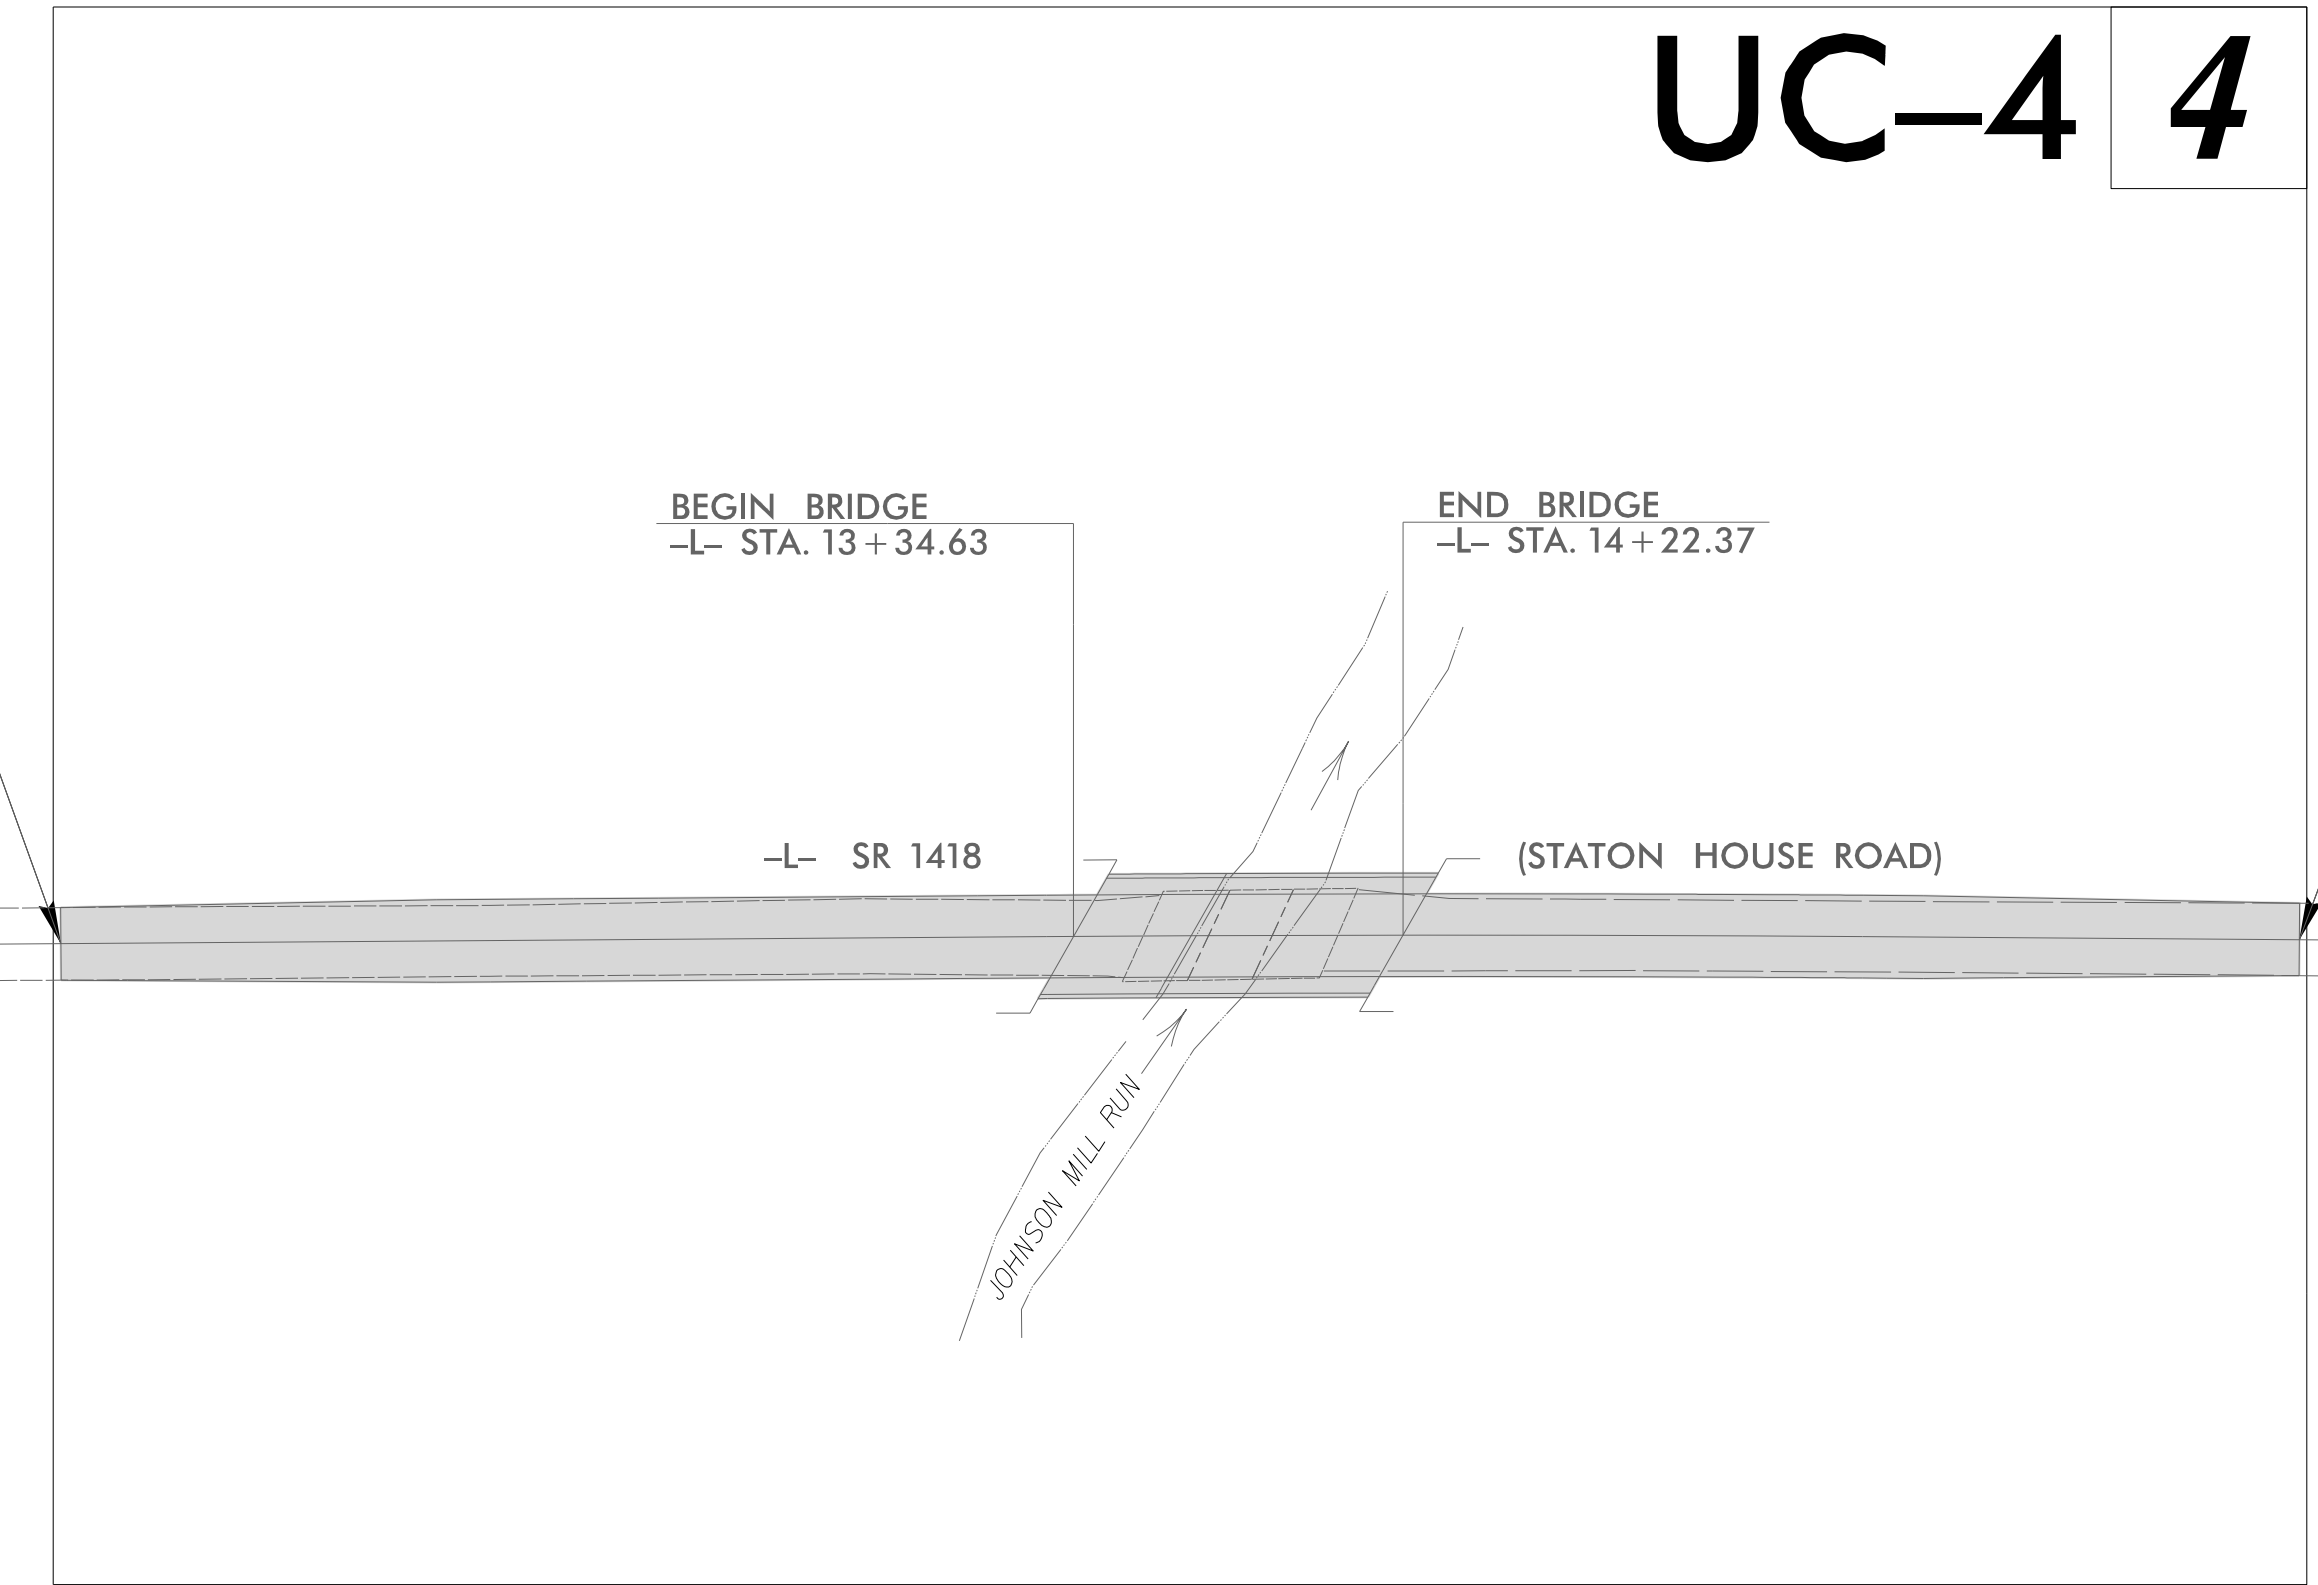

INDEX OF SHEETS

SHEET NO.	DESCRIPTION
UC-1	TITLE SHEET
UC-2	UTILITY SYMBOLOGY
UC-3	NOTES
UC-3A THRU UC-3B	DETAILS
UC-4	UTILITY PLAN & PROFILE

**WATER OWNER
ON PROJECT**

(A) GREENVILLE UTILITIES COMMISSION
- WATER

PREPARED IN THE OFFICE OF:

**HINDE
ENGINEERING**

License No. C-2639
401 Harrison Oaks Blvd., Suite 220 Cary, NC 27513
Ph. (919) 653-0001

<u>Clint L. Stevens, P.E.</u>	UTILITIES PROJECT MANAGER
<u>Corey Bousquet, P.E.</u>	UTILITIES PROJECT ENGINEER
<u>Jordan Chapman</u>	UTILITIES PROJECT DESIGNER

SEAL

**DIVISION OF HIGHWAYS
UTILITIES UNIT**

1555 MAIL SERVICES CENTER
RALEIGH NC 27699-1555
PHONE (919) 707-6690
FAX (919) 250-4151

<u>Preston Hunter, P.E.</u>	DIVISION CONTACT #1
<u>Cadmus Capehart, P.E.</u>	DIVISION CONTACT #2
<u>Sarah Lentine, P.E.</u>	DIVISION CONTACT #3
<u>David Kramer</u>	DIVISION CONTACT #4