

**This electronic collection of documents is provided
for the convenience of the user
and is Not a Certified Document –**

**The documents contained herein were originally issued
and sealed by the individuals whose names and license
numbers appear on each page, on the dates appearing
with their signature on that page.**

**This file or an individual page
shall not be considered a certified document.**

7/7/2021 U:\Projects\Signing\CADD\Signing\U-4405A Revised\Signing\U-4405A Revised Title Sheet and F Assembly Sheet.dgn hambricht


T.I.P.: U-4405A

CONTRACT: C204404

**STATE OF NORTH CAROLINA
DEPARTMENT OF TRANSPORTATION**

**SIGNING PLAN
CUMBERLAND COUNTY**

**LOCATION: US 401 (RAEFORD ROAD) FROM SOUTH RAEFORD ROAD / BENTRIDGE LANE
TO EAST OF NC 162 (BUNCE ROAD) IN FAYETTEVILLE**

TIP NO. U-4405A	SHEET NO. SIGN-1
APPROVED: <u>Betsy L. Watson</u> 7/7/2021	
DATE: 7/7/2021	
SEAL 	
DOCUMENT NOT CONSIDERED FINAL UNLESS ALL SIGNATURES COMPLETED	

ROADWAY STANDARD DRAWING

THE FOLLOWING ROADWAY STANDARDS AS APPEAR IN "ROADWAY STANDARD DRAWINGS" - PROJECT SERVICES UNIT - N.C. DEPARTMENT OF TRANSPORTATION - RALEIGH, N.C., DATED JANUARY 2018 ARE APPLICABLE TO THIS PROJECT AND BY REFERENCE HEREBY ARE CONSIDERED A PART OF THESE PLANS:

STD. NO.	TITLE
904.10	ORIENTATION OF GROUND MOUNTED SIGNS
904.50	MOUNTING OF TYPE 'D', 'E' AND 'F' SIGNS ON 'U' CHANNEL POSTS

GENERAL NOTES

- SIGNS FURNISHED BY STATE
- CONFIRM IN WRITING AT LEAST 4 MONTHS IN ADVANCE, THE ACTUAL DATE THE DEPARTMENT FURNISHED SIGNS WILL BE REQUIRED.
- ALL TYPE 'D' SIGNS SHALL BE MOUNTED ON TWO U-CHANNEL POSTS UNLESS OTHERWISE INDICATED ON THE PLANS.
- IF REMOVAL OR RELOCATION OF SIGNS ON PRIVATE STREET (NON-STATE MAINTAINED) IS REQUIRED DUE TO CONSTRUCTION, THE CONTRACTOR SHALL INFORM THE ENGINEER. THE WORK WILL BE COMPLETED BY OTHERS.
- WHEN NOT STATIONED OR DIMENSIONED ON PLANS, ALL 'E' AND 'F' SIGNS SHALL BE FIELD LOCATED BY THE ENGINEER
- ALL EXISTING SIGNS ON "U" CHANNEL POST WITHIN THE PROJECT LIMITS SHALL BE REMOVED AND DISPOSED OF UNLESS OTHERWISE NOTED ON PLANS.
- WHEN EXISTING SIGNS ARE REMOVED AND INSTALLED ON NEW SUPPORTS, THE RE-ERECTION SHALL IMMEDIATELY FOLLOW THE REMOVAL WHEN REINSTALLATION IS NOT IN CONFLICT WITH CONSTRUCTION OPERATIONS.
- THE BACKGROUND FOR TYPE E & F SIGNS SHALL BE TYPE C REFLECTIVE SHEETING.
- SEE ROADWAY PLANS FOR GUARD/GUIDE RAIL DETAILS.

SUMMARY OF QUANTITIES

ITEM NO.	ITEM DESCRIPTION	QUANTITY	UNIT
DESC. NO.	SECT. NO.		
4048000000	902	REINFORCED CONCRETE SIGN FOUNDATION	0 C.Y.
4054000000	902	PLAIN CONCRETE SIGN FOUNDATION	0 C.Y.
4057000000	SP	OVERHEAD FOOTING	0 C.Y.
4060000000	903	SUPPORTS, BREAKAWAY STEEL BEAM	0 LB.
4072000000	903	SUPPORTS, 3 LB STEEL U-CHANNEL	2746 L.F.
4082100000	906	SUPPORTS, OVERHEAD SIGN STRUCTURE @ -RPB- STA. 12+74	0 L.S.
4096000000	904	SIGN ERECTION, TYPE D	4 EA.
4102000000	904	SIGN ERECTION, TYPE E	171 EA.
4108000000	904	SIGN ERECTION, TYPE F	11 EA.
4109000000	904	SIGN ERECTION, TYPE A (OVERHEAD)	0 EA.
4110000000	904	SIGN ERECTION, TYPE A (GROUND MOUNTED)	0 EA.
4116100000	904	SIGN ERECTION, RELOCATE SIGN TYPE D (GROUND MOUNTED)	24 EA.
4152000000	907	DISPOSAL OF SIGN SYSTEM, STEEL BEAM	0 EA.
4155000000	907	DISPOSAL OF SIGN SYSTEM, U-CHANNEL	139 EA.
4192000000	907	DISPOSAL OF SUPPORT, U-CHANNEL	24 EA.
4234000000	907	DISPOSAL OF SIGN, A OR B (OVERHEAD)	0 EA.
4360000000	SP	DISPOSAL OF SIGN SYSTEM ON SPANWIRE	0 EA.


INDEX

SHEET NO.	DESCRIPTION
SIGN-1	TITLE SHEET
SIGN-2A-2B	E SIGN SHEETS
SIGN-3	F SIGN SHEETS
SIGN-4	SIGN DESIGNS
SIGN-5-14	SIGNING PLAN SHEETS

PLAN PREPARED FOR THE N.C.D.O.T. SIGNING AND DELINEATION UNIT

Ayman Alqudwah, PE SIGNING & DELINEATION REGIONAL ENGINEER

Stacy Johns SIGNING & DELINEATION DESIGN ENGINEER

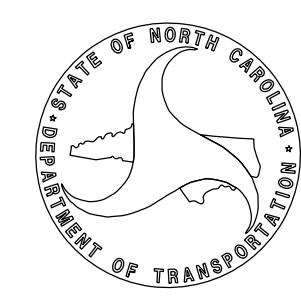

Stantec Consulting Services Inc.
801 Jones Franklin Road
Suite 300
Raleigh, NC 27606
Tel. (919) 851-6866
Fax. (919) 851-7024
www.stantec.com
License No. F-0672

PLAN PREPARED BY: Stantec Consulting Services, Inc.

Betsy L. Watson, PE Senior Principal

Jay Woolard, PE Senior Transportation Engineer

James Hambricht Senior Transportation Technician



2/25/2019
Us:\Traffic\Signing\CA00\Signing\U-4405A\Signing Plan Sheets\Proposed Signing\U-4405 Title Sheet and Details.dgn
Inamberight

401 QUANTITY REQ'D 10



42" X 30"
R5-1a

ONE "U" POST PER SIGN

402 QUANTITY REQ'D 17



36" X 36"
R1-1

TWO "U" POST PER SIGN
(MOUNT BELOW SIGN #403
IN 15 INSTALLATIONS)

403 QUANTITY REQ'D 24



54" X 18"
R6-1

TWO "U" POST PER SIGN
(MOUNT BACK TO BACK WITH
SIGN #404 IN 7 INSTALLATIONS)


404 QUANTITY REQ'D 21



54" X 18"
R6-1

TWO "U" POST PER SIGN
(MOUNT BACK TO BACK WITH
SIGN #403 IN 7 INSTALLATIONS)


405 QUANTITY REQ'D 8

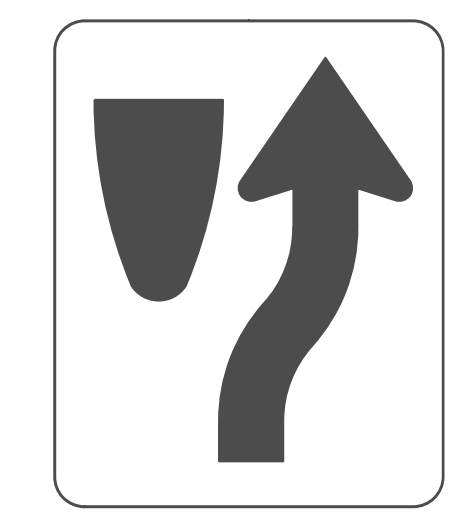

24" X 30"
R4-7

ONE "U" POST PER SIGN

406 QUANTITY REQ'D 8

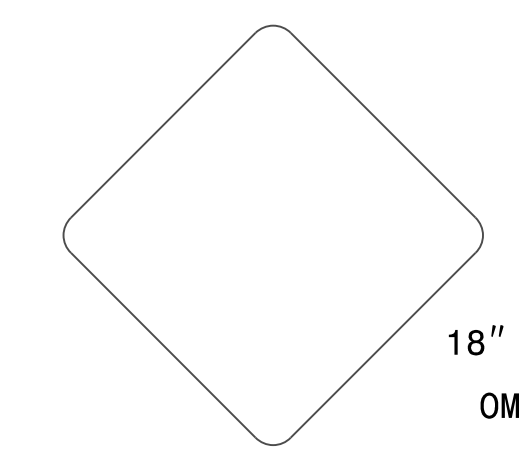

18" X 18"
OM1-3

MOUNT BELOW SIGN #405

TIP NO. U-4405A	SHEET NO. SIGN-2A
APPROVED: <i>Betsy L. Watson</i> 3/4/2019	
DATE: 3/4/2019	
SEAL 	
DOCUMENT NOT CONSIDERED FINAL UNLESS ALL SIGNATURES COMPLETED	



407 QUANTITY REQ'D 15



36" X 36"
R5-1

ONE "U" POST PER SIGN

408 QUANTITY REQ'D 0



24" X 12"
W16-9p

ONE "U" POST PER SIGN

409 QUANTITY REQ'D 9



30" X 36"
R2-1

ONE "U" POST PER SIGN


410 QUANTITY REQ'D 4



30" X 36"
R2-1

ONE "U" POST PER SIGN

411 QUANTITY REQ'D 5

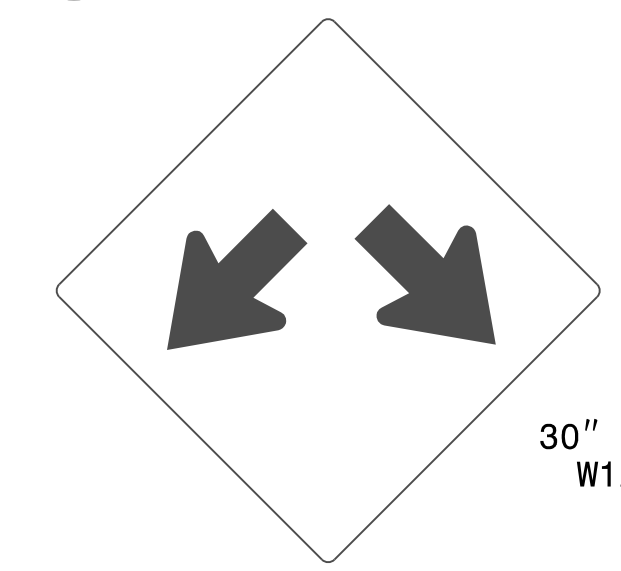

30" X 30"
W12-1

ONE "U" POST PER SIGN

412 QUANTITY REQ'D 12



36" X 36"
R3-7


ONE "U" POST PER SIGN

413 QUANTITY REQ'D 0



36" X 36"
R3-7


414 QUANTITY REQ'D 4

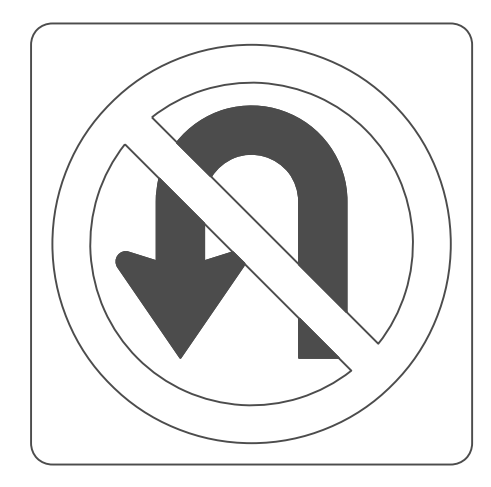

36" X 36"
R3-4

ONE "U" POST PER SIGN

415 QUANTITY REQ'D 0

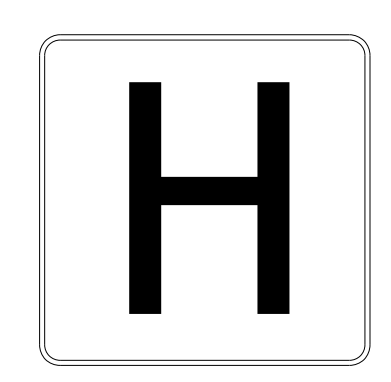

24" X 24"
D9-2

ONE "U" POST PER SIGN


416 QUANTITY REQ'D 0



24" X 12"
D9-13dP

ONE "U" POST PER SIGN


417 QUANTITY REQ'D 0

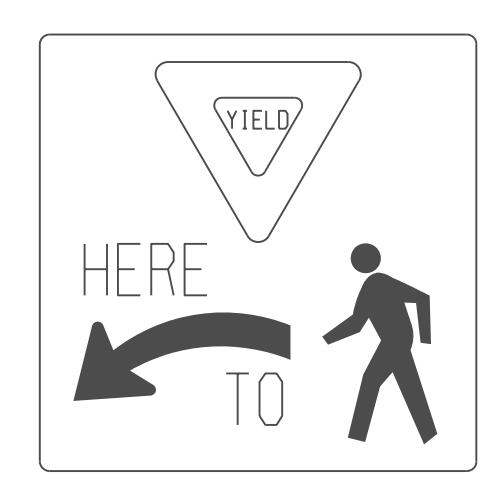

36" X 36"
R1-5

ONE "U" POST PER SIGN

418 QUANTITY REQ'D 4

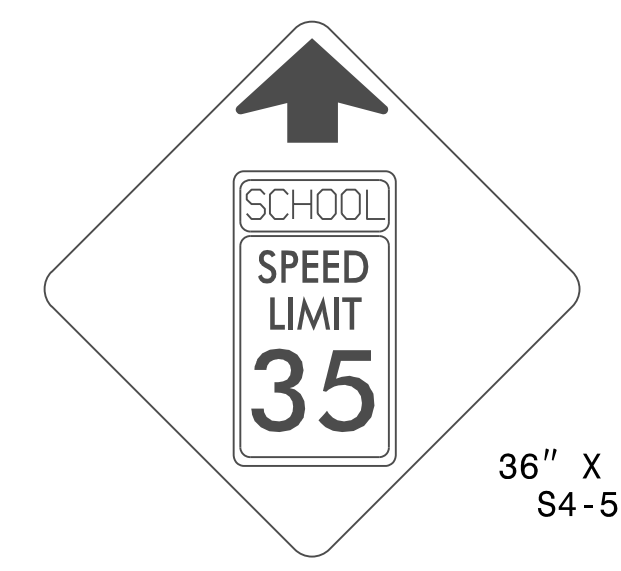

36" X 36"
S4-5

ONE "U" POST PER SIGN

419 QUANTITY REQ'D 7



36" X 36"
S1-1

ONE "U" POST PER SIGN


420 QUANTITY REQ'D 7



24" X 8"
S4-3p

(MOUNT BELOW SIGN #419 IN
3 INSTALLATIONS)
(MOUNT ABOVE SIGN #410 IN
4 INSTALLATIONS)


421 QUANTITY REQ'D 2

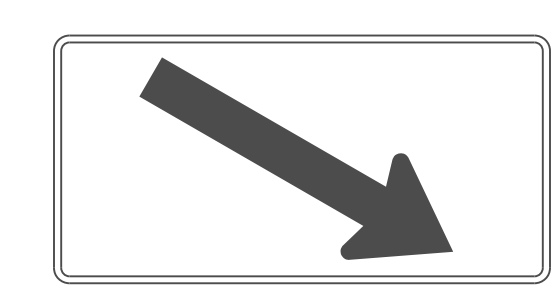

24" X 12"
W16-7p

(MOUNT BELOW SIGN #419
IN 2 INSTALLATIONS)

422 QUANTITY REQ'D 2

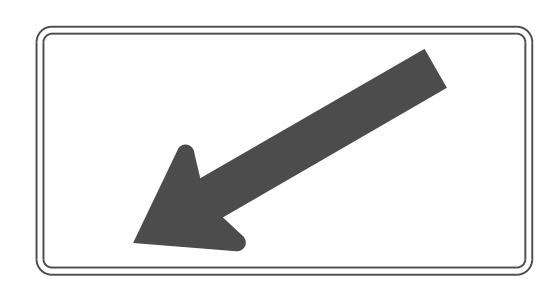

24" X 12"
W16-7p

(MOUNT BELOW SIGN #419
IN 2 INSTALLATIONS)


423 QUANTITY REQ'D 1



24" X 48"
S5-1

SIGN TO BE MOUNTED ON A
SUPPORT WITH A FLASHER ASSEMBLY.


424 QUANTITY REQ'D 2

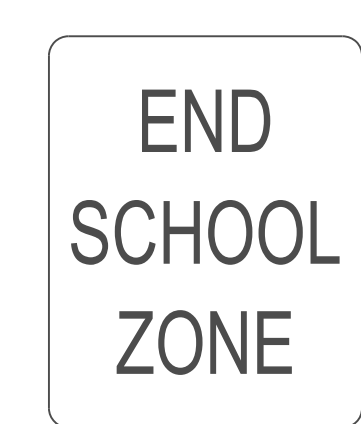

24" X 30"
S5-2

ONE "U" POST PER SIGN


425 QUANTITY REQ'D 4

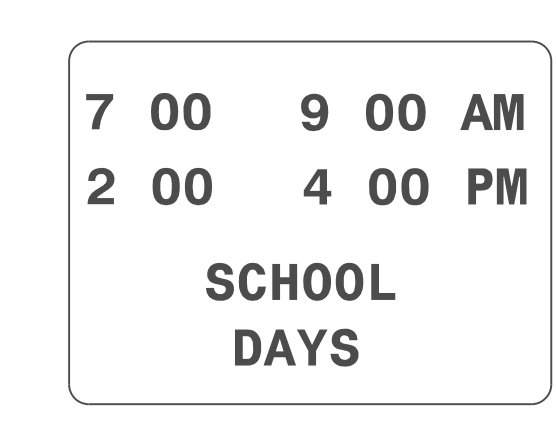

24" X 10"
S4-1p


(MOUNT BELOW SIGN #410
IN 4 INSTALLATIONS)

426 QUANTITY REQ'D 0

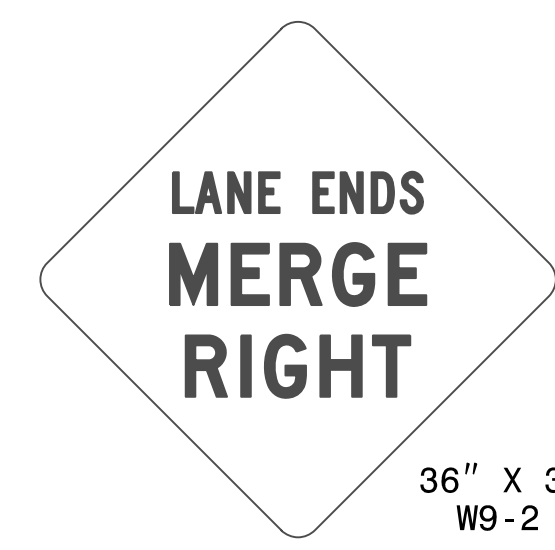


36" X 36"
W9-2

427 QUANTITY REQ'D 0

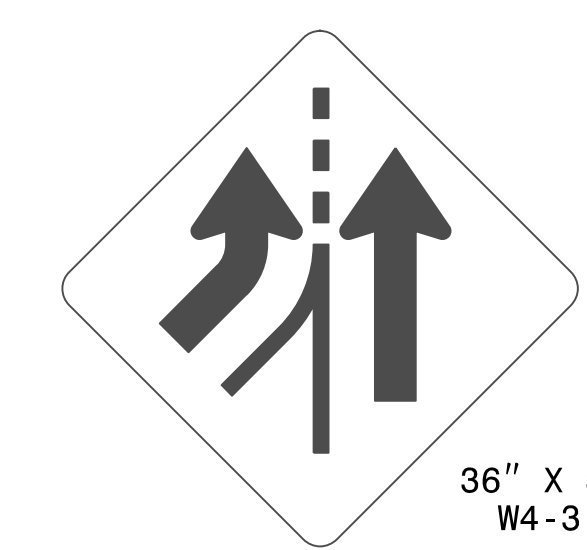


36" X 36"
W4-3

428 QUANTITY REQ'D 0

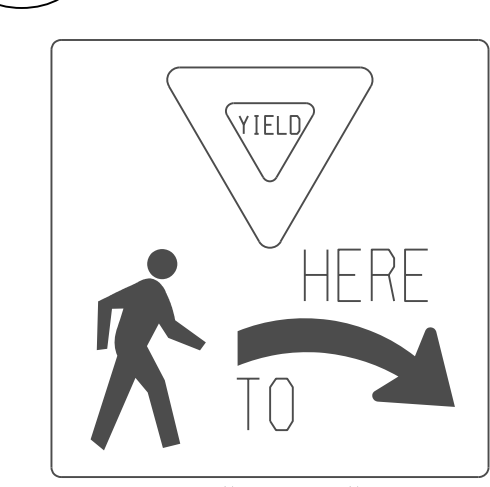

36" X 36"
R1-5


429 QUANTITY REQ'D 1

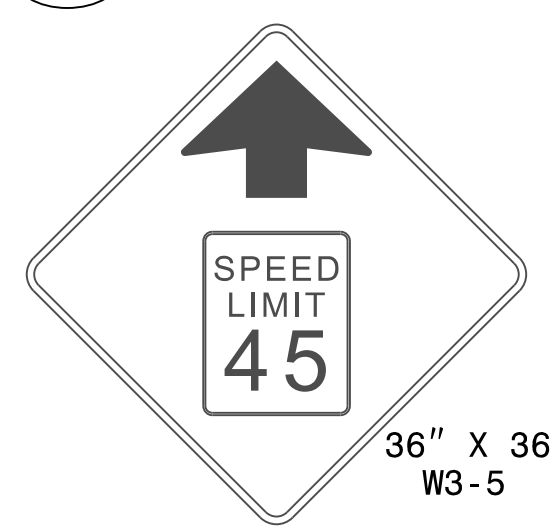

36" X 36"
W3-5

ONE "U" POST PER SIGN

430 QUANTITY REQ'D 0

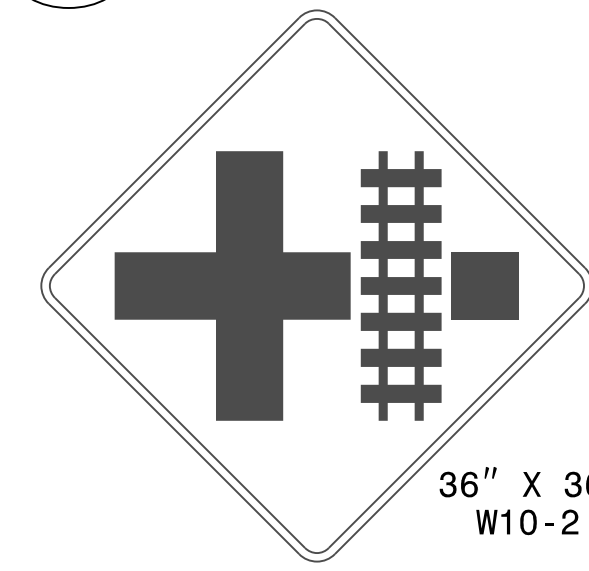


36" X 36"
W10-2

431 QUANTITY REQ'D 0



24" X 30"
R8-8


432 QUANTITY REQ'D 0

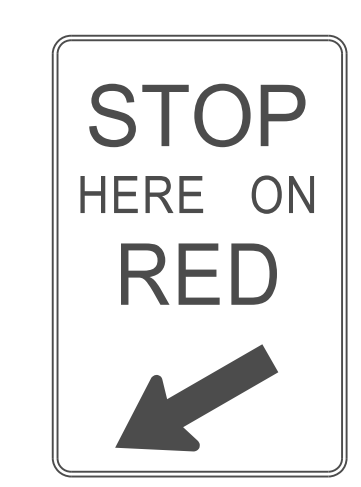

24" X 36"
R10-6

TYPE "E" SIGNS

433 QUANTITY REQ'D 0_

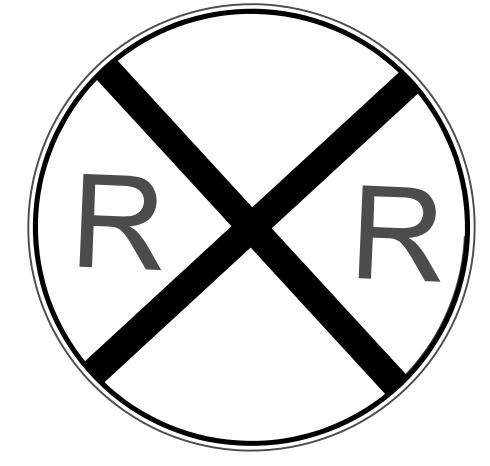


36" Diameter
W10-2

434 QUANTITY REQ'D 0_



24" X 12"
S4-7p

435 QUANTITY REQ'D 0_

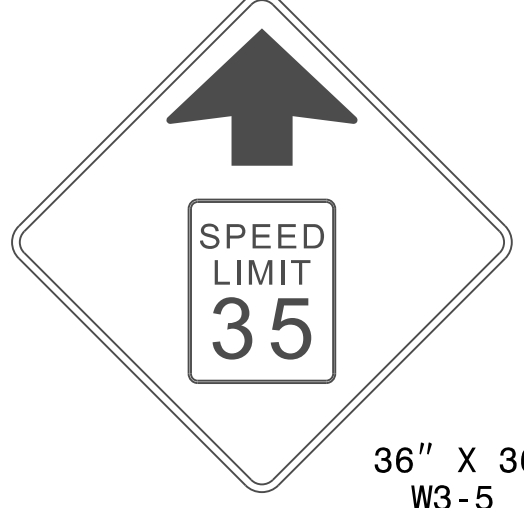

36" X 36"
W3-5

308 QUANTITY REQ'D 4_




24" X 12"

(SEE SIGN DESIGN #308, SHEET SIGN-4)

(MOUNT BELOW SIGN #414
IN 4 INSTALLATIONS)

309 QUANTITY REQ'D 0_

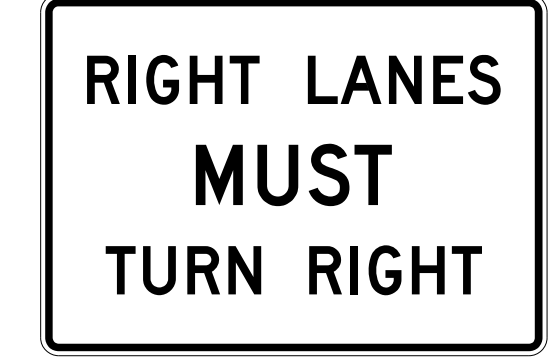

36" X 30"

TIP NO. SHEET NO.

U-4405A SIGN-2B

DocuSigned by:
APPROVED: *Betsy L. Watson*

DATE: 3/4/2019

 




DOCUMENT NOT CONSIDERED FINAL
UNLESS ALL SIGNATURES COMPLETED




2/25/2019
Us:\Tr\offic\Signing\CA00\Signing\U-4405A\Signing Plan Sheets\Proposed Signing\U-4405 Title Sheet and Details.dgn
Inamberight

TYPE "E" SIGNS


TIP NO. U-4405A	SHEET NO. SIGN-3
APPROVED:  <small>—SSE87B834F8743F—</small>	
DATE: 7/7/2021	
SEAL 	
DOCUMENT NOT CONSIDERED FINAL UNLESS ALL SIGNATURES COMPLETED	
	

501 QUANTITY REQ'D 3

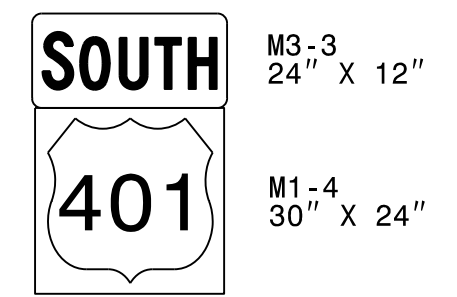


ONE "U" POST PER ASSEMBLY

502 QUANTITY REQ'D 2

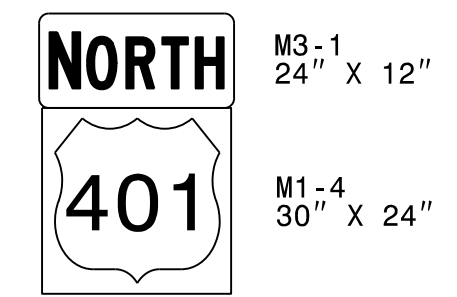


ONE "U" POST PER ASSEMBLY

503 QUANTITY REQ'D 2

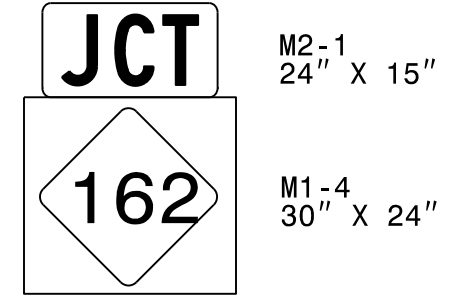


ONE "U" POSTS PER ASSEMBLY

504 QUANTITY REQ'D 1

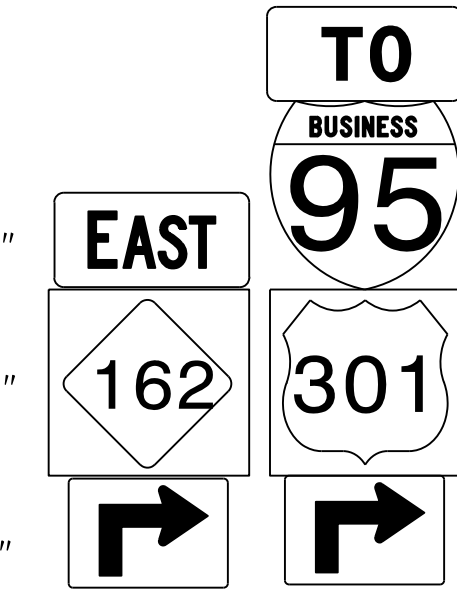


TWO "U" POST PER ASSEMBLY

505 QUANTITY REQ'D 1

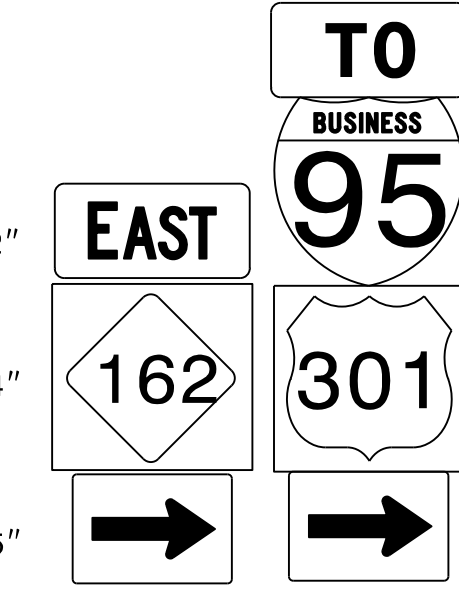


TWO "U" POST PER ASSEMBLY

506 QUANTITY REQ'D 1

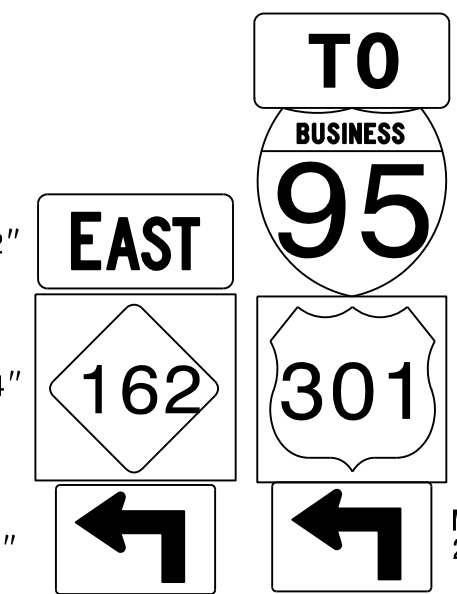

TWO "U" POST PER ASSEMBLY

507 QUANTITY REQ'D 1

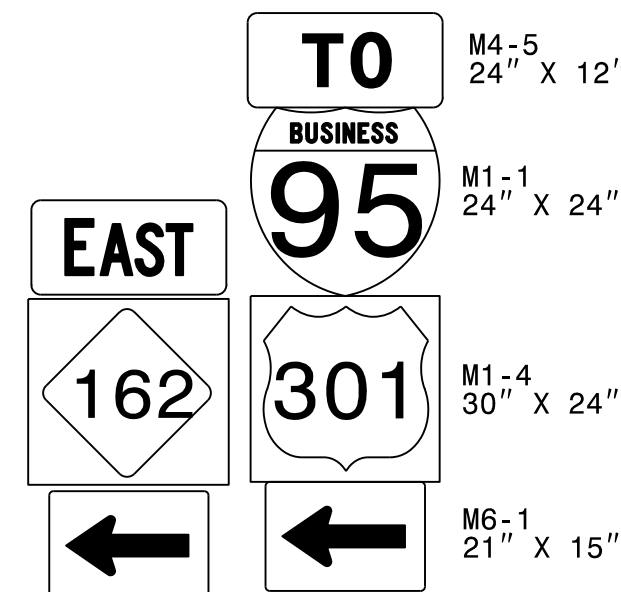

TWO "U" POSTS PER ASSEMBLY

TYPE "F" SIGNS

7/7/2021 U:\Traffic\Signing\CA00\Signing\U-4405A Revised\Signing Plan Sheets\Proposed Signing\U-4405A Revised Title Sheet and F Assembly Sheet.dgn

TIP NO. U-4405A	SHEET NO. SIGN-4
APPROVED: <i>Betsy L. Watson</i> 35E7BB34F8743F...	
DATE: 3/4/2019	
DOCUMENT NOT CONSIDERED FINAL UNLESS ALL SIGNATURES COMPLETED	



SIGN NUMBER: 301 **BACKG COLOR: Green** **COPY COLOR: White** **PROJECT ID: U-4405A** **CHECKED BY: Name** **DIVISION: 6**
TYPE: D **QUANTITY: 1** **DESIGN BY: James Hambricht** **DATE: Aug 04, 2017**
LOCATION: Sign Location

SYMBOL	X	Y	WID	HT
AR_Type D	50.8	6	6	9

SIGN WIDTH: 5'-6"
HEIGHT: 1'-6"
TOTAL AREA: 8.3 Sq.Ft.

BORDER TYPE: FLUSH
RECESS: 0"
WIDTH: 0.75"
RADII: 3"

MAT'L: 0.125" (3.2 mm) ALUMINUM

No. Z BARS:
LENGTH:

NOTES:

- Legend and border shall be direct applied, Grade "C" sheeting (except those that are colored black).
- Background shall be Grade "C" reflective sheeting.

Panel Style: Standard 6 Inch_D.ssi
M.U.T.C.D.: 2009 Edition

LETTER POSITIONS

Letter spacings are to start of next letter

Series/Size	Text Length
D 2000	38.6

6.2	5.2	4.6	4.3	3.5	6	6	2.2	2.2	1.8	2.8	21.2
H o p e M i l l s											

FILENAME: U-4405 Sign Designs NORTH CAROLINA D.O.T. SIGN DETAIL

SIGN NUMBER: 302 **BACKG COLOR: Green** **COPY COLOR: White** **PROJECT ID: U-4405A** **CHECKED BY: Name** **DIVISION: 6**
TYPE: D **QUANTITY: 1** **DESIGN BY: James Hambricht** **DATE: Jan 02, 2018**
LOCATION: US 401 Business Southbound

SYMBOL	X	Y	WID	HT
AR_Type D	6.2	22.3	6	9
AR_Type D	6.2	6.2	6	9

SIGN WIDTH: 5'-6"
HEIGHT: 3'-0"
TOTAL AREA: 16.5 Sq.Ft.

BORDER TYPE: FLUSH
RECESS: 0"
WIDTH: 0.75"
RADII: 3"

MAT'L: 0.125" (3.2 mm) ALUMINUM

No. Z BARS:
LENGTH:

NOTES:

- Legend and border shall be direct applied, Grade "C" sheeting (except those that are colored black).
- Background shall be Grade "C" reflective sheeting.

Panel Style: Standard 6 Inch_D.ssi
M.U.T.C.D.: 2009 Edition

LETTER POSITIONS

Letter spacings are to start of next letter

Series/Size	Text Length
D 2000	26.6
D 2000	38.6

18.2	4.7	4.3	4	2.6	4.6	2.8	3.6	21.1			
R a e f o r d											
21.2	5.2	4.6	4.3	3.5	6	6	2.2	2.2	1.8	2.8	6.2
H o p e M i l l s											

FILENAME: U-4405 Sign Designs NORTH CAROLINA D.O.T. SIGN DETAIL

SIGN NUMBER: 308 **BACKG COLOR: White** **COPY COLOR: Black** **PROJECT ID: U-4405A** **CHECKED BY:** **DIVISION: 6**
TYPE: E **QUANTITY: 4** **DESIGN BY: James Hambricht** **DATE: Oct 27, 2017**
LOCATION: SEE SHEET SIGN-3B

SYMBOL	X	Y	WID	HT

SIGN WIDTH: 2'-0"
HEIGHT: 1'-0"
TOTAL AREA: 2.0 Sq.Ft.

BORDER TYPE: RECESSED
RECESS: 0.38"
WIDTH: 0.63"
RADII: 1.13"

MAT'L: 0.063" (1.6 mm) ALUMINUM

No. Z BARS:
LENGTH:

NOTES:

- Legend and border shall be silk screened opaque black ink.
- Background shall be Grade "C" reflective sheeting.

Panel Style: regulatory.ssi
M.U.T.C.D.: 2009 Edition

LETTER POSITIONS

Letter spacings are to start of next letter

Series/Size	Text Length
D 2000	19.6


2.2	3.1	3.4	3.6	3.6	3.2	2.7	2.2
T R U C K S							

FILENAME: U-4405 Sign Designs NORTH CAROLINA D.O.T. SIGN DETAIL

SIGN DESIGNS

2/25/2019 U:\Traffic\Signing\CADD\Signing\U-4405A\Sign Designs\Sign Design Plan Sheets.dgn jhambricht

TIP NO. U-4405A	SHEET NO. SIGN-5
APPROVED: <i>Petsy L. Watson</i> 35E87BB34F8743F...	
DATE: 3/4/2019	
SEAL	
DOCUMENT NOT CONSIDERED FINAL UNLESS ALL SIGNATURES COMPLETED	

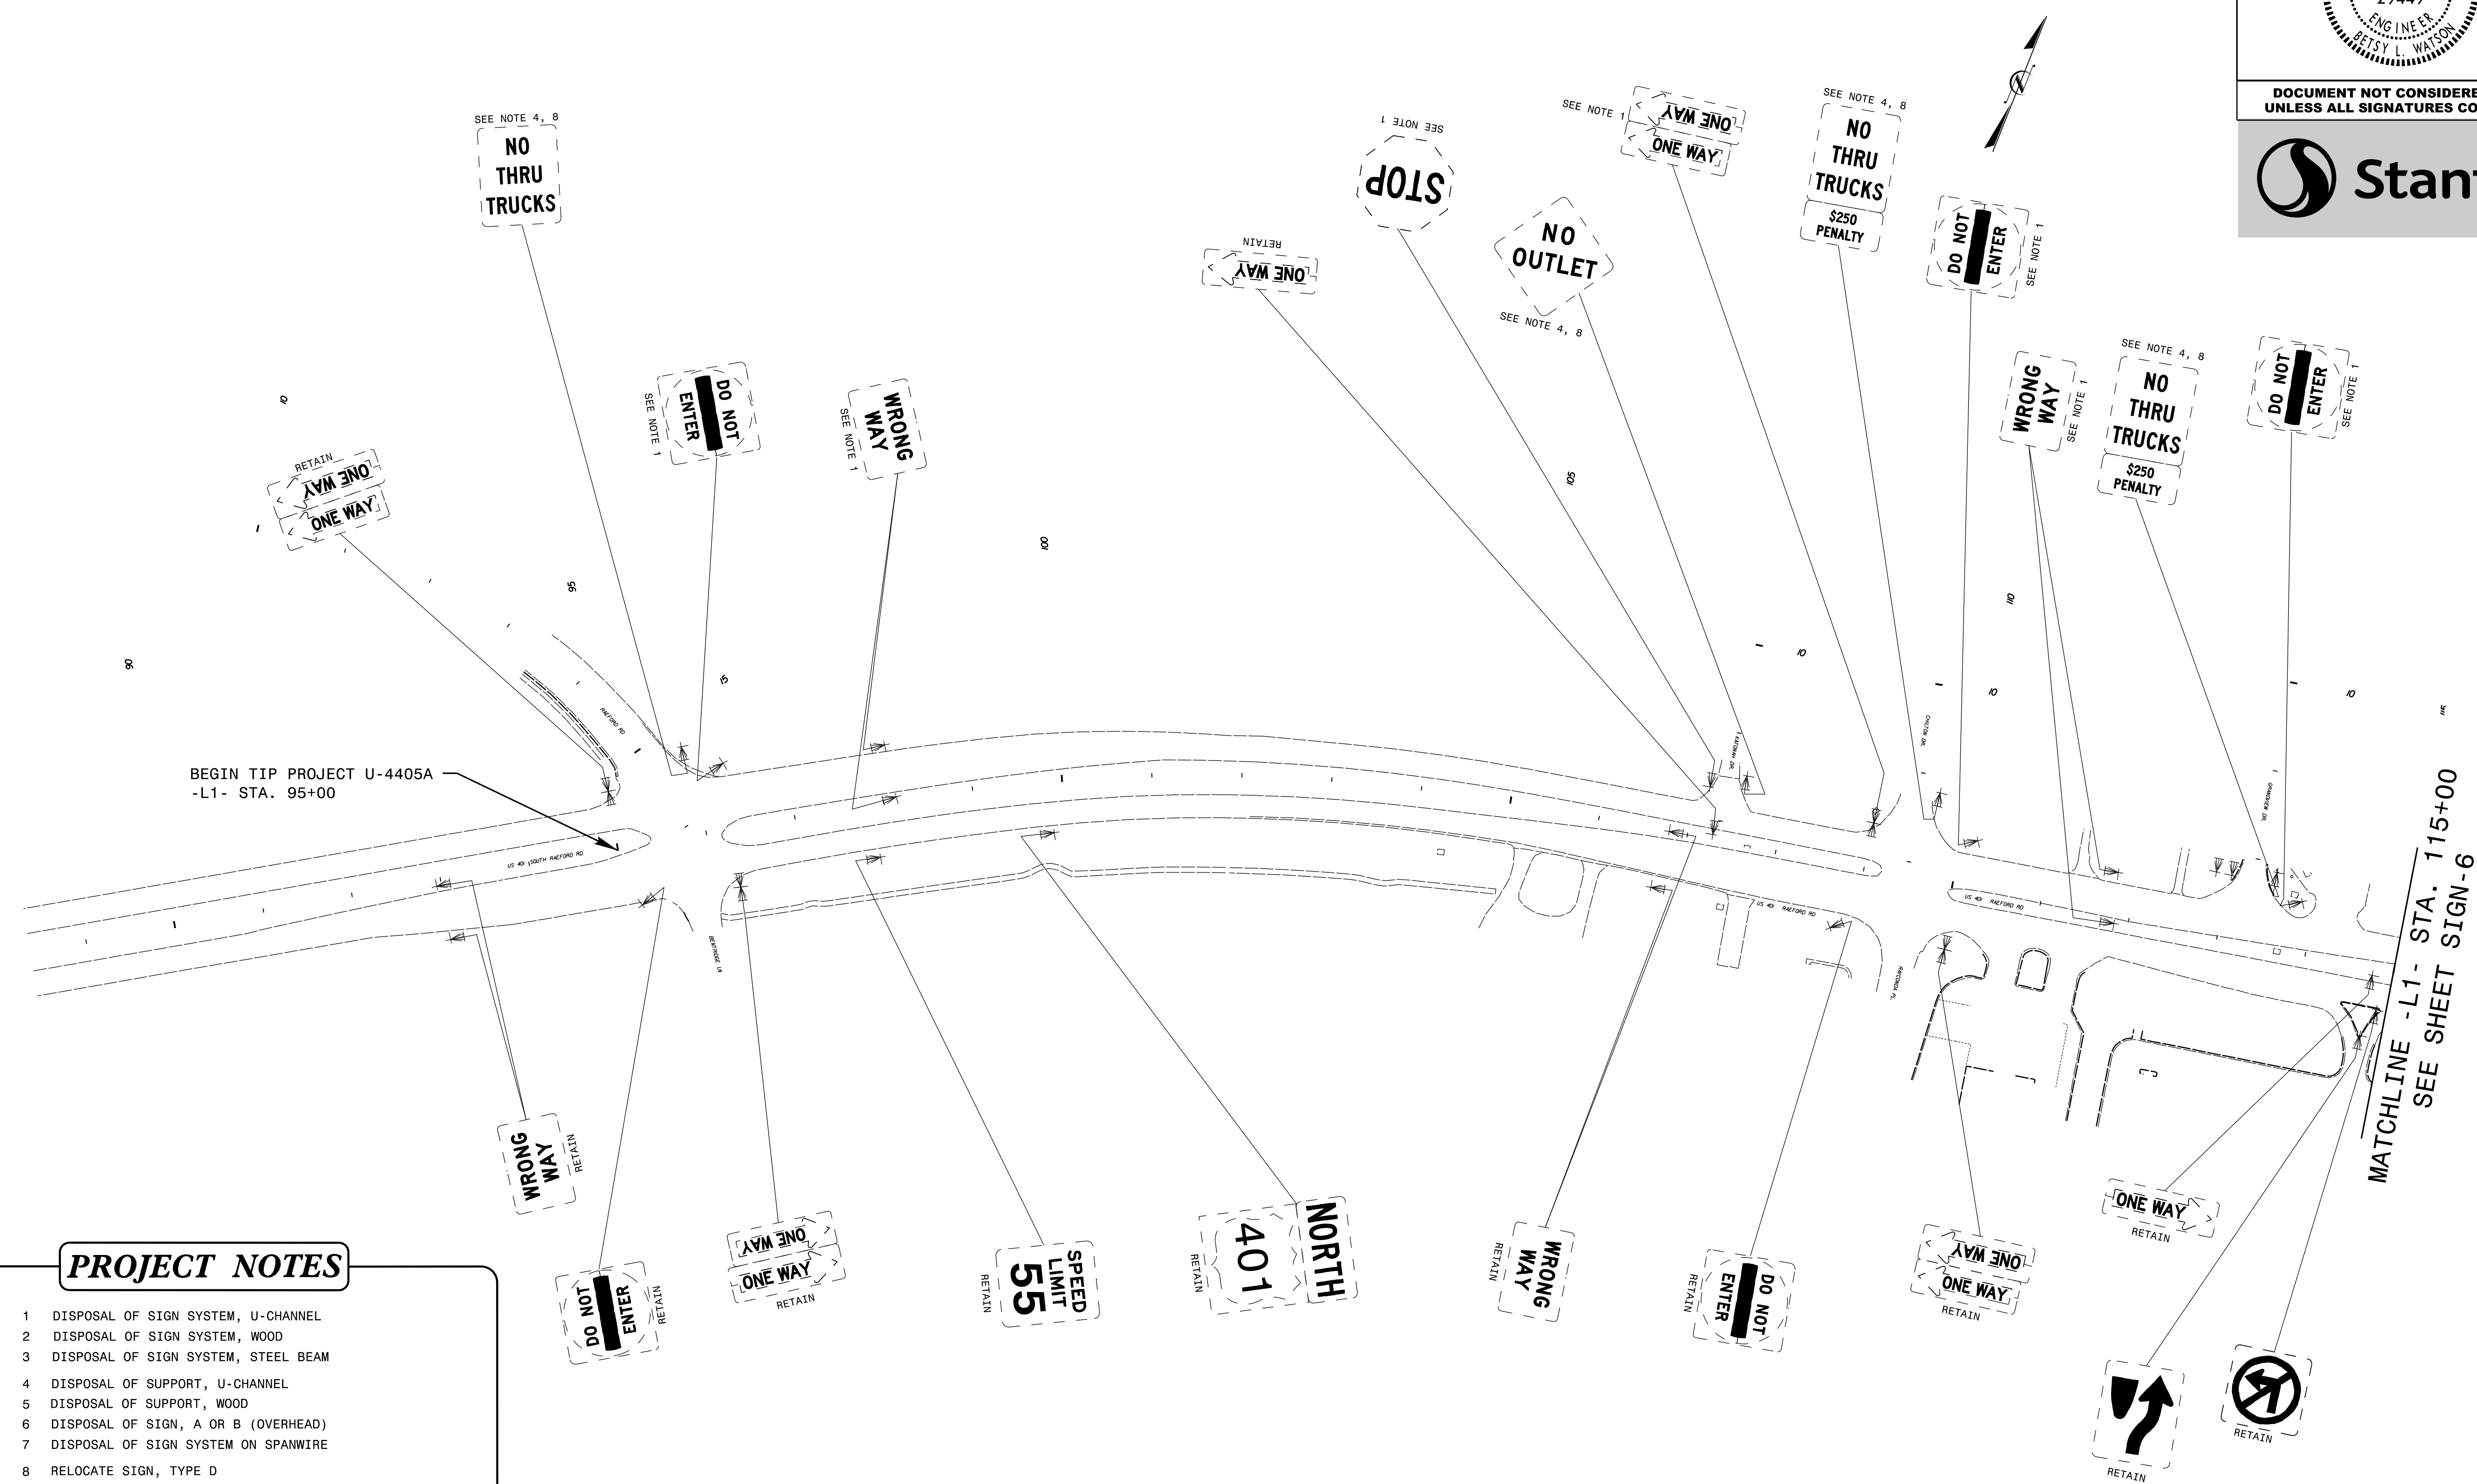

PROJECT NOTES

- 1 DISPOSAL OF SIGN SYSTEM, U-CHANNEL
- 2 DISPOSAL OF SIGN SYSTEM, WOOD
- 3 DISPOSAL OF SIGN SYSTEM, STEEL BEAM
- 4 DISPOSAL OF SUPPORT, U-CHANNEL
- 5 DISPOSAL OF SUPPORT, WOOD
- 6 DISPOSAL OF SIGN, A OR B (OVERHEAD)
- 7 DISPOSAL OF SIGN SYSTEM ON SPANWIRE
- 8 RELOCATE SIGN, TYPE D
- 9 SIGN ERECTION, TYPE A (OVERHEAD)
- 10 SIGN ERECTION, TYPE A (GROUND MOUNTED)
- 11 SIGN ERECTION, TYPE D, E, AND F
- 12 SIGN ERECTION, RELOCATE SIGN TYPE D

EXISTING SIGNING


2/25/2019
 U:\Traffic\Signing\CADD\Signing\U-4405A\Signing Plan Sheets\Existing Signs\U-4405A_EXISTING_SIGN_05.dgn
 jhambright

BEGIN TIP PROJECT U-4405A
-L1- STA. 95+00


MATCHLINE -L1- STA. 115+00
SEE SHEET SIGN-6


TIP NO.	SHEET NO.
U-4405A	SIGN-6
APPROVED: <i>Betsy L. Watson</i> 35E7BB34F8743F...	
DATE: 3/4/2019	
SEAL	
DOCUMENT NOT CONSIDERED FINAL UNLESS ALL SIGNATURES COMPLETED	

- PROJECT NOTES**
- DISPOSAL OF SIGN SYSTEM, U-CHANNEL
 - DISPOSAL OF SIGN SYSTEM, WOOD
 - DISPOSAL OF SIGN SYSTEM, STEEL BEAM
 - DISPOSAL OF SUPPORT, U-CHANNEL
 - DISPOSAL OF SUPPORT, WOOD
 - DISPOSAL OF SIGN, A OR B (OVERHEAD)
 - DISPOSAL OF SIGN SYSTEM ON SPANWIRE
 - RELOCATE SIGN, TYPE D
 - SIGN ERECTION, TYPE A (OVERHEAD)
 - SIGN ERECTION, TYPE A (GROUND MOUNTED)
 - SIGN ERECTION, TYPE D, E, AND F
 - SIGN ERECTION, RELOCATE SIGN TYPE D

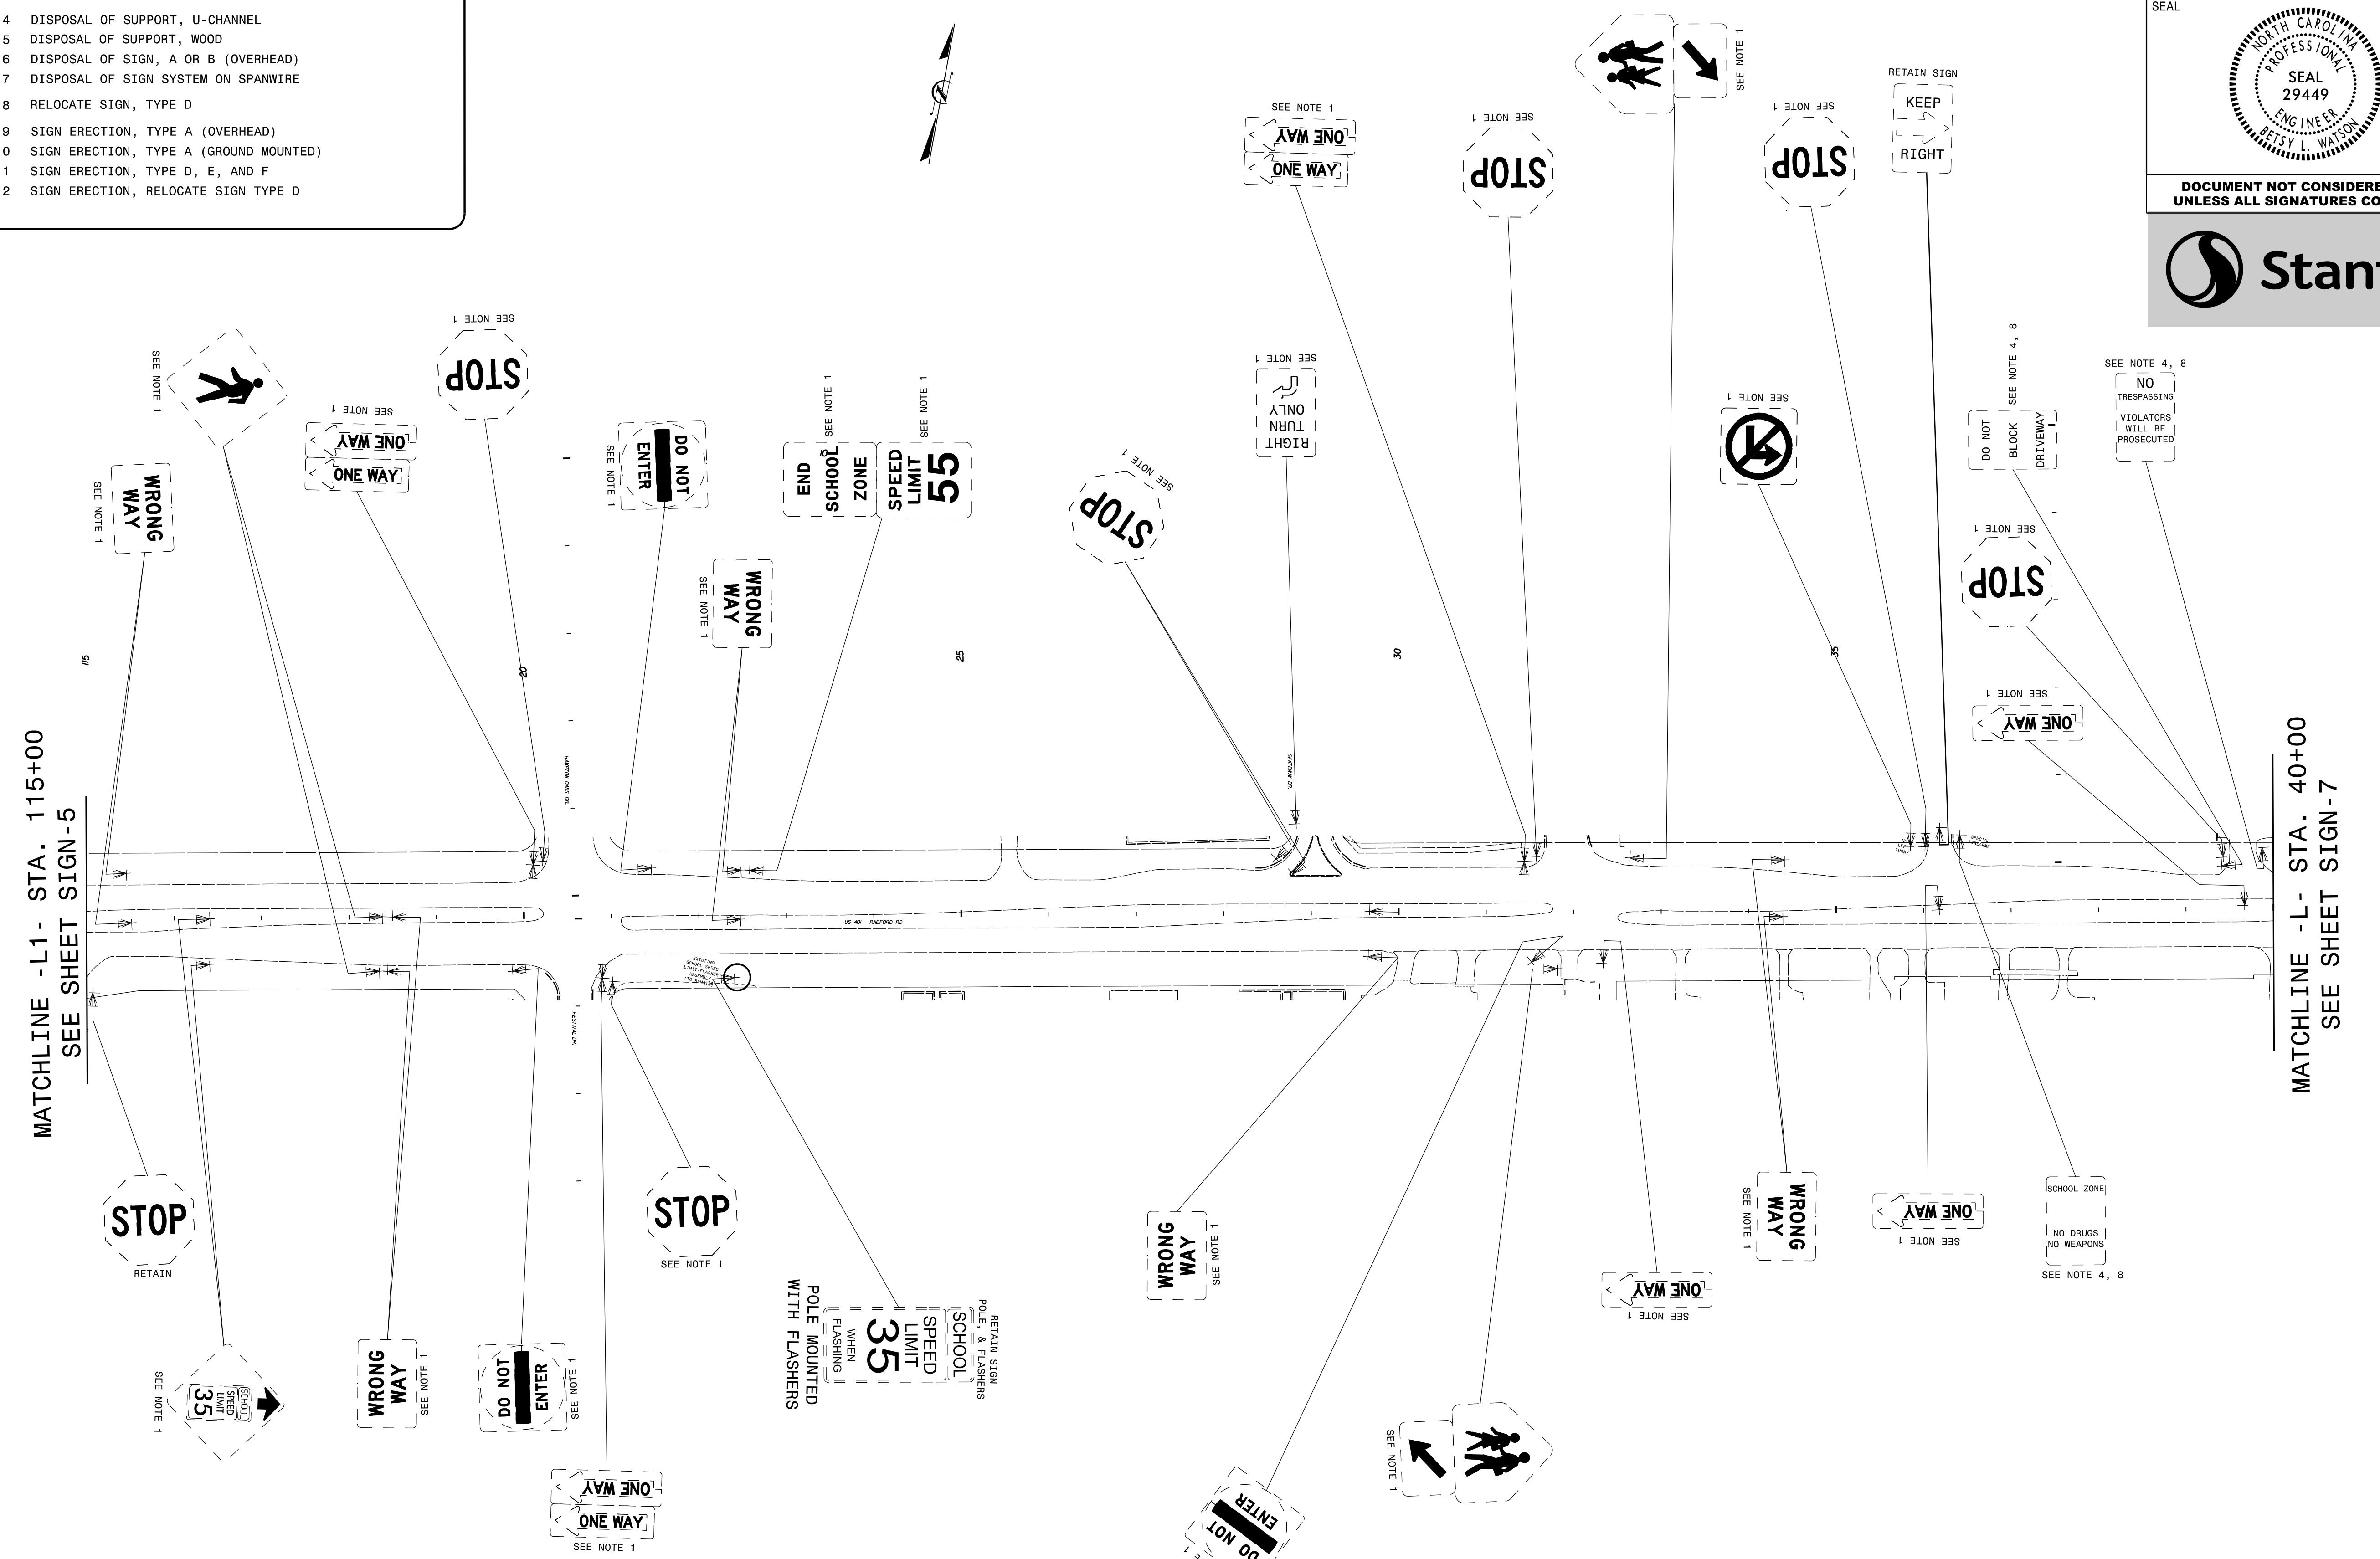

EXISTING SIGNING

TIP NO. U-4405A	SHEET NO. SIGN-7
APPROVED: <i>Betsy L. Watson</i> 35E78B34F743F...	
DATE: 3/4/2019	
SEAL 	
DOCUMENT NOT CONSIDERED FINAL UNLESS ALL SIGNATURES COMPLETED	

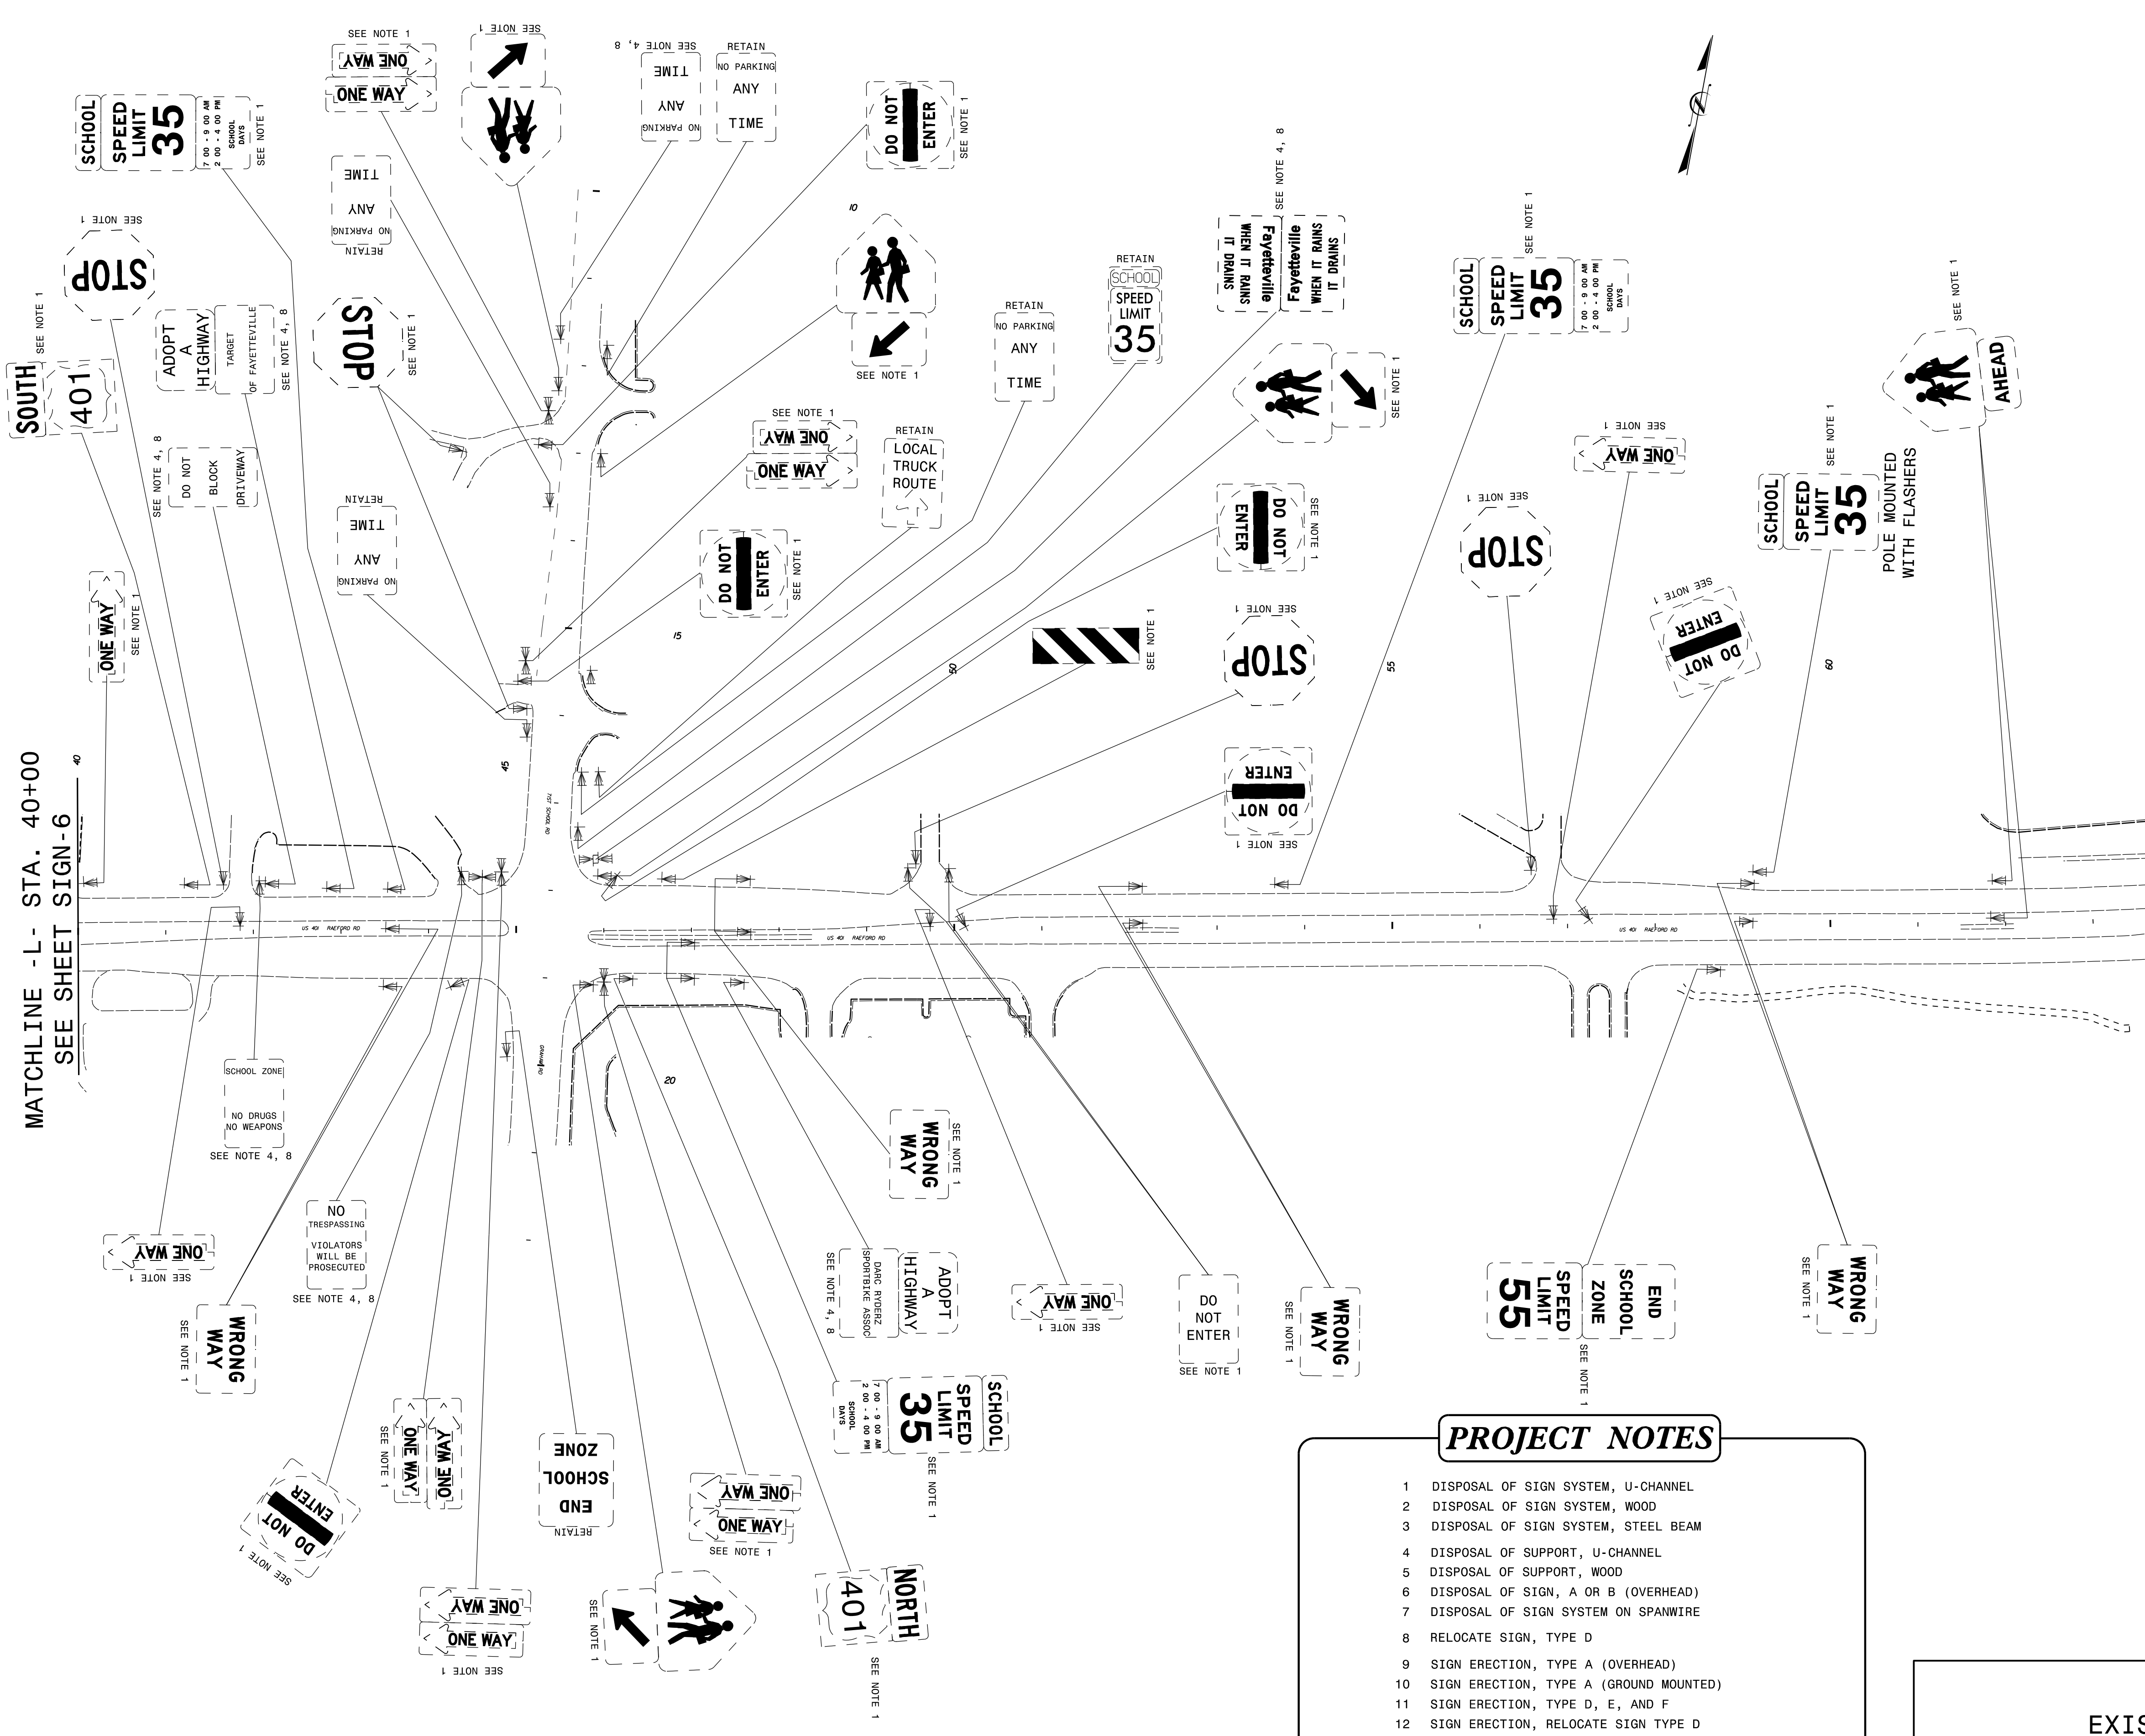


- PROJECT NOTES**
- DISPOSAL OF SIGN SYSTEM, U-CHANNEL
 - DISPOSAL OF SIGN SYSTEM, WOOD
 - DISPOSAL OF SIGN SYSTEM, STEEL BEAM
 - DISPOSAL OF SUPPORT, U-CHANNEL
 - DISPOSAL OF SUPPORT, WOOD
 - DISPOSAL OF SIGN, A OR B (OVERHEAD)
 - DISPOSAL OF SIGN SYSTEM ON SPANWIRE
 - RELOCATE SIGN, TYPE D
 - SIGN ERECTION, TYPE A (OVERHEAD)
 - SIGN ERECTION, TYPE A (GROUND MOUNTED)
 - SIGN ERECTION, TYPE D, E, AND F
 - SIGN ERECTION, RELOCATE SIGN TYPE D


EXISTING SIGNING

2/25/2019
L:\Traffic\Signing\CADD\Signing\U-4405A\Signing Plan Sheets\Existing Signs\U-4405A_EXISTING_SIGN_07.dgn
Inambari

MATCHLINE -L- STA. 40+00
SEE SHEET SIGN-6

MATCHLINE -L- STA. 65+00
SEE SHEET SIGN-8

TIP NO. U-4405A	SHEET NO. SIGN-8
APPROVED: <i>Betsy L. Watson</i> 35E78B34F8743F...	
DATE: 3/4/2019	
SEAL	
	
DOCUMENT NOT CONSIDERED FINAL UNLESS ALL SIGNATURES COMPLETED	

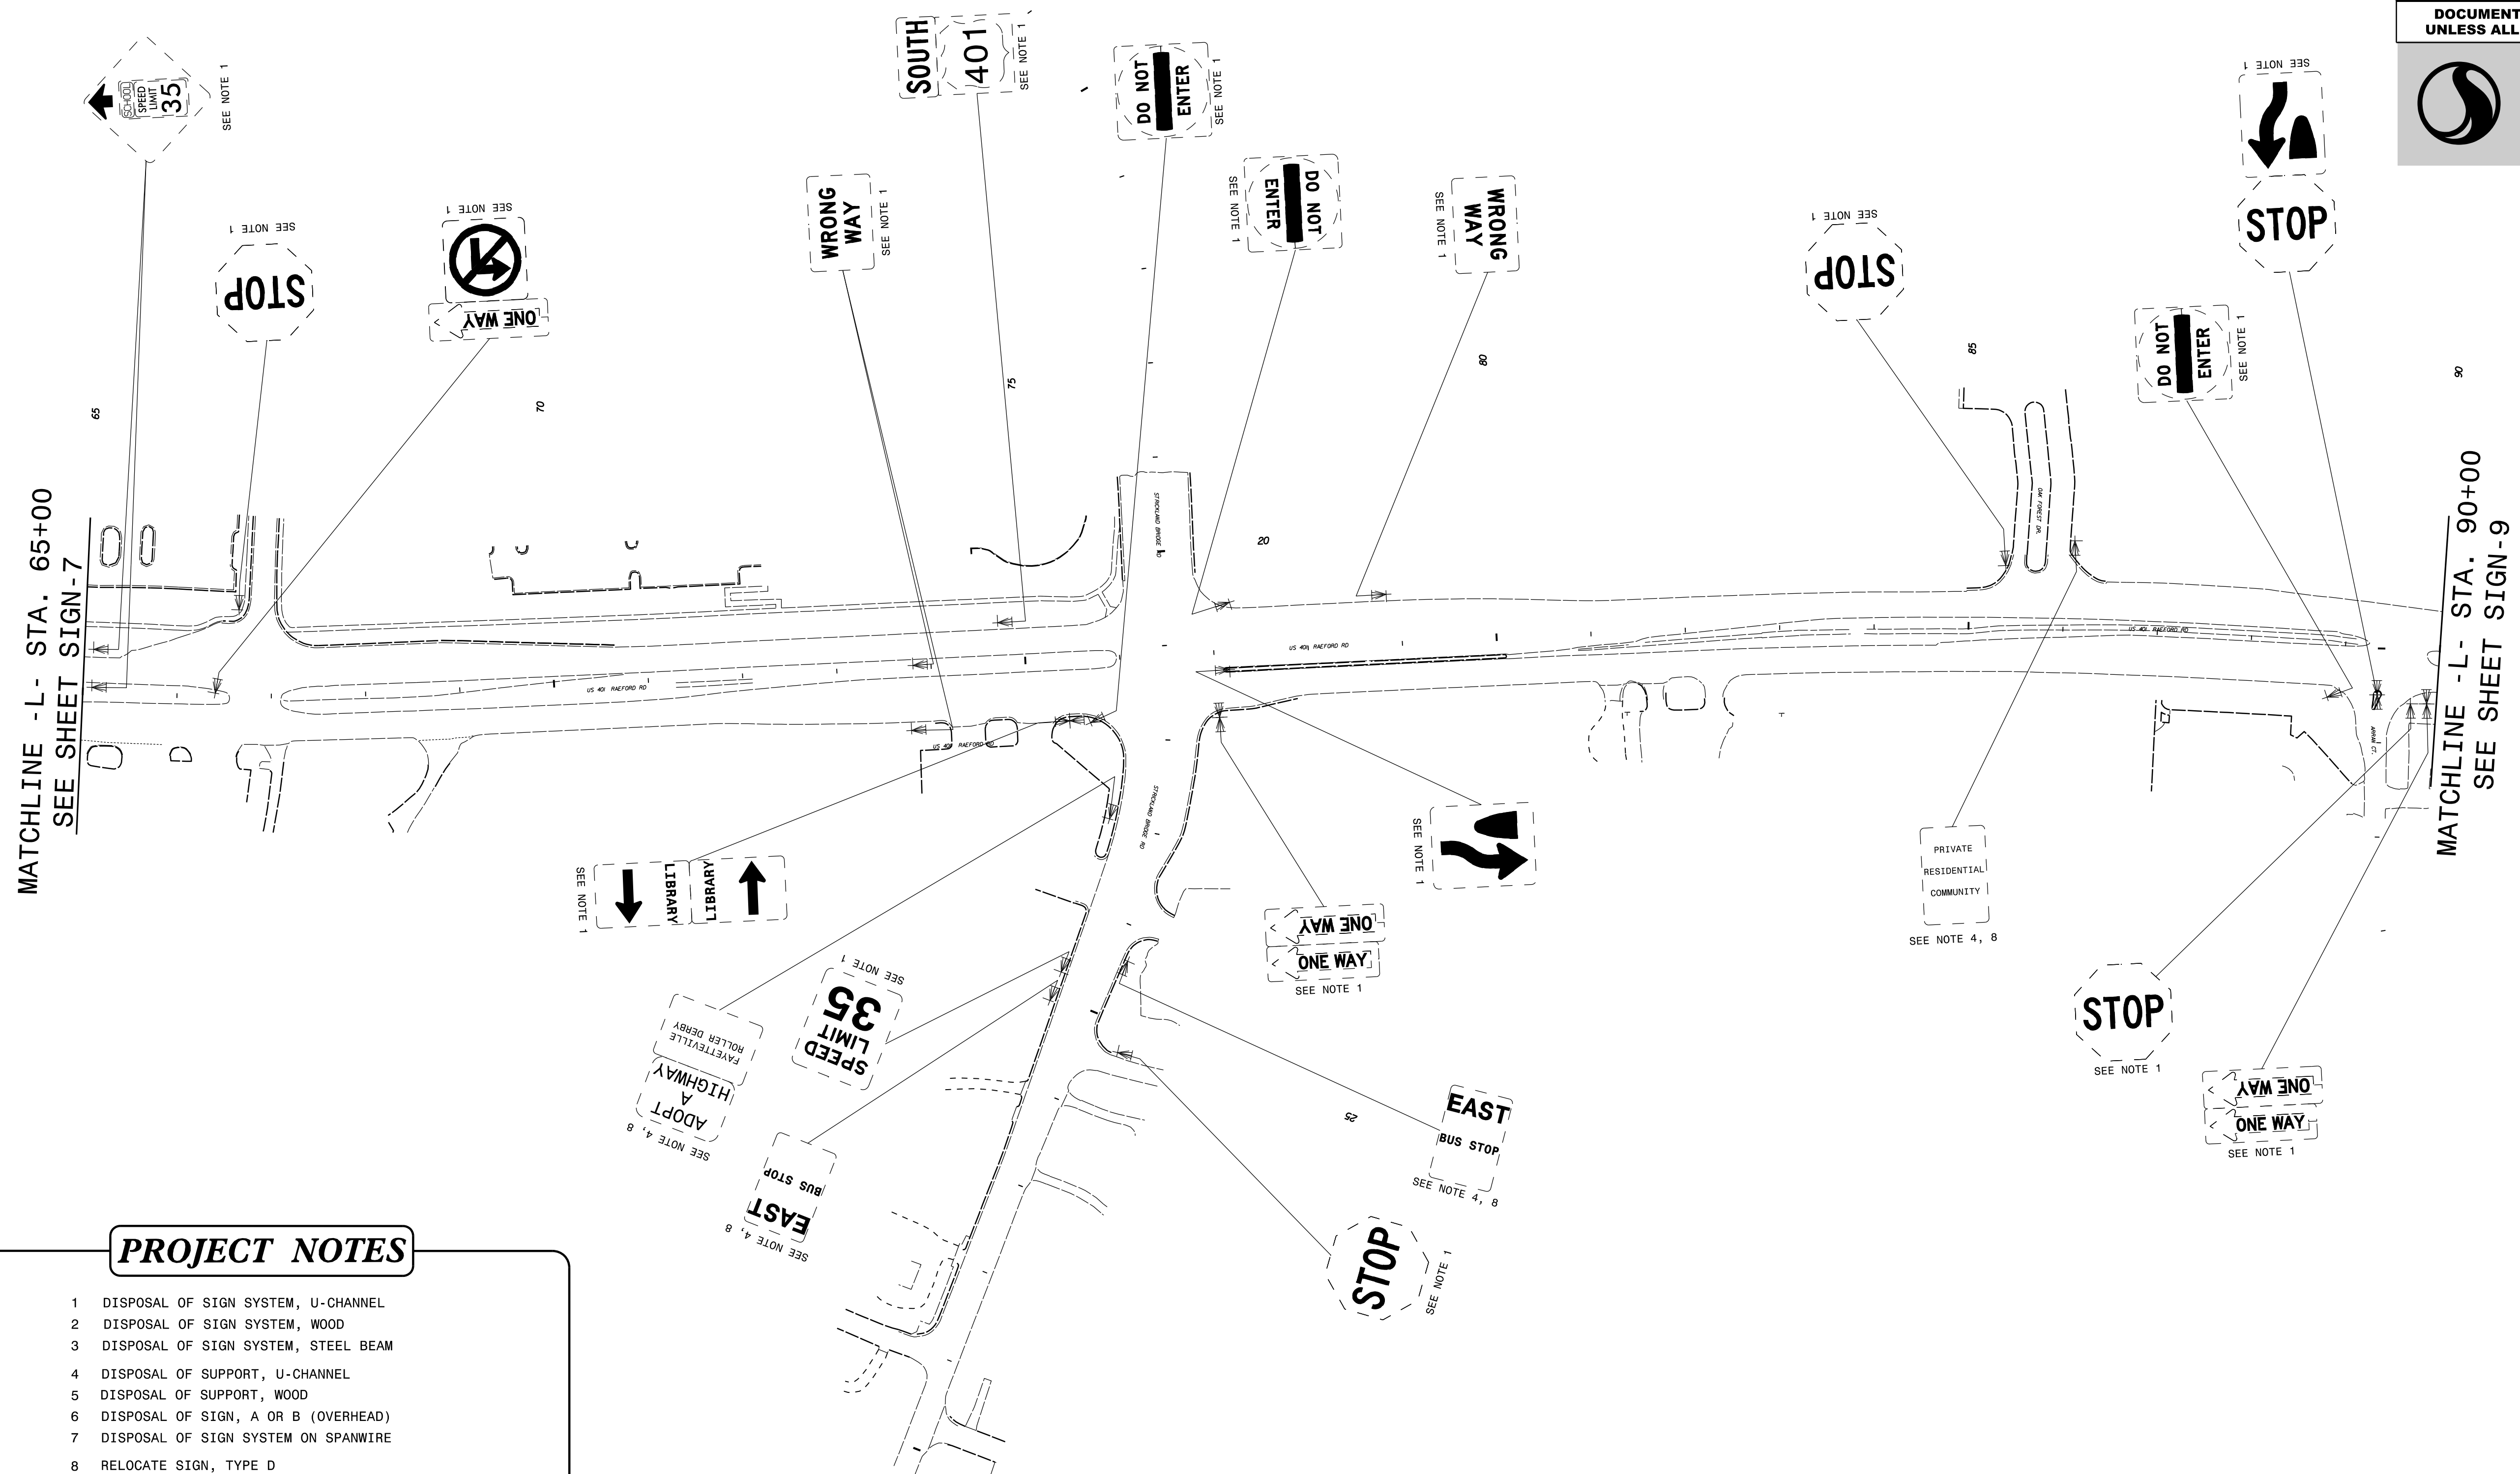

- PROJECT NOTES**
- DISPOSAL OF SIGN SYSTEM, U-CHANNEL
 - DISPOSAL OF SIGN SYSTEM, WOOD
 - DISPOSAL OF SIGN SYSTEM, STEEL BEAM
 - DISPOSAL OF SUPPORT, U-CHANNEL
 - DISPOSAL OF SUPPORT, WOOD
 - DISPOSAL OF SIGN, A OR B (OVERHEAD)
 - DISPOSAL OF SIGN SYSTEM ON SPANWIRE
 - RELOCATE SIGN, TYPE D
 - SIGN ERECTION, TYPE A (OVERHEAD)
 - SIGN ERECTION, TYPE A (GROUND MOUNTED)
 - SIGN ERECTION, TYPE D, E, AND F
 - SIGN ERECTION, RELOCATE SIGN TYPE D

EXISTING SIGNING

2/25/2019
L:\Traffic\Signing\CADD\Signing\U-4405A\Signing Plan Sheets\Existing Signs\U-4405A_EXISTING_SIGN_08.dgn
jhambright

TIP NO.	SHEET NO.
U-4405A	SIGN-9
APPROVED: <i>Betsy L. Watson</i>	
DATE: 3/4/2019	
SEAL	
DOCUMENT NOT CONSIDERED FINAL UNLESS ALL SIGNATURES COMPLETED	



MATCHLINE -L- STA. 90+00
SEE SHEET SIGN-8


END TIP PROJECT U-4405A
-L- STA. 108+00

PROJECT NOTES


- 1 DISPOSAL OF SIGN SYSTEM, U-CHANNEL
- 2 DISPOSAL OF SIGN SYSTEM, WOOD
- 3 DISPOSAL OF SIGN SYSTEM, STEEL BEAM
- 4 DISPOSAL OF SUPPORT, U-CHANNEL
- 5 DISPOSAL OF SUPPORT, WOOD
- 6 DISPOSAL OF SIGN, A OR B (OVERHEAD)
- 7 DISPOSAL OF SIGN SYSTEM ON SPANWIRE
- 8 RELOCATE SIGN, TYPE D
- 9 SIGN ERECTION, TYPE A (OVERHEAD)
- 10 SIGN ERECTION, TYPE A (GROUND MOUNTED)
- 11 SIGN ERECTION, TYPE D, E, AND F
- 12 SIGN ERECTION, RELOCATE SIGN TYPE D

EXISTING SIGNING

2/25/2019
L:\Traffic\Signing\CADD\Signing\U-4405A\Signing Plan Sheets\Existing Signs\U-4405A-EXISTING-SIGN-09.dgn
jhambricht

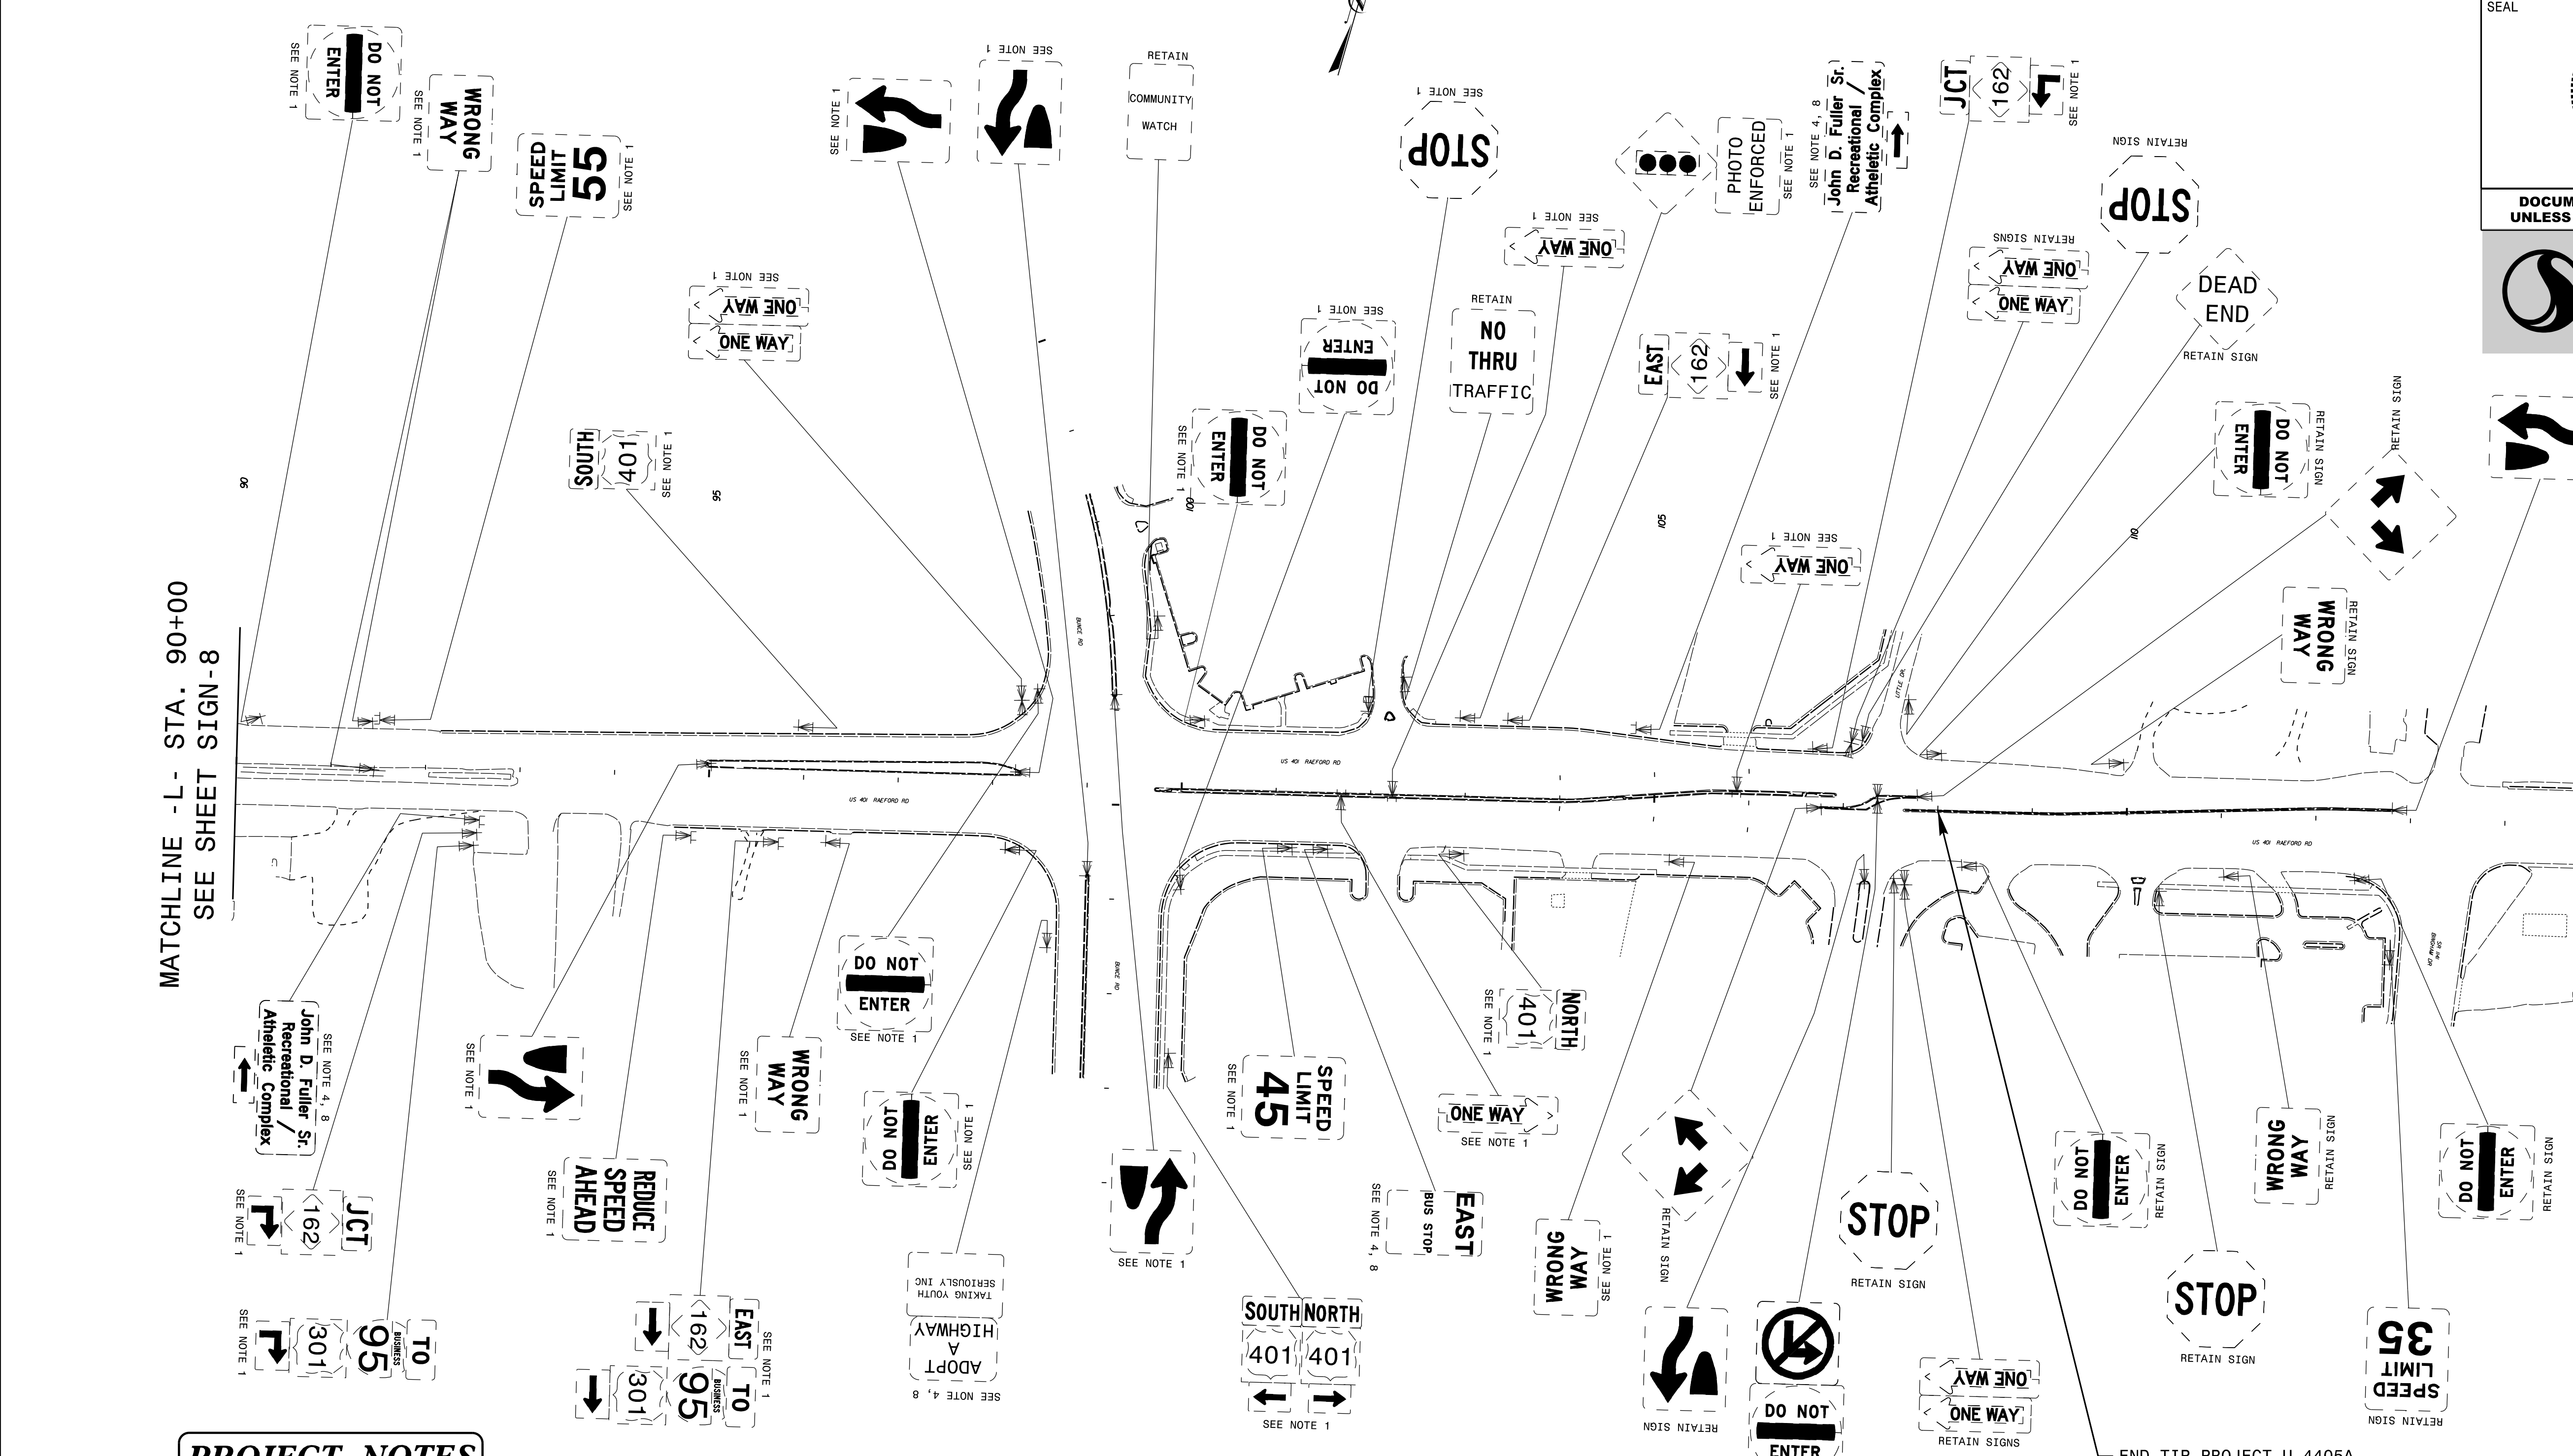

TIP NO. U-4405A	SHEET NO. SIGN-10
APPROVED: <i>Betsy L. Watson</i> 35E78B34F8743F...	
DATE: 3/4/2019	
SEAL	
DOCUMENT NOT CONSIDERED FINAL UNLESS ALL SIGNATURES COMPLETED	

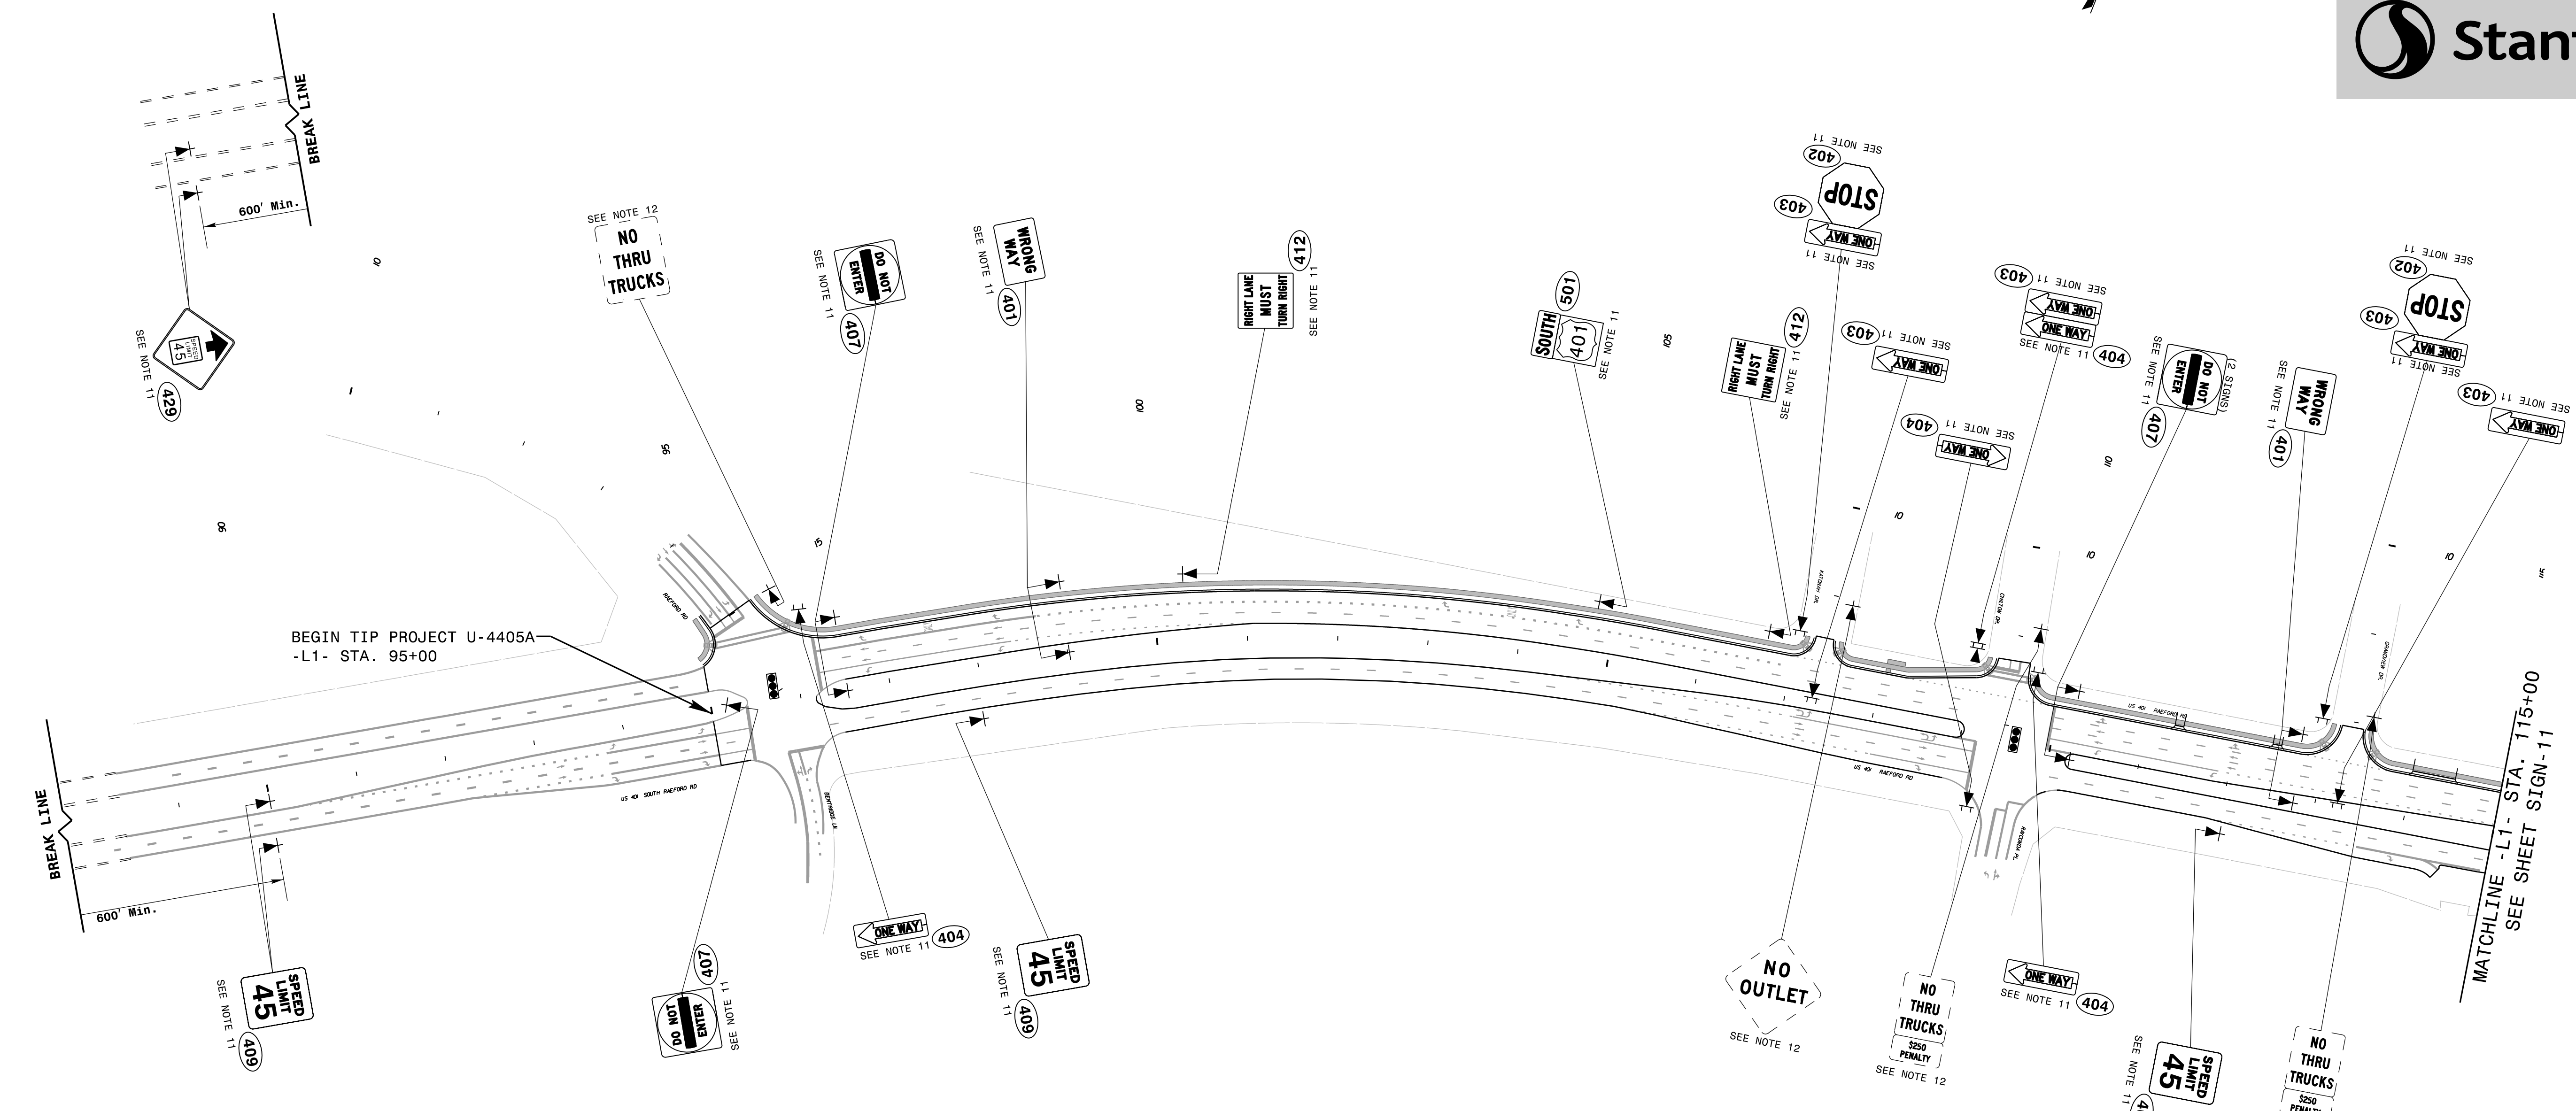

PROJECT NOTES

- 1 DISPOSAL OF SIGN SYSTEM, U-CHANNEL
- 2 DISPOSAL OF SIGN SYSTEM, WOOD
- 3 DISPOSAL OF SIGN SYSTEM, STEEL BEAM
- 4 DISPOSAL OF SUPPORT, U-CHANNEL
- 5 DISPOSAL OF SUPPORT, WOOD
- 6 DISPOSAL OF SIGN, A OR B (OVERHEAD)
- 7 DISPOSAL OF SIGN SYSTEM ON SPANWIRE
- 8 RELOCATE SIGN, TYPE D
- 9 SIGN ERECTION, TYPE A (OVERHEAD)
- 10 SIGN ERECTION, TYPE A (GROUND MOUNTED)
- 11 SIGN ERECTION, TYPE D, E, AND F
- 12 SIGN ERECTION, RELOCATE SIGN TYPE D

PROPOSED SIGNING
(-L1- Sta. 95+00 to -L1- Sta. 115+00)


2/25/2019
 Us:\Traffic\Signing\CADD\Signing\U-4405A\Signing Plan Sheets\Proposed Signing\U-4405A_PROPOSED_SIGN_10.dgn
 jhambright

TIP NO.	SHEET NO.
U-4405A	SIGN-11
APPROVED: <i>Patsy L. Watson</i> 35E78B34F8743F...	
DATE: 3/4/2019	
SEAL	
DOCUMENT NOT CONSIDERED FINAL UNLESS ALL SIGNATURES COMPLETED	



PROJECT NOTES

- 1 DISPOSAL OF SIGN SYSTEM, U-CHANNEL
- 2 DISPOSAL OF SIGN SYSTEM, WOOD
- 3 DISPOSAL OF SIGN SYSTEM, STEEL BEAM
- 4 DISPOSAL OF SUPPORT, U-CHANNEL
- 5 DISPOSAL OF SUPPORT, WOOD
- 6 DISPOSAL OF SIGN, A OR B (OVERHEAD)
- 7 DISPOSAL OF SIGN SYSTEM ON SPANWIRE
- 8 RELOCATE SIGN, TYPE D
- 9 SIGN ERECTION, TYPE A (OVERHEAD)
- 10 SIGN ERECTION, TYPE A (GROUND MOUNTED)
- 11 SIGN ERECTION, TYPE D, E, AND F
- 12 SIGN ERECTION, RELOCATE SIGN TYPE D

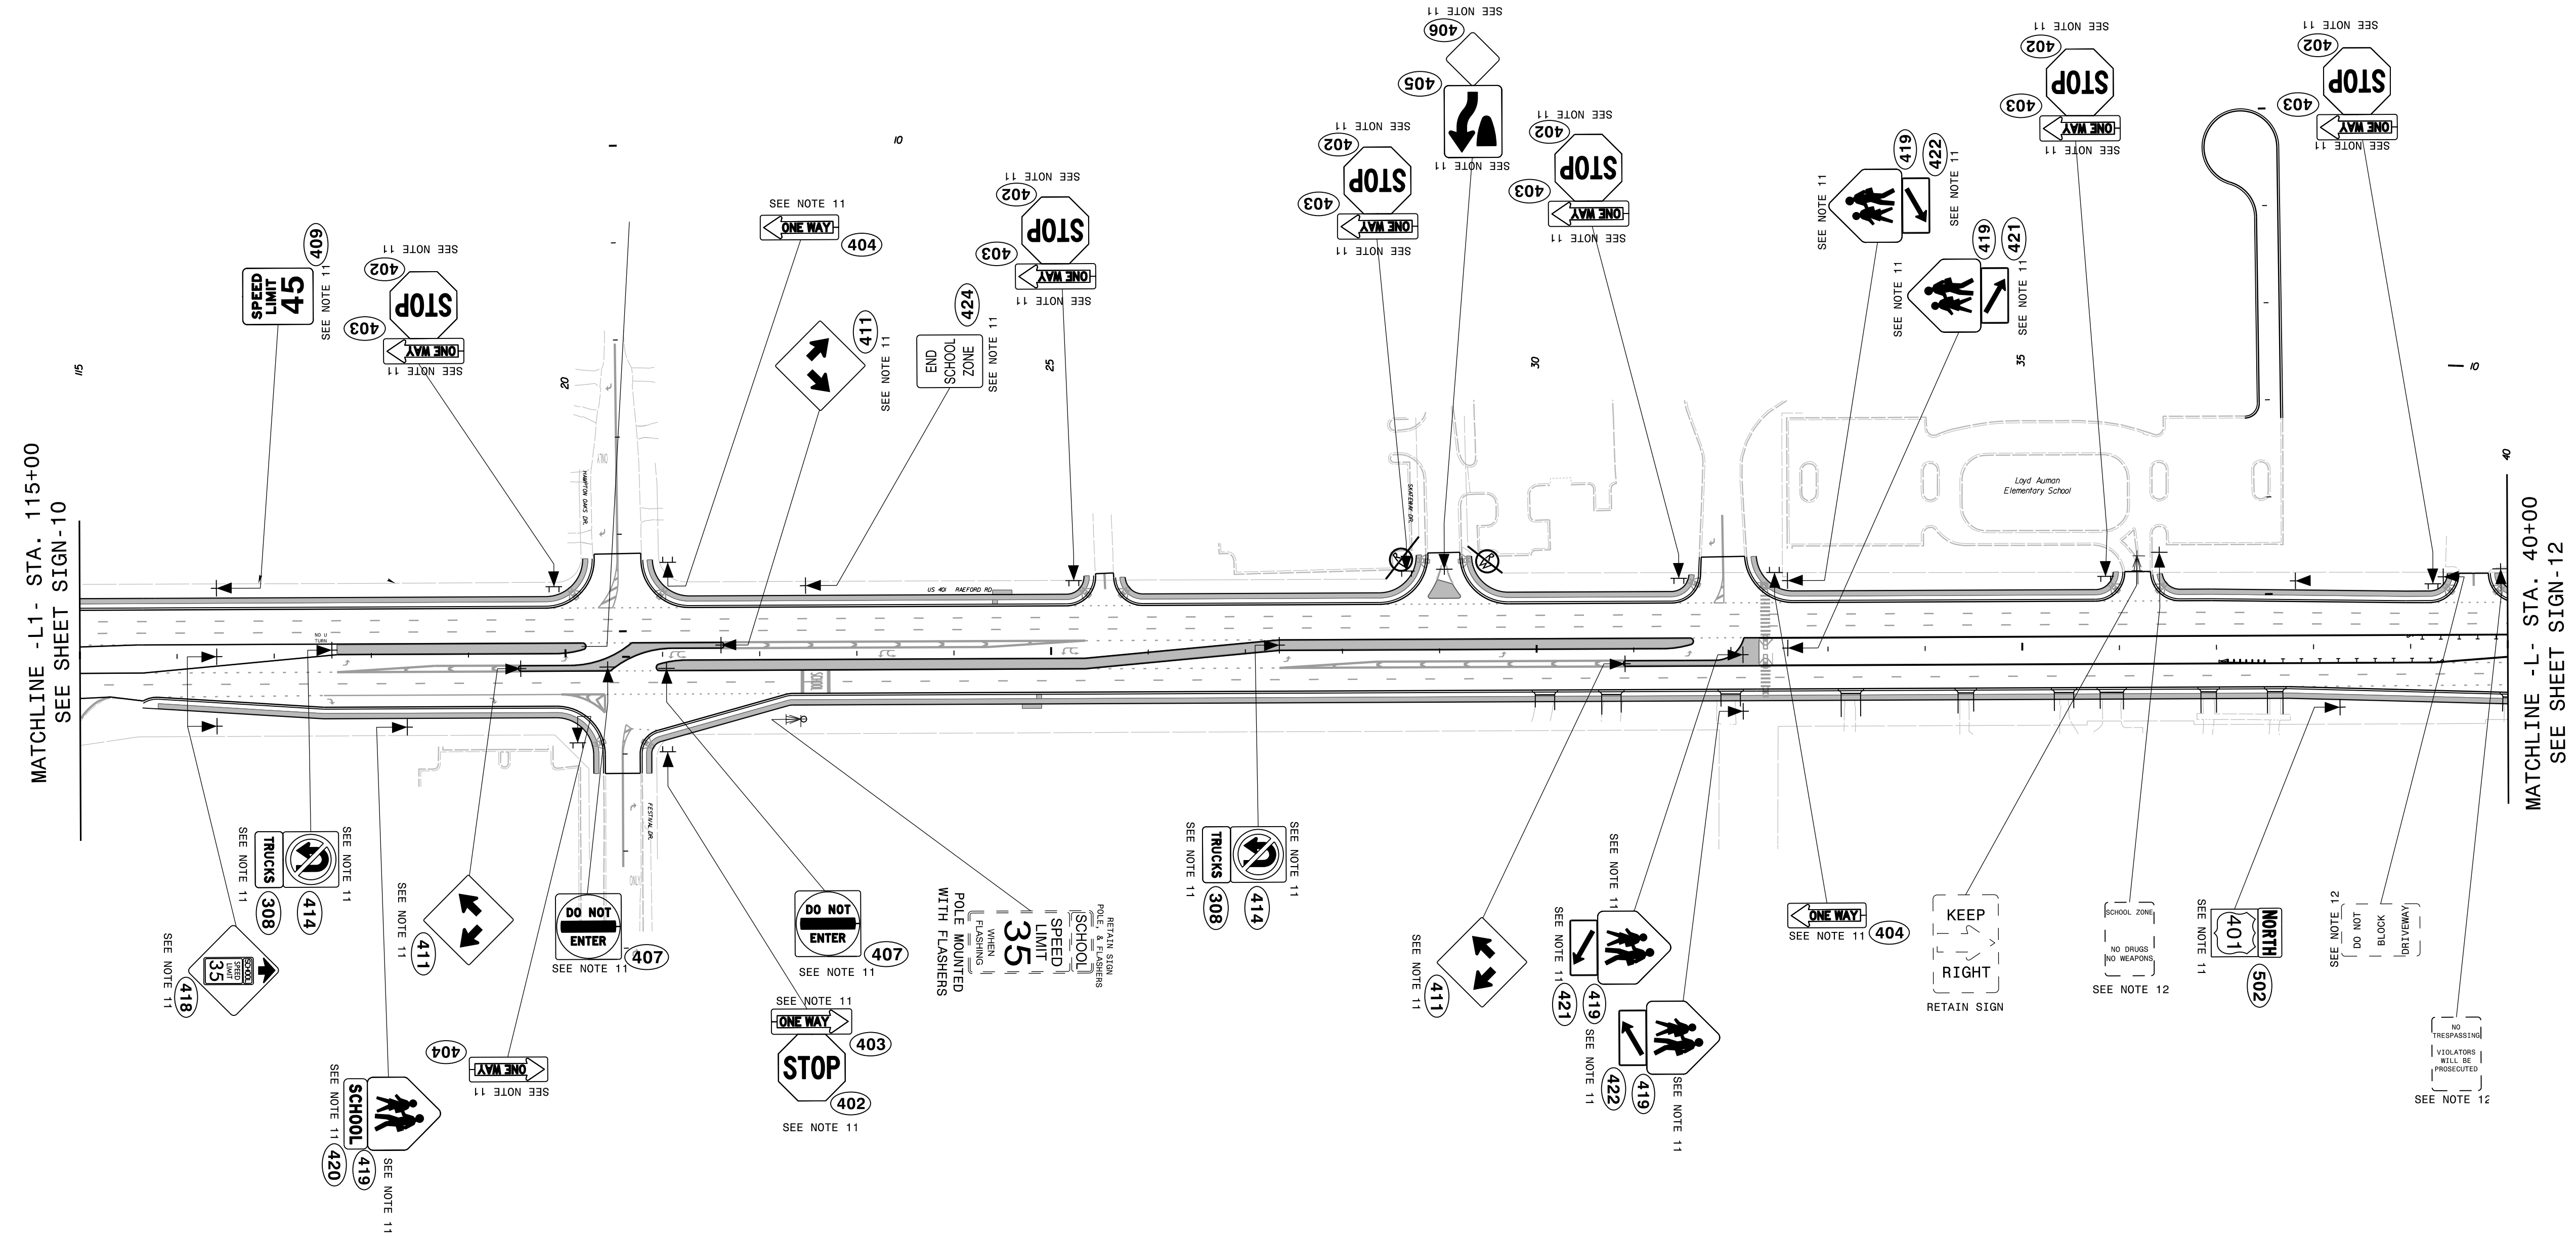


MATCHLINE -L1- STA. 115+00
SEE SHEET SIGN-10

MATCHLINE -L1- STA. 40+00
SEE SHEET SIGN-12

PROPOSED SIGNING
(-L1- Sta. 115+00 to -L- Sta. 40+00)

2/25/2019
 U:\Traffic\Signing\CADD\Signing\U-4405A\Signing Plan Sheets\Proposed Signing\U-4405A_PROPOSED_SIGN-11.dgn
 jhambright

TIP NO.	SHEET NO.
U-4405A	SIGN-12
APPROVED: <i>Betsy L. Watson</i> 35E78B34F8743F...	
DATE: 3/4/2019	
SEAL	
DOCUMENT NOT CONSIDERED FINAL UNLESS ALL SIGNATURES COMPLETED	

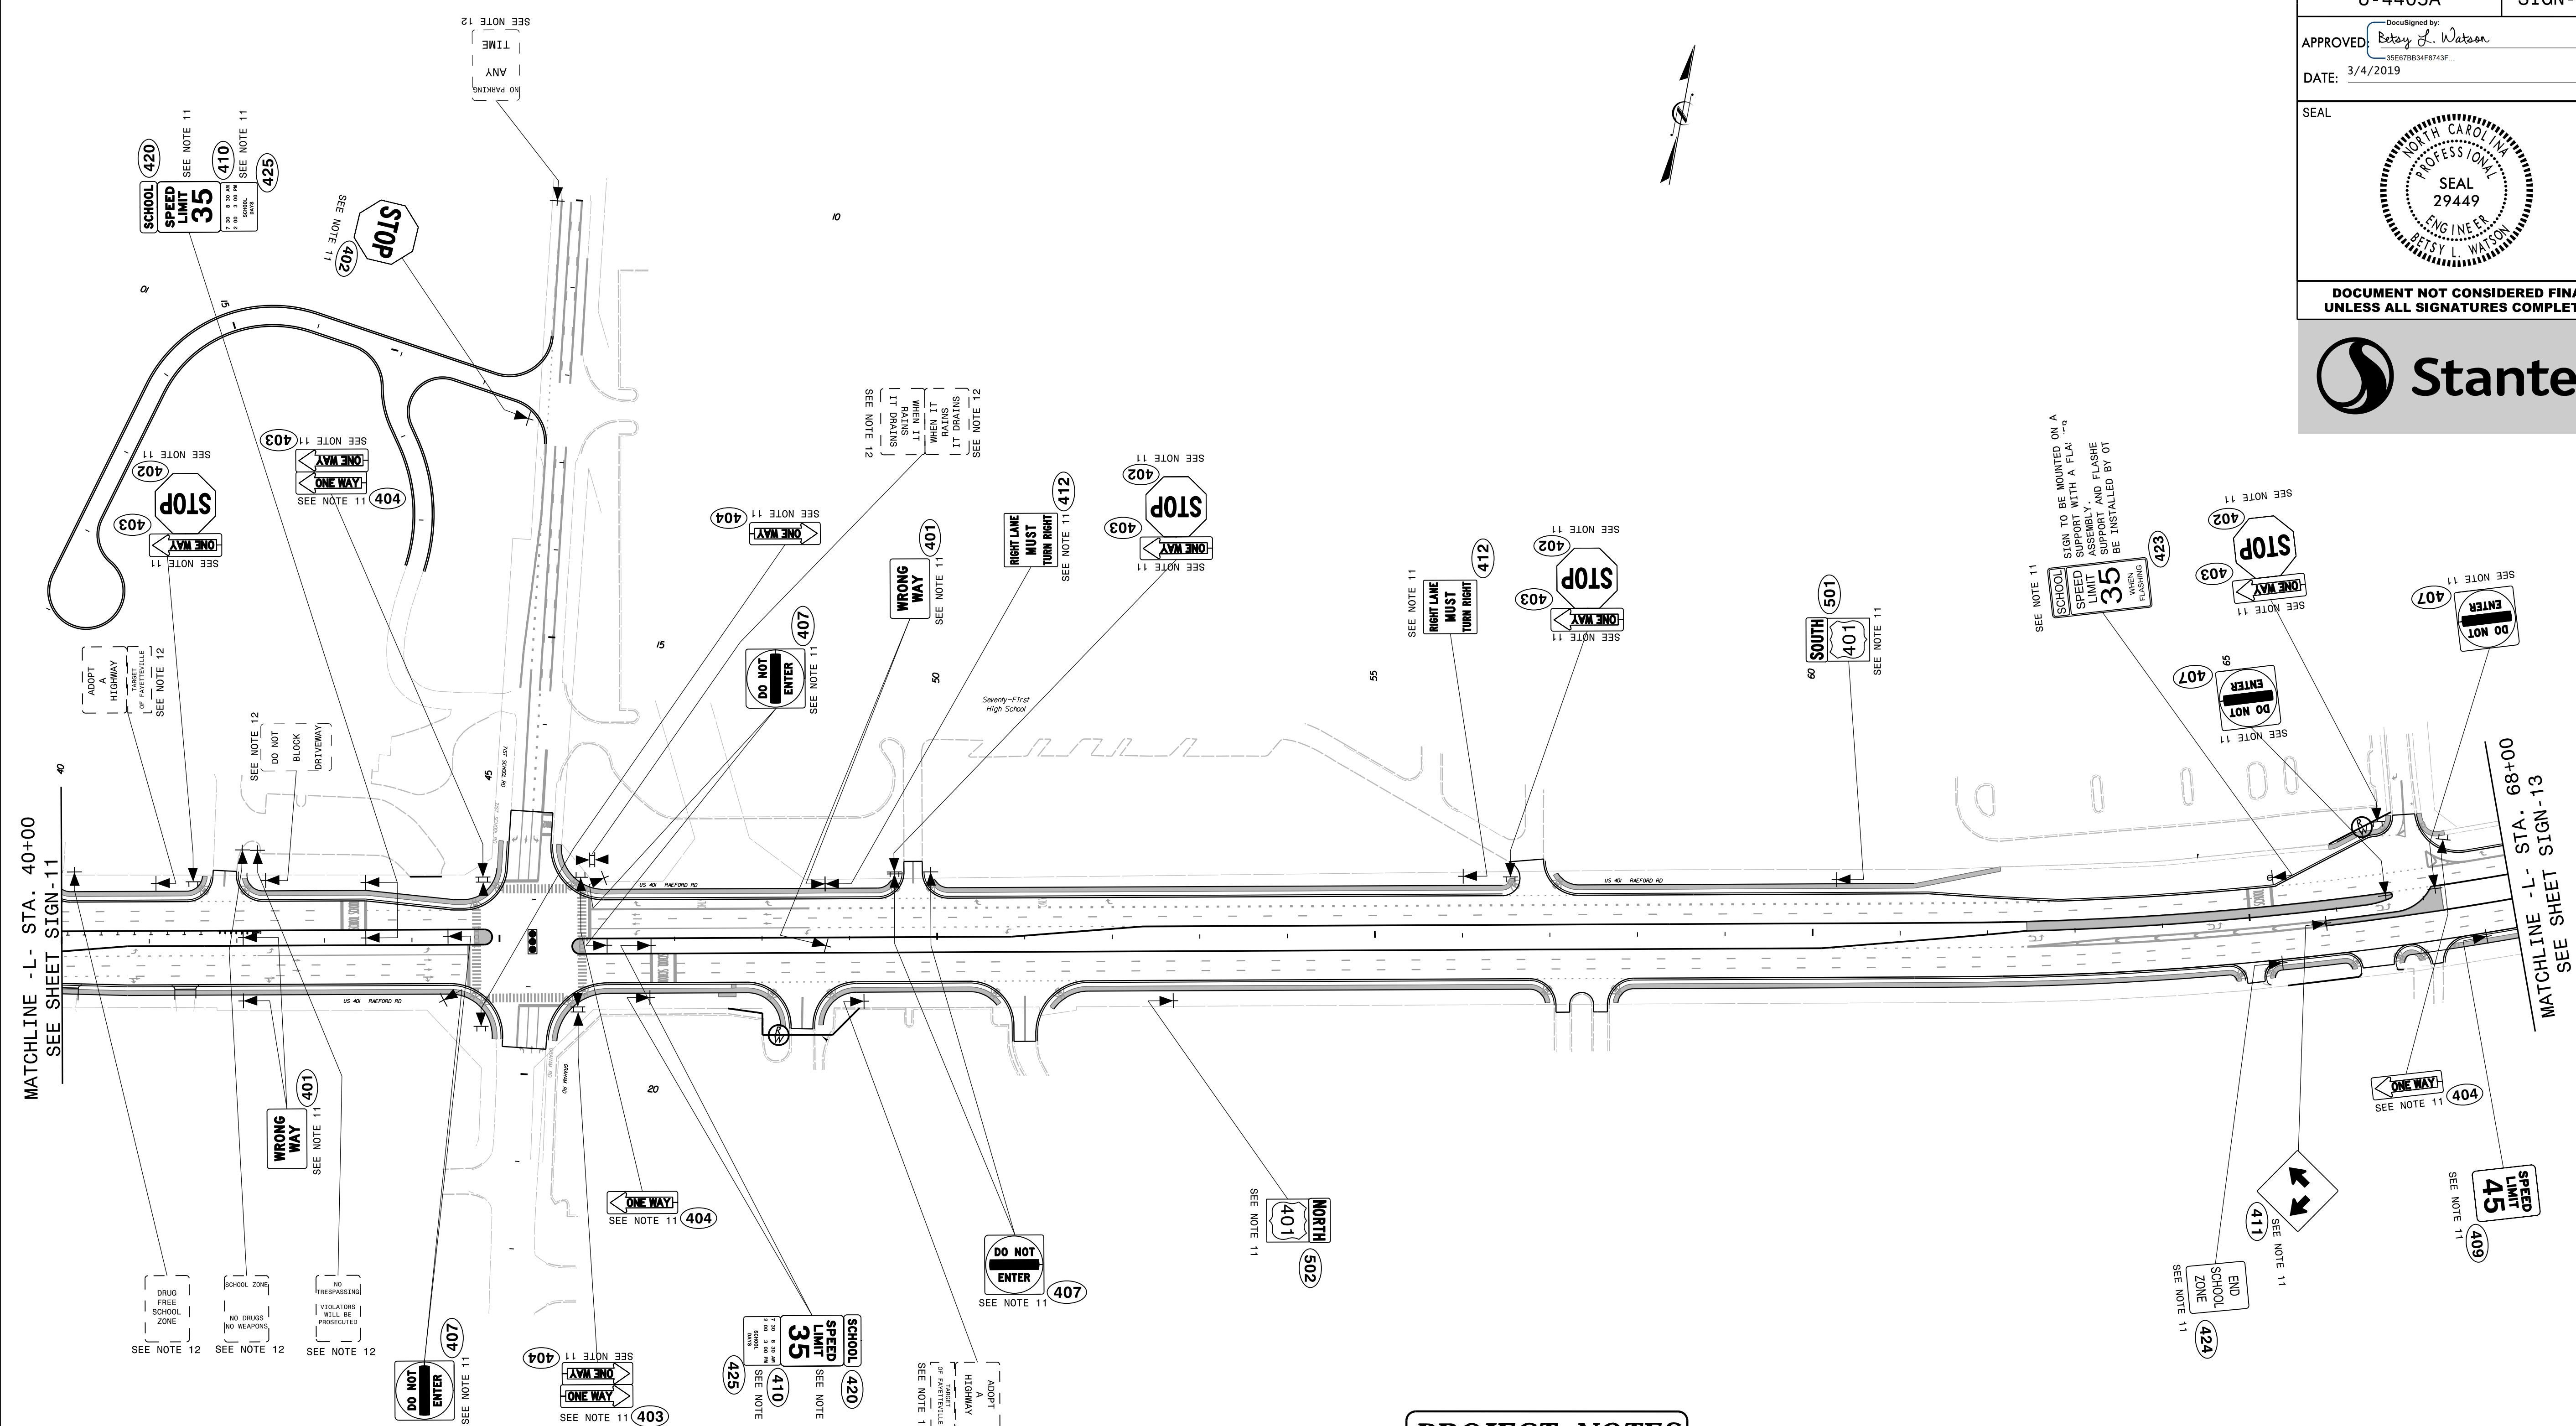


- PROJECT NOTES**
- DISPOSAL OF SIGN SYSTEM, U-CHANNEL
 - DISPOSAL OF SIGN SYSTEM, WOOD
 - DISPOSAL OF SIGN SYSTEM, STEEL BEAM
 - DISPOSAL OF SUPPORT, U-CHANNEL
 - DISPOSAL OF SUPPORT, WOOD
 - DISPOSAL OF SIGN, A OR B (OVERHEAD)
 - DISPOSAL OF SIGN SYSTEM ON SPANWIRE
 - RELOCATE SIGN, TYPE D
 - SIGN ERECTION, TYPE A (OVERHEAD)
 - SIGN ERECTION, TYPE A (GROUND MOUNTED)
 - SIGN ERECTION, TYPE D, E, AND F
 - SIGN ERECTION, RELOCATE SIGN TYPE D

PROPOSED SIGNING
(-L- Sta. 40+00 to -L- Sta. 68+00)

2/25/2019
U:\Traffic\Signing\CADD\Signing\U-4405A\Signing Plan Sheets\Proposed Signing\U-4405A_PROPOSED_SIGN_L2.dgn
jhambright


TIP NO.	SHEET NO.
U-4405A	SIGN-13
APPROVED: <i>Betsy L. Watson</i> 35E78B34F8743F...	
DATE: 3/4/2019	
SEAL	
DOCUMENT NOT CONSIDERED FINAL UNLESS ALL SIGNATURES COMPLETED	

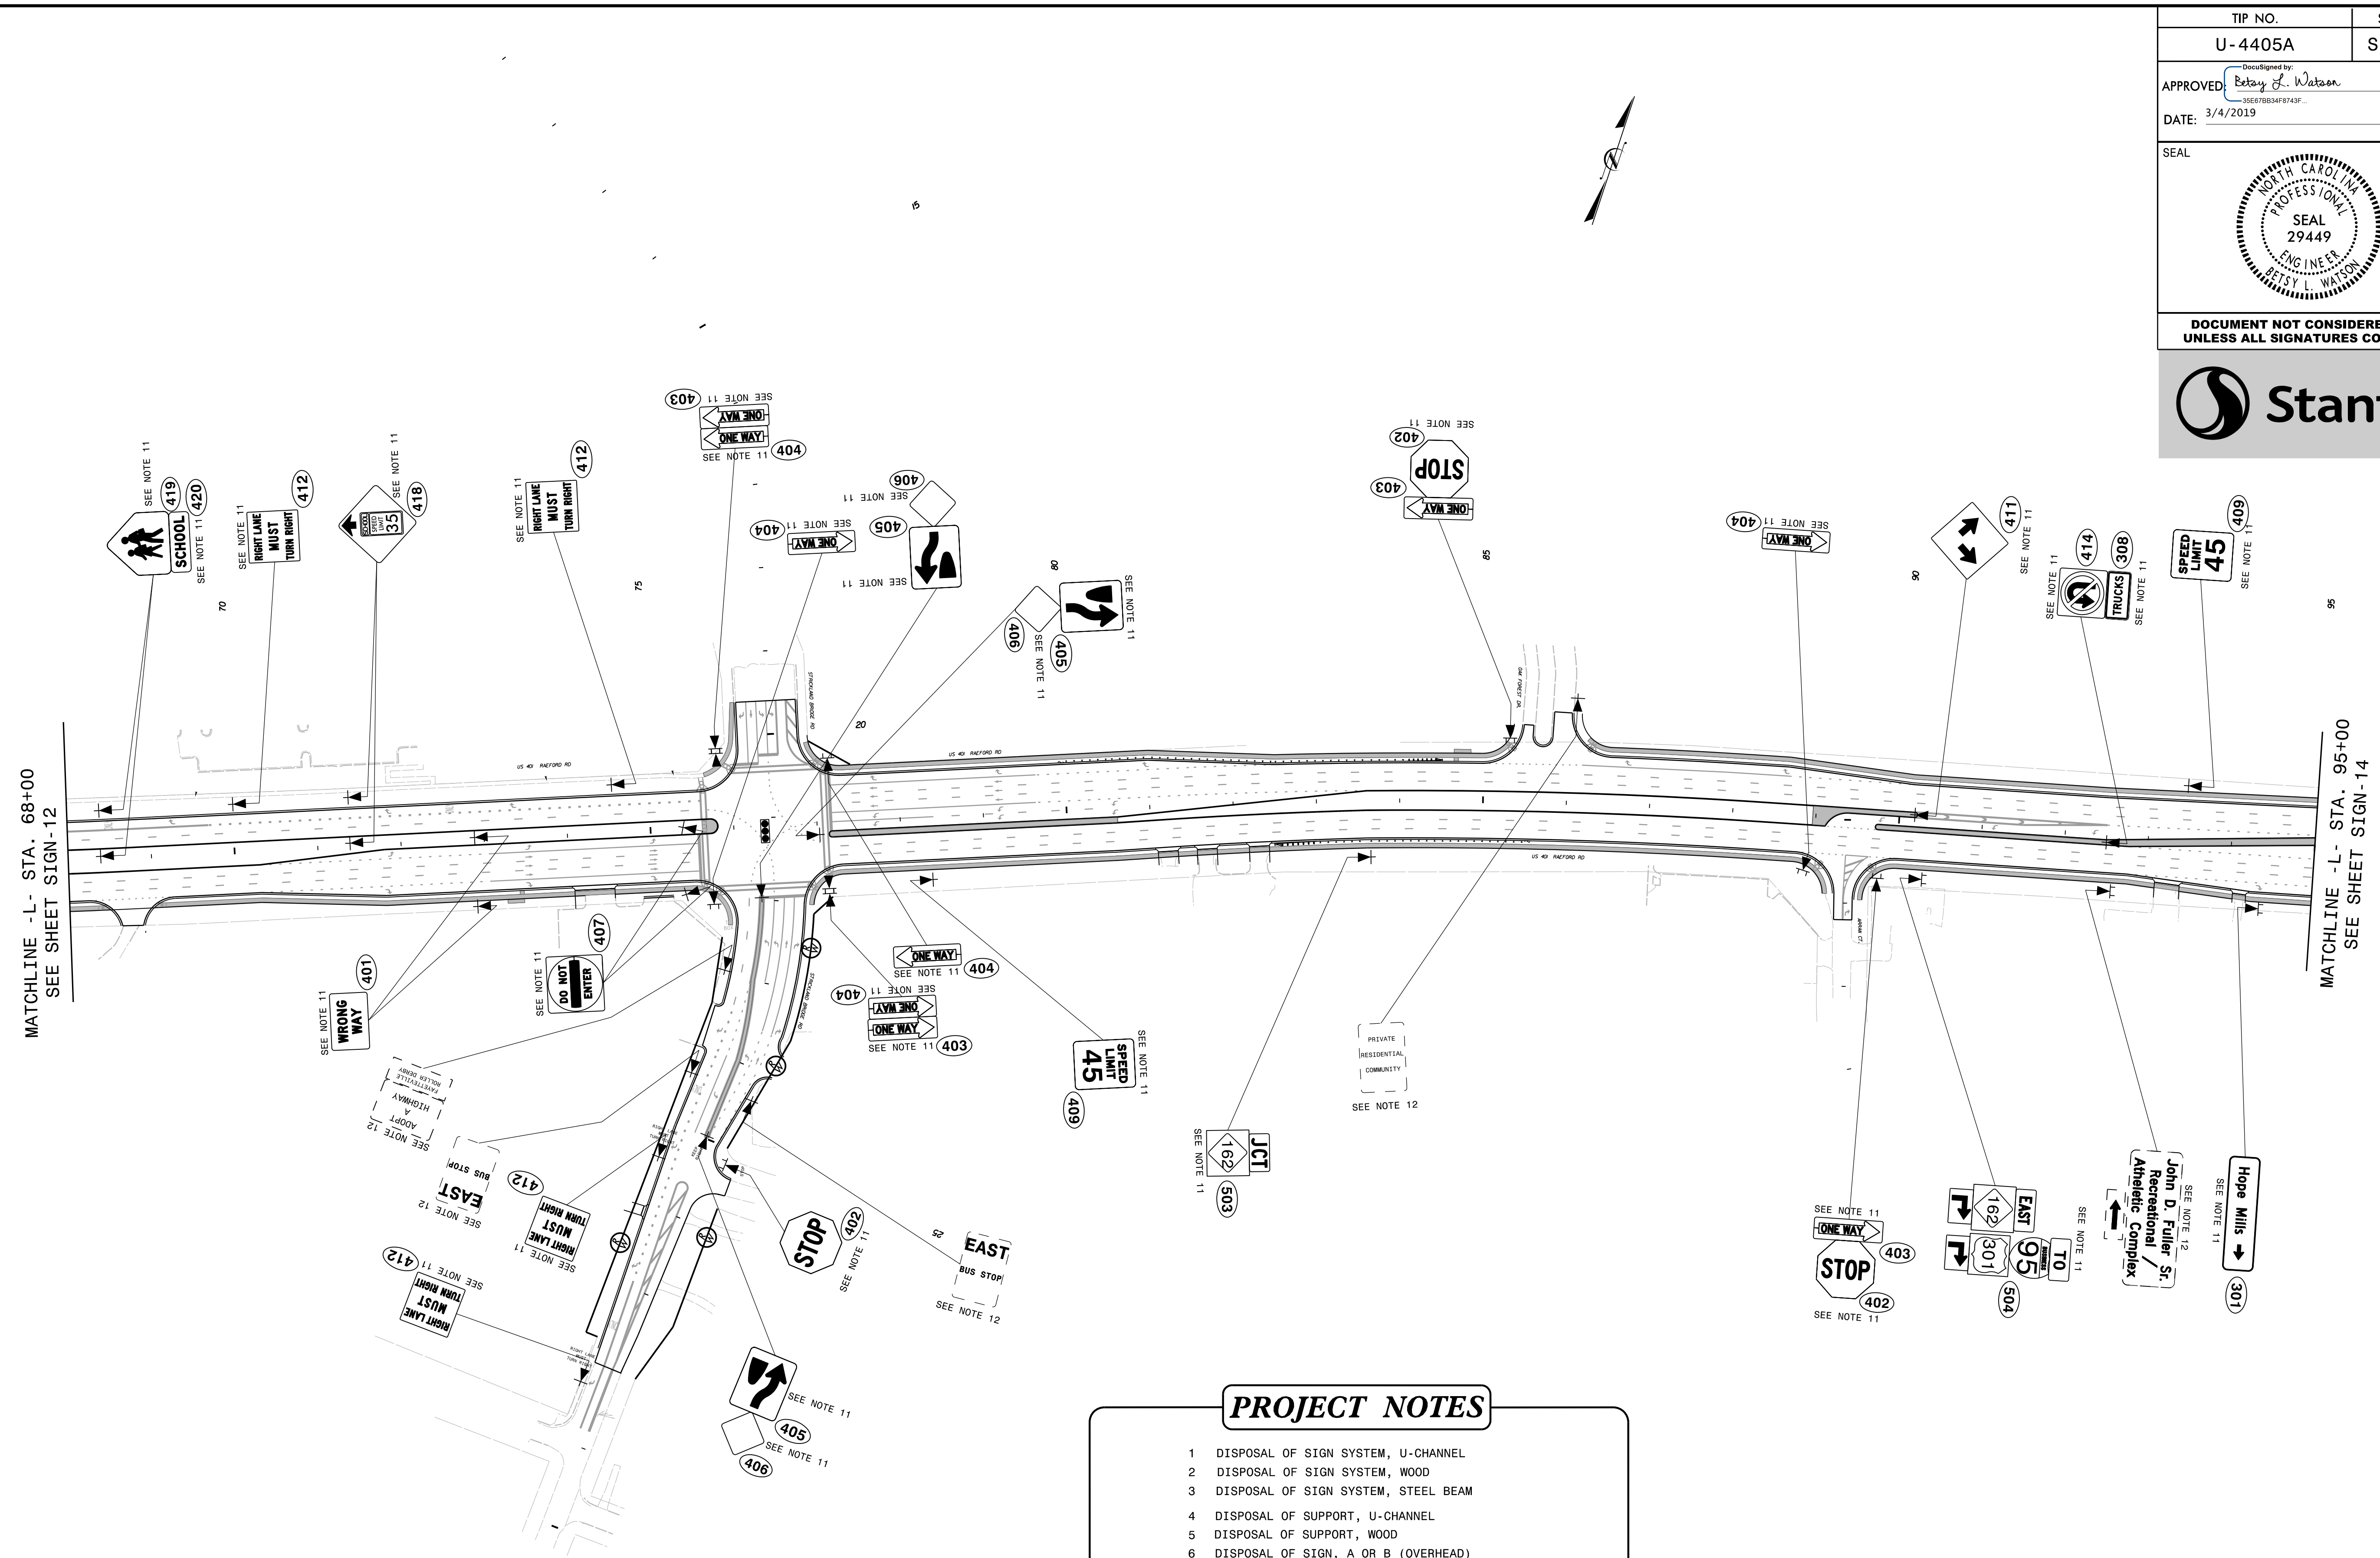


- PROJECT NOTES**
- DISPOSAL OF SIGN SYSTEM, U-CHANNEL
 - DISPOSAL OF SIGN SYSTEM, WOOD
 - DISPOSAL OF SIGN SYSTEM, STEEL BEAM
 - DISPOSAL OF SUPPORT, U-CHANNEL
 - DISPOSAL OF SUPPORT, WOOD
 - DISPOSAL OF SIGN, A OR B (OVERHEAD)
 - DISPOSAL OF SIGN SYSTEM ON SPANWIRE
 - RELOCATE SIGN, TYPE D
 - SIGN ERECTION, TYPE A (OVERHEAD)
 - SIGN ERECTION, TYPE A (GROUND MOUNTED)
 - SIGN ERECTION, TYPE D, E, AND F
 - SIGN ERECTION, RELOCATE SIGN TYPE D

PROPOSED SIGNING
(-L- Sta. 68+00 to -L- Sta. 95+00)

2/25/2019
 U:\Traffic\Signing\CADD\Signing\U-4405A\Signing Plan Sheets\Proposed Signing\U-4405A_PROPOSED_SIGN_13.dgn
 jhambright

TIP NO.	SHEET NO.
U-4405A	SIGN-14
APPROVED: <i>Petsy L. Watson</i> 35E78B34F8743F...	
DATE: 3/4/2019	
SEAL	
	
DOCUMENT NOT CONSIDERED FINAL UNLESS ALL SIGNATURES COMPLETED	

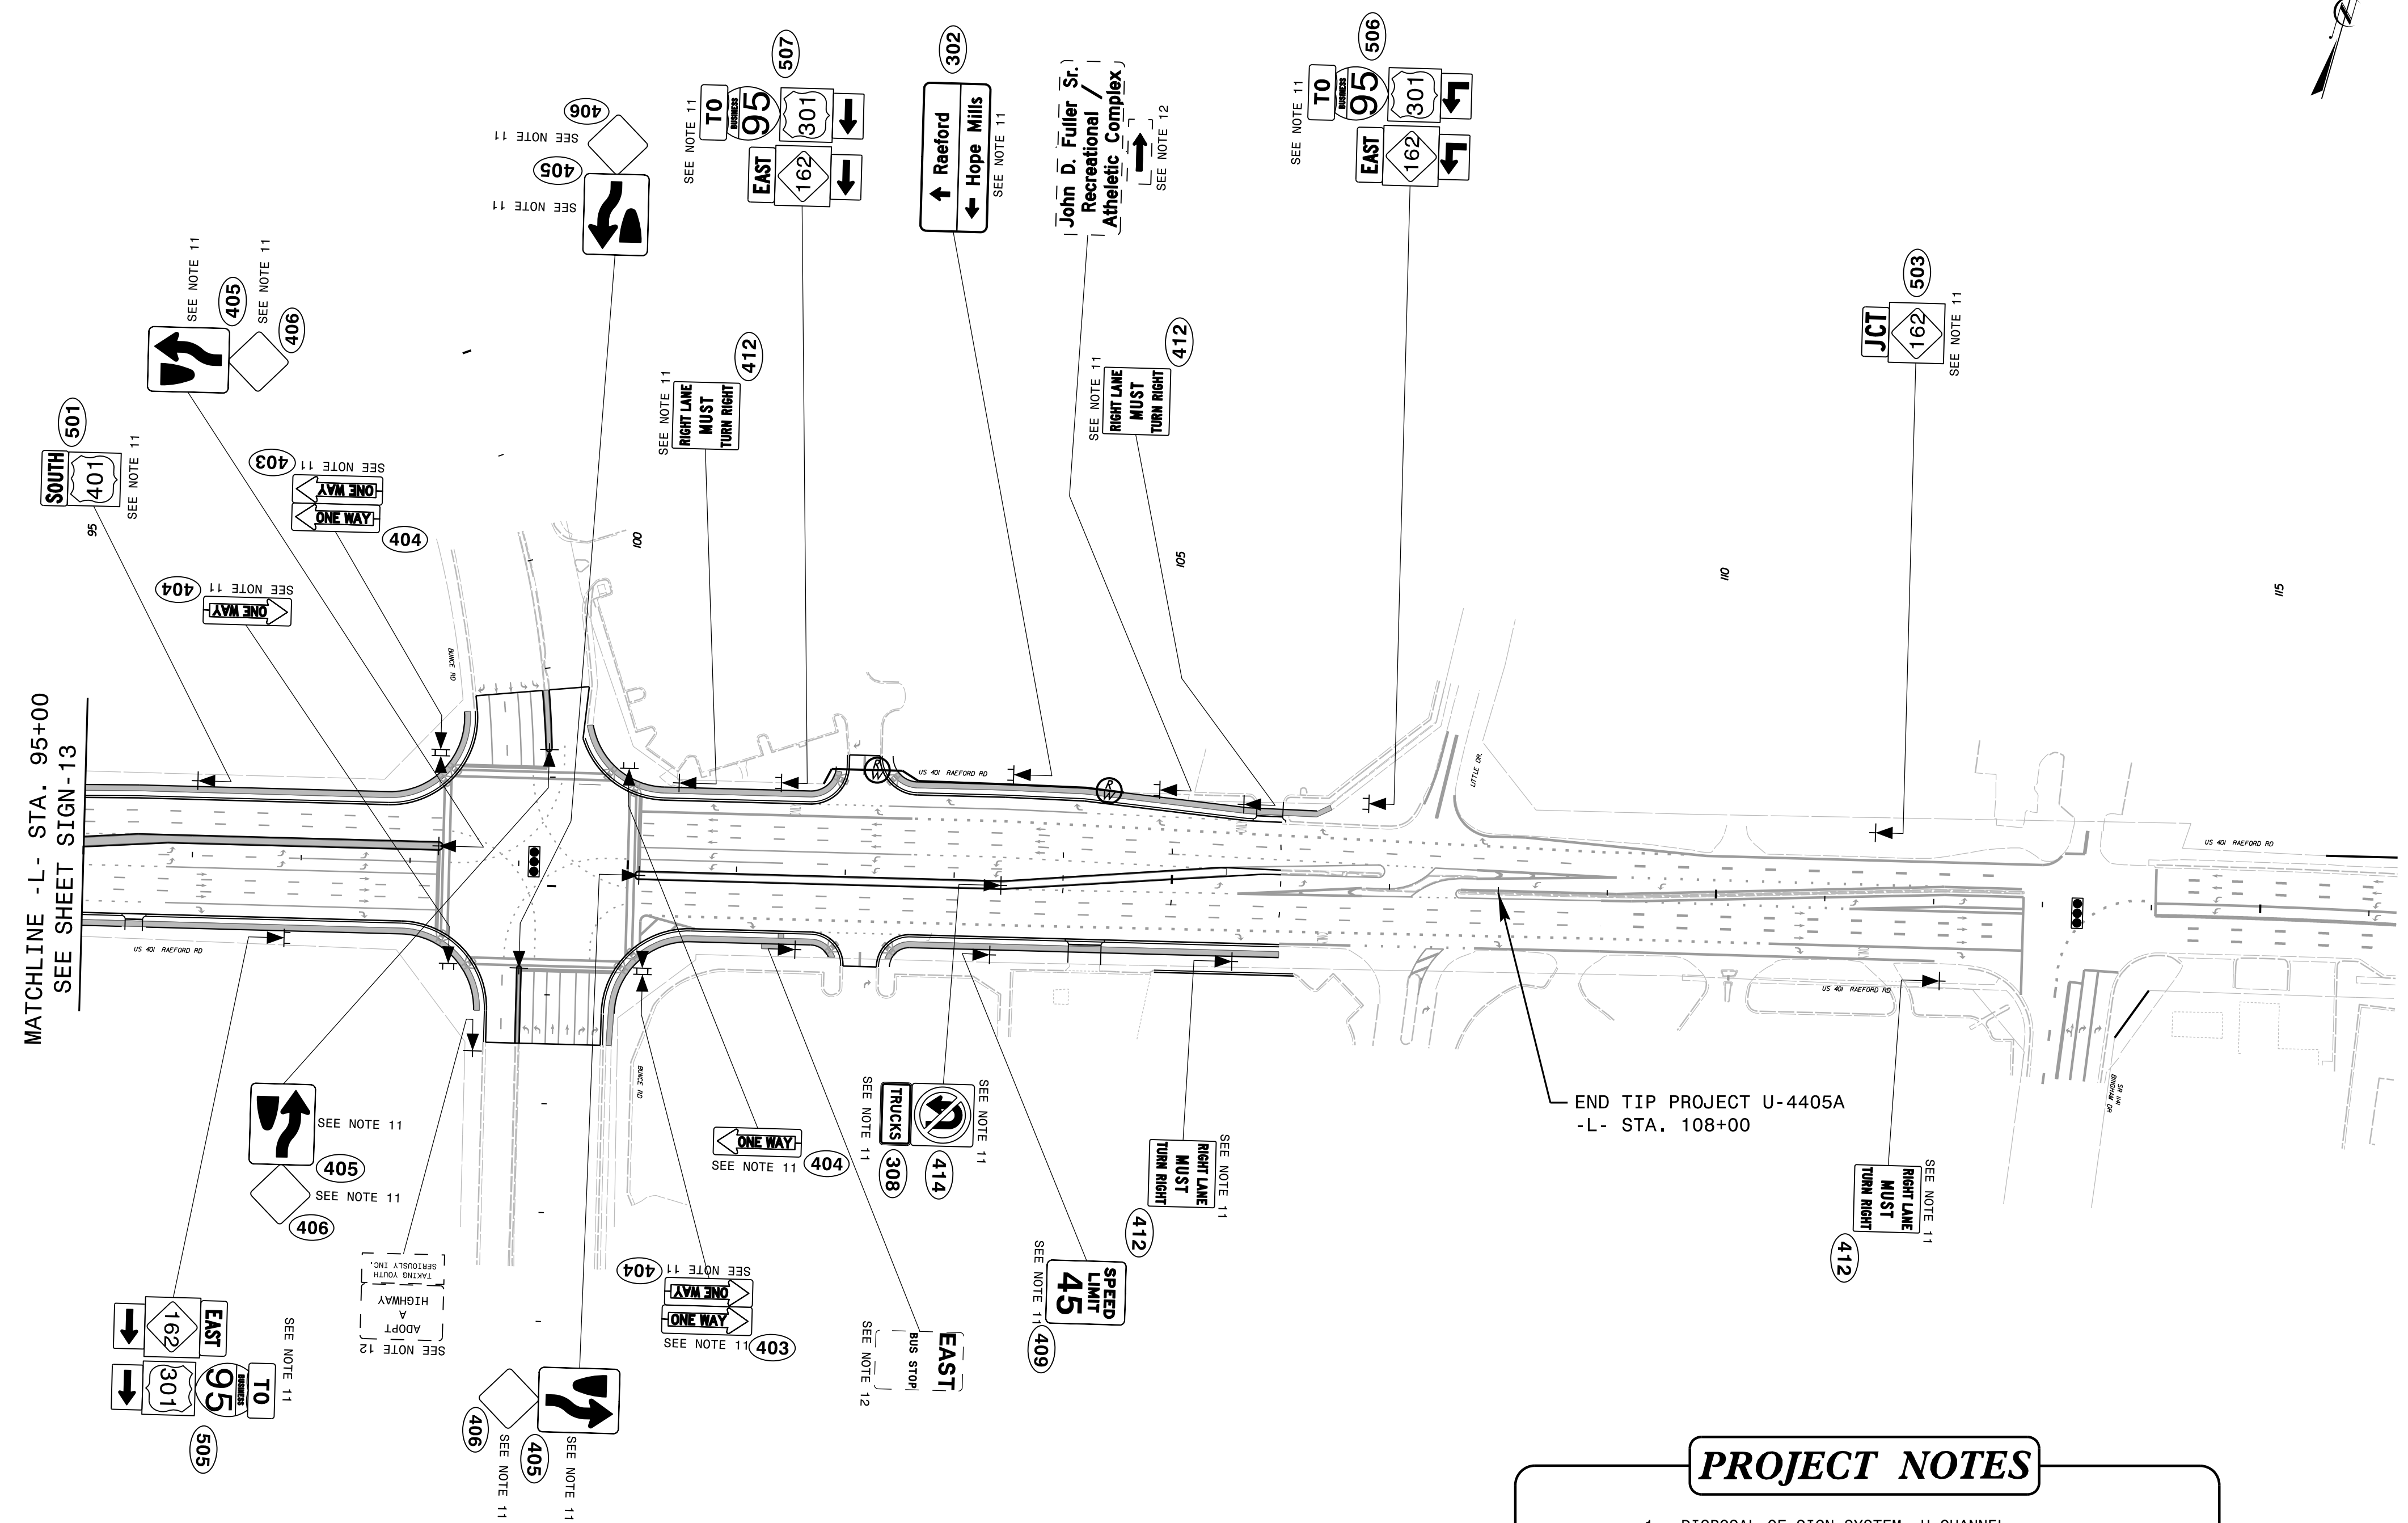

MATCHLINE -L- STA. 95+00
SEE SHEET SIGN-13

END TIP PROJECT U-4405A
-L- STA. 108+00

PROJECT NOTES

- 1 DISPOSAL OF SIGN SYSTEM, U-CHANNEL
- 2 DISPOSAL OF SIGN SYSTEM, WOOD
- 3 DISPOSAL OF SIGN SYSTEM, STEEL BEAM
- 4 DISPOSAL OF SUPPORT, U-CHANNEL
- 5 DISPOSAL OF SUPPORT, WOOD
- 6 DISPOSAL OF SIGN, A OR B (OVERHEAD)
- 7 DISPOSAL OF SIGN SYSTEM ON SPANWIRE
- 8 RELOCATE SIGN, TYPE D
- 9 SIGN ERECTION, TYPE A (OVERHEAD)
- 10 SIGN ERECTION, TYPE A (GROUND MOUNTED)
- 11 SIGN ERECTION, TYPE D, E, AND F
- 12 SIGN ERECTION, RELOCATE SIGN TYPE D

PROPOSED SIGNING
(-L- Sta. 95+00 to -L- Sta. 108+00)

2/25/2019
 U:\Traffic\Signing\CADD\Signing\U-4405A\Signing Plan Sheets\Proposed Signing\U-4405A_PROPOSED_SIGN_14.dgn
 jhambright