



USE FOR LIGHTING CONSTRUCTION ONLY

PROJECT REFERENCE NO. U-5754 SHEET NO. E-2

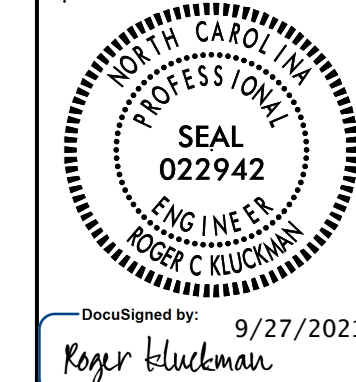

DOCUMENT NOT CONSIDERED FINAL UNLESS ALL SIGNATURES COMPLETED

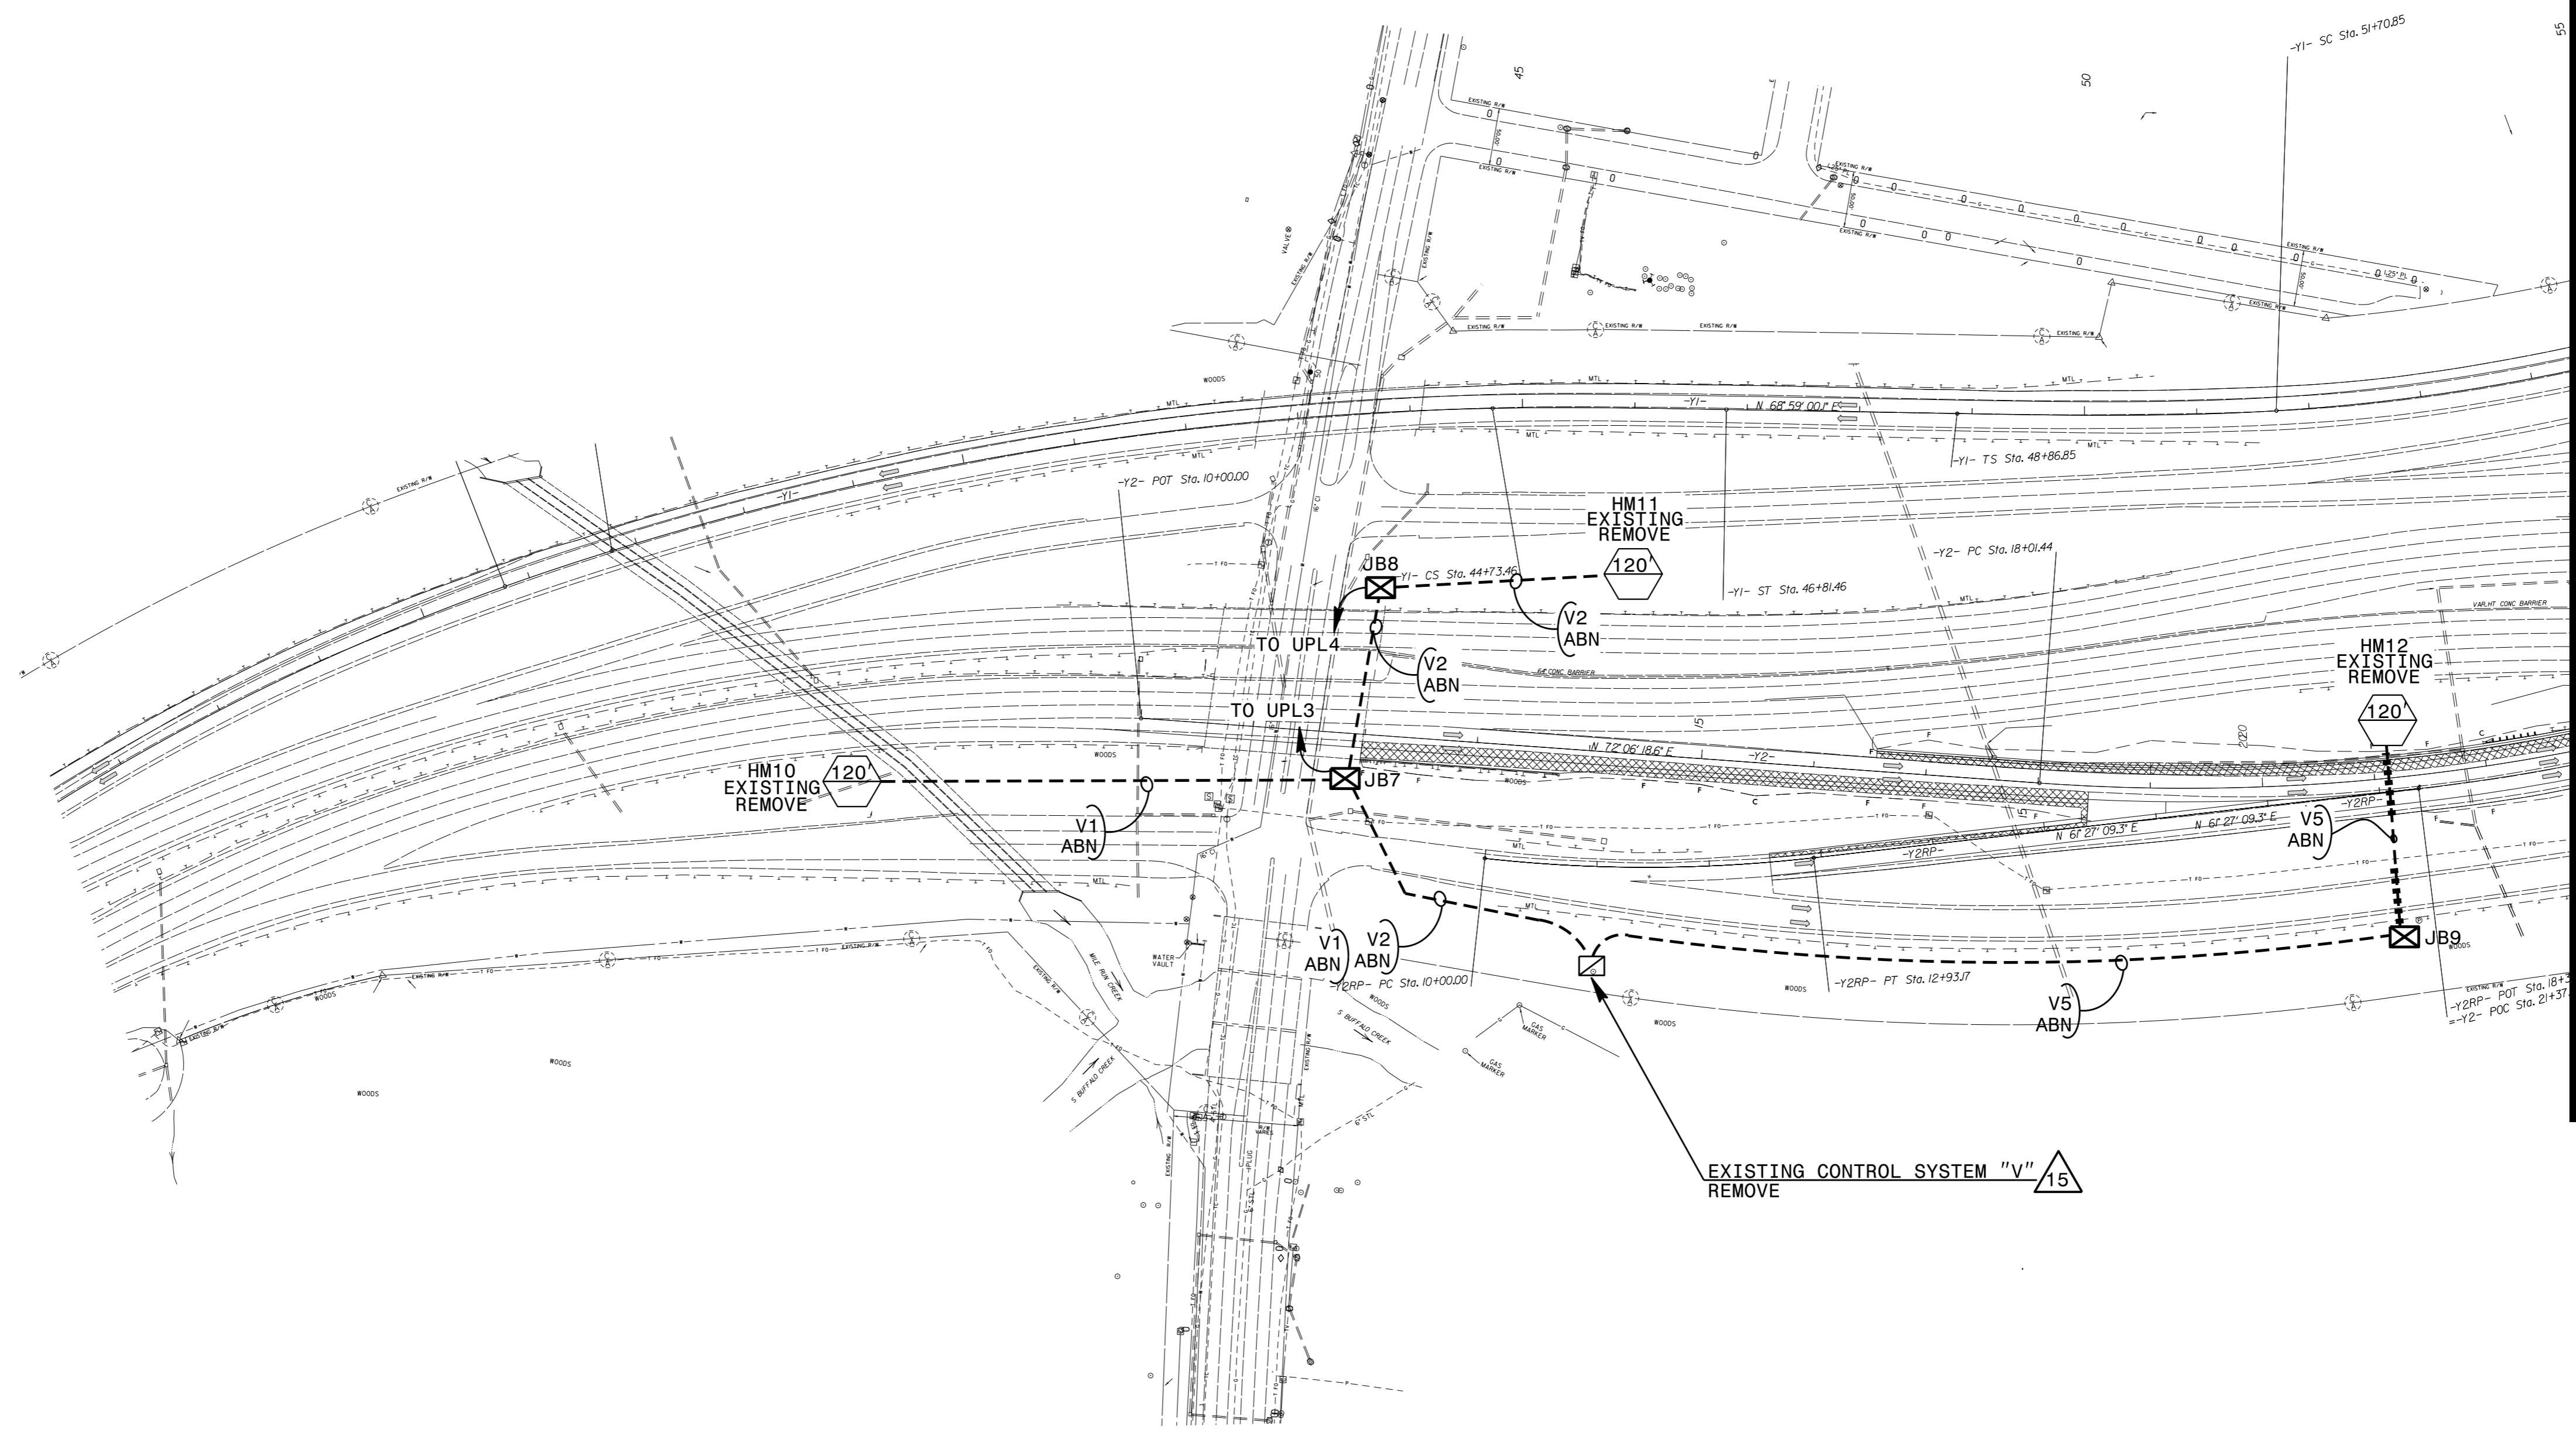

MATCHLINE WITH SHEET E-3

SEE SHEET "E-1" FOR LEGEND & △ NOTES

NOTE: ALL EQUIPMENT SHOWN AS EXISTING ON THIS SHEET IS TO BE REMOVED OR ABANDONED.

2			
1			
Rev.	Date	Description	Approved
NORTH CAROLINA DEPARTMENT OF TRANSPORTATION ROADWAY DESIGN LIGHTING/ELECTRICAL SECTION			
LIGHTING LAYOUT EXISTING I-40/MLK JR DR. INTERCHANGE GUILFORD COUNTY			
Drawn By:	AB	Approved By:	Dwg No.:

21-SEP-2021 08:04 R:\Lighting\Lighting Design\U5754_1&e-psh.e2.dgn