
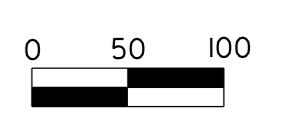


DocuSigned by:
Roger Kluckman
9/27/2021

**DOCUMENT NOT CONSIDERED FINAL
UNLESS ALL SIGNATURES COMPLETED**

USE FOR LIGHTING CONSTRUCTION ONLY

MATCHLINE WITH SHEET E2

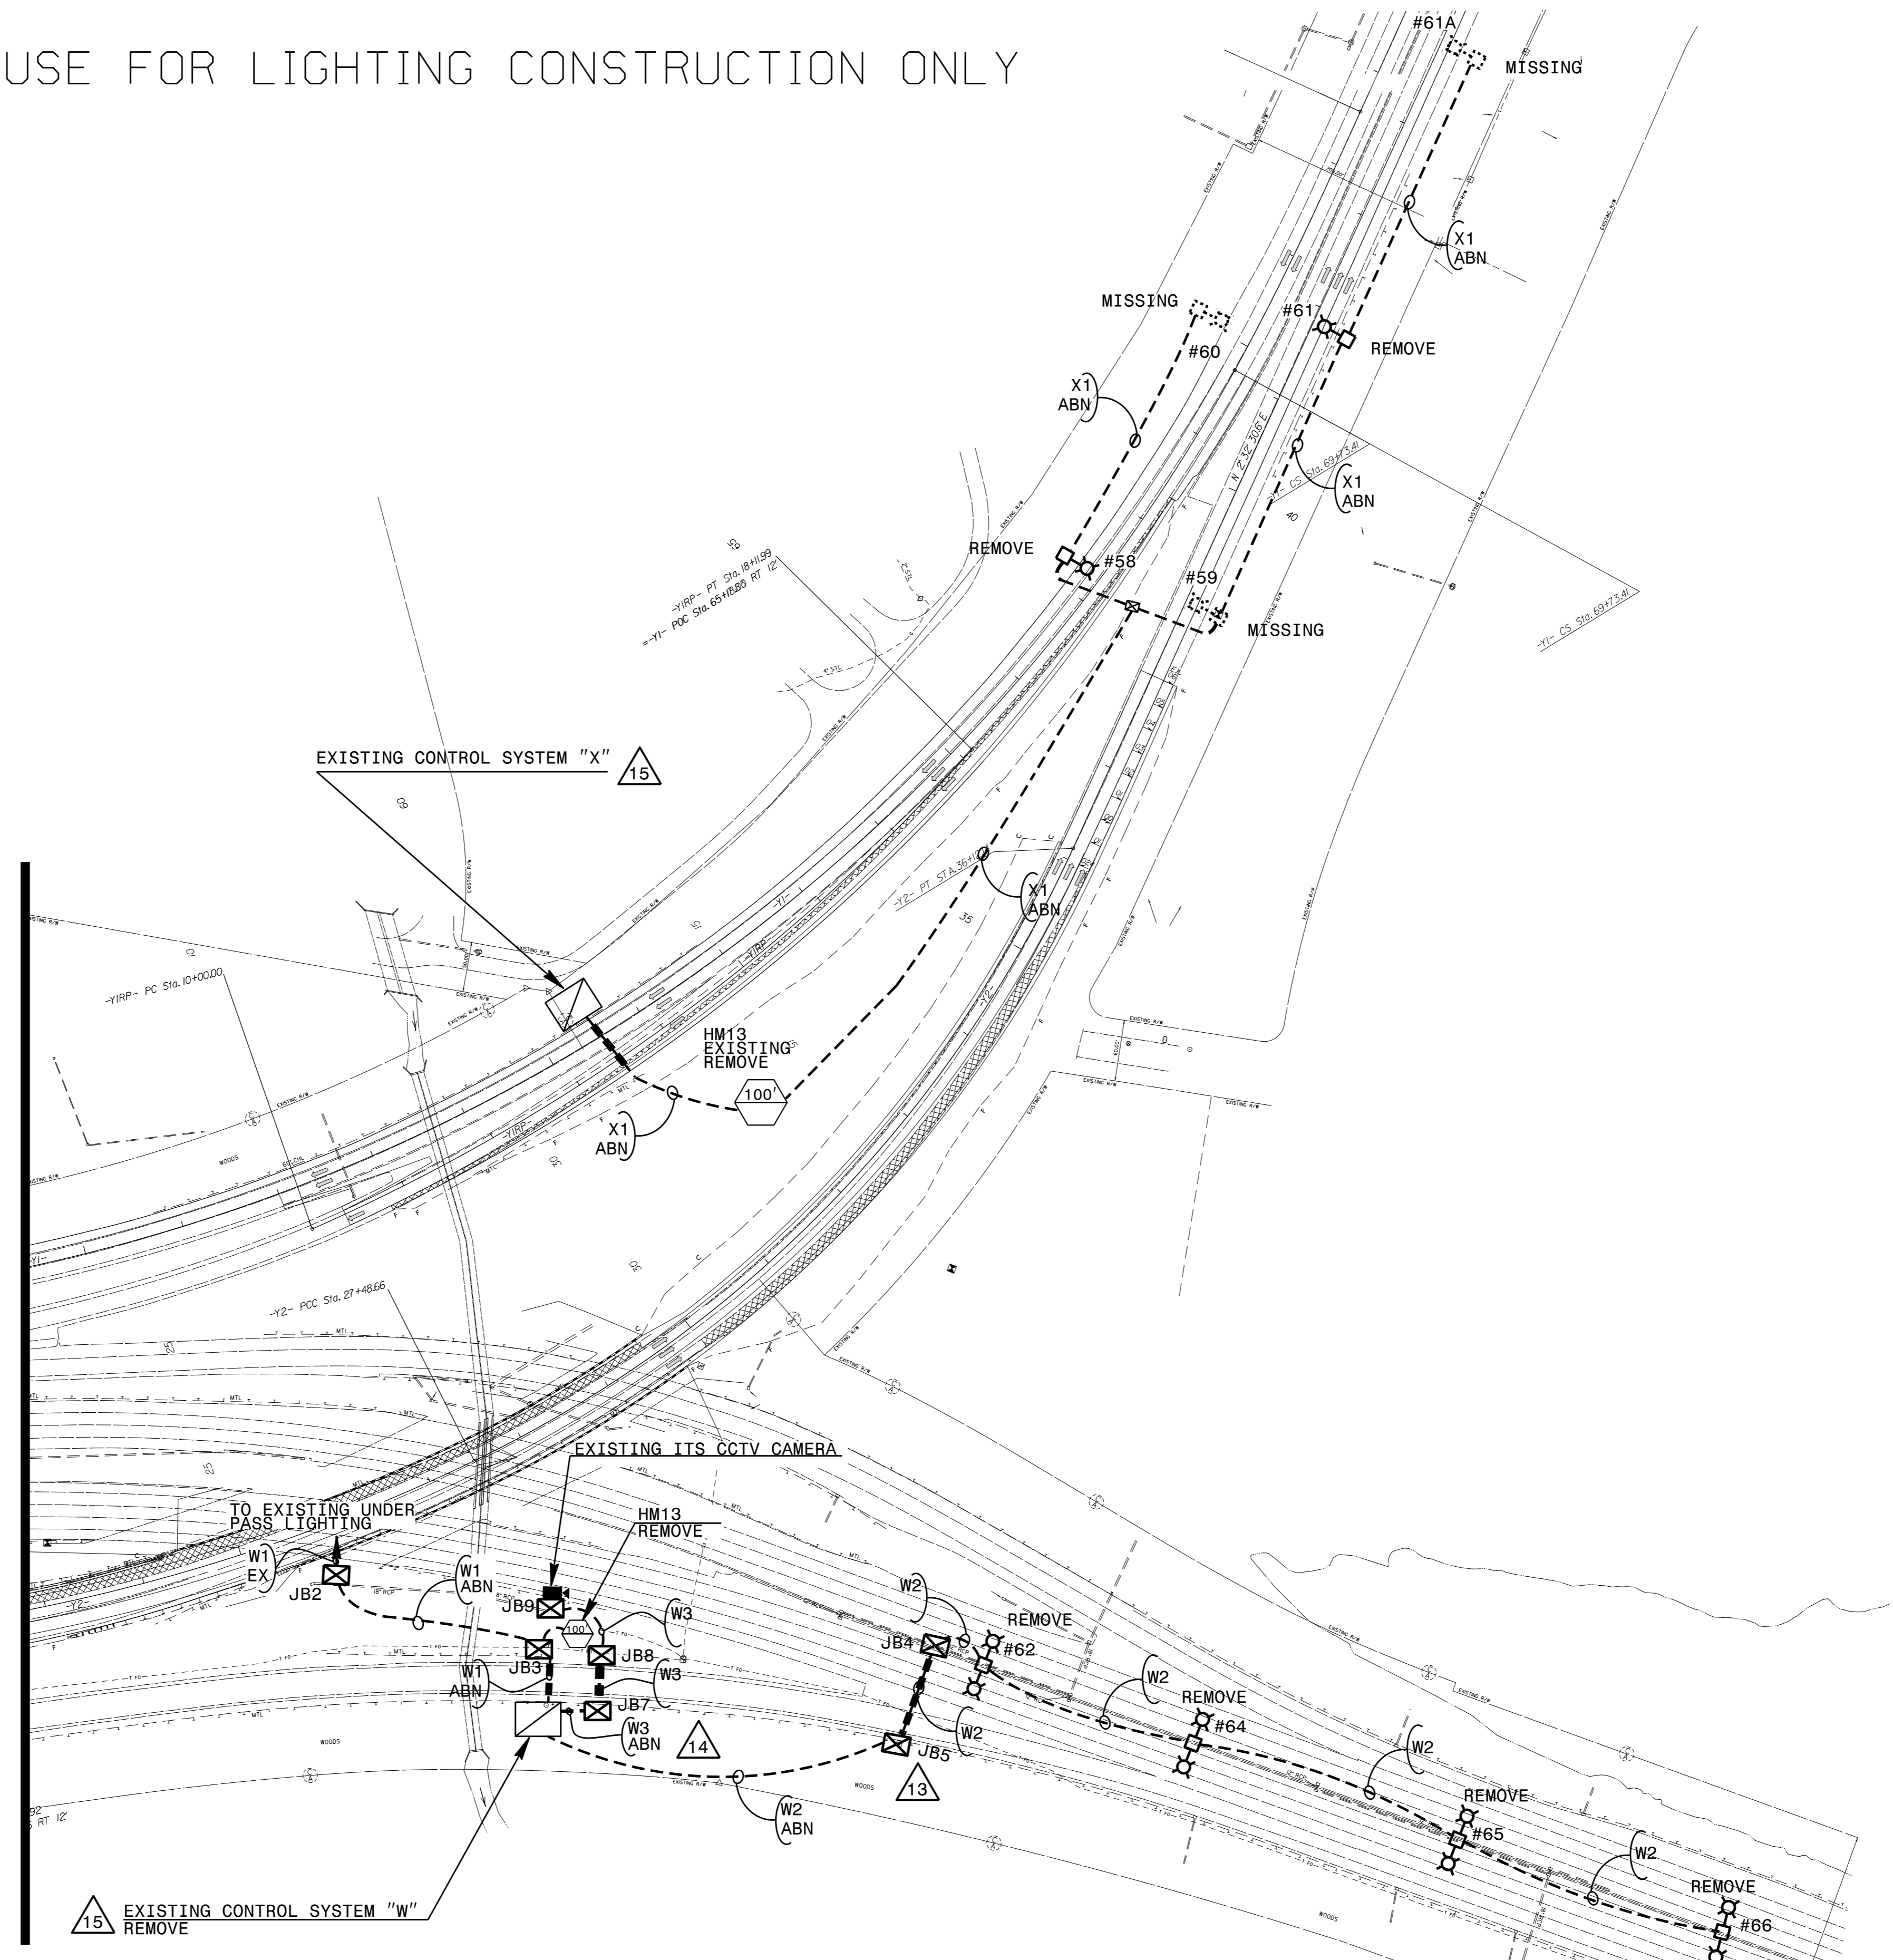

SEE SHEET "E-1" FOR
LEGEND & △ NOTES

2			
1			
Rev.	Date	Description	Approved
NORTH CAROLINA DEPARTMENT OF TRANSPORTATION ROADWAY DESIGN LIGHTING/ELECTRICAL SECTION LIGHTING LAYOUT EXISTING I-40/US 220 INTERCHANGE GUILFORD COUNTY			
Drawn By:	AB	Approved By:	Dwg No.:

NOTE: EXISTING JUNCTION BOXES JB2, JB4, JB5, JB7-9 AND THE CCTV CAMERA ARE TO BE REUSED.
ALL OTHER EXISTING EQUIPMENT IS TO BE REMOVED OR ABANDONED.

21-SEP-2021 08:35
R:\Lighting\Lighting Design\U5754_1&e_psh.e3.dgn
labr.cwrn
RD-304554