
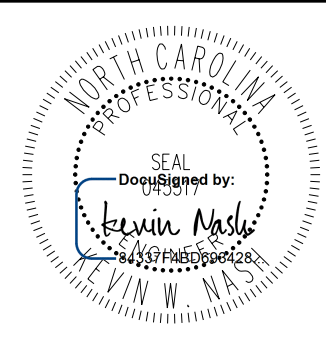
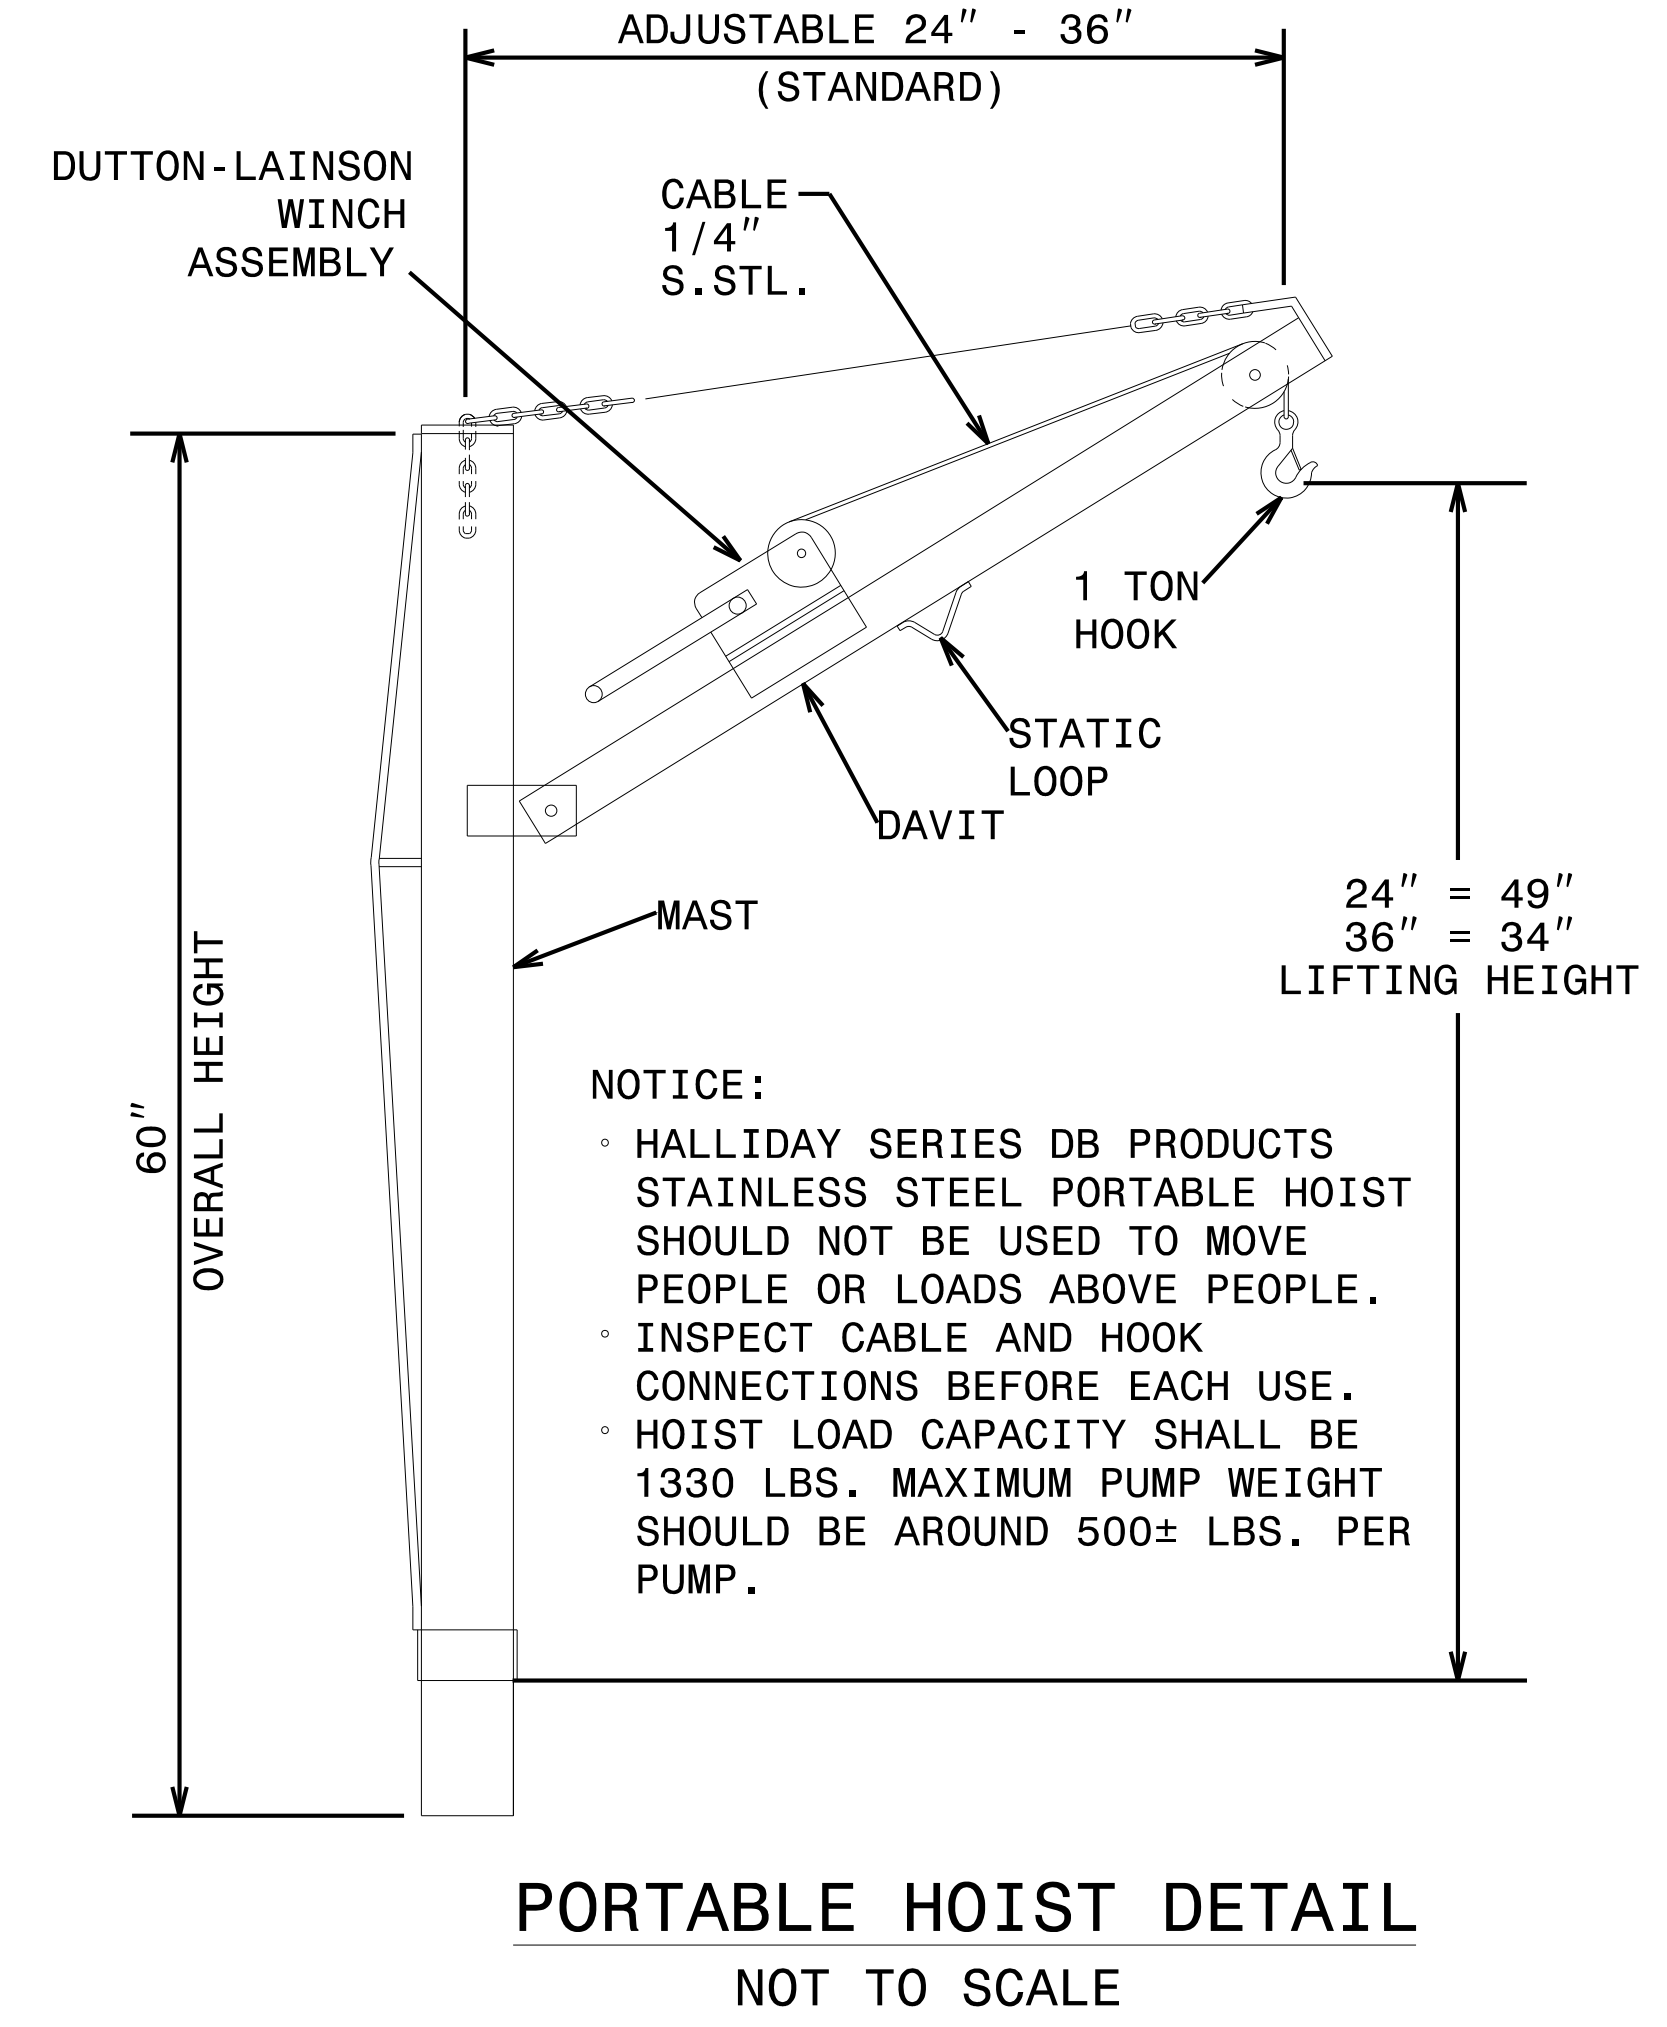
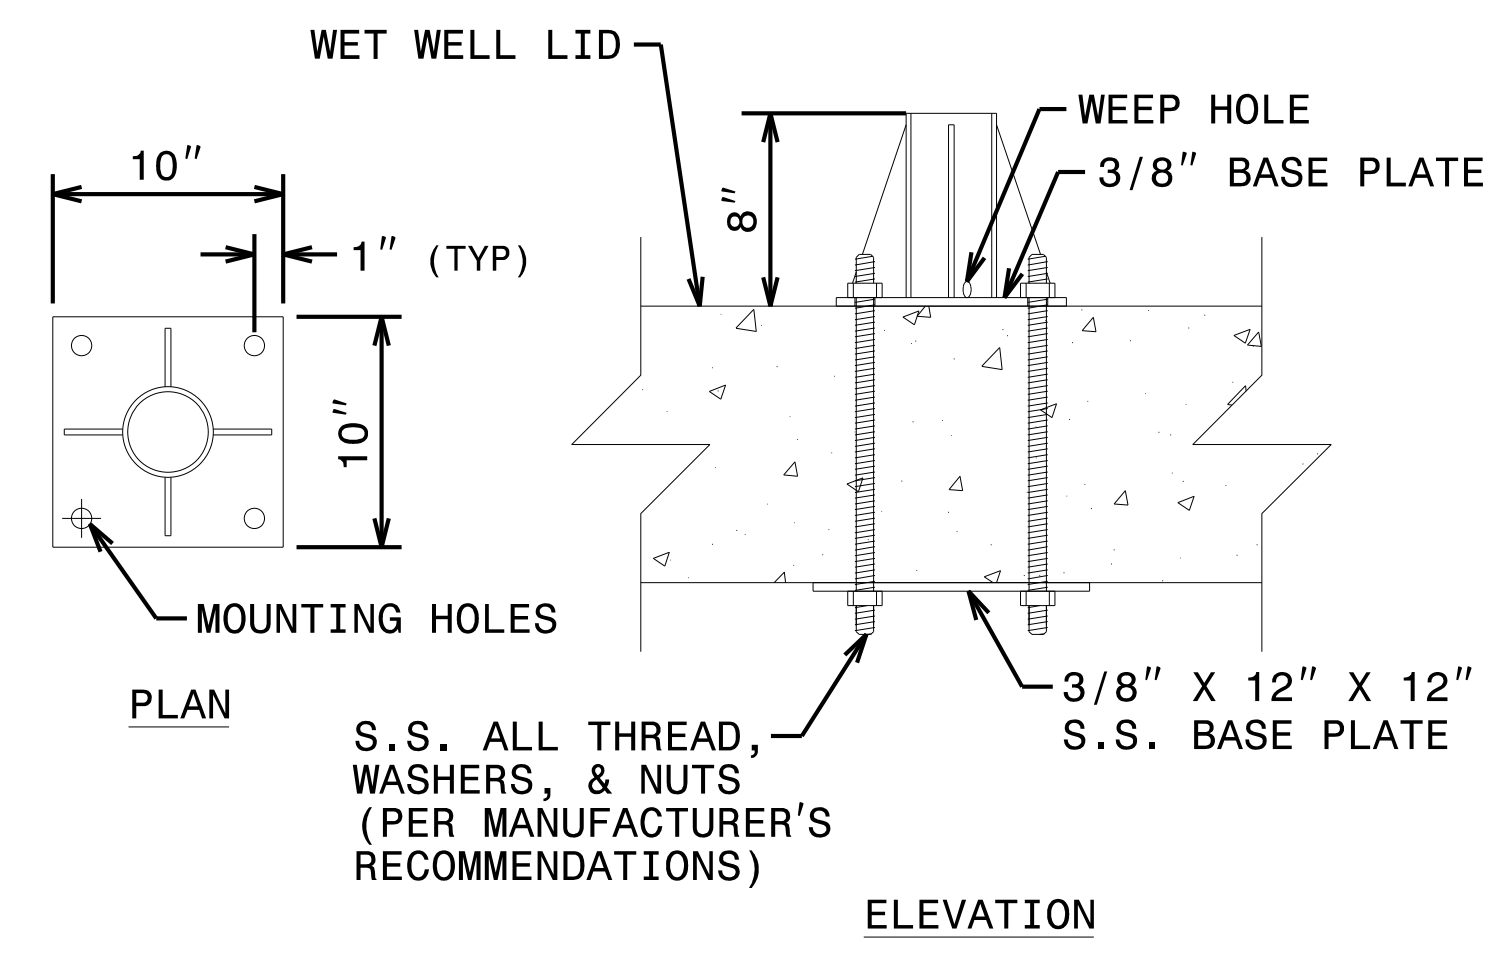
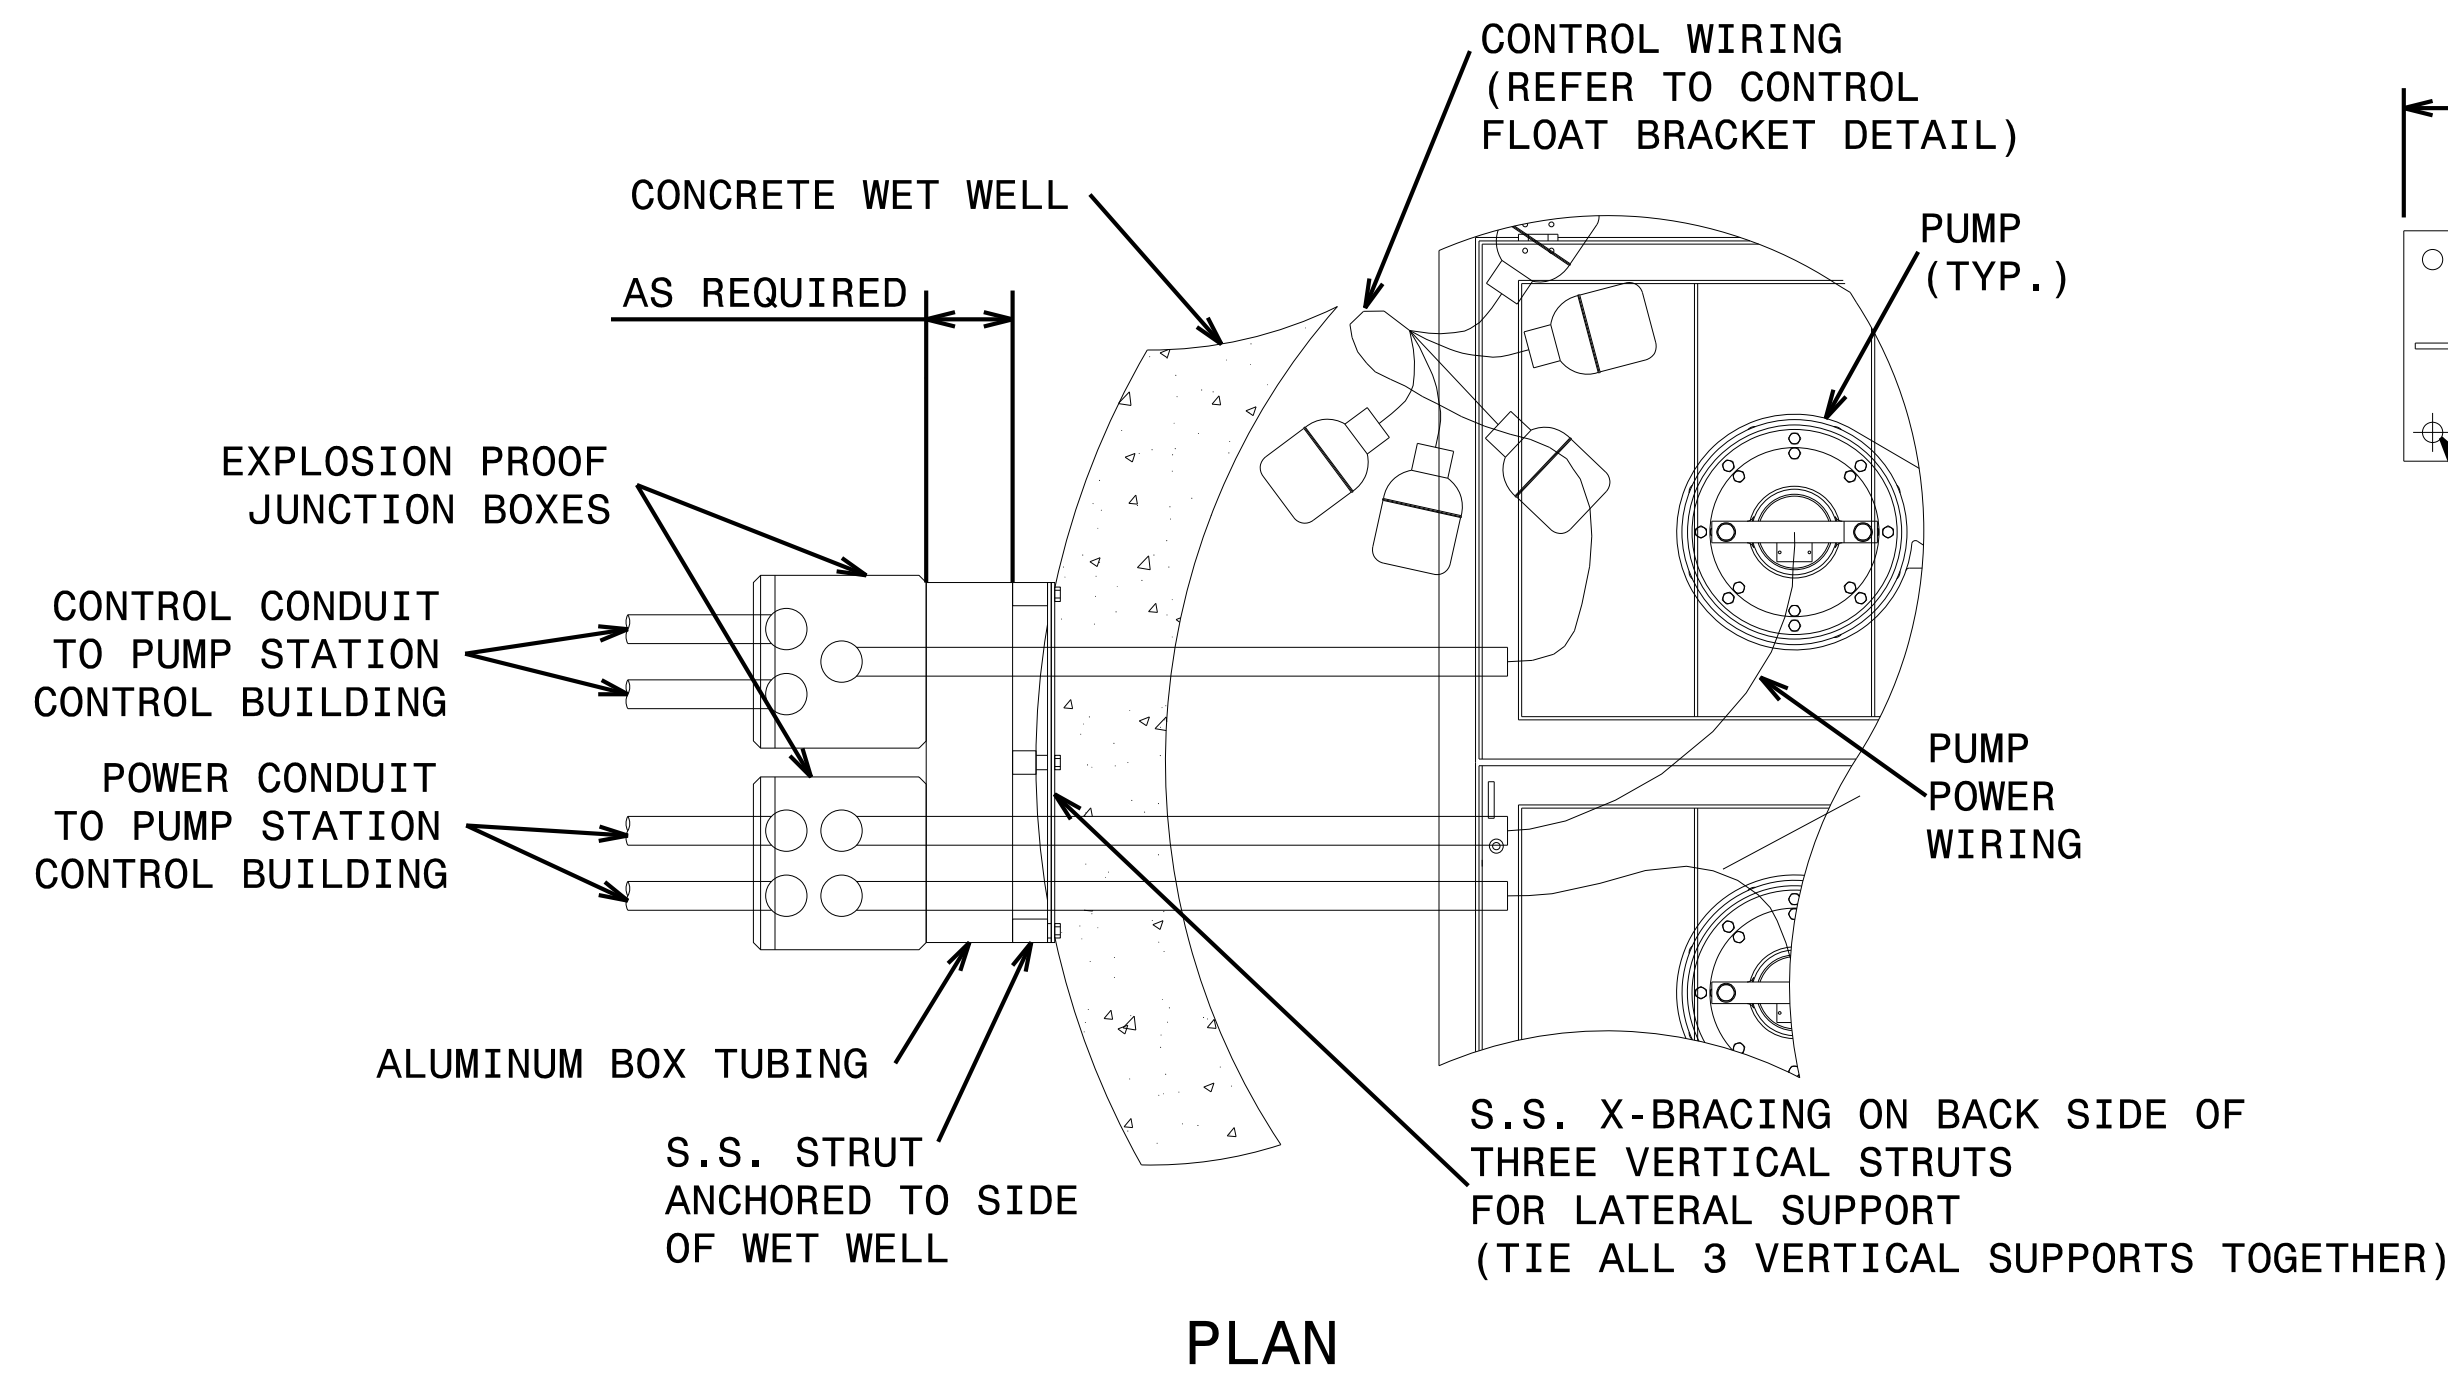
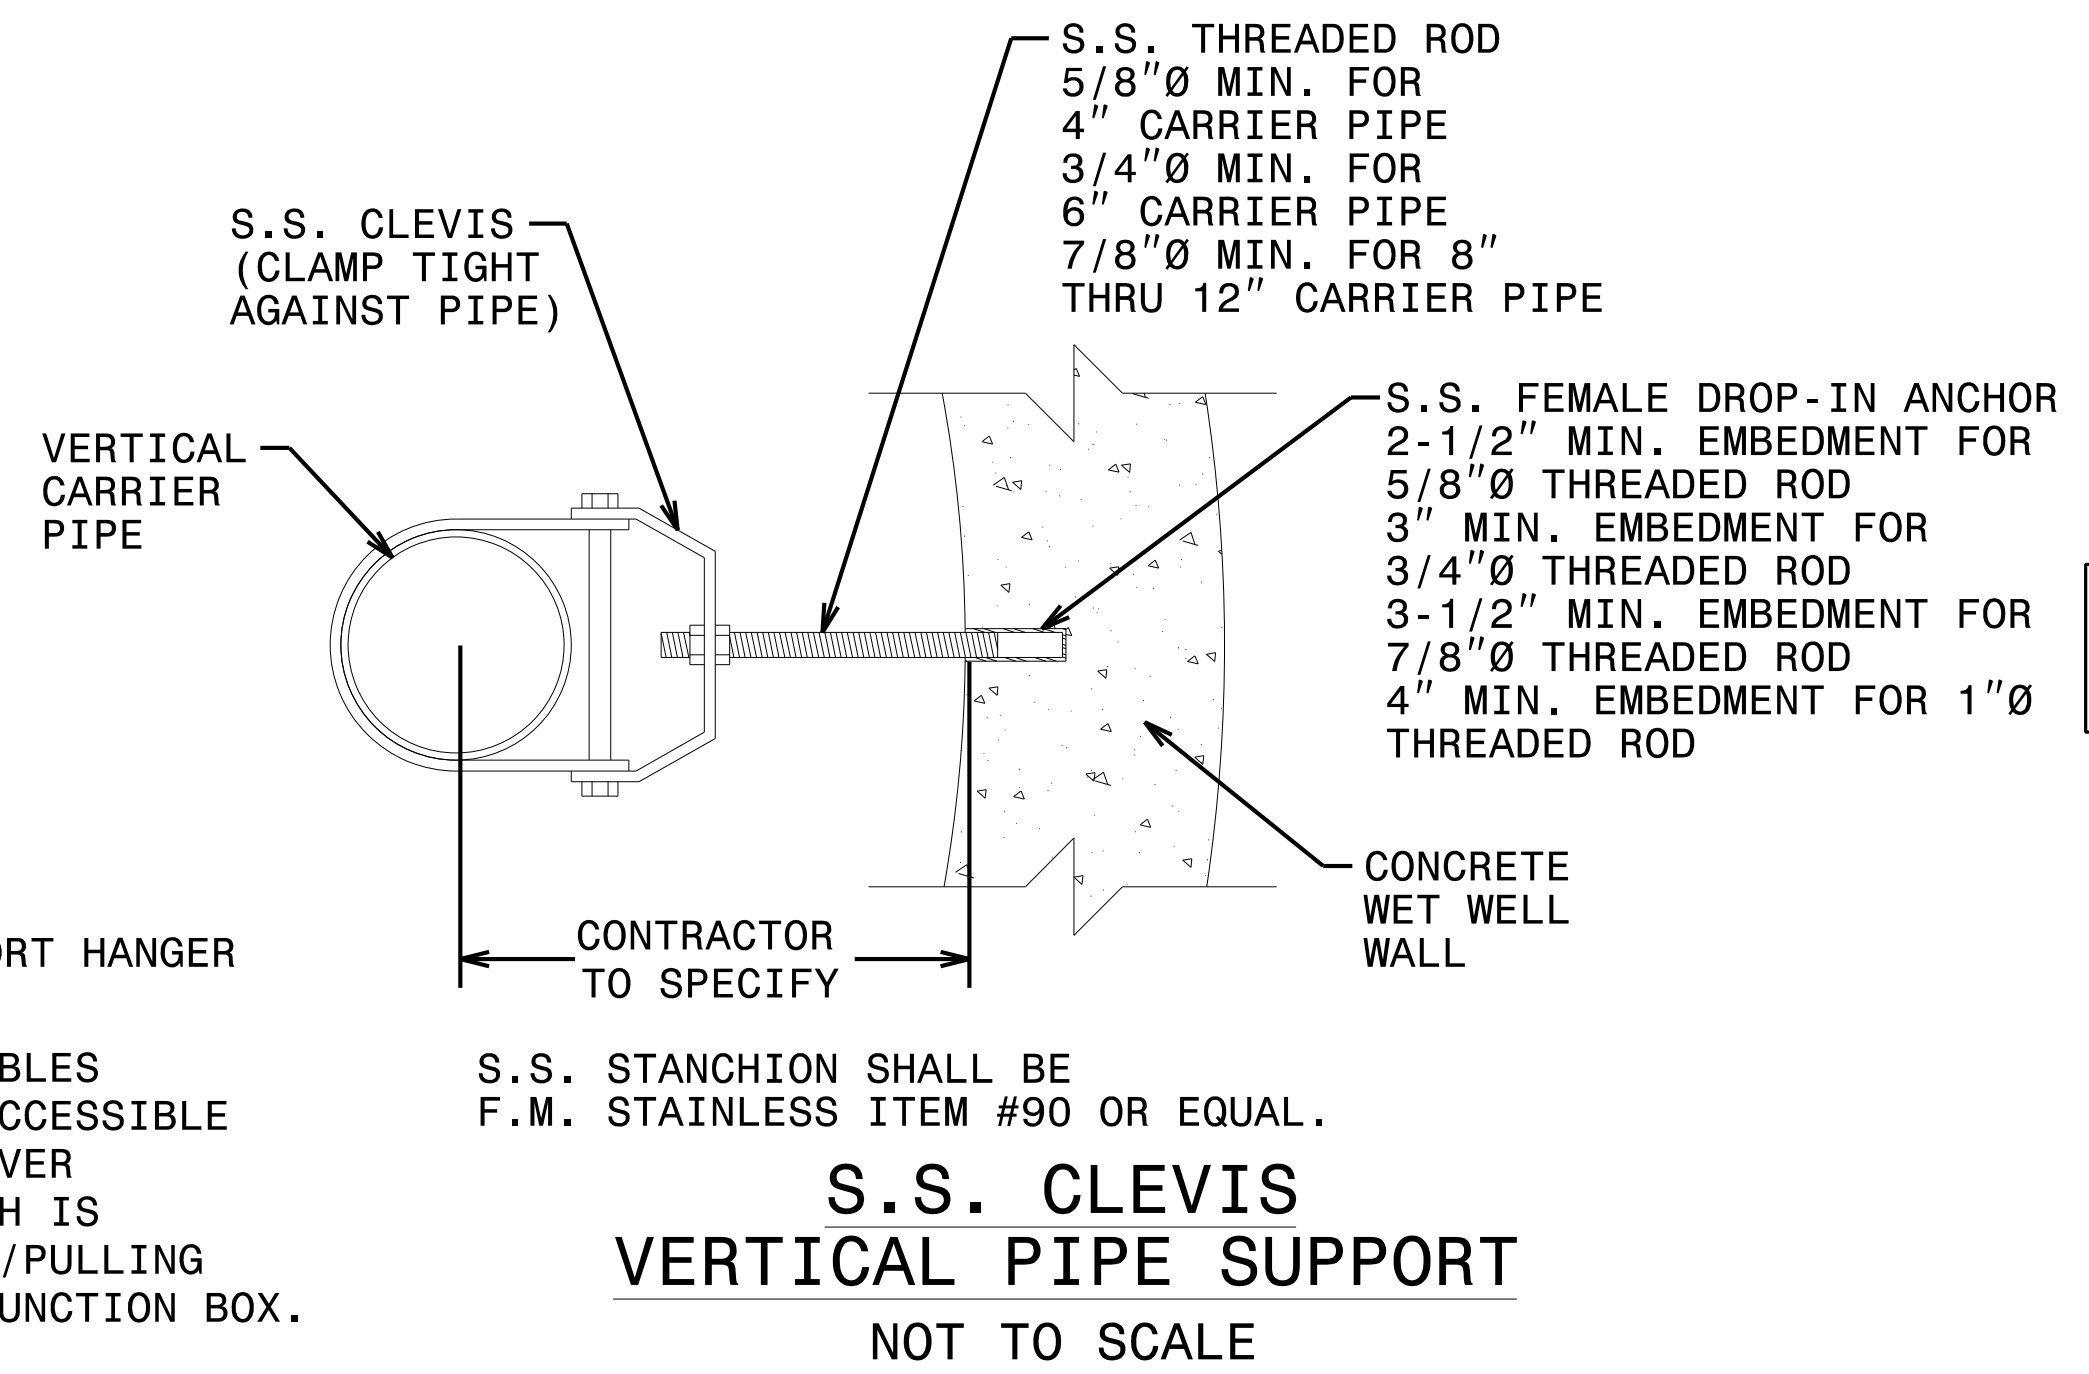


PROJECT REFERENCE NO.	SHEET NO.
R-5021	UC-P10
DESIGNED BY: DWT	
DRAWN BY: RAS	
CHECKED BY: JWC	
APPROVED BY: BMB	
REVISED:	
NORTH CAROLINA DEPARTMENT OF TRANSPORTATION	
UTILITIES ENGINEERING SEC. PHONE: (919) 707-6690 FAX: (919) 250-4151	UTILITY CONSTRUCTION PLANS ONLY

UTILITY CONSTRUCTION
DOCUMENT NOT CONSIDERED FINAL
UNLESS ALL SIGNATURES COMPLETED

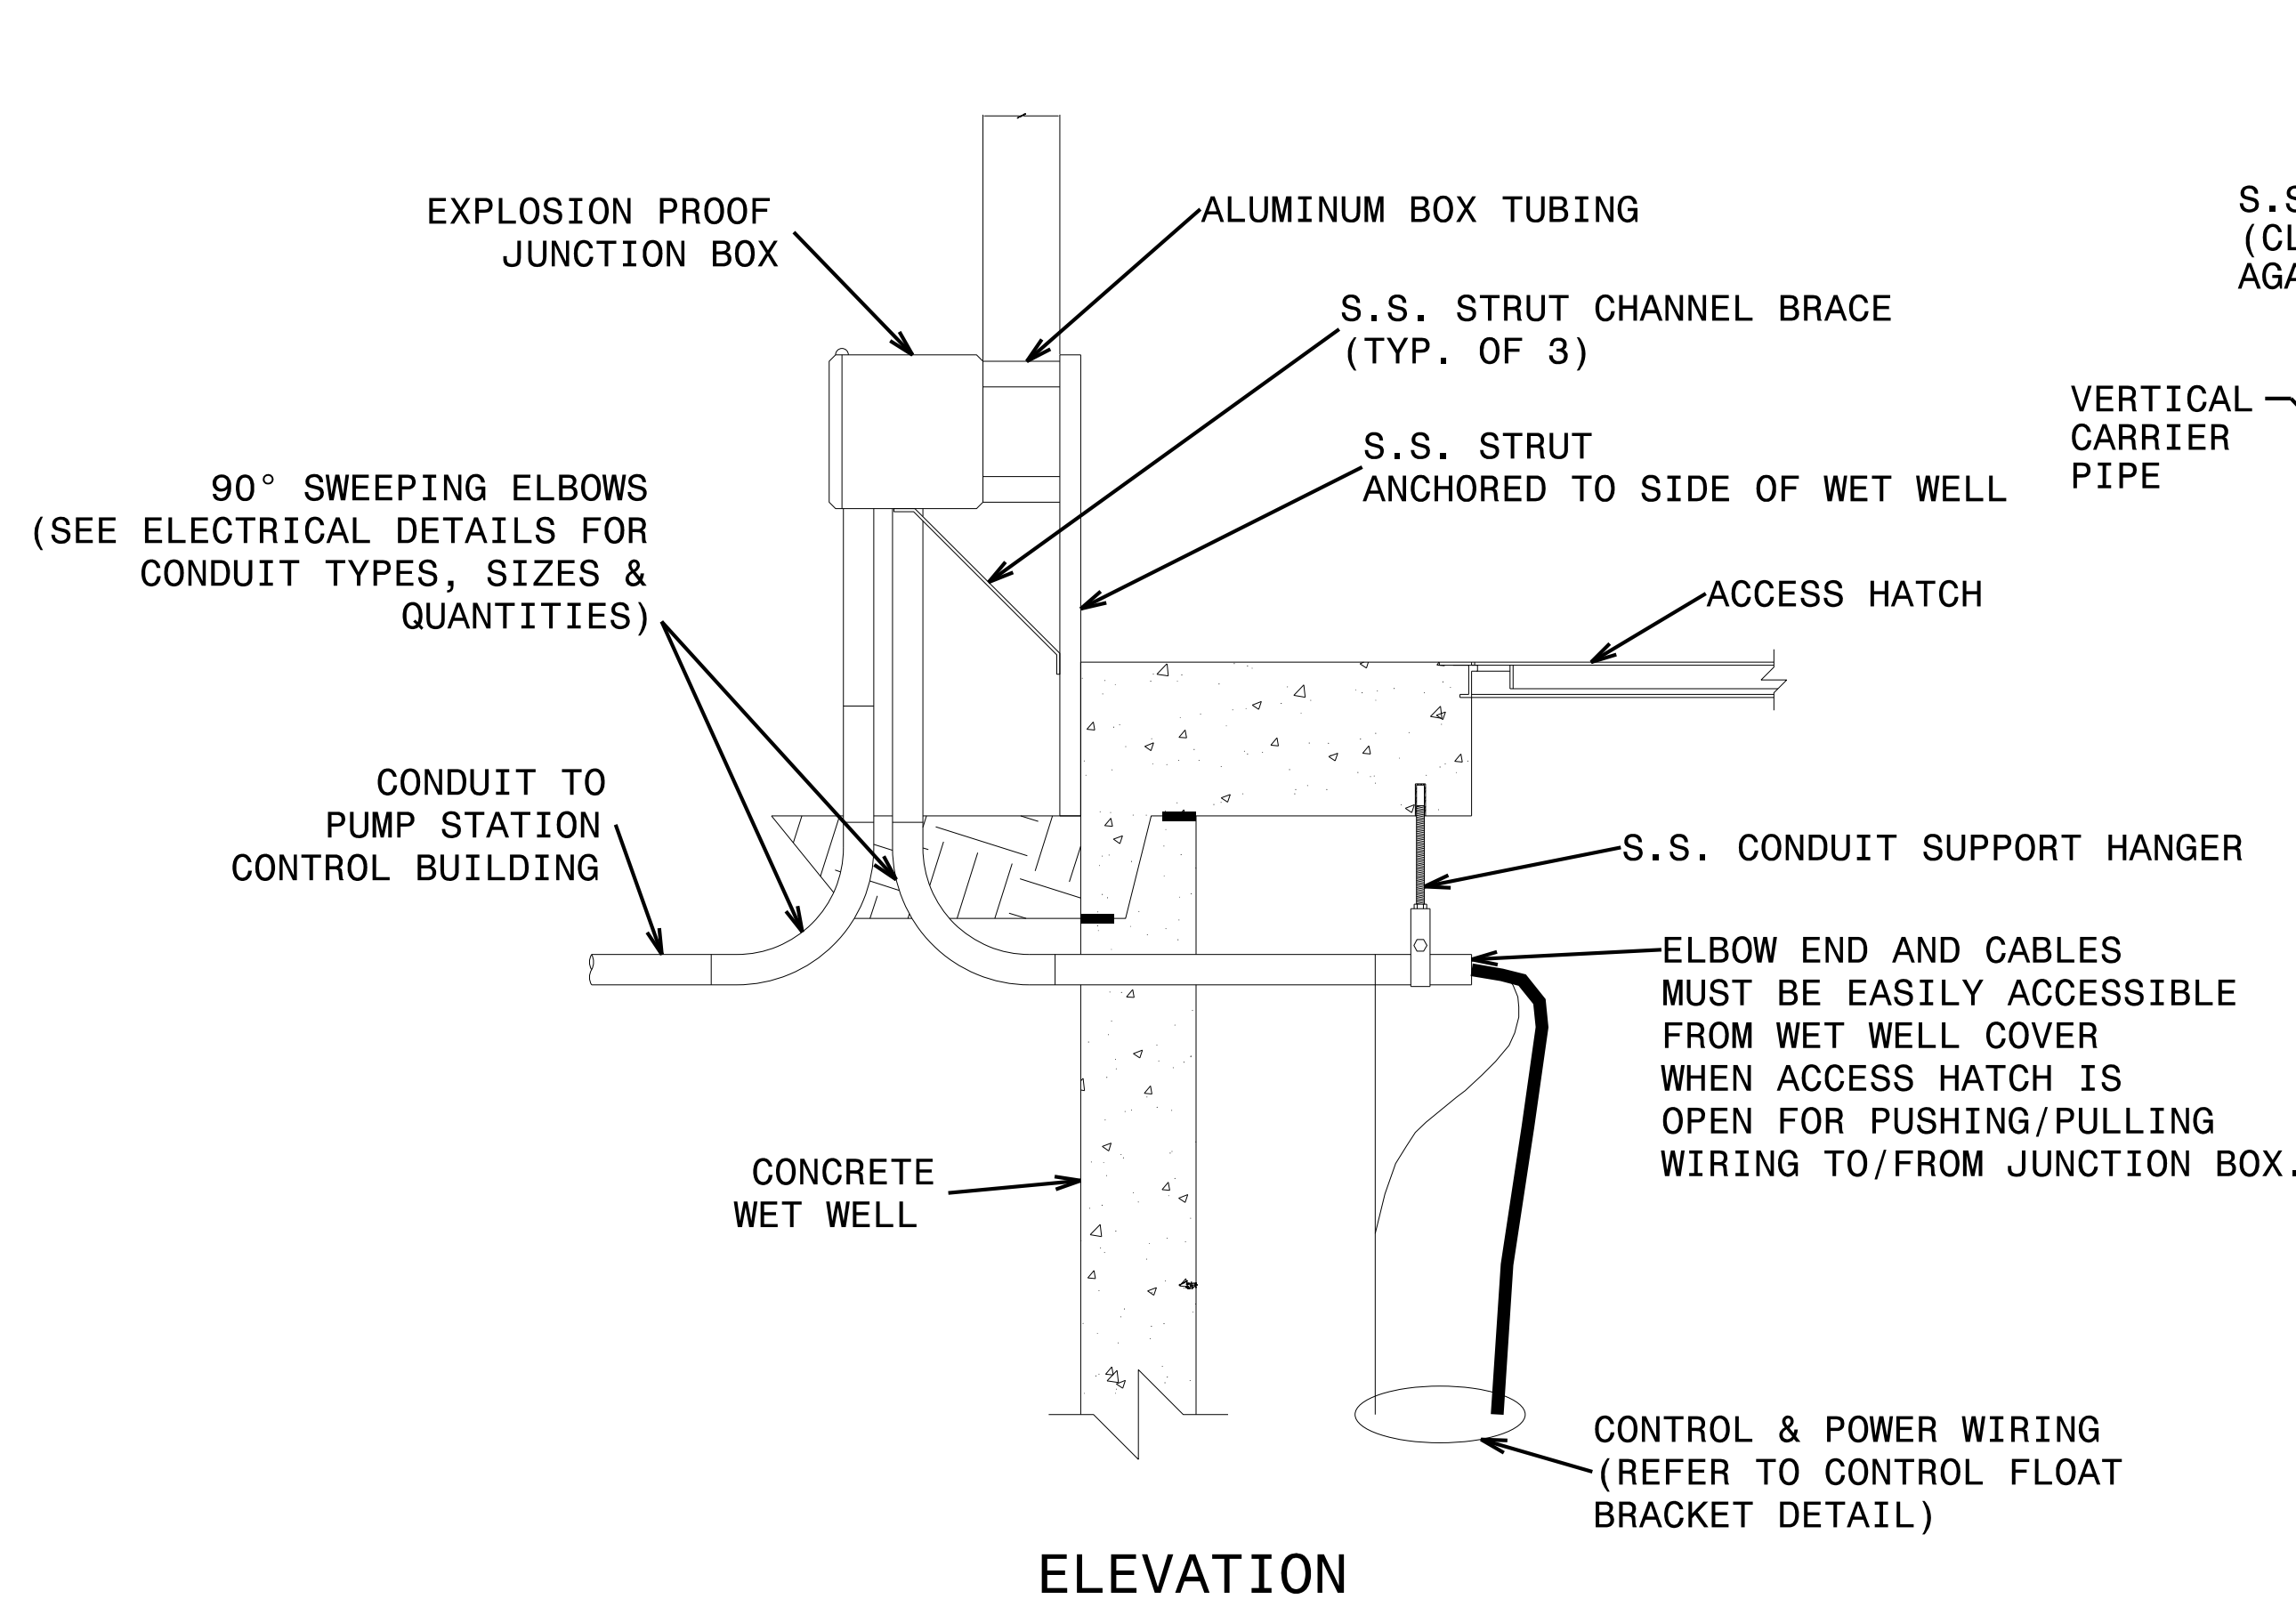

NOTE: REFER TO ELECTRICAL PLANS AND DETAILS FOR FURTHER INFORMATION.

JUNCTION BOX ARRANGEMENT
DETAIL
NOT TO SCALE

PUMP STATION DETAILS