


STATE OF NORTH CAROLINA  
DIVISION OF HIGHWAYS

UTILITY CONSTRUCTION PLANS  
DARE COUNTY

LOCATION: SR 1217 (COLINGTON RD.) FROM COLINGTON DRIVE TO  
BERMUDA BAY BOULEVARD


TYPE OF WORK: WATER LINE RELOCATION

TIP PROJECT: R-5014

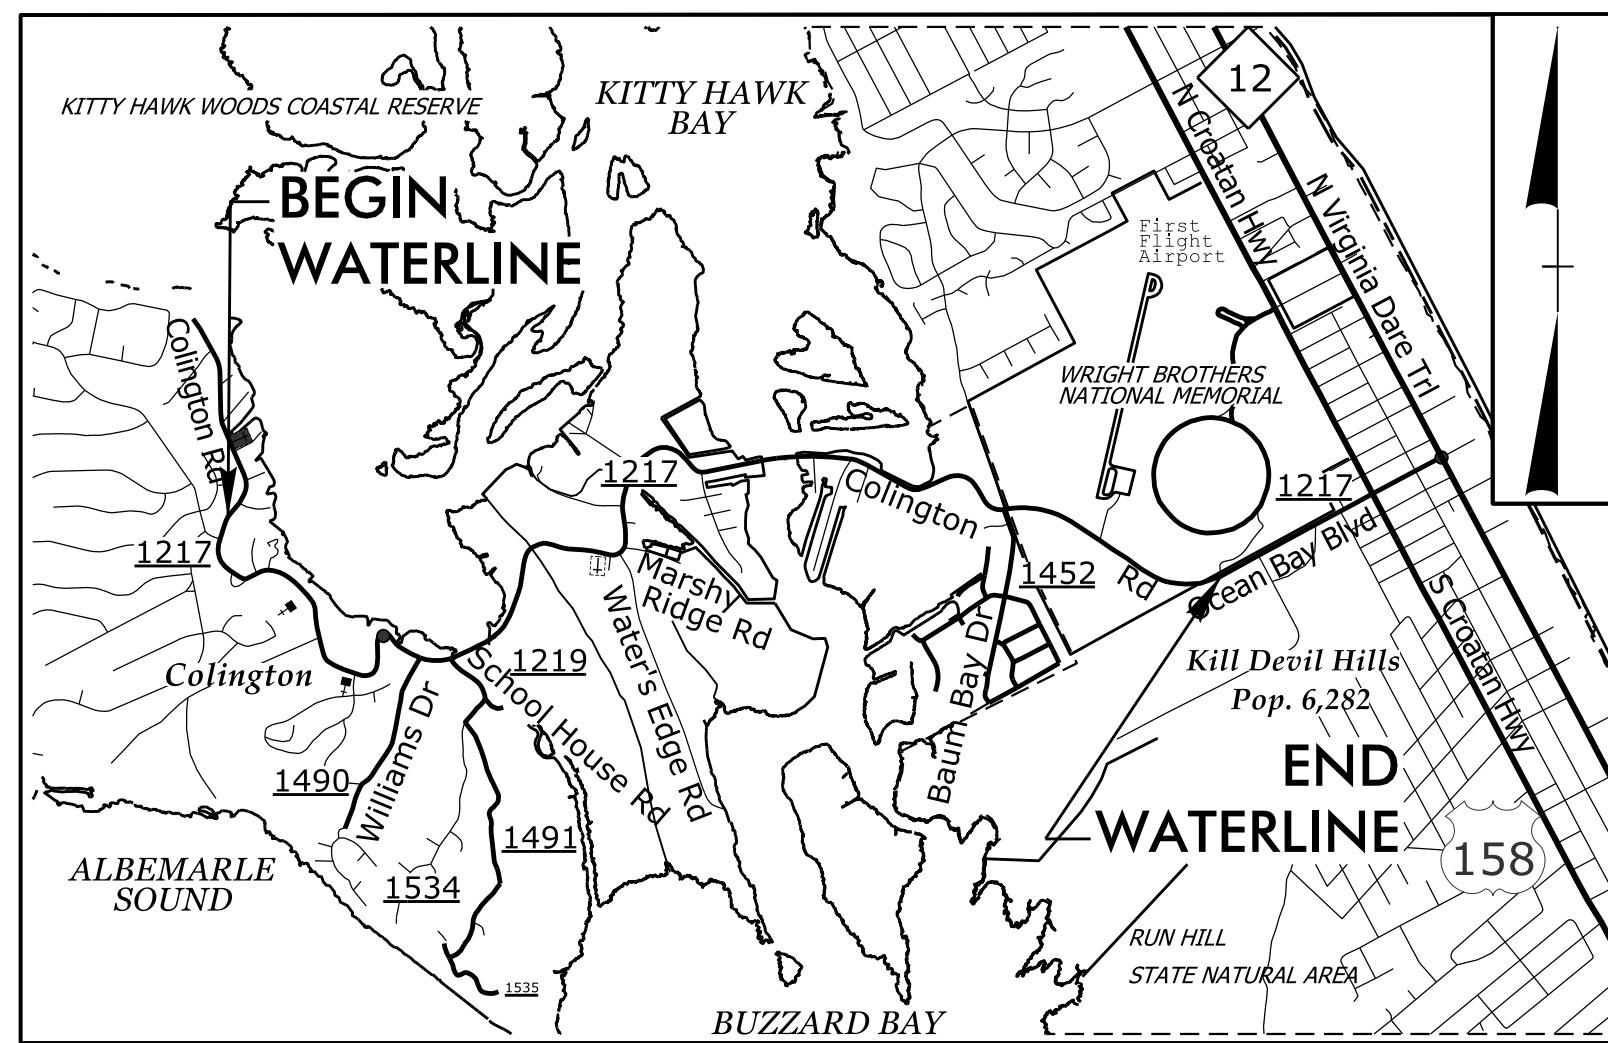


VICINITY MAP

N. T. S.

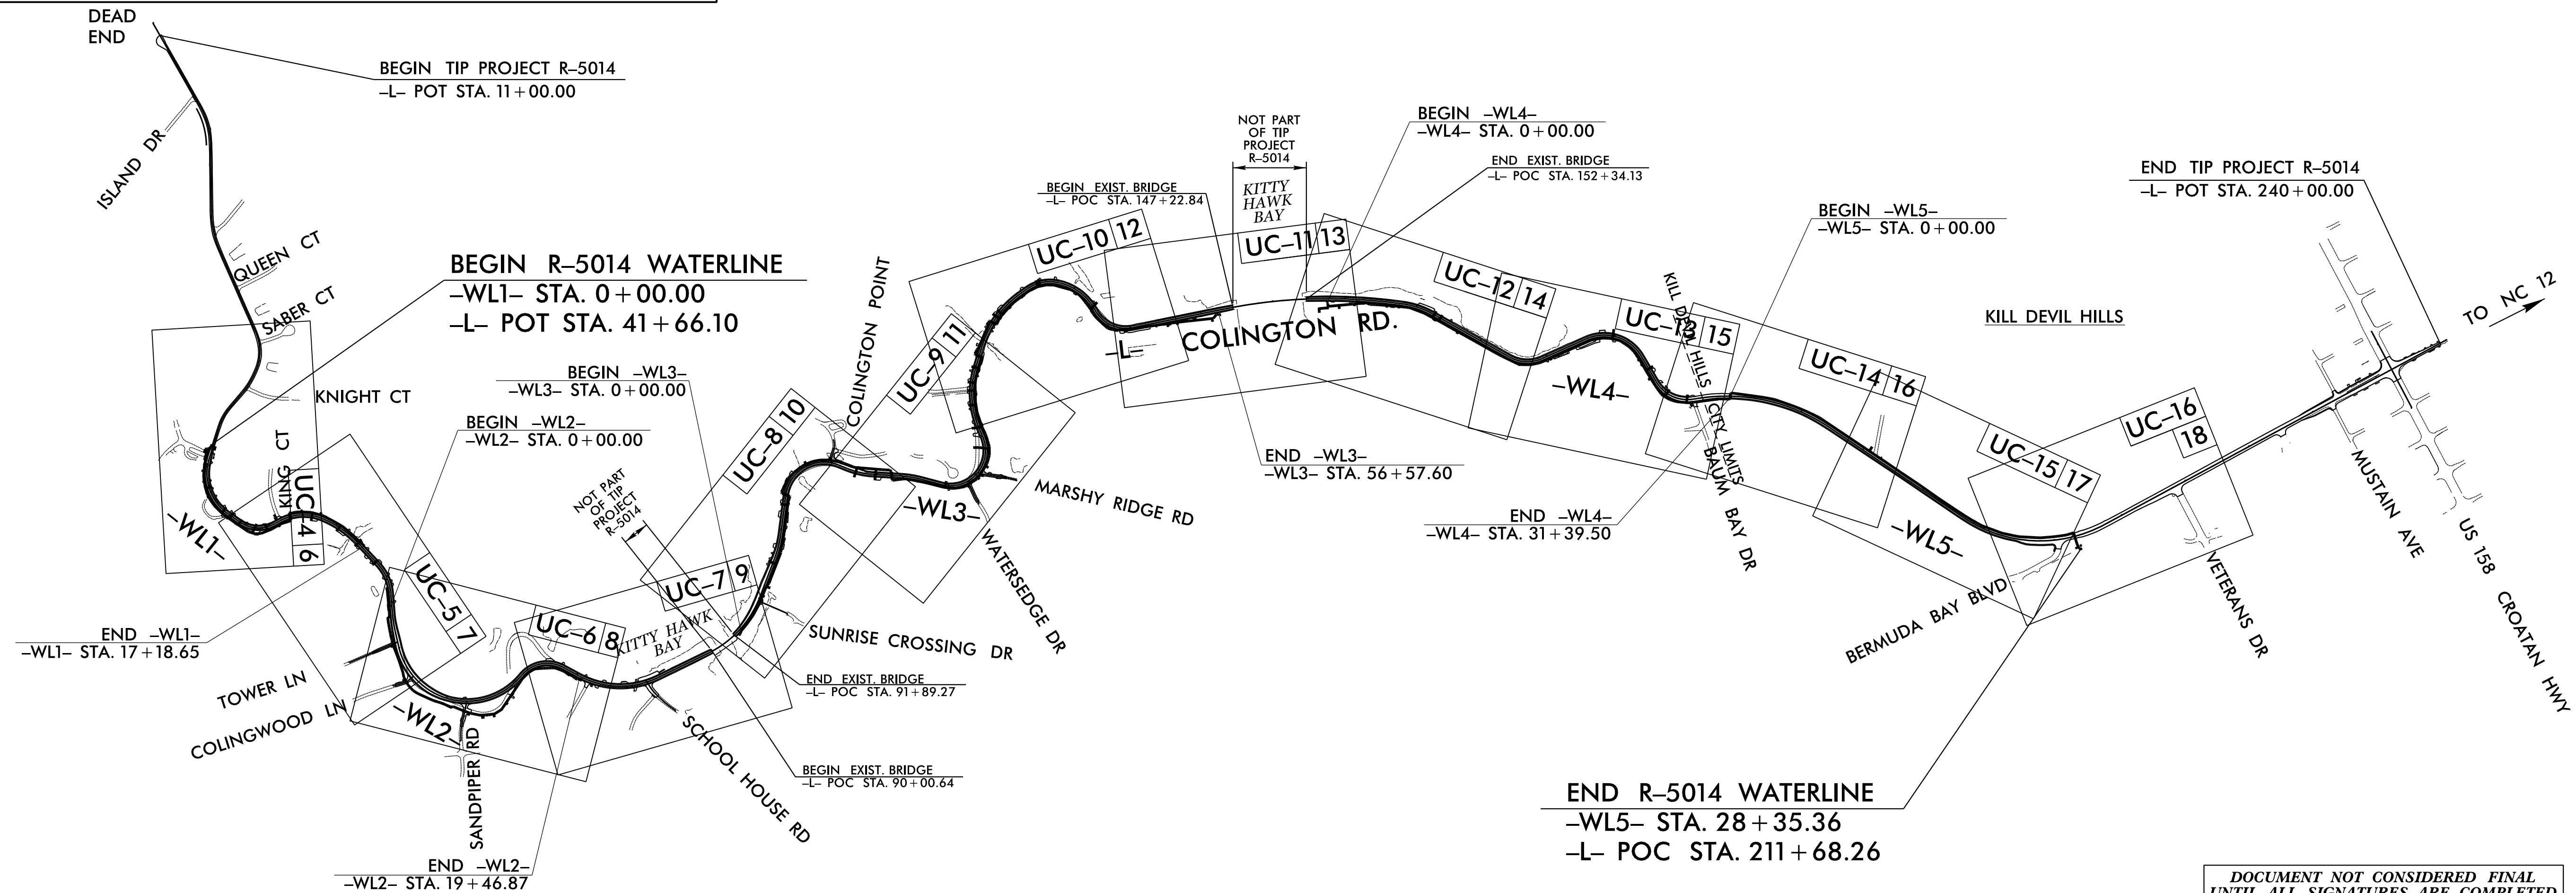

DOCUMENT NOT CONSIDERED FINAL  
UNTIL ALL SIGNATURES ARE COMPLETED

GRAPHIC SCALES

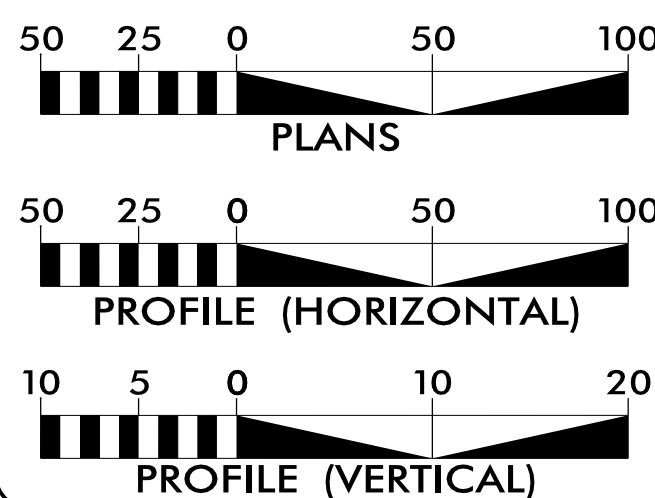

INDEX OF SHEETS

SHEET NO.:	DESCRIPTION:
UC-1	TITLE SHEET
UC-2	UTILITY SYMBOLOGY
UC-3 THRU UC-3A	NOTES
UC-3B THRU UC-3G	DETAILS
UC-4 THRU UC-16	UTILITY PLAN SHEETS
UC-17 THRU UC-22	UTILITY PROFILE SHEETS

WATER AND SEWER  
OWNERS ON PROJECT

- (A) WATER - DARE COUNTY  
WATER DEPT
- (B) SANITARY SEWER - KILL DEVIL HILLS  
WASTE WATER TREATMENT PLANT  
(KDHWWTP, LLC)



PREPARED IN THE OFFICE OF



CDM Smith Inc.  
5400 Glenwood Avenue  
Suite 400  
Raleigh, NC 27612-3228  
NC COA No. F-1255

DAVID DORAN PROJECT ENGINEER  
 JOHN BOYER, P.E. PROJECT MANAGER  
 CLAY TAPPAN, P.E. PROJECT DESIGN ENGINEER

SEAL

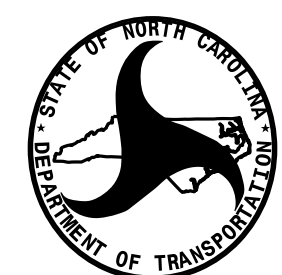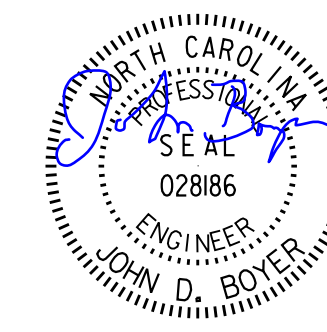

DIVISION OF HIGHWAYS  
UTILITIES UNIT  
1555 MAIL SERVICES CENTER  
RALEIGH, NC 27699-1555  
PHONE (919) 707-6690  
FAX (919) 250-4151

NABIL HAMDAN UTILITIES REGIONAL ENGINEER  
 KELVIN MARTIN UTILITIES ENGINEER  
 VACANT UTILITIES AREA COORDINATOR  
 DAYTON MARTIN UTILITIES COORDINATOR