




USE FOR LIGHTING CONSTRUCTION ONLY

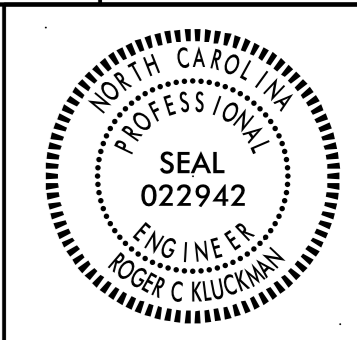

DocuSigned by: Roger Kluckman 7/13/2021

DOCUMENT NOT CONSIDERED FINAL UNLESS ALL SIGNATURES COMPLETED

 SEE SHEET "E-1" FOR LEGEND & △ NOTES

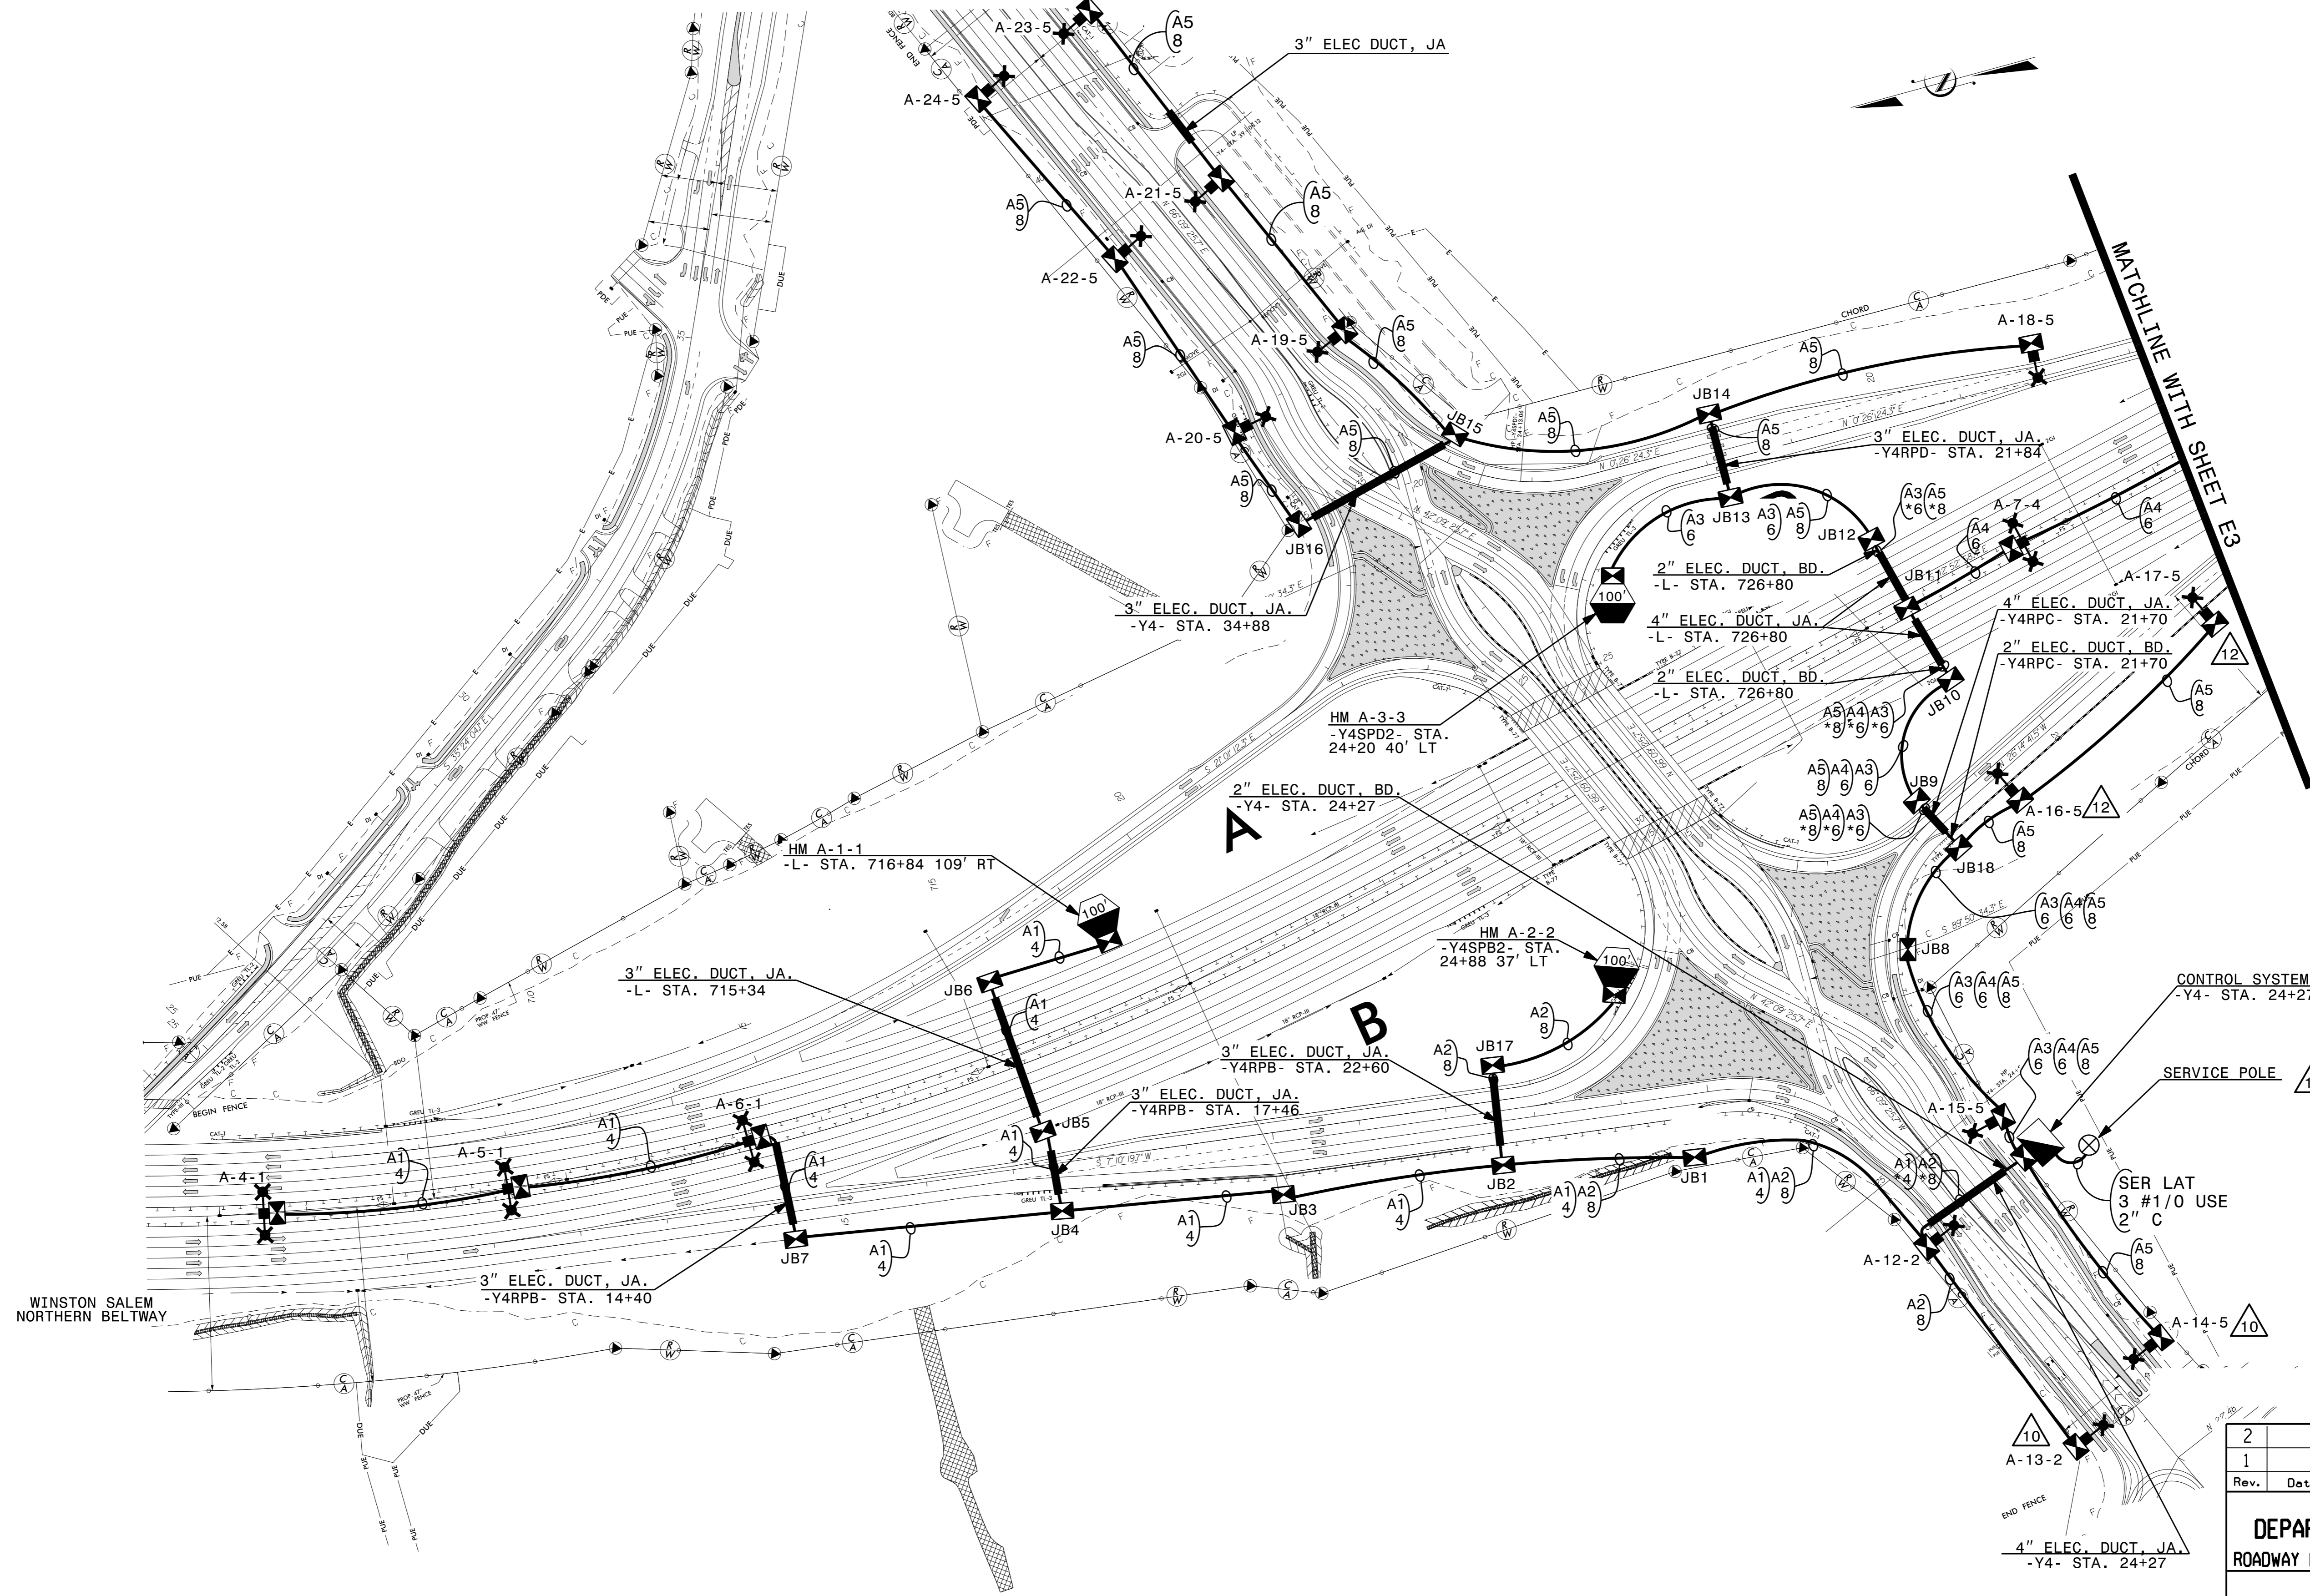

Rev.	Date	Description	Approved
2			
1			

NORTH CAROLINA DEPARTMENT OF TRANSPORTATION
ROADWAY DESIGN LIGHTING/ELECTRICAL SECTION

LIGHTING LAYOUT
WS NORTHERN BELTWAY / KERNERSVILLE RD INTERCHANGE

FORSYTH COUNTY

Drawn By: AB Approved By: Dwg No.:

09-JUL-2021 08:59 R:\Lighting\Lighting Design\U-2579AB-1&e.psh.e2.dgn labr.cwm AT RD-304554