


09/08/99

TIP PROJECT: U-5888

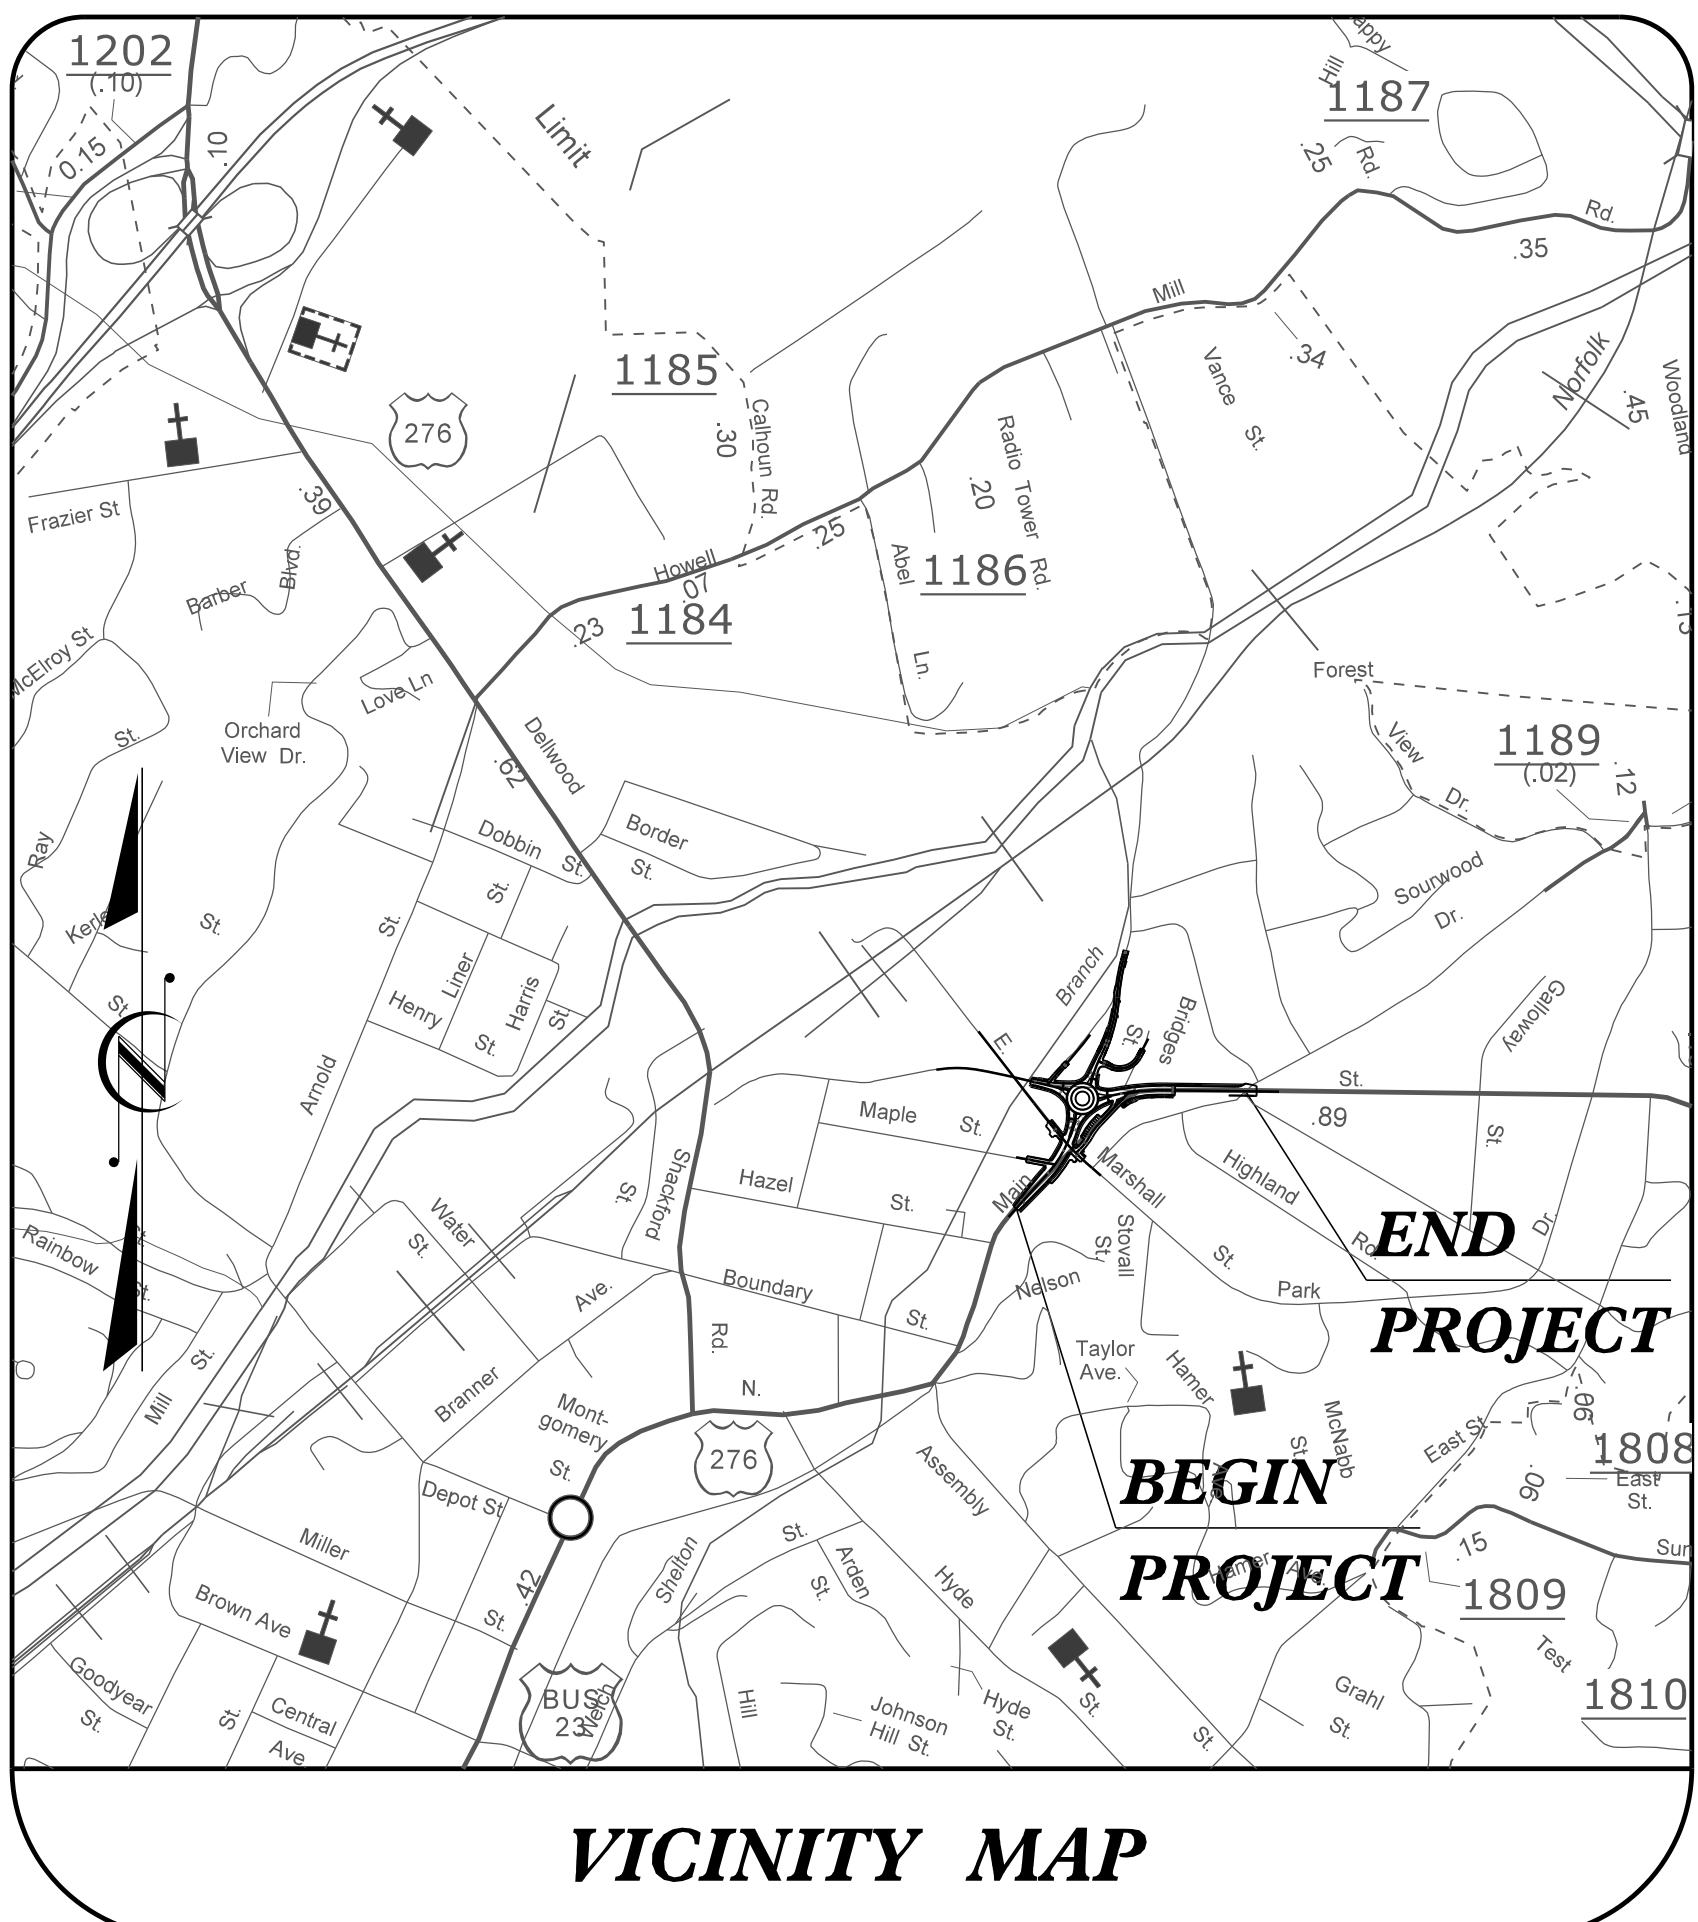

See Sheet 1-A For Index of Sheets
See Sheet 1-B For Conventional Symbols


STATE OF NORTH CAROLINA
DIVISION OF HIGHWAYS

**UTILITIES BY OTHERS PLANS
HAYWOOD COUNTY**

T.I.P. NO.	SHEET NO.
U-5888	UO-1

NOTE:
ALL UTILITY WORK SHOWN ON THIS SHEET WILL BE DONE BY OTHERS. NO PAYMENT WILL BE MADE TO THE CONTRACTOR FOR UTILITY WORK SHOWN ON THIS SHEET.


**LOCATION: WAYNESVILLE - INTERSECTION OF
US 23 BUSINESS (N. MAIN ST.) AND
WALNUT ST.**
**TYPE OF WORK: POWER, TELEPHONE, AND
CATV RELOCATION**

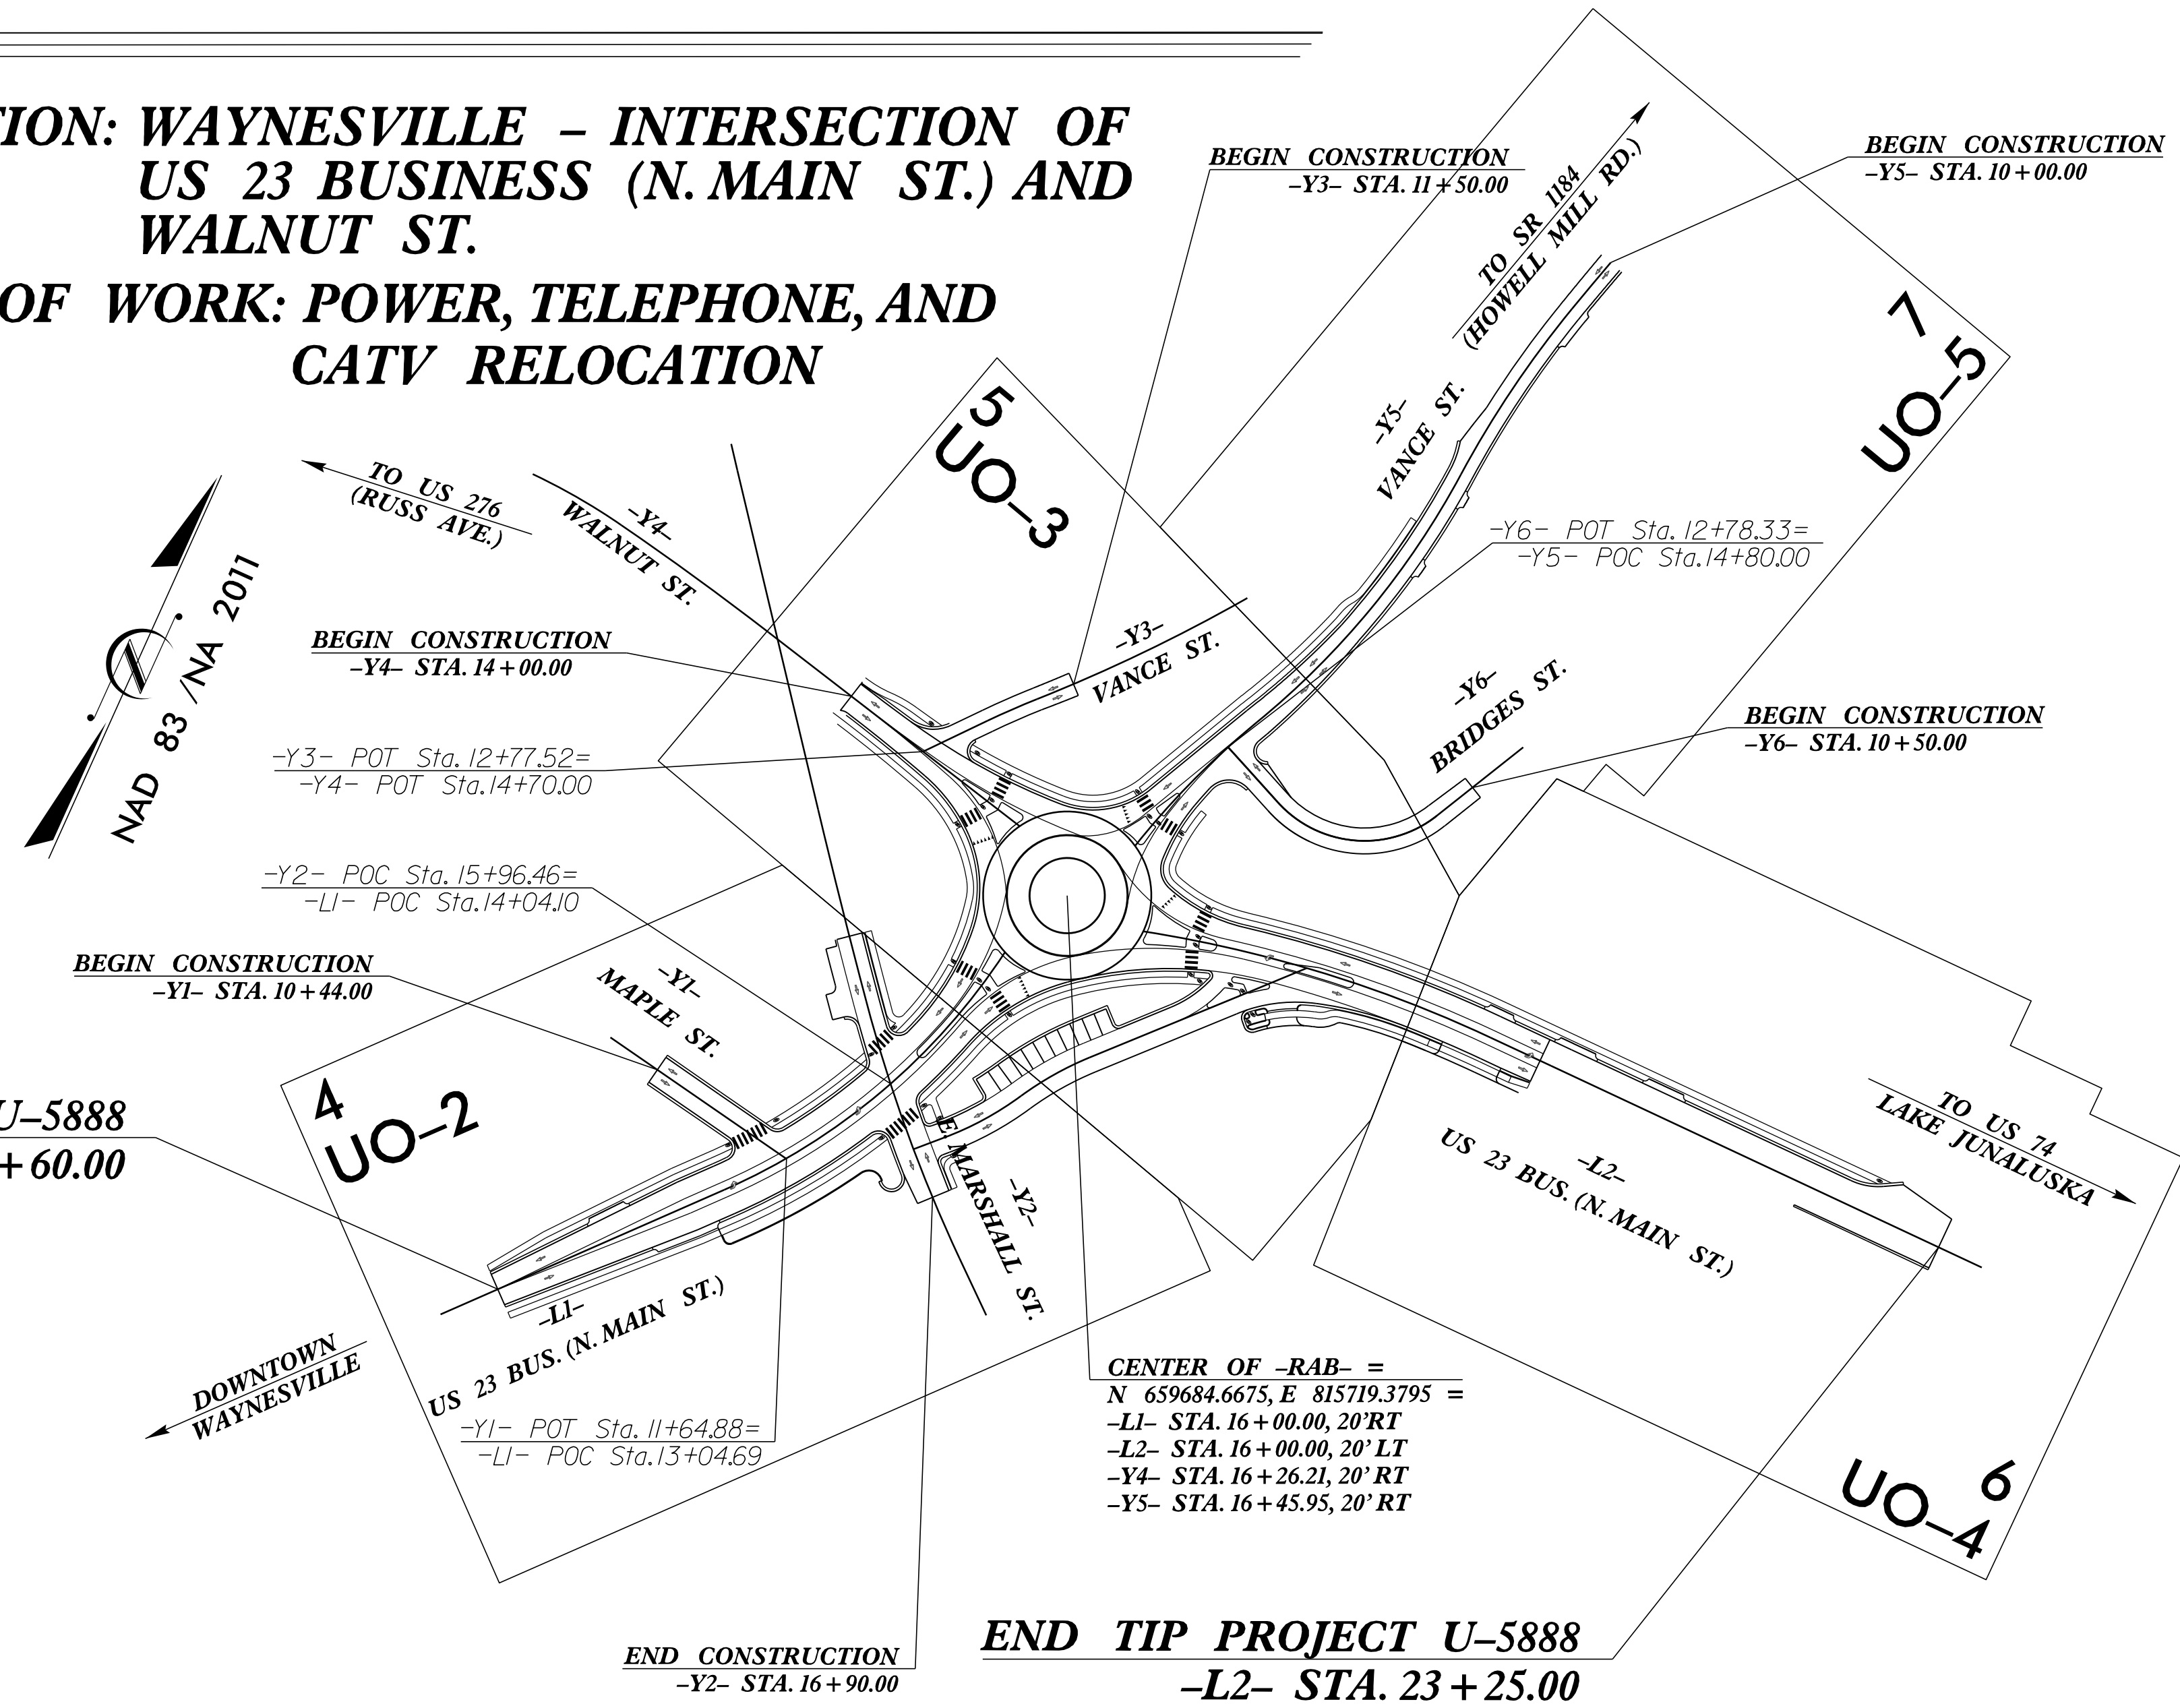

**BEGIN TIP PROJECT U-5888
-L1- STA. 10+60.00**

**END TIP PROJECT U-5888
-L2- STA. 23+25.00**

GRAPHIC SCALES

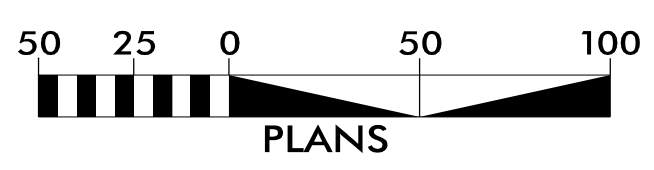

INDEX OF SHEETS

SHEET NO.:	DESCRIPTION:
UO-1	TITLE SHEET
UO-2	PLAN SHEET SYMBOLS
UO-3	NOT USED
UO-4 THRU UO-7	UBO PLAN SHEETS

UTILITY OWNERS WITH CONFLICTS

- (A) POWER - TOWN OF WAYNESVILLE
- (B) COMMUNICATION - AT&T
- (C) COMMUNICATION - MCNC
- (D) COMMUNICATION - BASLAM WEST
- (E) COMMUNICATION - ERC
- (F) CATV - CHARTER

PREPARED IN THE OFFICE OF:

1223 Jones Franklin Rd.
Raleigh, N.C. 27606
License No. F-0377
Bus: 919 851 8077
Fax: 919 851 8107

TRANSPORTATION PLANNING/DESIGN - BRIDGE/STRUCTURE DESIGN
CIVIL/SITE DESIGN - GIS/GPS - CONSTRUCTION OBSERVATION

John D. Schriener, PLS PROJECT UTILITY COORDINATOR

**DIVISION OF HIGHWAYS
DIVISION 14**

253 Webster Road
Sylva, NC, 28779

J. Scott Miller, III Division 14 DDC Engineer
Bob Golding Division Utility Coordinator
Bill Green Division Utility Coordinator

\$\$\$\$\$ SYSTEM \$\$\$\$\$\$ DGN\$\$\$\$\$ USER NAME \$\$\$\$\$\$