


09.08/19

10/19/2021 12:51:28 PM  
 P:\2016\16133.01\_U-5888\Structures\DCN\U-5888\_SMU\_TSH.dgn

**TIP PROJECT: U-5888**

**CONTRACT: C204675**

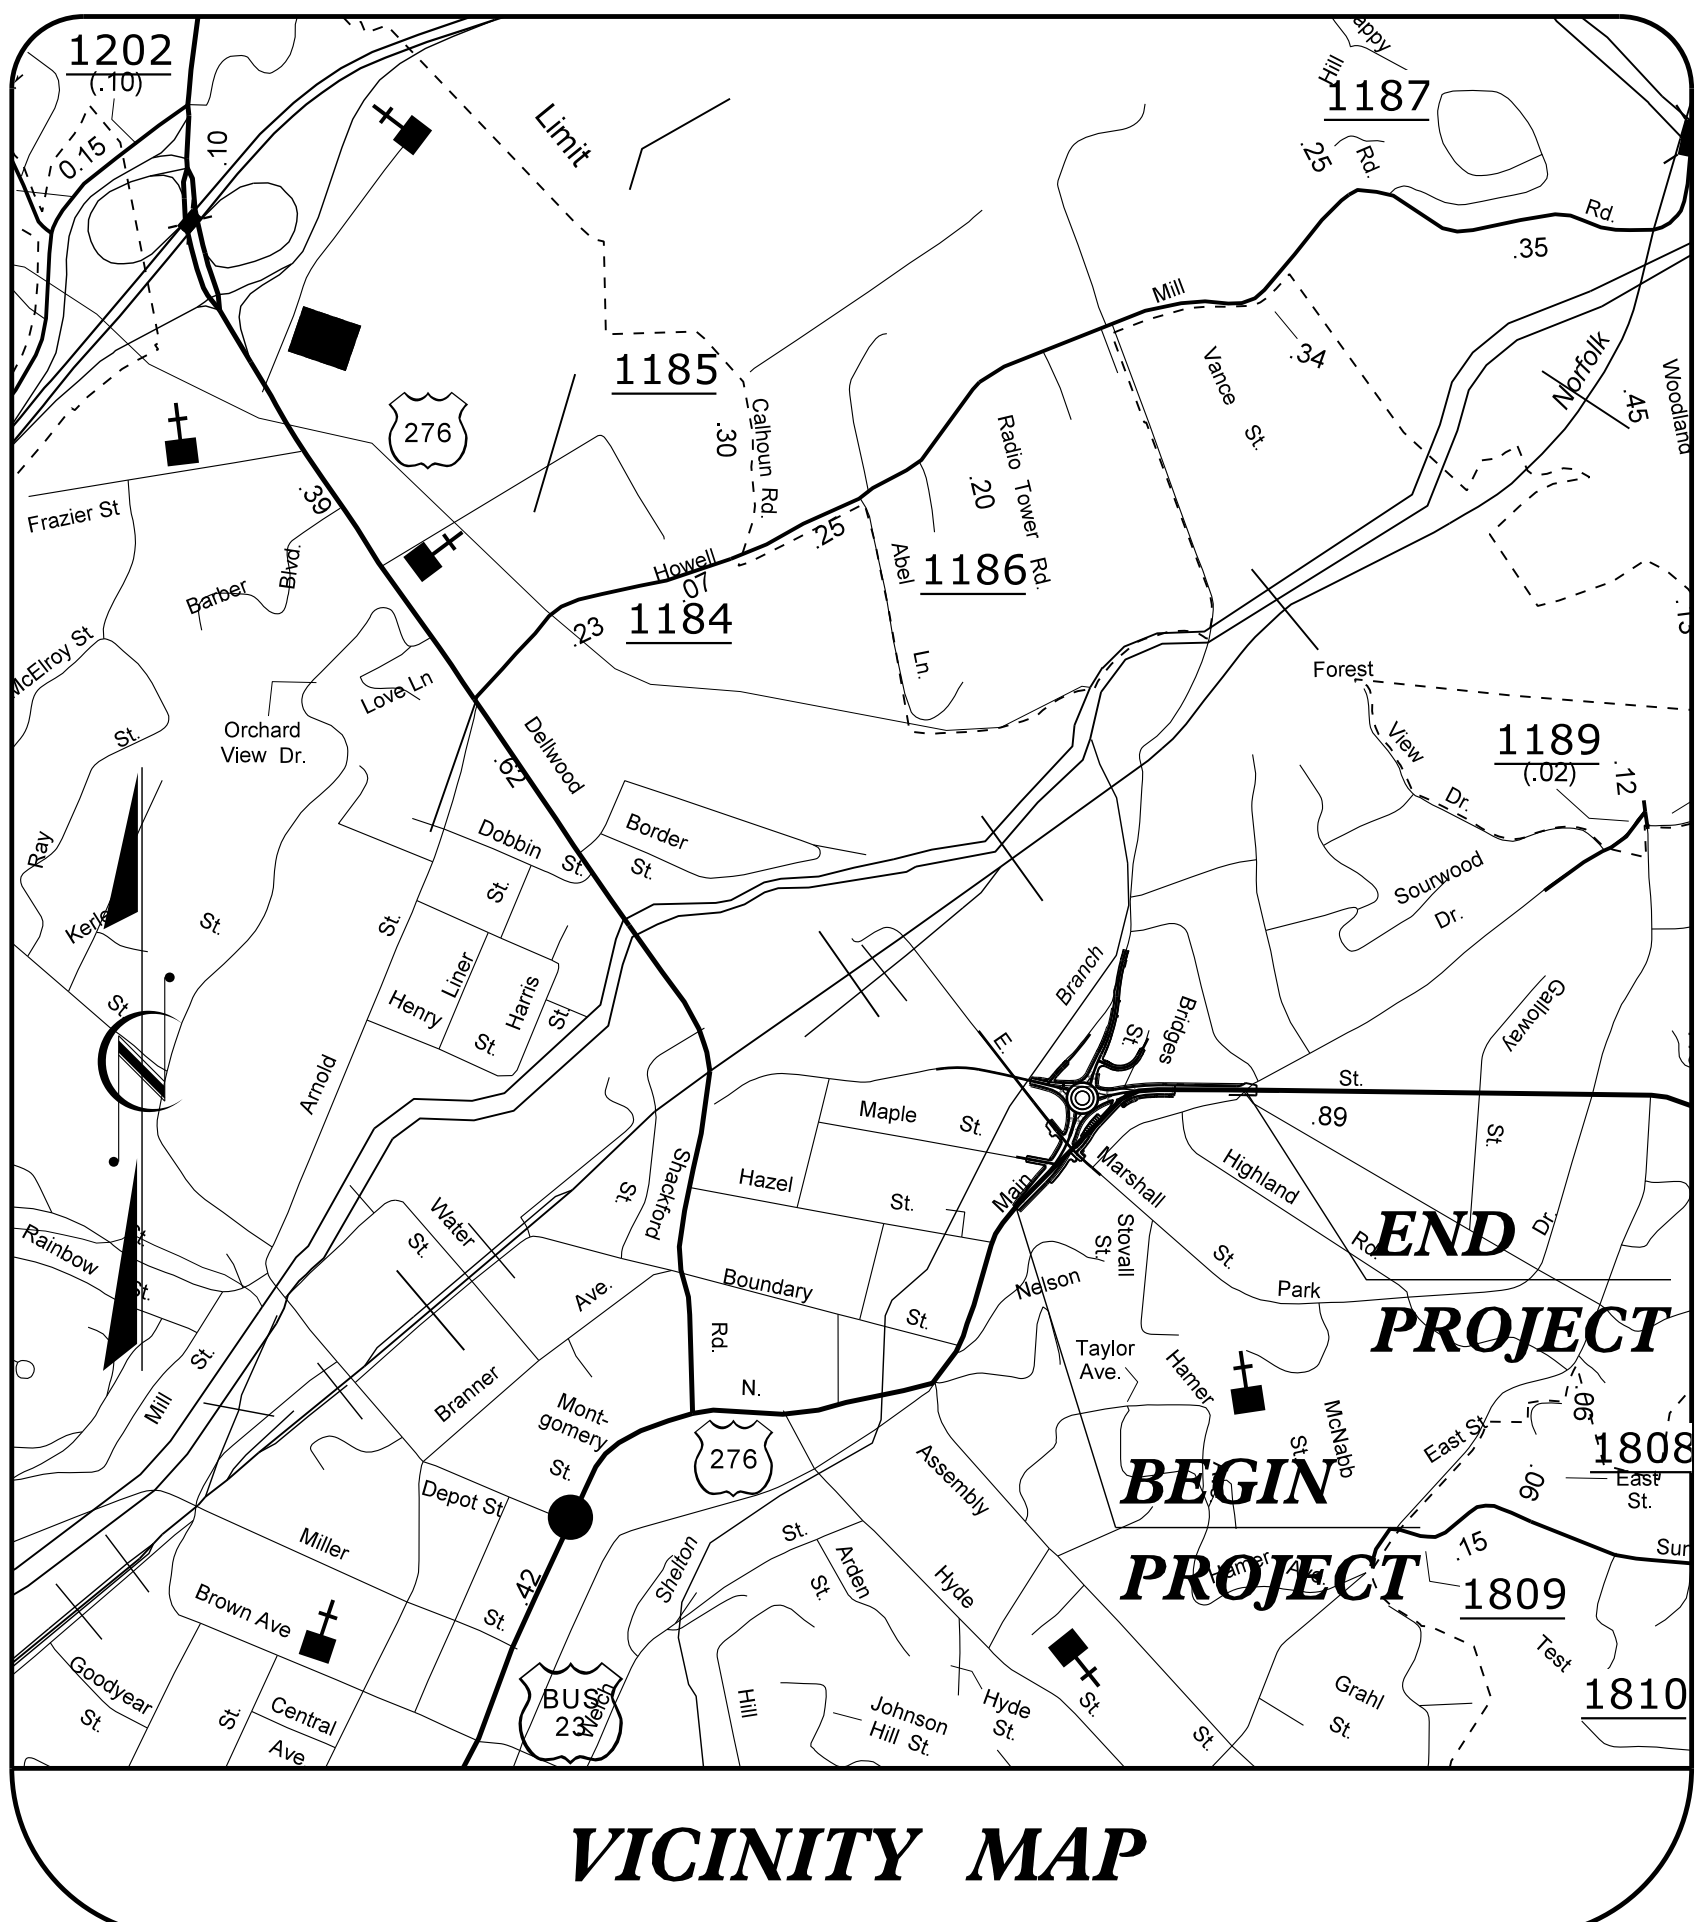

**VICINITY MAP**

U-5888 Right-Of-Way Plans


STATE OF NORTH CAROLINA  
 DIVISION OF HIGHWAYS  
**HAYWOOD COUNTY**

**LOCATION: WAYNESVILLE - INTERSECTION OF US 23 BUSINESS (N. MAIN ST.) AND WALNUT ST.**  
**TYPE OF WORK: GRADING, DRAINAGE, PAVING, & CULVERT.**

STATE	STATE PROJECT REFERENCE NO.	SHEET NO.	TOTAL SHEETS
N.C.	<b>U-5888</b>		
STATE PROJ. NO.	F.A. PROJ. NO.	DESCRIPTION	
44625.1.1	N/A	PE	
44625.2.1	N/A	RW /UTIL.	
44625.3.1	N/A	CONST.	

**BRIDGE #430460**

**STRUCTURE PLANS**

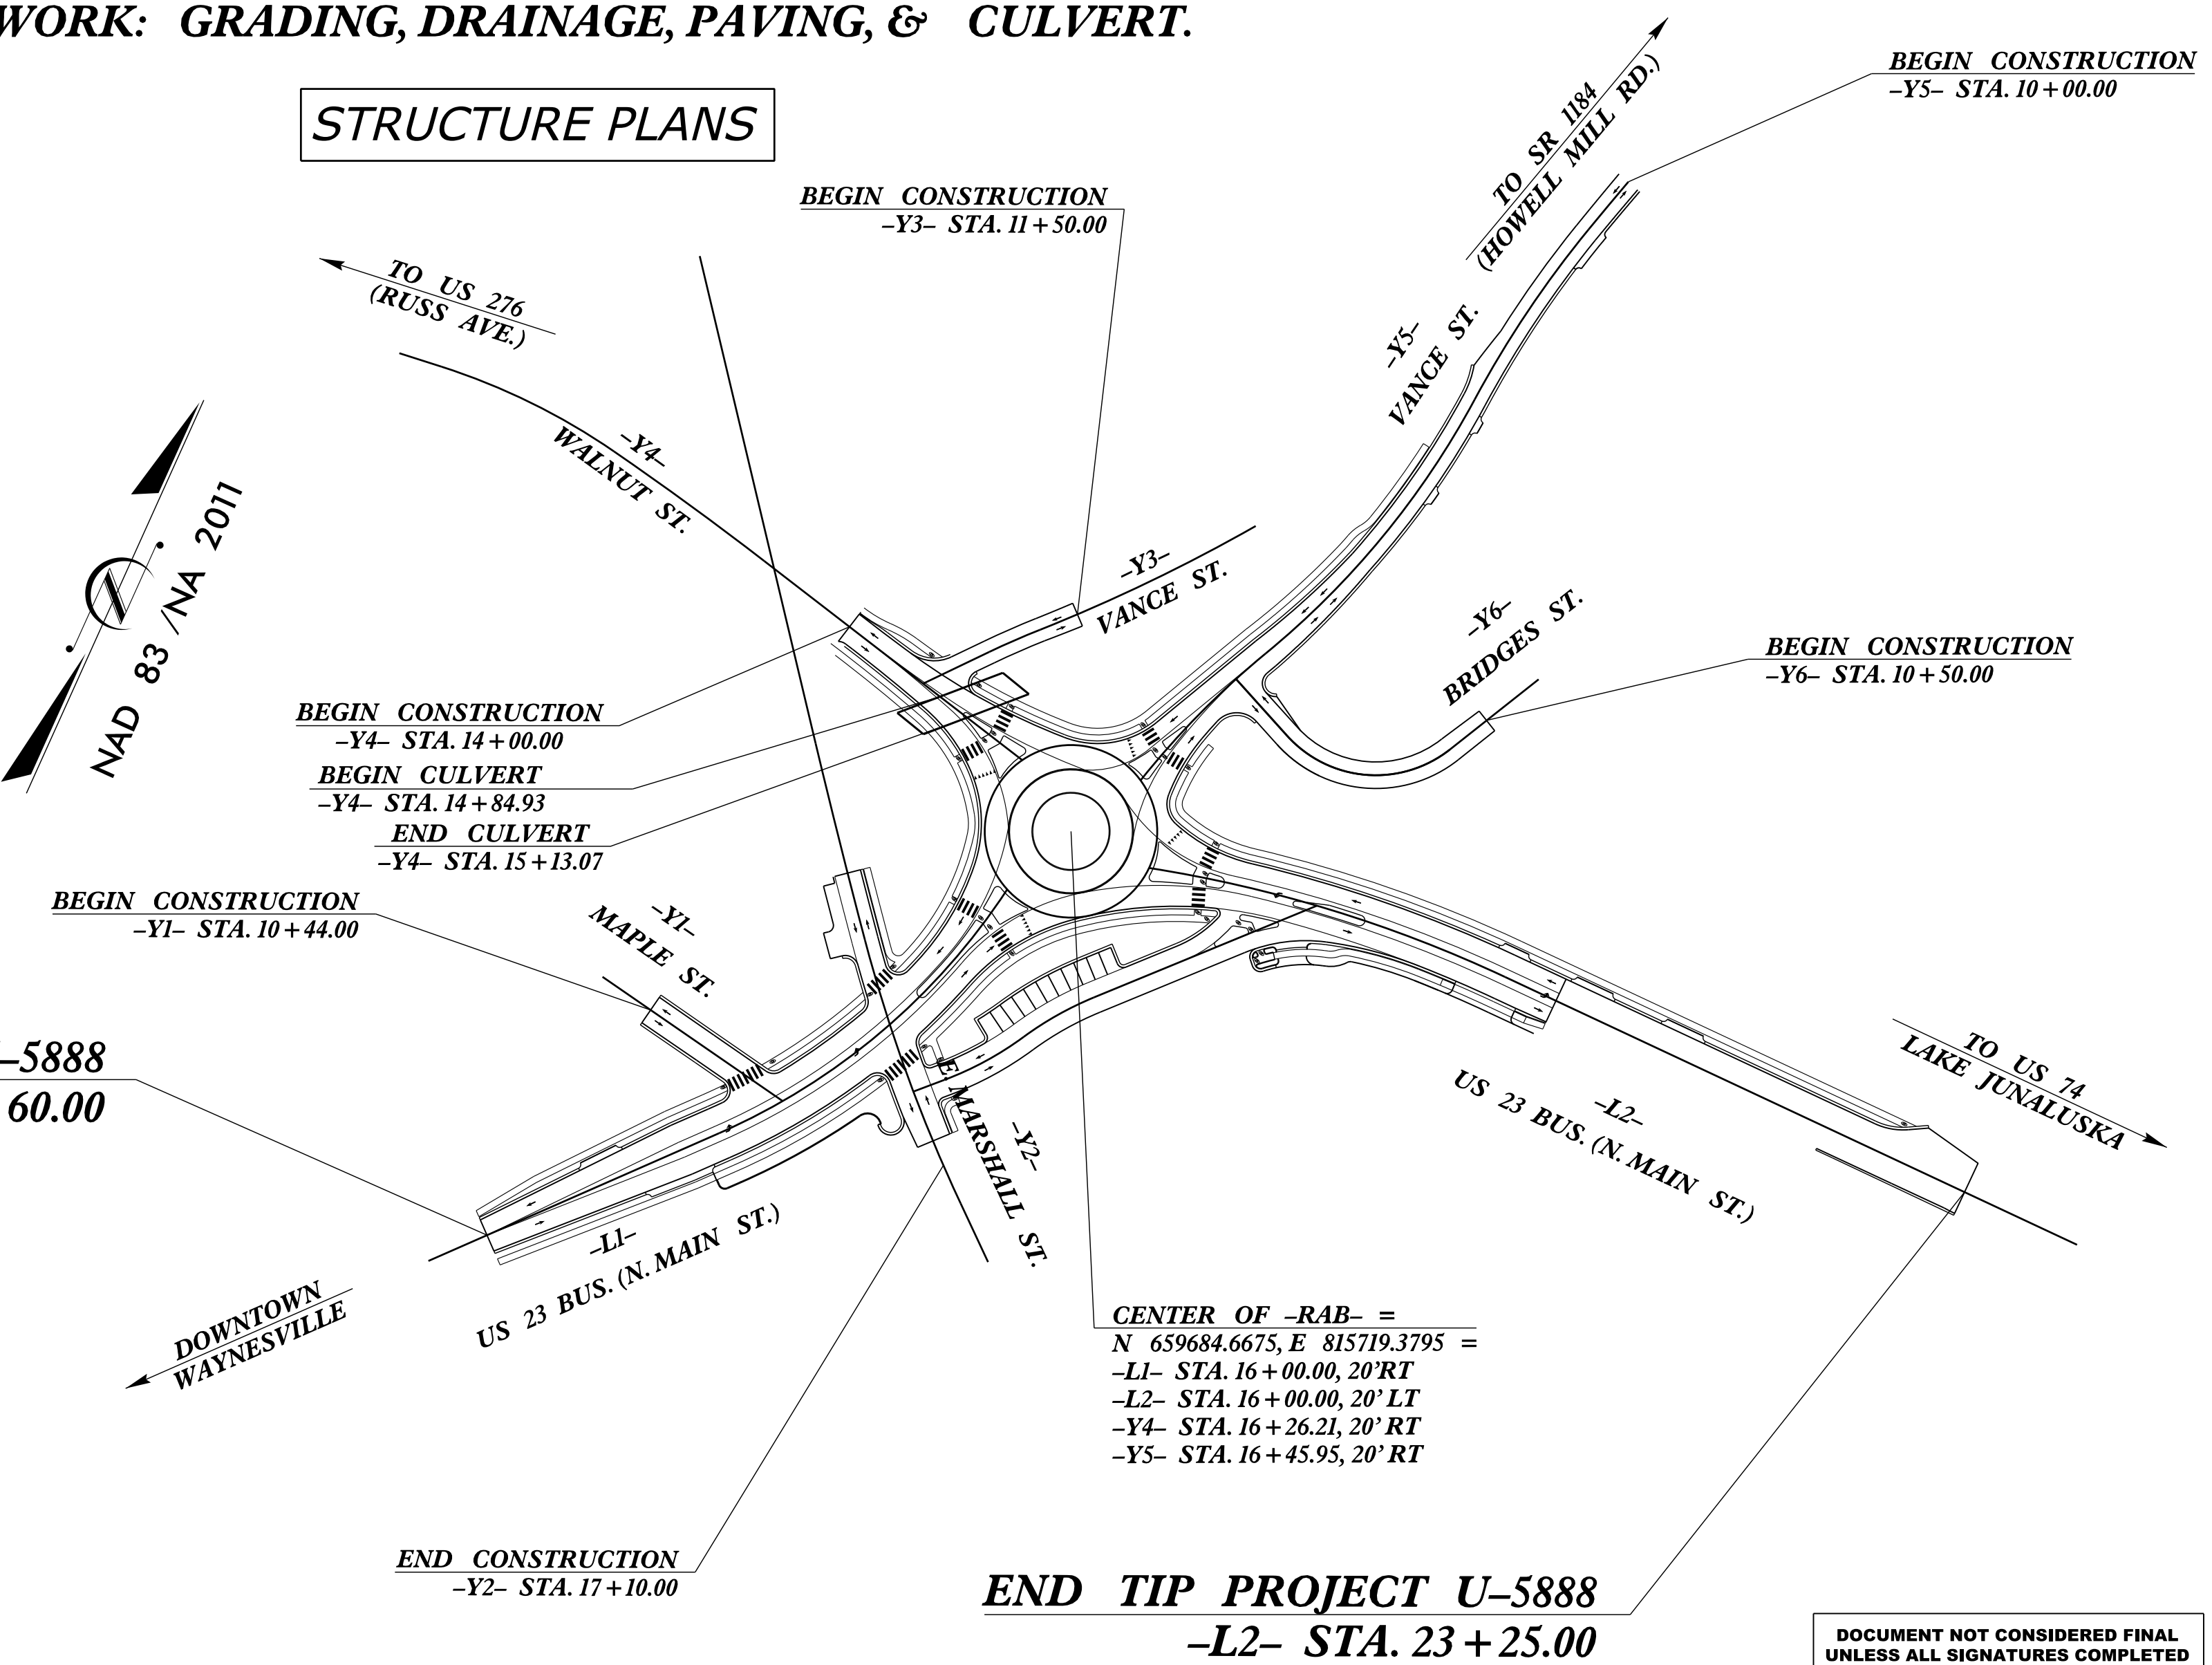

**DOCUMENT NOT CONSIDERED FINAL  
 UNLESS ALL SIGNATURES COMPLETED**

**DESIGN DATA**

ADT 2021 =	7,800
ADT 2040 =	9,000
K =	9 %
D =	50 %
T =	6 % *
V =	40 MPH
* TTST =	2% DUAL = 4%
FUNC. CLASS =	MINOR ARTERIAL

**PROJECT LENGTH**

LENGTH ROADWAY TIP PROJECT U-5888	=	0.240 MILES
TOTAL LENGTH TIP PROJECT U-5888	=	0.240 MILES

NOTE: -L1- AND -L2- USED FOR PROJECT LENGTH

Prepared in the Office of:

1223 Jones Franklin Rd. Raleigh, N.C. 27606  
 License No. F-0377  
 Bus: 919.851.8077 Fax: 919.851.8107  
 2018 STANDARD SPECIFICATIONS

**LETTING DATE:**  
 December 21, 2021

**NCDOT CONTACT:**

Prepared for:

**DIVISION OF HIGHWAYS  
 DIVISION 14**

253 Webster Road  
 Sylva NC, 28779

**GREG S. PURVIS, PE**  
 PROJECT ENGINEER

**JOHN A. DILWORTH, PE**  
 PROJECT DESIGN ENGINEER

**JOSHUA B. DEYTON, PE**  
 DIVISION 14 DDC ENGINEER

