


09_08/19

05-APR-2022 07:46 Maintenance\Madison\I-583I\Roadway\Proj\I-583I\A-ddc.tsh.dgn
S:\DC\InterState
\$\$\$USERNAME\$\$\$

CONTRACT: C204709 **TIP PROJECT: I-5831A**

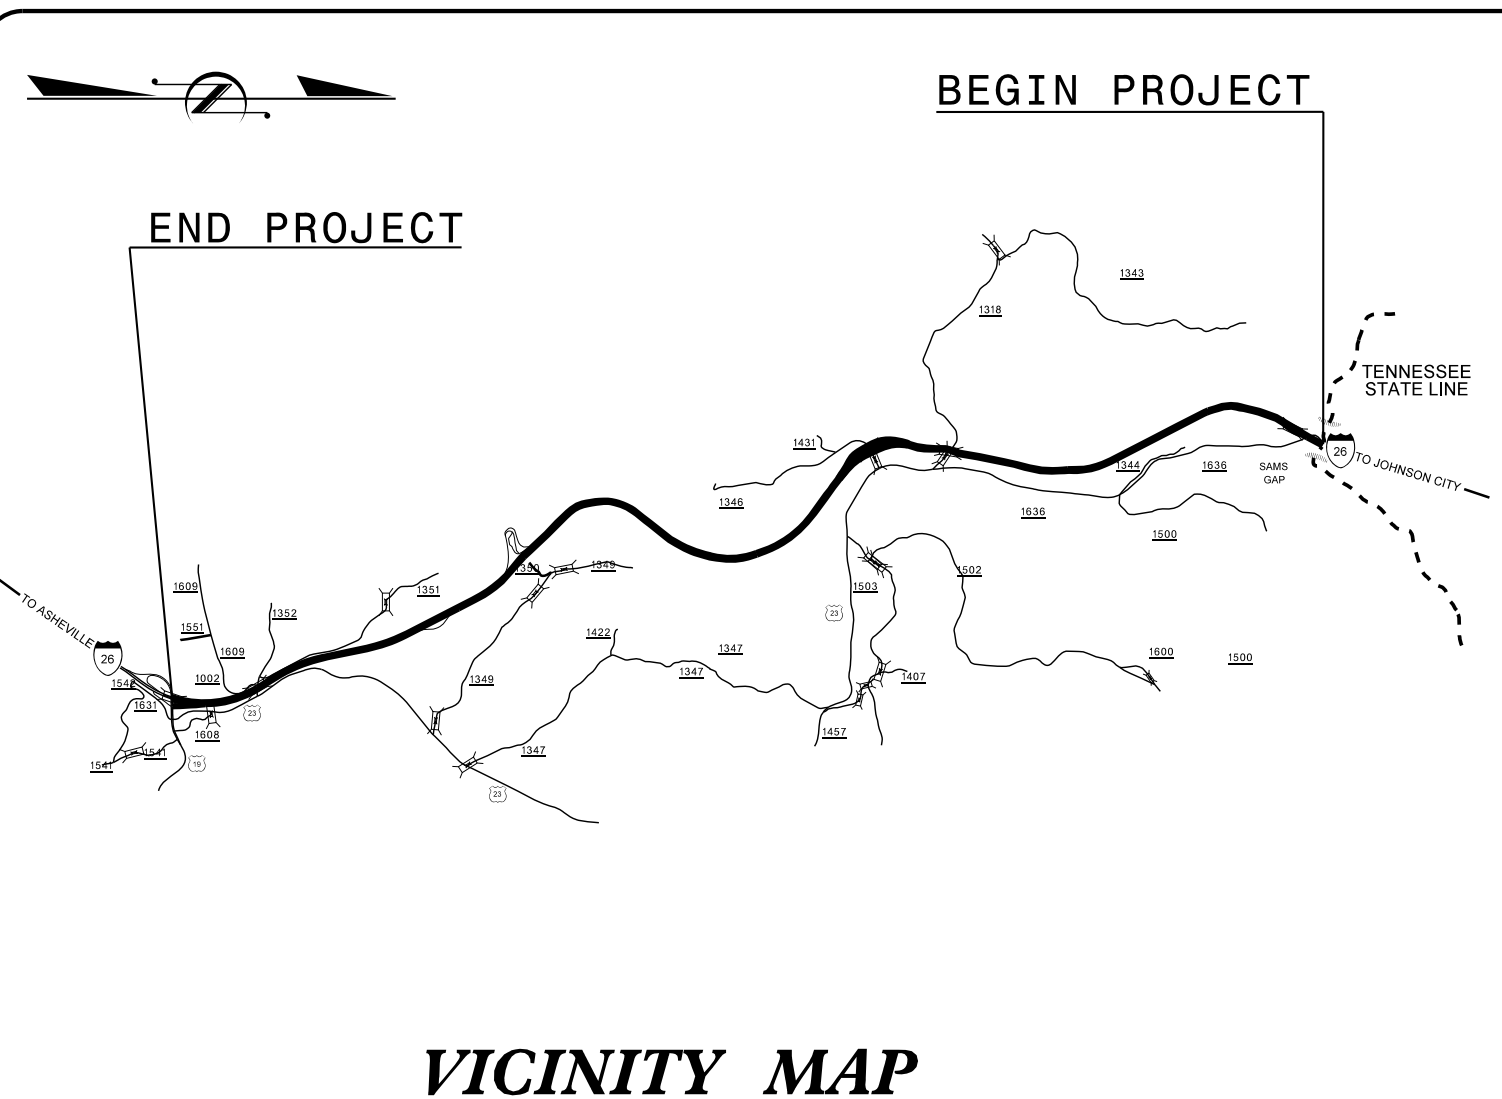



STATE OF NORTH CAROLINA
DIVISION OF HIGHWAYS

MADISON COUNTY

LOCATION: I-26 FROM TENNESSEE STATE LINE MM 0.00 TO MM 9.05

TYPE OF WORK: REPLACE CURB AND DRAINAGE BOXES, AND REHABILITATE BRIDGES

STATE	STATE PROJECT REFERENCE NO.	SHEET NO.	TOTAL SHEETS
N.C.	I-5831A	1	
STATE PROJ. NO.	F.A. PROJ. NO.	DESCRIPTION	
53037.1.2		PE	
53037.3.2	0026020	CONST.	

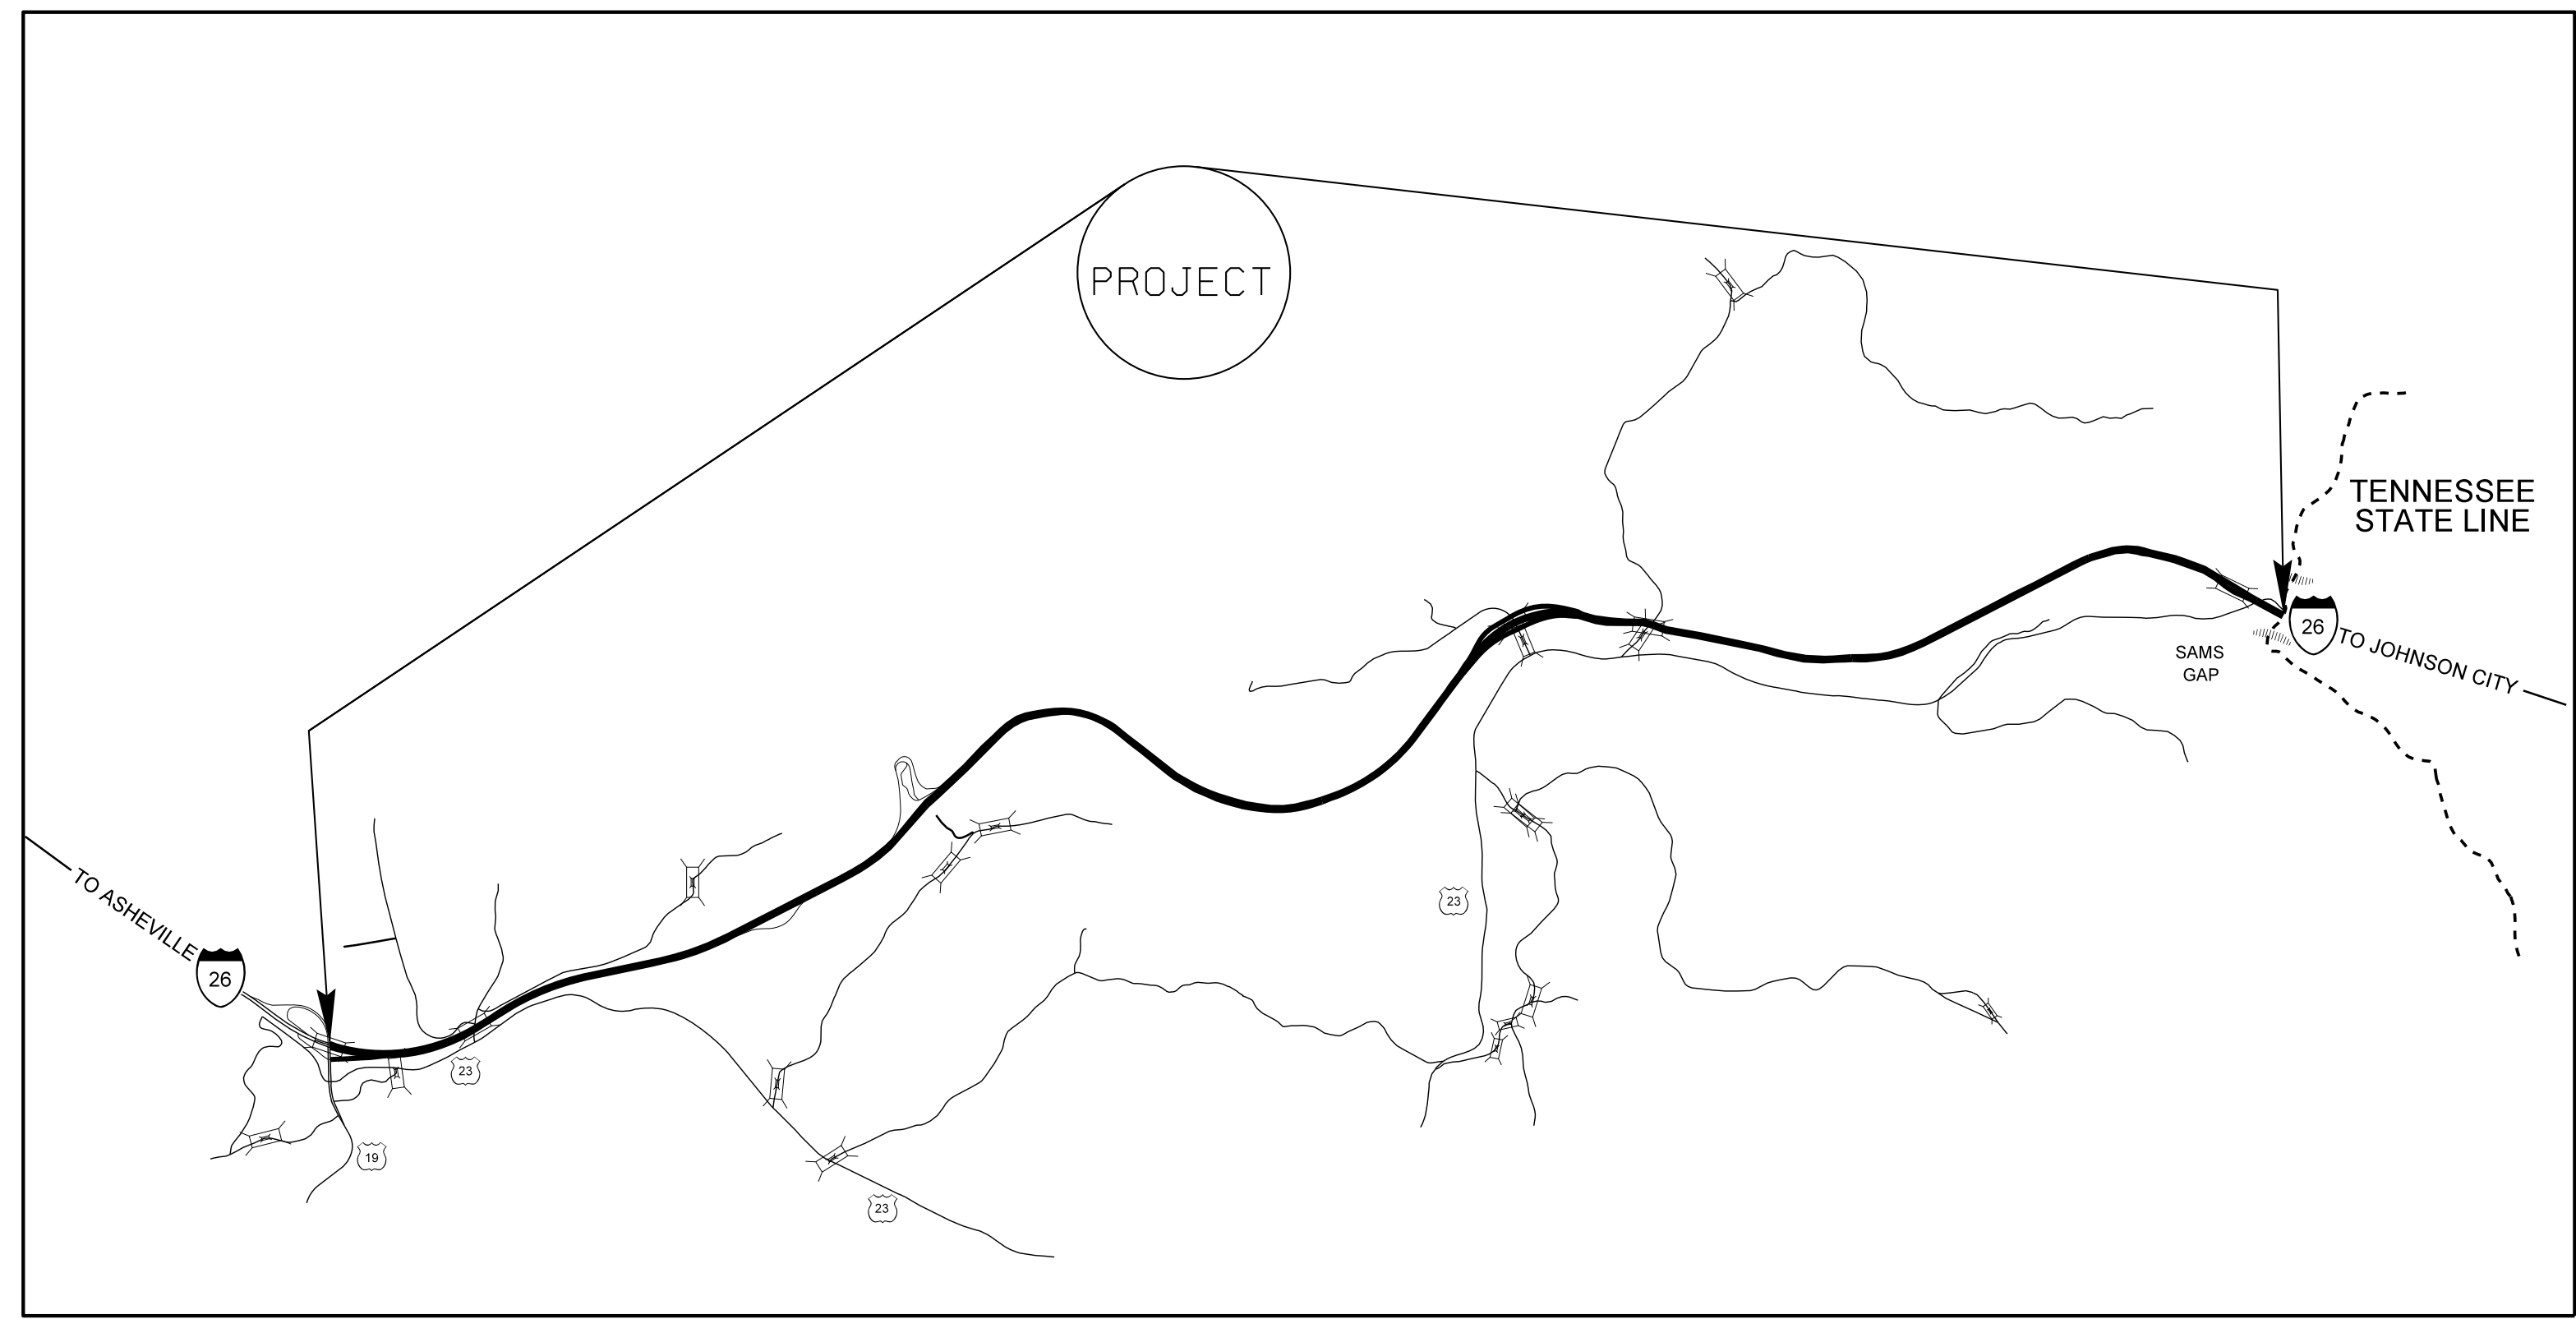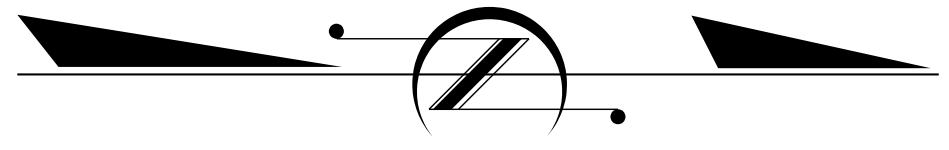

2018 ROADWAY ENGLISH STANDARD DRAWINGS

The following Roadway Standards as appear in "Roadway Standard Drawings" Highway Design Branch - N. C. Department of Transportation - Raleigh, N.C., Dated January, 2018 are applicable to this project and by reference hereby are considered a part of these plans:

STD. NO.	TITLE
840.37	Steel Frame and Grate
846.01	Concrete Curb, Gutter and Curb & Gutter
1605.01	Temporary Silt Fence

PROJECT LENGTH

LENGTH ROADWAY TIP PROJECT I-5831A = 8.617 MI
 LENGTH STRUCTURE TIP PROJECT I-5831A = 0.356 MI
 TOTAL LENGTH OF TIP PROJECT I-5831A = 8.973 MI

Prepared In the Office of:
DIVISION OF HIGHWAYS
 1000 Birch Ridge Dr., Raleigh NC, 27610

2018 STANDARD SPECIFICATIONS

RIGHT OF WAY DATE:

MCCRAY COATES, PE
 PROJECT ENGINEER

LETTING DATE:
 MAY 17, 2022

WILLIAM C. CARVER, PE
 PROJECT DESIGN ENGINEER

