

PROJECT REFERENCE NO. R-5726A	SHEET NO. EC-8/CONST. 8
ROADWAY DESIGN ENGINEER	HYDRAULICS ENGINEER

Prepared in the Office of:


M MOTT MACDONALD
 PO Box 700
 Fuquay-Varina, NC 27526
 www.mottmac.com/americas

HDR HDR Engineering, Inc. of the Carolinas
 555 Fayetteville St, Suite 900 Raleigh, N.C. 27601
 N.C.B.E.L.S. License Number: F-0116

FOR -L- PROFILE SEE SHEET 29

CLEARING AND GRUBBING
 EROSION CONTROL FOR
 CONSTRUCTION SHEET 8

NOTE:
 PLACE TEMPORARY ROCK SEDIMENT DAMS TYPE - B
 AND TEMPORARY ROCK SILT CHECKS TYPE - A AT
 DRAINAGE OUTLETS.

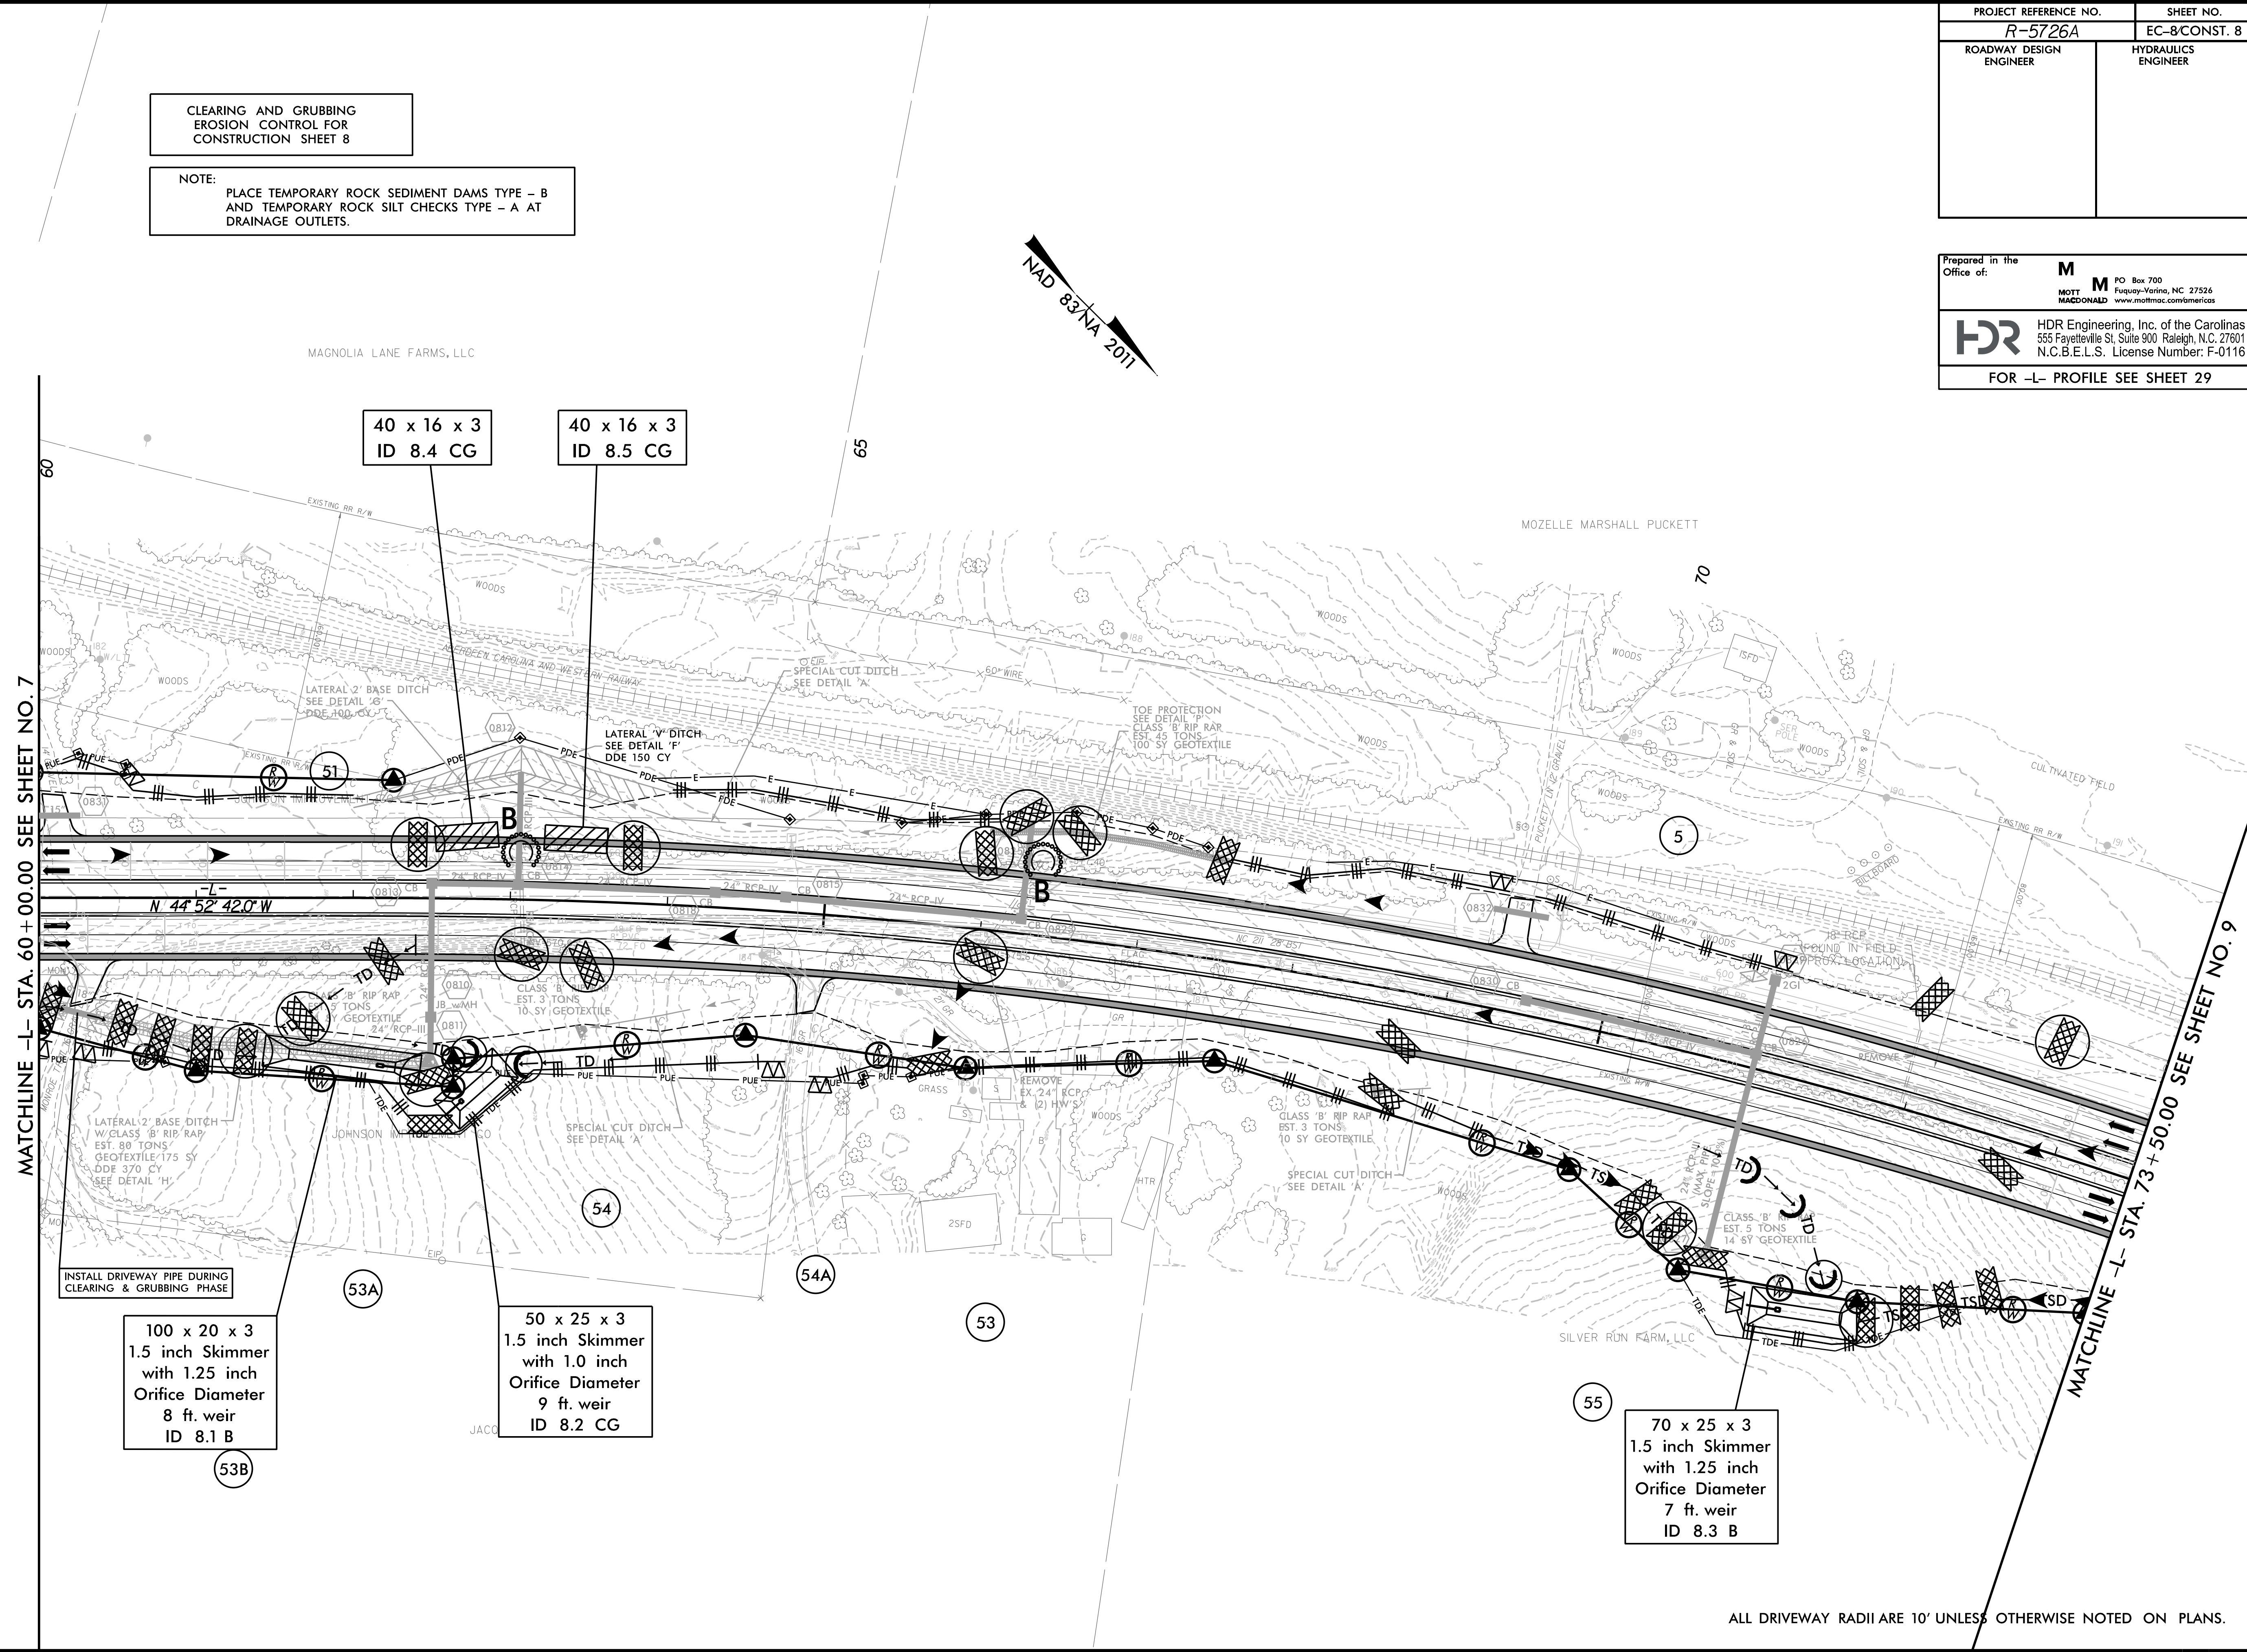

40 x 16 x 3
 ID 8.4 CG

40 x 16 x 3
 ID 8.5 CG

MATCHLINE -L- STA. 60 + 00.00 SEE SHEET NO. 7

MATCHLINE -L- STA. 73 + 50.00 SEE SHEET NO. 9

INSTALL DRIVEWAY PIPE DURING
 CLEARING & GRUBBING PHASE

100 x 20 x 3
 1.5 inch Skimmer
 with 1.25 inch
 Orifice Diameter
 8 ft. weir
 ID 8.1 B

50 x 25 x 3
 1.5 inch Skimmer
 with 1.0 inch
 Orifice Diameter
 9 ft. weir
 ID 8.2 CG

70 x 25 x 3
 1.5 inch Skimmer
 with 1.25 inch
 Orifice Diameter
 7 ft. weir
 ID 8.3 B

ALL DRIVEWAY RADII ARE 10' UNLESS OTHERWISE NOTED ON PLANS.

8/17/99
 2/17/2022
 5:31:46 PM
 R-5726A-EC_PSH.dgn
 5/21/24 PM