

STATE OF NORTH CAROLINA  
DIVISION OF HIGHWAYS

**NASH & EDGECOMBE COUNTIES**


LOCATION: US 64 (FUTURE I-87) FROM SR-1603 (OLD CARRIAGE RD.)  
TO SR 1225 (KINGSBORO RD.)

STATE	STATE PROJECT REFERENCE NO.	SHEET NO.	TOTAL SHEETS
N.C.	I-6046	1	
STATE PROJ. NO.	F.A. PROJ. NO.	DESCRIPTION	
47995.1.1		PE	
47995.3.1	NHPIM-0087(047)	CONST	

TIP PROJECT: I-6046

CONTRACT: C204396

TYPE OF WORK: PAVEMENT REHABILITATION.

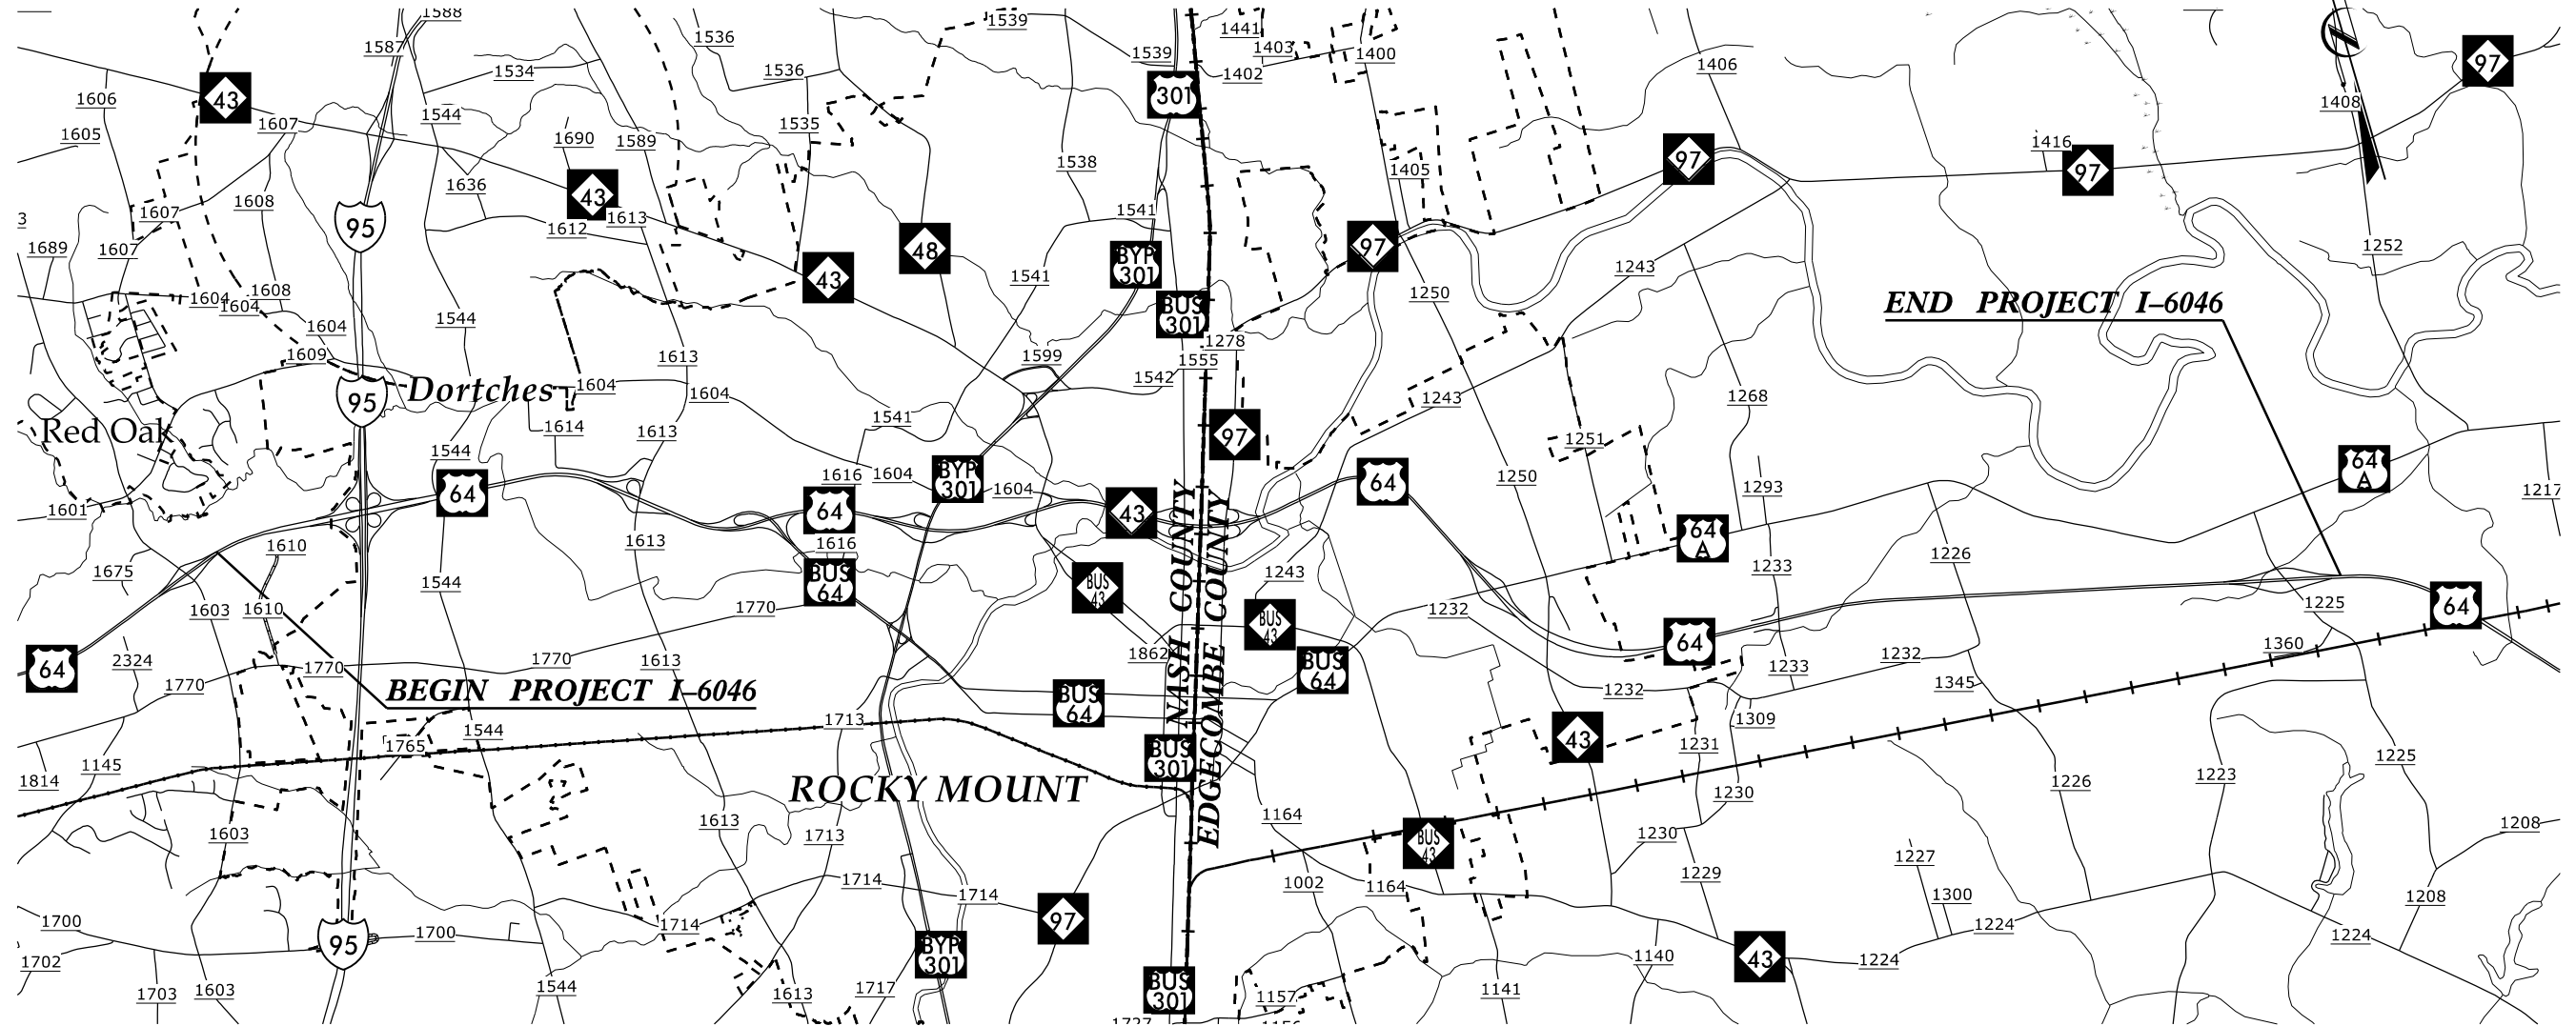

**VICINITY MAP**

**DESIGN DATA**  
ADT 2017 = 44000

FUNCTIONAL CLASS  
OTHER FREEWAY  
(FUTURE INTERSTATE)

**PROJECT LENGTH**

LENGTH ROADWAY (EBL) TIP PROJECT I-6046 = 14.02 MILES  
TOTAL LENGTH TIP PROJECT I-6046 = 14.02 MILES

Prepared in the Office of:  
**DIVISION OF HIGHWAYS**

Division 4 DDC  
509 Ward Blvd., Wilson NC, 27895

2018 STANDARD SPECIFICATIONS

RIGHT OF WAY DATE:  
NA

LETTING DATE:  
JUNE 21, 2022

K.G. BOWEN, PE  
PROJECT ENGINEER

D.R. ETHRIDGE  
PROJECT DESIGN ENGINEER

