
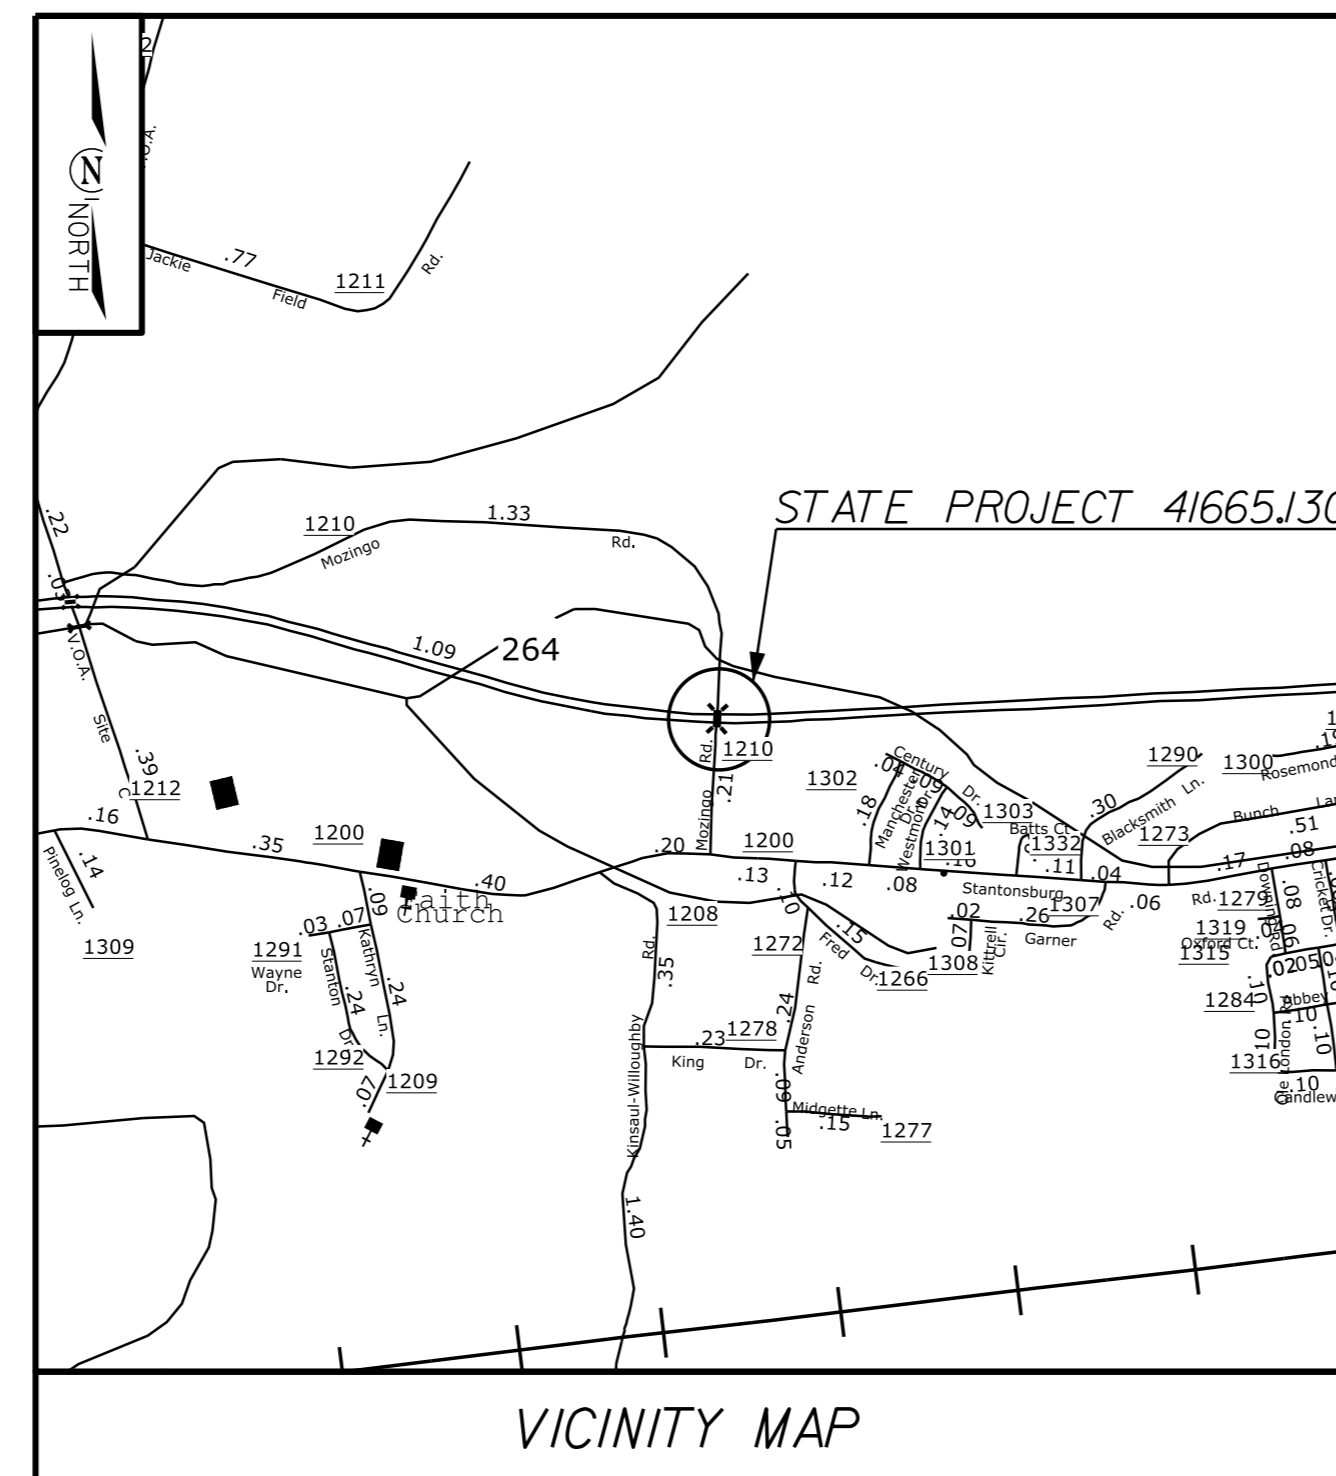


STATE OF NORTH CAROLINA
DIVISION OF HIGHWAYS

TRANSPORTATION MANAGEMENT PLAN

PITT COUNTY

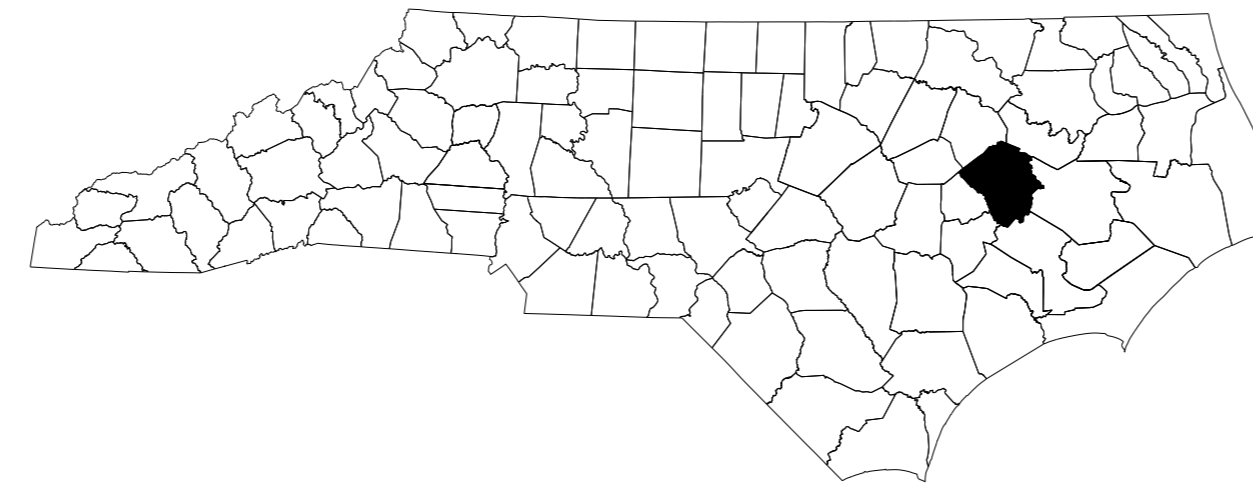

**LOCATION: BRIDGE 730472 ON MOZINGO ROAD OVER
US 264 IN PITT COUNTY**

TYPE OF WORK: CONCRETE BRIDGE REPAIR

INDEX OF SHEETS


<u>SHEET NO.</u>	<u>TITLE</u>
TMP-1	TITLE SHEET, VICINITY MAP, AND INDEX OF SHEETS
TMP-1A	LIST OF APPLICABLE ROADWAY STANDARD DRAWINGS, AND LEGEND
TMP-1B	TRANSPORTATION OPERATIONS PLAN: (MANAGEMENT STRATEGIES, GENERAL NOTES, AND LOCAL NOTES)
TMP-2	PROJECT PHASING

SHEET NO.
TMP-1



41665.13C

PROJECT:

 **DOCUMENT NOT CONSIDERED FINAL
UNLESS ALL SIGNATURES COMPLETED**


APPROVED: 
DATE: 03/22/2022

SEAL

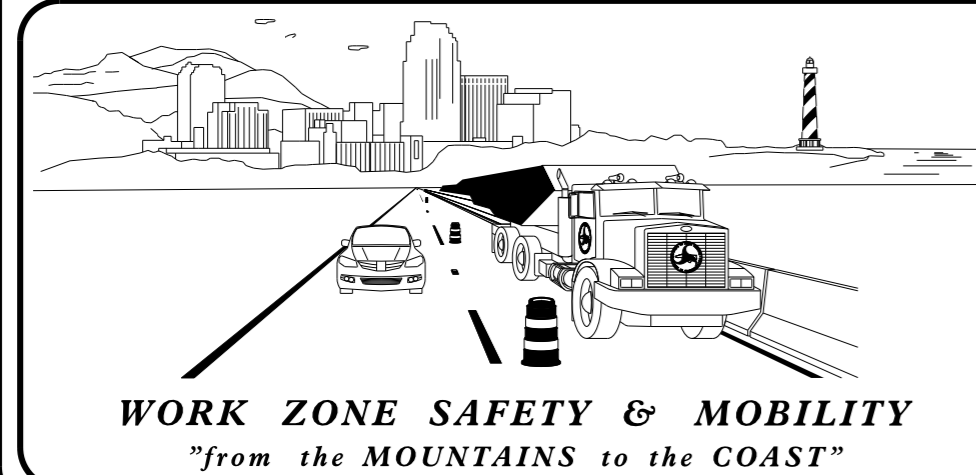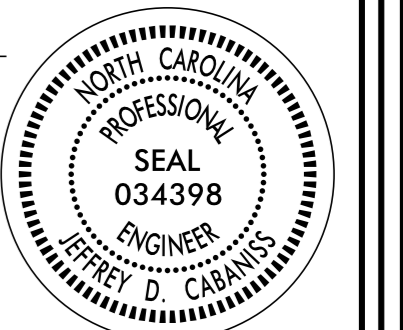

PLANS PREPARED BY:
NCDOT DIV2 DDC UNIT
1037 W.H. SMITH BLVD.
GREENVILLE, NC 27858

NCDOT CONTACTS:
JEFF CABANISS P.E.
PROJECT ENGINEER
LANG JONES
PROJECT DESIGN ENGINEER

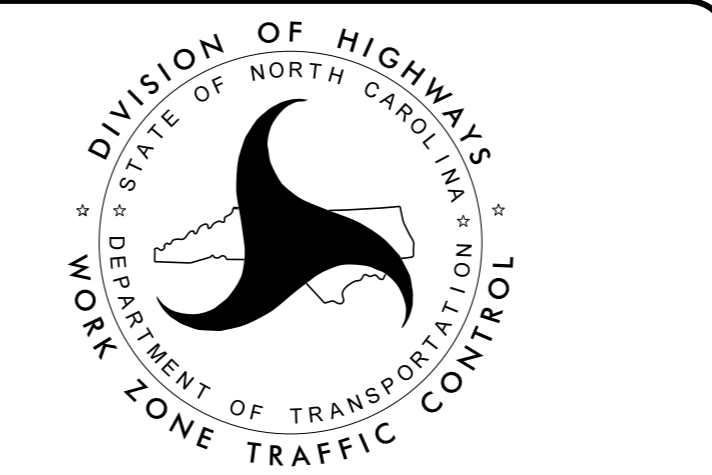

22-MAR-2022 10:26
G:\PROJECTS\PITT\Mozingo_Rd_Bridge_Repairs\Mozingo_TMP1.dgn
\$\$\$\$\$USERNAME\$\$\$\$\$