
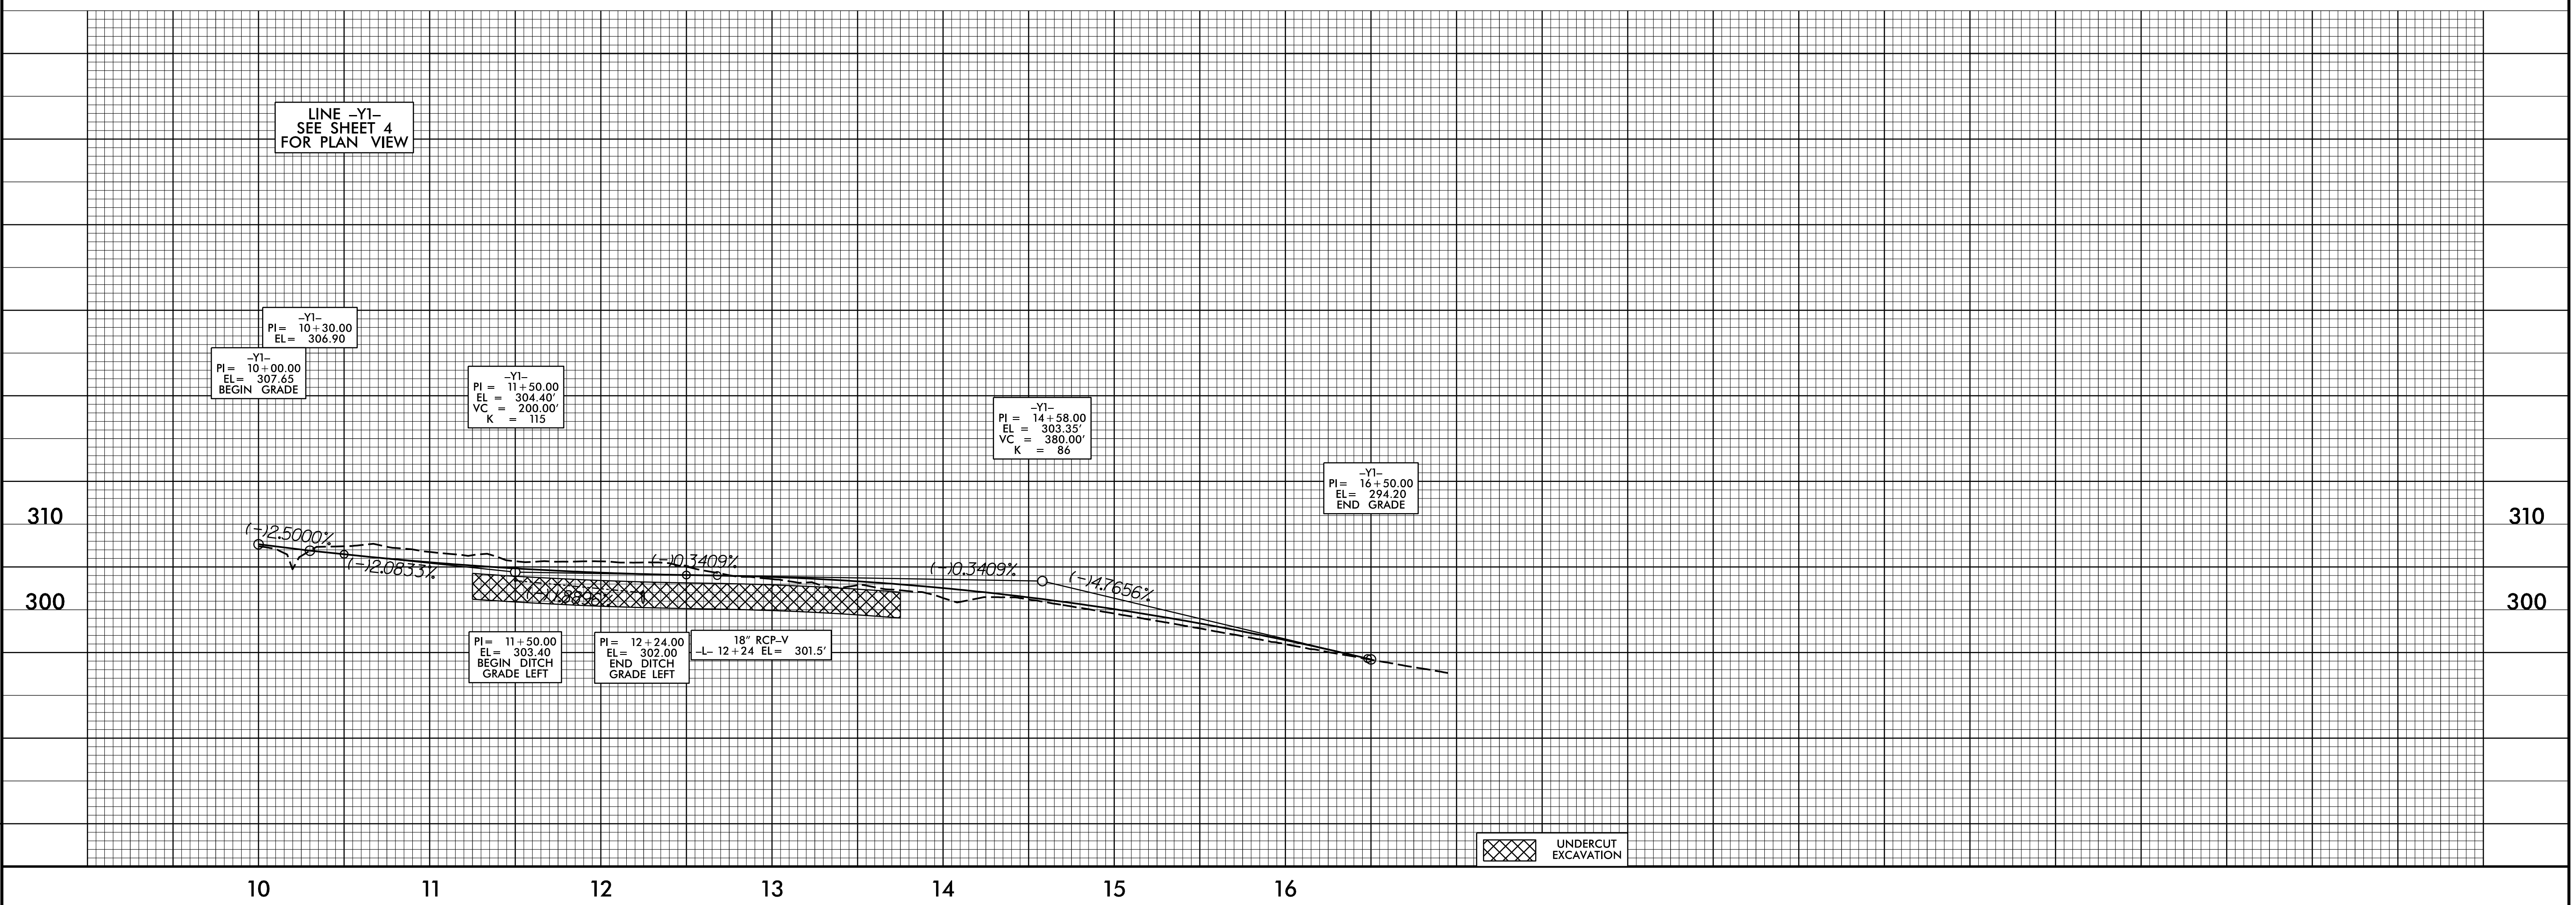


PROJECT REFERENCE NO.	SHEET NO.
U-6223	08
RW SHEET NO.	08
ROADWAY DESIGN ENGINEER	HYDRAULICS ENGINEER
05/17/2022	05/17/2022
SEAL 040774	SEAL 022000
NORWOOD H. GAINES III	WILLIAM G. CALDWELL
DOCUMENT NOT CONSIDERED FINAL UNLESS ALL SIGNATURES COMPLETED	

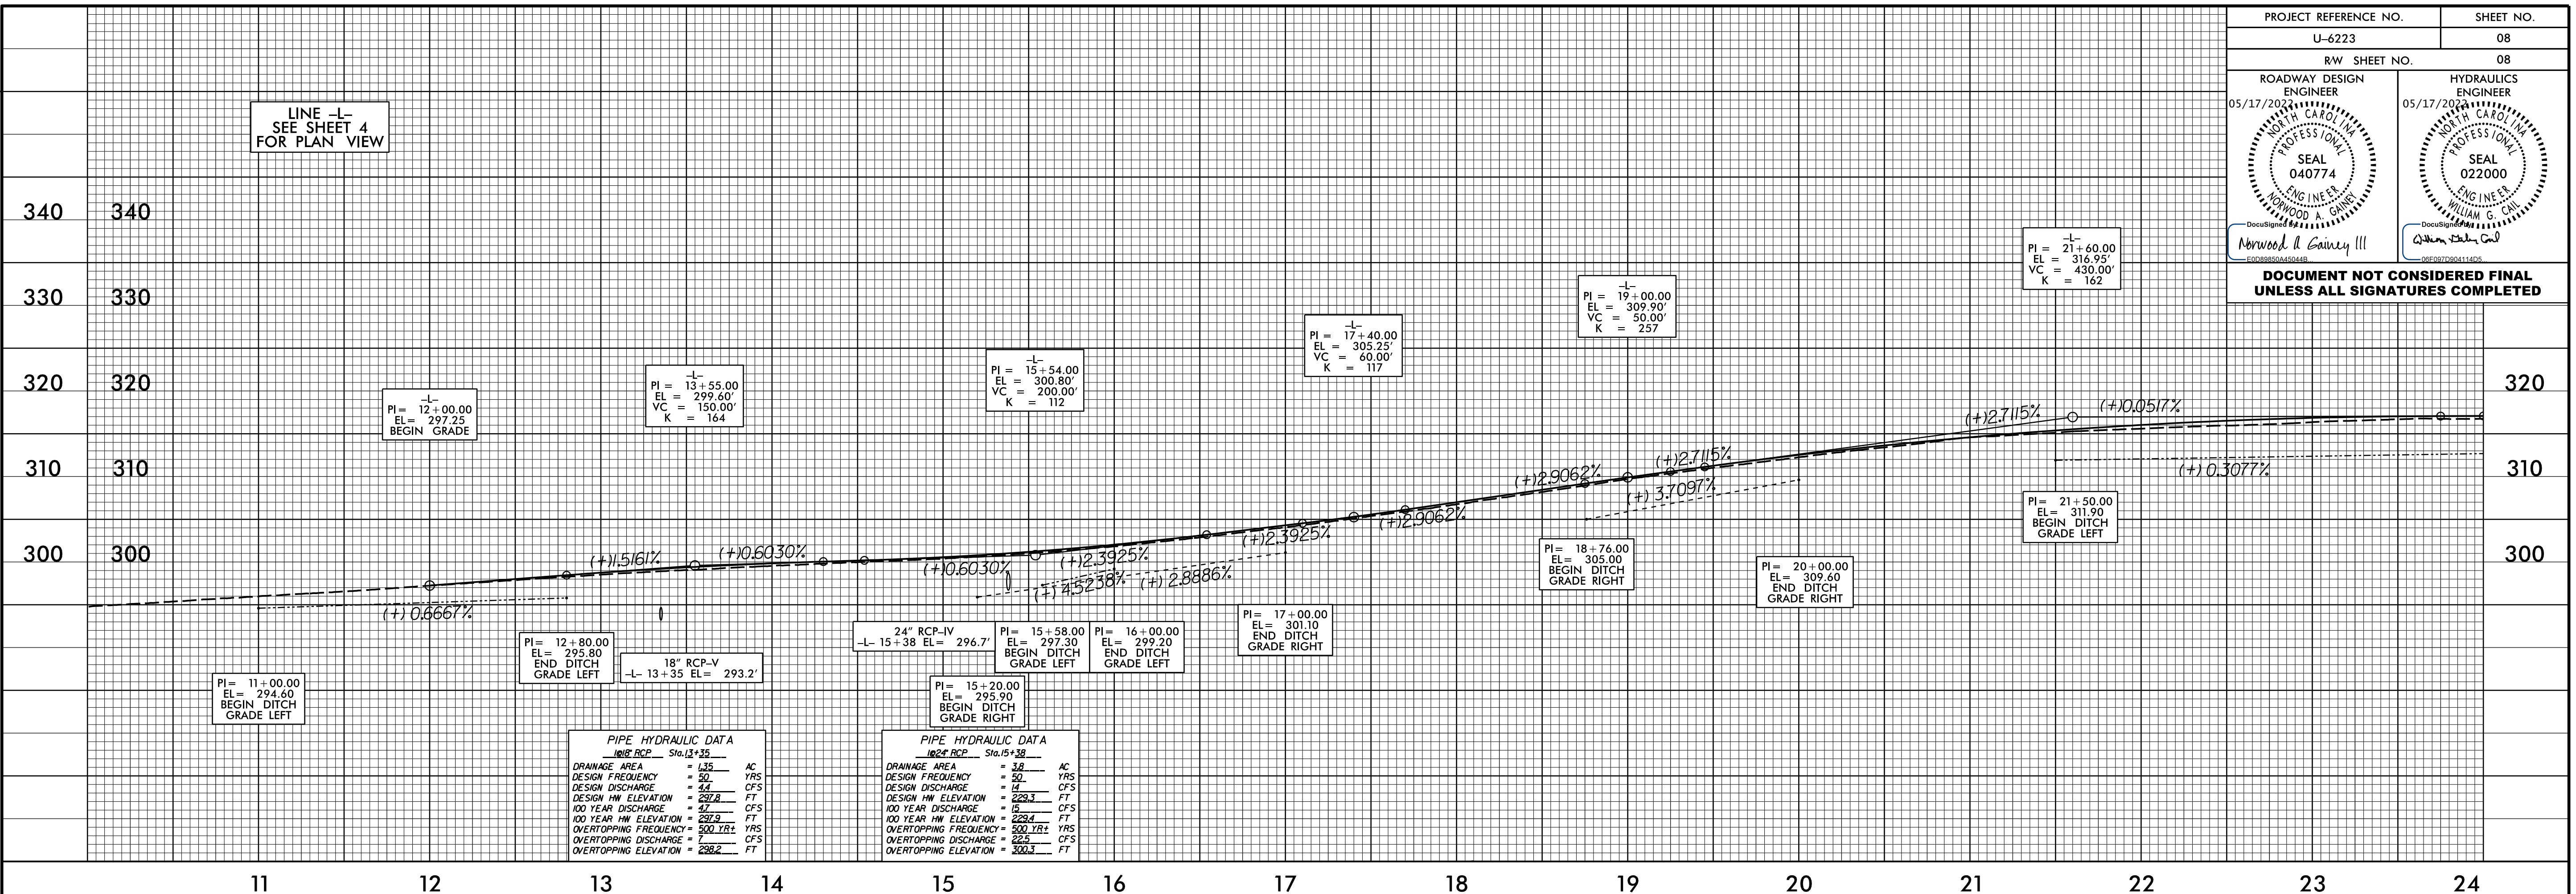

UNDERCUT EXCAVATION

LINE -L-
SEE SHEET 4
FOR PLAN VIEW

LINE -Y1-
SEE SHEET 4
FOR PLAN VIEW

REVISIONS

03-MAY-2022 09:55
R:\Projects\17601\U-6223_DDC4_PROJ\08.dgn
Division 4 DDC

DDC4

5/17/2022