
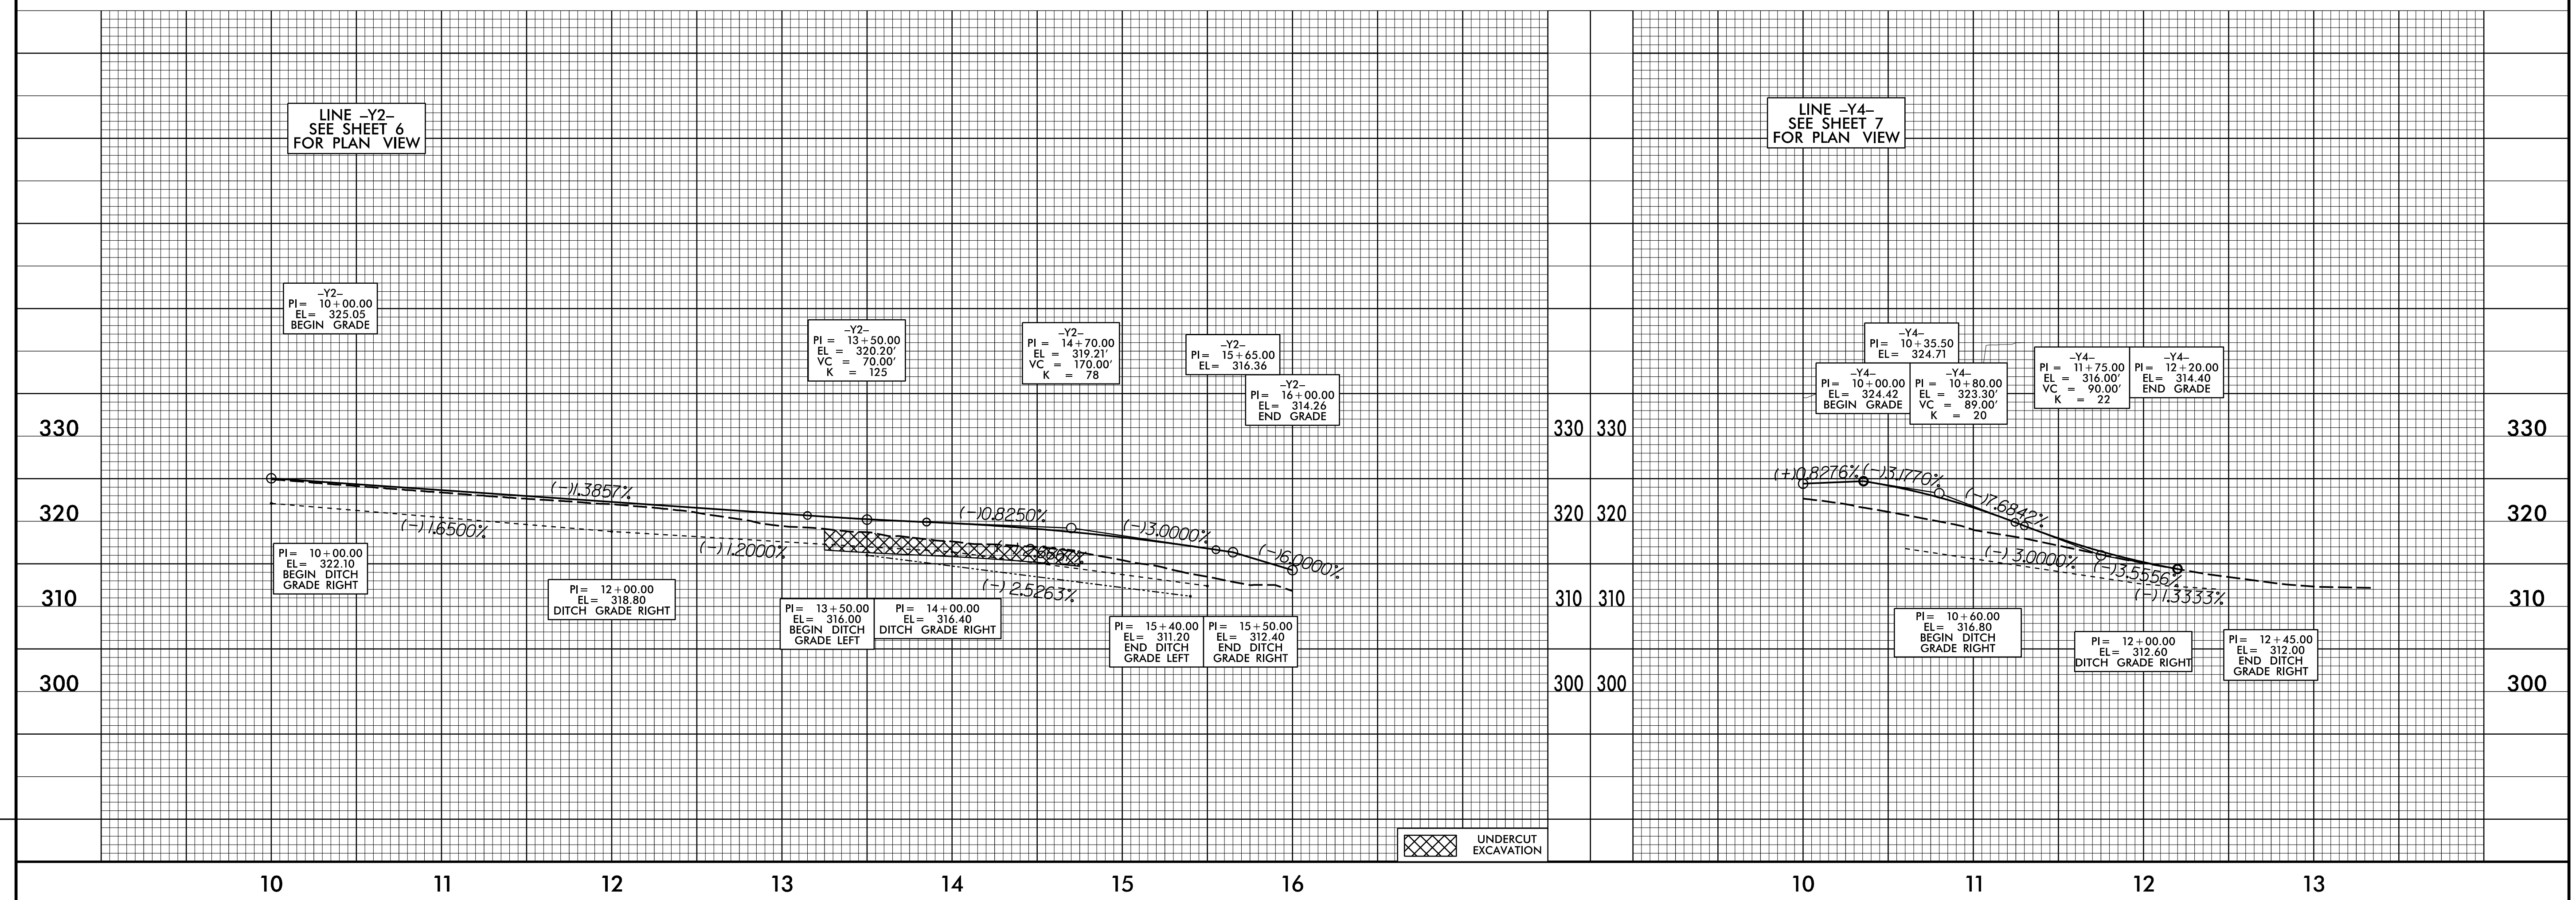


PROJECT REFERENCE NO.	SHEET NO.
U-6223	09
RW SHEET NO.	
09	
ROADWAY DESIGN ENGINEER	HYDRAULICS ENGINEER
05/17/2022	05/17/2022
SEAL 040774	SEAL 022000
NORWOOD A. GAINES III	WILLIAM G. CALDWELL

DOCUMENT NOT CONSIDERED FINAL  
UNLESS ALL SIGNATURES COMPLETED

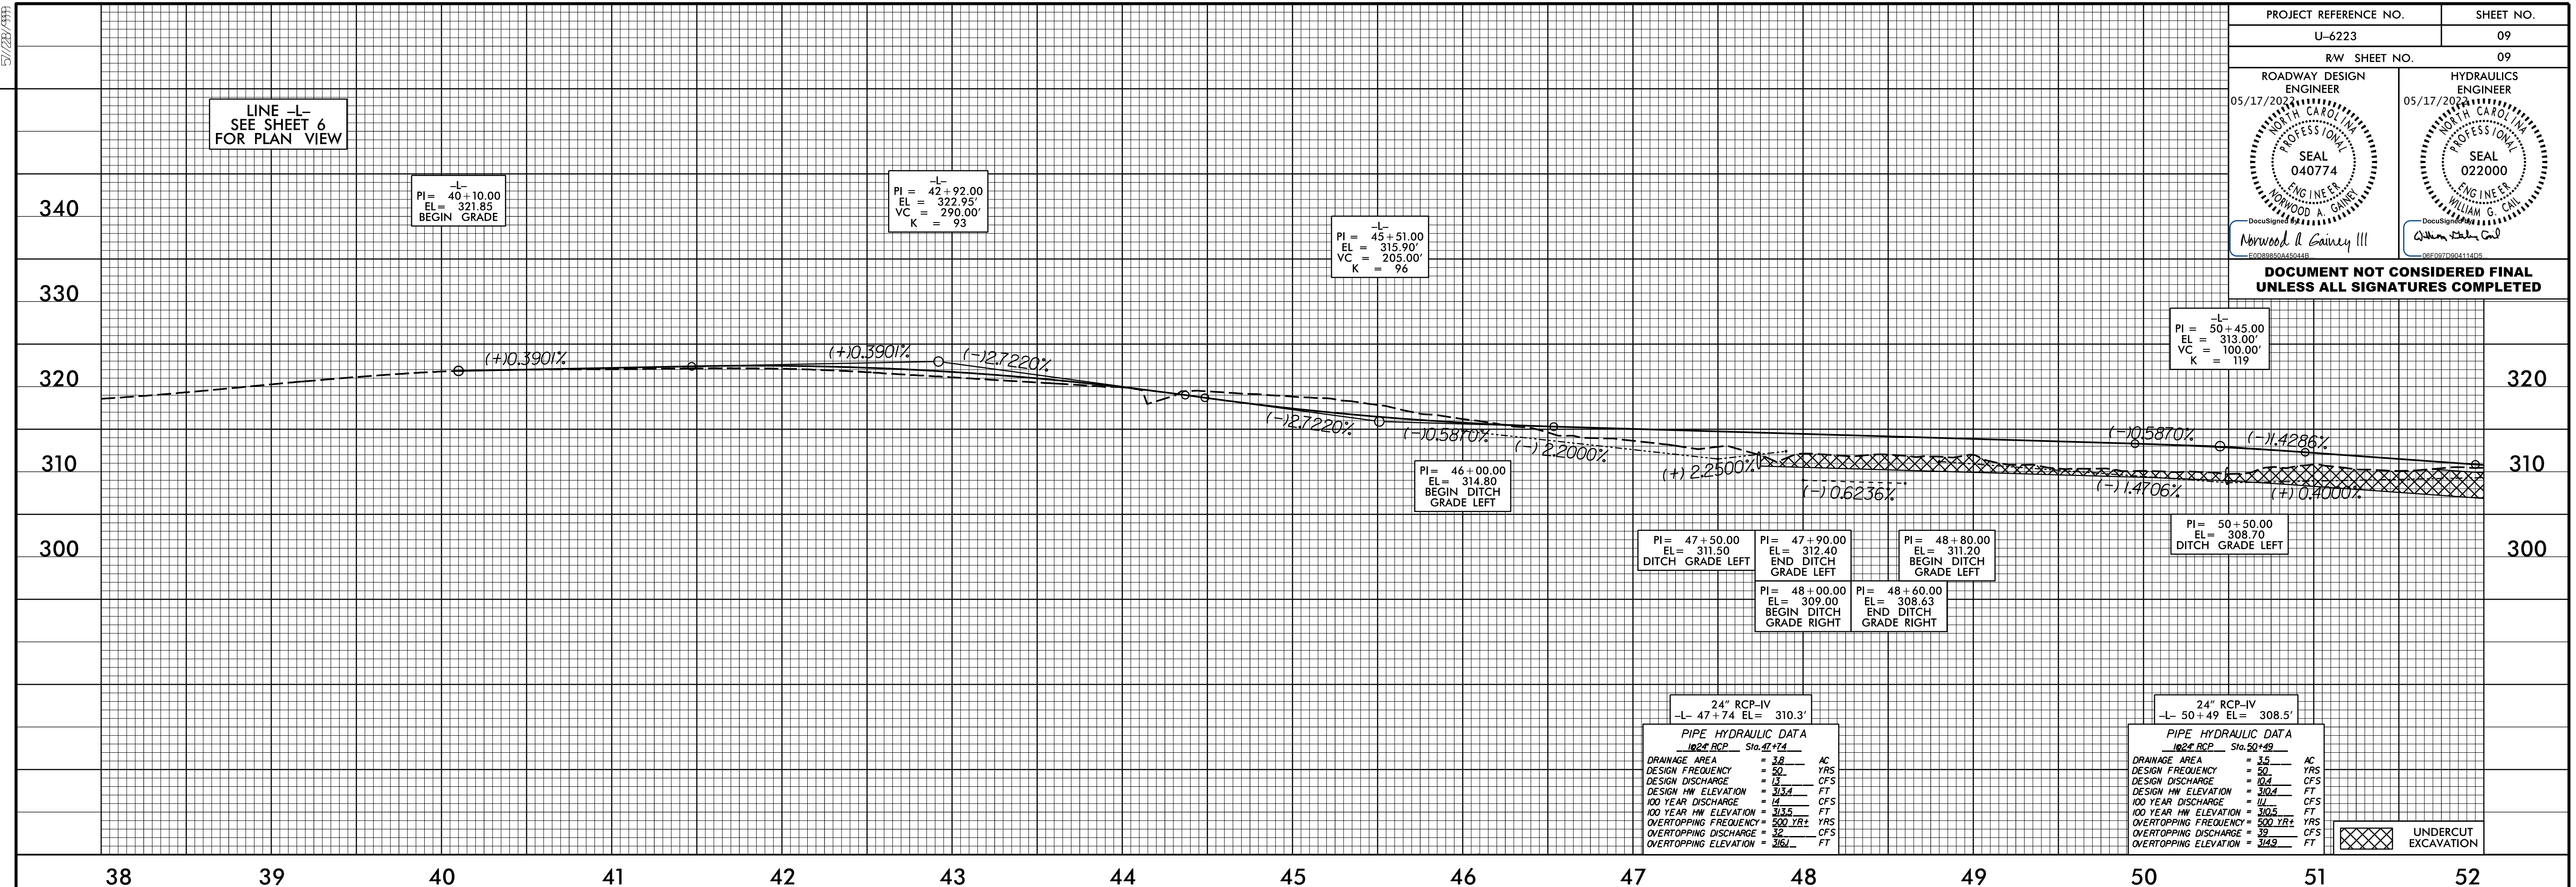

UNDERCUT EXCAVATION

REVISIONS

03-MAY-2022 10:11  
E:\PROJECTS\U-6223\_DDC4\_PROJ.dgn  
Division 4 DDC

DDC4

5/17/2022