


09/08/99

TIP PROJECT: U-6223

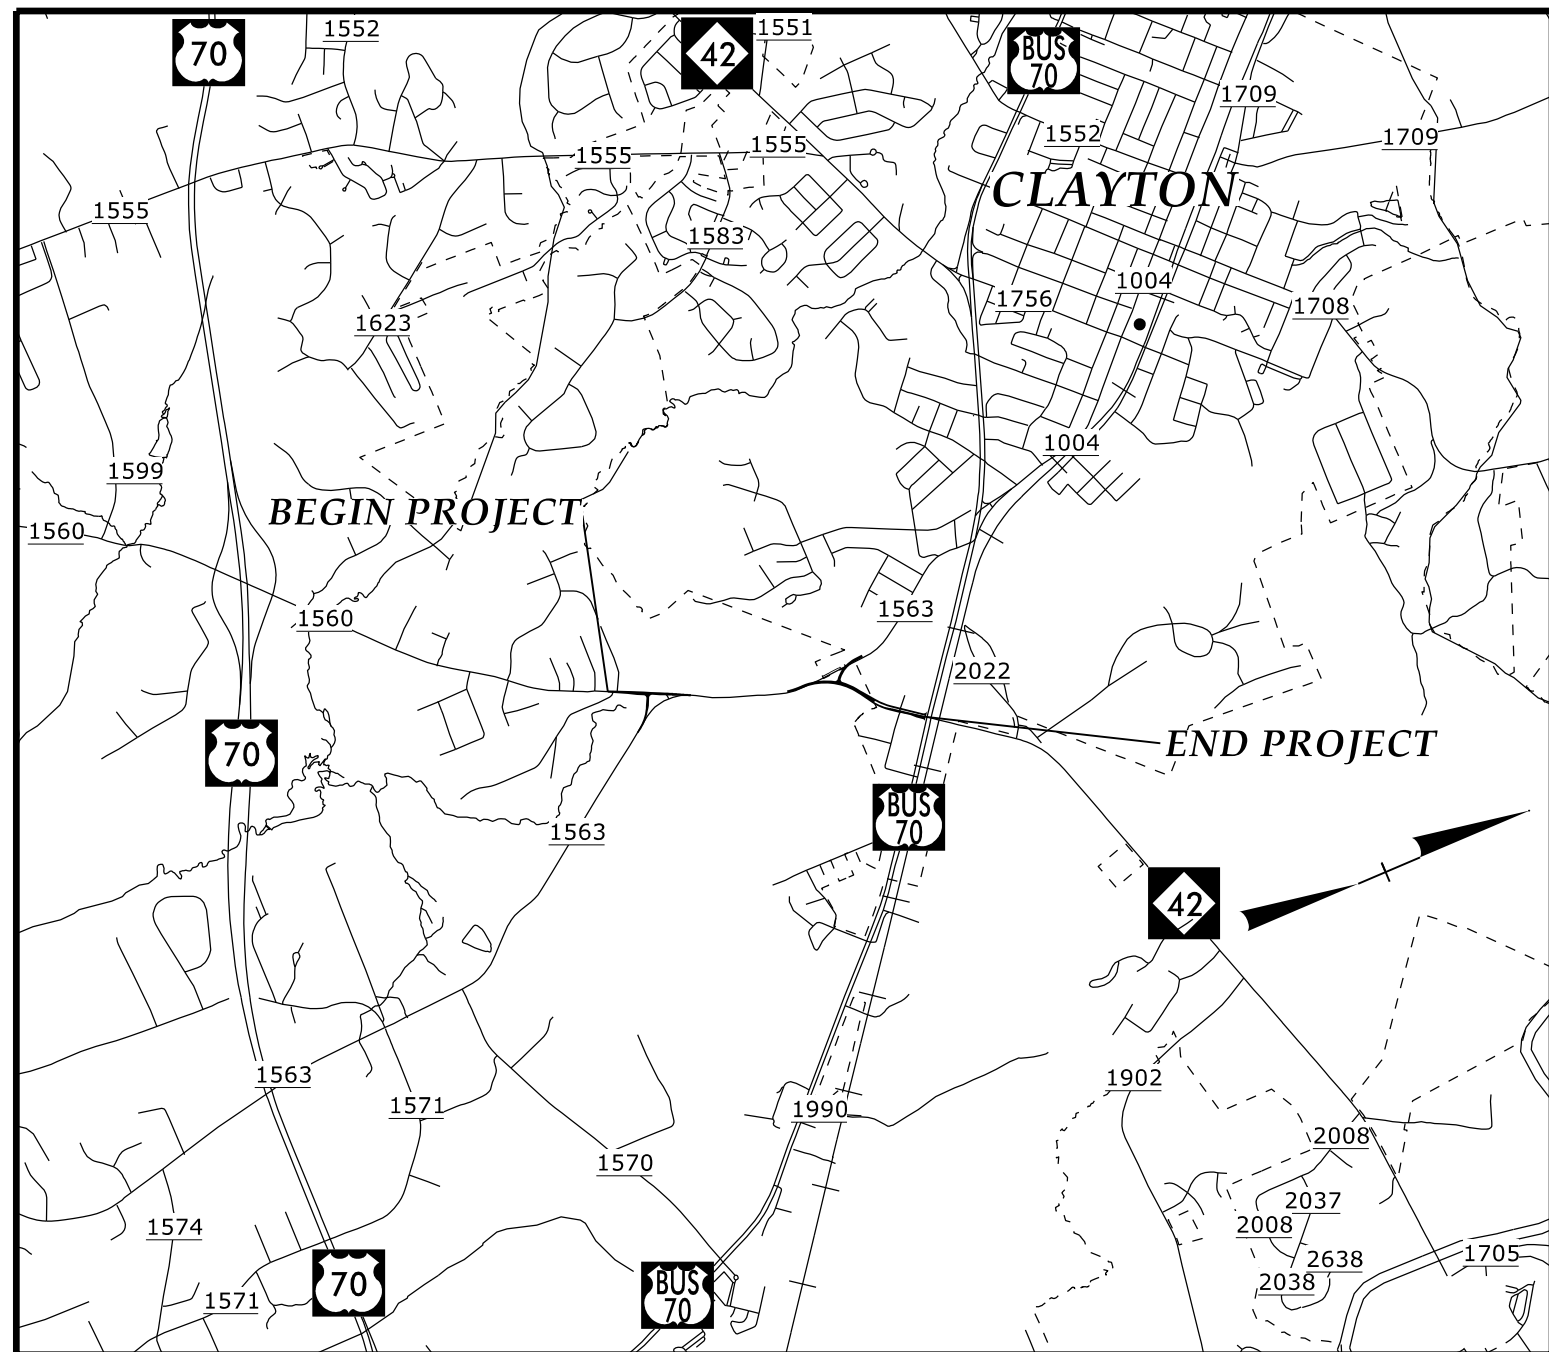

VICINITY MAP

STATE OF NORTH CAROLINA
DIVISION OF HIGHWAYS


UTILITIES BY OTHERS PLANS
JOHNSTON COUNTY

LOCATION: NEW LOCATION FROM SR-1560 (RANCH ROAD)
TO THE US-70 BUS & NC-42 INTERSECTION.


TYPE OF WORK: UTILITY

T.I.P. NO.	SHEET NO.
U-6223	UBO-1

NOTE:
ALL UTILITY WORK SHOWN ON THIS SHEET IS DONE BY OTHERS.
NO PAYMENT WILL BE MADE TO THE CONTRACTOR FOR UTILITY WORK SHOWN ON THIS SHEET.

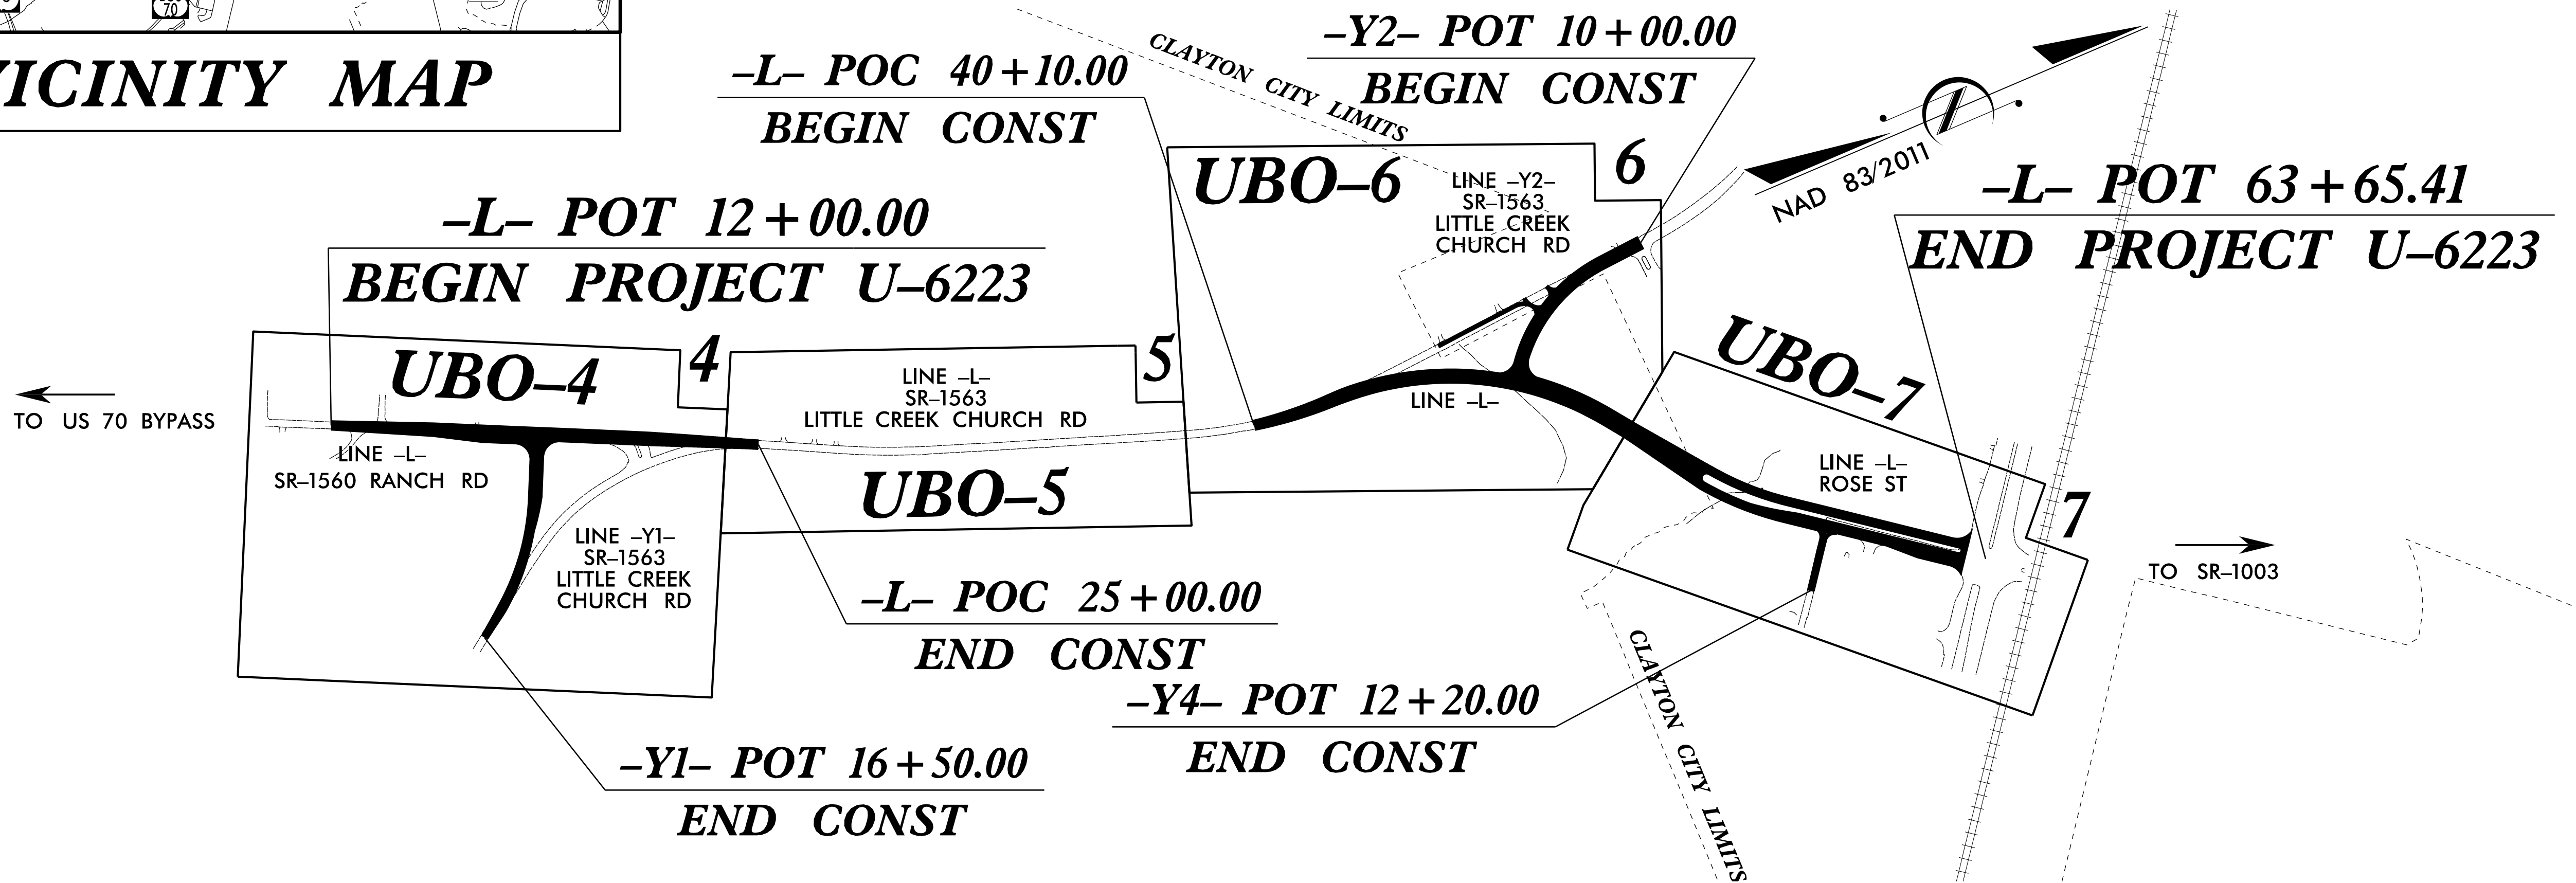

24-MAY-2022 15:35 R:\Roadway\Proj\Utility\U-6223_UTIL_TSH01.dgn Division 4 DDC

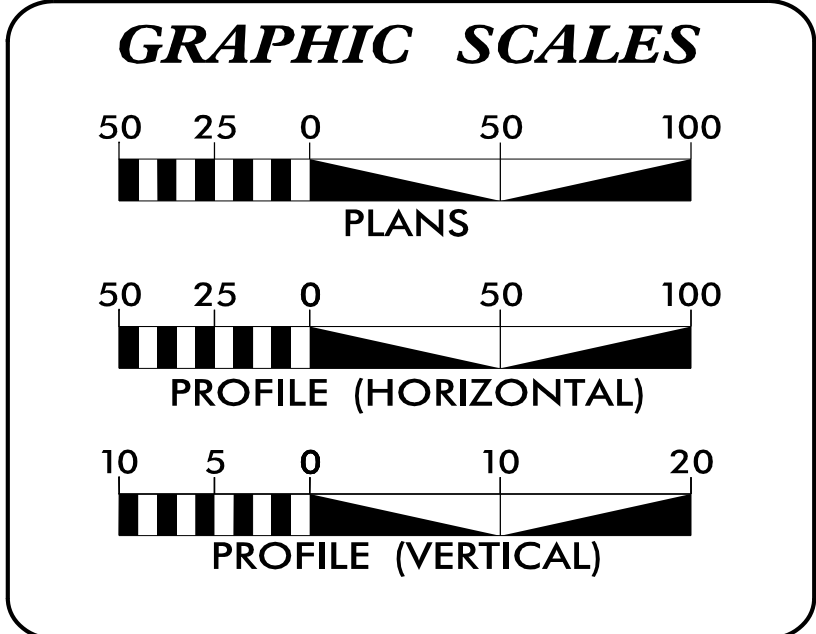

INDEX OF SHEETS

SHEET NO.:	DESCRIPTION:
UO-1	TITLE SHEET
UO-02 THRU UO-07	UBO PLAN SHEETS

UTILITY OWNERS WITH CONFLICTS

- (A) POWER - DUKE ENERGY
- (B) POWER - TOWN OF CLAYTON
- (C) COMMUNICATION - SPECTRUM
- (D) COMMUNICATION - LUMEN TECHNOLOGIES
- (E) GAS - PIEDMONT NATURAL GAS

PREPARED IN THE OFFICE OF:
DIVISION OF HIGHWAYS
Division 4
509 Ward Blvd.
Wilson NC, 27895

KYLE PLEASANT PROJECT UTILITIES ENGINEER
FRANK ZDELAR PROJECT UTILITY COORDINATOR

DIVISION OF HIGHWAYS
DIVISION 04
509 Ward Blvd.
Wilson NC, 27895

ADDISON GAINES, PE DIVISION CONTACT #1