



T.I.P. NO.	SHEET NO.
B-4593	UC-1

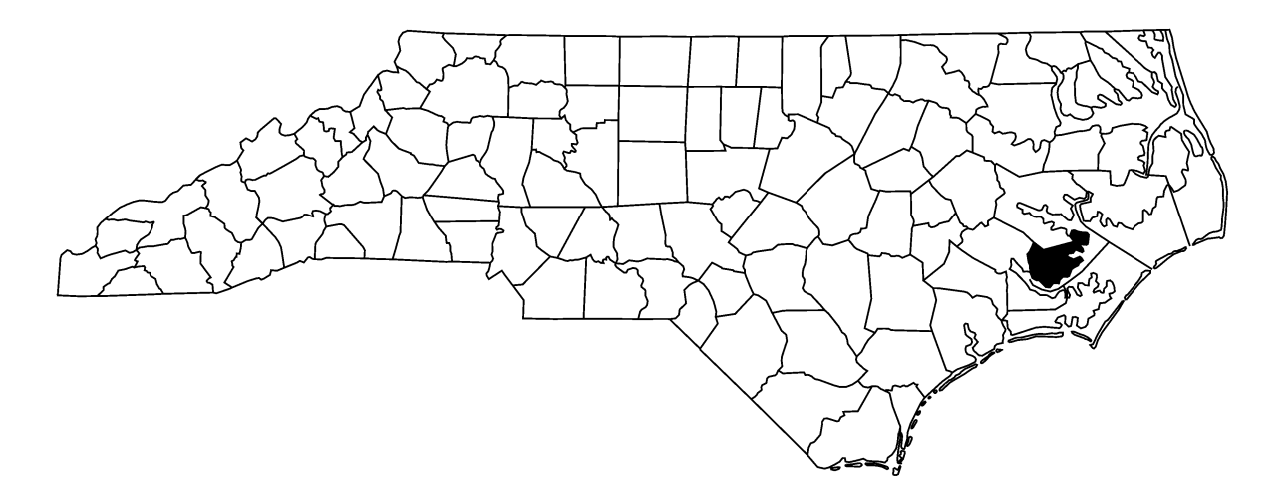


STATE OF NORTH CAROLINA
DIVISION OF HIGHWAYS

**UTILITY CONSTRUCTION PLANS
PAMLICO COUNTY**

LOCATION: BRIDGE No. 38 ON NC 55 OVER TRENT CREEK
TYPE OF WORK: RELOCATION OF SANITARY SEWER AND WATER LINE

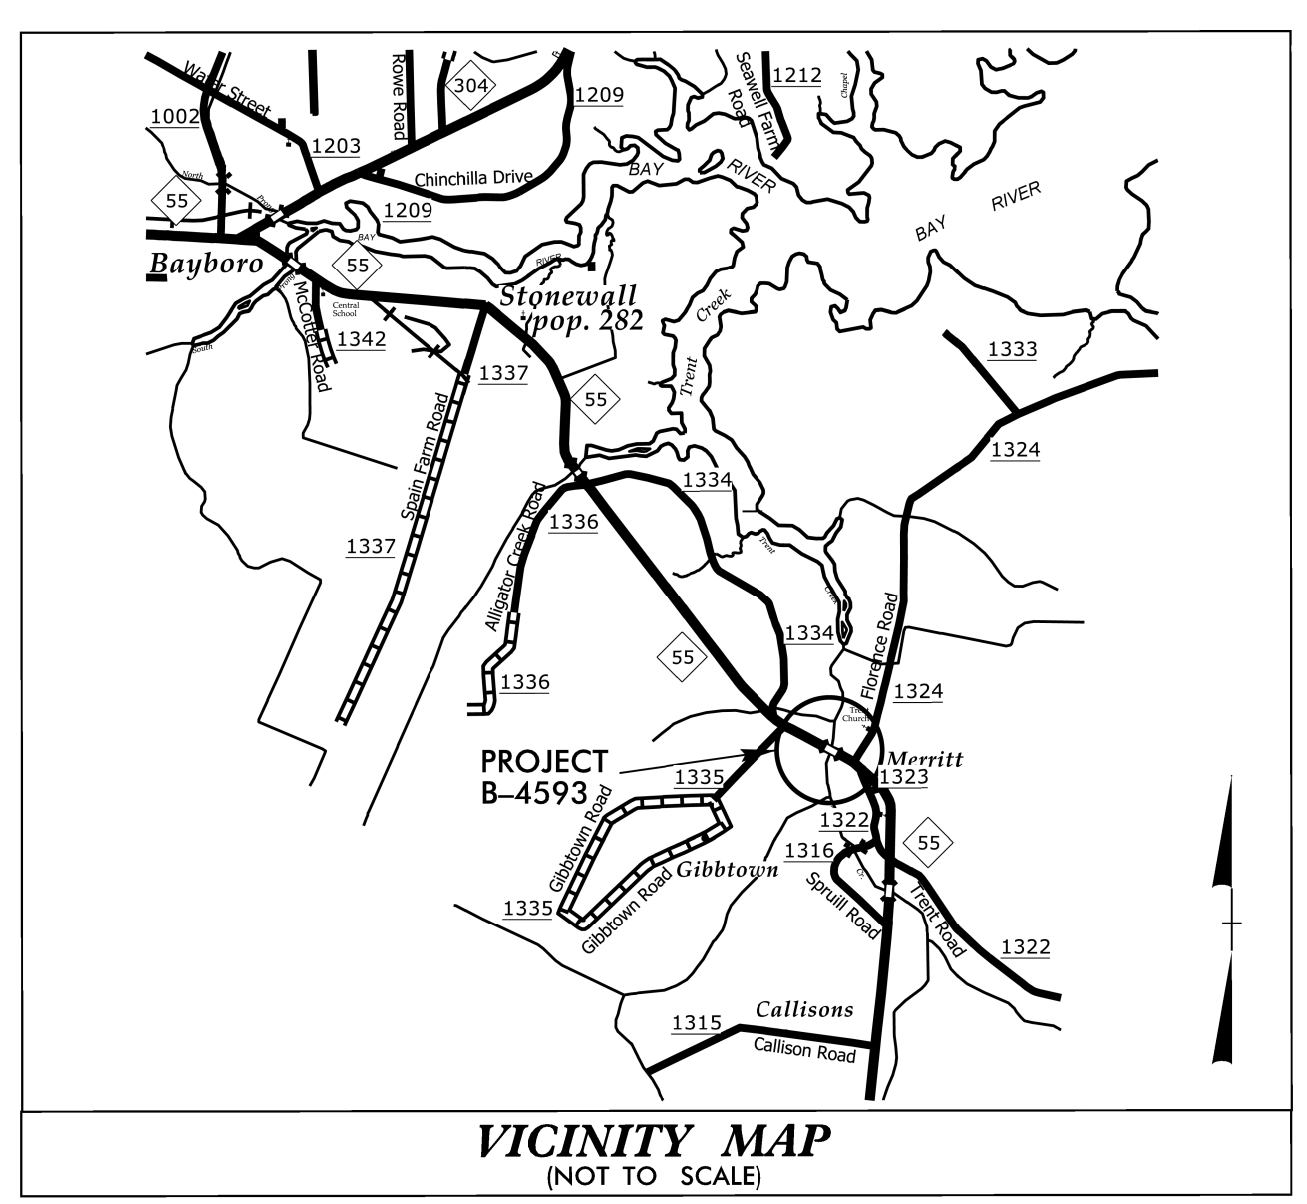


TIP PROJECT: B-4593

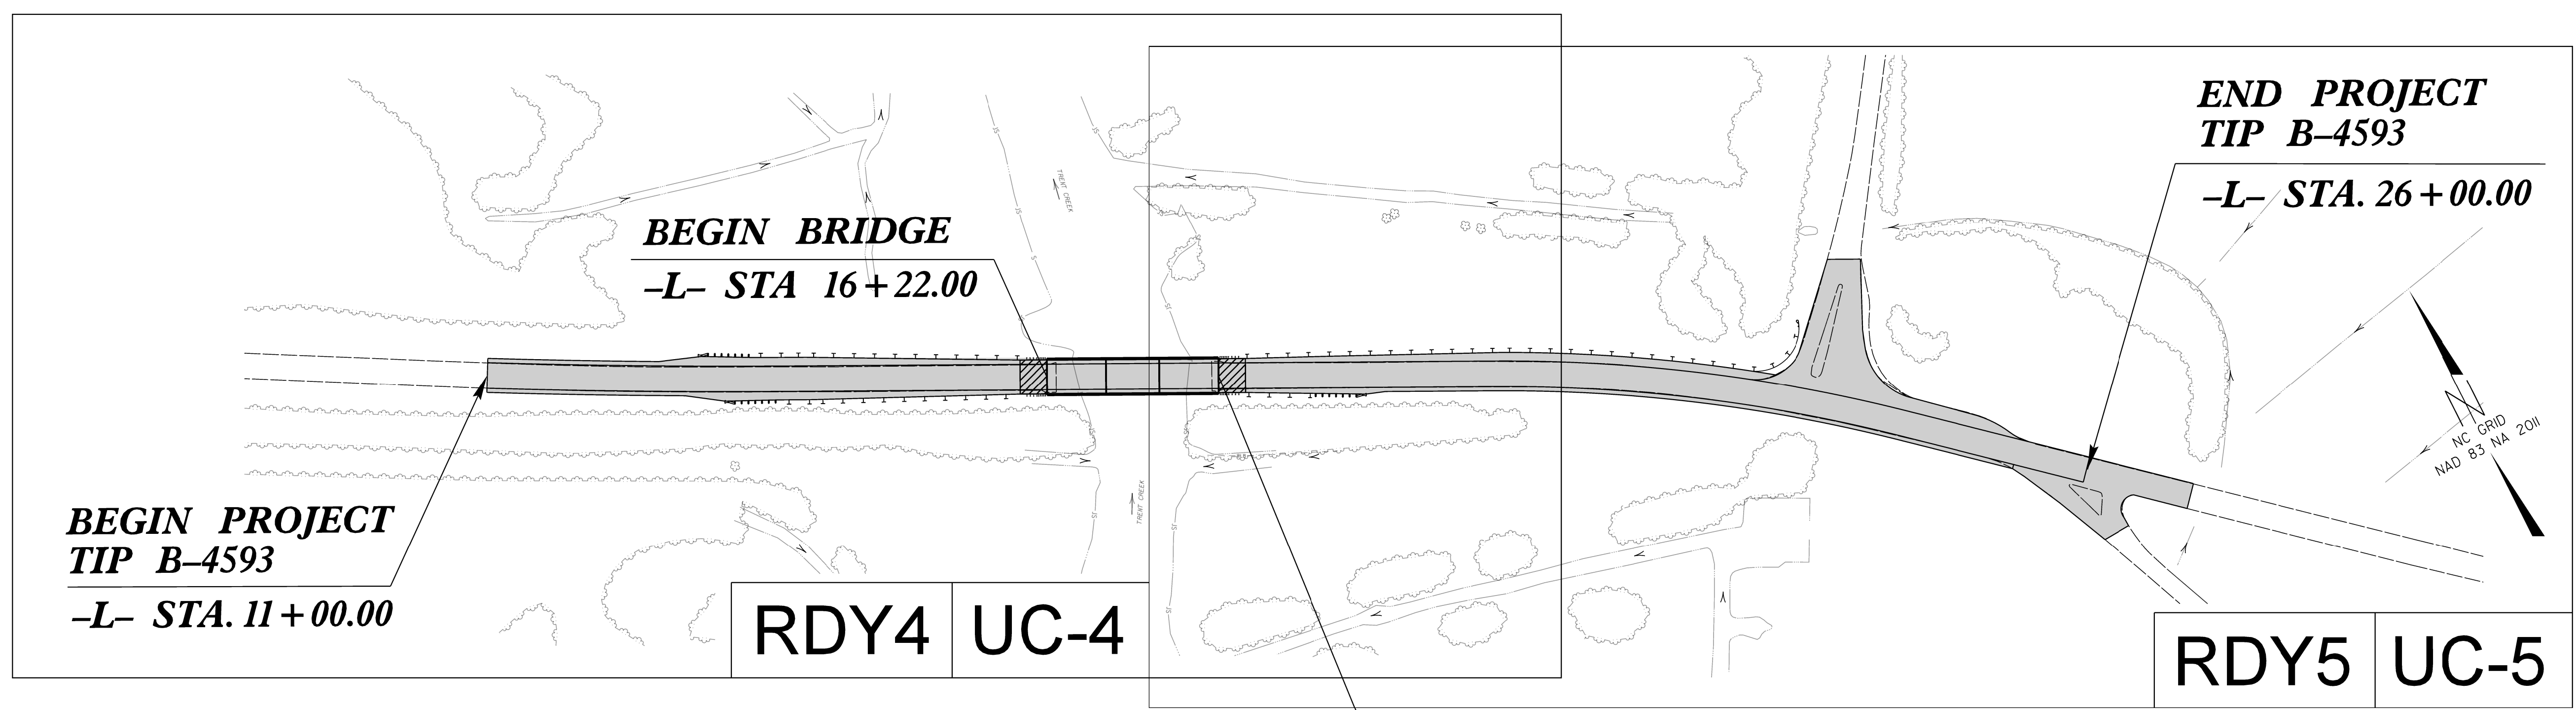

100% FINAL DESIGN

**DOCUMENT NOT CONSIDERED FINAL
UNLESS ALL SIGNATURES COMPLETED**

PLOT DRIVER: Tdotpffuplptcfcg
 USER: LLIGHTFO
 DATE: 6/28/2019
 TIME: 9:51:19 AM
 FILE: NCDOT\NCDOT_2016-2018_Utility_Design\6.0_CAD_BIM\6.2_WIP\Plan Sheets\280_001_B4593_ut_tsh_UC01_psh.dgn
 6/28/2019
 9:51:26 AM

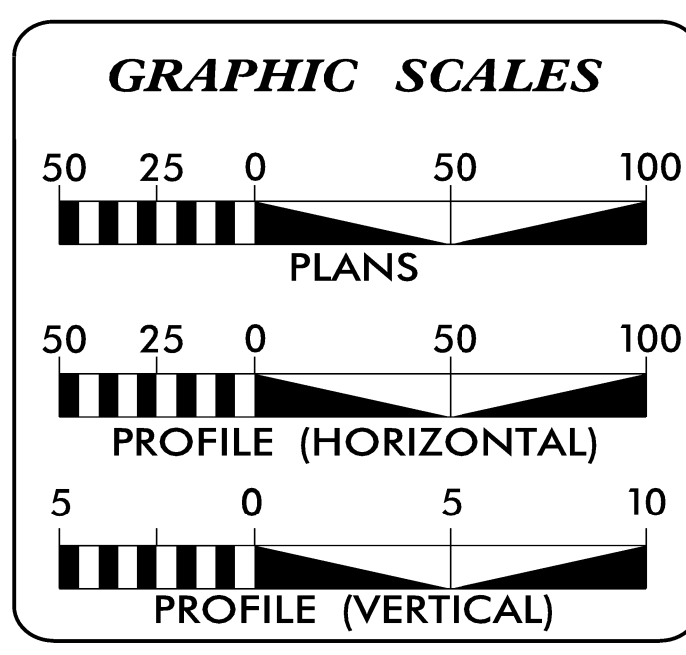

INDEX OF SHEETS

SHEET NO.:	DESCRIPTION:
UC-1	TITLE SHEET
UC-2	UTILITY SYMBOLOGY
UC-3	UTILITY NOTES
UC-3A	UTILITY DETAILS
UC-4	SITE UTILITY PLAN AND PROFILE
UC-5	SITE UTILITY PLAN AND PROFILE

WATER AND SEWER OWNERS ON PROJECT

(A) WATER - PAMLICO CO. WATER DEPT.
(B) SANITARY - BAY RIVER METROPOLITAN SEWER DIST.

PREPARED IN THE OFFICE OF

HDR Engineering, Inc. of the Carolinas
555 Fayetteville St, Suite 900 Raleigh, N.C. 27601
N.C.B.E.L.S. License Number: F-0116

CHRISTOPHER BROWN, PE UTILITY ENGINEER
JACOB VANDENBOSCH, PE UTILITY DESIGN ENGINEER

SEAL

7/1/2019

DIVISION OF HIGHWAYS UTILITIES UNIT
1555 MAIL SERVICES CENTER
RALEIGH NC 27699-1555
PHONE (919) 707-6690
FAX (919) 250-4151

NABIL HAMDAN UTILITIES REGIONAL ENGINEER
KELVIN MARTIN, EI UTILITIES ENGINEER
KYLE PLEASANT UTILITIES AREA COORDINATOR
LARRY JAMES UTILITIES COORDINATOR