



USE FOR LIGHTING CONSTRUCTION ONLY

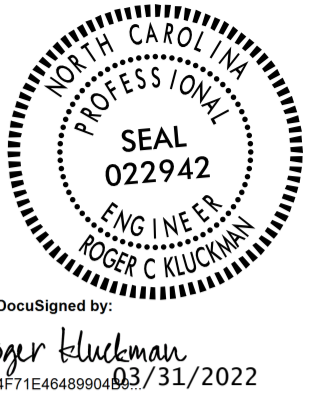

DOCUMENT NOT CONSIDERED FINAL UNLESS ALL SIGNATURES COMPLETED

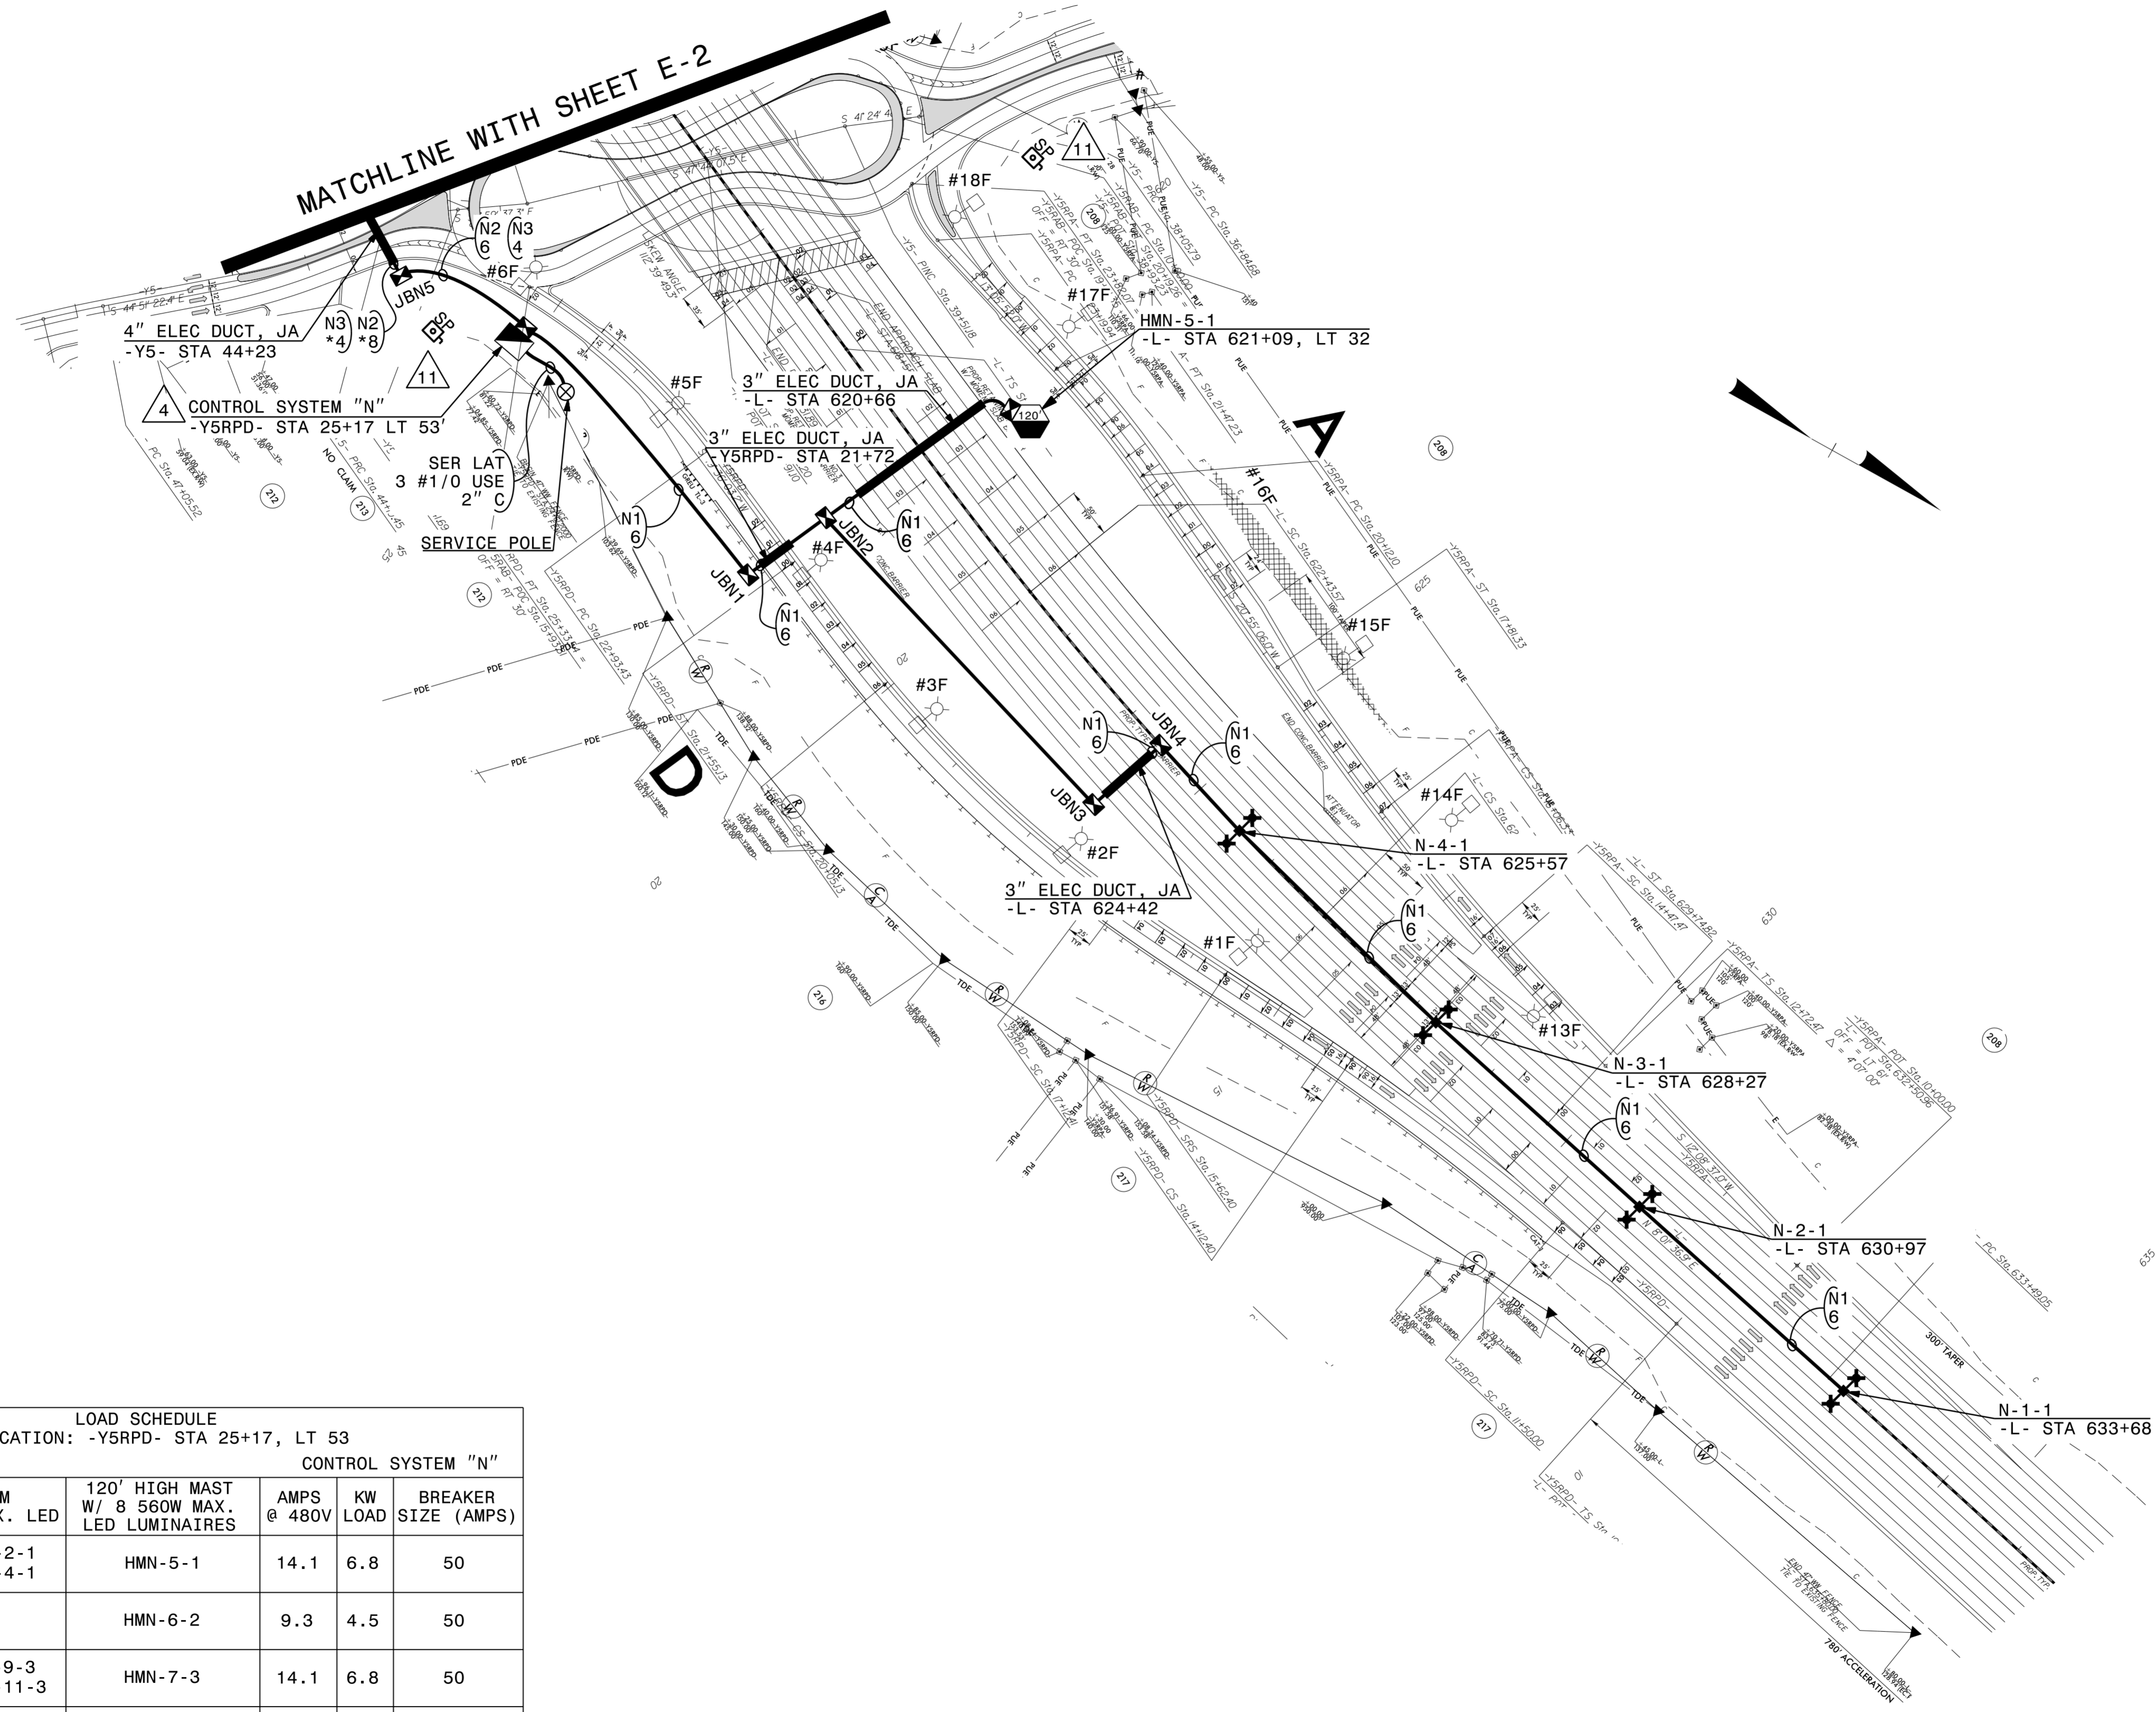

LOAD SCHEDULE  
CS LOCATION: -Y5RPD- STA 25+17, LT 53  
CONTROL SYSTEM "N"

CIRCUIT ID	TWIN ARM 2 @ 285W MAX. LED	120' HIGH MAST W/ 8 560W MAX. LED LUMINAIRES	AMPS @ 480V	KW LOAD	BREAKER SIZE (AMPS)
N1	N-1-1, N-2-1 N-3-1, N-4-1	HMN-5-1	14.1	6.8	50
N2	--	HMN-6-2	9.3	4.5	50
N3	N-8-3, N-9-3 N-10-3, N-11-3	HMN-7-3	14.1	6.8	50
--	--	--	--	--	--
--	--	--	--	--	--
SPARE	--	--	--	--	50
TOTAL	8	3	37.5	18.1	

SEE SHEET "E-1" FOR LEGEND & Δ NOTES

2			
1			
Rev.	Date	Description	Approved
NORTH CAROLINA DEPARTMENT OF TRANSPORTATION ROADWAY DESIGN LIGHTING/ELECTRICAL SECTION <b>LIGHTING LAYOUT</b> I-95/W BROAD ST INTERCHANGE (EXIT 31) ROBESON COUNTY			
Drawn By:	Approved By:	Dwg No.:	
SAM	RGH		

28-MAR-2022 14:58  
 R:\Lighting Design\1-5987B CS - N & P\15987B.LE\_PSH.E-3.dgn  
 somehtk AT RD-304555