 




USE FOR LIGHTING CONSTRUCTION ONLY

PROJECT REFERENCE NO. U-5987B SHEET NO. E-4

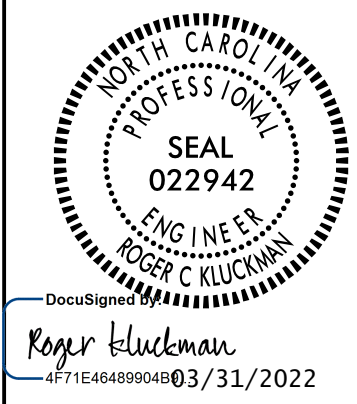

DOCUMENT NOT CONSIDERED FINAL UNLESS ALL SIGNATURES COMPLETED

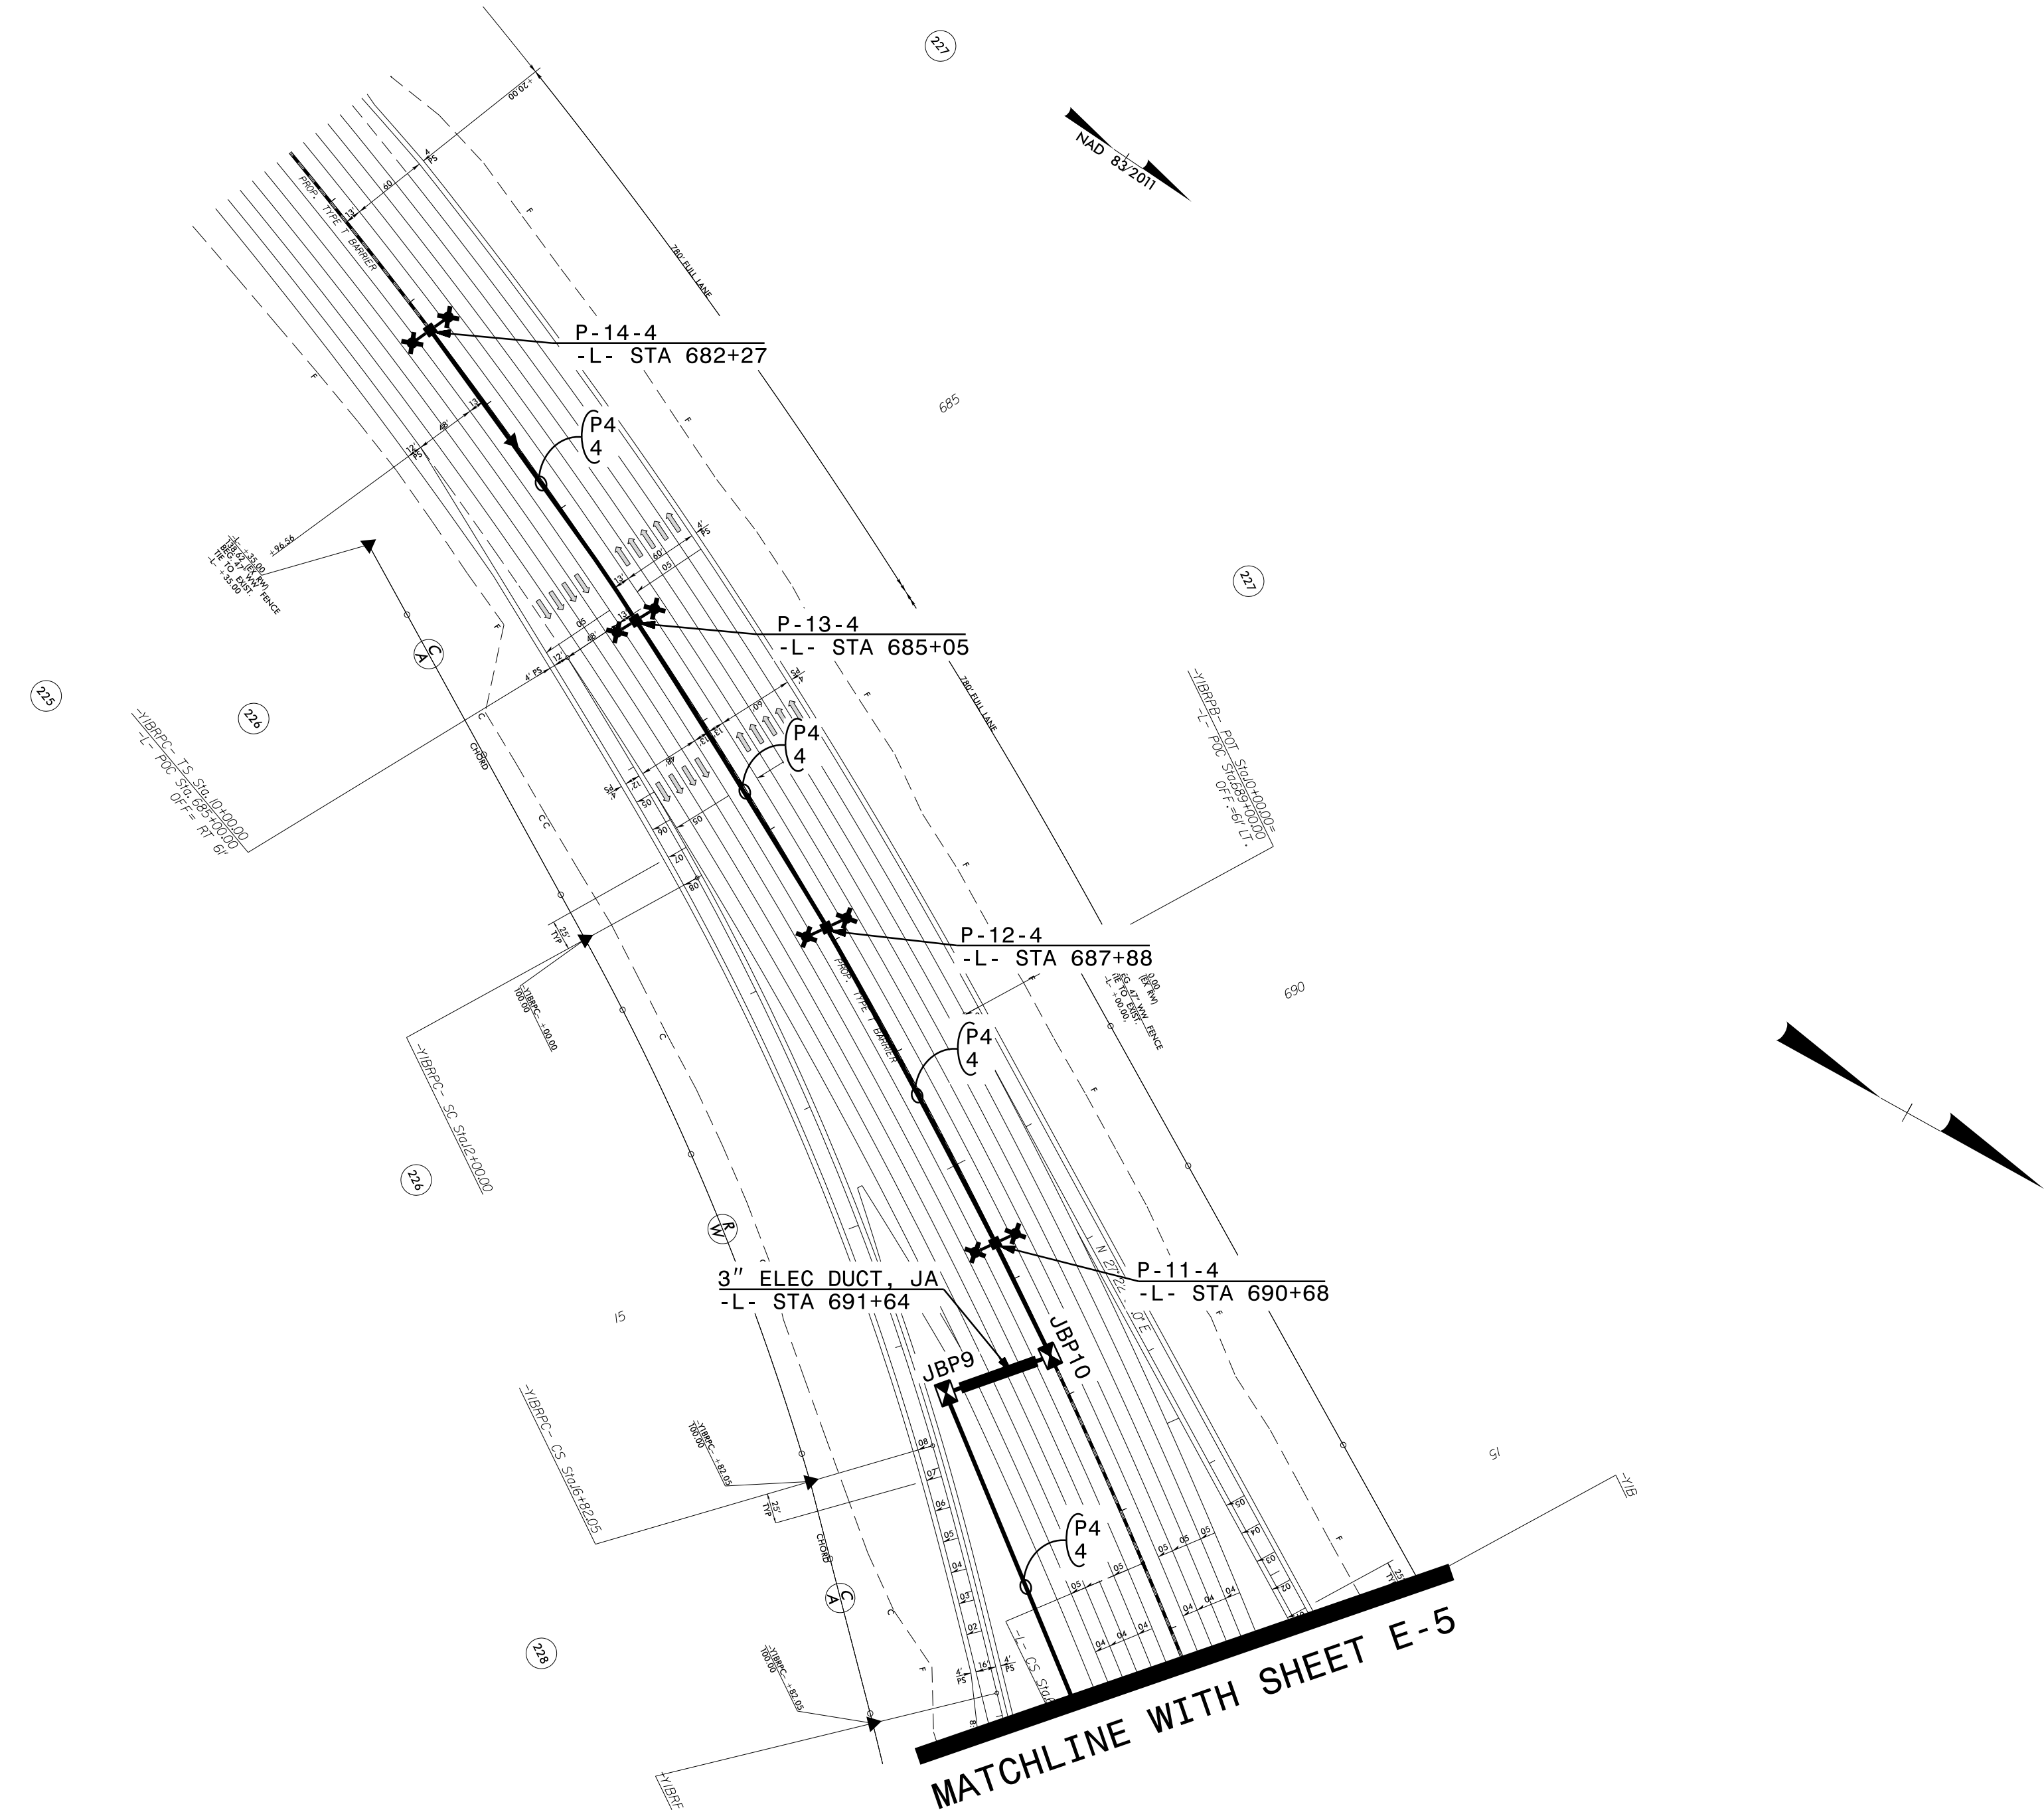

MATCHLINE WITH SHEET E-5

SEE SHEET "E-1" FOR LEGEND & △ NOTES

2			
1			
Rev.	Date	Description	Approved
NORTH CAROLINA DEPARTMENT OF TRANSPORTATION ROADWAY DESIGN LIGHTING/ELECTRICAL SECTION LIGHTING LAYOUT I-95/US 301 INTERCHANGE (EXIT 33) ROBESON COUNTY			
Drawn By:	Approved By:	Dwg No.:	
SAM	RGH		

28-MAR-2022 14:56
 P:\Lighting Design\I-5987B CS - N & P\I5987B.LE_PSH_E-4.dgn
 somehtk AT RD-307555