

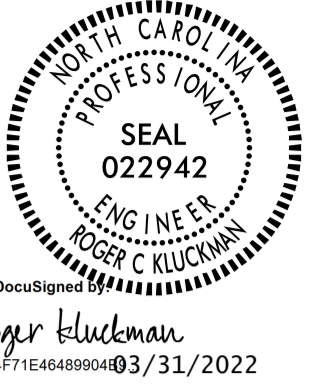


USE FOR LIGHTING CONSTRUCTION ONLY

PROJECT REFERENCE NO. U-5987B	SHEET NO. E-6
----------------------------------	------------------

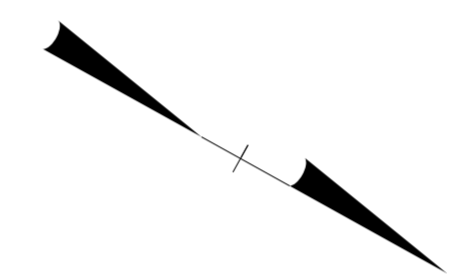

**DOCUMENT NOT CONSIDERED FINAL
UNLESS ALL SIGNATURES COMPLETED**

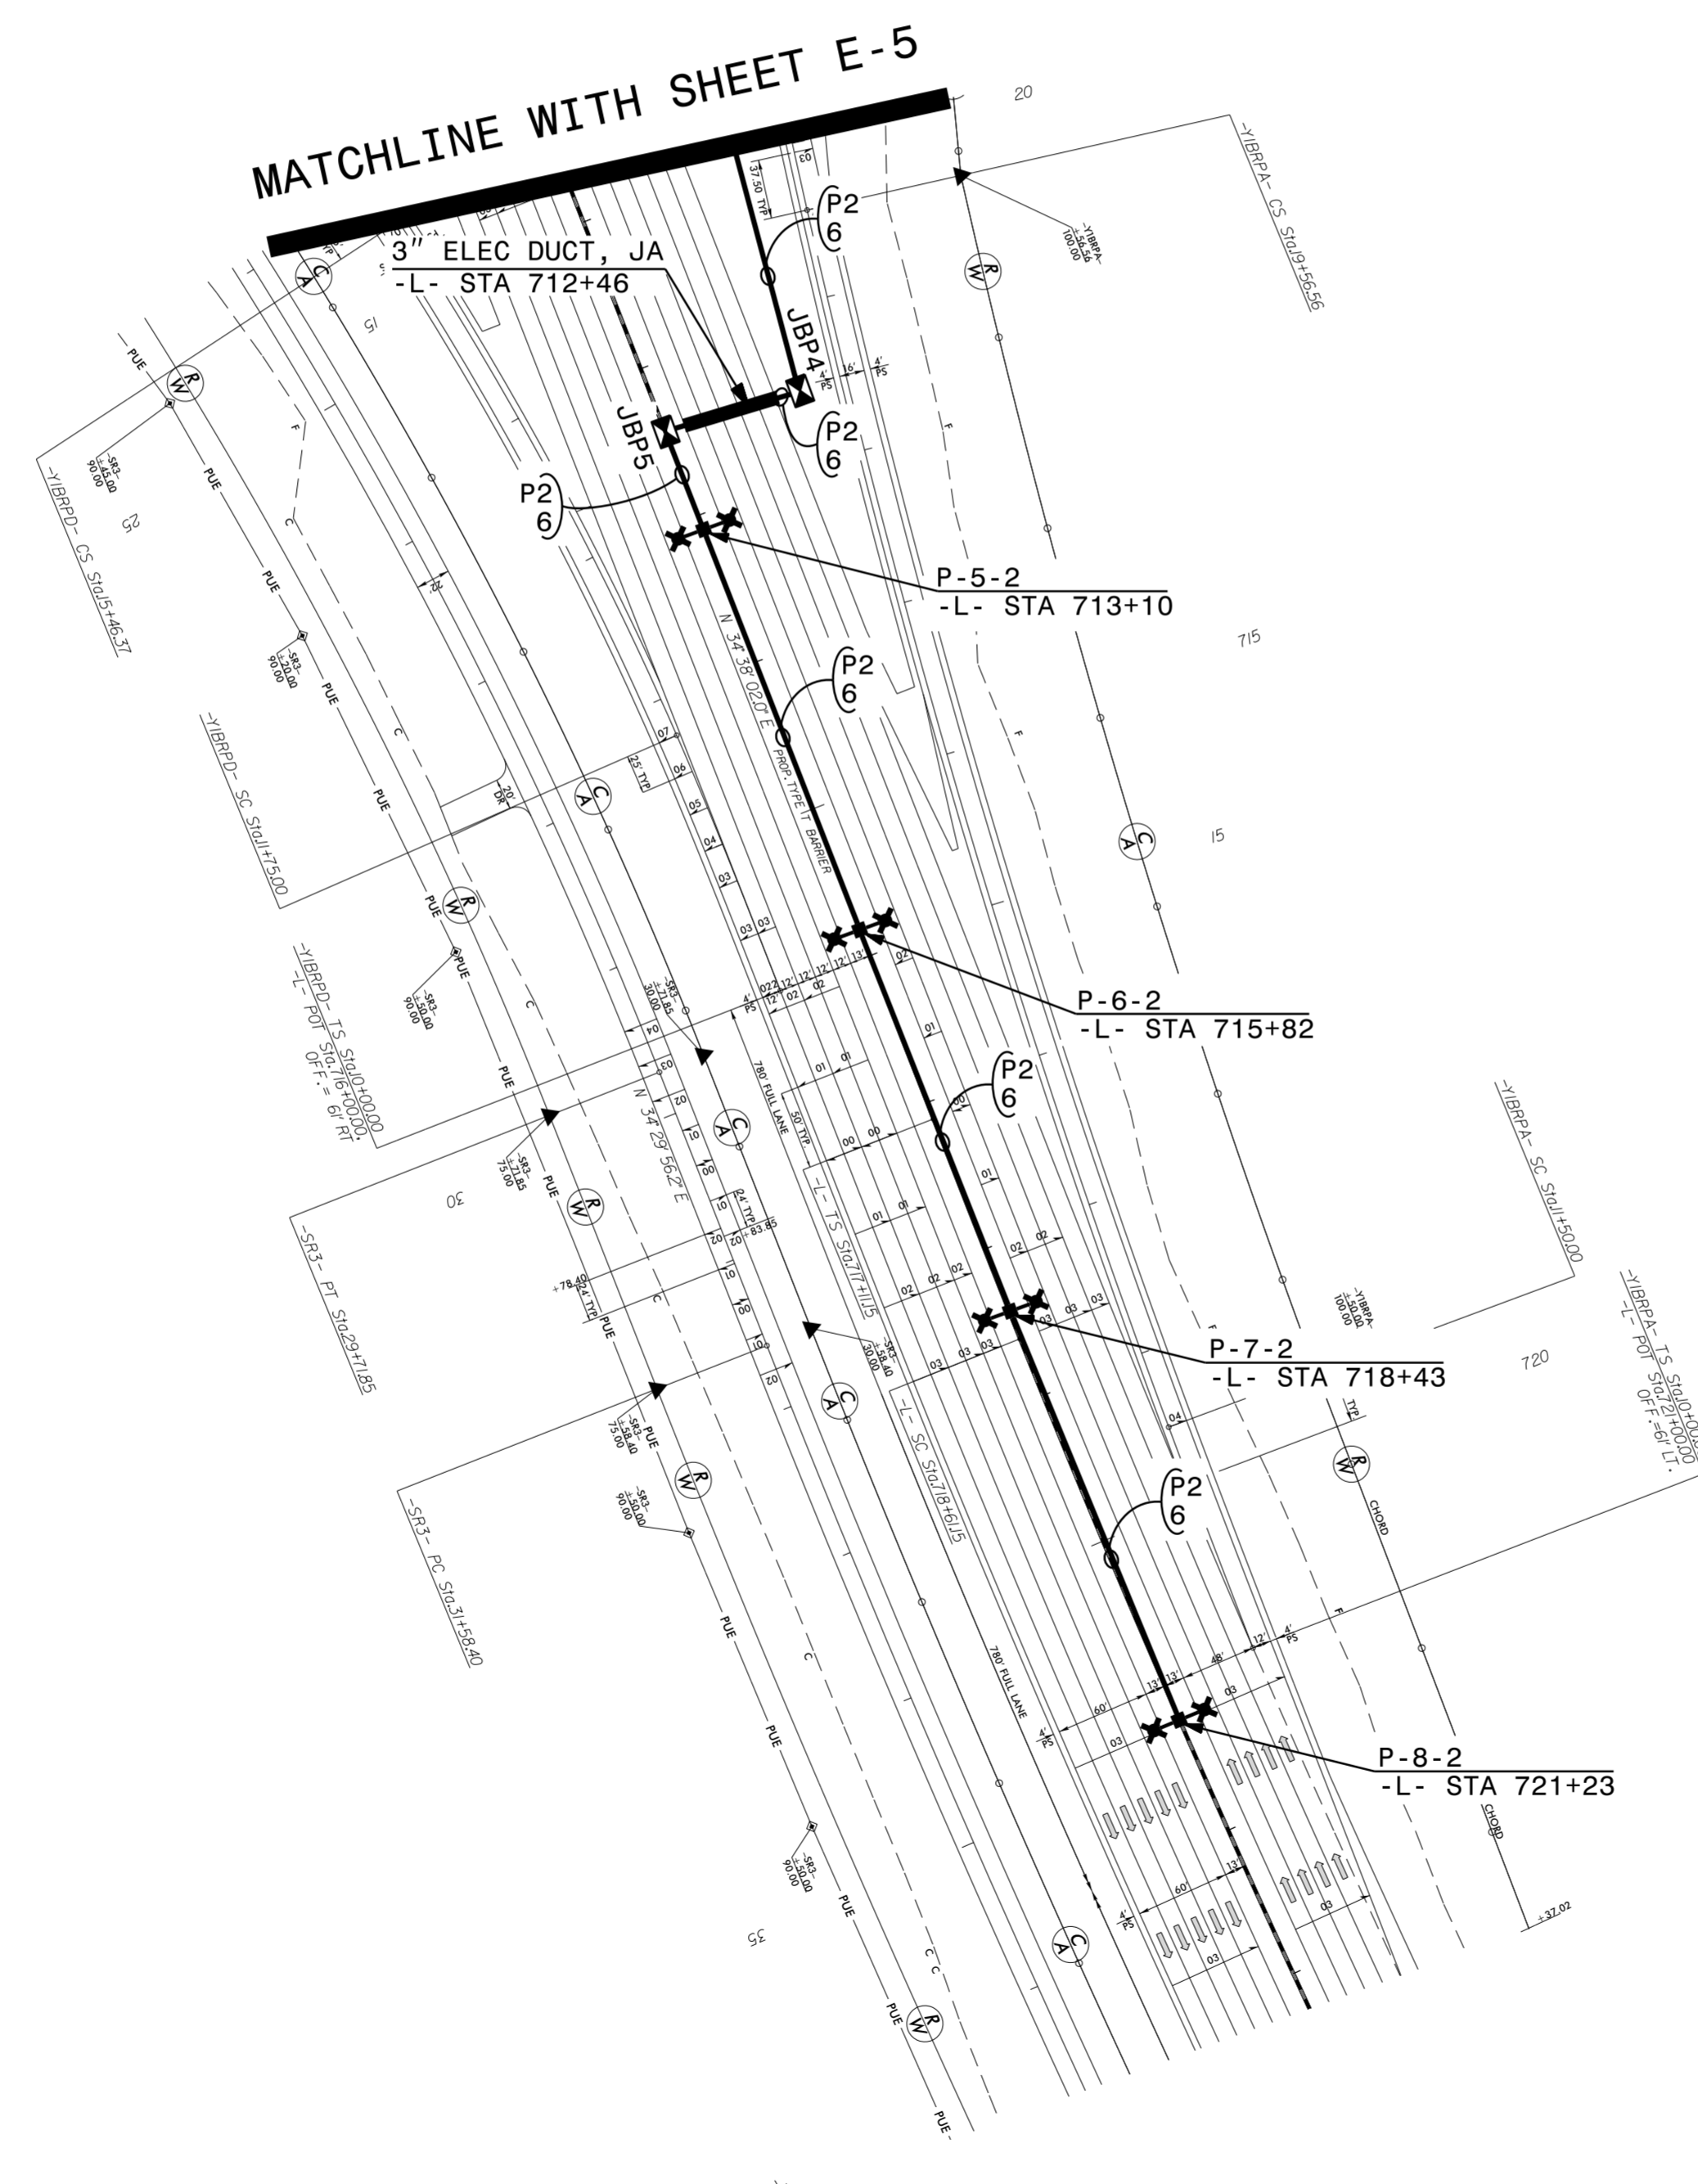

SEE SHEET "E-1" FOR
LEGEND & △ NOTES

2			
1			
Rev.	Date	Description	Approved
NORTH CAROLINA DEPARTMENT OF TRANSPORTATION ROADWAY DESIGN LIGHTING/ELECTRICAL SECTION LIGHTING LAYOUT I-95/US 301 INTERCHANGE (EXIT 33) ROBESON COUNTY			
Drawn By:	SAM	Approved By:	RGH
		Dwg No.:	

28-MAR-2022 15:03
 R:\Lighting\Lighting Design\I-5987B CS - N & P\I5987B.LE_PSH_E-6.dgn
 somehtk AT RD-307555